



2 Balustrade Type BF - elevation - RTB6
1 : 20

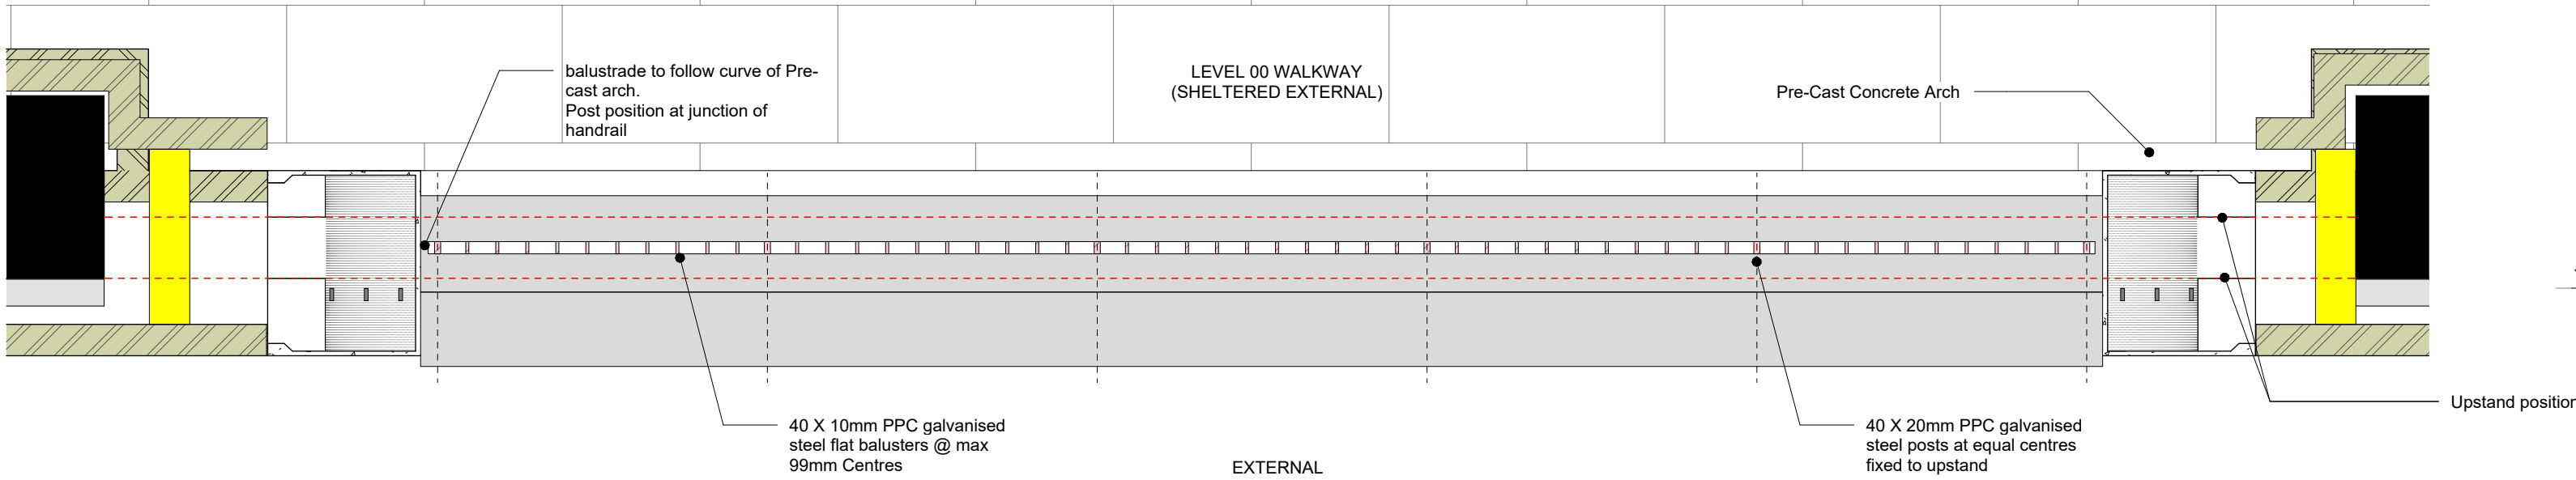

3 Balustrade Type BF - plan detail - RTB6
1 : 20

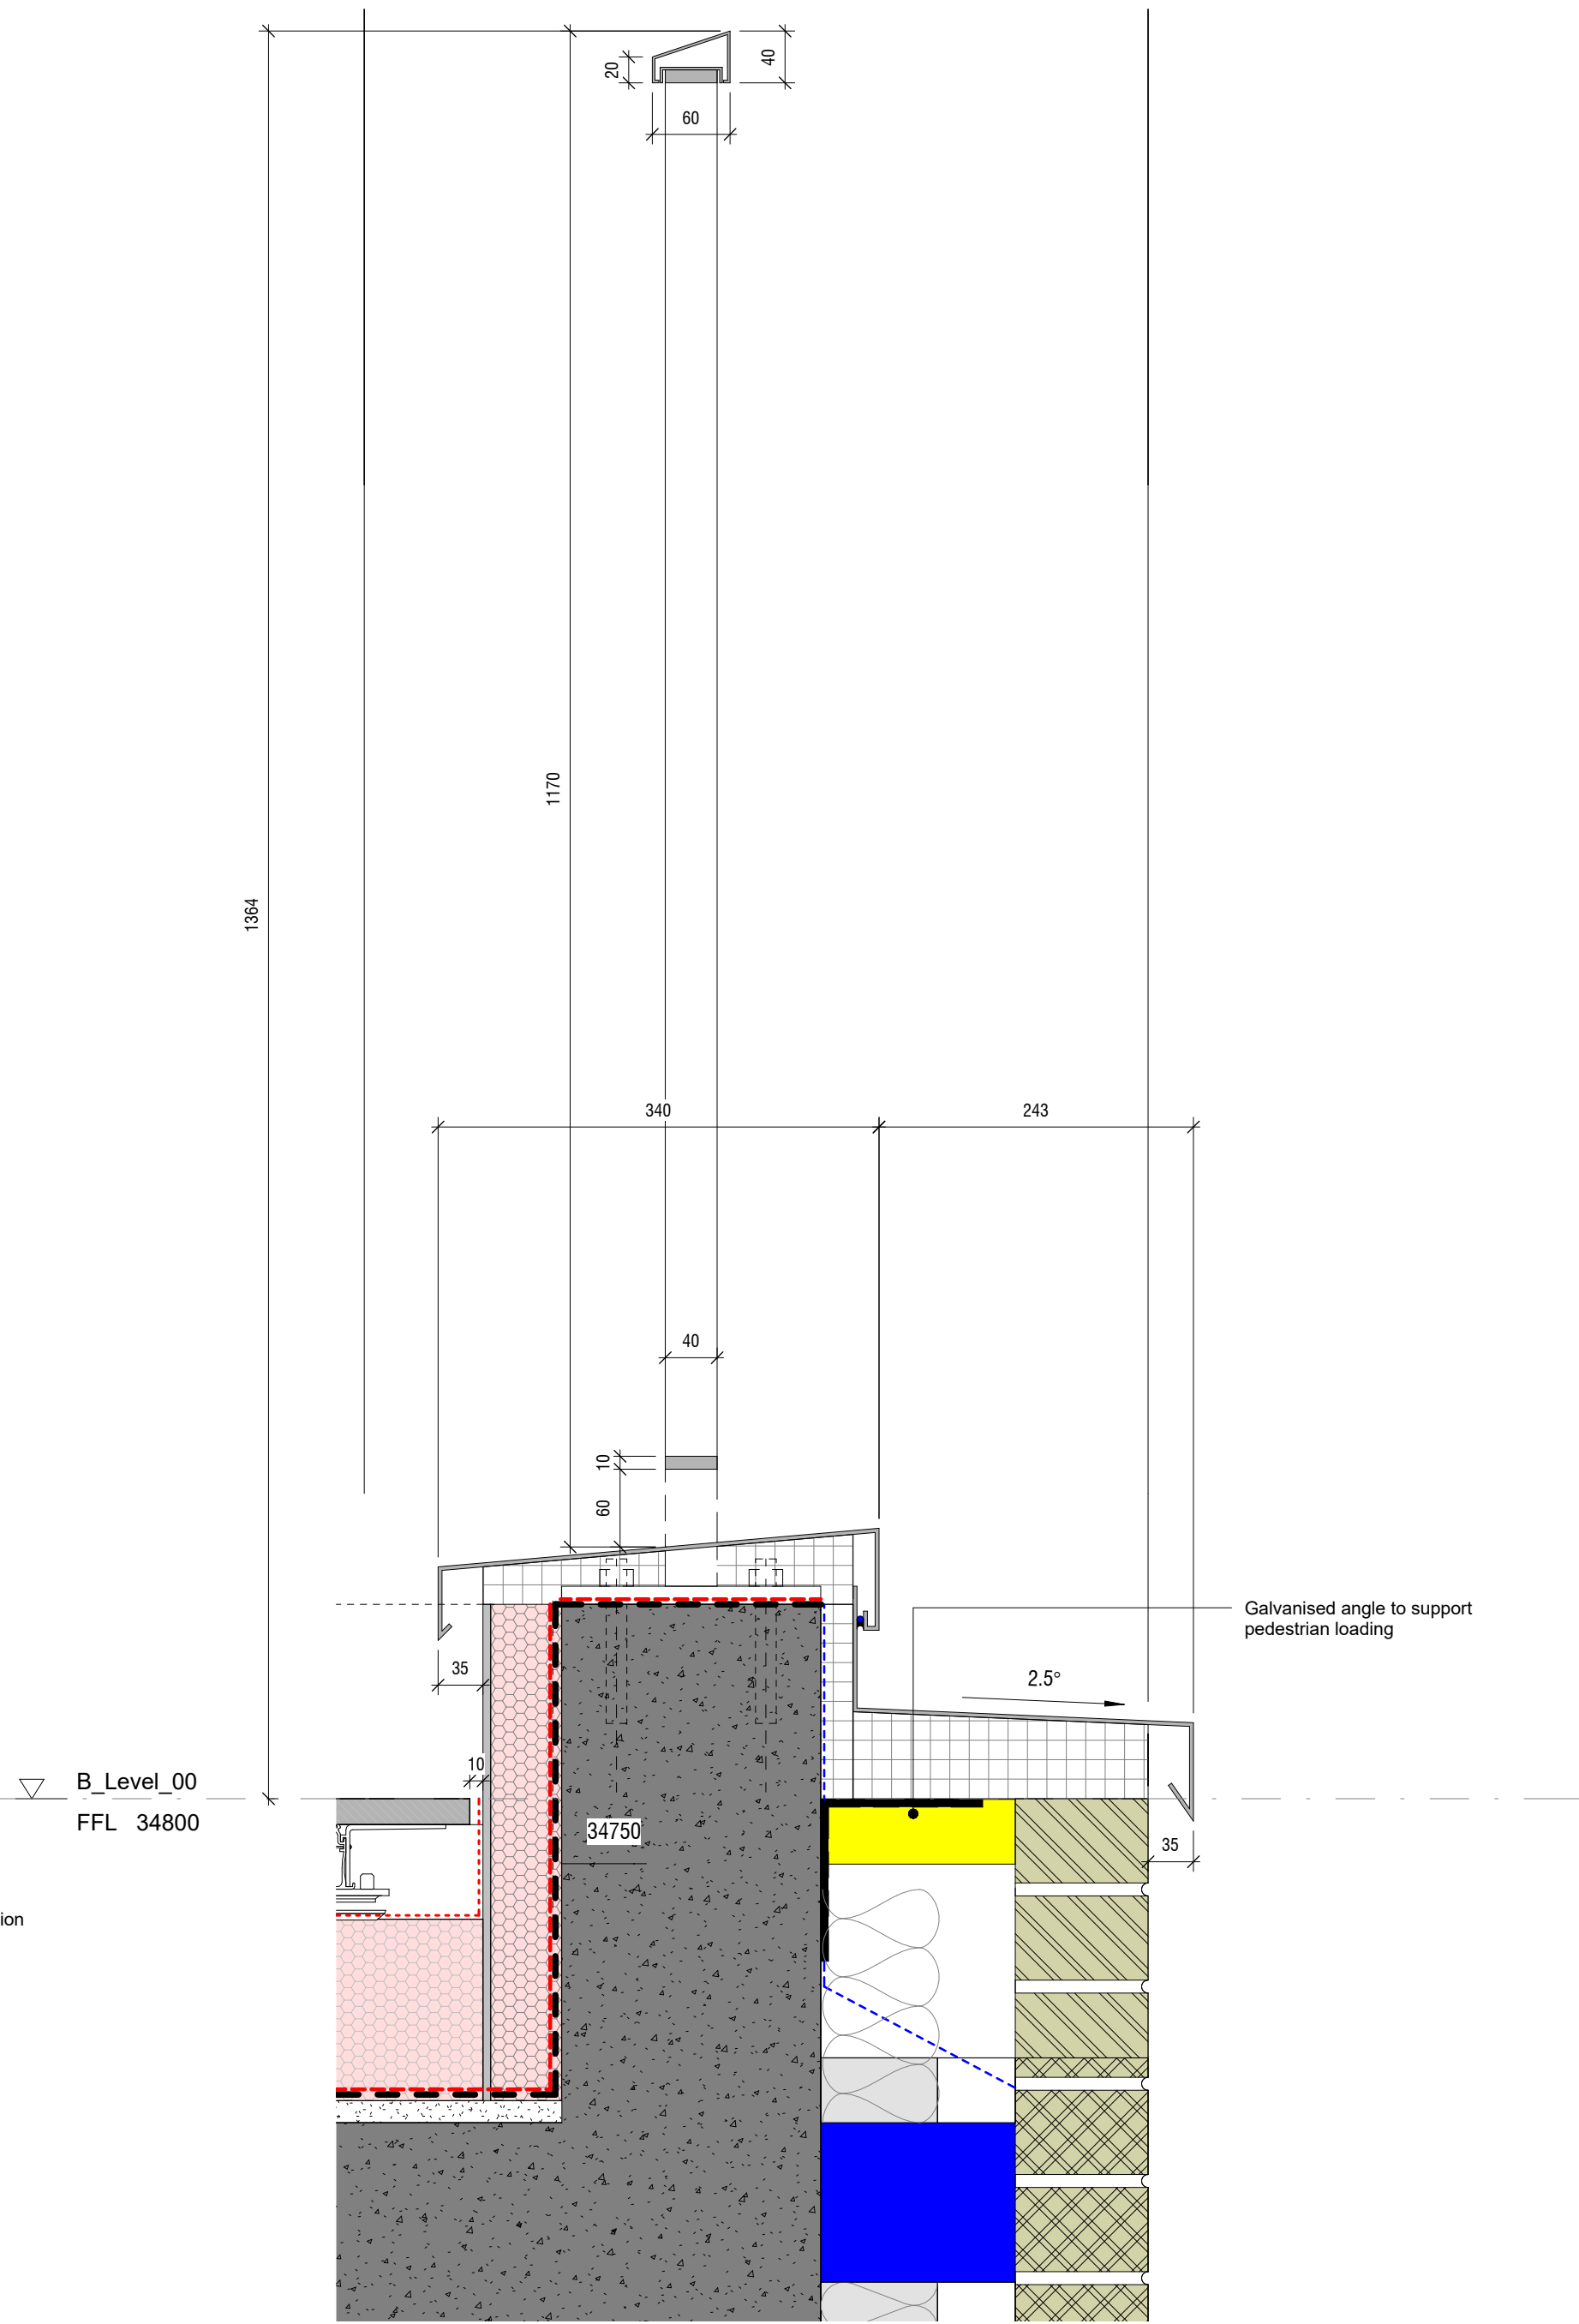

1 Balustrade Type BF - section detail
1 : 5


BALUSTRADES

For balustrade locations and instance references refer to 03 Series.

For balustrade types, details and schedules refer to 36 Series.

For balustrade specification refer to:
Ss_25_60_05_05 Balustrades and guarding systems - Carbon Steel balustrade

Detailed design to be developed by specialist subcontractor.

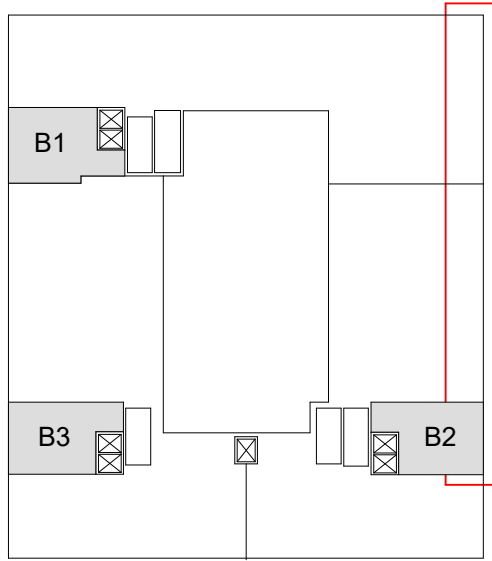

DRAWING SERIES

Series 00 - Accommodation Schedules
Series 00 - NBS Specification
Series 02 - Conveyance Plans
Series 03 - GA Plans, GA Setting out Plans & Marketing Plans
Series 04 - GA Sections
Series 05 - GA Elevations
Series 06 - Stage 2 Drawings
Series 07 - Bay Studies
Series 09 - 3D Views
Series 16 - Substructure
Series 20 - Superstructure
Series 21 - External Wall Types & Details
Series 22 - Internal Wall Types & Details
Series 23 - Floor Types & Details
Series 24 - Staircases & Lifts
Series 27 - Roof Types & Details
Series 31 - Window & Doors Types, Details & Schedules
Series 35 - Reflected Ceiling Plans
Series 36 - Balconies & External Metalwork
Series 40 - Internal Finishes
Series 43 - Floor Finishes
Series 60 - Electrical Plans
Series 67 - Fire Strategy Plans
Series 70 - Flat Type Layouts
Series 71 - Signage Plans
Series 73 - Kitchen Layouts & Schedules
Series 74 - Bathroom Layouts & Schedules
Series 79 - Residents Facilities
Series 82 - Commercial Units
Series 83 - Offices

Refer to:
03 Series Cladding plans for scoping extent,
35 Series SW soffit plans (insulation & metalwork),
36 Series for metalwork details &
DDU / TFS NBS specification for metalwork elements

C02	Updated Metalwork Issue	05.09.23	CS	JR
C01	Construction Issue	30.06.23	CS	ACS
Revision	Description	Date	Drawn	Checked

design
delivery
unit

77 Endell Street
London WC2H 9DZ
T + 44 (0)20 7240 7766
W designdeliveryunit.com

Client's Name

St George North London Limited



Job Title

Camden Goods Yard

Drawing Title

Building B Balustrade Details Type Bf

Scale

As indicated @A1

Practice Project No.

20226

Client Project Code	Originator	Volume	Level	Type	Role	Number
CGYB0-DDU-B0-ZZ-DR-A-36126						
Description						
CONSTRUCTION						CO