



For balustrade locations and instance references refer to 03 Series.

For balustrade specification refer to:
Ss_25_60_05_05 Balustrades and guarding systems - Carbon
Steel balustrade

NOTE:
Windows **WTB11-07-28 & 31** (2485mm S/O) sliding door system to provide mid-span fixing to frame.
Central baluster to be increased to 20 x 40mm

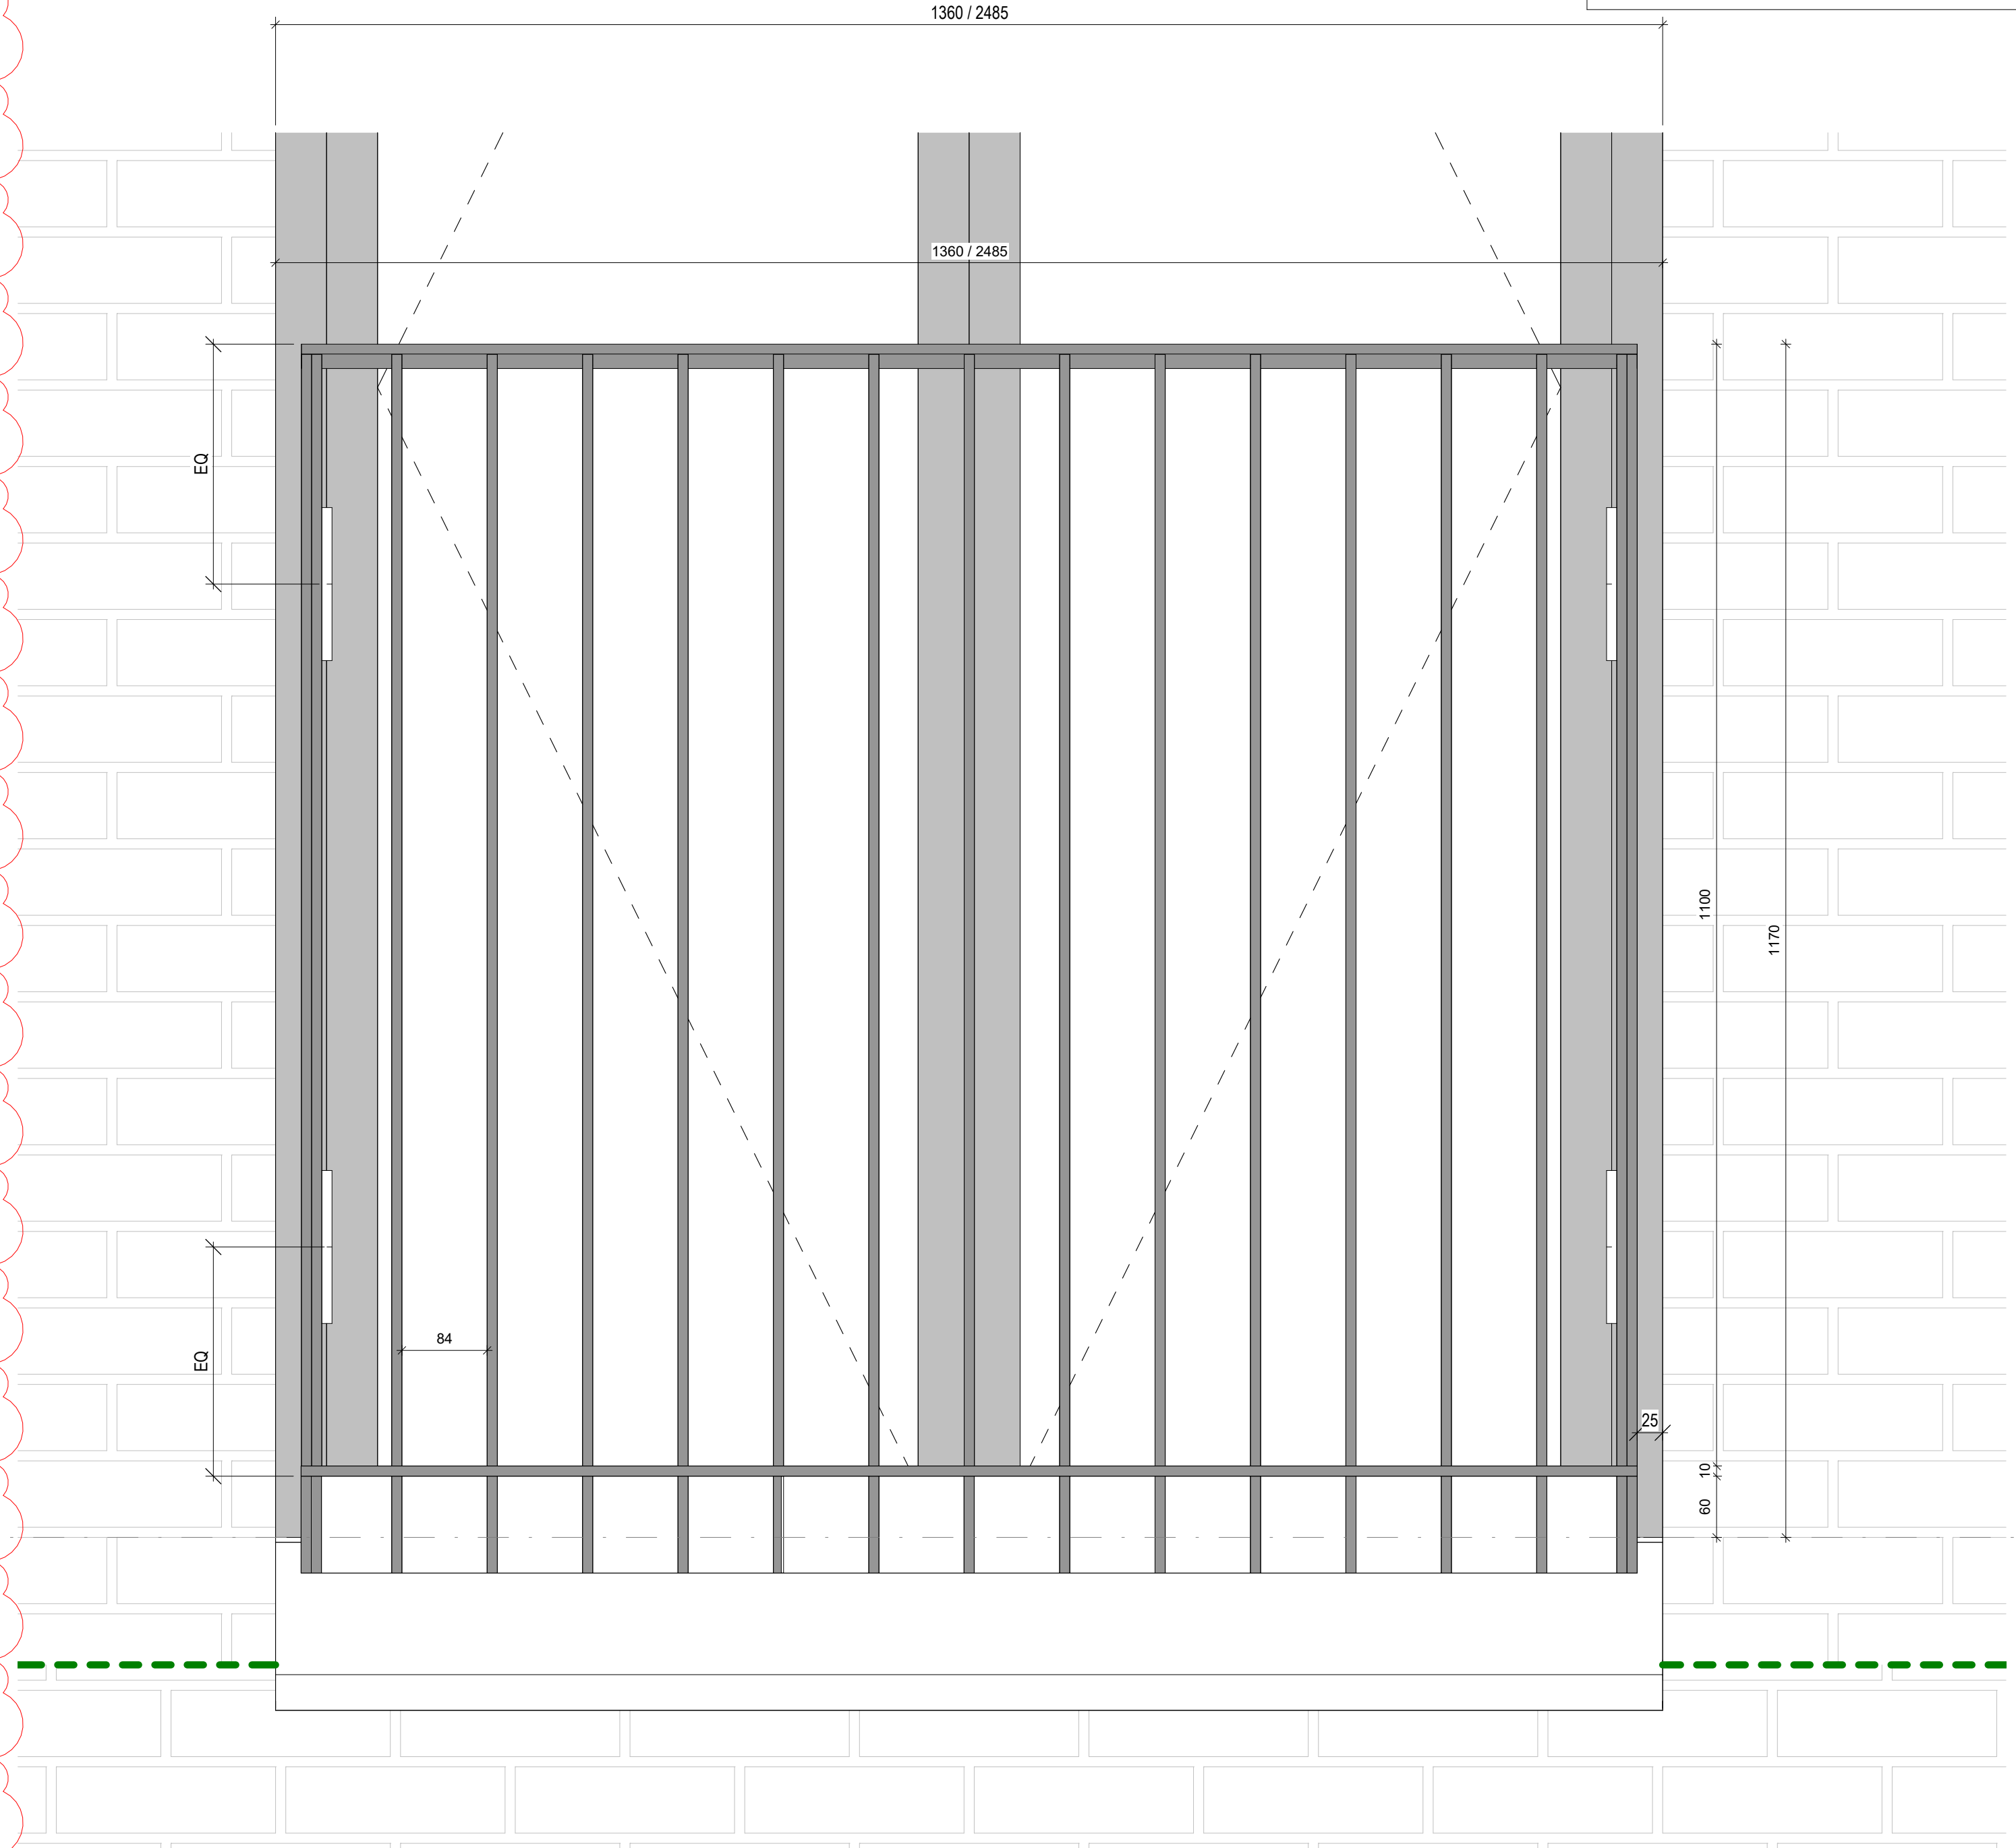

3 Balustrade Type BA - plan detail

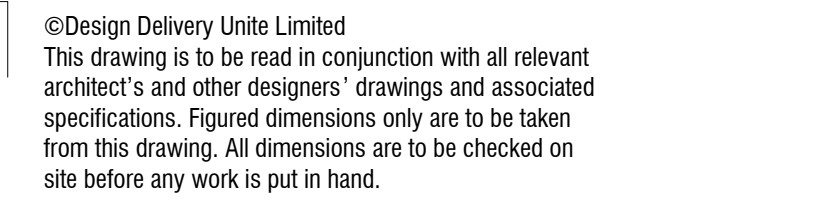

- Series 00 - Accommodation Schedules
- Series 00 - NBS Specification
- Series 02 - Conveyance Plans
- Series 03 - GA Plans, GA Setting out Plans & Marketing Plans
- Series 04 - GA Sections
- Series 05 - GA Elevations
- Series 06 - Stage 2 Drawings
- Series 07 - Bay Studies
- Series 09 - 3D Views
- Series 16 - Substructure
- Series 20 - Superstructure
- Series 21 - External Wall Types & Details
- Series 22 - Internal Wall Types & Details
- Series 23 - Floor Types & Details
- Series 24 - Staircases & Lifts
- Series 27 - Roof Types & Details
- Series 31 - Window & Doors Types, Details & Schedules
- Series 35 - Reflected Ceiling Plans
- Series 36 - Balconies & External Metalwork
- Series 40 - Internal Finishes
- Series 43 - Floor Finishes
- Series 60 - Electrical Plans
- Series 67 - Fire Strategy Plans
- Series 70 - Flat Type Layouts
- Series 71 - Signage Plans
- Series 73 - Kitchen Layouts & Schedules
- Series 74 - Bathroom Layouts & Schedules
- Series 79 - Residents Facilities
- Series 82 - Commercial Units
- Series 83 - Offices

| | | | | |
|----------|---|----------|-------|---------|
| C03 | Updated Metalwork Issue | 05.09.23 | CS | JR |
| C02 | Amended to Client change to Window system | 26.07.23 | CS | ACS |
| C01 | Construction Issue | 30.06.23 | CS | ACS |
| Revision | Description | Date | Drawn | Checked |

77 Endell Street
London WC2H 9DZ
T +44 (0)20 7240 7766
W designdeliveryunit.com



Drawing Title

Building B Balustrade Details Type Ba

| Client Project Code | Originator | Volume | Level | Type | Role | Number |
|-----------------------------------|------------|--------|-------|------|------|--------|
| CGYB0-DDU-B0-ZZ-DR-A-36120 | | | | | | |

| Description | Rev |
|--------------|-----|
| CONSTRUCTION | C03 |