


1 Cladding Bay Study 03 - Dependent 1  
 1:20

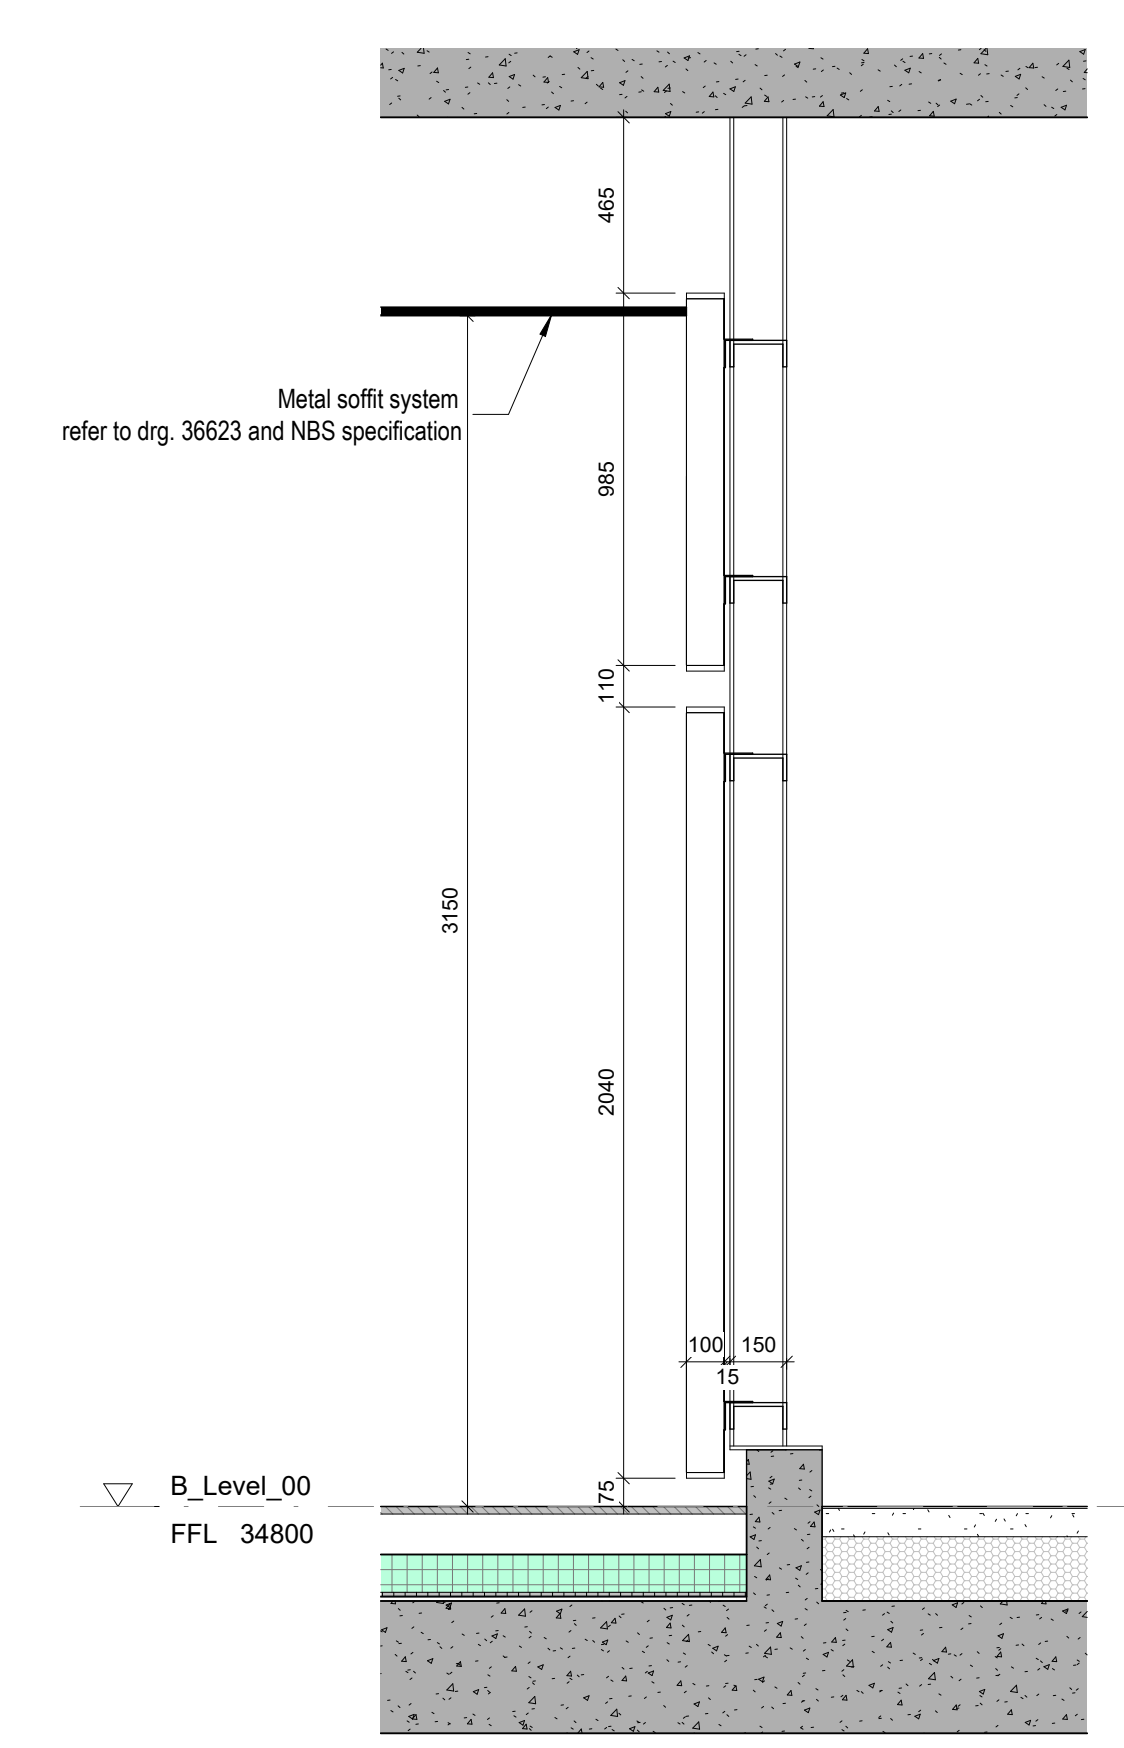

3 Cladding Bay Study 03 Section  
 1:20

**DRAWING SERIES**

- Series 00 - Accommodation Schedules
- Series 00 - NBS Specification
- Series 02 - Conveyance Plans
- Series 03 - GA Plans, GA Setting out Plans & Marketing Plans
- Series 04 - GA Sections
- Series 05 - GA Elevations
- Series 06 - Stage 2 Drawings
- Series 07 - Bay Studies
- Series 09 - 3D Views
- Series 16 - Substructure
- Series 24 - Staircases & Lifts
- Series 21 - External Wall Types & Details
- Series 22 - Internal Wall Types & Details
- Series 26 - Balconies & Lincs
- Series 27 - Roof Types & Details
- Series 31 - Window & Doors Types, Details & Schedules
- Series 35 - Reflected Ceiling Plans
- Series 35 - Floor Types & Details
- Series 36 - Balconies & External Metalwork
- Series 43 - Internal Finishes
- Series 43 - Floor Finishes
- Series 60 - Electrical Plans
- Series 67 - Fire Strategy Plans
- Series 70 - Flat Type Layouts
- Series 71 - Garage Plans
- Series 73 - Kitchen Layouts & Schedules
- Series 74 - Bathroom Layouts & Schedules
- Series 79 - Residents Facilities
- Series 82 - Commercial Units
- Series 83 - Offices
- Series 84 - Area Plans

**GENERAL NOTES**

**STRUCTURAL** - For design, detailing and setting out of structural elements refer to Structural Engineers drawings.


**SERVICES** - For design, detailing and setting out of services, including SVTs, Gas, Water, Electrical & Telecoms etc refer to M&E Engineers and Structural Engineers drawings.

All information on this drawing must be read in conjunction with relevant series and specifications.

Refer to WMS Development Agreement for Acoustic Louvre Screen requirements

Note: All steel sizes are indicative and subject to specialist design

Refer to:  
 03 Series Cladding plans for scoping extent,  
 35 Series SW soffit plans (insulation & metalwork),  
 35 Series for metalwork details &  
 DDU / TFS NBS specification for metalwork elements

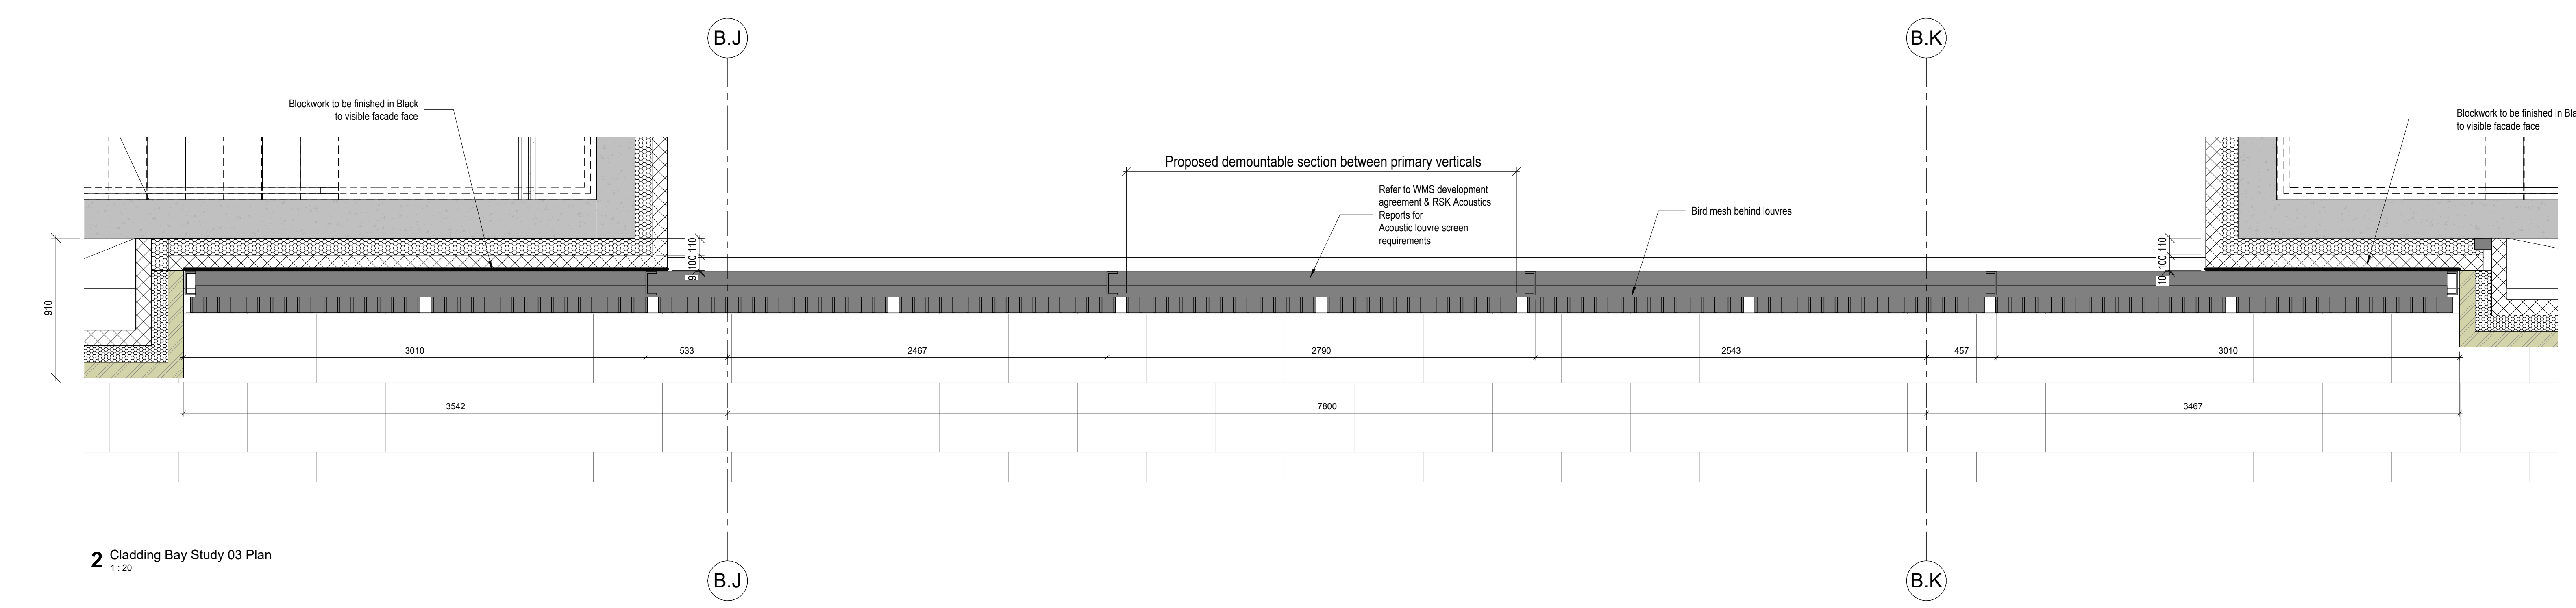

2 Cladding Bay Study 03 Plan  
 1:20

Revision	Description	Date	Drawn	Checked
C02	Updated Metalwork Issue	05.09.23	CS	JR
C01	Construction Issue	30.06.23	CS	ACS

**design delivery unit**

77 Endell Street  
 London WC2H 9DZ  
 T +44 (0)20 7240 7766  
 W designdeliveryunit.com

Client's Name  
**St George North London Limited**



Job Title  
**Camden Goods Yard**

Drawing Title  
**Building B Metalwork Level 00 Walkway Screen**

Scale  
**As indicated @A0** Punch/Project No.  
20226

Punch/Project No.	Original	Issue	Level	Type	Rev	Number
<b>CGYB0-DDU-80-00-DR-A-36829</b>						

Description  
**CONSTRUCTION** Rev  
C02