

Brickwork and Blockwork

For elements of facade refer to hyperlinks with specification document.

CGY00-PTA-XXX-XX-SP-AR-00010

Ss\_25\_13\_50\_51  
00 - Masonry wall leaf systems Type A - Facing Brickwork

©Design Delivery Unite Limited  
This drawing is to be read in conjunction with all relevant architect's and other designers' drawings and associated specifications. Figured dimensions only are to be taken from this drawing. All dimensions are to be checked on site before any work is put in hand.

DRAWING SERIES

Series 00 - Accommodation Schedules  
Series 00 - NBS Specification  
Series 02 - Conveyance Plans  
Series 03 - GA Plans, GA Setting out Plans & Marketing Plans  
Series 04 - GA Sections  
Series 05 - GA Elevations  
Series 06 - Stage 2 Drawings  
Series 07 - Bay Studies  
Series 09 - 3D Views  
Series 16 - Substructure  
Series 20 - Superstructure  
Series 21 - External Wall Types & Details  
Series 22 - Internal Wall Types & Details  
Series 23 - Floor Types & Details  
Series 24 - Staircases & Lifts  
Series 27 - Roof Types & Details  
Series 31 - Window & Doors Types, Details & Schedules  
Series 35 - Reflected Ceiling Plans  
Series 36 - Balconies & External Metalwork  
Series 40 - Internal Finishes  
Series 43 - Floor Finishes  
Series 60 - Electrical Plans  
Series 67 - Fire Strategy Plans  
Series 70 - Flat Type Layouts  
Series 71 - Signage Plans  
Series 73 - Kitchen Layouts & Schedules  
Series 74 - Bathroom Layouts & Schedules  
Series 79 - Residents Facilities  
Series 82 - Commercial Units  
Series 83 - Offices

C02	Amended to Client change to Window system	26.07.23	CS	ACS
C01	CONSTRUCTION ISSUE	24.02.23	CS	ACS
Revision	Description	Date	Drawn	Checked

design  
delivery  
unit

77 Endell Street  
London WC2H 9DZ  
T +44 (0)20 7240 7766  
W designdeliveryunit.com

Client's Name  
St George North London Limited



Job Title  
Camden Goods Yard


Drawing Title  
Building B Bay Details Call-Outs Sheet1

Scale  
1 : 5 @A1


Practice Project No.  
20226

Client Project Code	Originator	Volume	Level	Type	Role	Number
CGYB0-DDU-B0-ZZ-DR-A-07130						
Description						Rev
CONSTRUCTION						C02

Previous Drawing Number  
CGYB0 - PTA - ZZZ - ZZ - DR - A - 07130  
Last Revision  
P1, Preliminary Issue, 20.06.22

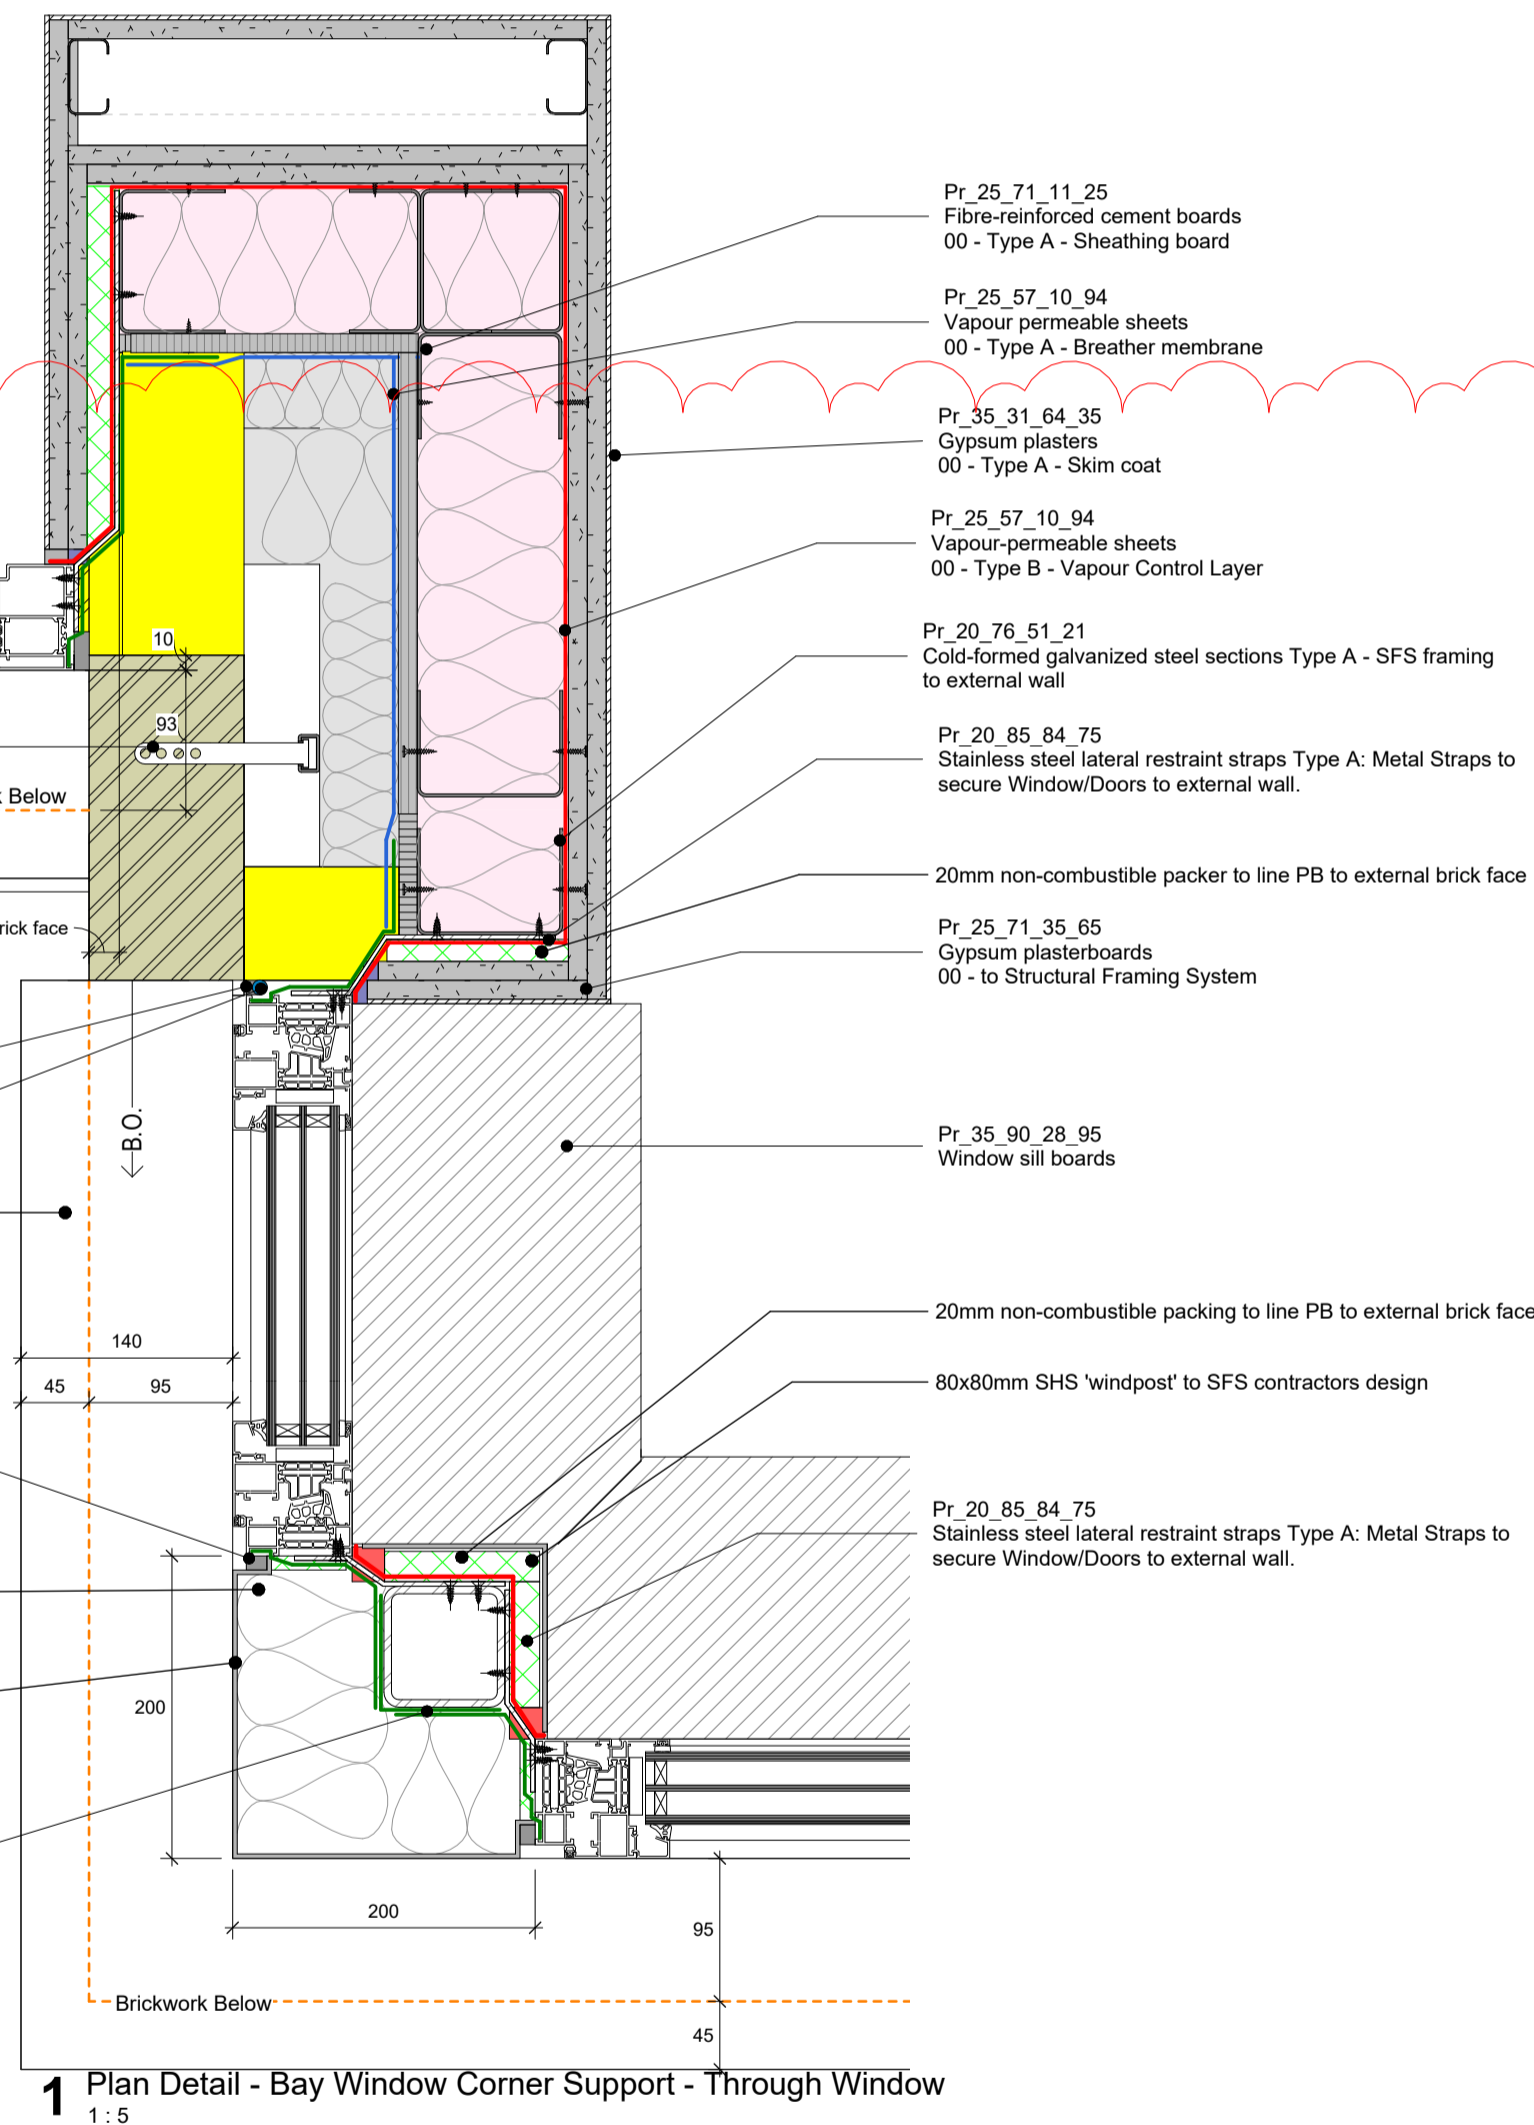

1 Plan Detail - Bay Window Corner Support - Through Window  
1 : 5

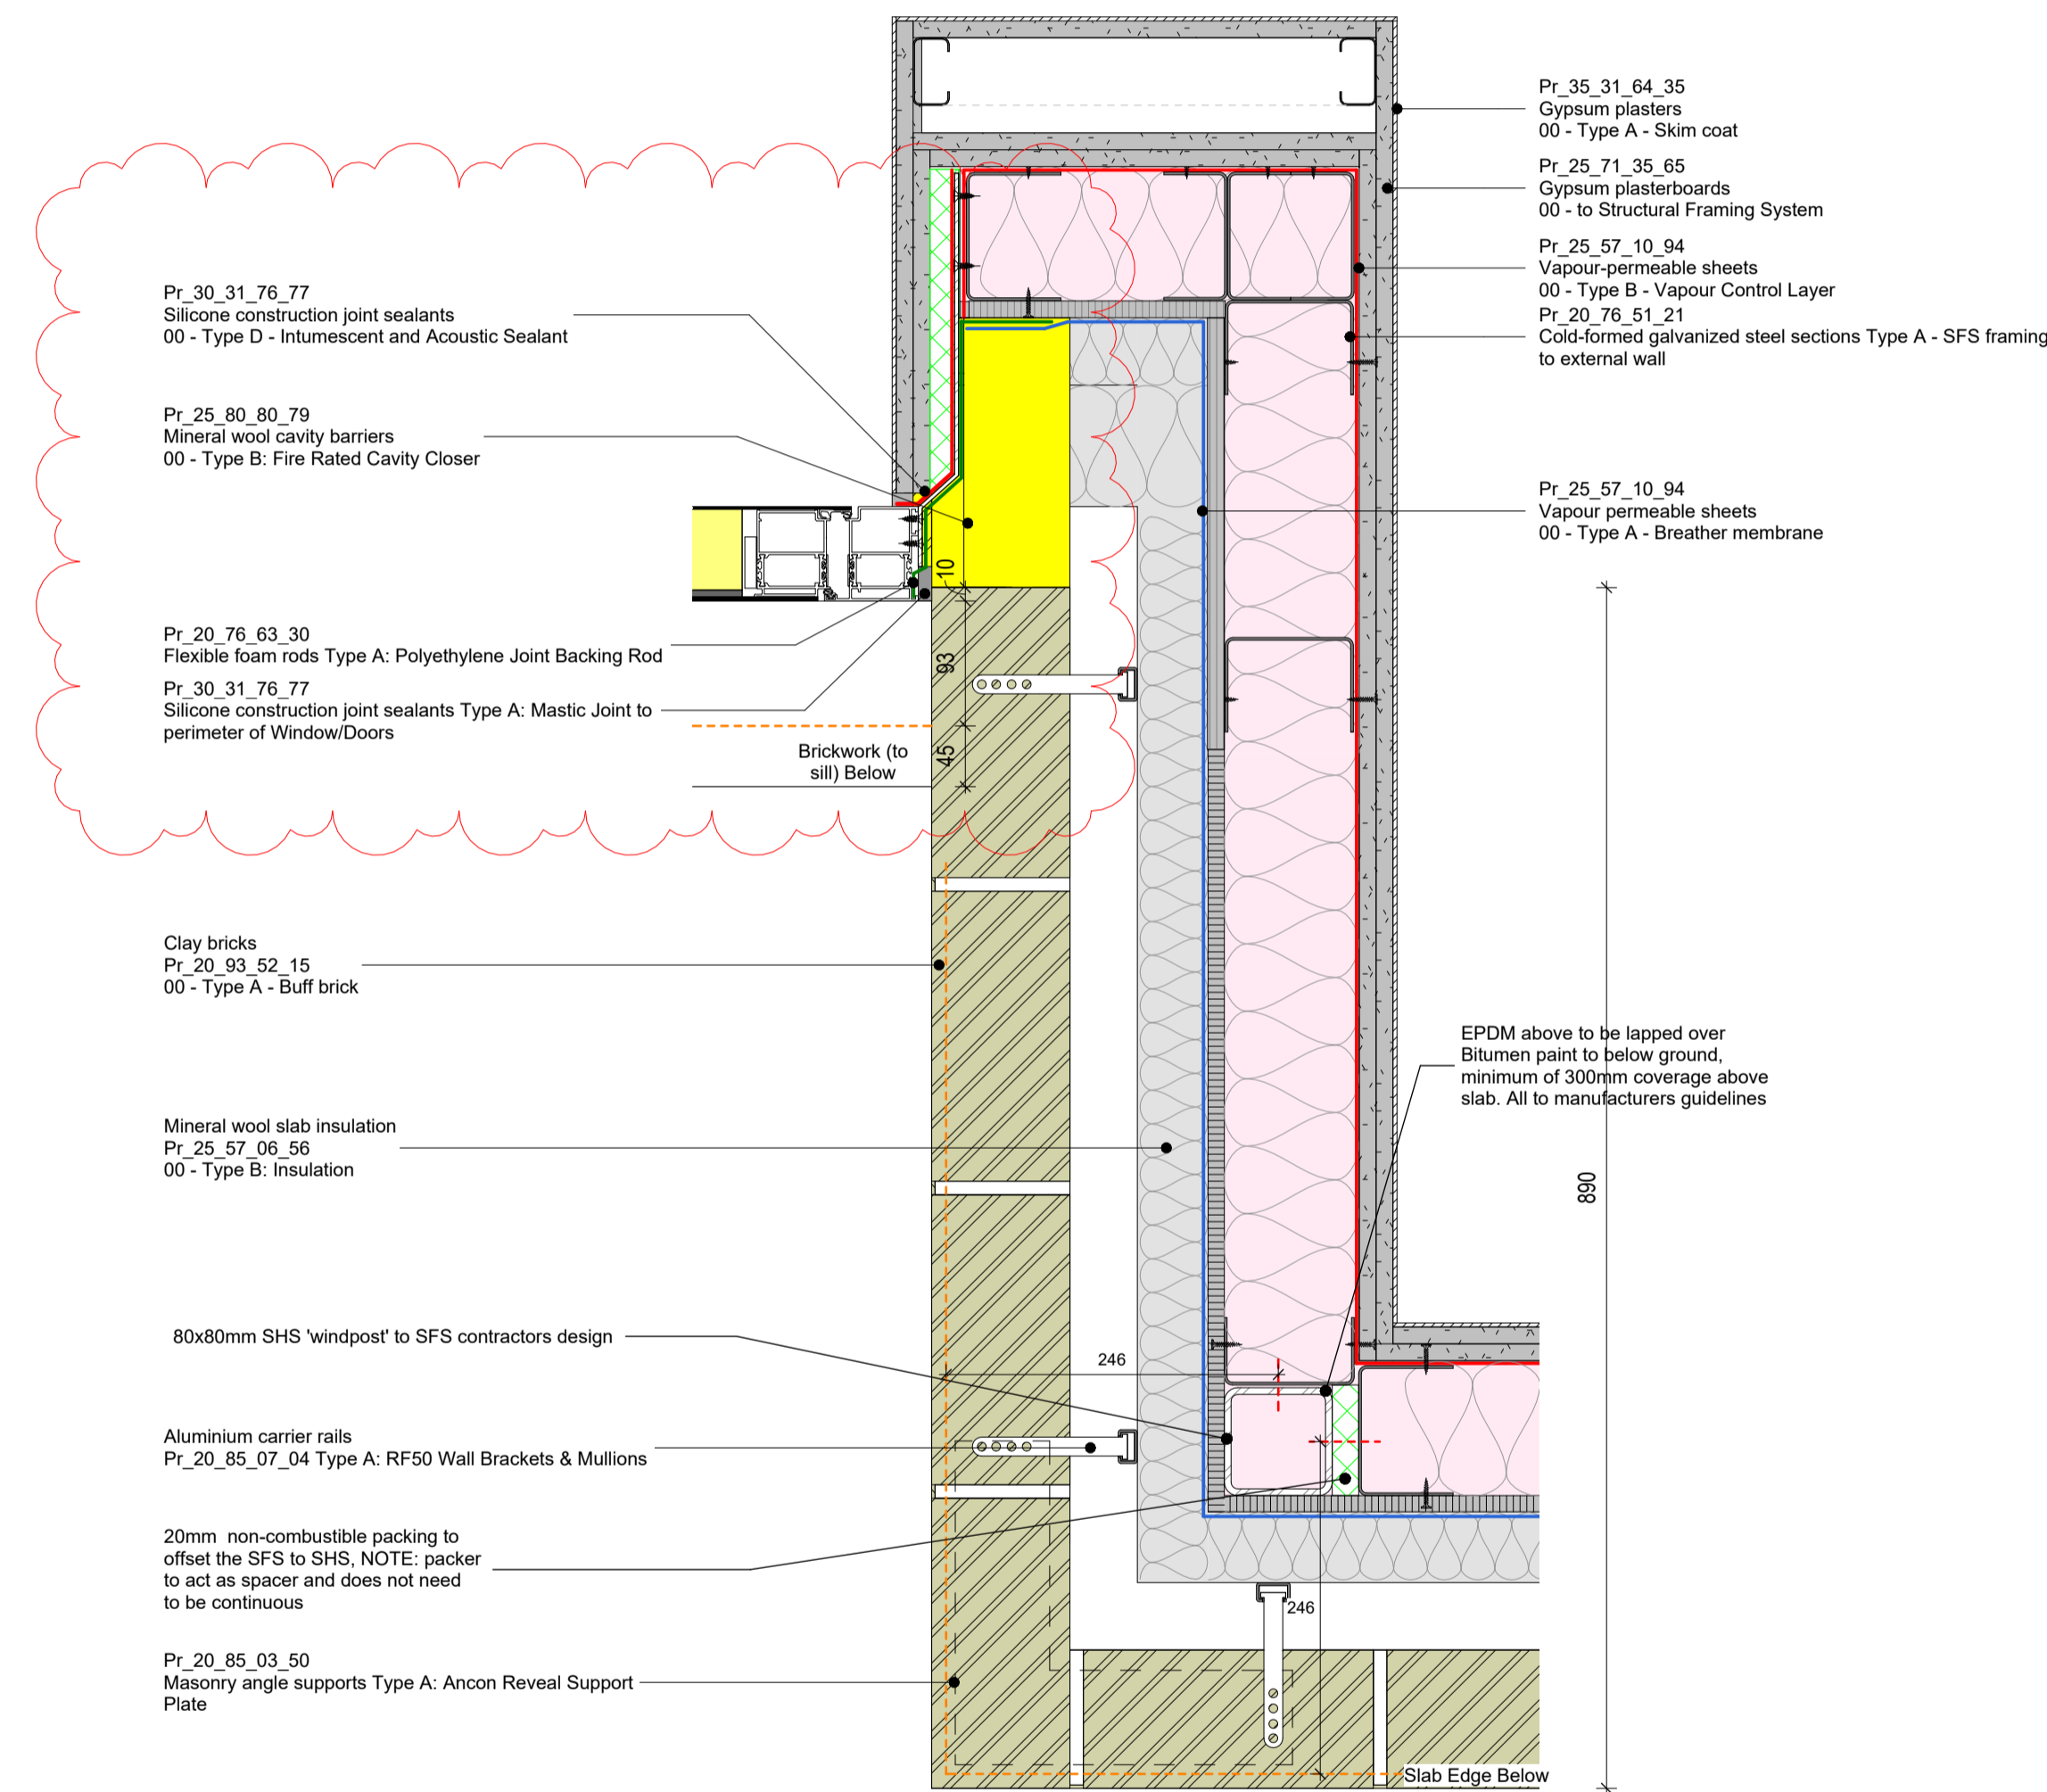

2 Plan Detail - Bay Window Corner Support - Below Window  
1 : 5