

- DRAWING SERIES**
- Series 00 - Accommodation Schedules
 - Series 00 - NBS Specification
 - Series 02 - Conveyance Plans
 - Series 03 - GA Plans, GA Setting out Plans & Marketing Plans
 - Series 04 - GA Sections
 - Series 05 - GA Elevations
 - Series 06 - Stage 2 Drawings
 - Series 07 - Bay Studies
 - Series 08 - 3D Views
 - Series 16 - Substructure
 - Series 20 - Superstructure
 - Series 21 - External Wall Types & Details
 - Series 22 - Internal Wall Types & Details
 - Series 24 - Staircases & Lifts
 - Series 27 - Roof Types & Details
 - Series 31 - Window & Door Types, Details & Schedules
 - Series 35 - Reflected Ceiling Plans
 - Series 35 - Floor Types & Details
 - Series 35 - Balconies & External Metalwork
 - Series 43 - Internal Finishes
 - Series 43 - Floor Finishes
 - Series 60 - Electrical Plans
 - Series 67 - Fire Strategy Plans
 - Series 70 - Flat Type Layouts
 - Series 71 - Signage Plans
 - Series 73 - Kitchen Layouts & Schedules
 - Series 74 - Bathroom Layouts & Schedules
 - Series 79 - Residents Facilities
 - Series 82 - Commercial Units
 - Series 83 - Offices
 - Series 84 - Area Plans

GENERAL NOTES

STRUCTURAL - For design, detailing and setting out of structural elements refer to Structural Engineers drawings.

SERVICES - For design, detailing & setting out of services, including SVPS, Gas, Water, Electrical & Telecoms etc refer to M&E Engineers and Structural Engineers drawings.

All information on this drawing must be read in conjunction with relevant series and specifications.

C01 Update general arrangement as discussed with Client. Growing space plant introduced, WC added. Access pantry added, drainage noted. 16.10.23 JR ACS

Revision Description Date Drawn Checked

design
delivery
unit

77 Endell Street
London WC2H 9DZ
T +44 (0)20 7240 7766
W designdeliveryunit.com

Client's Name
St George North London Limited



Job Title
Camden Goods Yard

Drawing Title
Building B Level 08 GA Plan

Scale
1 : 100 @A0


Practice Project No.
20226

Previous Drawing Number
CGYB0 - PTA - ZZZ - 08 - DR - A - 03041

Previous Revision
P5, GA set reissued, 09.03.22

Description
CONSTRUCTION

100%
© Design Delivery 2022. All rights reserved. This drawing is for design purposes only and is not to be used for construction without the written authority of Design Delivery.

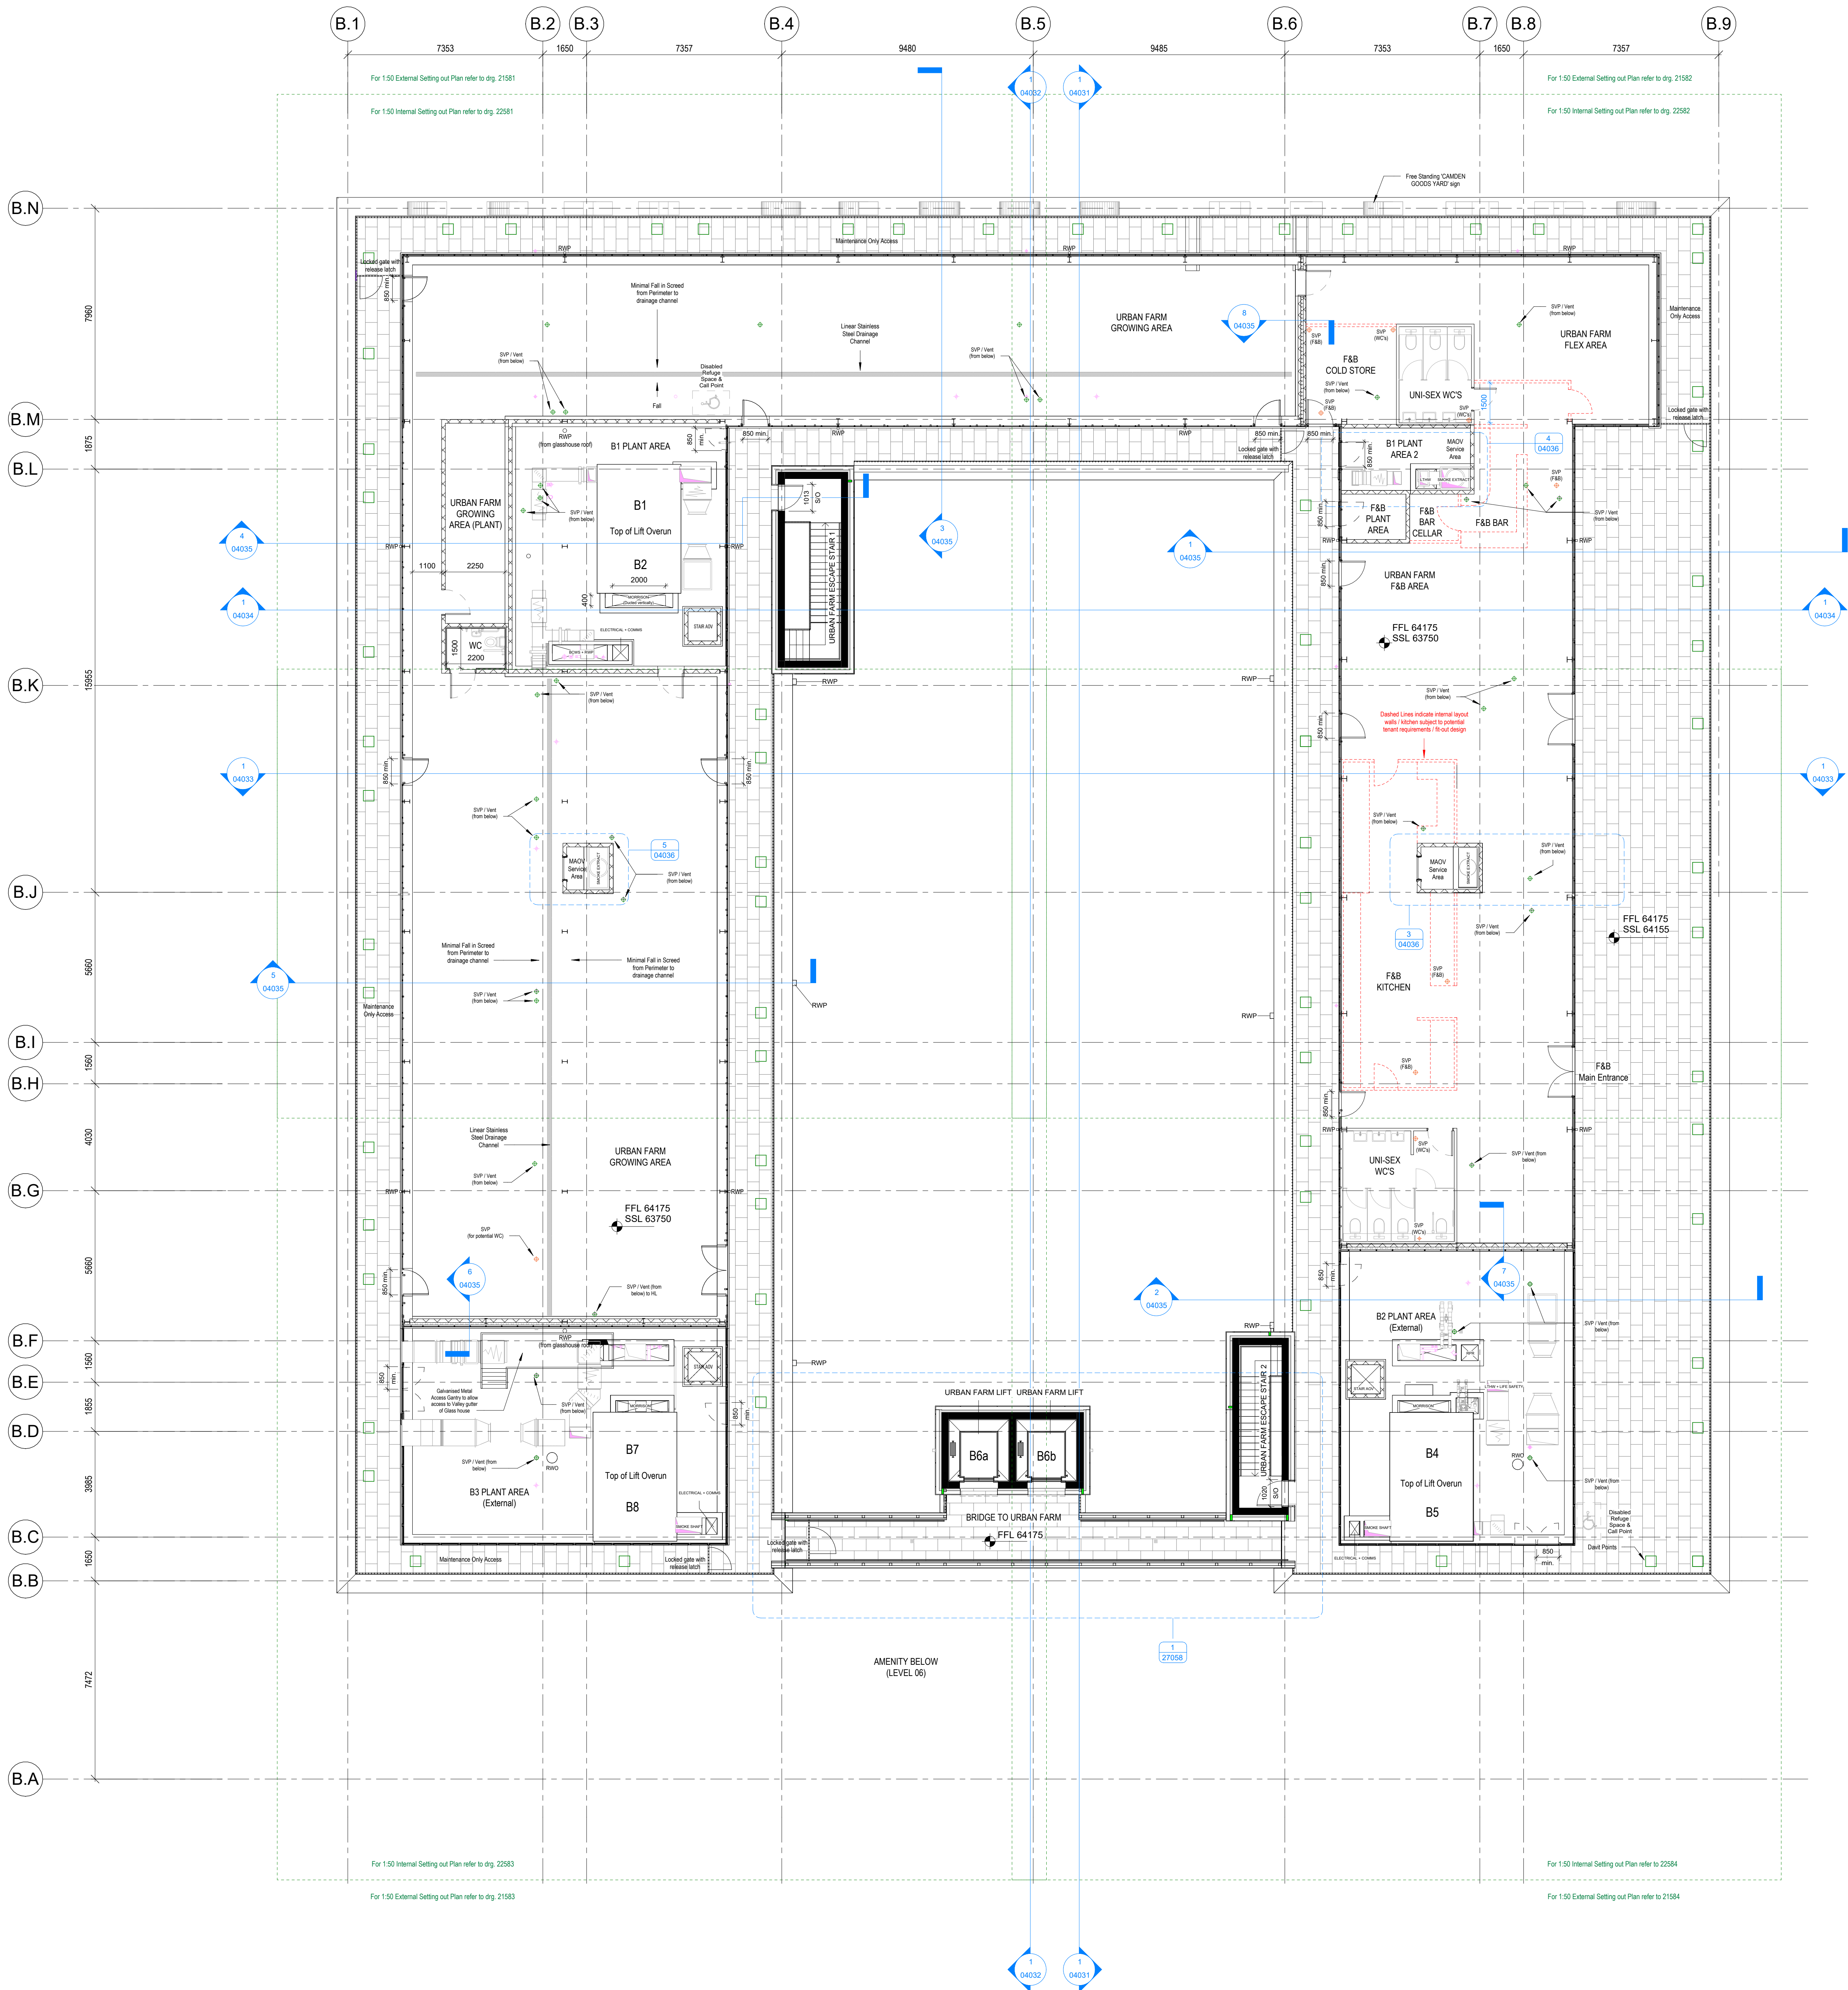

Previous Drawing Number
CGYB0 - PTA - ZZZ - 08 - DR - A - 03041

Previous Revision
P5, GA set reissued, 09.03.22

Description
CONSTRUCTION

100%
© Design Delivery 2022. All rights reserved. This drawing is for design purposes only and is not to be used for construction without the written authority of Design Delivery.