

DRAWING SERIES

Series 00 - Accommodation Schedules
Series 01 - NBS Specification
Series 02 - Conveyance Plans
Series 03 - GA Plans, GA Setting out Plans & Marketing Plans
Series 04 - GA Sections
Series 05 - GA Elevations
Series 06 - Stage 2 Drawings
Series 07 - Bay Studies
Series 08 - 3D Views
Series 16 - Substructure
Series 20 - Superstructure
Series 21 - External Wall Types & Details
Series 22 - Internal Wall Types & Details
Series 24 - Staircases & Lifts
Series 27 - Roof Types & Details
Series 31 - Window & Doors Types, Details & Schedules
Series 35 - Reflected Ceiling Plans
Series 36 - Floor Types & Details
Series 38 - Balconies & External Metalwork
Series 40 - Internal Finishes
Series 43 - Floor Finishes
Series 60 - Electrical Plans
Series 67 - Fire Strategy Plans
Series 70 - Flat Type Layouts
Series 71 - Spillage Plans
Series 73 - Kitchen Layouts & Schedules
Series 74 - Bathroom Layouts & Schedules
Series 79 - Residents Facilities
Series 82 - Commercial Units
Series 83 - Offices
Series 84 - Area Plans


GENERAL NOTES

SETTING OUT - DO NOT SCALE from this drawing, use figured dimensions ONLY. If in doubt, ASK! Dimensions are shown to structural face generally, or to finished face of ducts and lining. All dimensions are shown in millimetres unless otherwise indicated. Angular dimensions are shown in decimal degrees to the nearest whole degree. Where items are to be fabricated off-site, site dimensions are to be used and confirmed prior to ordering or manufacturing.

STRUCTURAL - For design, detailing and setting out of structural elements refer to Structural Engineers drawings.

SERVICES - For design, detailing & setting out of services, including SVPS, Gas, Water, Electrical & Telecoms etc refer to M&E Engineers and Structural Engineers drawings.

All information on this drawing must be read in conjunction with relevant series and specifications.

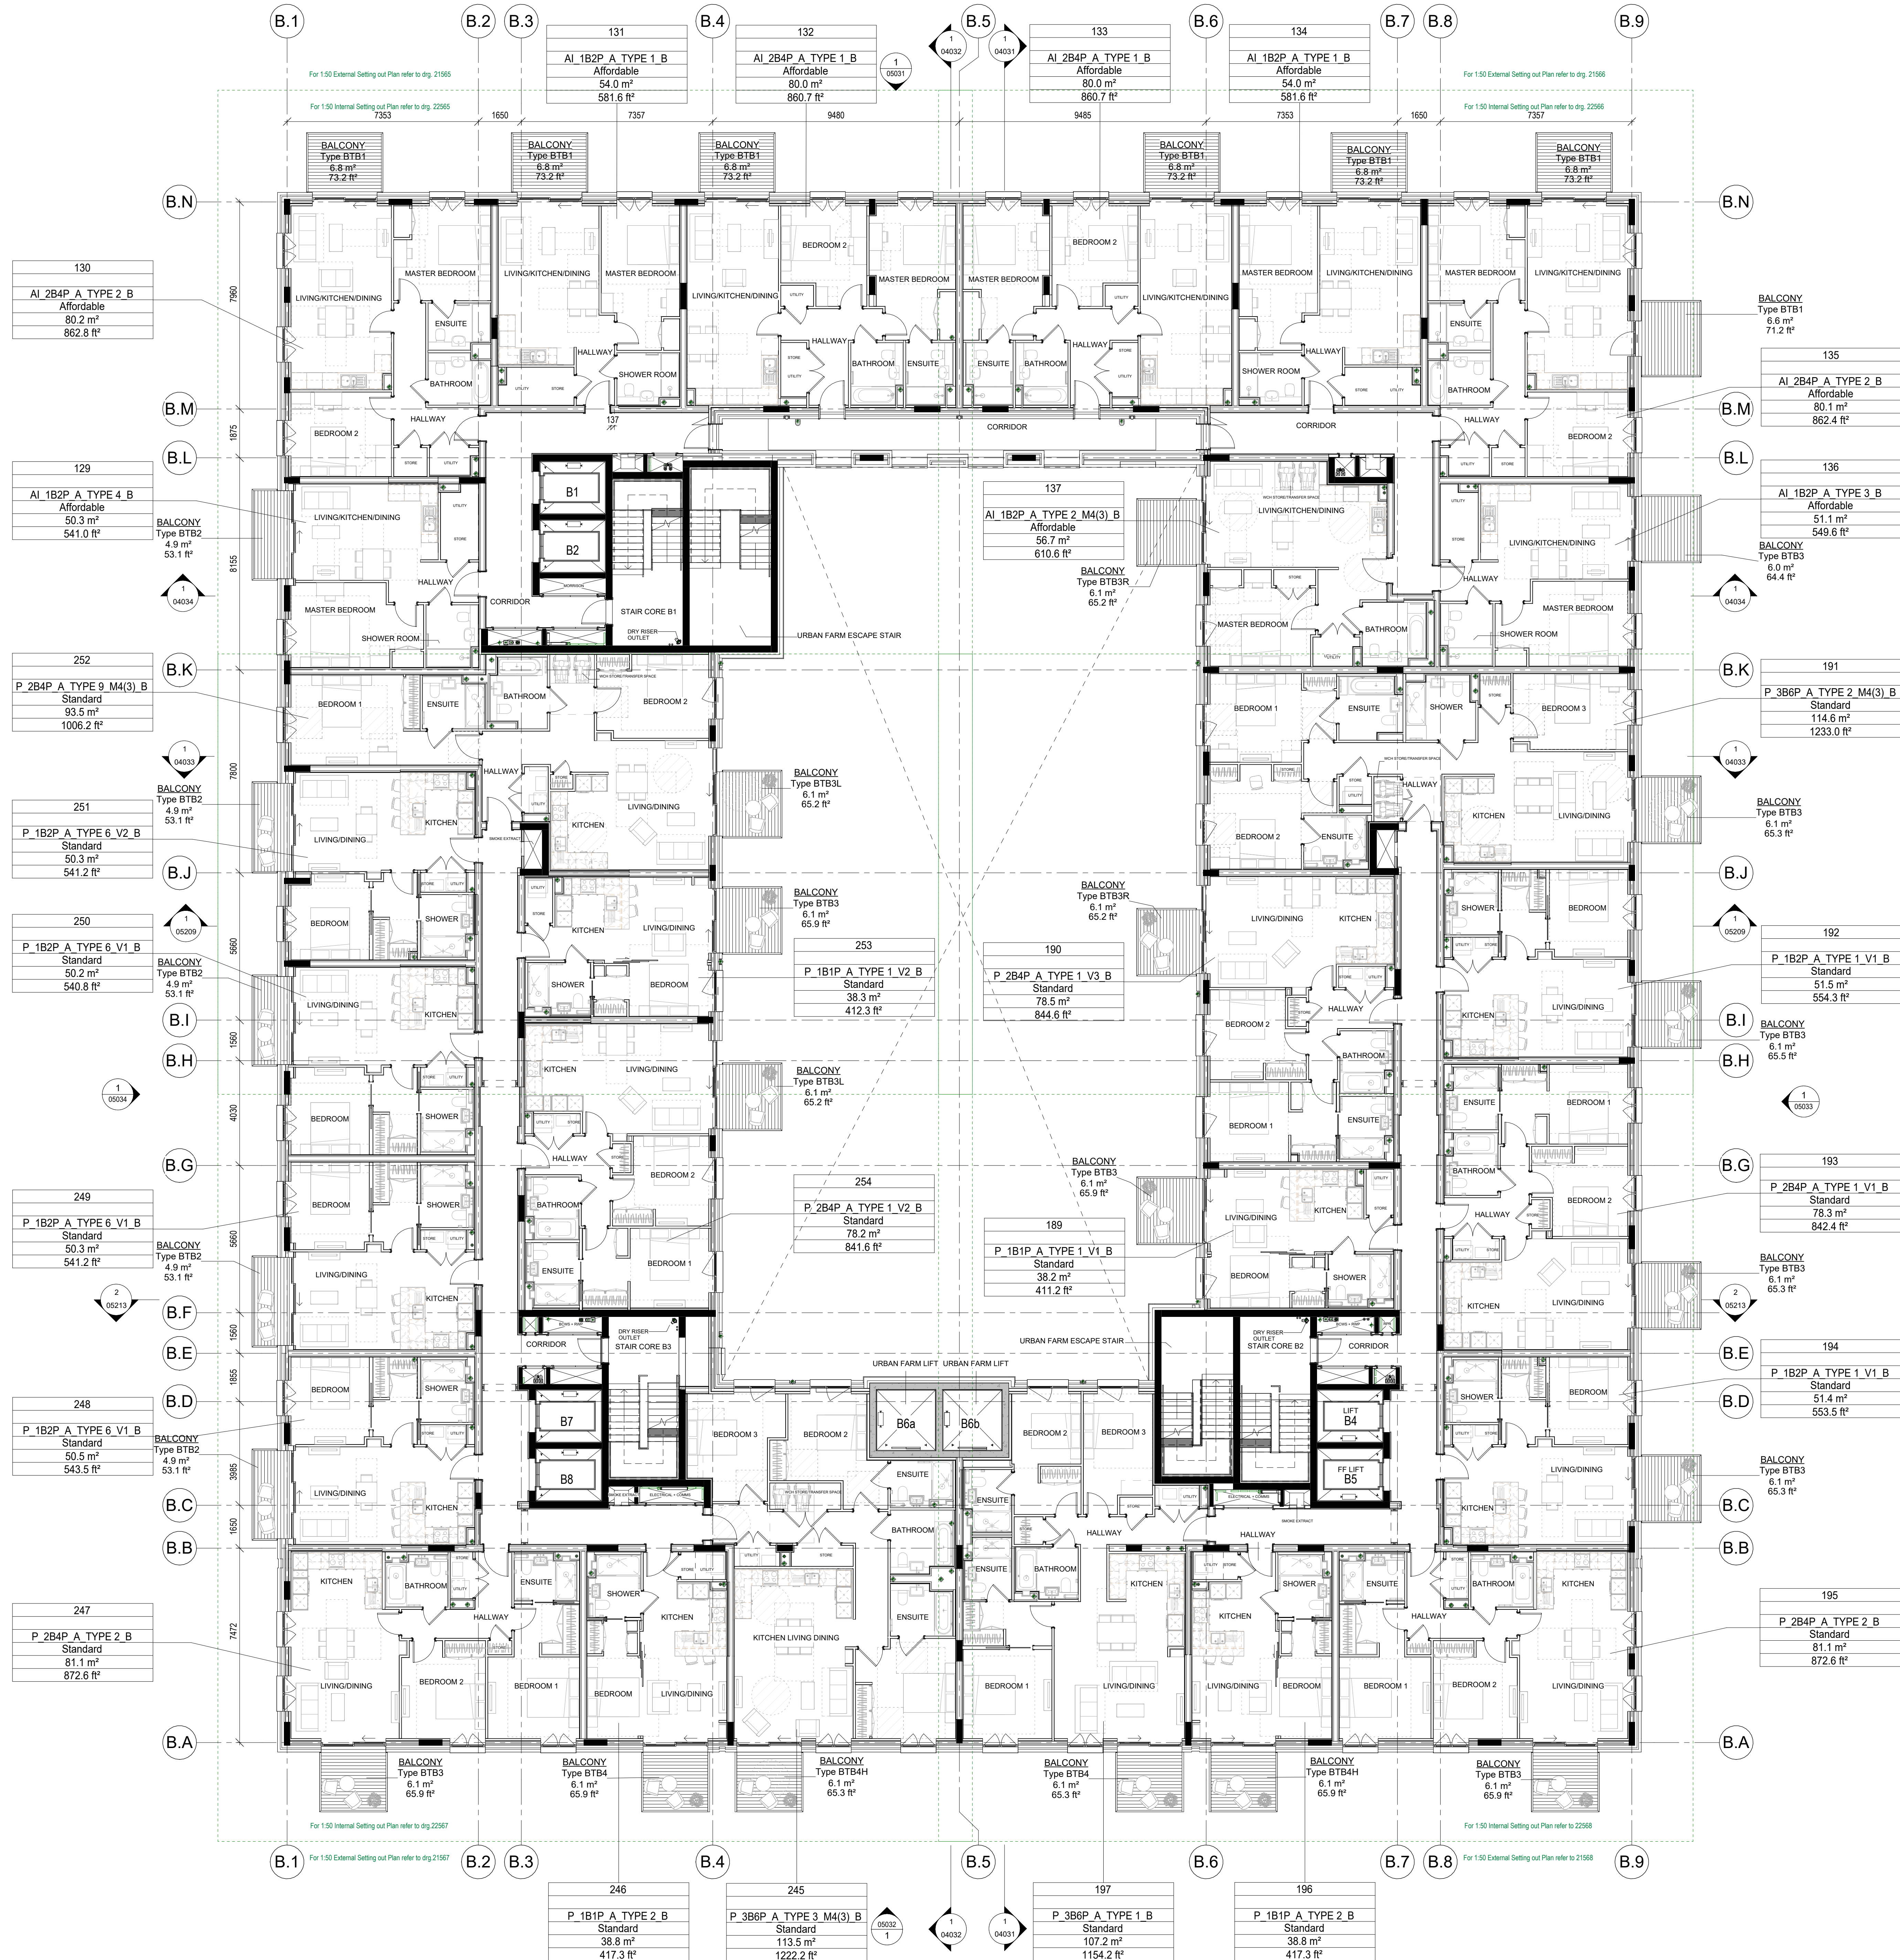

CD1	CONSTRUCTION ISSUE	02.06.23	JW	JR
Revised	Description	Date	Drawn	Checked

design
delivery
unit

77 Endell Street
London WC2H 9DZ
T +44 (0)20 7240 7766
W designdeliveryunit.com

Clients Name

St George North London Limited



Job Title

Camden Goods Yard

Drawing Title

Building B Level 04 GA Plan

Scale

1 : 100 @A0

Practice Project No.

20226

Previous Drawing Number
CCYB0 - PTA - ZZZ - 04 - DR - AR - 03037

Previous Revision
P5, Affordable Apartment layouts (Levels 2-7)
updated - GA set reissued, 09.03.22

Description
CONSTRUCTION

Rev

CD1