

- DRAWING SERIES**
- Series 00 - Accommodation Schedules
 - Series 00 - NBS Specification
 - Series 02 - Circulation Plans
 - Series 03 - GA Plans, GA Setting out Plans & Marketing Plans
 - Series 04 - GA Sections
 - Series 05 - GA Elevations
 - Series 06 - Stage 2 Drawings
 - Series 07 - Bay Studies
 - Series 08 - 3D Views
 - Series 10 - Substructure
 - Series 20 - Superstructure
 - Series 21 - External Wall Types & Details
 - Series 22 - Internal Wall Types & Details
 - Series 24 - Staircases & Lifts
 - Series 27 - Roof Types & Details
 - Series 31 - Window & Doors Types, Details & Schedules
 - Series 35 - Reflected Ceiling Plans
 - Series 36 - Floor Types & Details
 - Series 36 - Balconies & External Metalwork
 - Series 40 - Internal Finishes
 - Series 43 - Floor Finishes
 - Series 60 - Electrical Plans
 - Series 67 - Fire Strategy Plans
 - Series 70 - Flat Type Layouts
 - Series 71 - Garage Plans
 - Series 73 - Kitchen Layouts & Schedules
 - Series 74 - Bathroom Layouts & Schedules
 - Series 76 - Residents Facilities
 - Series 82 - Commercial Units
 - Series 83 - Offices
 - Series 84 - Area Plans

GENERAL NOTES


SETTING OUT - DO NOT SCALE from this drawing, use figured dimensions ONLY. If in doubt, ASK! Dimensions are shown to structural face generally, or to finished face of ducts and lining. All dimensions are shown in millimeters unless otherwise indicated. Angular dimensions are shown in decimal degrees to the nearest whole degree. Where items are to be fabricated off-site, site dimensions are to be used and confirmed prior to ordering or manufacturing.

STRUCTURAL - For design, detailing and setting out of structural elements refer to Structural Engineers drawings.

SERVICES - For design, detailing and setting out of services, including SWPs, Gas, Water, Electricals & Telecoms etc refer to M&E Engineers and Structural Engineers drawings.

All information on this drawing must be read in conjunction with relevant series and specifications.

NOTE: OFFICE/COMMERCIAL AREAS INDICATIVE ONLY.

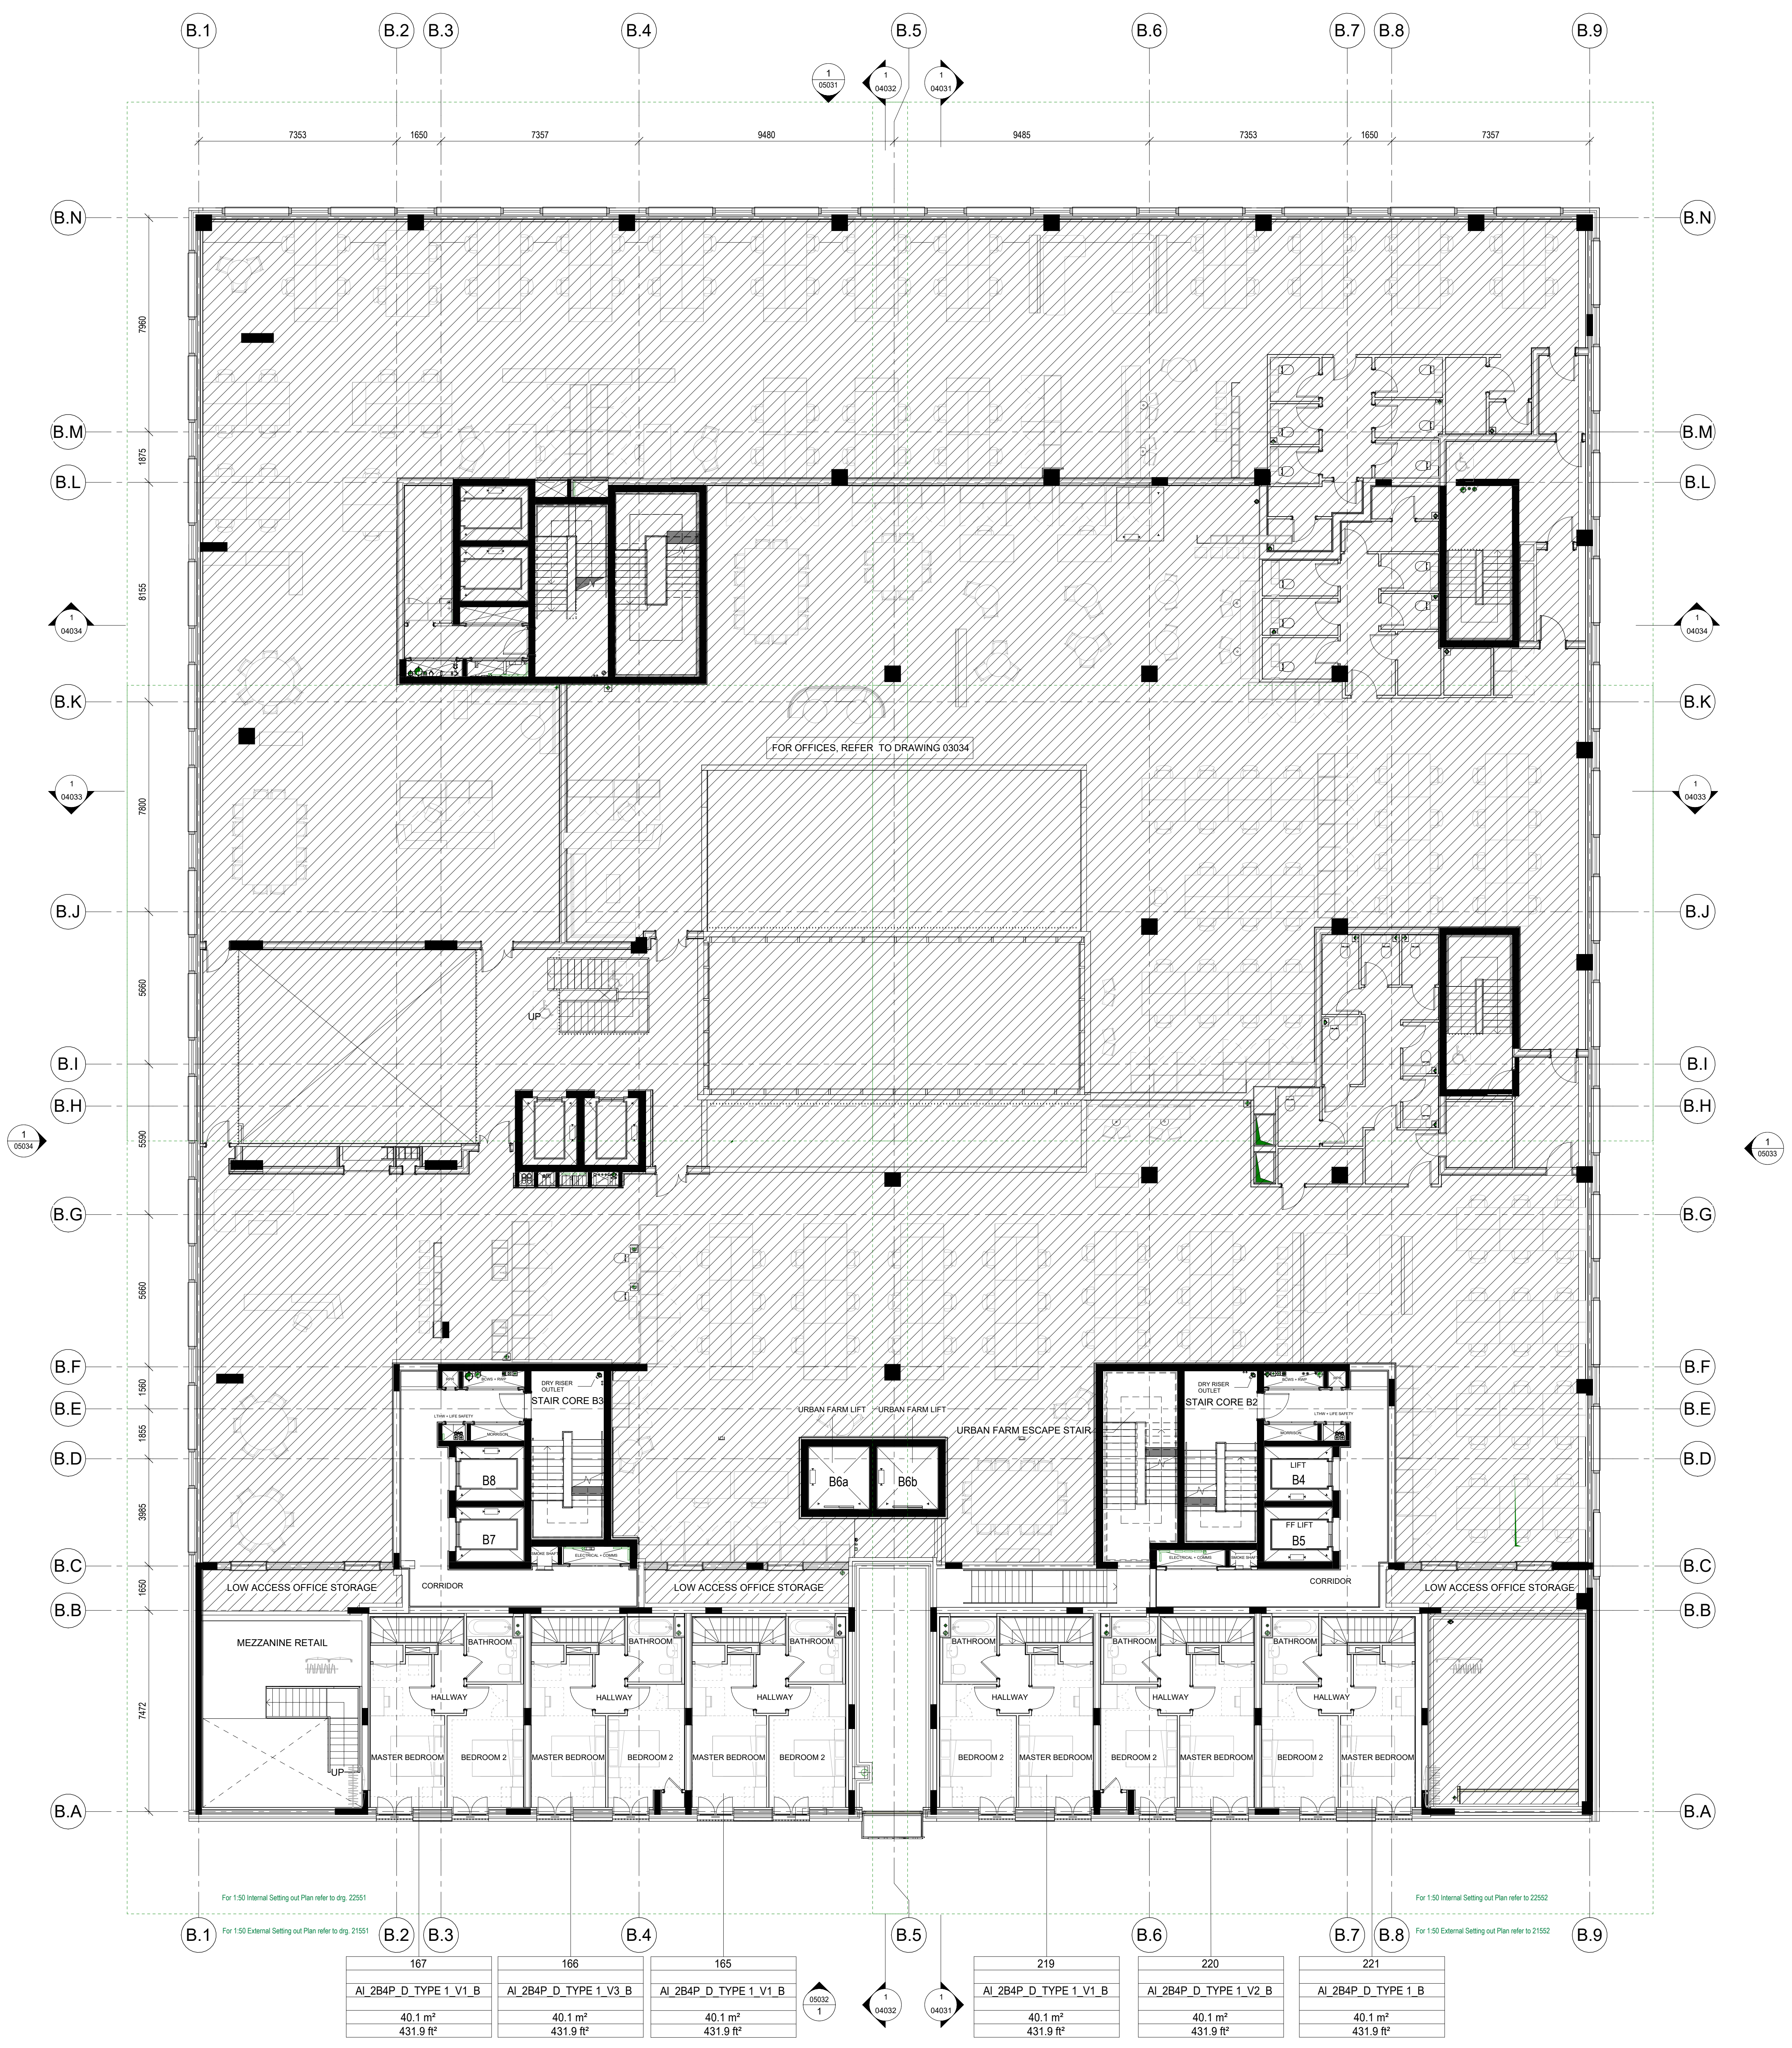

Area	Area	Area	Area	Area	Area
167	166	165	219	220	221
AI_2B4P_D_TYPE 1_V1_B	AI_2B4P_D_TYPE 1_V3_B	AI_2B4P_D_TYPE 1_V1_B	AI_2B4P_D_TYPE 1_V1_B	AI_2B4P_D_TYPE 1_V2_B	AI_2B4P_D_TYPE 1_B
40.1 m ²	40.1 m ²	40.1 m ²	40.1 m ²	40.1 m ²	40.1 m ²
431.9 ft ²	431.9 ft ²	431.9 ft ²	431.9 ft ²	431.9 ft ²	431.9 ft ²

Revision	Description	Date	Drawn	Checked
001	CONSTRUCTION ISSUE	02.06.23	JV	JR



77 Endell Street
 London WC2H 9DZ
 T +44 (0)20 7240 7766
 W designdeliveryunit.com

Client's Name
St George North London Limited



206 166
Camden Goods Yard

Drawing Title
Building B Level OM GA Plan

Scale
1 : 100 @A0

Project No.
20226

Previous Drawing Number
CGYB0 - PTA - ZZZ - OM - DR - AR - 03033

Previous Revision
P5, GA set reissued, 09.03.22

CONSTRUCTION

© design delivery unit 2022