 

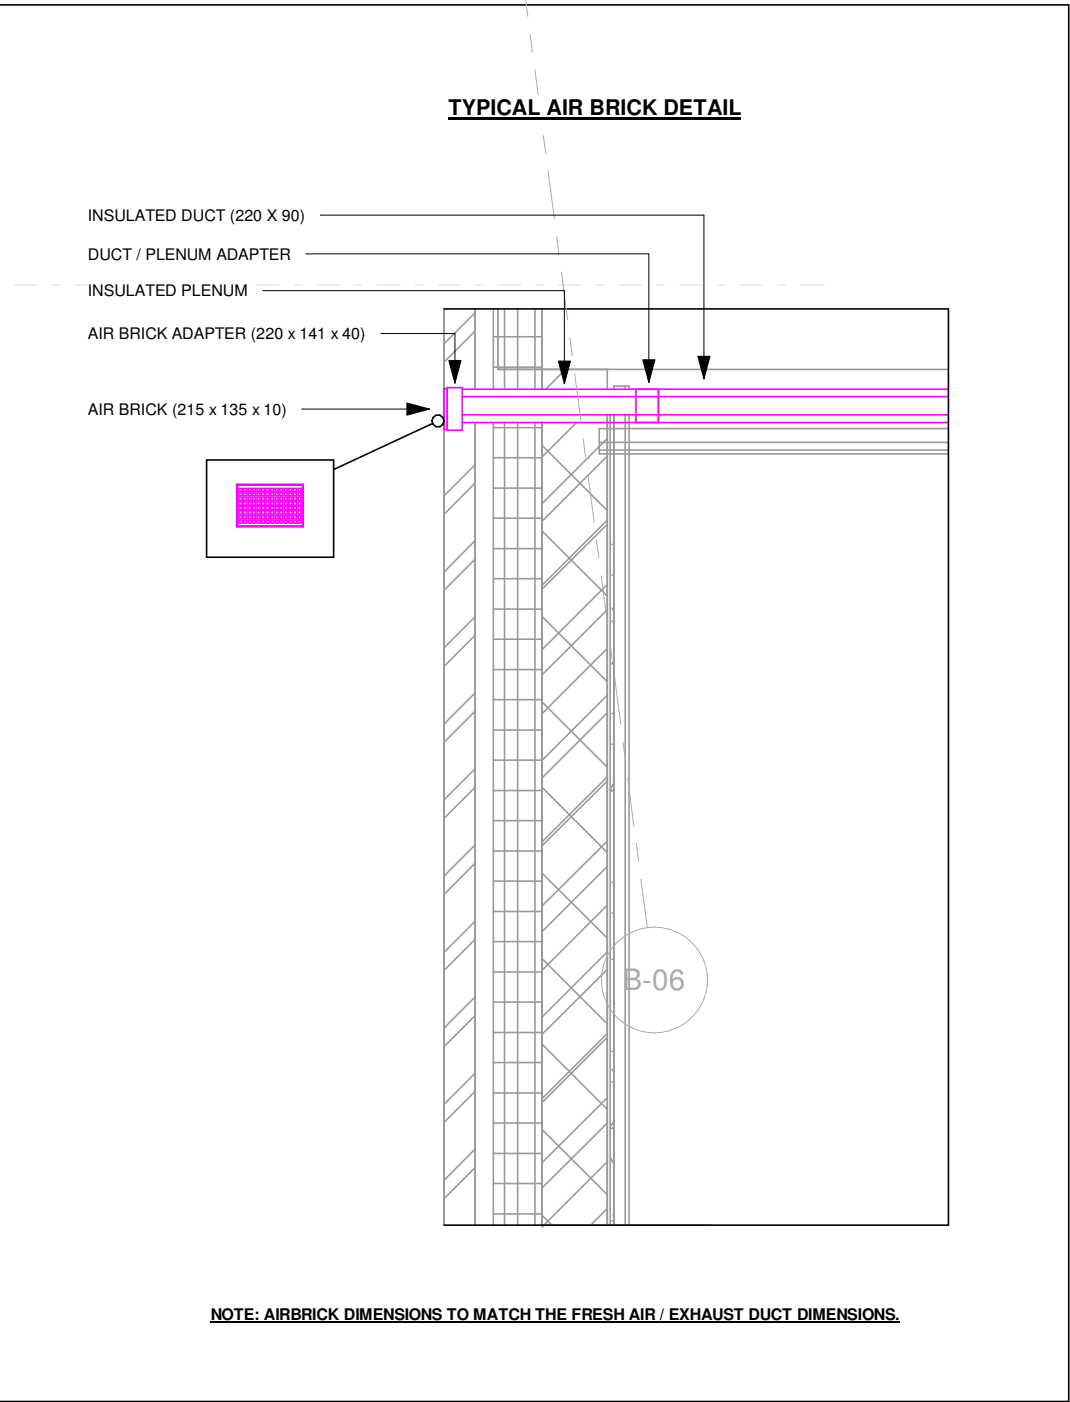


VENTILATION LEGEND

	FIRE SLEEVE
	ATTENUATOR
	SUPPLY AIR
	RETURN AIR
	EXHAUST AIR
	FRESH AIR
	30 MIN FIRE WALL
	60 MIN FIRE WALL

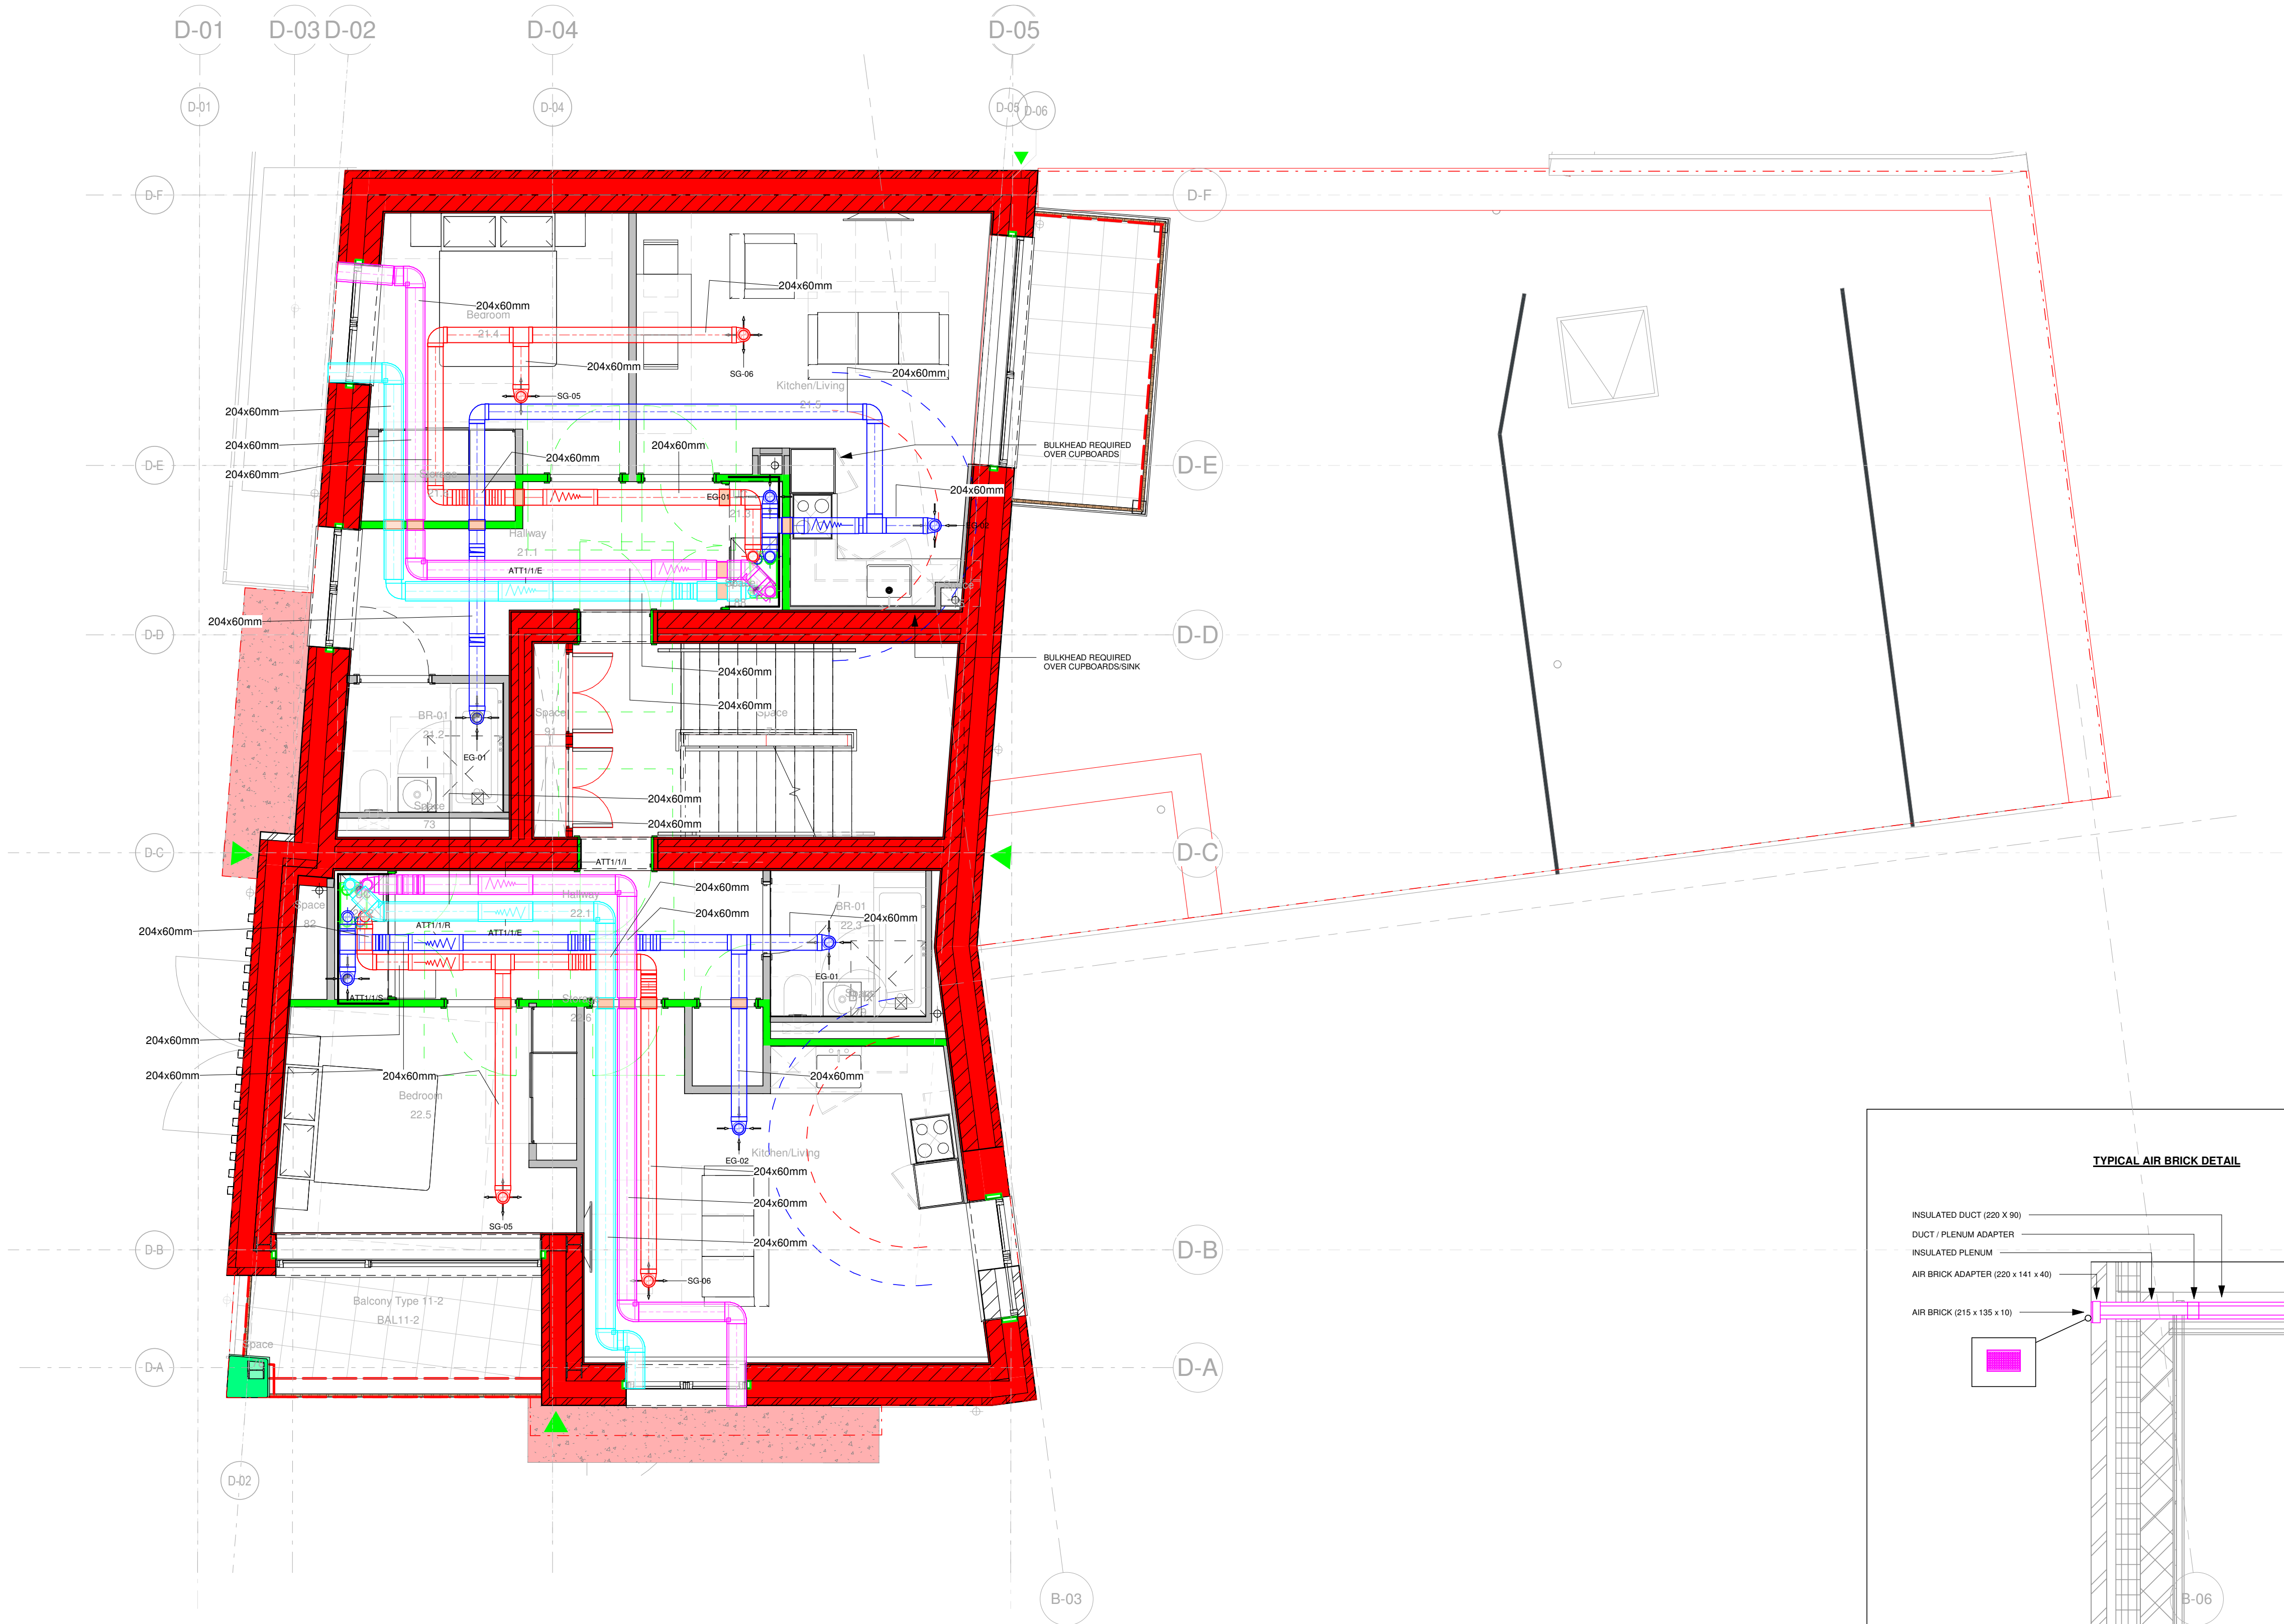

1 Vent Level 2
1:50

REV	DESCRIPTION	DRN	CKD	DATE
ISSUE	AS INSTALLED			AI

Harvey

FIRST CLASS SERVICES



semple mckillop

NATURALLY INNOVATIVE CONSULTING ENGINEERS



ISO 9001
ISO 14001
OHSAS 18001
Registered

Belfast +44 (0)28 90331700
Castleblayney +353 (0)42 9749570
www.semplemckillop.com
admin@semplemckillop.com

PROJECT TITLE
HIGHGATE NEWTOWN COMMUNITY CENTRE - BLOCK D

DRAWING TITLE
VENTILATION INSTALLATION
SECOND FLOOR

DRAWING REFERENCE
HNC-SMK-D-02-DR-M-5401

DRN
KB

SCALE
A1 As indicated