












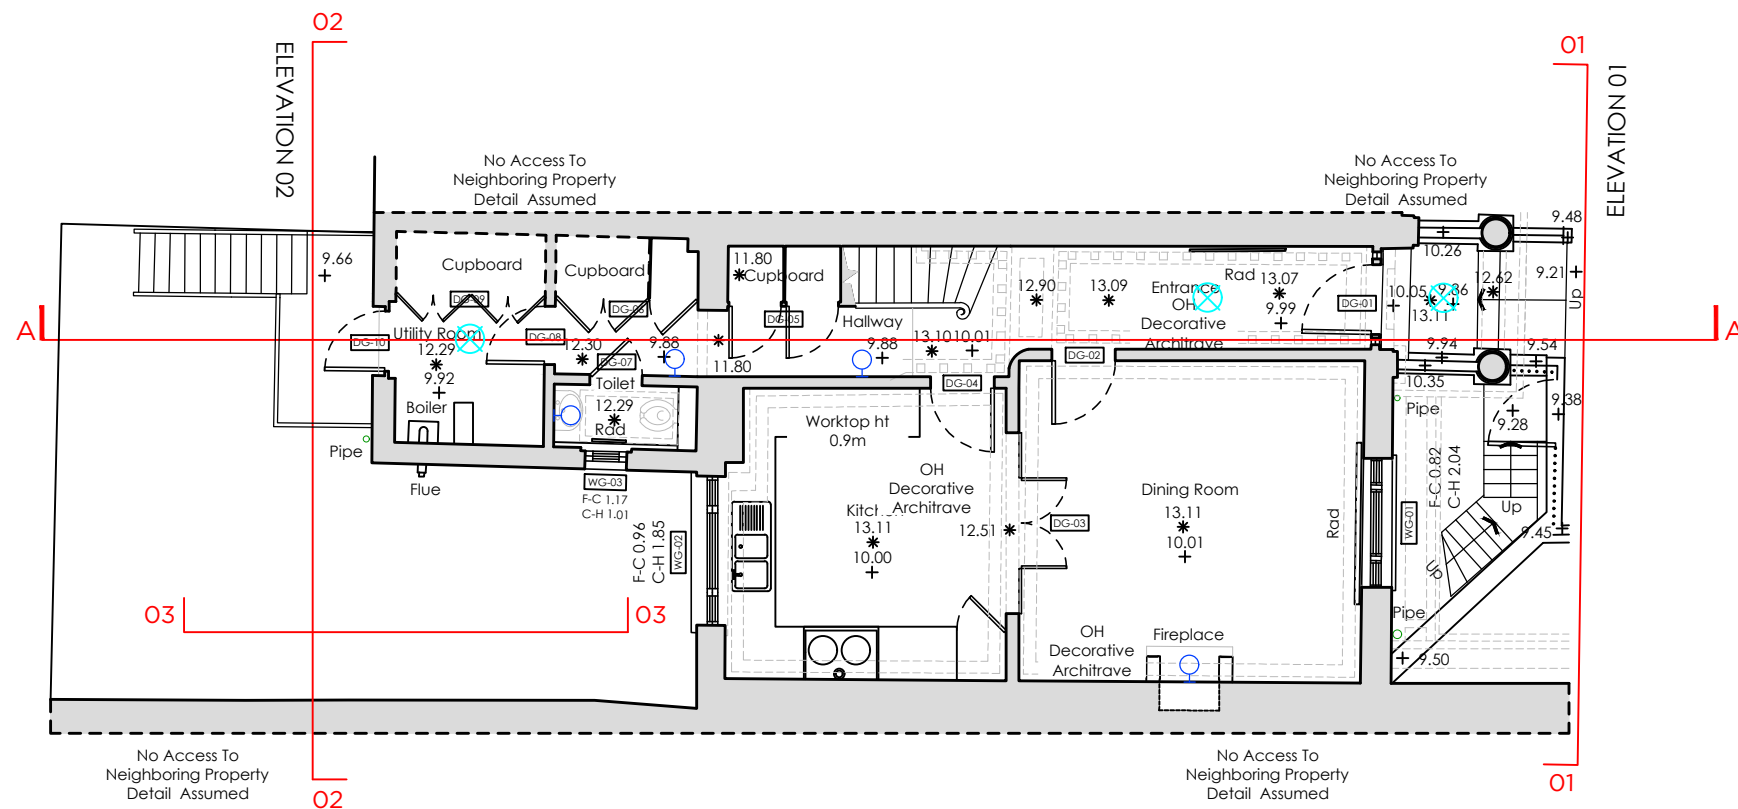





KEY

-  PENDANT
-  DOWNLIGHT
-  IP RATED DOWNLIGHT
-  LED STRIP
-  WALL LIGHT
-  5A SOCKET
-  SWITCH
-  DOUBLE SWITCH
-  TRIPLE SWITCH
-  DIMMABLE SWITCH
-  MAINS SMOKE DETECTOR & SOUNDER
-  MAINS HEAT DETECTOR & SOUNDER
-  CARBON MONOXIDE DETECTOR

NOTE:
1. Exact lighting layout and switching TBC on site



EXISTING
GROUND FLOOR PLAN

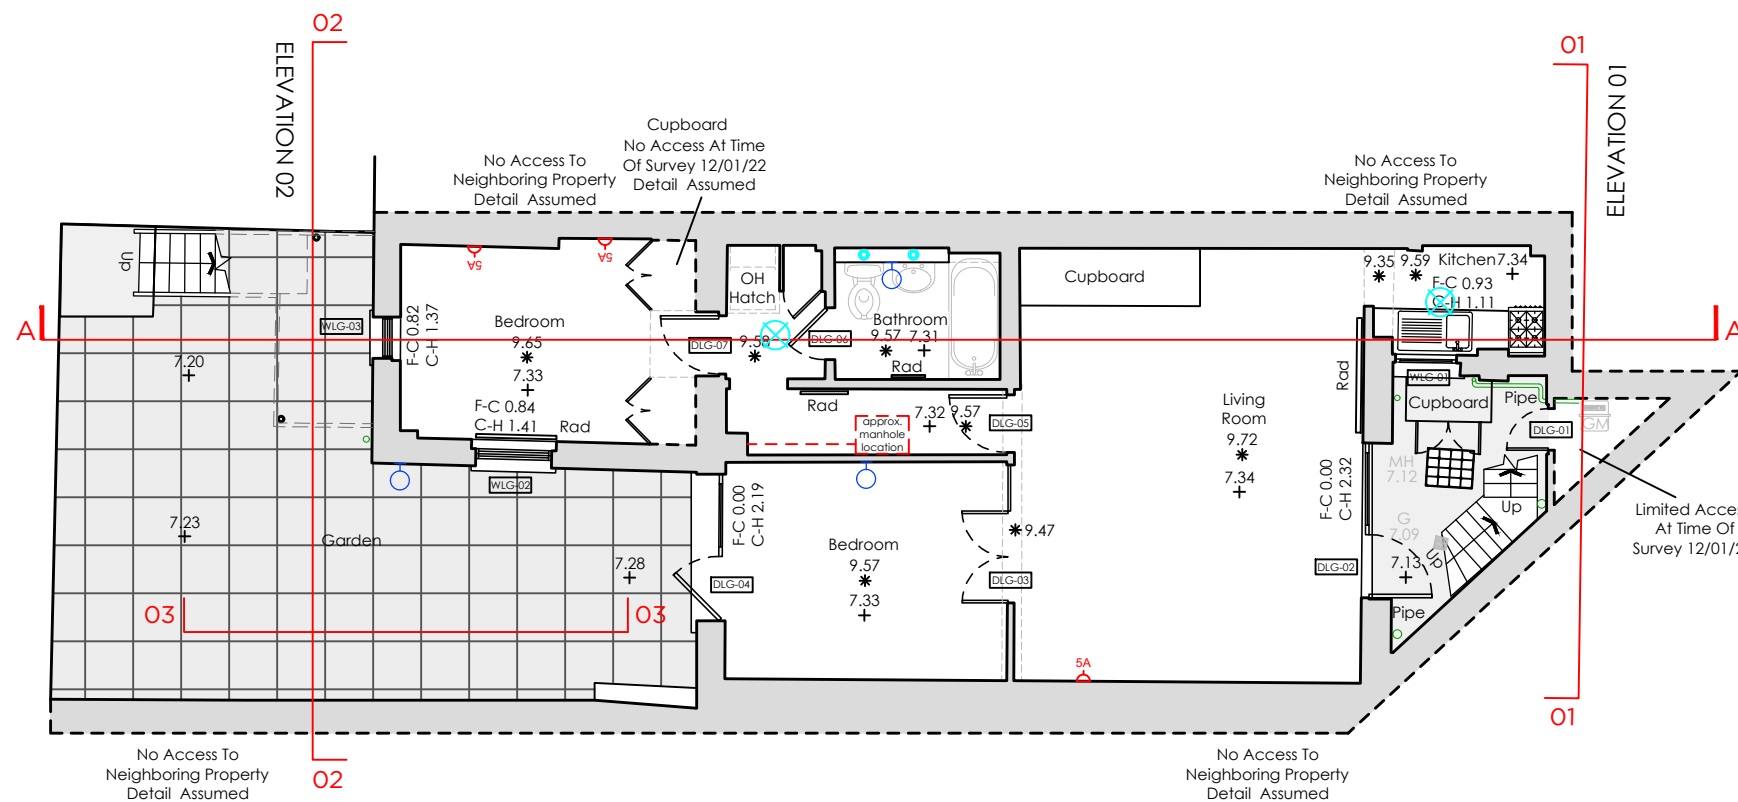

EXISTING
LOWER GROUND FLOOR PLAN

CHALCOT SQUARE

CHALCOT SQUARE

PR2 PLANNING ISSUE	06.10.23	LWT
PR1 REVIEW	30.06.23	LWT

Rev	Revision	Date	By
-----	----------	------	----

NOTES
All setting out dimensions and points will be found on the construction issue drawings
All dimensions to be checked on site prior to commencement of works. Do not scale this drawing

PLANNING

PROJECT
28 CHALCOT SQUARE

 
TITLE
EXISTING LG & GF
LIGHTING LAYOUT

SCALE
1:100 @ A3

DATE
30.05.23

DRAWING NO
638 GA 105

REVISION
PR2



GRAVITY DESIGN

Old Bank Court, Morocco Street, London SE1 3HB
+44(0)20 7089 9134 studio@gravitydesign.uk.com