














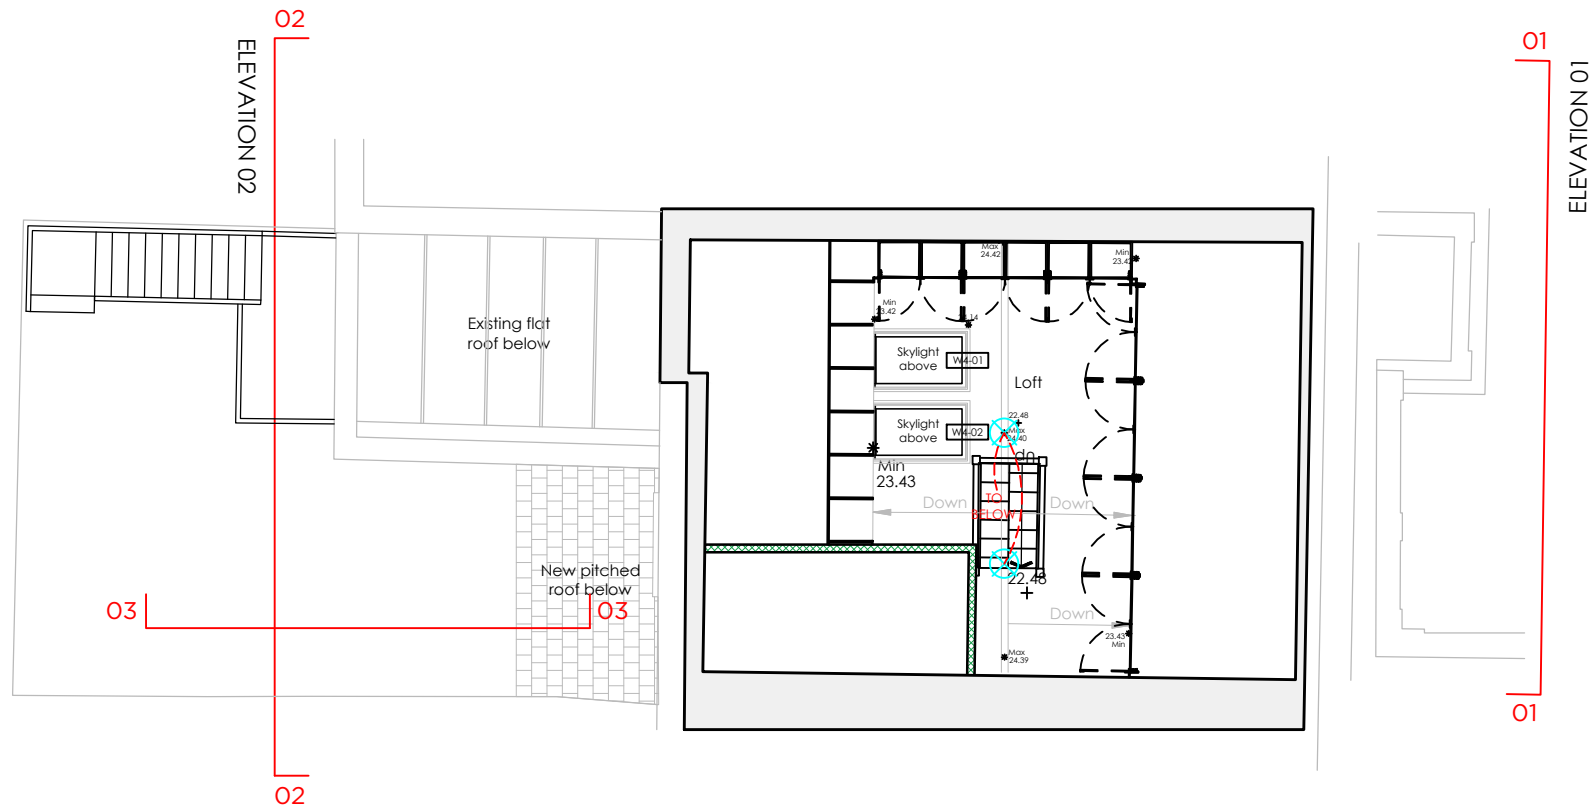





KEY

-  PENDANT
-  SURFACE MOUNT FITTING
-  DOWNLIGHT
-  IP RATED DOWNLIGHT
-  LED STRIP
-  WALL LIGHT
-  SA SOCKET
-  SWITCH
-  DOUBLE SWITCH
-  TRIPLE SWITCH
-  DIMMABLE SWITCH
-  PULL CORD SWITCH
-  MAINS SMOKE DETECTOR & SOUNDER
-  MAINS HEAT DETECTOR & SOUNDER
-  CARBON MONOXIDE DETECTOR




PROPOSED LOFT FLOOR PLAN

CHALCOT SQUARE

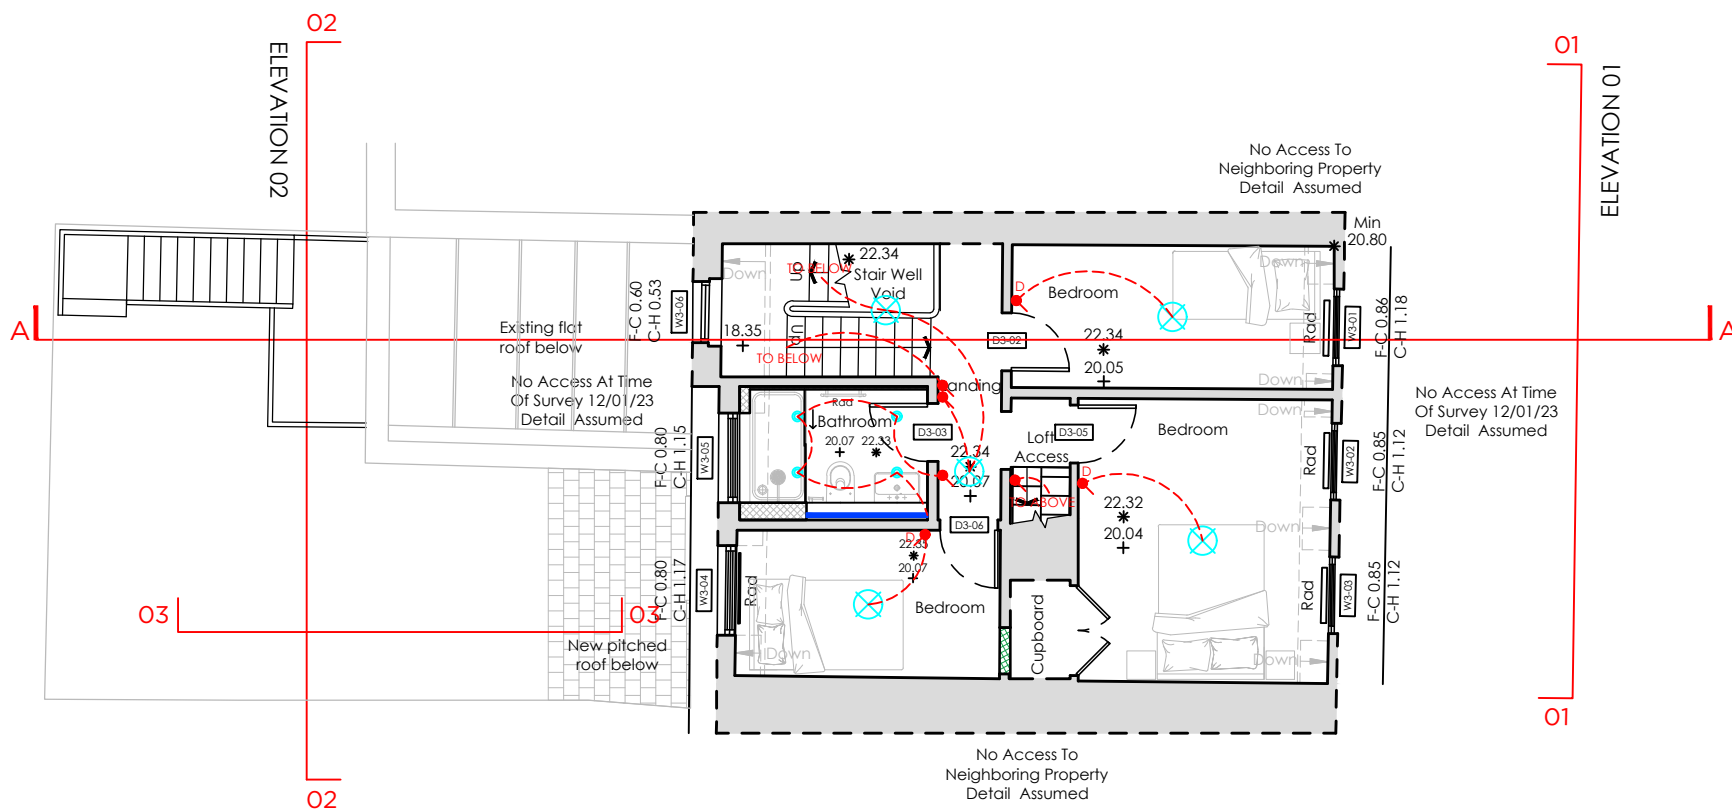

PROPOSED THIRD FLOOR PLAN

 CHALCOT SQUARE



PR2 PLANNING ISSUE	06.10.23	LWT
PR1 REVIEW	30.06.23	LWT

Rev	Revision	Date	By
-----	----------	------	----

NOTES

All setting out dimensions and points will be found on the construction issue drawings

All dimensions to be checked on site prior to commencement of works. Do not scale this drawing

### PLANNING

PROJECT  
28 CHALCOT SQUARE

TITLE  
PROPOSED 3F & LOFT  
LIGHTING LAYOUT

SCALE  
1:100 @ A3

DATE  
19.04.23

DRAWING NO  
638 GA 142

REVISION  
PR2



GRAVITY DESIGN

Old Bank Court, Morocco Street, London SE1 3HB  
+44(0)20 7089 9134 studio@gravitydesign.co.uk