














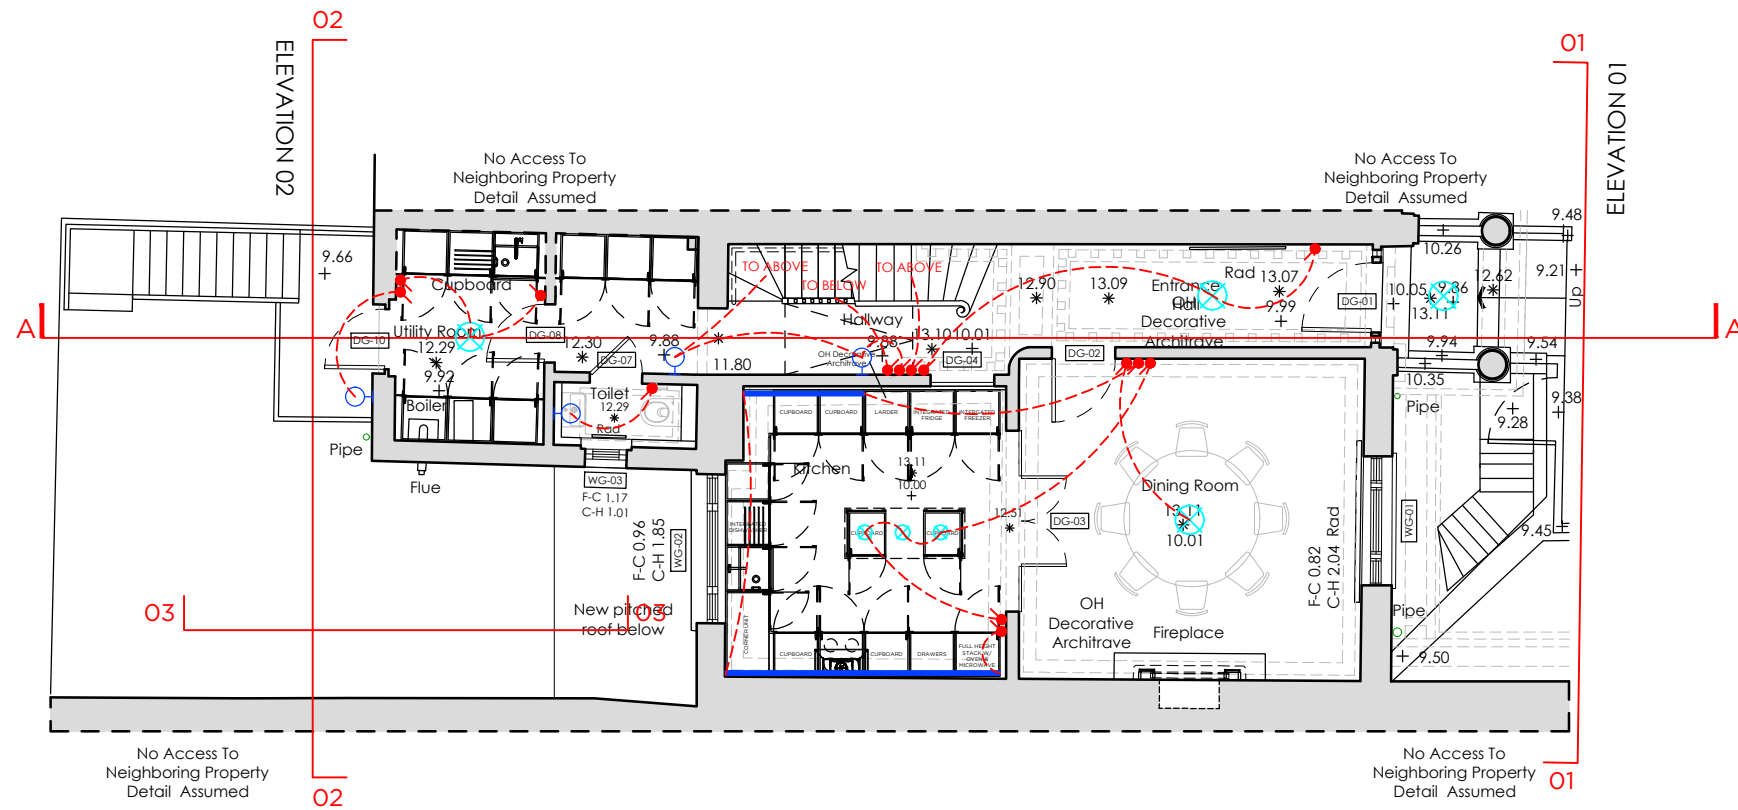





KEY

-  PENDANT
-  SURFACE MOUNT FITTING
-  DOWNLIGHT
-  IP RATED DOWNLIGHT
-  LED STRIP
-  WALL LIGHT
-  SA SOCKET
-  SWITCH
-  DOUBLE SWITCH
-  TRIPLE SWITCH
-  DIMMABLE SWITCH
-  PULL CORD SWITCH
-  MAINS SMOKE DETECTOR & SOUNDER
-  MAINS HEAT DETECTOR & SOUNDER
-  CARBON MONOXIDE DETECTOR



PROPOSED  
GROUND FLOOR PLAN

CHALCOT SQUARE

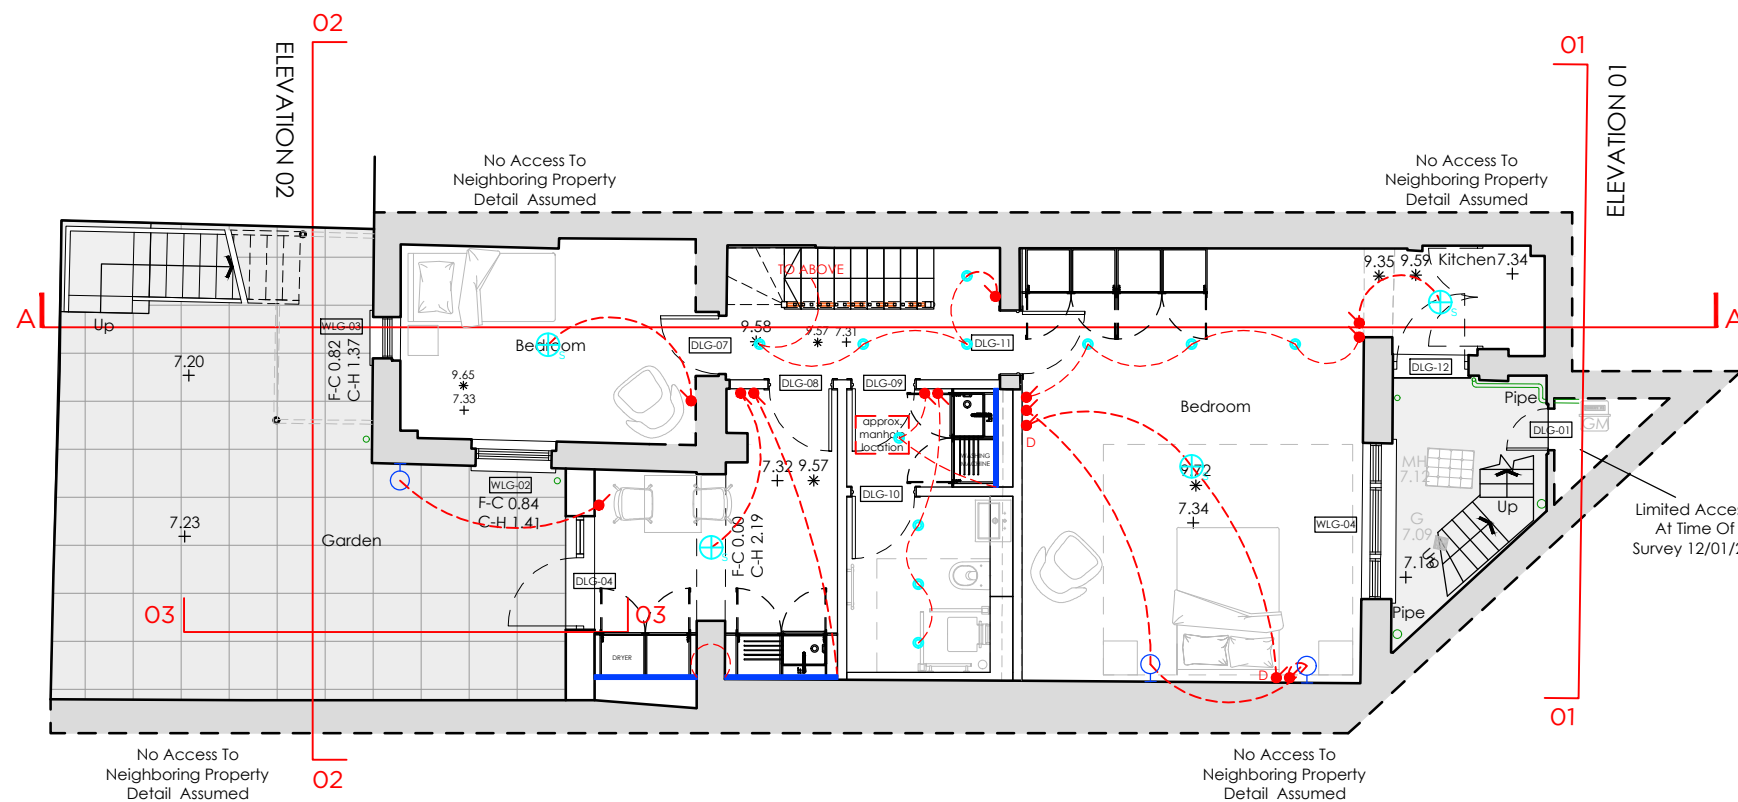

PROPOSED  
LOWER GROUND FLOOR PLAN

CHALCOT SQUARE

PR5 PLANNING ISSUE	23.10.23	LWT
PR4 PLANNING ISSUE	06.10.23	LWT
PR3 REVIEW	11.07.23	LWT
PR2 REVIEW	11.07.23	LWT
PR1 REVIEW	30.06.23	LWT

Rev	Revision	Date	By
-----	----------	------	----

NOTES

All setting out dimensions and points will be found on the construction issue drawings

All dimensions to be checked on site prior to commencement of works. Do not scale this drawing

PLANNING

PROJECT  
28 CHALCOT SQUARE

 
TITLE  
PROPOSED LG & GF  
LIGHTING LAYOUT

SCALE  
1:100 @ A3

DATE  
19.04.23

DRAWING NO  
638 GA 140

REVISION  
PR5



METRES



GRAVITY DESIGN

Old Bank Court, Morocco Street, London SE1 3HB  
+44(0)20 7089 9134 studio@gravitydesign.co.uk