












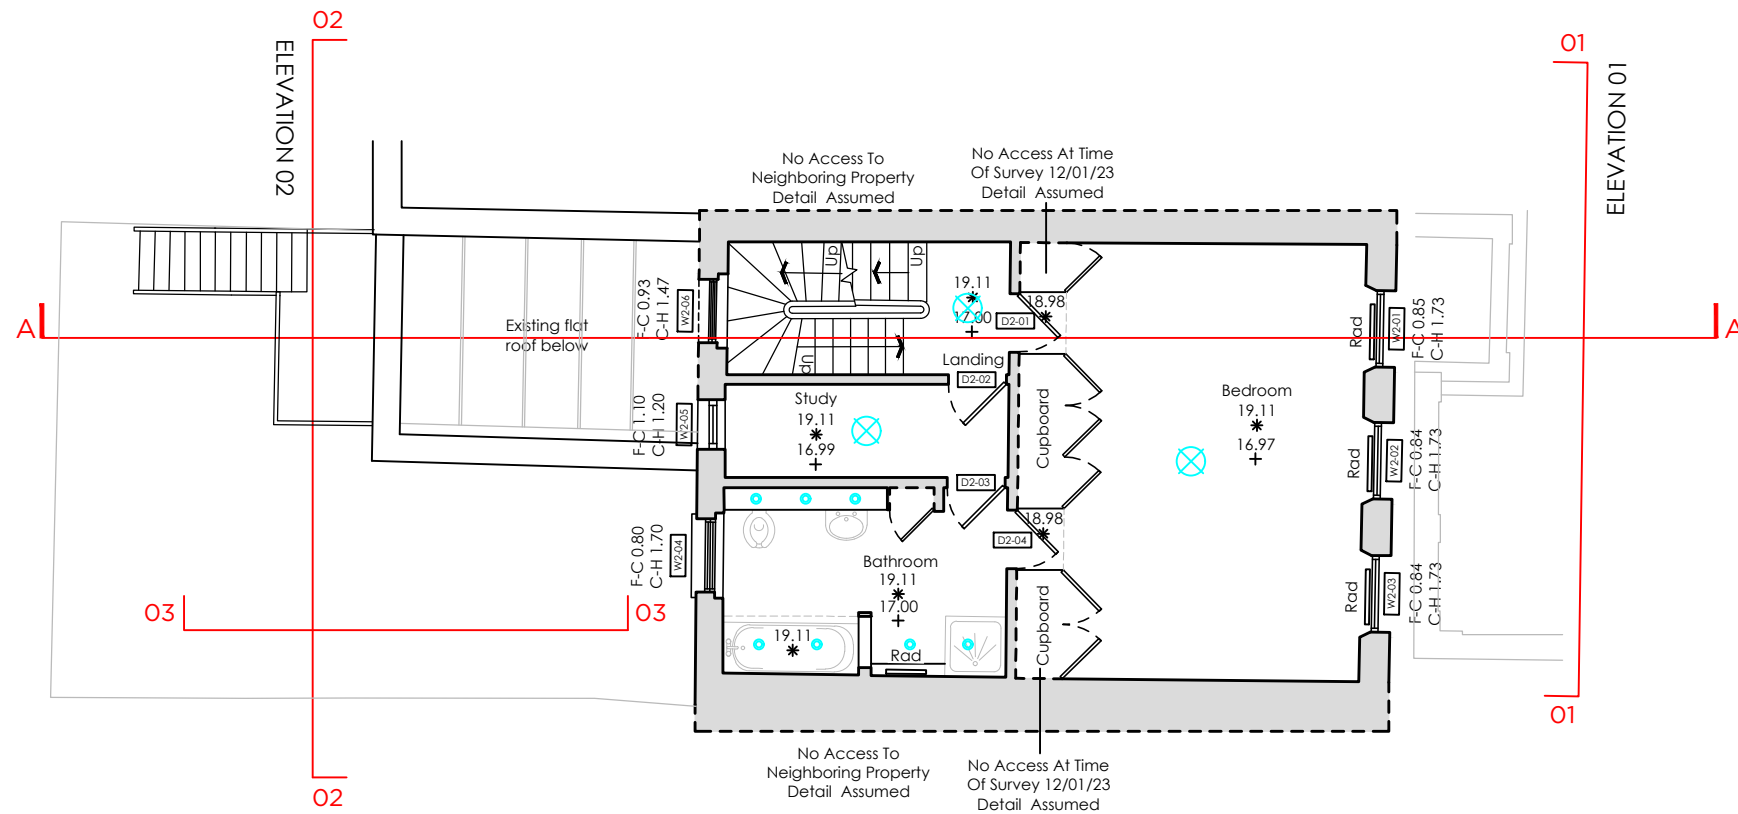





KEY

-  PENDANT
-  DOWNLIGHT
-  IP RATED DOWNLIGHT
-  LED STRIP
-  WALL LIGHT
-  5A SOCKET
-  SWITCH
-  DOUBLE SWITCH
-  TRIPLE SWITCH
-  DIMMABLE SWITCH
-  MAINS SMOKE DETECTOR & SOUNDER
-  MAINS HEAT DETECTOR & SOUNDER
-  CARBON MONOXIDE DETECTOR

NOTE:  
1. Exact lighting layout and switching TBC on site




EXISTING SECOND FLOOR PLAN

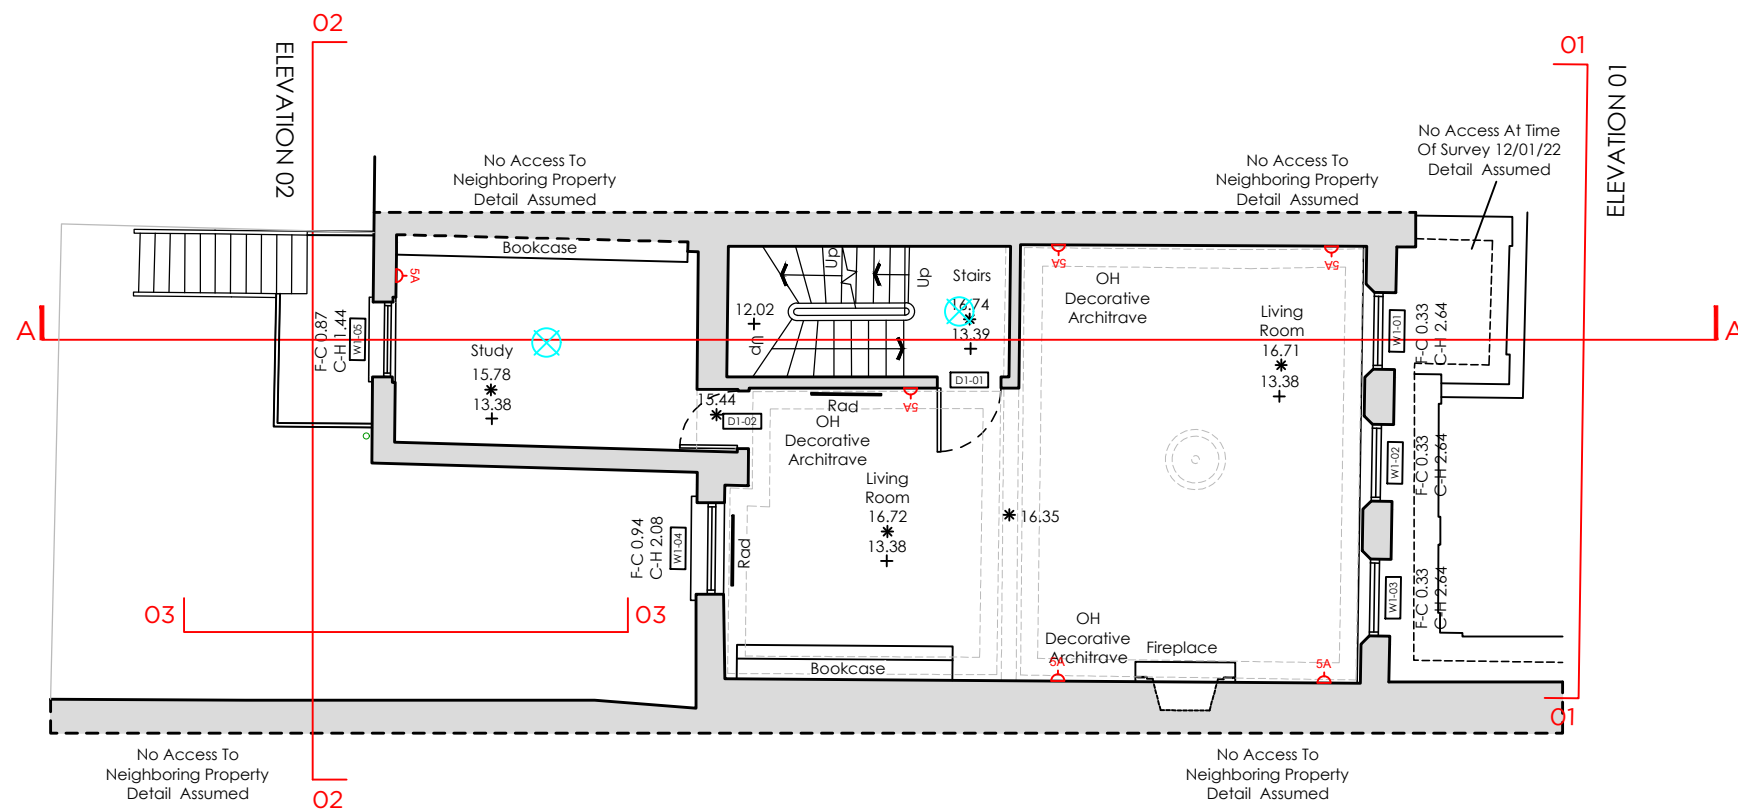

EXISTING FIRST FLOOR PLAN

CHALCOT SQUARE

 CHALCOT SQUARE



PR2 PLANNING ISSUE	06.10.23	LWT
PR1 REVIEW	30.06.23	LWT

Rev	Revision	Date	By
-----	----------	------	----

NOTES  
All setting out dimensions and points will be found on the construction issue drawings  
All dimensions to be checked on site prior to commencement of works. Do not scale this drawing

### PLANNING

PROJECT  
28 CHALCOT SQUARE

TITLE  
EXISTING 1F & 2F  
LIGHTING LAYOUT

SCALE  
1:100 @ A3

DATE  
30.05.23

DRAWING NO  
638 GA 106

REVISION  
PR2



GRAVITY DESIGN

Old Bank Court, Morocco Street, London SE1 3HB  
+44(0)20 7089 9134 studio@gravitydesign.uk.com