














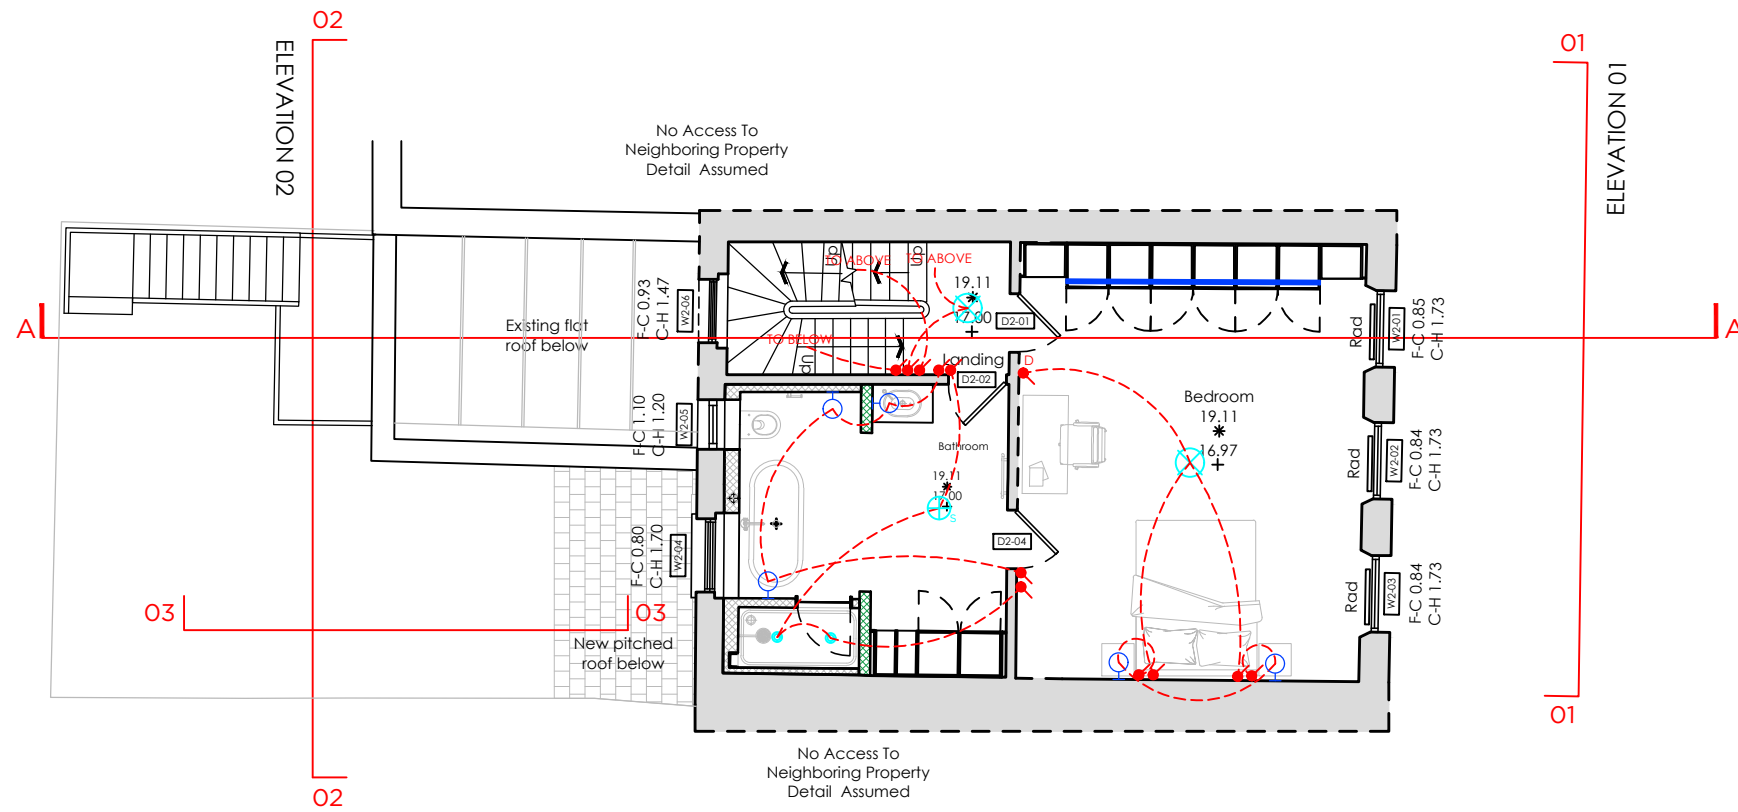





KEY

-  PENDANT
-  SURFACE MOUNT FITTING
-  DOWNLIGHT
-  IP RATED DOWNLIGHT
-  LED STRIP
-  WALL LIGHT
-  SA SOCKET
-  SWITCH
-  DOUBLE SWITCH
-  TRIPLE SWITCH
-  DIMMABLE SWITCH
-  PULL CORD SWITCH
-  MAINS SMOKE DETECTOR & SOUNDER
-  MAINS HEAT DETECTOR & SOUNDER
-  CARBON MONOXIDE DETECTOR



PROPOSED SECOND FLOOR PLAN

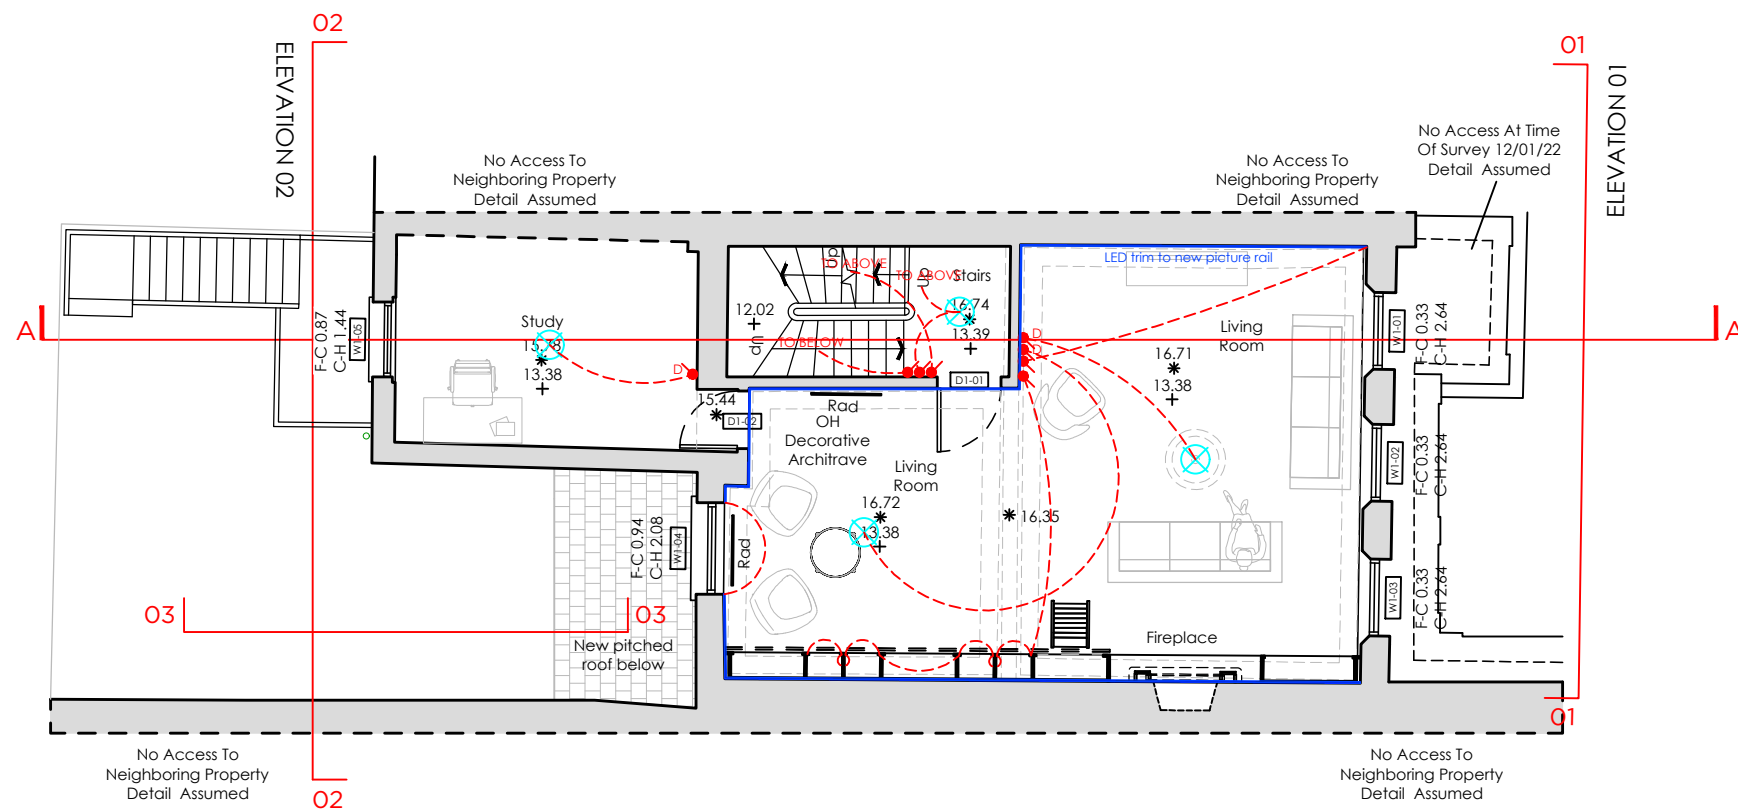

PROPOSED FIRST FLOOR PLAN

CHALCOT SQUARE

CHALCOT SQUARE

|                    |          |     |
|--------------------|----------|-----|
| PR2 PLANNING ISSUE | 06.10.23 | LWT |
| PR1 REVIEW         | 30.06.23 | LWT |

| Rev | Revision | Date | By |
|-----|----------|------|----|
|-----|----------|------|----|

NOTES

All setting out dimensions and points will be found on the construction issue drawings

All dimensions to be checked on site prior to commencement of works. Do not scale this drawing

### PLANNING

PROJECT  
28 CHALCOT SQUARE


TITLE  
PROPOSED 1F & 2F  
LIGHTING LAYOUT

SCALE 1:100 @ A3

DATE 19.04.23

DRAWING NO 638 GA 141

 REVISION PR2



METRES



GRAVITY DESIGN

Old Bank Court, Morocco Street, London SE1 3HB  
+44(0)20 7089 9134 studio@gravitydesign.uk.com