



For roof plan information. Refer to dwg 3467_LB_120008

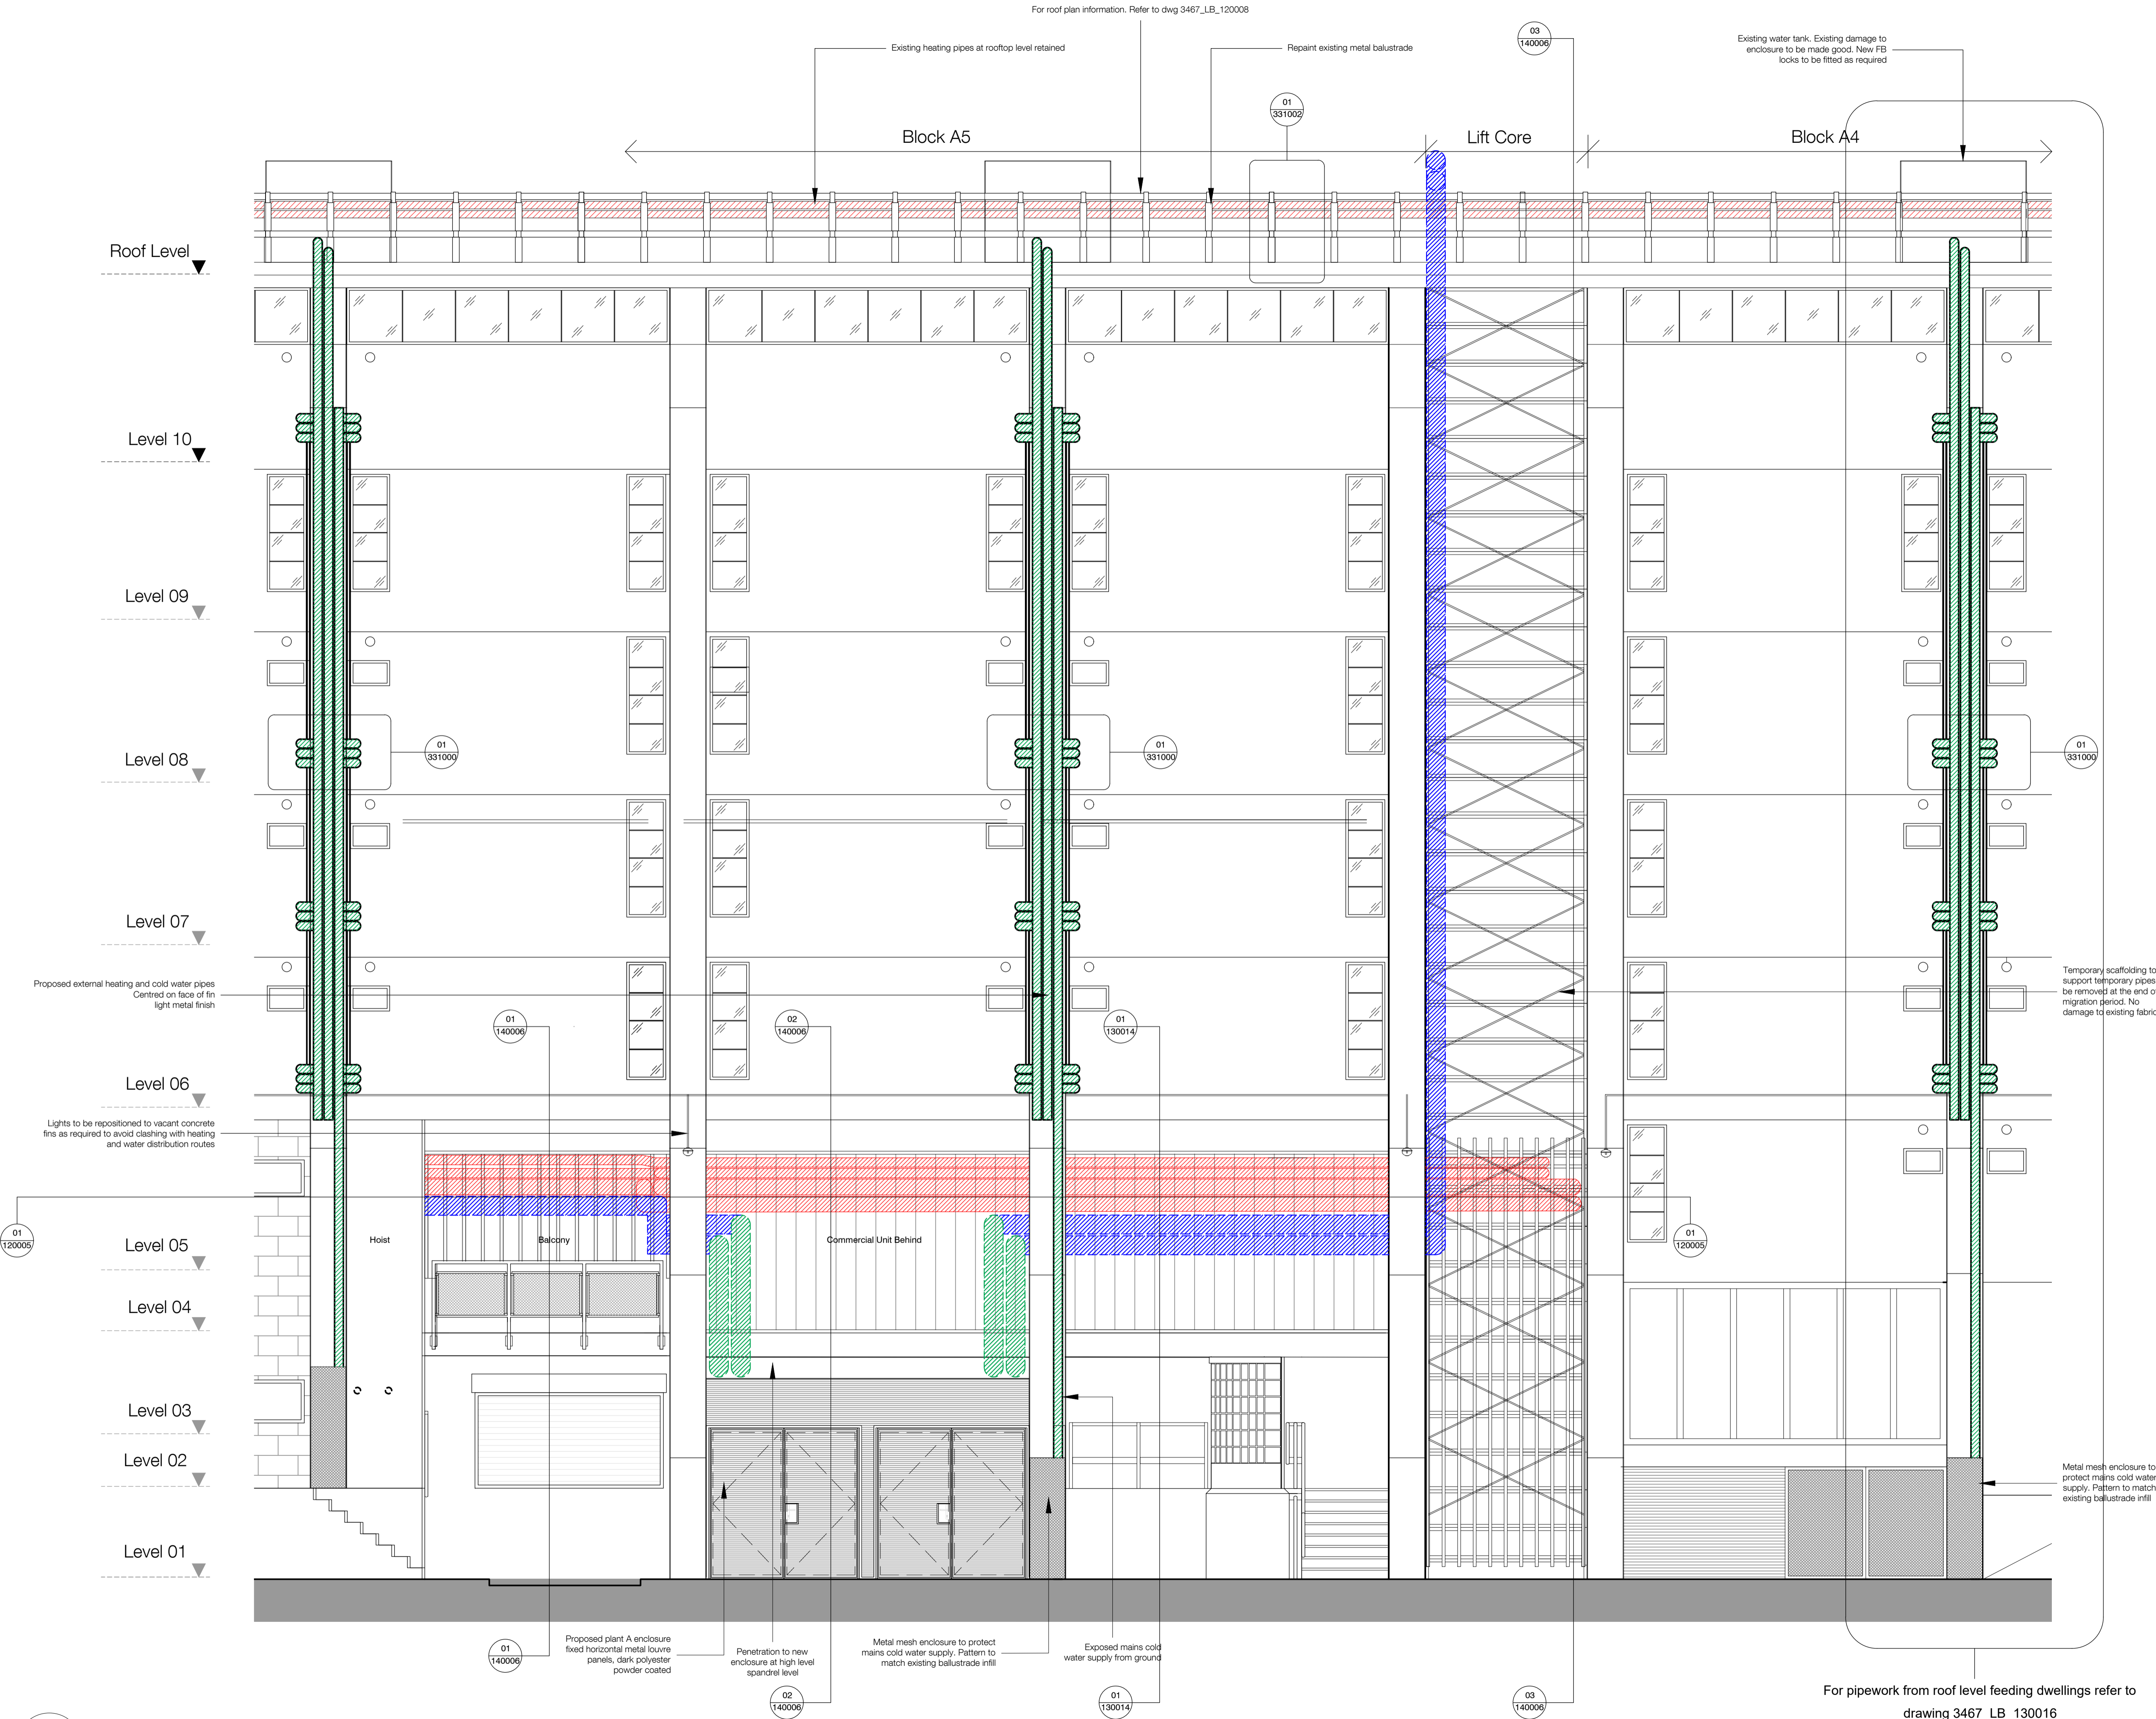

Notes

1. Do not scale this drawing.
2. All dimensions must be checked on site and any discrepancies verified with the architect.
3. Unless shown otherwise, all dimensions are to structural surfaces.
4. Drawing to be read with all other issued information. Any discrepancies to be brought to the attention of the architect.
5. This drawing is the copyright of Levitt Bernstein and may not be copied, altered or reproduced in any form, or passed to a third party without license or written consent.

This is not a construction drawing, it is unsuitable for the purpose of construction and must on no account be used as such.

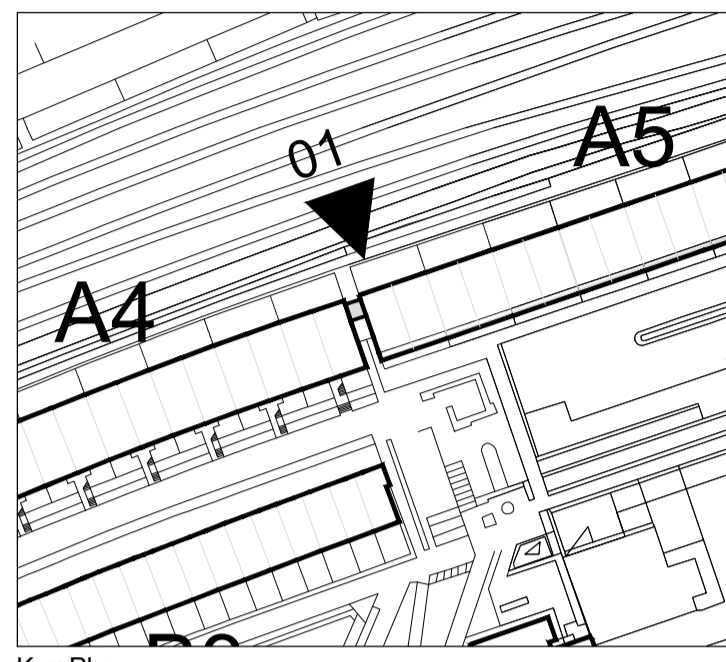

- ▨▨▨▨ Proposed pipework for final install
- ▨▨▨▨ Proposed pipework for initial install, removed at end of migration period
- ▨▨▨▨ Existing pipework retained in place during migration period.

P2 10.11.23 - Planning & Listed Building Consent KS
 P1 07.04.22 - For comment KS

Rev Date	Description	Initials

Project name

Alexandra Rd Estate
 Heating Infrastructure

Drawing number

3467_LB_130010 P2

Drawing
Block A - Existing and Temporary - Distribution Route from Housing Office Balcony to Roof - Elevation

Purpose of issue

PLANNING 10.11.23

Scale

1:50 @ A1 KS

Client

Camden CC PM

levittbernstein.co.uk

London Thane Studios 2-4 Thane Villas London N7 7PA +44 (0)20 7275 7676	Manchester Bonded Warehouse Grape Street Manchester M3 3JE +44 (0)16 1669 8740
--	---

01 Block A - Existing and Temporary - Distribution Route from Housing Office Balcony to Roof - Elevation
 1:50

For pipework from roof level feeding dwellings refer to drawing 3467_LB_130016

