



- Notes**
1. Do not scale this drawing.
 2. All dimensions must be checked on site and any discrepancies verified with the architect.
 3. Unless shown otherwise, all dimensions are to finished surfaces.
 4. Drawing to be read with all other issued information. Any discrepancies to be brought to the attention of the architect.
 5. This drawing is the copyright of Levitt Bernstein and may not be copied, altered or reproduced in any form, or passed to a third party without license or written consent.
- This is not a construction drawing. It is unsuitable for the purpose of construction and must not be used as such.

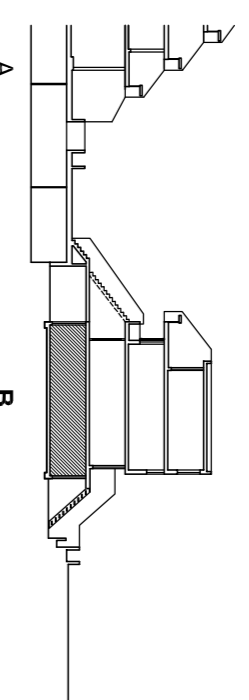


Block B Section Key
 Key:
 ● Proposed heating and main cold water supply riser riser
 --- water supply riser riser


For more information on heating distribution in B3 Flats, Refer to 3467_LB_335004

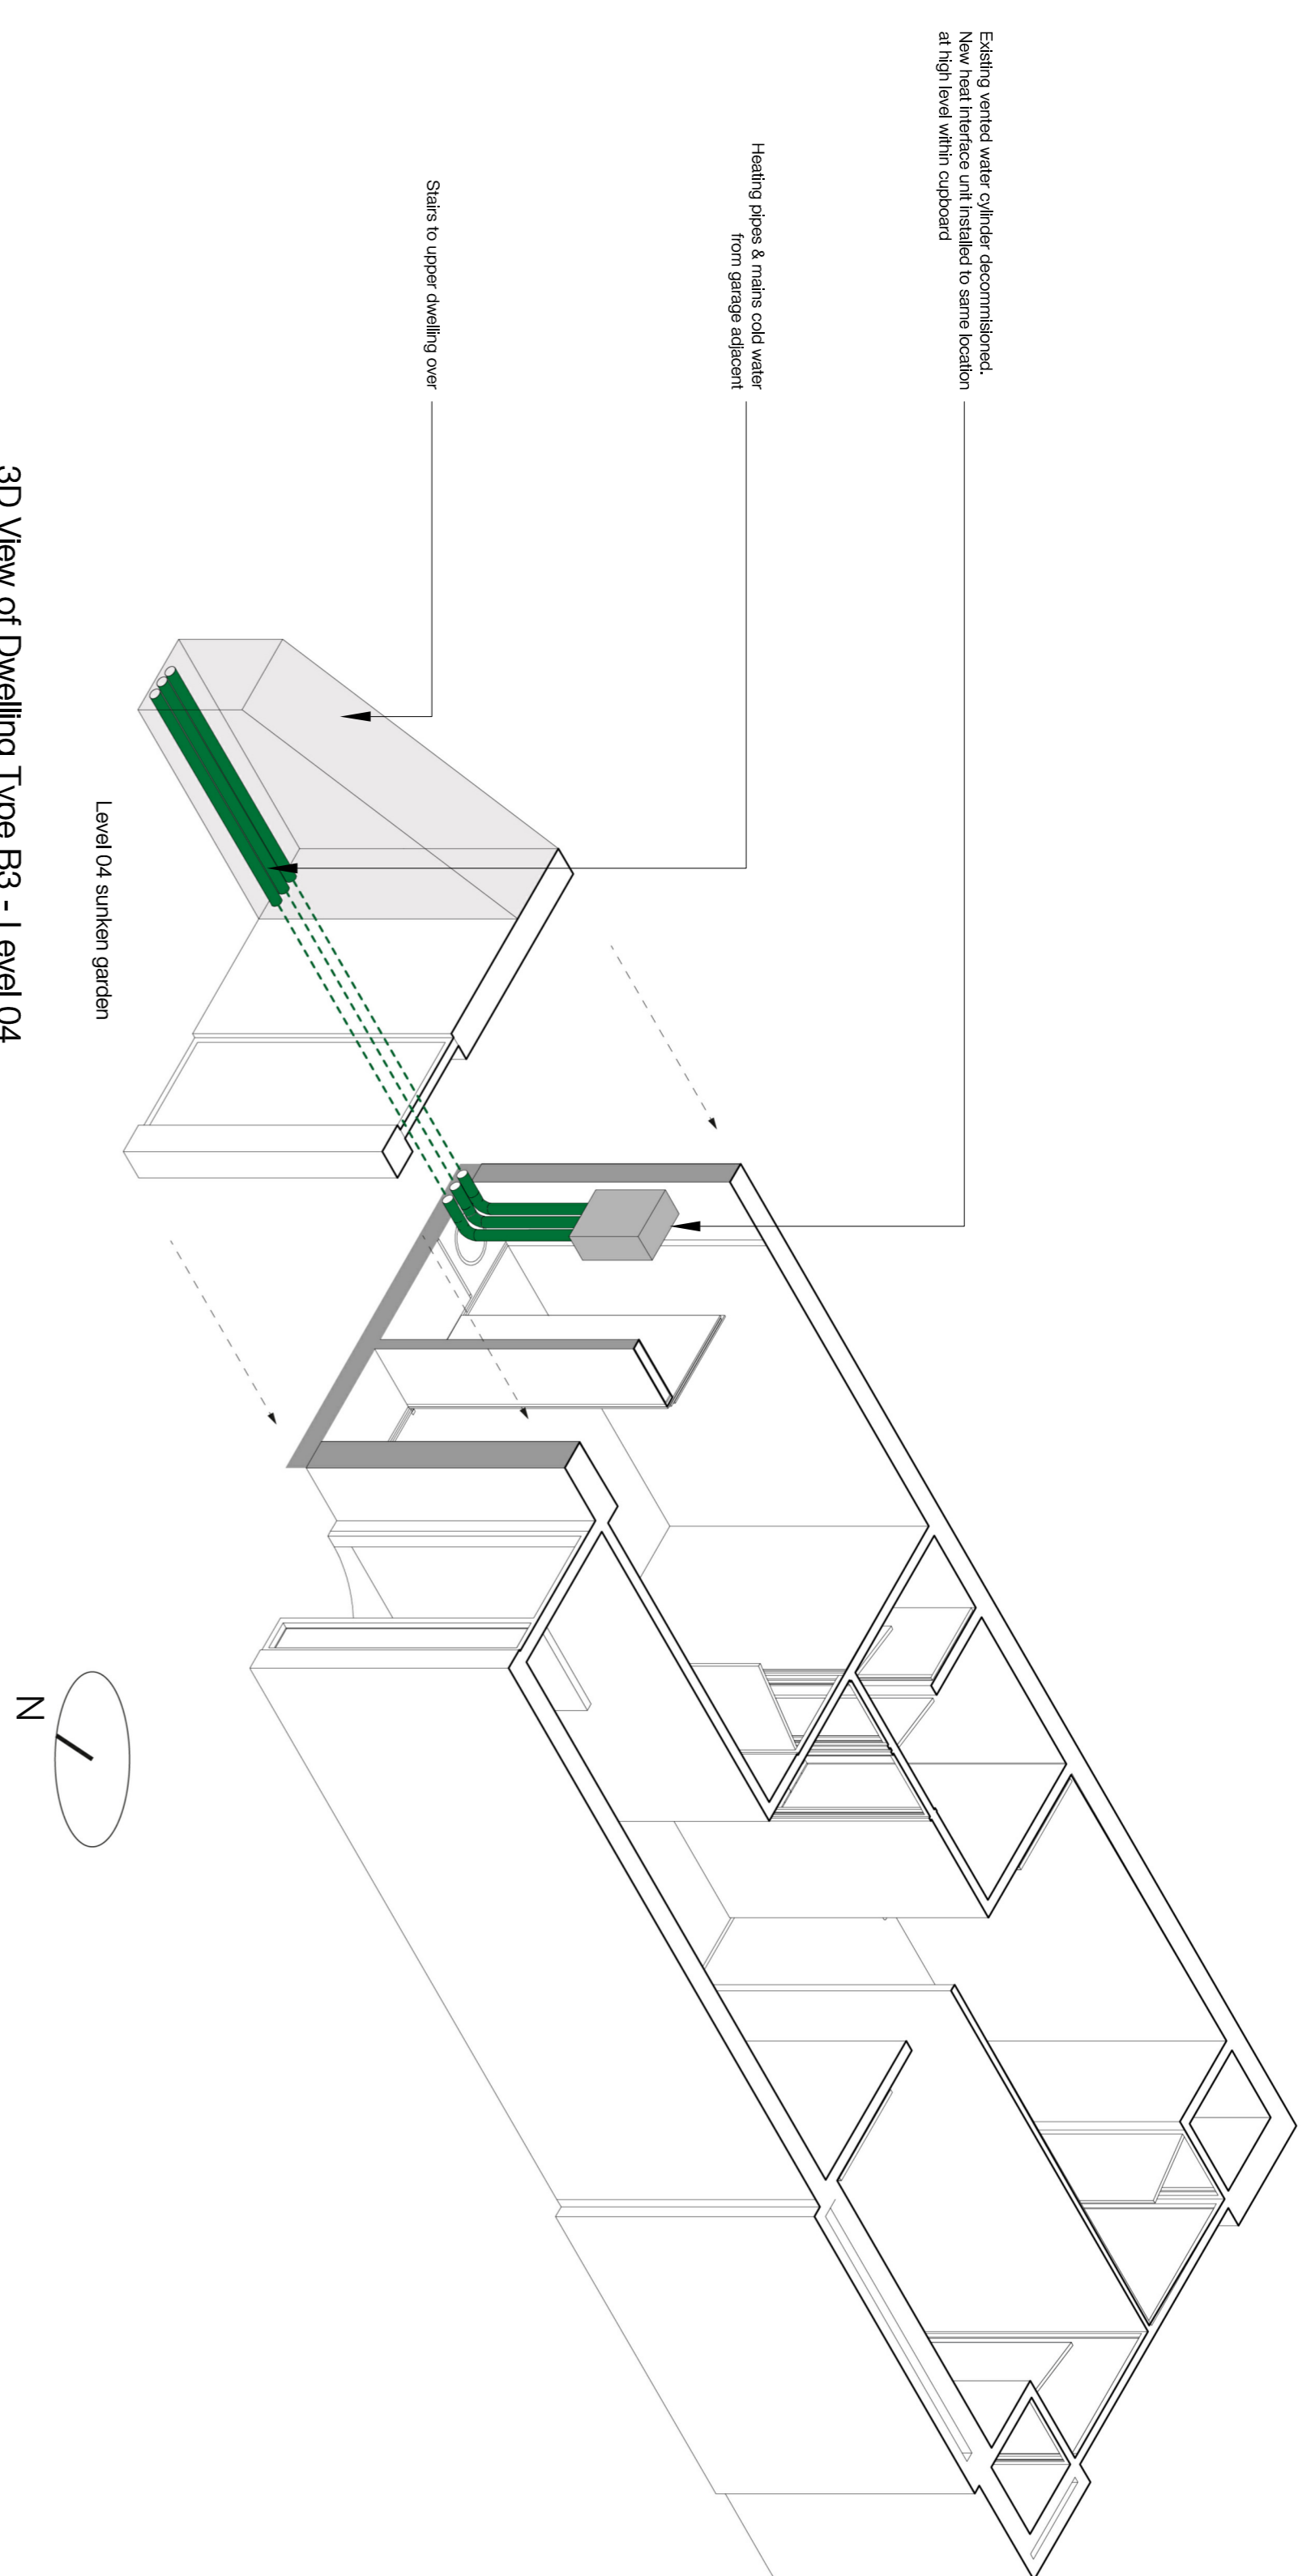

3D View of Dwelling Type B3 - Level 04

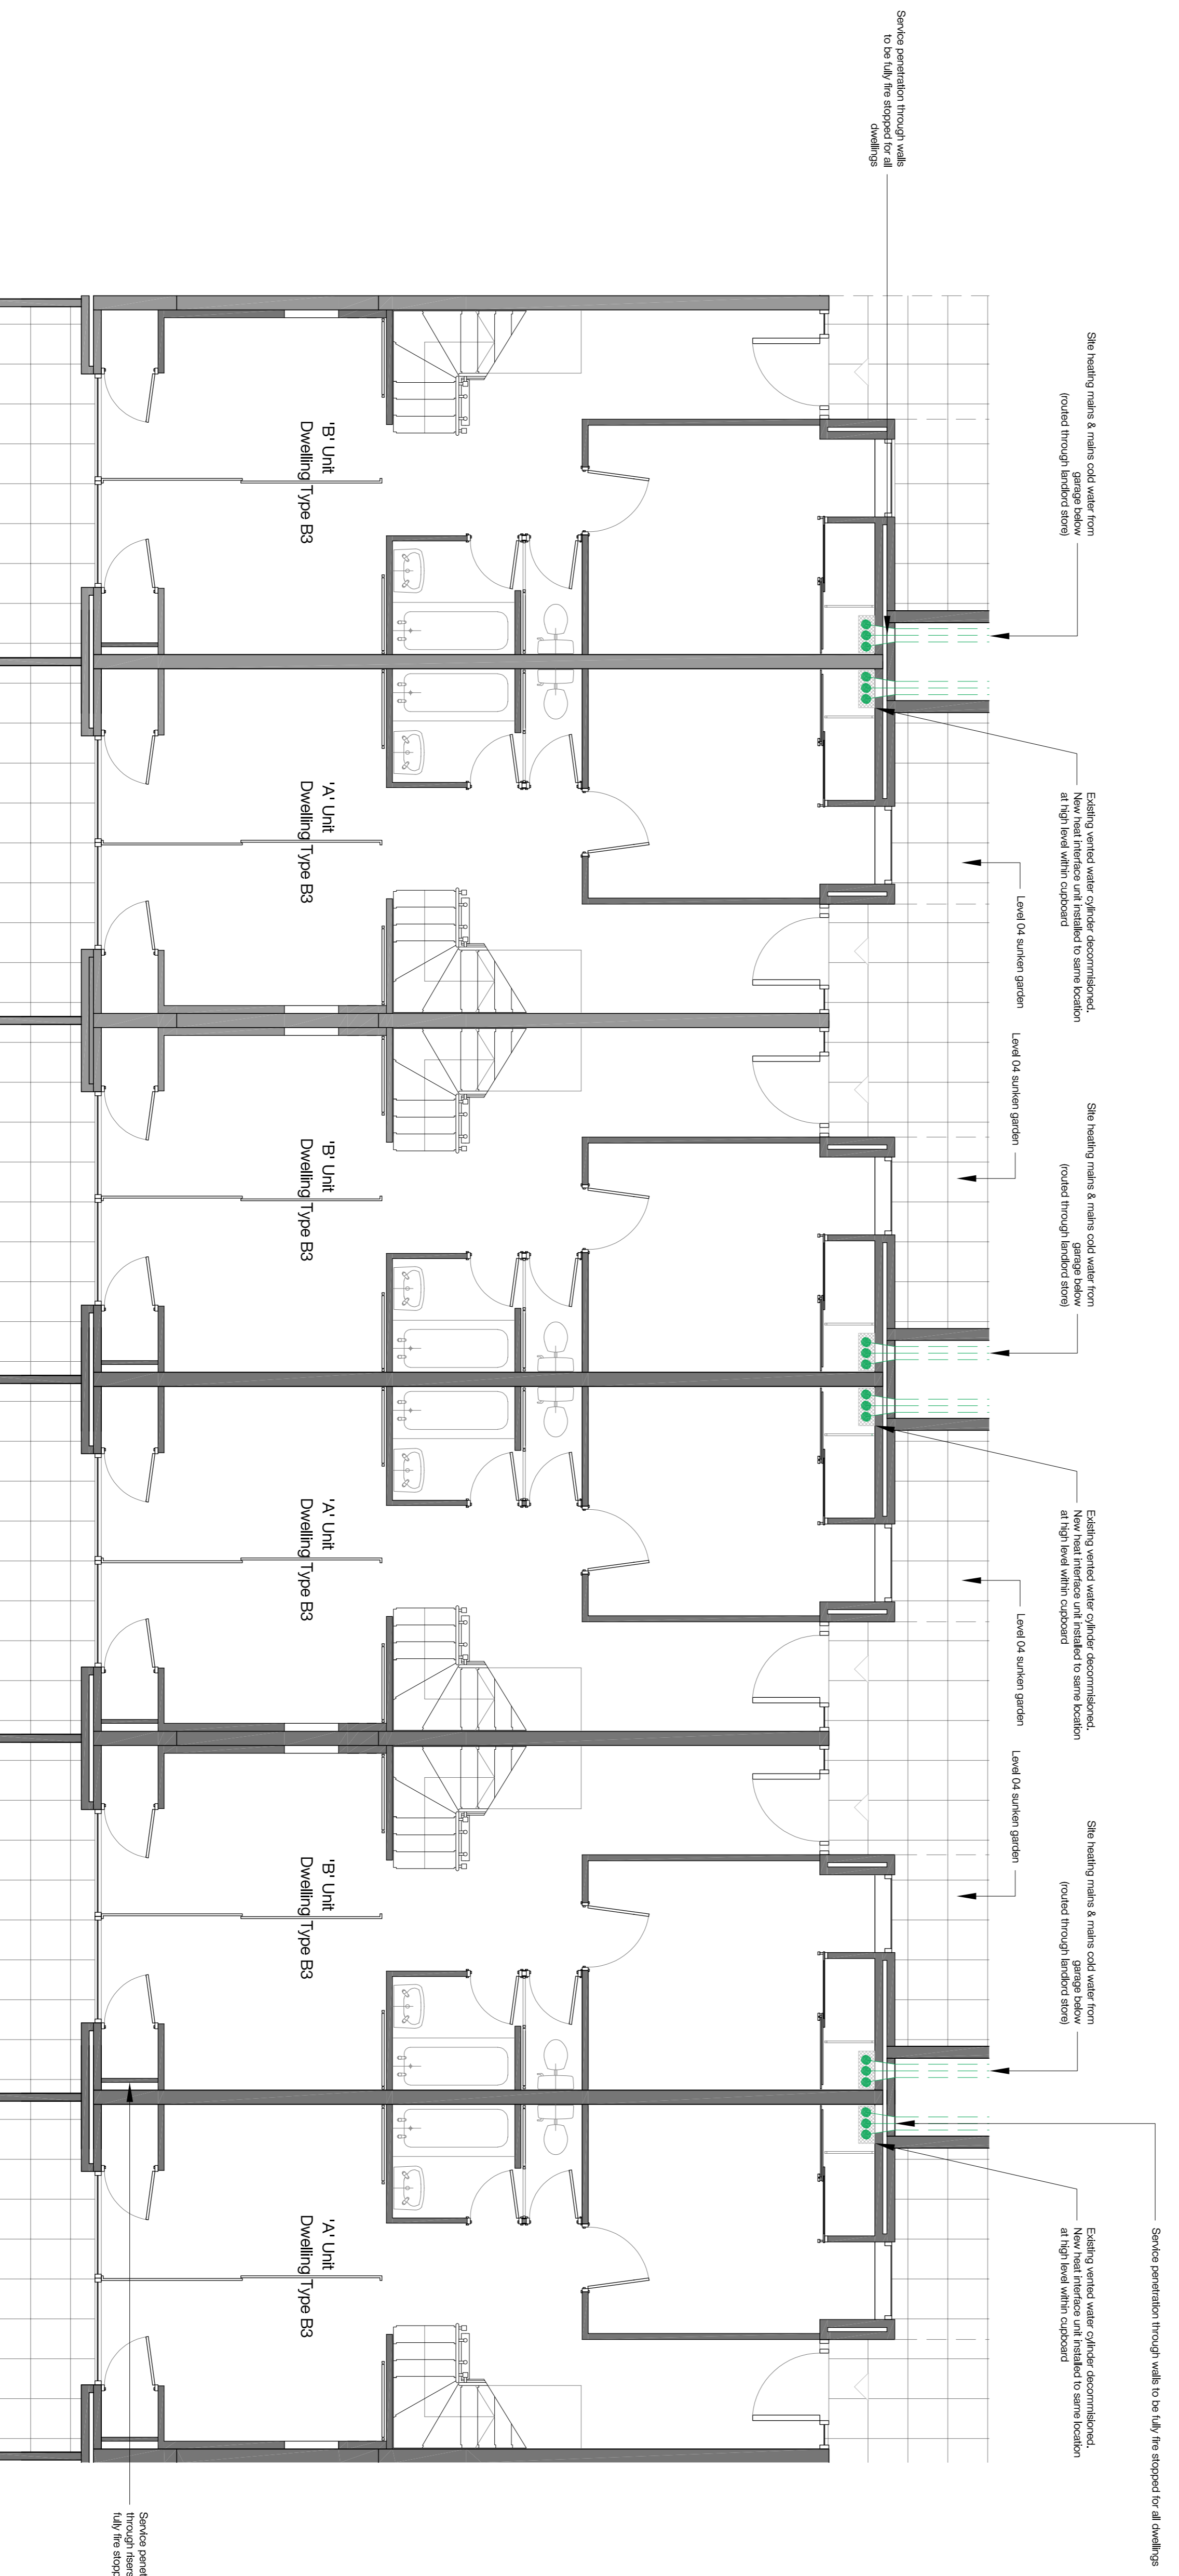

01 Block B - Proposed Level 04 - Typical B3 Lower Floor Plan
 120024

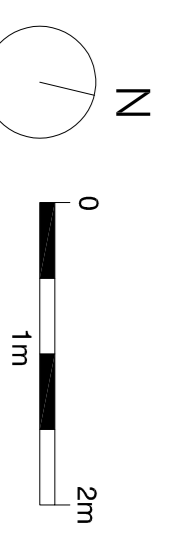

Project name	P2 17.11.23 - Planning & Listed Building Consent	Issue	KS
Rev. Date	P1 07/04/22 - For comment	Issue	KS
Rev. Date		Issue	
Alexandra Rd Estate			
Heating Infrastructure			
Drawing number	3467_LB_120024	Rev.	P2
Drawing	Block B - Proposed Level 04 Typical B3 Lower Floor Plan	Date	17.11.23
Purpose of Issue	PLANNING	Drawn	KS
Scale	1:50 @ A1	Checked	PM
Client	Camden CC	Checked	PM
lewithernstein.co.uk			
London		Manchester	
77-79 Whitechapel Road London E1 1DU +44 (0)20 7275 7676		52-54 Piccadilly Manchester M1 2AZ +44 (0)16 1689 8740	