



- Notes**
1. Do not scale this drawing.
 2. All dimensions must be checked on site and any discrepancies verified with the architect.
 3. Dimensions shown otherwise, all dimensions are to structural surfaces.
 4. Drawing to be read with all other issued information. Any discrepancies to be brought to the attention of the architect.
 5. This drawing is the copyright of Levitt Bernstein and may not be copied, altered or reproduced in any form, or passed to a third party without license or written consent.
- This is not a construction drawing. It is unsuitable for the purpose of construction and must on no account be used as such.

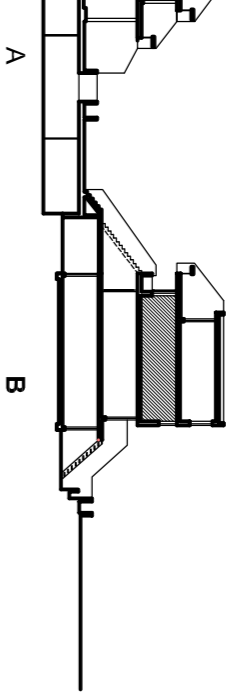


Block B Section Key

- Key:
- Proposed heating and main cold water supply into flats


For more information on heating distribution in B2 Flats, Refer to 3467_LB_335003

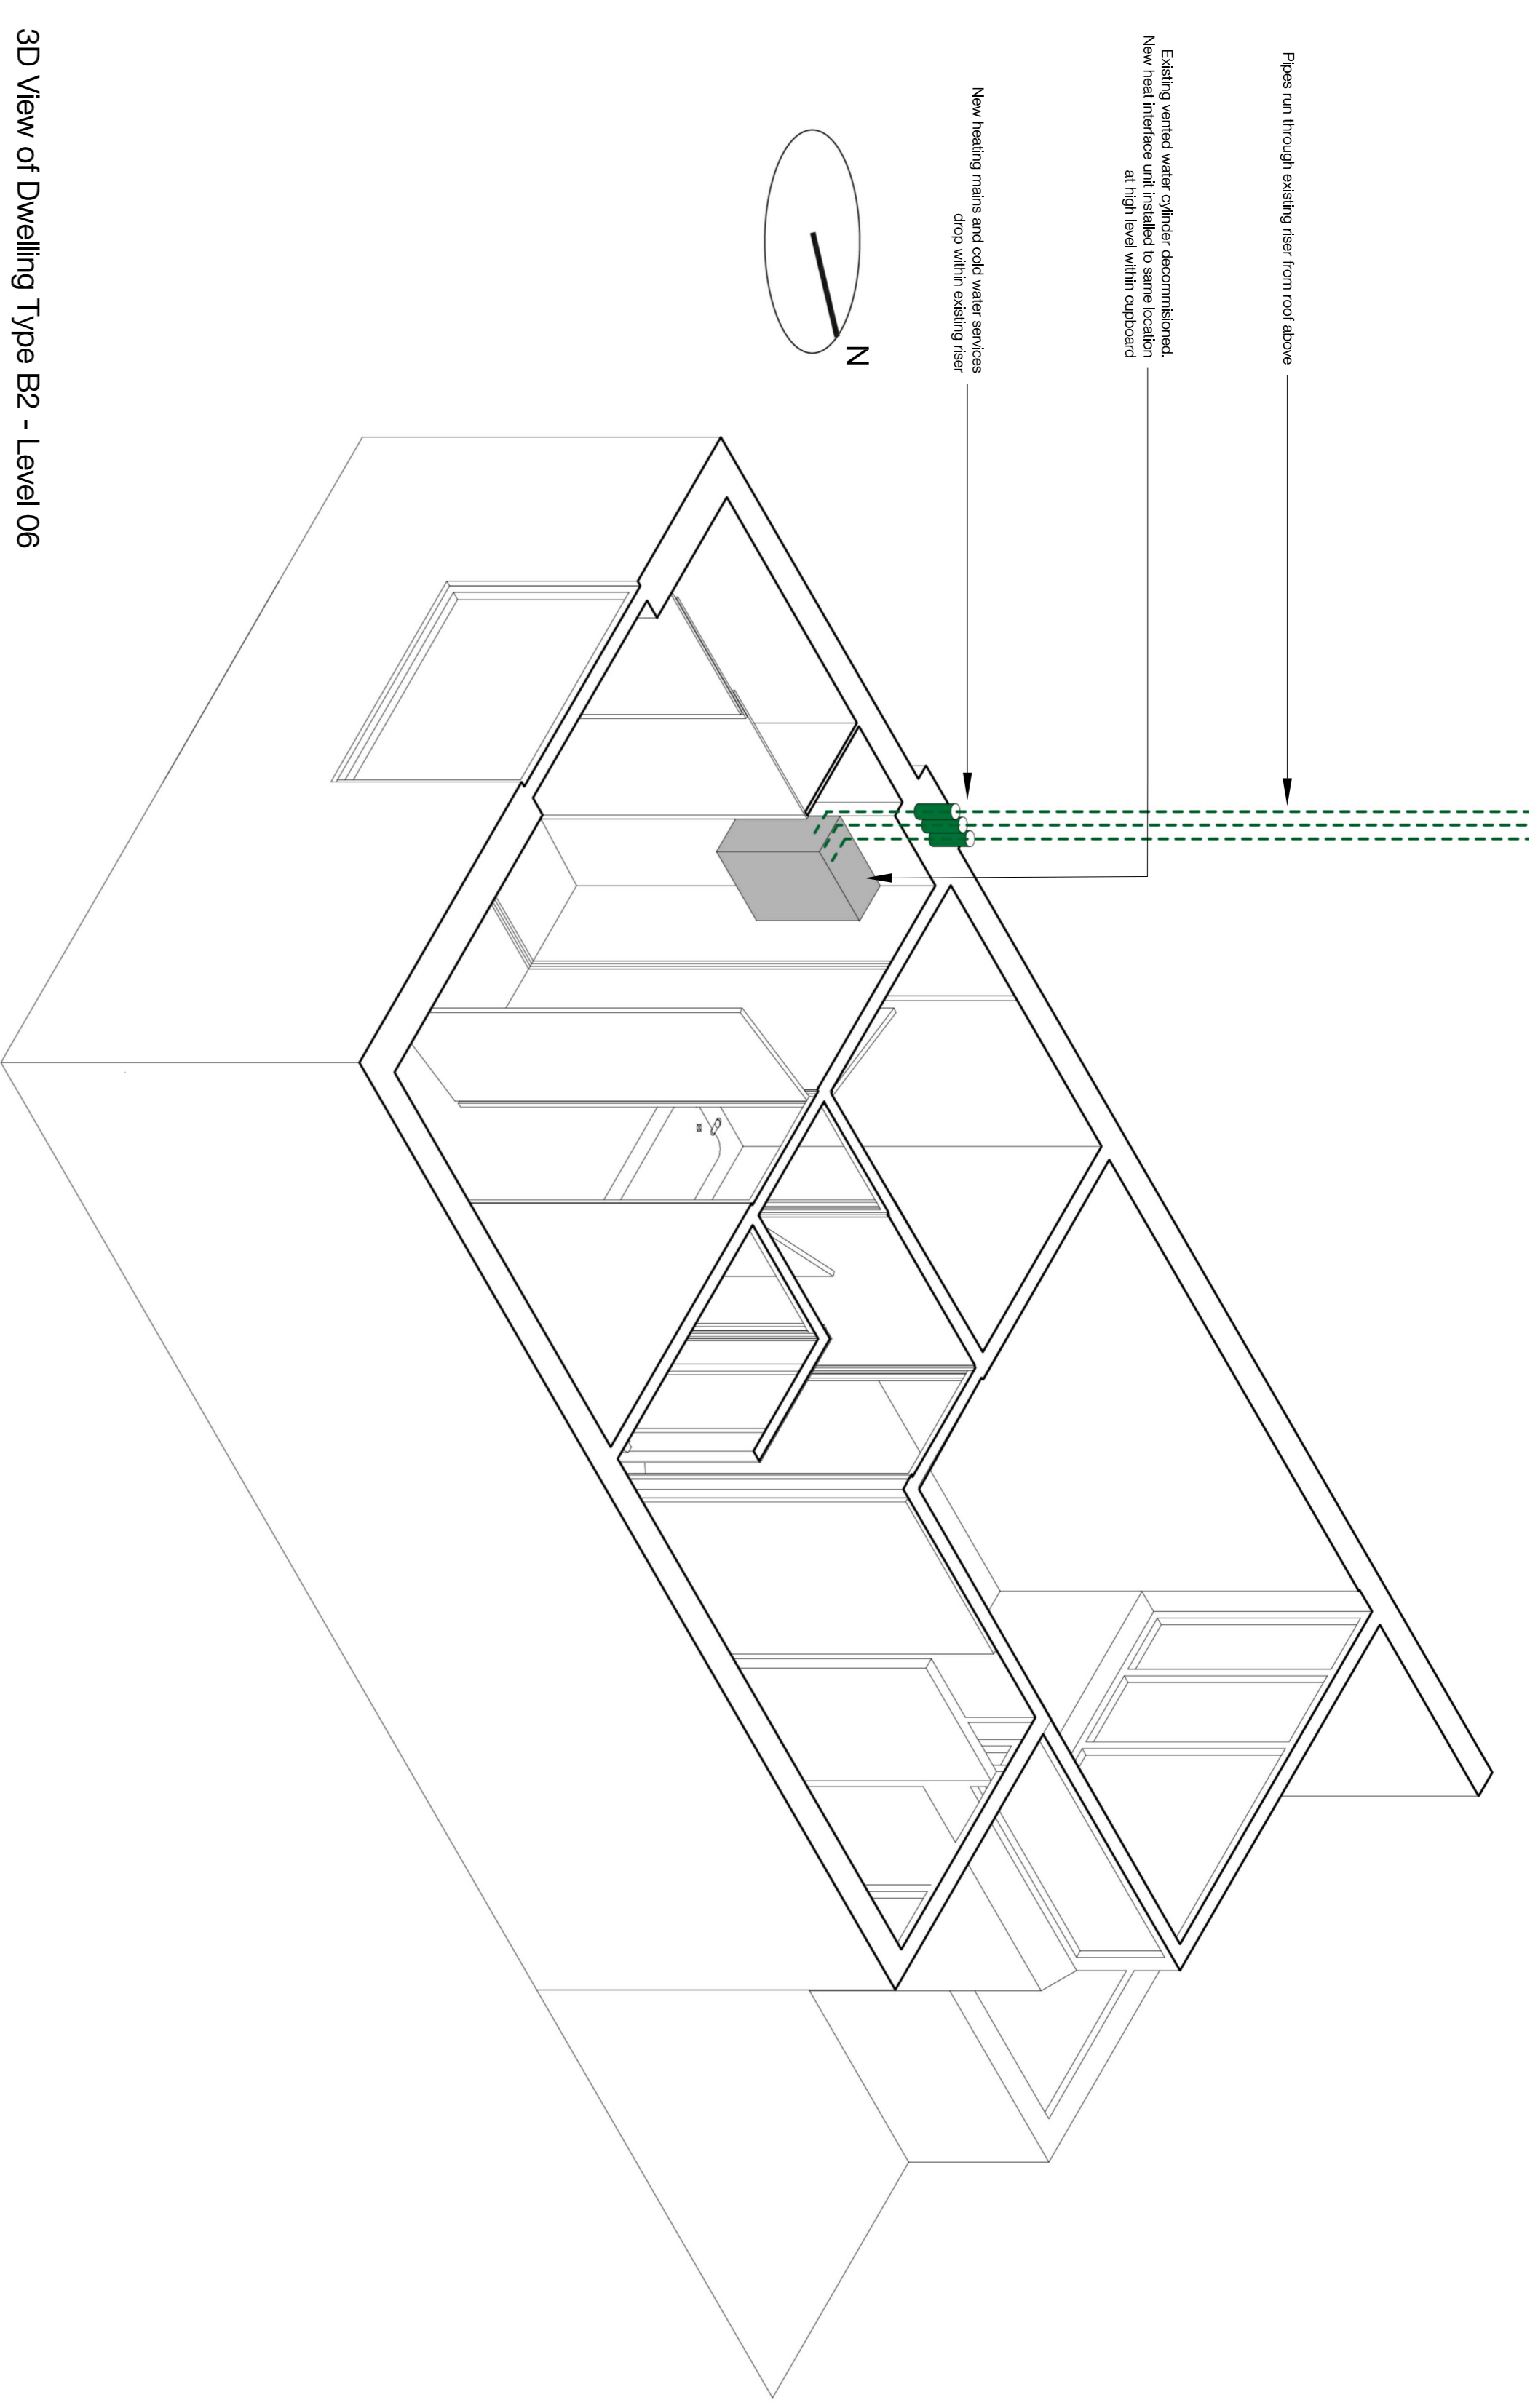

3D View of Dwelling Type B2 - Level 06

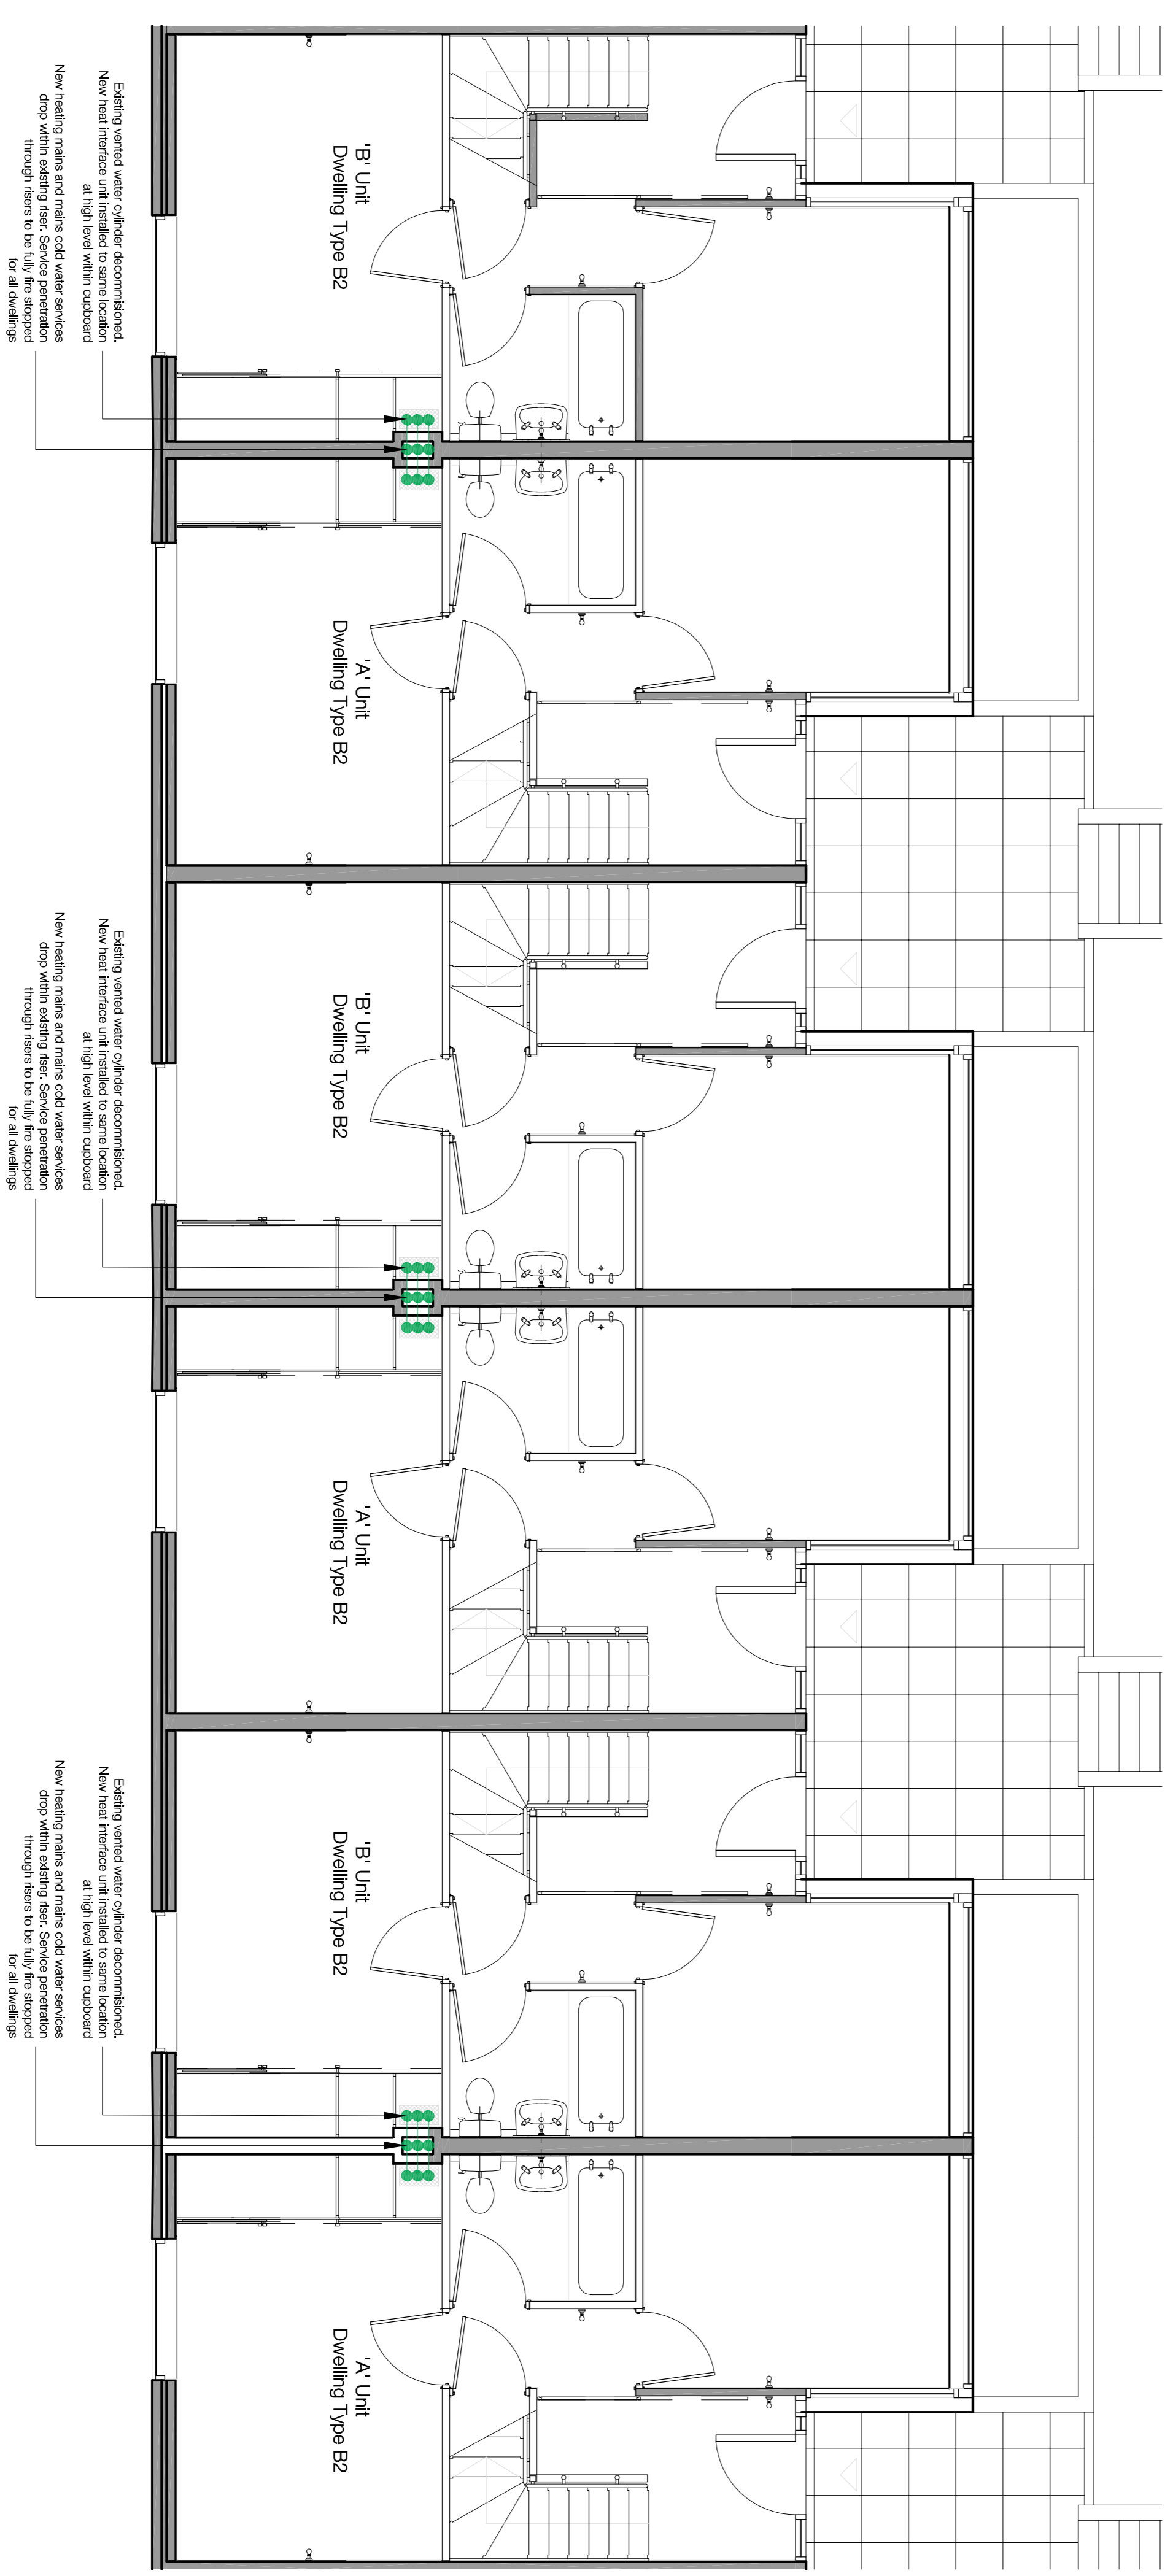

01 Block B Proposed Level 06 - Typical B2 Lower Floor Plan
120025 1:50

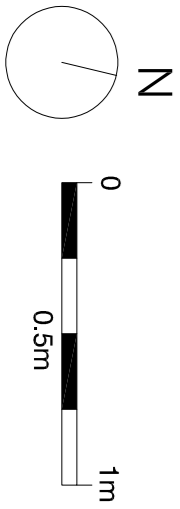

Project name	P2 17.11.23 - Planning & Listed Building Consent	KS
Rev. Date	P1 07.04.22 - For comment	KS
Rev. Date	Description	Initials
Project name		
Alexandra Rd Estate		
Heating Infrastructure		
Drawing number	3467_LB_120025	Rev
Drawing	Block B - Proposed Level 06	P2
Purpose of issue	Typical B2 Lower Floor Plan	
PLANNING	Date	17.11.23
Scale	1:50 @ A1	Drawn
Client	Camden CC	KS
Checked	PM	KS
lewtibenstein.co.uk		
London	Manchester	
2-4, Thorne Villas	2, Seagrave Street	
London N7 7PA	Manchester M3 4LZ	
+44 (0)20 7275 7676	+44 (0)16 1689 6740	