


DO NOT SCALE

NOTES:
1. FOR STANDARD DRAWING NOTES & LEGEND PLEASE REFER TO
DRAWING NO: 3547-RW-M-600)

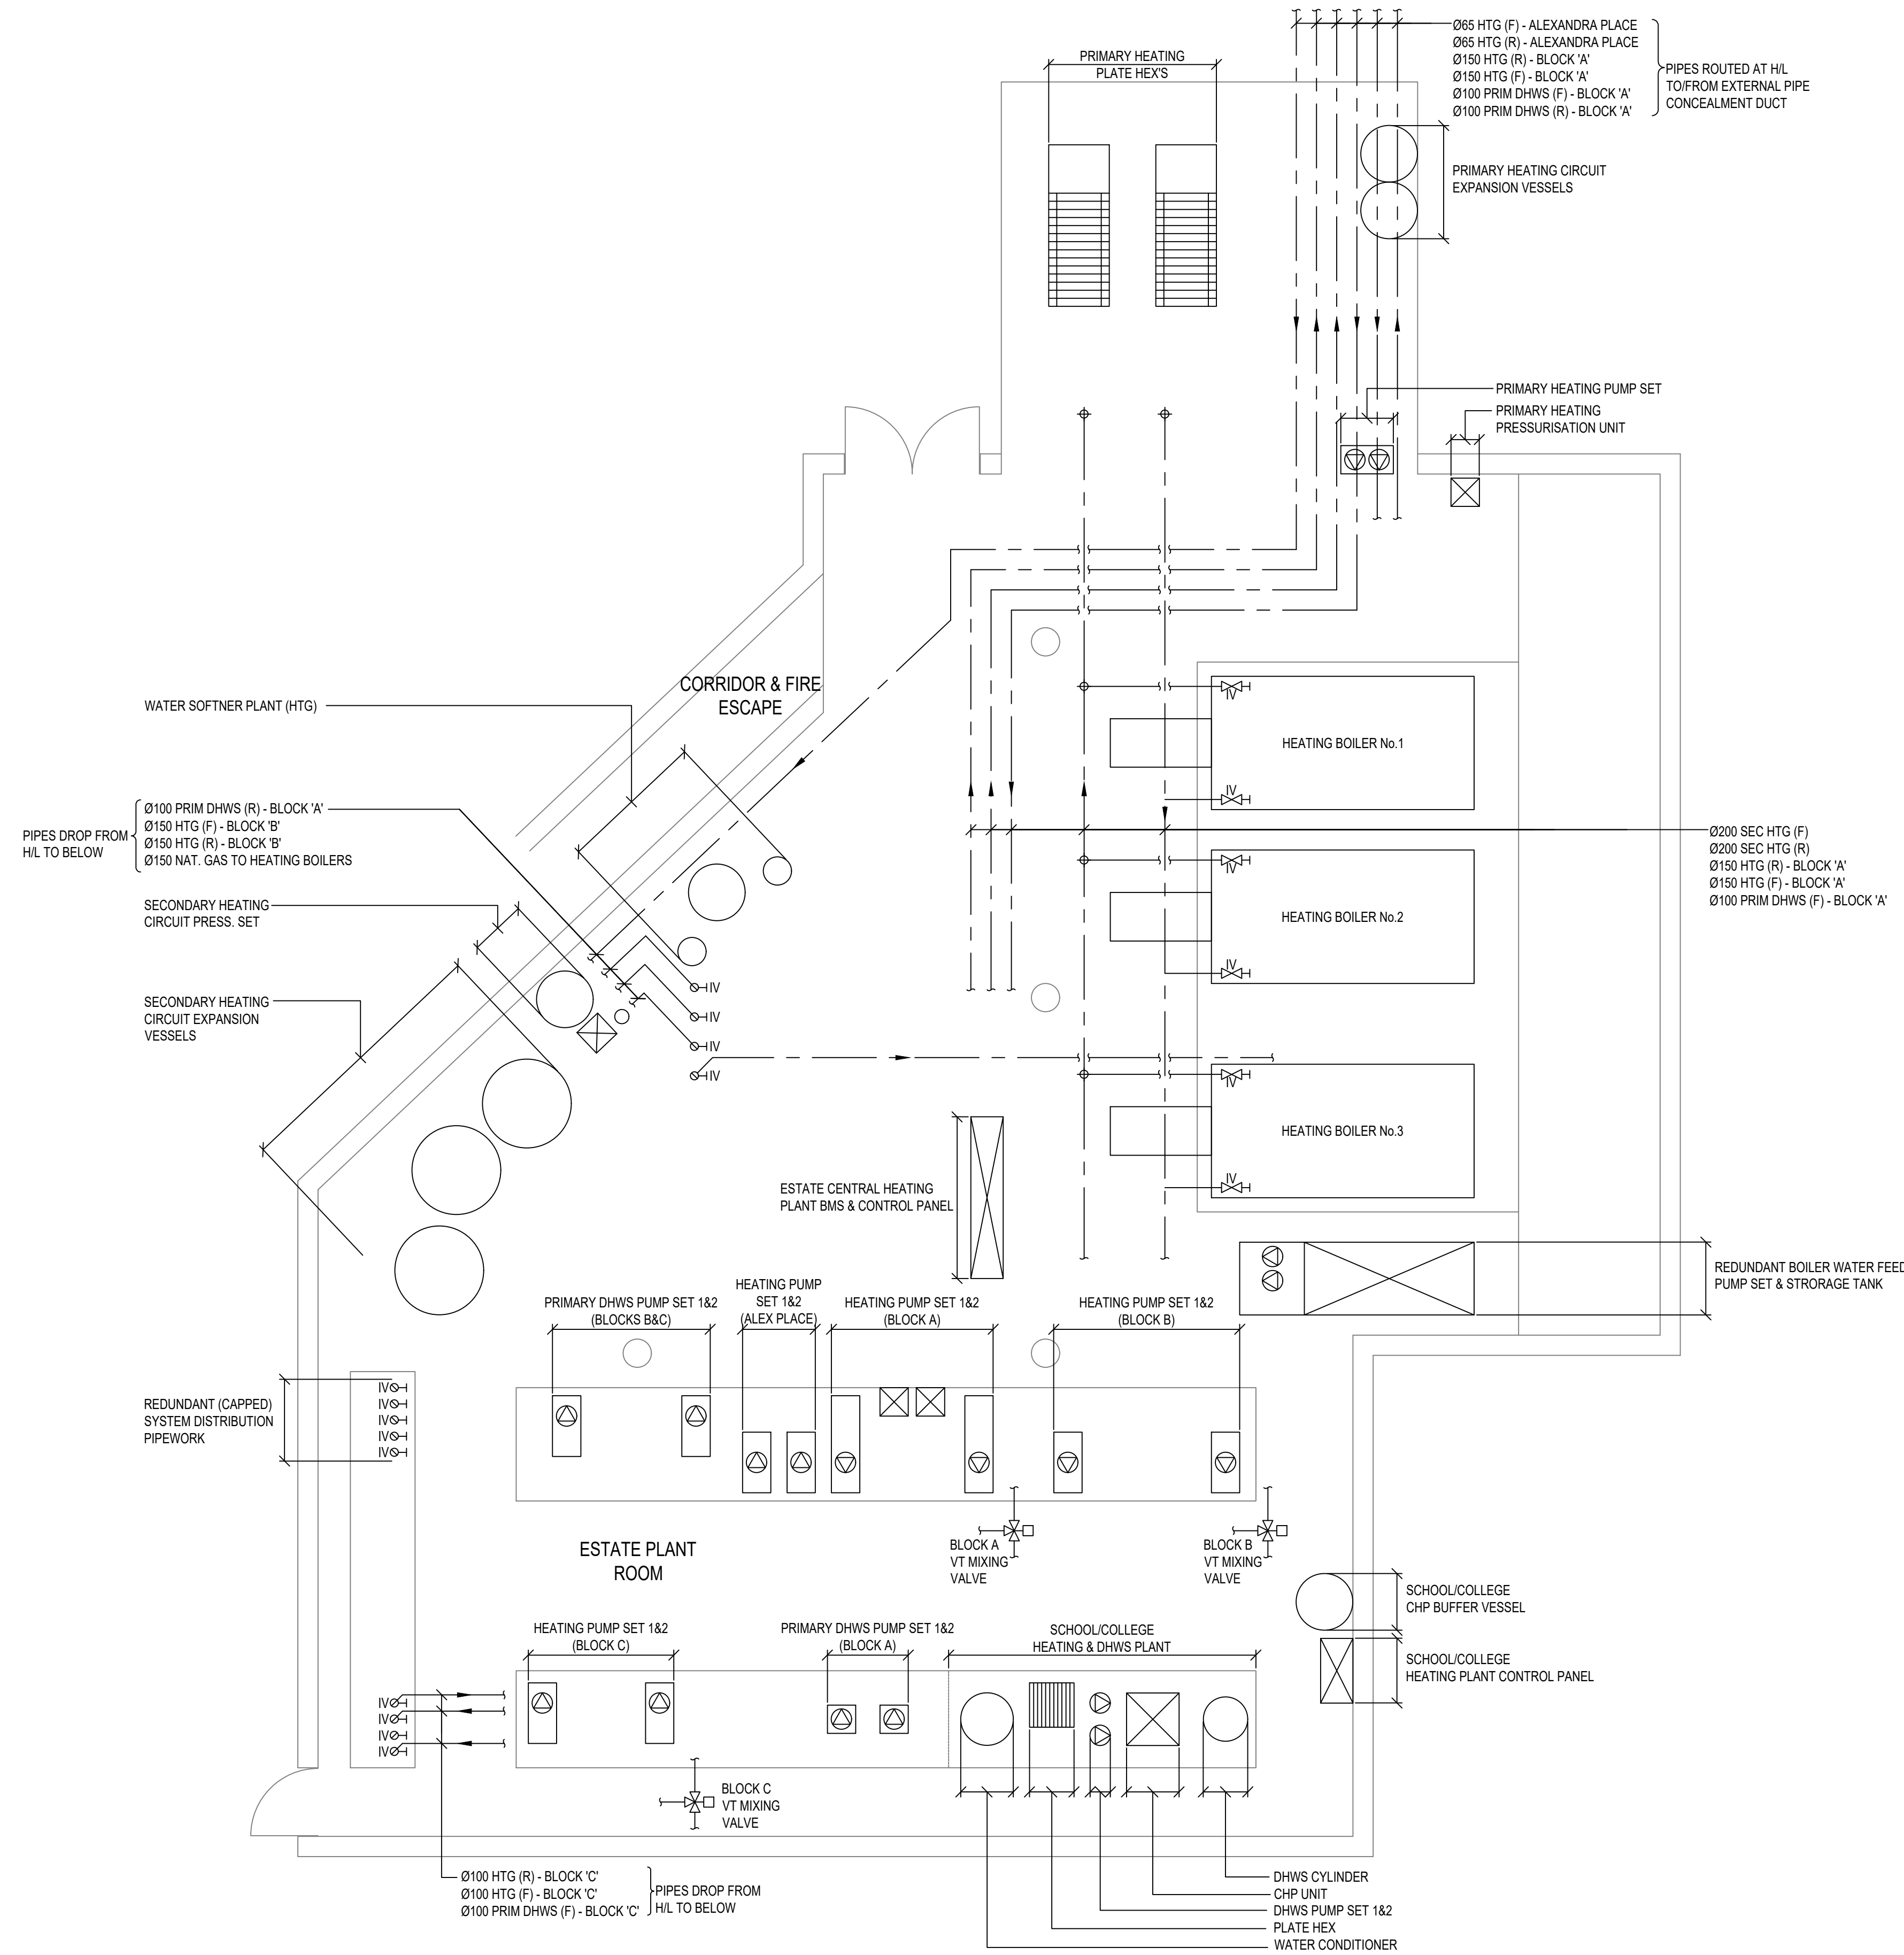

PLANNING DRAWING



ARGYLE STREET
LONDON
WC1H 8NJ



Mechanical and Electrical Consulting Engineers
1st Floor, 54-62 Station Road East, Oxted, Surrey RH8 0PG
Telephone 01883 717172 Fax 01883 717174
Website www.bya.co.uk Email enquiries@bya.co.uk

Project
ALEXANDRA ROAD ESTATE
(ROWLEY WAY)

Drawing Title
LAYOUT OF EXISTING ESTATE CENTRAL
HEATING PLANT ROOM

Scales 1:50	Ref: -	Drwg Sheet A1
Drawn NS	Checked FAF	Date NOV 23
BYA Ref: 3547	Drawing Number: 3547-RW-M-502	REV:
BYA Cad Ref: 3547-RW-M-502		