



DO NOT SCALE

NOTES:  
1. FOR STANDARD DRAWING NOTES & LEGEND PLEASE REFER TO  
DRAWING NO: 3547-RW-M-600)

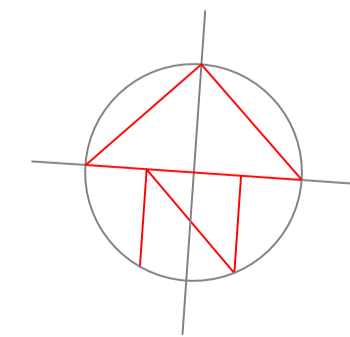

PLANNING DRAWING

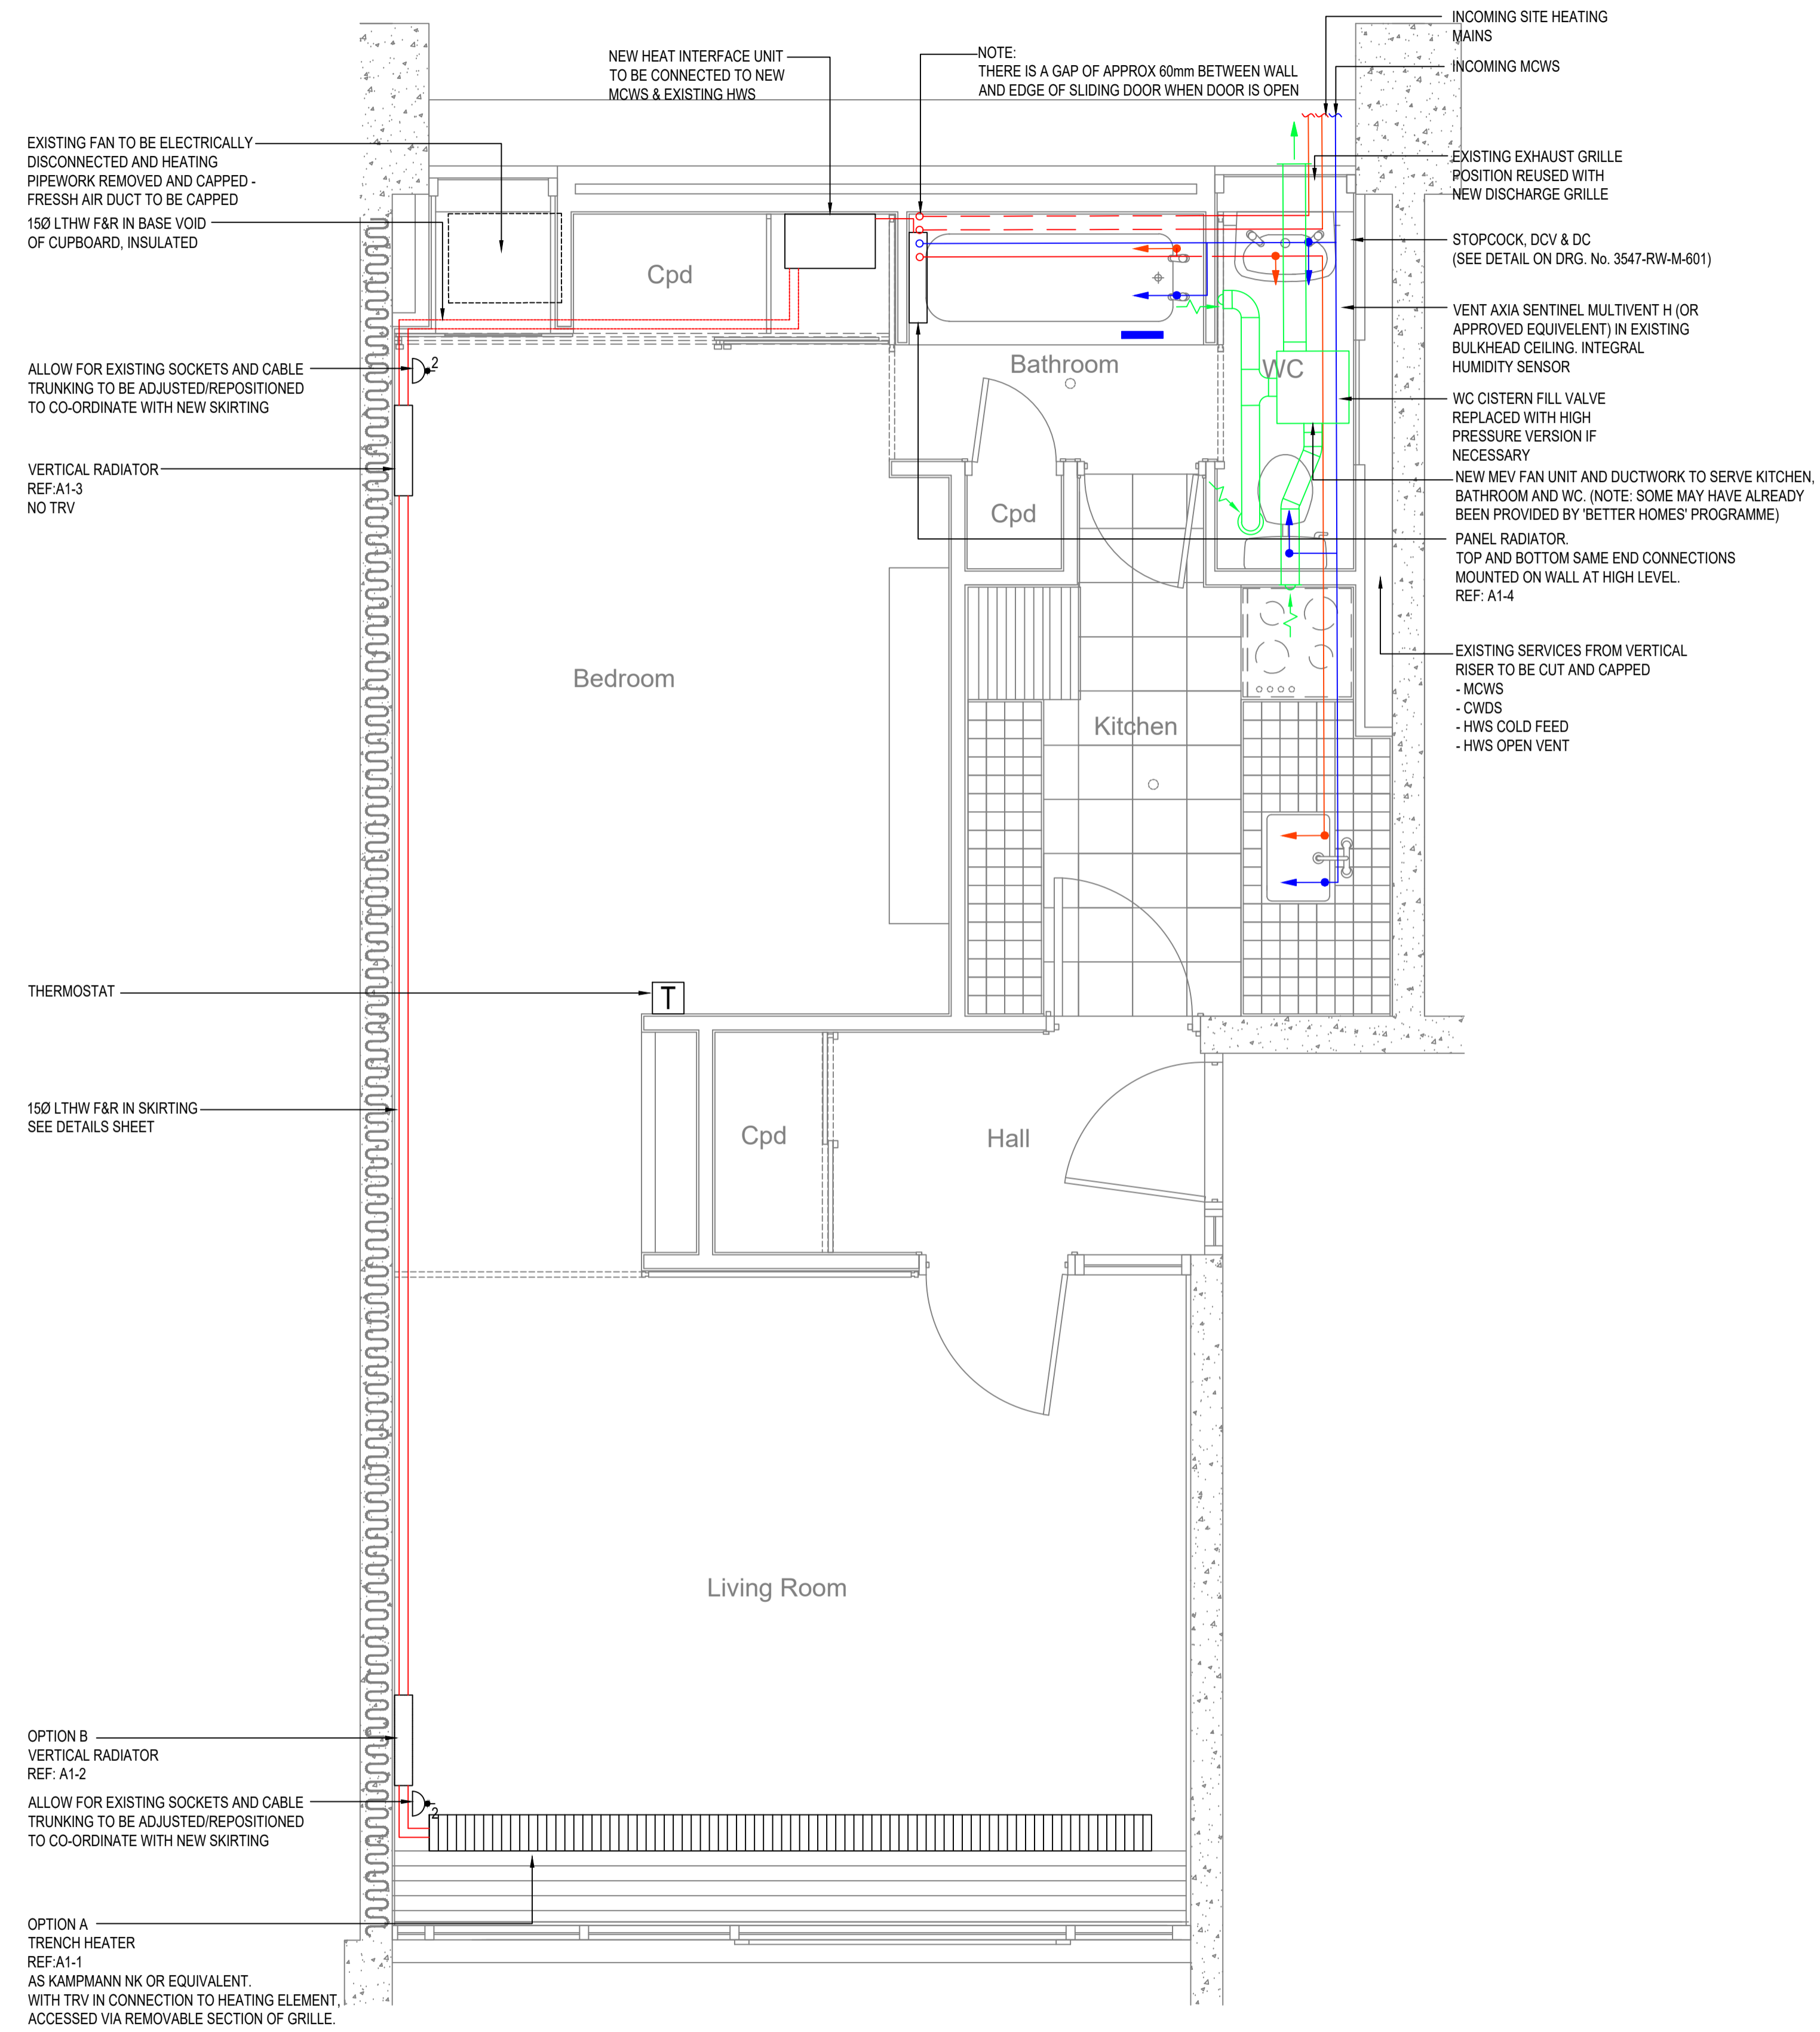

ARGYLE STREET  
LONDON  
WC1H 8NJ



Mechanical and Electrical Consulting Engineers  
1st Floor, 54-62 Station Road East, Oxted, Surrey RH8 0PG  
Telephone 01883 717172 Fax 01883 717174  
Website [www.bya.co.uk](http://www.bya.co.uk) Email [enquiries@bya.co.uk](mailto:enquiries@bya.co.uk)

Project  
ALEXANDRA ROAD ESTATE

Drawing Title  
MECHANICAL SERVICES  
UNIT TYPE A1  
HEATING LAYOUT

Scales 1:25	Xref.	Drwg Sheet A1
Drawn NS	Checked	Date NOV 23
BYA Ref. 3547	Drawing Number: 3547-RW-A1-550	REV.
BYA Cad Ref. 3547-RW-A1-550		