
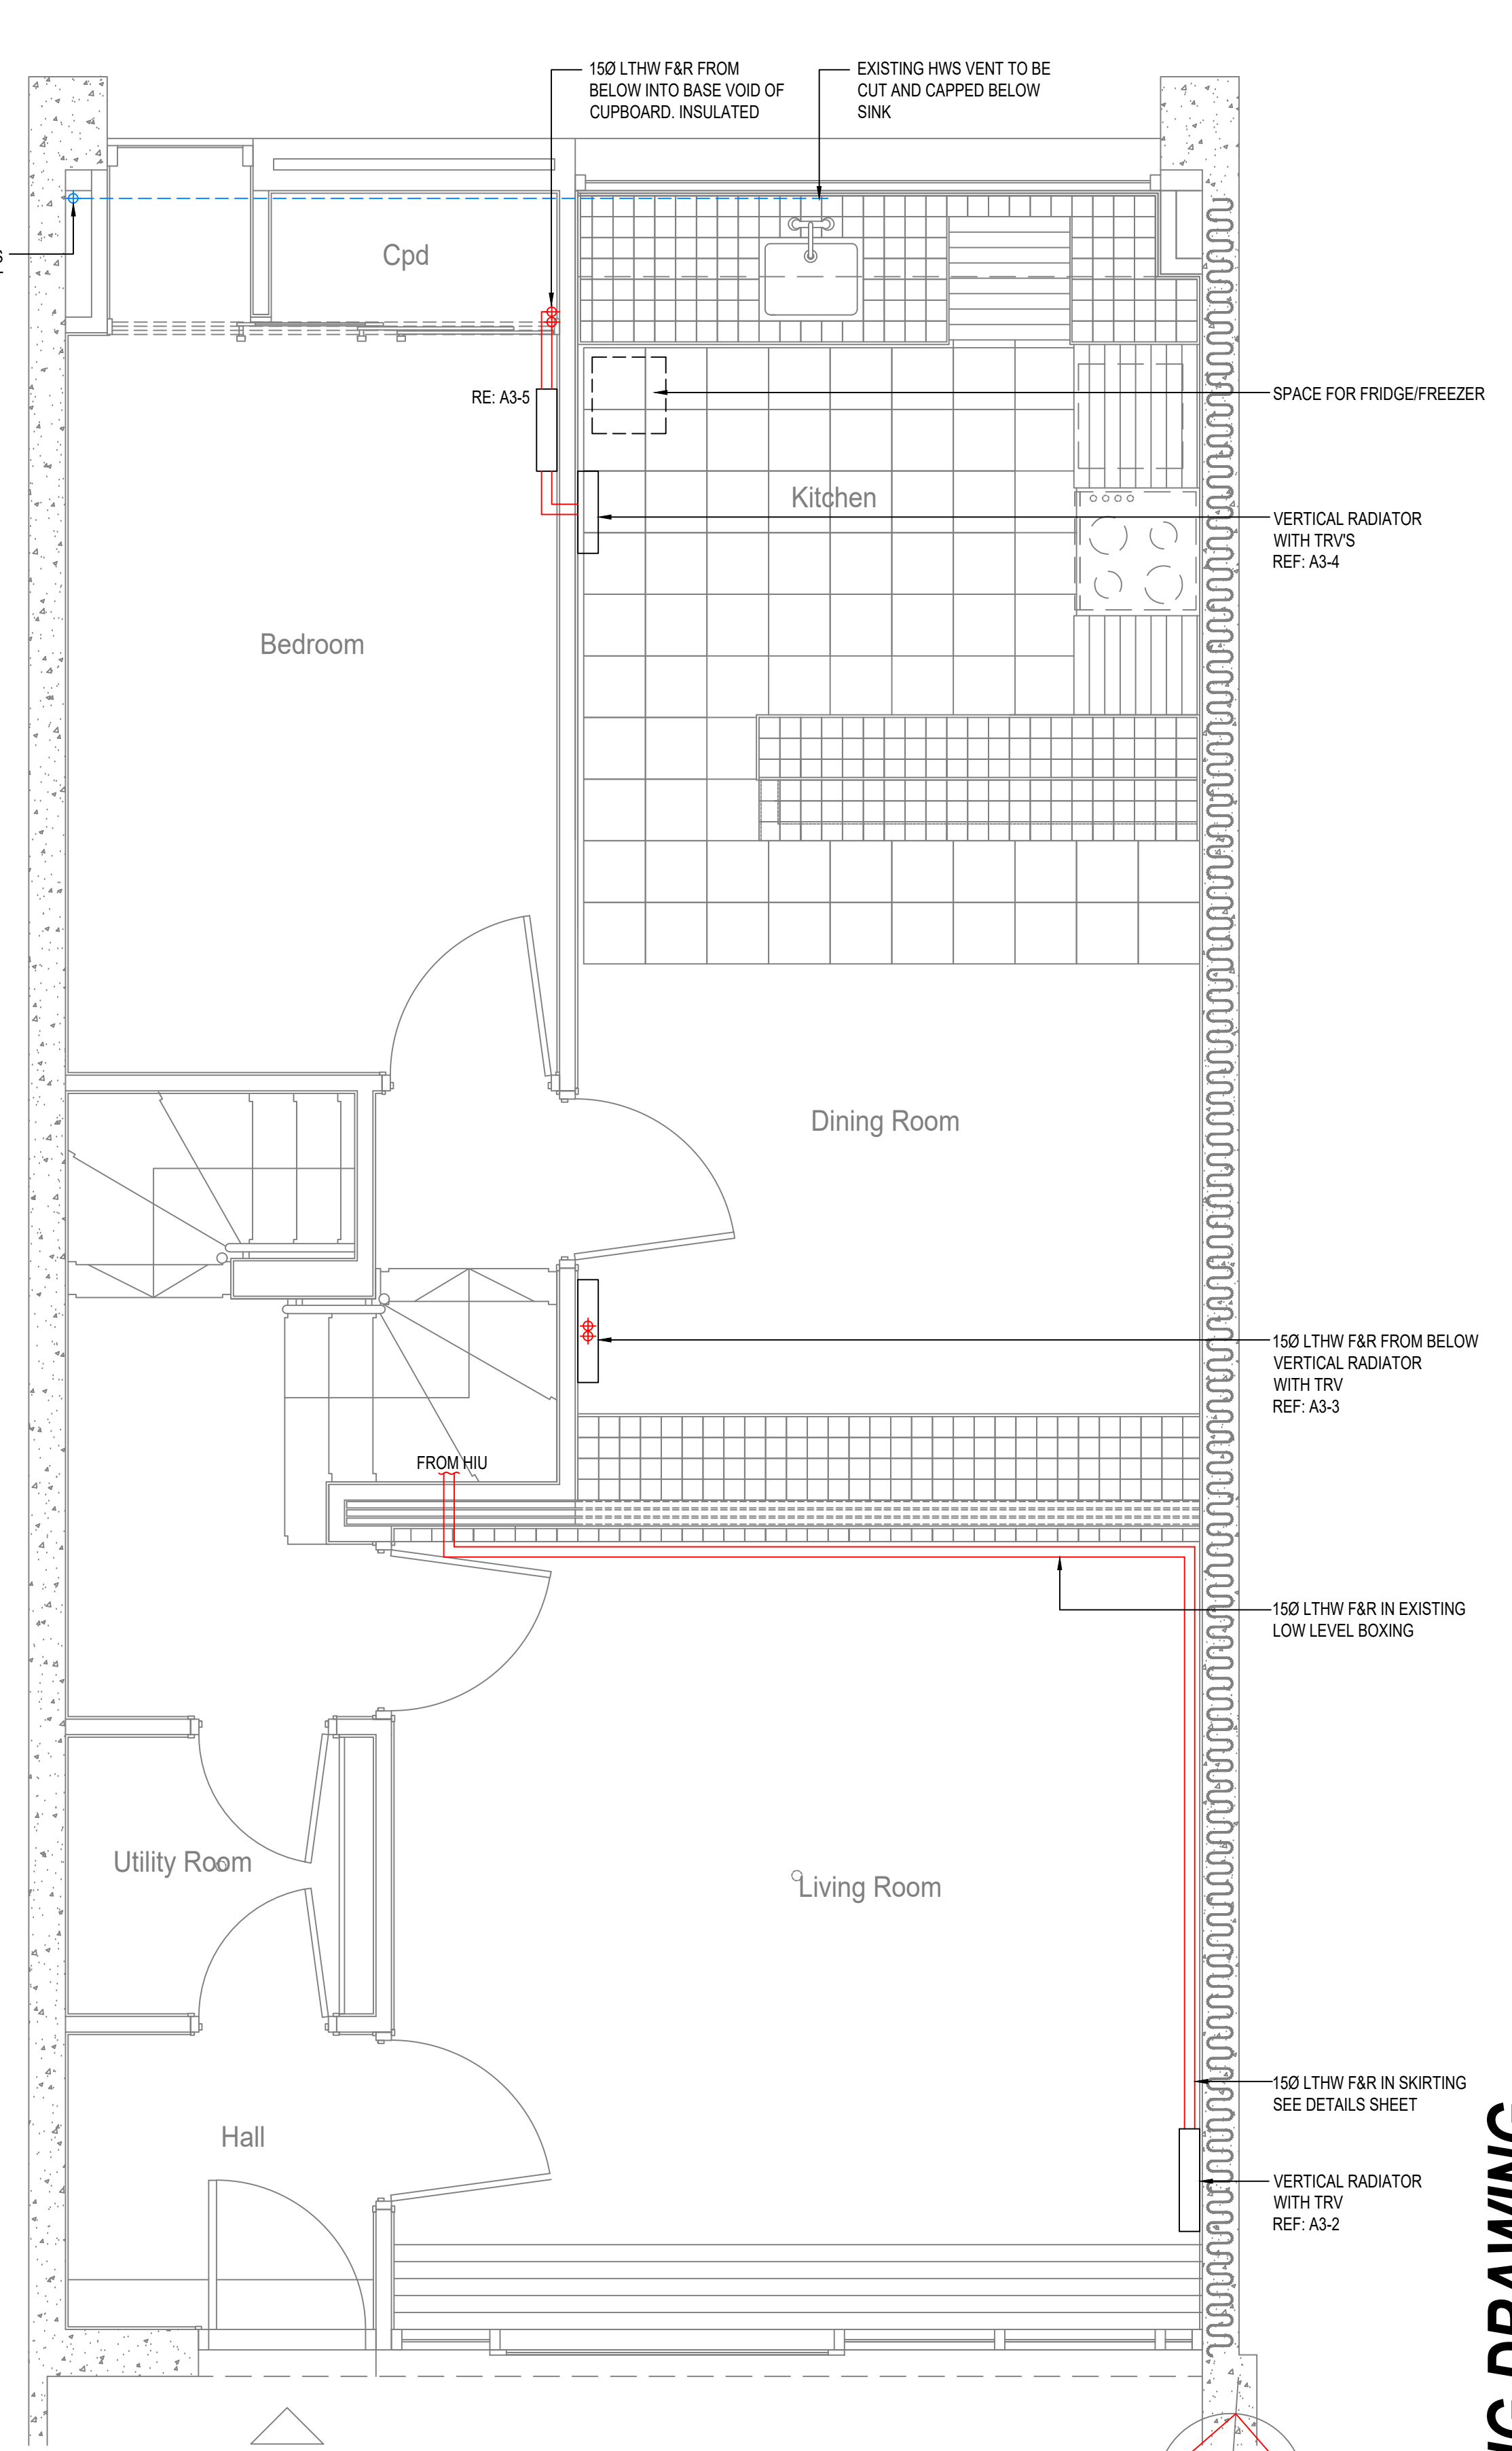


Drawing Number:  
**3547-RW-A3-552**

**DO NOT SCALE**

NOTES:  
1. FOR STANDARD DRAWING NOTES & LEGEND PLEASE REFER TO  
DRAWING NO: 3547-RW-M-600)

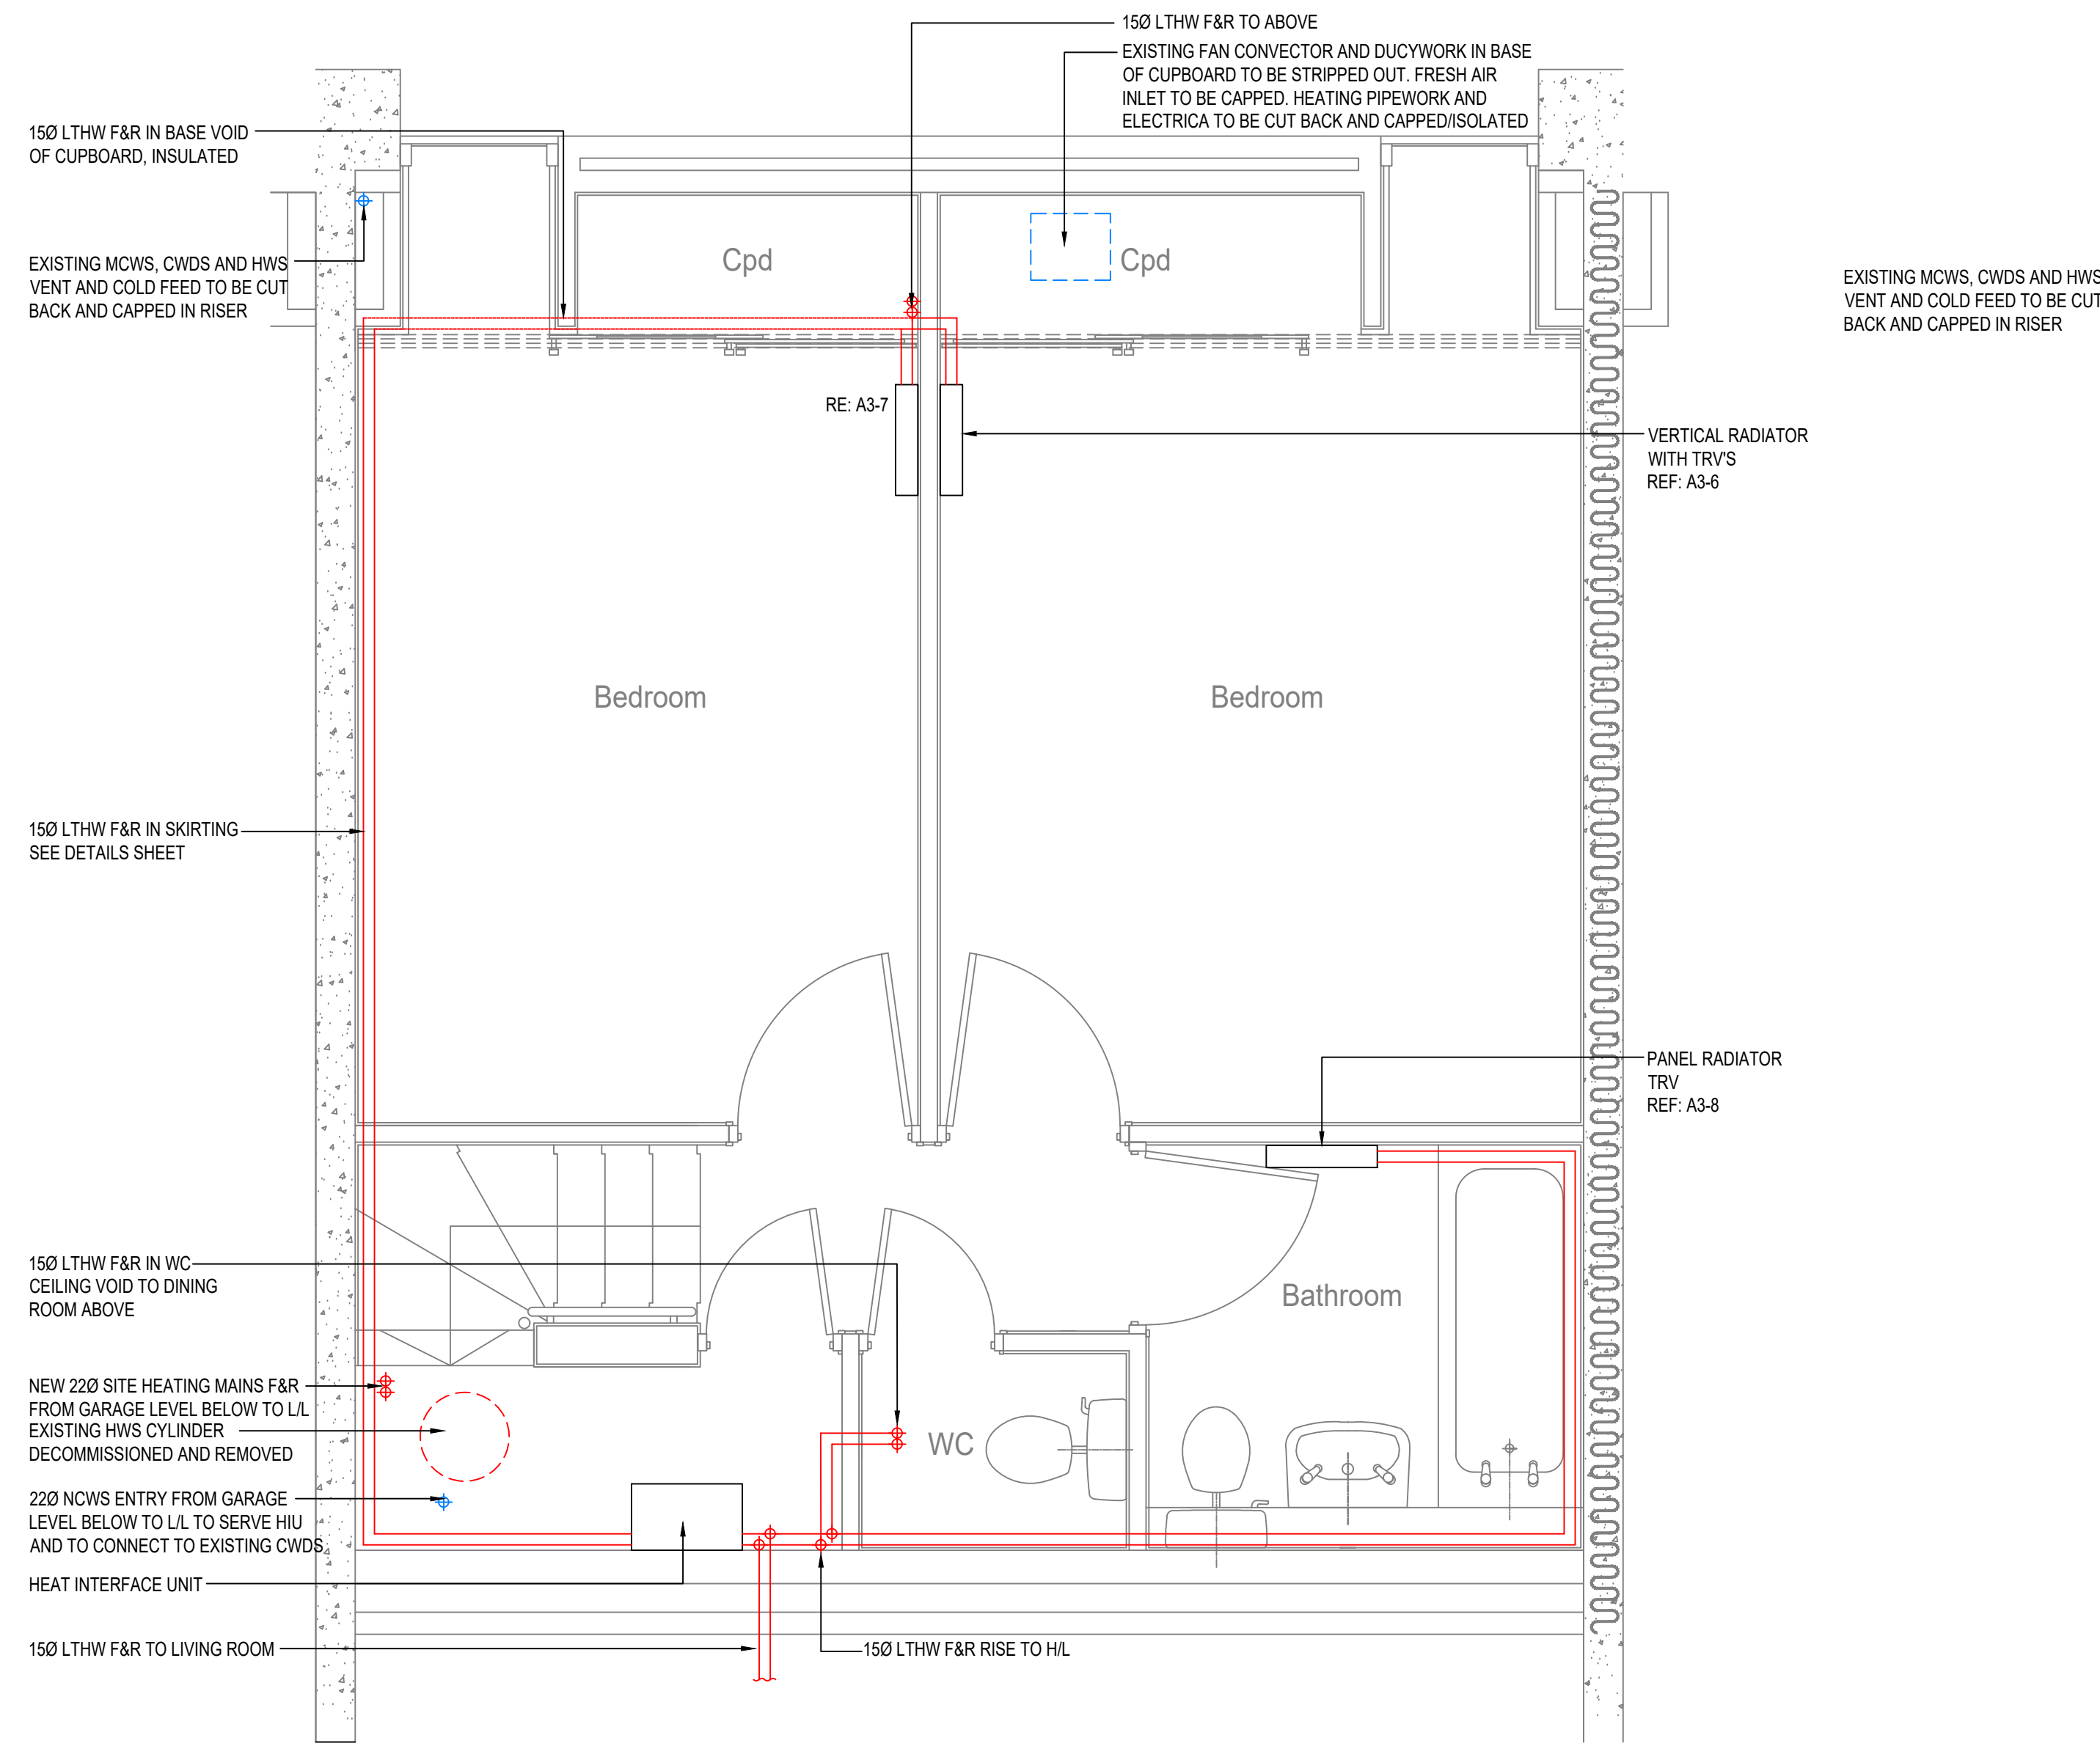

**PLANNING DRAWING**

Client  
  
 ARGYLE STREET  
 LONDON  
 WC1H 8NJ

**BYA** BUTLER & YOUNG ASSOCIATES

Mechanical and Electrical Consulting Engineers  
 1st Floor, 54-62 Station Road East, Oxted, Surrey RH8 0PG  
 Telephone 01883 717172 Fax 01883 717174  
 Website www.bya.co.uk Email enquiries@bya.co.uk

Project  
**ALEXANDRA ROAD ESTATE**

Drawing Title  
**MECHANICAL SERVICES  
 UNIT TYPE A3  
 HEATING LAYOUT**

Scales 1:25	Xref. NS	Drwg Sheet A1
Drawn NS	Checked	Date NOV 23
BYA Ref: 3547	BYA Cad Ref: 3547-RW-A3-552	Drawing Number: <b>3547-RW-A3-552</b>
		REV: