



Notes
 It is the responsibility of the person reading this drawing to establish that they are using the most current version including all other documents produced either by Synergy Consulting Engineers or by any other parties to the project. IF IN ANY DOUBT - ASK!
 No scaling permitted from this drawing. This drawing is copyright © S4-For Tender


- TYPICAL ELECTRIC LEGEND:**
- RED BED HEAD CONTROL
 - BT BT SERVICES
 - DA DOOR ASSIST
 - DW DISH WASHER
 - EX EXTRACTOR FAN
 - FR FRIDGE
 - HS COOKER CONNECTION
 - MVHR MECHANICAL VENTILATION HEAT RECOVERY
 - PH PANEL HEATER
 - TR TOWEL RAIL
 - WM WASHING MACHINE
- TYPICAL FLATS LEGEND:**
- HL HIGH LEVEL
 - LL LOW LEVEL
 - F/A FROM ABOVE
 - F/B FROM BELOW
 - T/B TO BELOW
 - T/A TO ABOVE
 - F&R FLOW & RETURN
 - DHW/SF DOMESTIC HOT WATER SERVICE
 - BCWS BOOSTED COLD WATER SERVICE
 - MCWS MAINS COLD WATER SERVICE
 - CAT 1 CAT 1 BOOSTED COLD WATER SERVICE
 - LTHW LOW TEMPERATURE HOT WATER
 - SK SINK
 - WBE WASH HAND BASIN
 - WC TOILET
 - SH SHOWER
 - BT BATH
 - AF ACCESS PANEL
 - EPH ELECTRIC PANEL HEATER
 - TMN THERMOSTATIC MIXING VALVE
 - WM WASHING MACHINE
 - DW DISH WASHER
 - FR FRIDGE
 - EX EXTRACTOR FAN
 - Ov OVEN
 - HE HOBB
- PIPEWORK LEGEND:**
- HIGH LEVEL PIPEWORK
 - LOW LEVEL PIPEWORK
 - BOOSTED COLD WATER SERVICE PIPEWORK
 - DOMESTIC HOT WATER SERVICE PIPEWORK
 - HEATING PIPEWORK
 - SPRINKLER PIPEWORK
- SYMBOLS:**
- SPRINKLER HEAD
 - ELECTRIC PANEL HEATER
 - ELECTRIC TOWEL RAIL
 - SUPPLY DUCT
 - RETURN DUCT
 - FRESH AIR DUCT
 - EXHAUST DUCT
 - ISOLATION VALVE
 - PENUM BOX
 - MVHR UNIT
 - CIRCULAR EXTRACT GRILLE
 - CIRCULAR SUPPLY GRILLE
- NOTES:**
- SPRINKLER LAYOUT INDICATIVE ONLY. SPRINKLER DESIGN IS TO BE COMPLETED BY SPECIALIST INCLUDING PIPE SIZING
 - ALL WASH HAND BASINS, BATHS & SHOWERS TO INCLUDE THERMOSTATIC MIXING VALVES TO AVOID SCALDING.

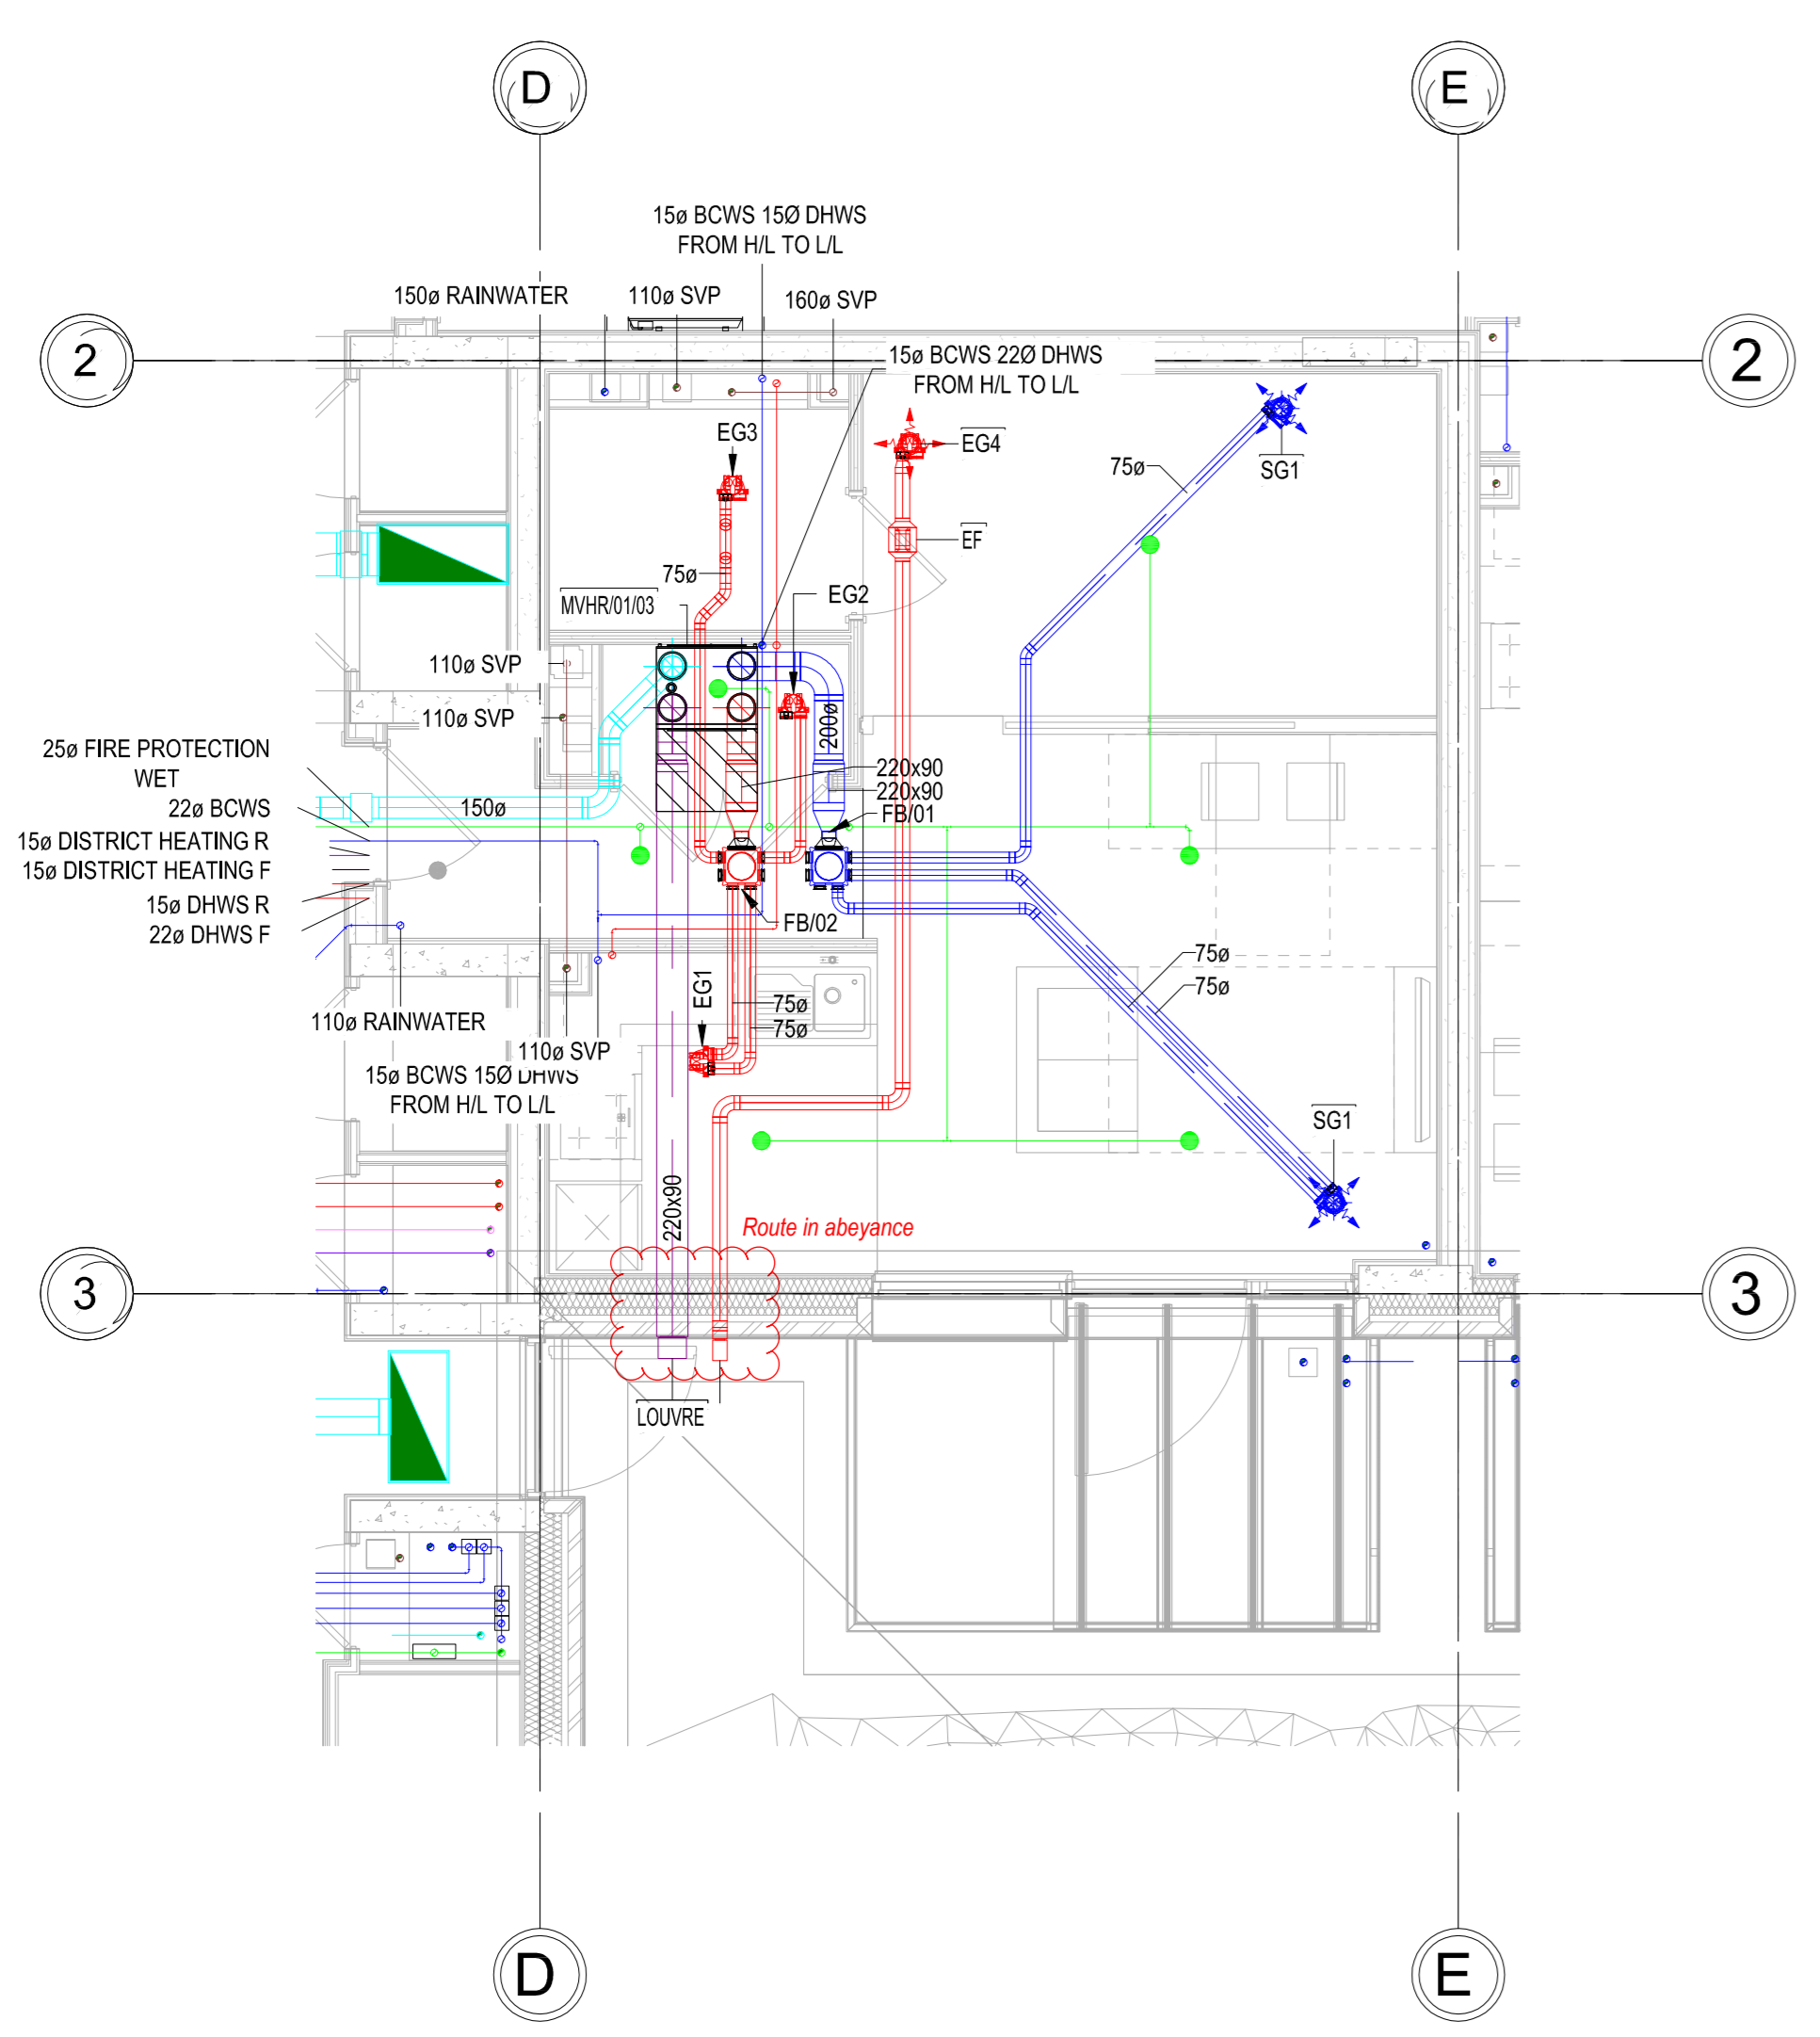


○ 01 - Typical Apartment Type A - H/L
 1 : 50

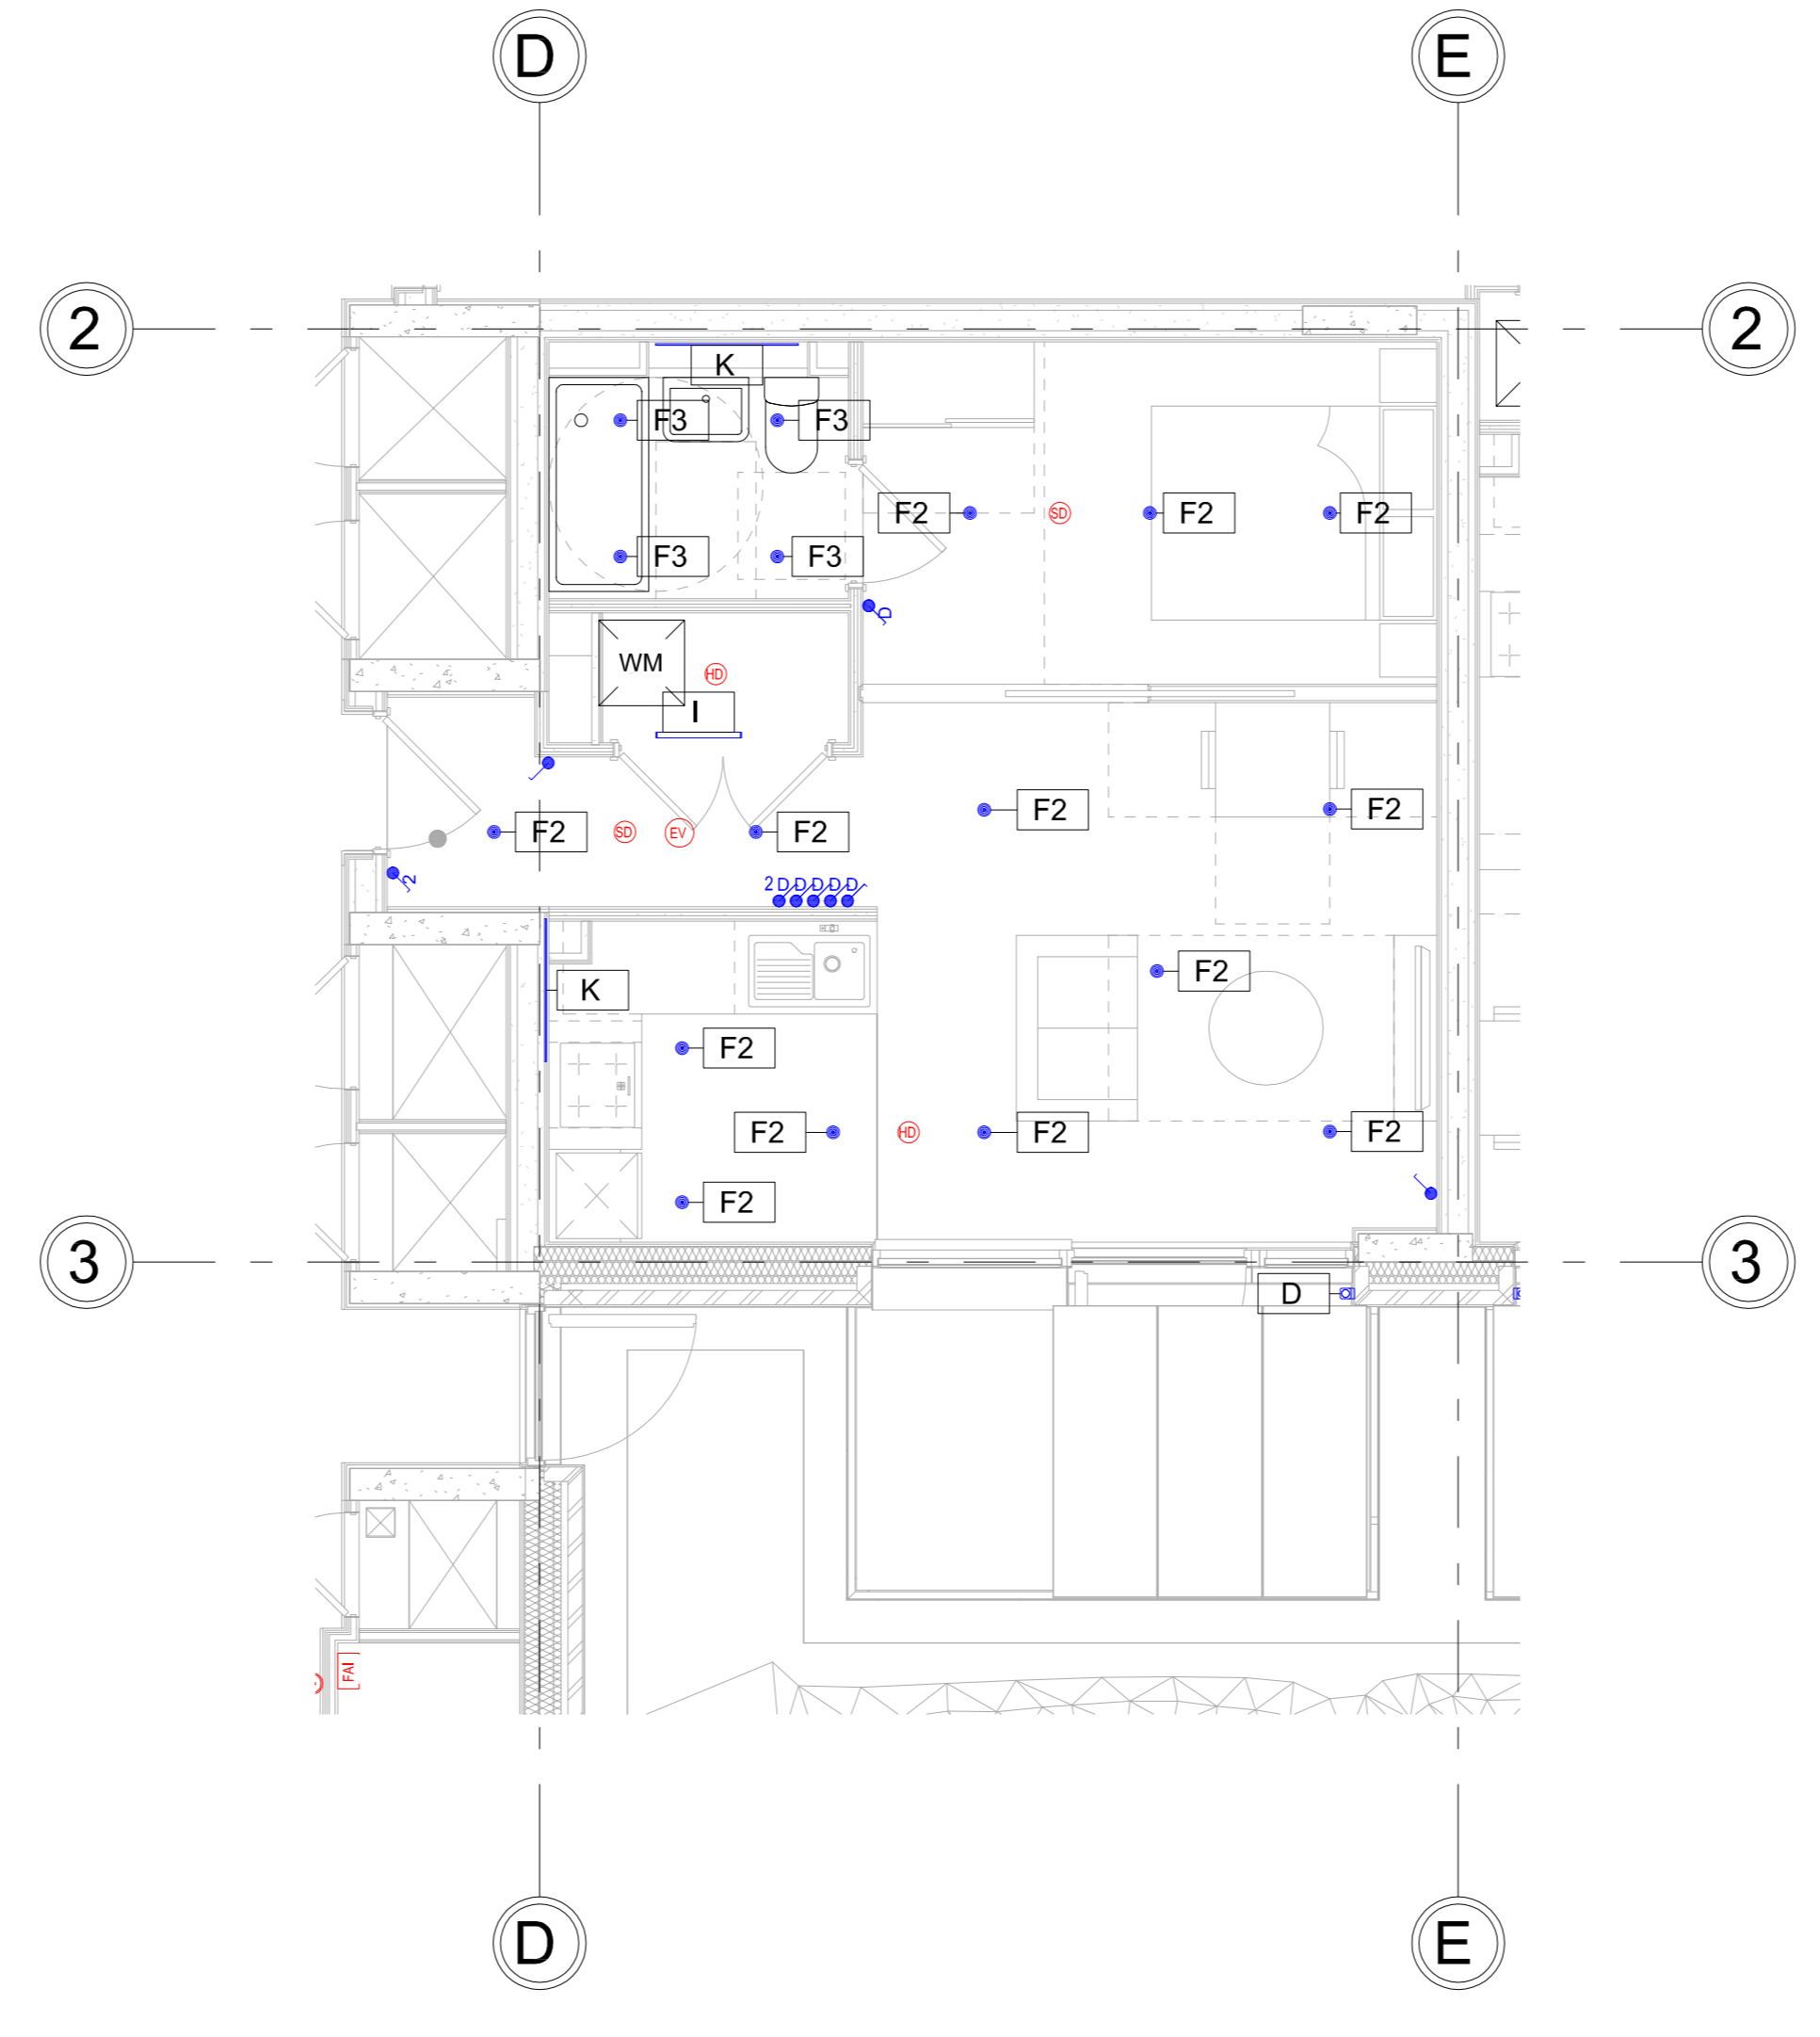

○ 01 - Typical Apartment Type A - Lighting and FA
 1 : 50

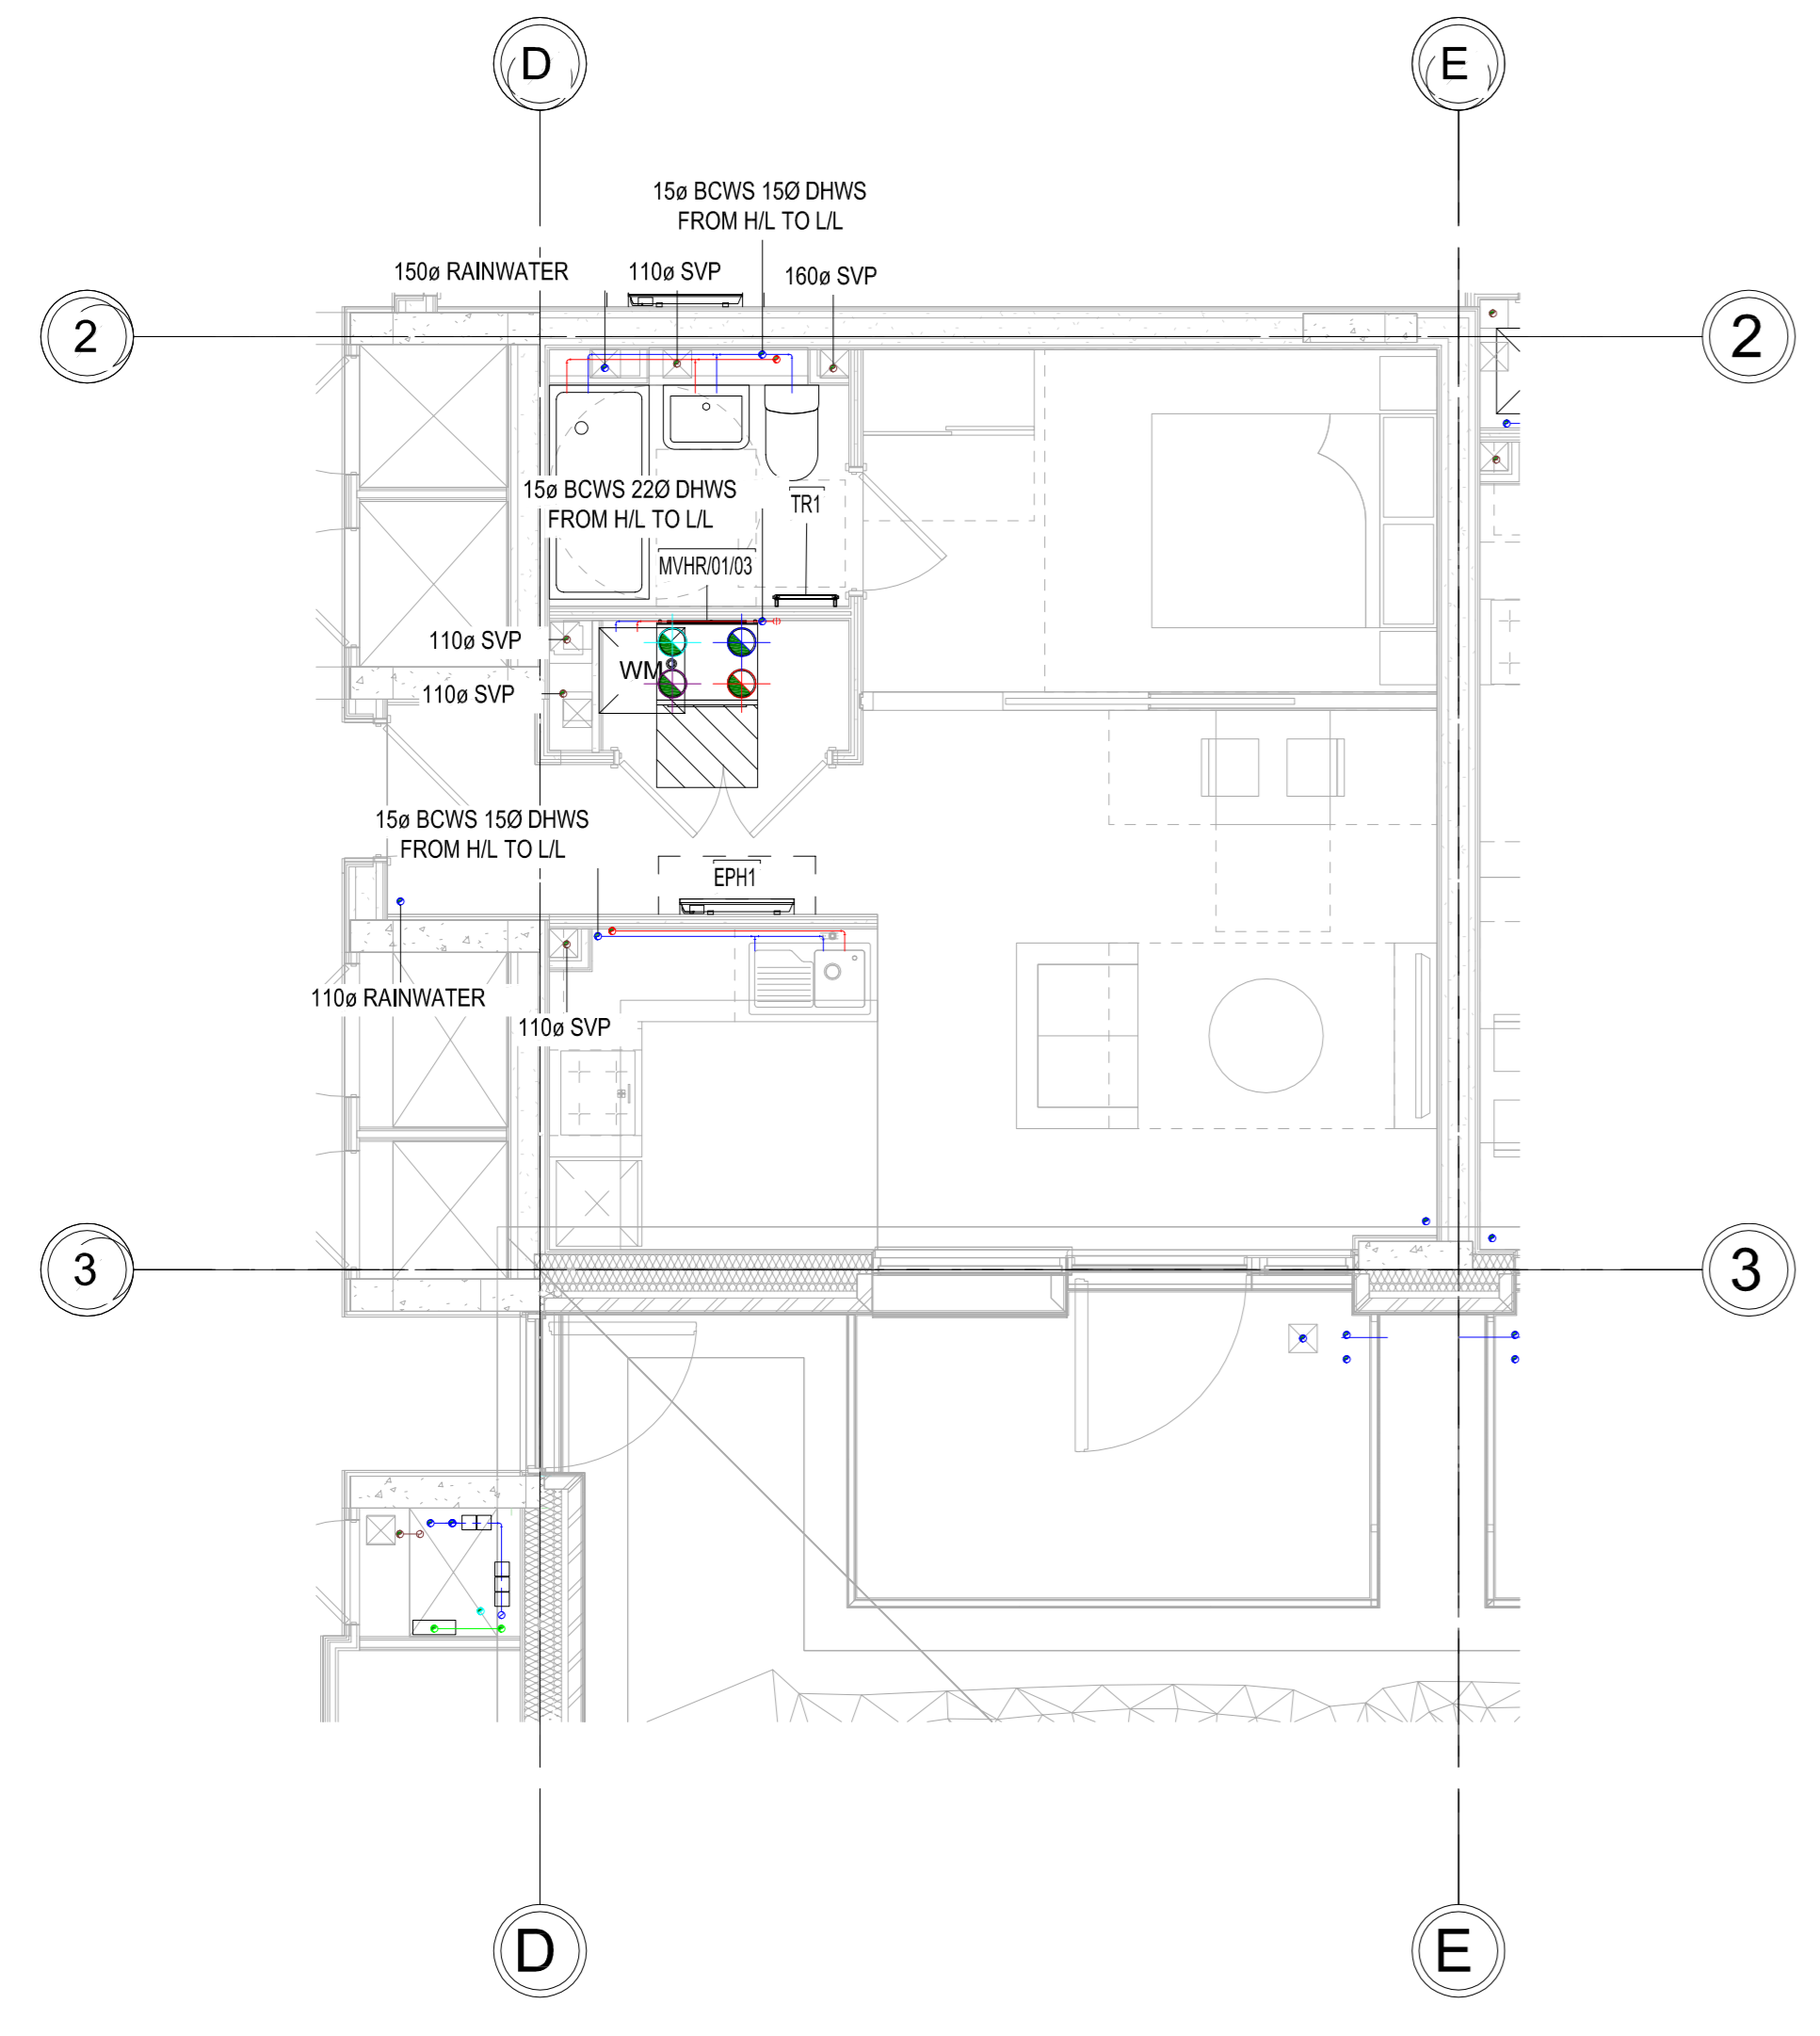

○ 01 - Typical Apartment Type A - L/L
 1 : 50

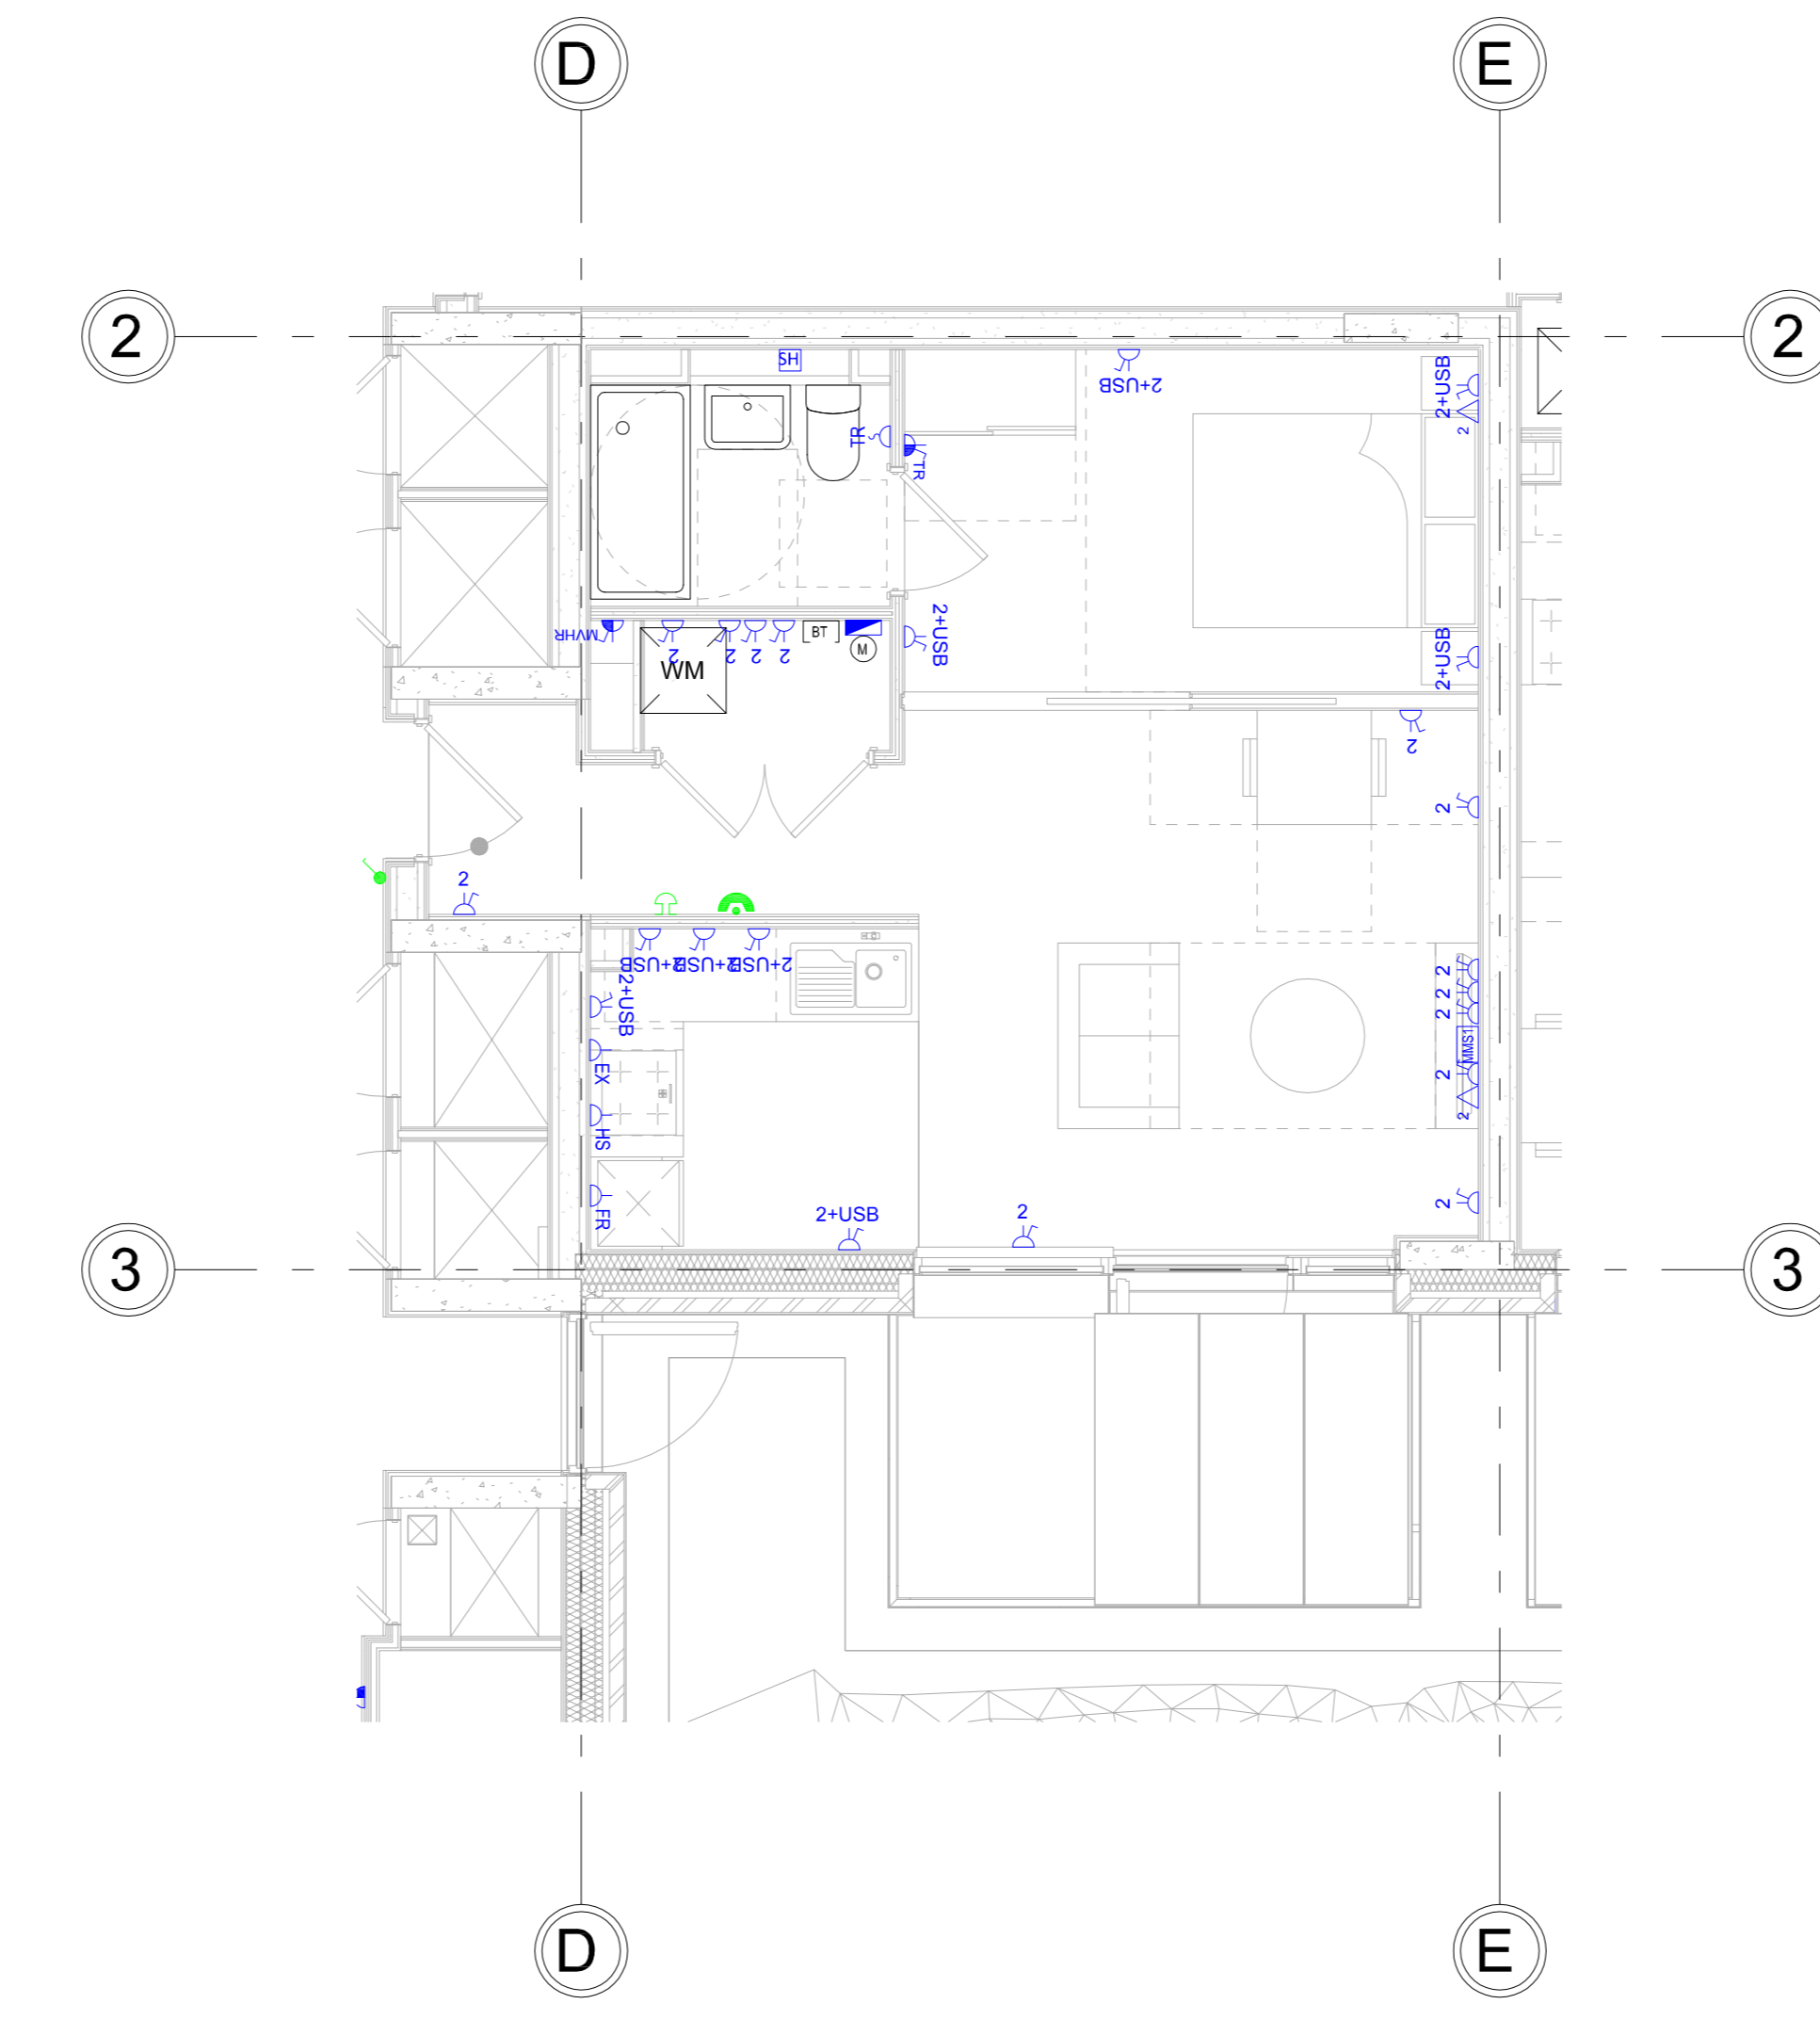

○ 01 - Typical Apartment Type A - Small Power and AC
 1 : 50

T01 TENDER	WB	10/11/23
P01 PRELIMINARY	WB	10/10/23
Rev. Amendment	Initial	Date

Synergy
 CONSULTING ENGINEERS
 Sustainable Mechanical, Electrical and Public Health Building Services
 8-14 St Pancras Way, 1 Canal Side Studios, London, NW1 0QQ
 Tel: 020 7300 8900 Fax: 020 7300 5132 Email: info@synergymech.co.uk www.synergymech.co.uk

Client
 Precis Advisory/
 Access Self Storage

Project
 Acorn House
 314-320 Grays Inn Rd, London
 WC1X 8DP

Drawing Title
 Typical Apartment Type A

Scale(s)	1 : 50 @ A0			
Drawn Date	08/10/23	Initial	BW/AM/Approved	AF
Job Number	08580	Status	S4-For Tender	
Purpose of Issue	TENDER			