



01 - Typical Apartment Type E - H/L
1 : 50

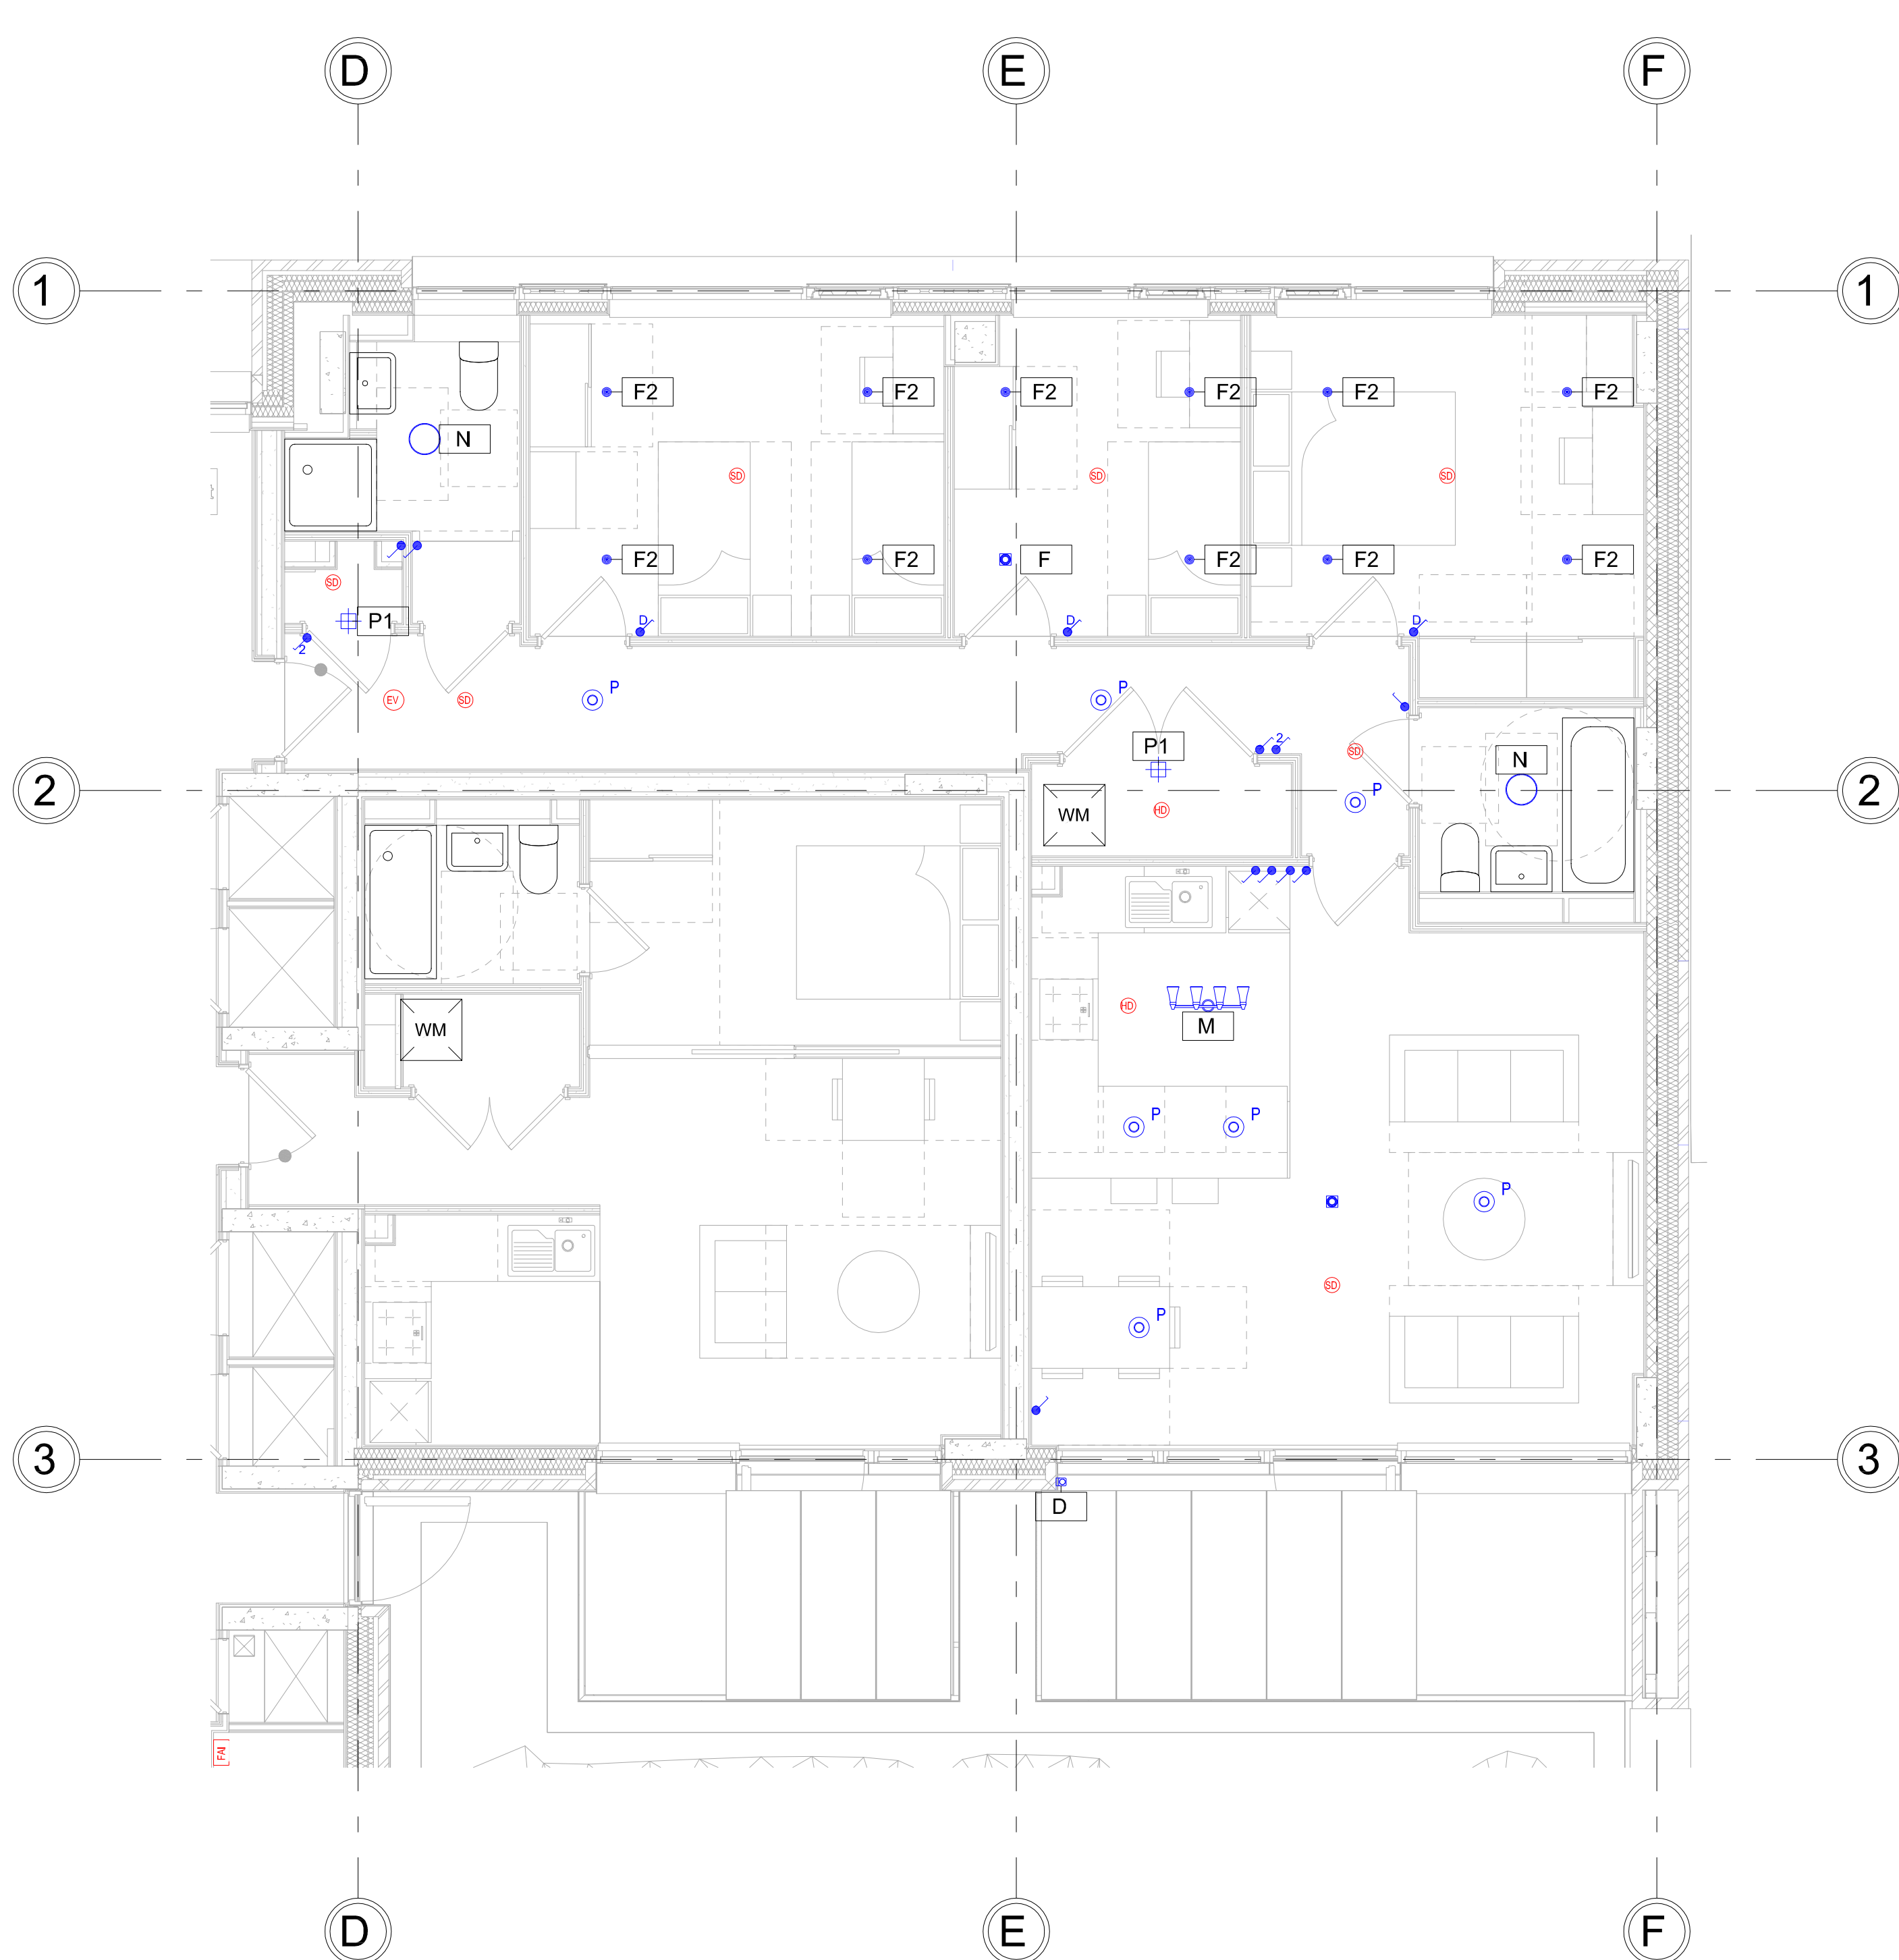

01 - Typical Apartment Type E - Lighting and FA
1 : 50

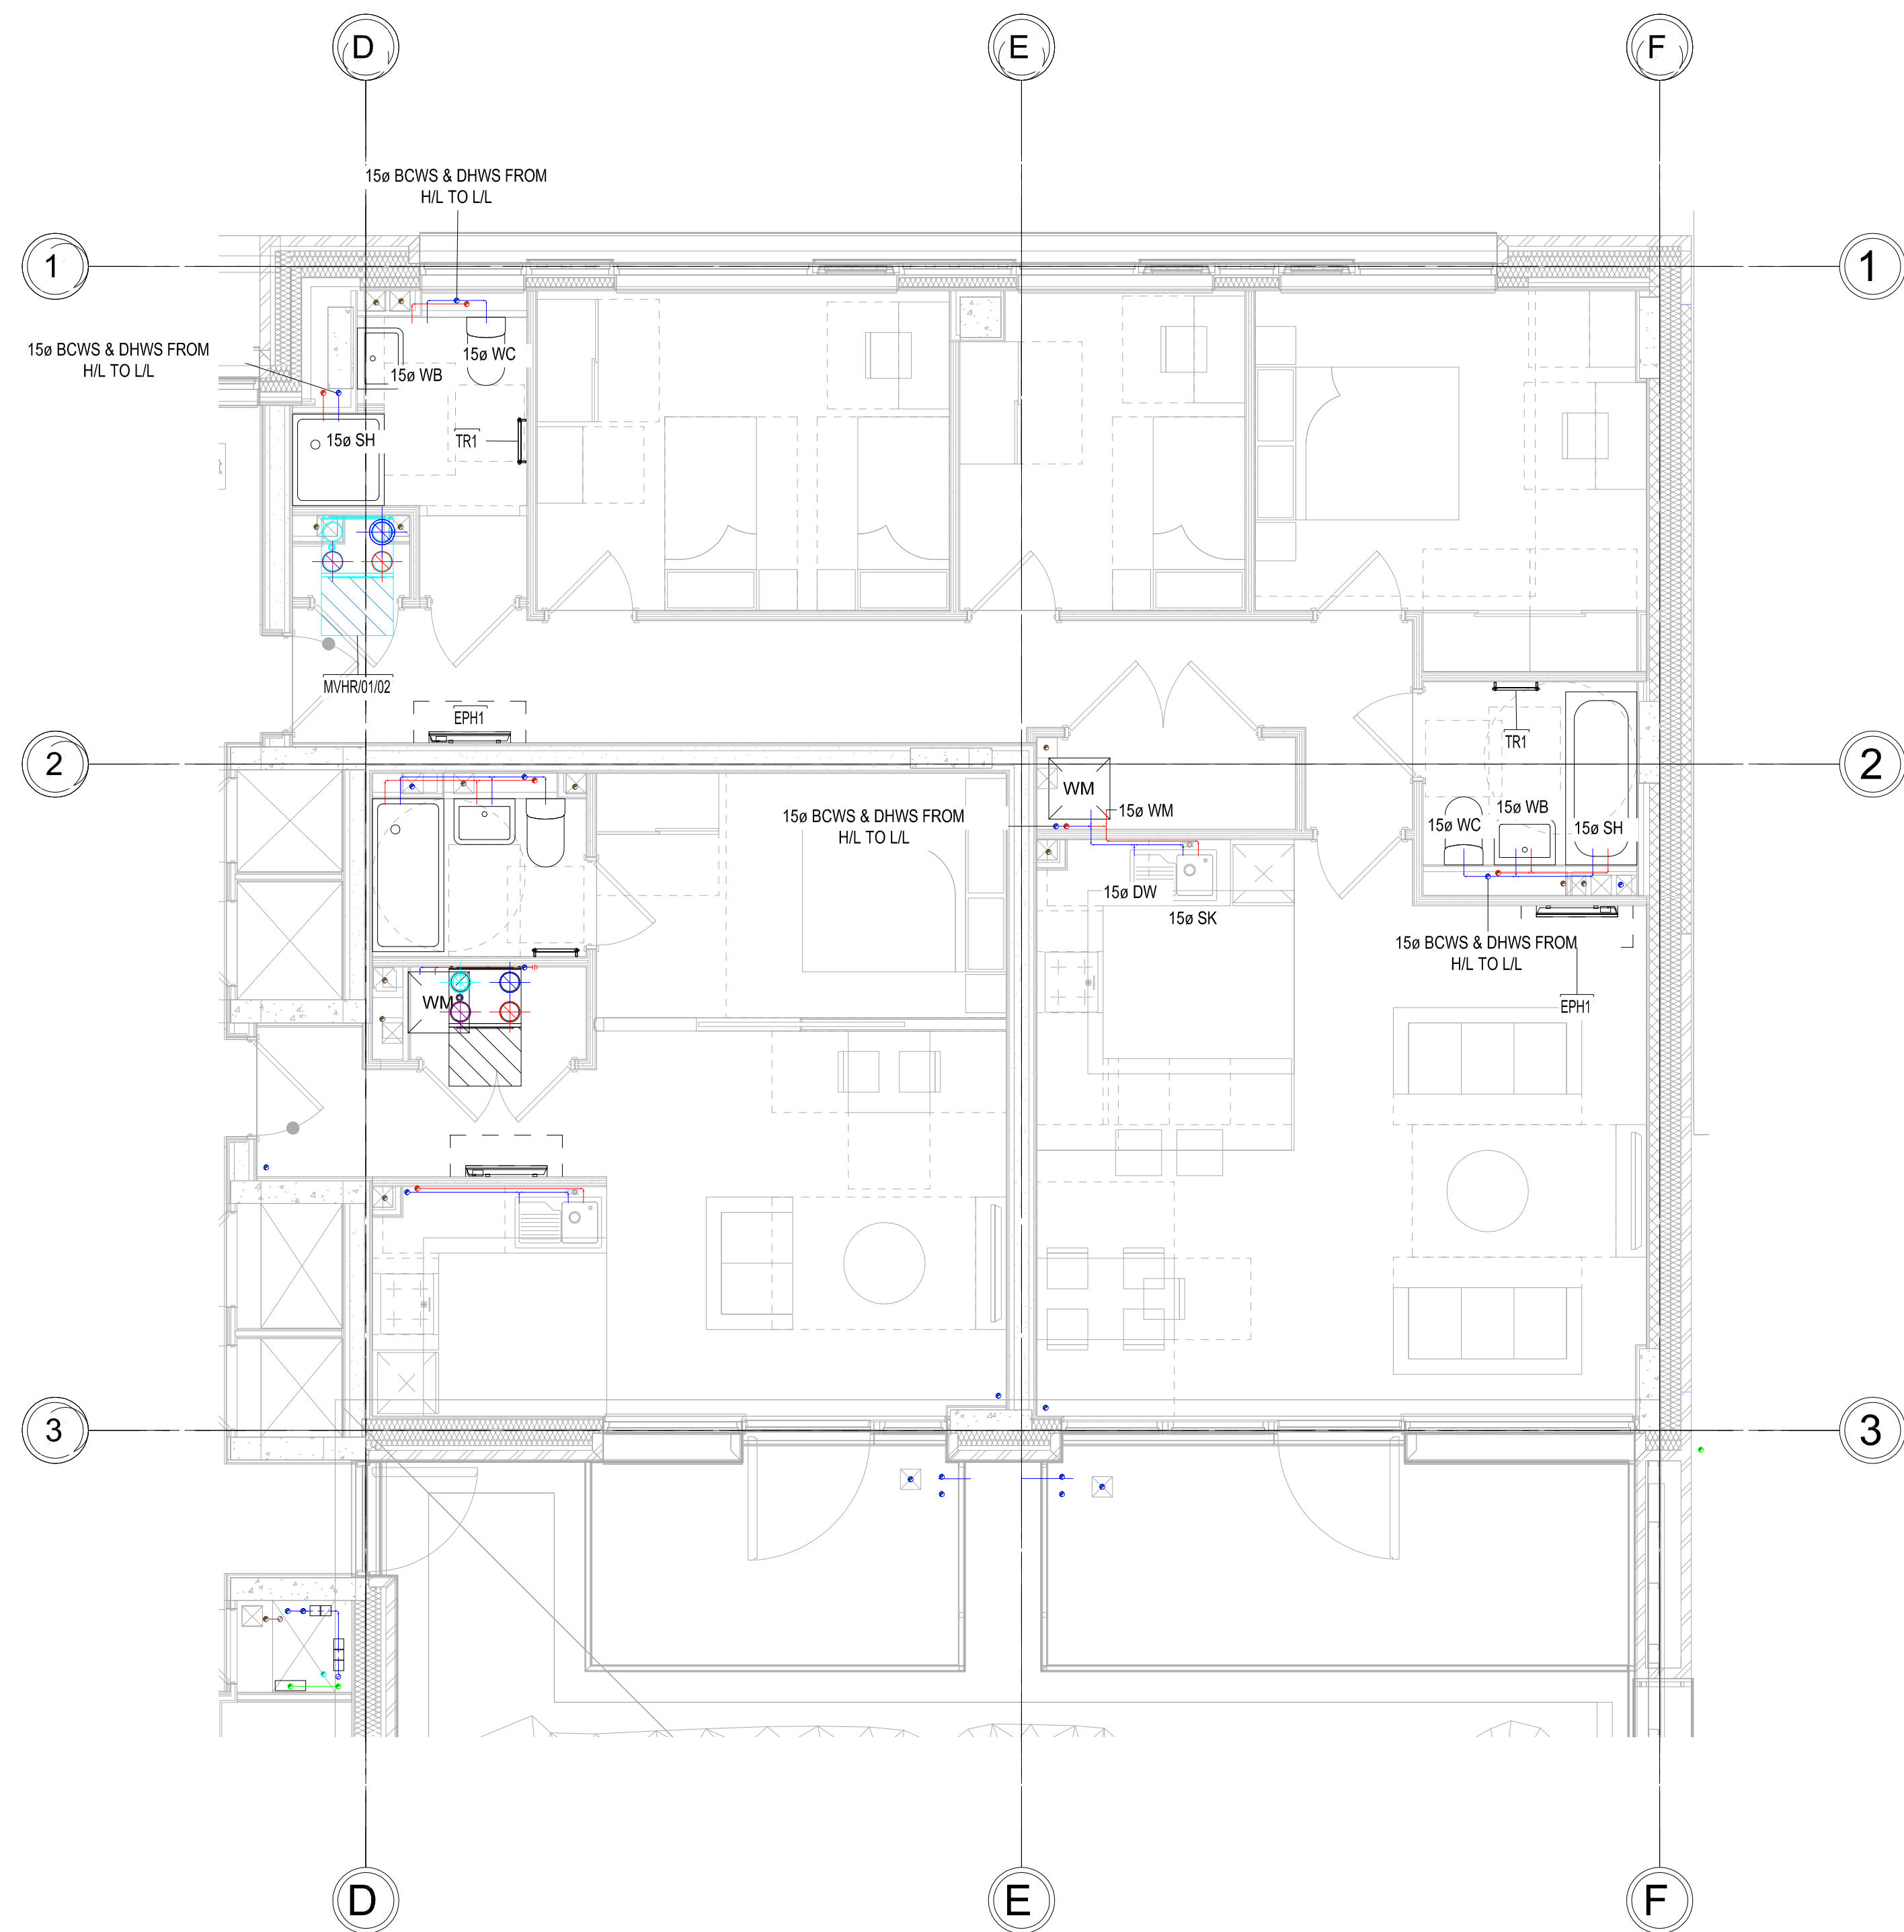

01 - Typical Apartment Type E - L/L
1 : 50



01 - Typical Apartment Type E - Small Power and AC
1 : 50

- TYPICAL ELECTRIC LEGEND:**
- BED BED HEAD CONTROL
 - BT BT SERVICES
 - DA DOOR ASSIST
 - DW DSH WASHER
 - EX EXTRACTOR FAN
 - FR FRIDGE
 - HS COOKER CONNECTION
 - MVHR MECHANICAL VENTILATION HEAT RECOVERY
 - PH PANEL HEATER
 - TR TOWEL RAIL
 - WM WASHING MACHINE
 - SINGLE UN-SWITCHED SOCKET OUTLET
 - TWIN UN-SWITCHED SOCKET OUTLET
 - SINGLE SWITCHED SOCKET OUTLET
 - TWIN SWITCHED SOCKET OUTLET
 - TWIN SWITCHED SOCKET OUTLET WITH USB
 - MCWS MAINS COLD WATER SERVICE
 - SINGLE SWITCHED FUSED SPUR
 - CONSUMER UNIT
 - 1 PHASE ELECTRIC METER
 - SINGLE DATA OUTLET
 - DOUBLE DATA OUTLET (WIFI-WIFI SOCKET)
 - SHOWER SOCKET
 - GRD SWITCH
 - QUADRAPLEX OUTLET WITH 2 DOUBLE SOCKETS, DATA POINT, 2X SAT, TV, FMDAB
 - 1 DOUBLE SOCKET, DATA POINT, TV OUTLET (TV, FMDAB)
 - DOOR BELL
 - CCTV CAMERA
 - EMERGENCY OVERRIDE BUTTON
 - PUSH TO EGRESS BUTTON
 - INTERROOM
 - DOOR BELL SWITCH
 - VIDEO ENTRY PANEL
 - VIDEO ENTRY HANDSET
 - ORLIGHT TOWER 2
 - F2 ORLIGHT 6009
 - F3 ORLIGHT 6009 IP44
 - ORLIGHT HORTON-BREZT
 - XAL STREETTA SURFACE
 - ORLIGHT 1009 SURFACE 65
 - K ORLIGHT IP65 RATED LED STRIP
 - M ASTRO KOTO FOUR BAR
 - N SYLVANIA GLOTTO 305
 - P1 SCHNEIDER BATTEN HOLDER
 - SCHNEIDER PENDANT
 - 1GANG 1 WAY SWITCH
 - 1GANG 2 WAY SWITCH
 - 2GANG 1 WAY SWITCH
 - INTERMEDIATE SWITCH
 - DIMMER SWITCH
 - STROBE BEACON WITH SOUNDER
 - FIRE ALARM INTERFACE
 - HEAT DETECTOR
 - HEAT DETECTOR WITH SOUNDER
 - HEAT DETECTOR WITH BEACON & SOUNDER
 - SMOKE DETECTOR
 - SMOKE DETECTOR WITH SOUNDER
 - SMOKE DETECTOR WITH BEACON & SOUNDER
 - EVACUATION ALERT SOUNDER
- TYPICAL FLATS LEGEND:**
- HL HIGH LEVEL
 - LL LOW LEVEL
 - F/A FROM ABOVE
 - F/B FROM BELOW
 - T/E TO BELOW
 - T/A TO ABOVE
 - F/A FLOW & RETURN
 - DHWSF DOMESTIC HOT WATER SERVICE
 - BCWS BOOSTED COLD WATER SERVICE
 - MCWS MAINS COLD WATER SERVICE
 - CAT 5 BOOSTED COLD WATER SERVICE
 - LTHW LOW TEMPERATURE HOT WATER
 - SK SHOWER
 - WHE WASH HAND BASIN
 - WC TOILET
 - SH SHOWER
 - BT BATH
 - AF ACCESS PANEL
 - EPH ELECTRIC PANEL HEATER
 - TMV THERMOSTATIC MIXING VALVE
 - WM WASHING MACHINE
 - DW DSH WASHER
 - FR FRIDGE
 - EX EXTRACTOR
 - OV OVEN
 - HE HOB
- NOTES:**
- SPRINKLER LAYOUT INDICATIVE ONLY. SPRINKLER DESIGN IS TO BE COMPLETED BY SPECIALIST INCLUDING PIPE SIZING
 - ALL WASH HAND BASINS, BATHS & SHOWERS TO INCLUDE THERMOSTATIC MIXING VALVES TO AVOID SCALDING.

T01 TENDER	WB	10/11/23
P01 PRELIMINARY	WB	10/10/23
Rev. Amendment	Initial	Date

Synergy
CONSULTING ENGINEERS
Sustainable Mechanical, Electrical and Public Health Building Services
8-14 St Pancras Way, 1 Canal Side Studios, London NW1 0QD
Tel: 020 7520 8950 Fax: 020 7350 5112 Email: info@synergymech.co.uk Web: www.synergymech.co.uk

Client
**Precis Advisory/
Access Self Storage**

Project
**Acorn House
314-320 Grays Inn Rd, London
WC1X 8DP**

Drawing Title
Typical Apartment Type E

Scale(s)	1 : 50 @ A0				
Drawn Date	08/10/23	Initial	BW/AM	Approved	AF
Job Number	08580	Status	S4-For Tender		
Purpose of Issue	TENDER				

Dwg. ACH+SYN+ZZ+XX-DR-ME-4006 Rev. T01