



05 - Typical Apartment Type F - H/L

1 : 50

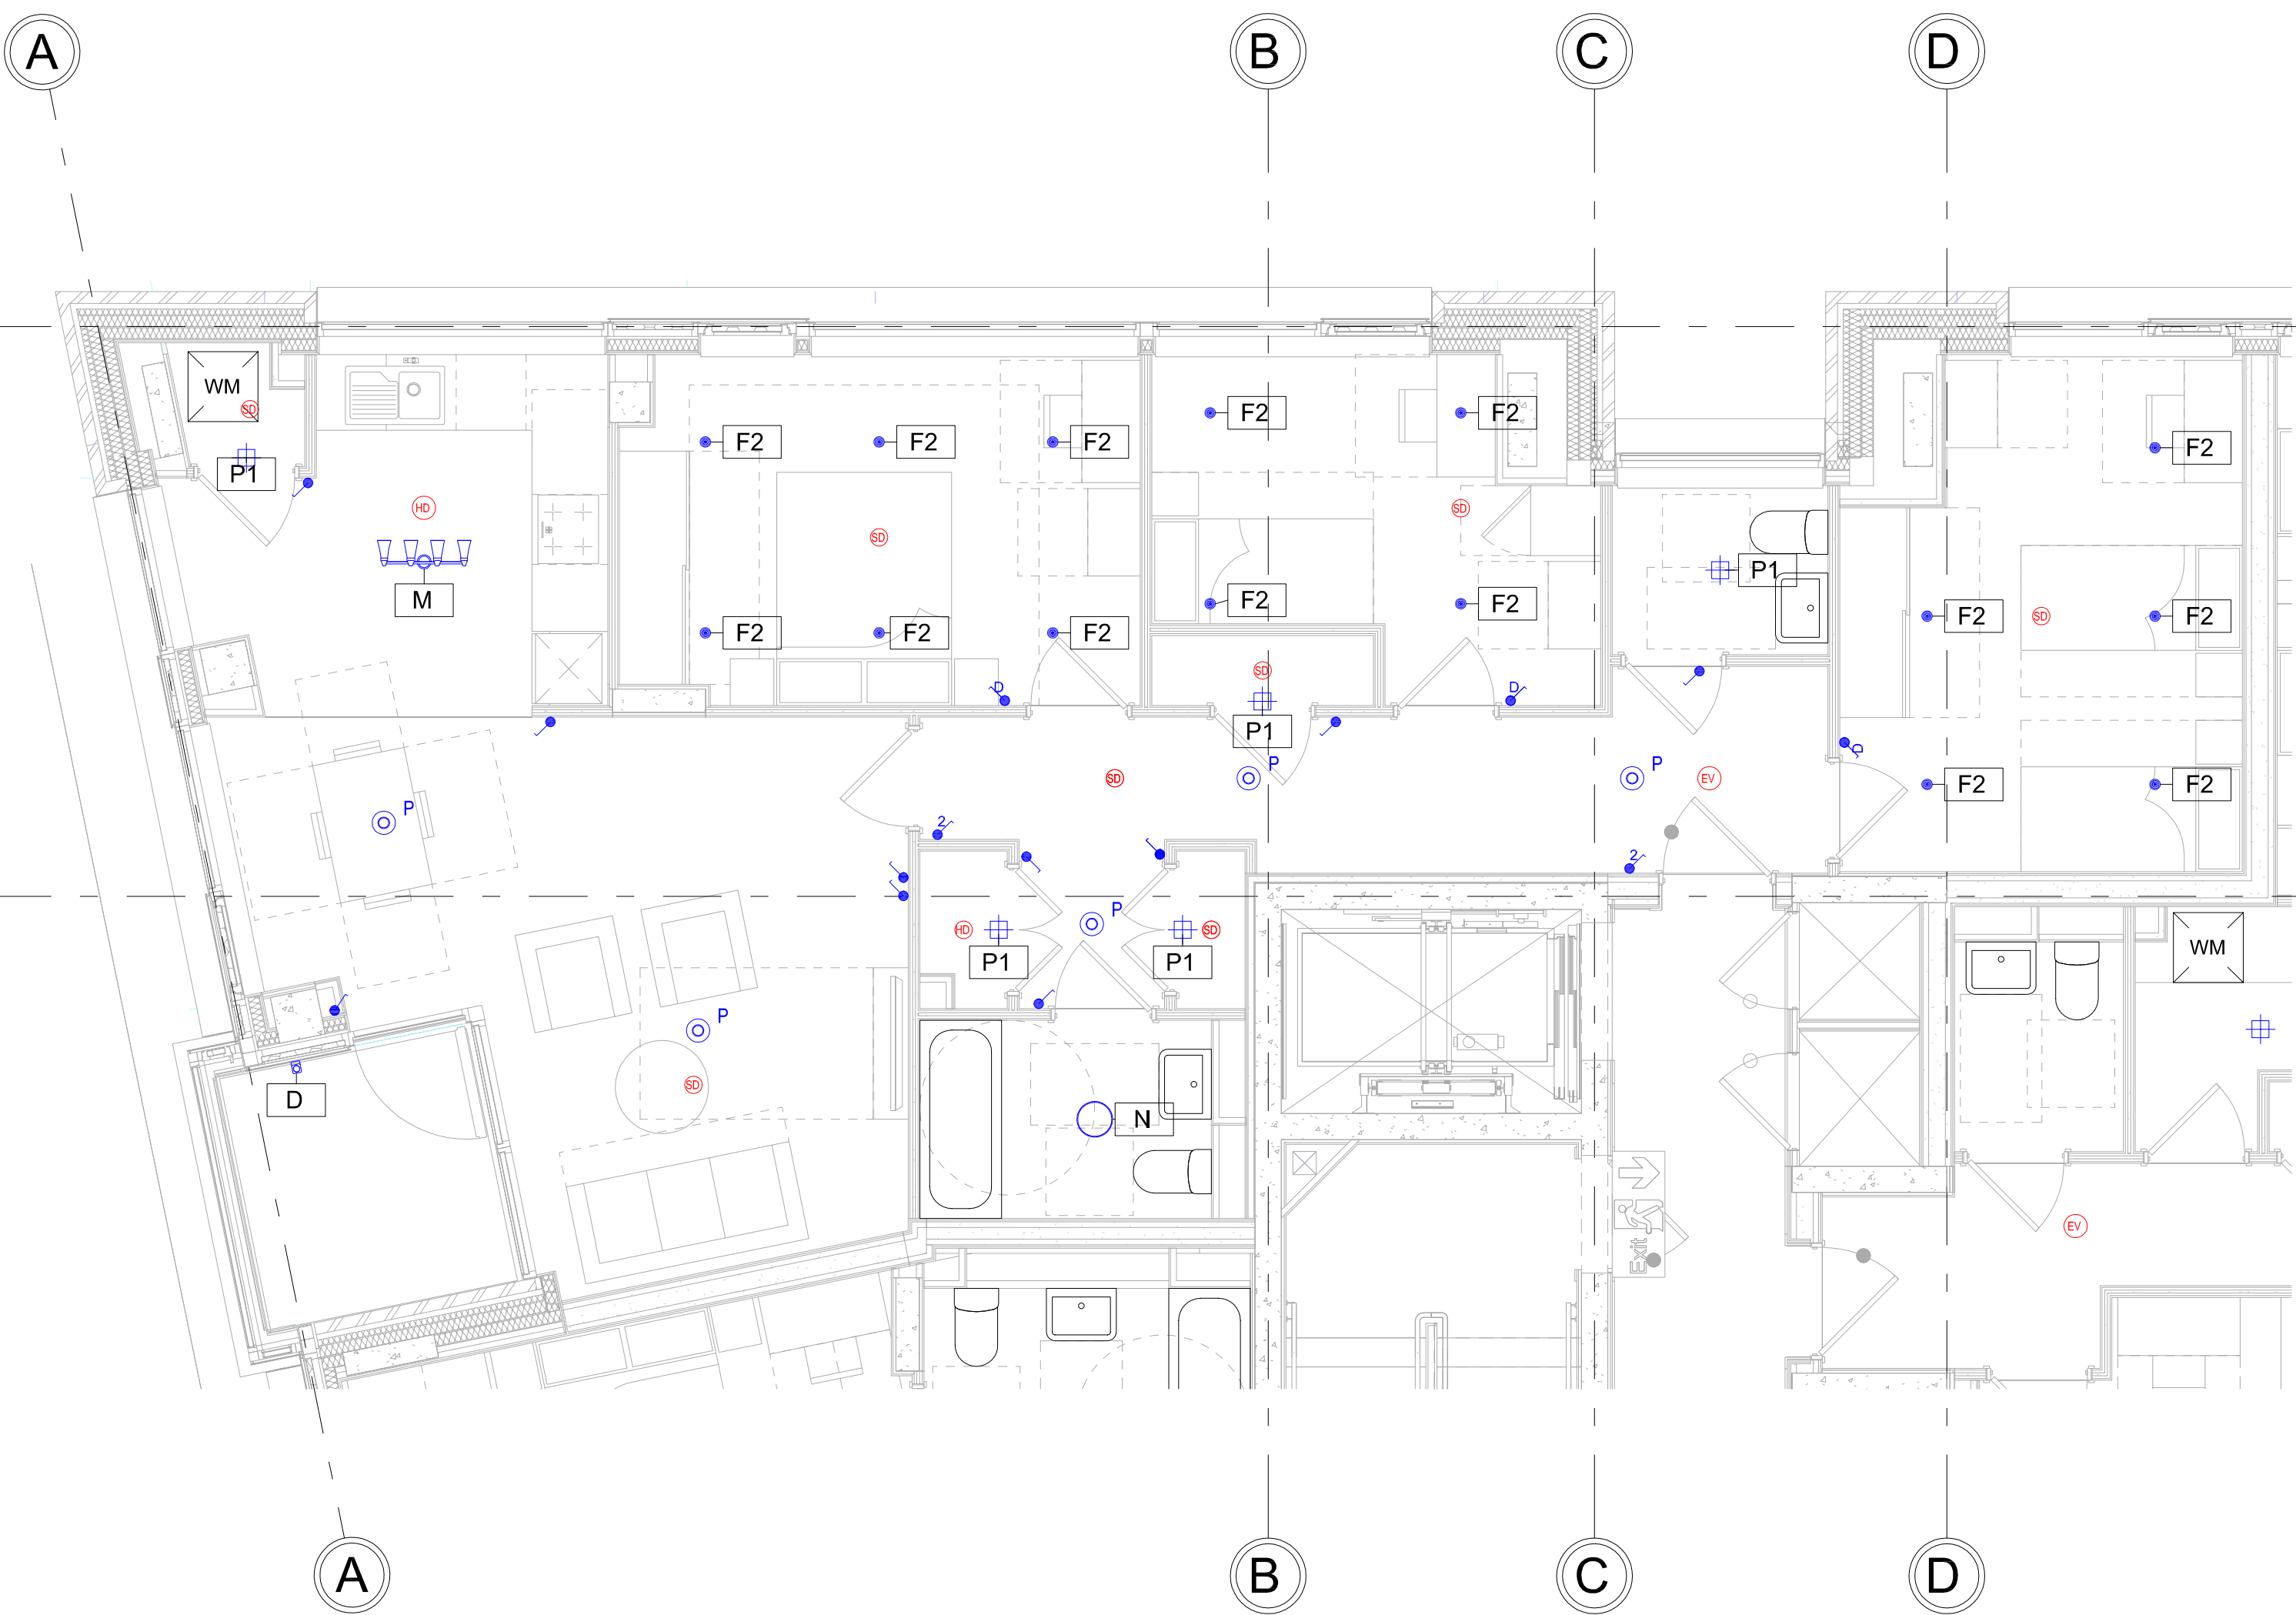

05 - Typical Apartment Type F - Lighting and FA

1 : 50

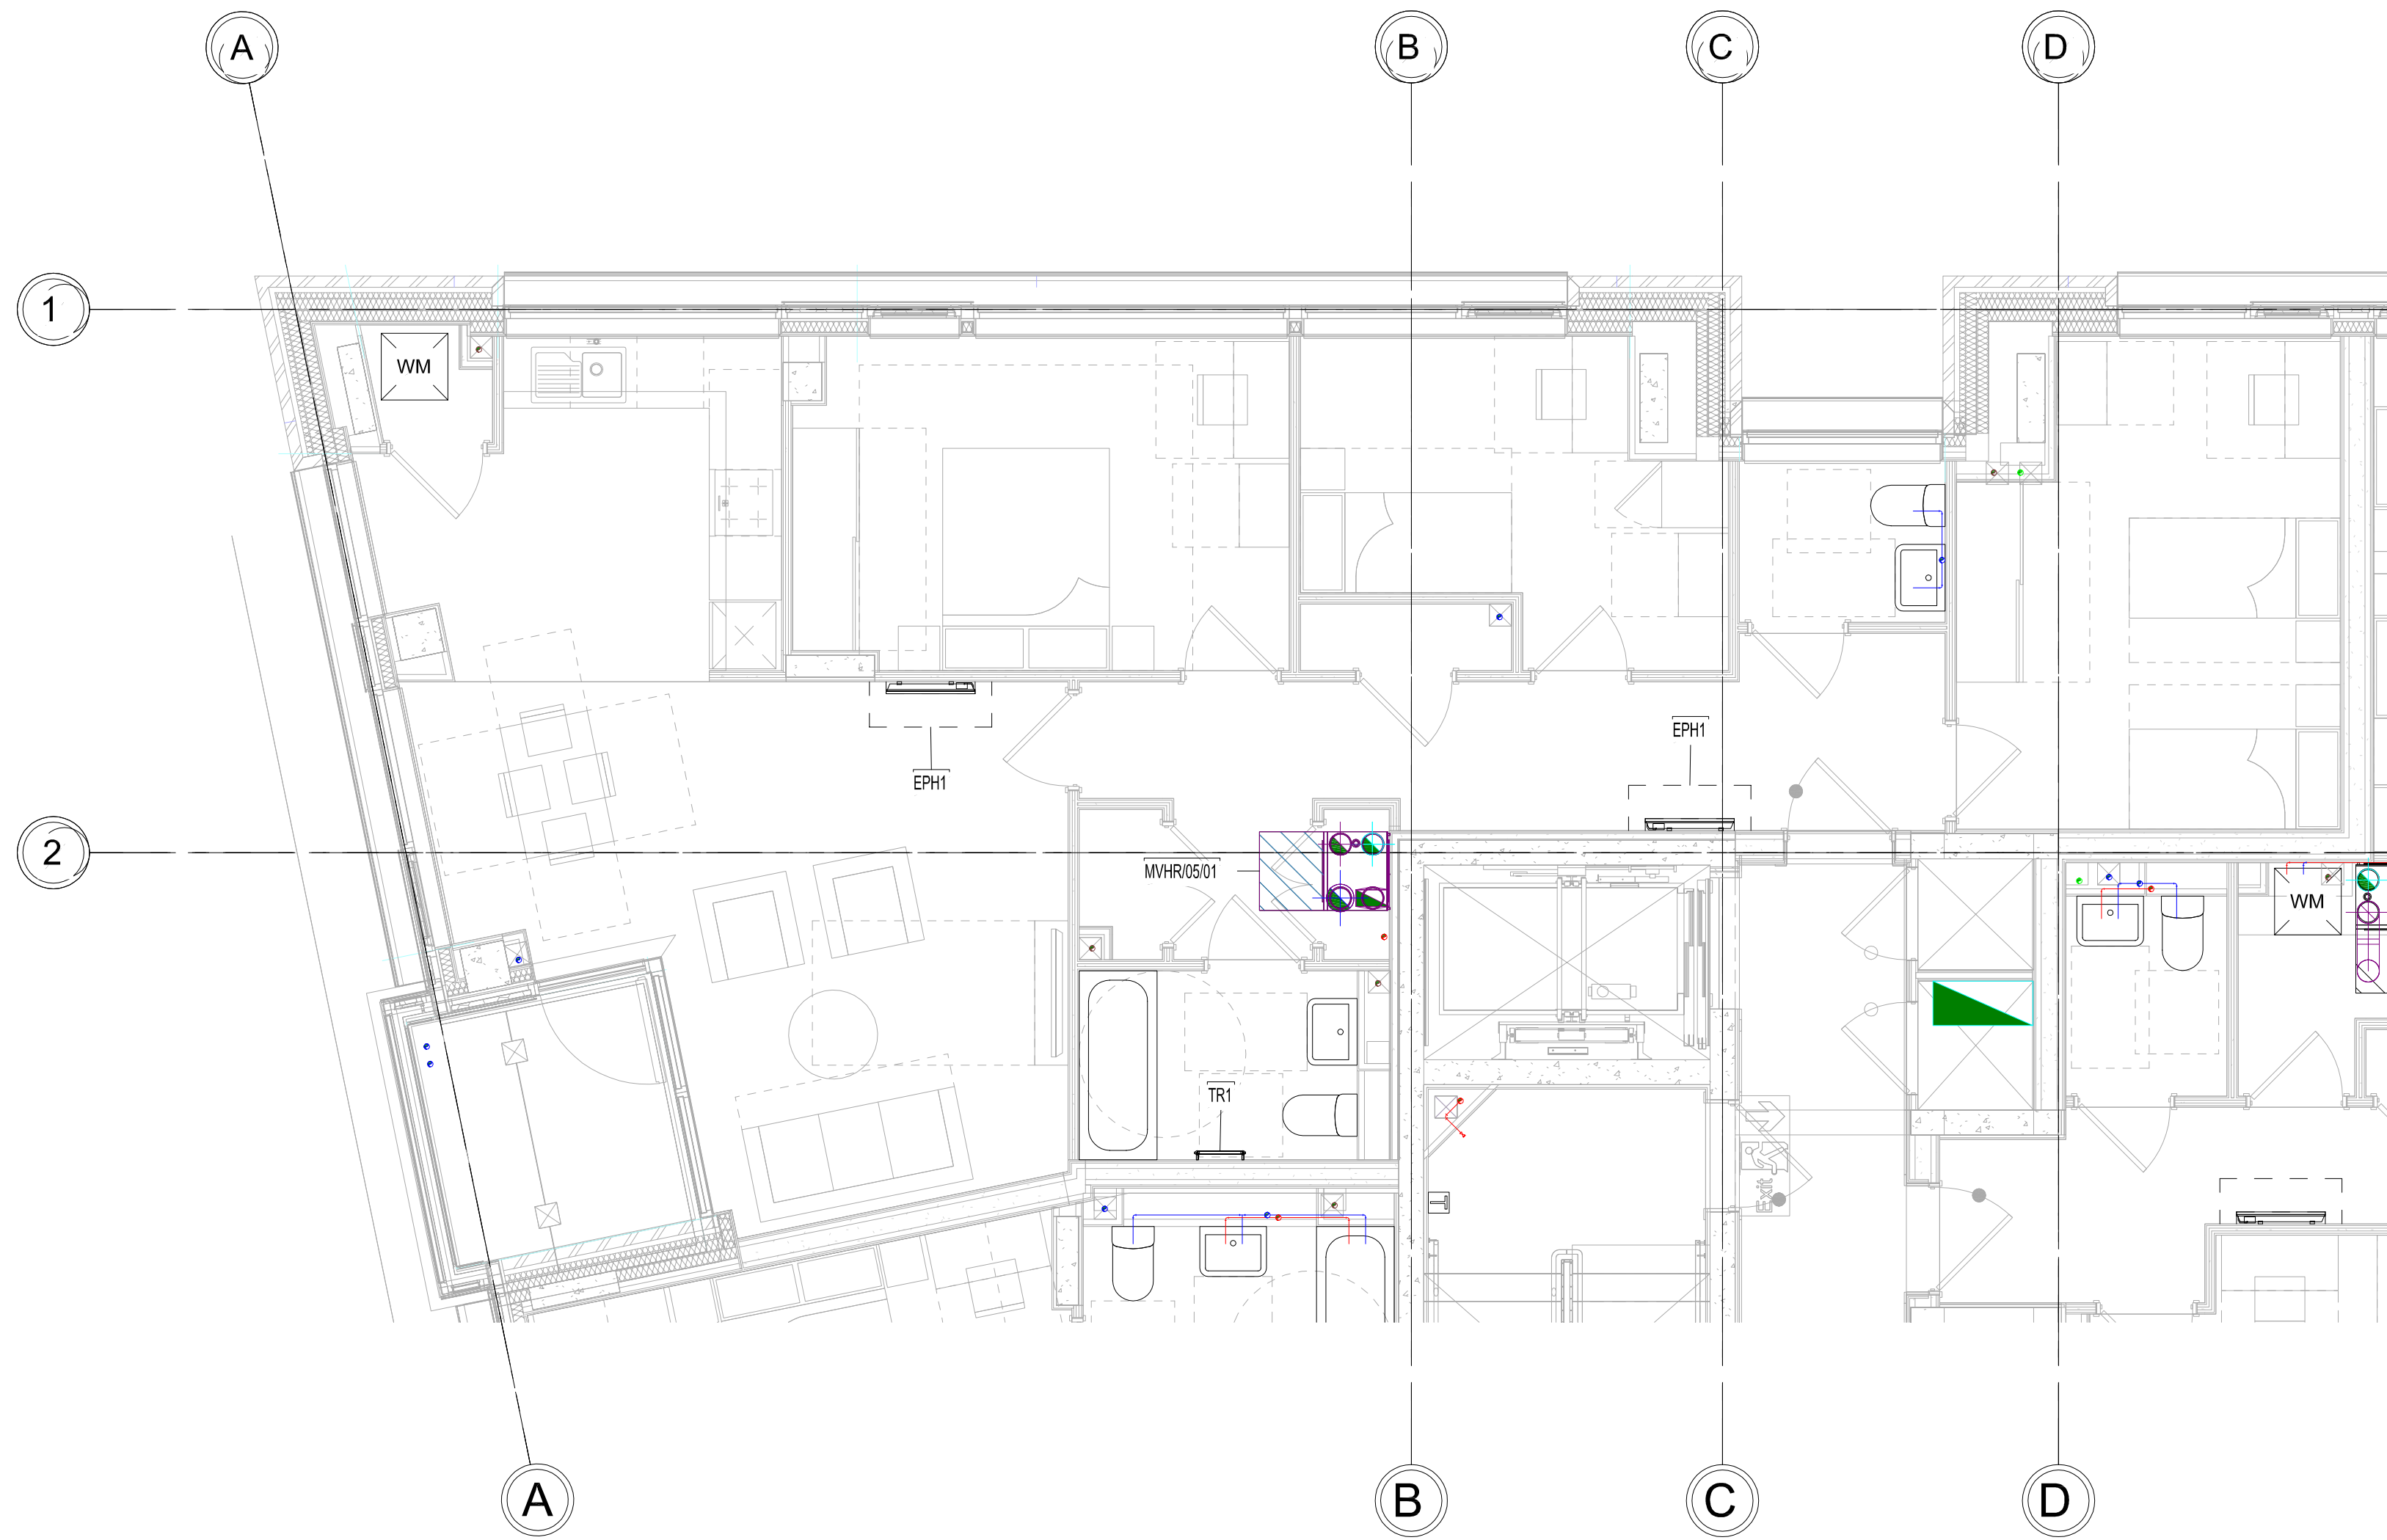

05 - Typical Apartment Type F - L/L

1 : 50



05 - Typical Apartment Type F - Small Power and AC

1 : 50

- TYPICAL ELECTRIC LEGEND:**
- RED BED
 - BT BT SERVICES
 - DA DOOR ASSIST
 - DW DSH WASHER
 - EX EXTRACTOR FAN
 - FR FRIDGE
 - HS COOKER CONNECTION
 - MYHR MECHANICAL VENTILATION HEAT RECOVERY
 - PH PANEL HEATER
 - TR TOWEL RAIL
 - WM WASHING MACHINE
 - SINGLE UN-SWITCHED SOCKET OUTLET
 - TWIN UN-SWITCHED SOCKET OUTLET
 - SINGLE SWITCHED SOCKET OUTLET
 - TWIN SWITCHED SOCKET OUTLET
 - TWIN SWITCHED SOCKET OUTLET WITH USB
 - SINGLE UN-SWITCHED FUSED SPUR
 - SINGLE SWITCHED FUSED SPUR
 - CONSUMER UNIT
 - 1 PHASE ELECTRIC METER
 - SINGLE DATA OUTLET
 - DOUBLE DATA OUTLET (WIFI-WIFI SOCKET)
 - SHOWER SOCKET
 - GRAB SWITCH
 - QUADRAPLEX OUTLET WITH 2 DOUBLE SOCKETS, DATA POINT, 2X SAT. TV, FMDAB
 - 1 DOUBLE SOCKET, DATA POINT, TV OUTLET (TV, FMDAB)
 - DOOR BELL
 - CCTV CAMERA
 - EMERGENCY OVERRIDE BUTTON
 - PUSH TO EGRESS BUTTON
 - INTERCOM
 - DOOR BELL SWITCH
 - VIDEO ENTRY PANEL
 - VIDEO ENTRY HANDSET
 - ORLIGHT TOWER 2
 - F2 ORLIGHT 6009
 - F3 ORLIGHT 6009 IP44
 - ORLIGHT HXOTON-BR-E27
 - XAL STRETTA SURFACE
 - ORLIGHT 1009 SURFACE 85
 - ORLIGHT IP65 RATED LED STRIP
 - ASTRO KOTO FOUR BAR
 - SYLVANIA GIOTTO 305
 - 3CHNEIDER BATTEN HOLDER
 - SCHNEIDER PENDANT
 - 1GANG 1 WAY SWITCH
 - 1GANG 2 WAY SWITCH
 - 2GANG 1 WAY SWITCH
 - INTERMEDIATE SWITCH
 - DIMMER SWITCH
 - STROBE BEACON WITH SOUNDER
 - FIRE ALARM INTERFACE
 - HEAT DETECTOR
 - HEAT DETECTOR WITH SOUNDER
 - HEAT DETECTOR WITH BEACON & SOUNDER
 - SMOKE DETECTOR
 - SMOKE DETECTOR WITH SOUNDER
 - SMOKE DETECTOR WITH BEACON & SOUNDER
 - EVACUATION ALERT SOUNDER

- TYPICAL FLATS LEGEND:**
- H/L HIGH LEVEL
 - L/L LOW LEVEL
 - F/A FROM ABOVE
 - F/B FROM BELOW
 - T/B TO BELOW
 - T/A TO ABOVE
 - F&R FLOW & RETURN
 - DHWSF DOMESTIC HOT WATER SERVICE
 - BCWS BOOSTED COLD WATER SERVICE
 - MCWS MAINS COLD WATER SERVICE
 - CAT 2 CAT 2 BOOSTED COLD WATER SERVICE
 - LTHW LOW TEMPERATURE HOT WATER
 - SK SINK
 - WHE WASH HAND BASIN
 - WC TOILET
 - SH SHOWER
 - BT BATH
 - AF ACCESS PANEL
 - EPH ELECTRIC PANEL HEATER
 - TMV THERMOSTATIC MIXING VALVE
 - WM WASHING MACHINE
 - DW DSH WASHER
 - FR FRIDGE
 - EX WASHING MACHINE
 - OV OVEN
 - HE HOBB

- HIGH LEVEL PIPEWORK
- LOW LEVEL PIPEWORK
- BOOSTED COLD WATER SERVICE PIPEWORK
- DOMESTIC HOT WATER SERVICE PIPEWORK
- HEATING PIPEWORK
- SPRINKLER PIPEWORK
- SPRINKLER HEAD
- ELECTRIC PANEL HEATER
- ELECTRIC TOWEL RAIL
- SUPPLY DUCT
- RETURN DUCT
- FRESH AIR DUCT
- EXHAUST DUCT
- ISOLATION VALVE
- PENUM BOX
- MVHR UNIT
- CIRCULAR EXTRACT GRILLE
- CIRCULAR SUPPLY GRILLE

NOTES:

- SPRINKLER LAYOUT INDICATIVE ONLY. SPRINKLER DESIGN IS TO BE COMPLETED BY SPECIALIST INCLUDING PIPE SIZING
- ALL WASH HAND BASINS, BATHS & SHOWERS TO INCLUDE THERMOSTATIC MIXING VALVES TO AVOID SCALDING.

T01 TENDER	WB	10/11/23
P01 PRELIMINARY	WB	10/10/23
Rev. Amendment	Initial	Date

Synergy
CONSULTING ENGINEERS
Sustainable Mechanical, Electrical and Public Health Building Services
8-14 St Pancras Way, 1 Canal Side Studios, London NW1 0QS
Tel: 020 7592 8950 Fax: 020 7380 5312 Email: info@synergymech.co.uk Web: www.synergymech.co.uk

Client
**Precis Advisory/
Access Self Storage**

Project
**Acorn House
314-320 Grays Inn Rd, London
WC1X 8DP**

Drawing Title
Typical Apartment Type F

Scale(s)	1 : 50 @ A0			
Drawn Date	08/10/23	Initial	BW/AM	Approved
Job Number	08580	Status	S4-For Tender	
Purpose of Issue	TENDER			