


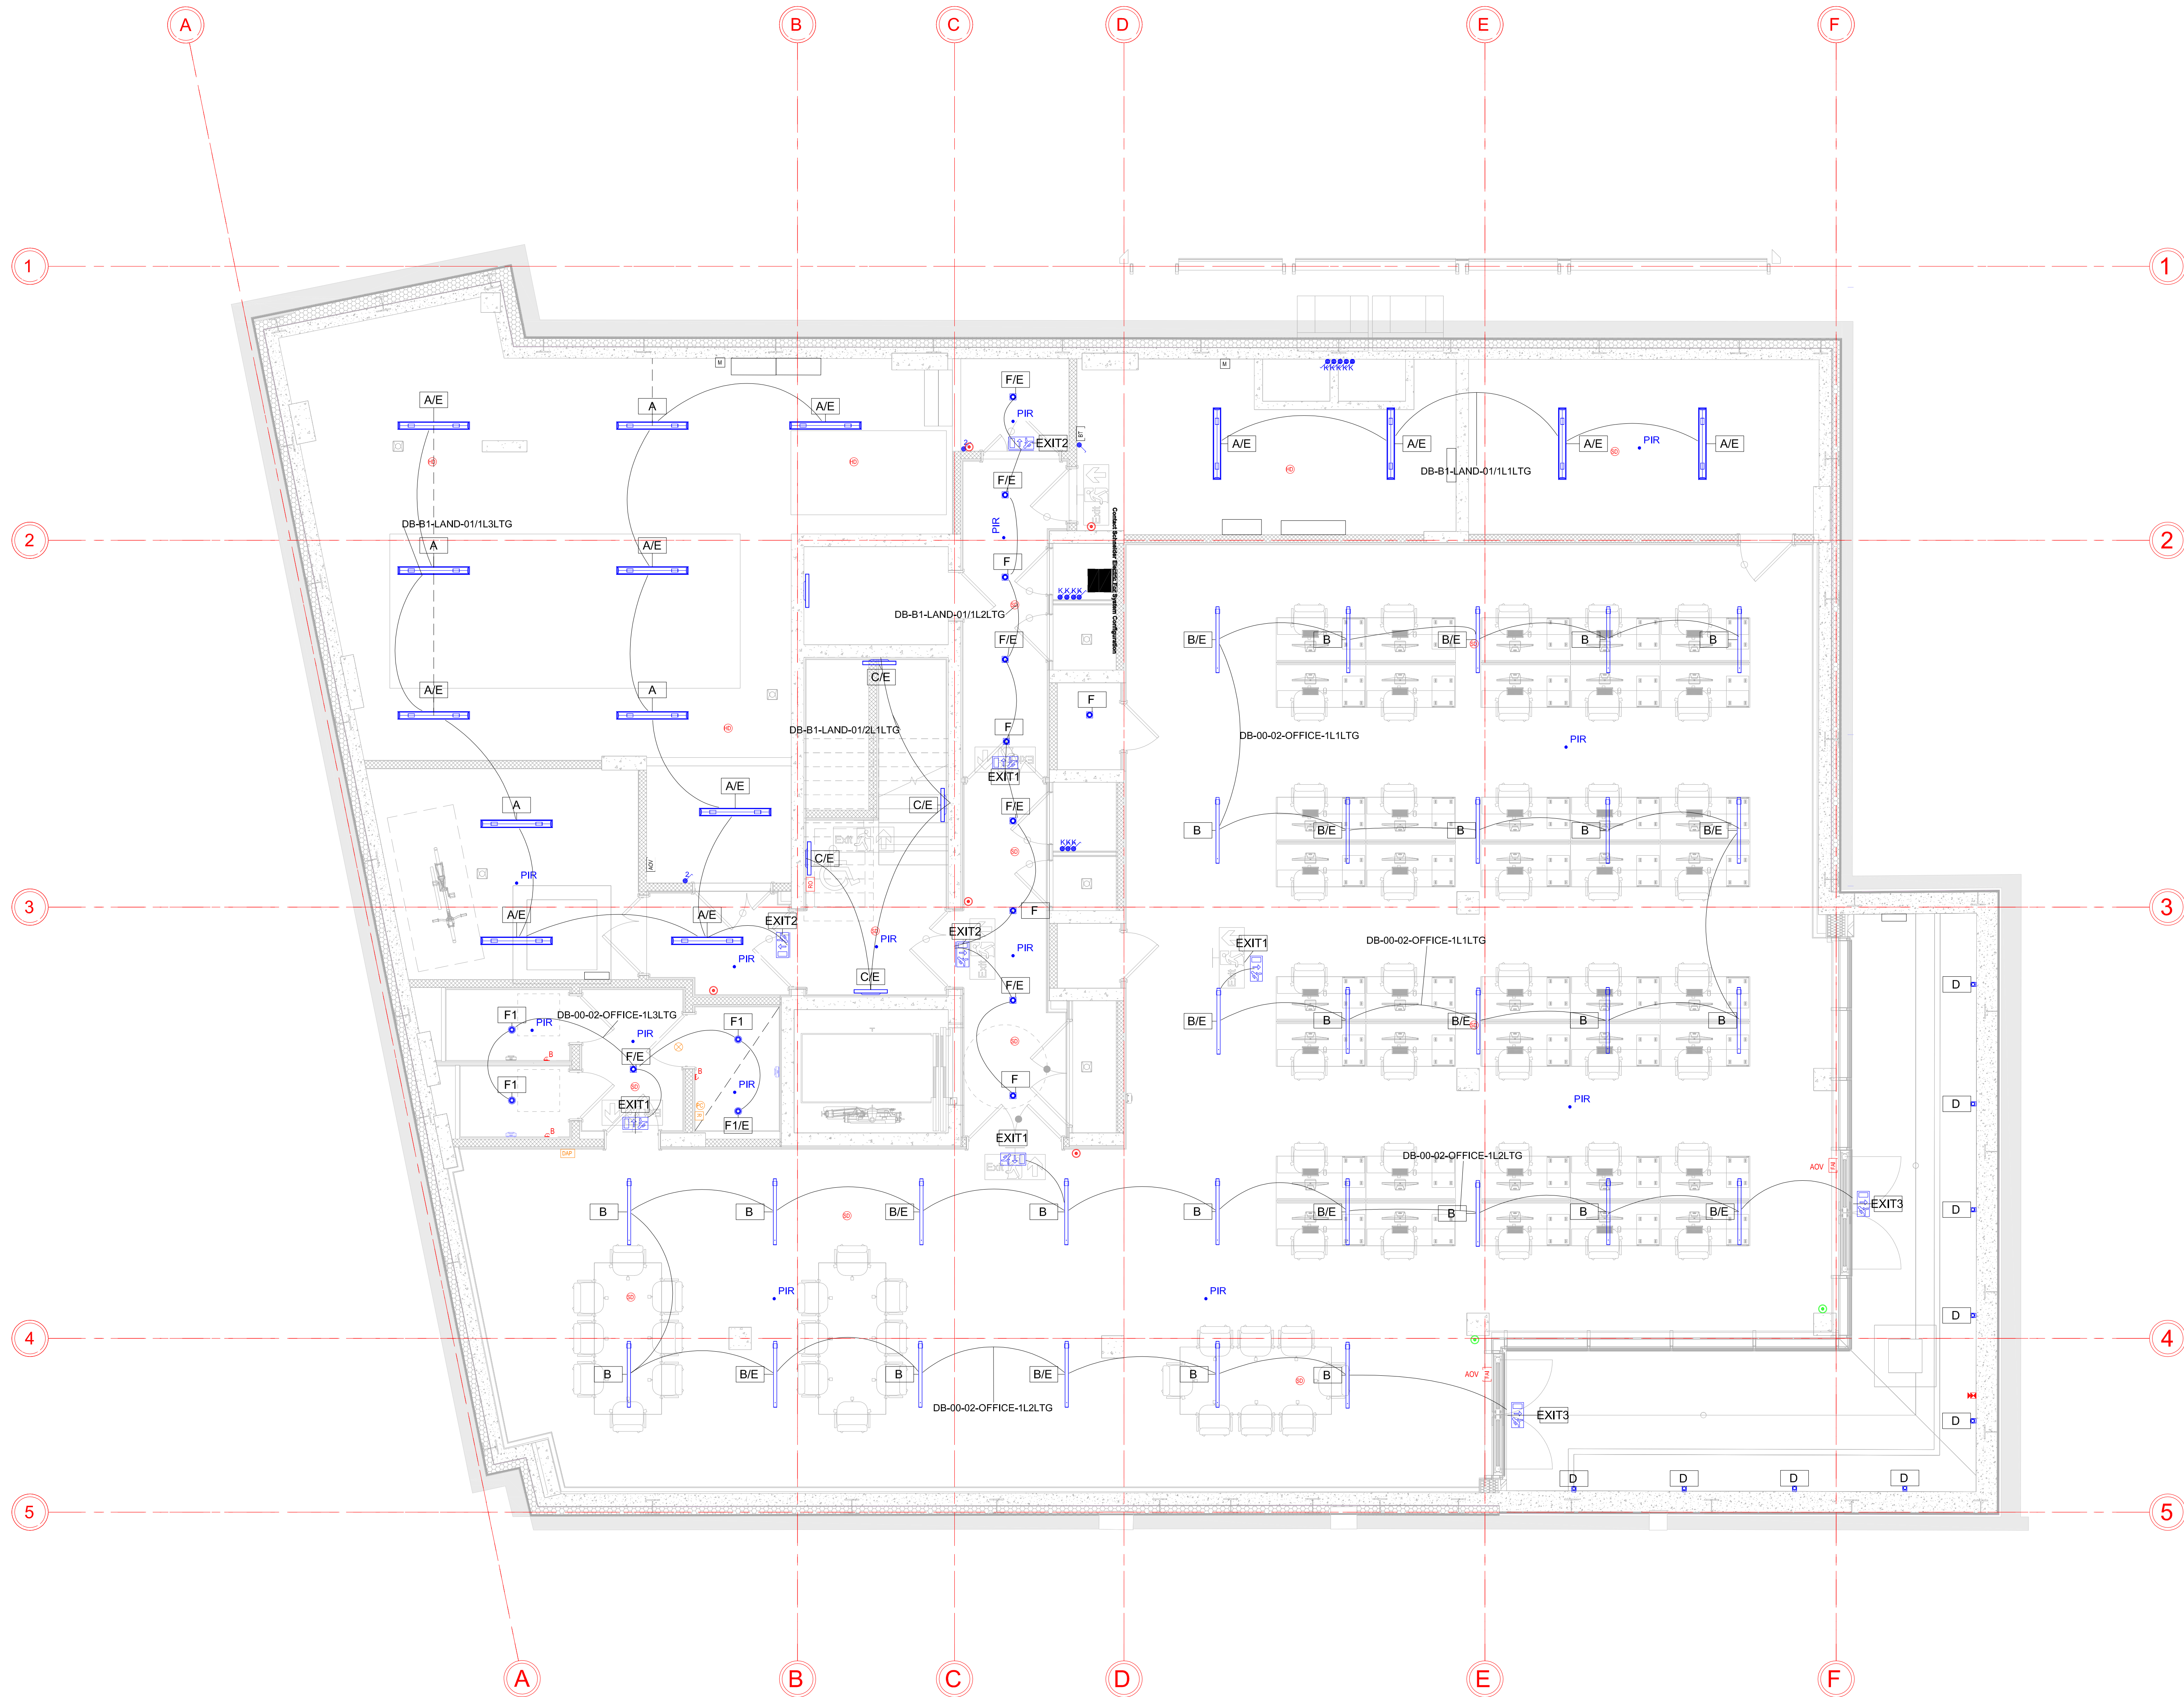

- LEGEND
- DOOR RELEASE
- EXTERNAL FLASHING BEACON & SOUNDER
- STROBE BEACON WITH SOUNDER
- DISABLED TOILET STROBE BEACON WITH SOUNDER
- FIRE ALARM INTERFACE
- FIRE ALARM PANEL
- HEAT DETECTOR
- HEAT DETECTOR WITH SOUNDER
- SMOKE DETECTOR
- SMOKE DETECTOR WITH SOUNDER
- SMOKE DETECTOR WITH BEACON & SOUNDER
- SMOKE DETECTOR SHUT OFF KEY SWITCH
- MAGNETIC HOLD OPEN DOOR
- MANUAL CALL POINT
- REFUGE OUTSTATION
- ADV CONTROL PANEL
- ADV MANUAL CALL POINT
- ADV SMOKE DETECTOR
- DISABLED ALARM INDICATOR
- DISABLED PULL CORD SWITCH
- DISABLED ALARM RESET BUTTON
- DISABLED ALARM PANEL

- LEGEND
- A
- B
- C
- D
- F
- F1
- G
- H
- I
- K
- EXIT1
- EXIT2
- EXIT3
- WHITE CROFT CONCERT EX3S WALL MOUNTED
- WHITE CROFT CONCERT EX3S CEILING MOUNTED
- CONCERT EX3S
- 15GANG 1 WAY SWITCH
- 15GANG 2 WAY SWITCH
- 20GANG 1 WAY SWITCH
- INTERMEDIATE SWITCH
- DIMMER SWITCH
- KAY SWITCH
- PHOTOCELL
- PIR DETECTOR
- SCEN SETTING KEYPAD

T02	TENDER	WB	14/11/23
T01	TENDER	WB	20/10/23
P02	PRELIMINARY	WB	30/06/23
P01	PRELIMINARY	WB	28/04/23
Rev.	Amendment	Initial	Date

Synergy

CONSULTING ENGINEERS

Sustainable Mechanical, Electrical and Public Health Building Services

8-14 St Pancras Way, 1 Canal Side Studios, London NW1 0QD

Tel: 020 7350 8950 Fax: 020 7350 9312 Email: info@synergymech.co.uk Web: www.synergymech.co.uk

Client

Precis Advisory/
Access Self Storage

Project

Acorn House
314-320 Grays Inn Rd, London
WC1X 8DP

Drawing Title

BASEMENT FLOOR LIGHTING
AND FIRE ALARM LAYOUT

Scale(s)	1 : 50 @ A0				
Drawn Date	09.02.23	Initial	Author	Approved	Checker
Job Number	08580	Status	S4-For Tender		
Purpose of Issue	TENDER				