



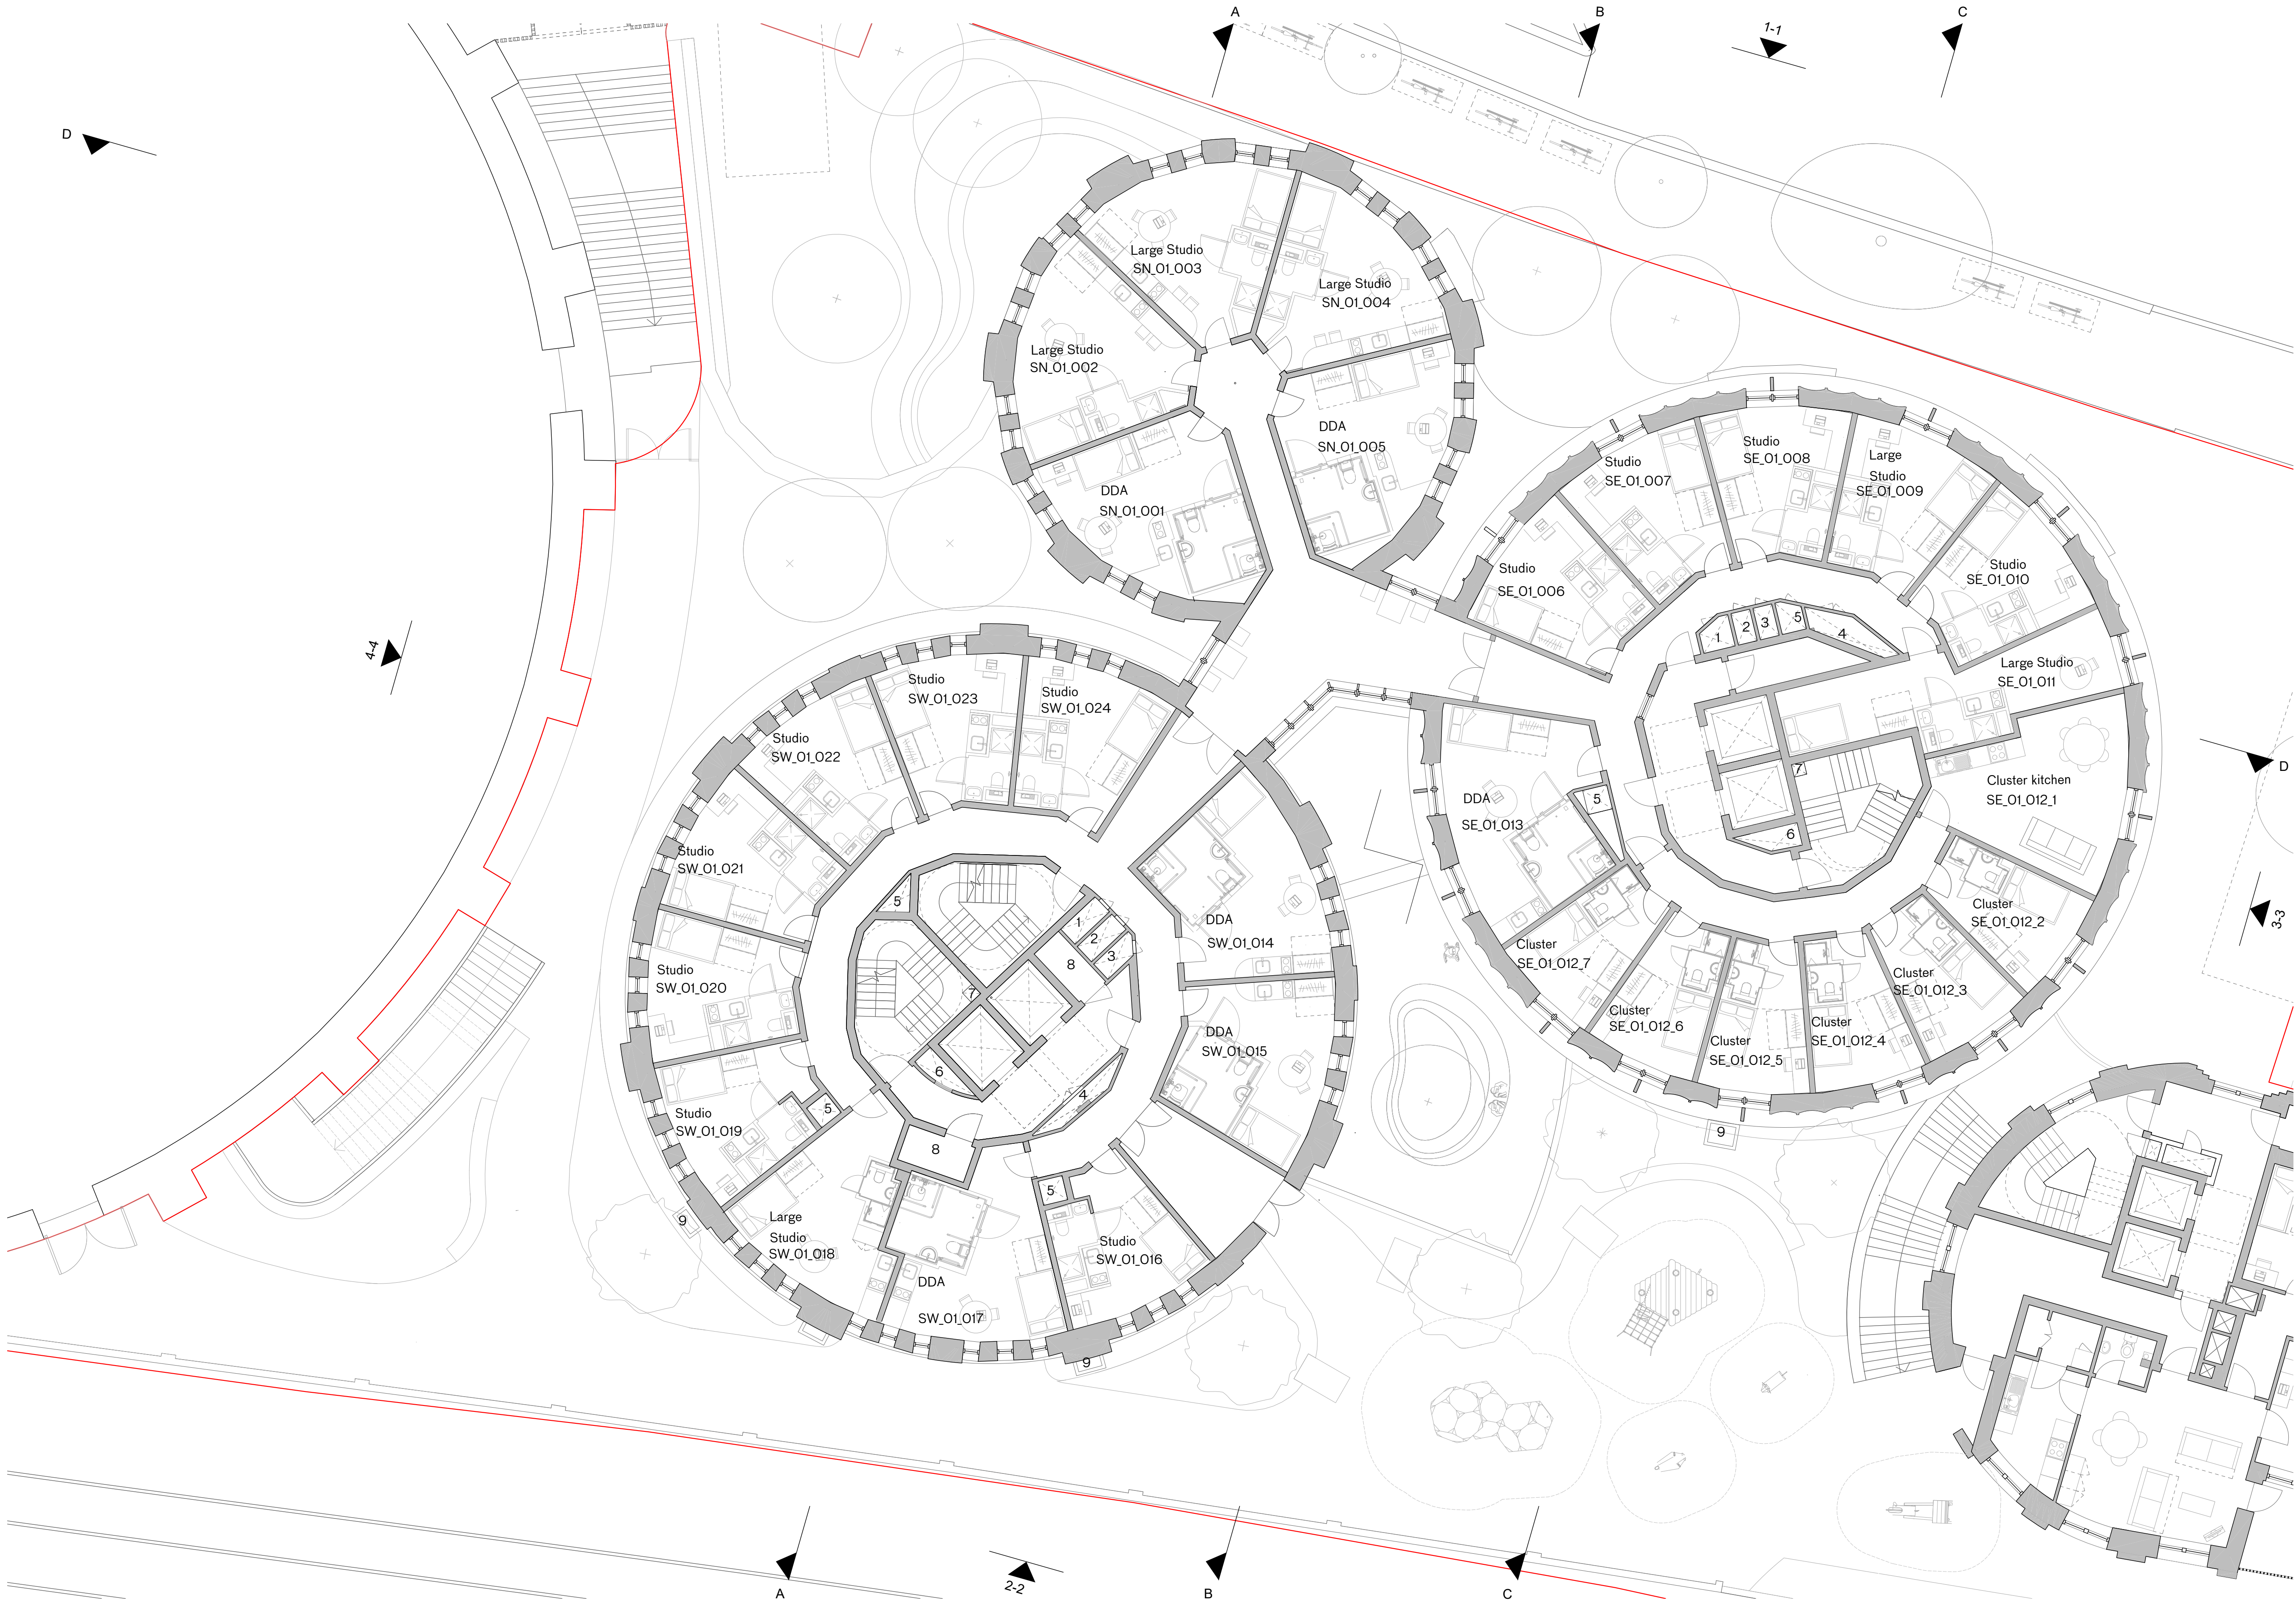

PBSA Level 1 Floor Plan

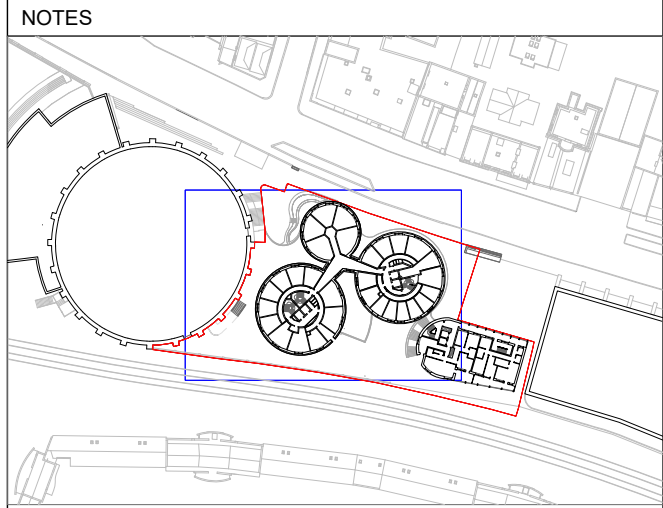

- Key to Risers
- 1 Heating Riser
 - 2 Water Riser
 - 3 Comms Riser
 - 4 Electrical Riser
 - 5 Smoke Outlet
 - 6 Smoke Inlet
 - 7 Dry Riser
 - 8 MVHR Cupboard
 - 9 Mechanical Ventilation
- Site Boundary
- Petrol Filling Station Consented Scheme, Planning Ref: 2022/3646/P

A - 31/01/24 Planning

Planning

rev	date	check	comments
DSDHA			
357 Kennington Lane London SE11 5QY			
T 020 7703 3555			
F 020 7703 3890			
E info@dsdha.co.uk			
W www.dsdha.co.uk			
project			

100 Chalk Farm Road

drawing title

PBSA Level 1 Floor Plan

drawn	size	date	scale
SZ	A1	12/01/24	1 : 100
drawing number			revision
356_P20.131			A

REPORT DISCREPANCIES
DO NOT SCALE FROM THIS DRAWING
COPYRIGHT DSDHA

USE LATEST REVISION
CHECK DIMENSIONS ON SITE