




PBSA Level 5 Floor Plan

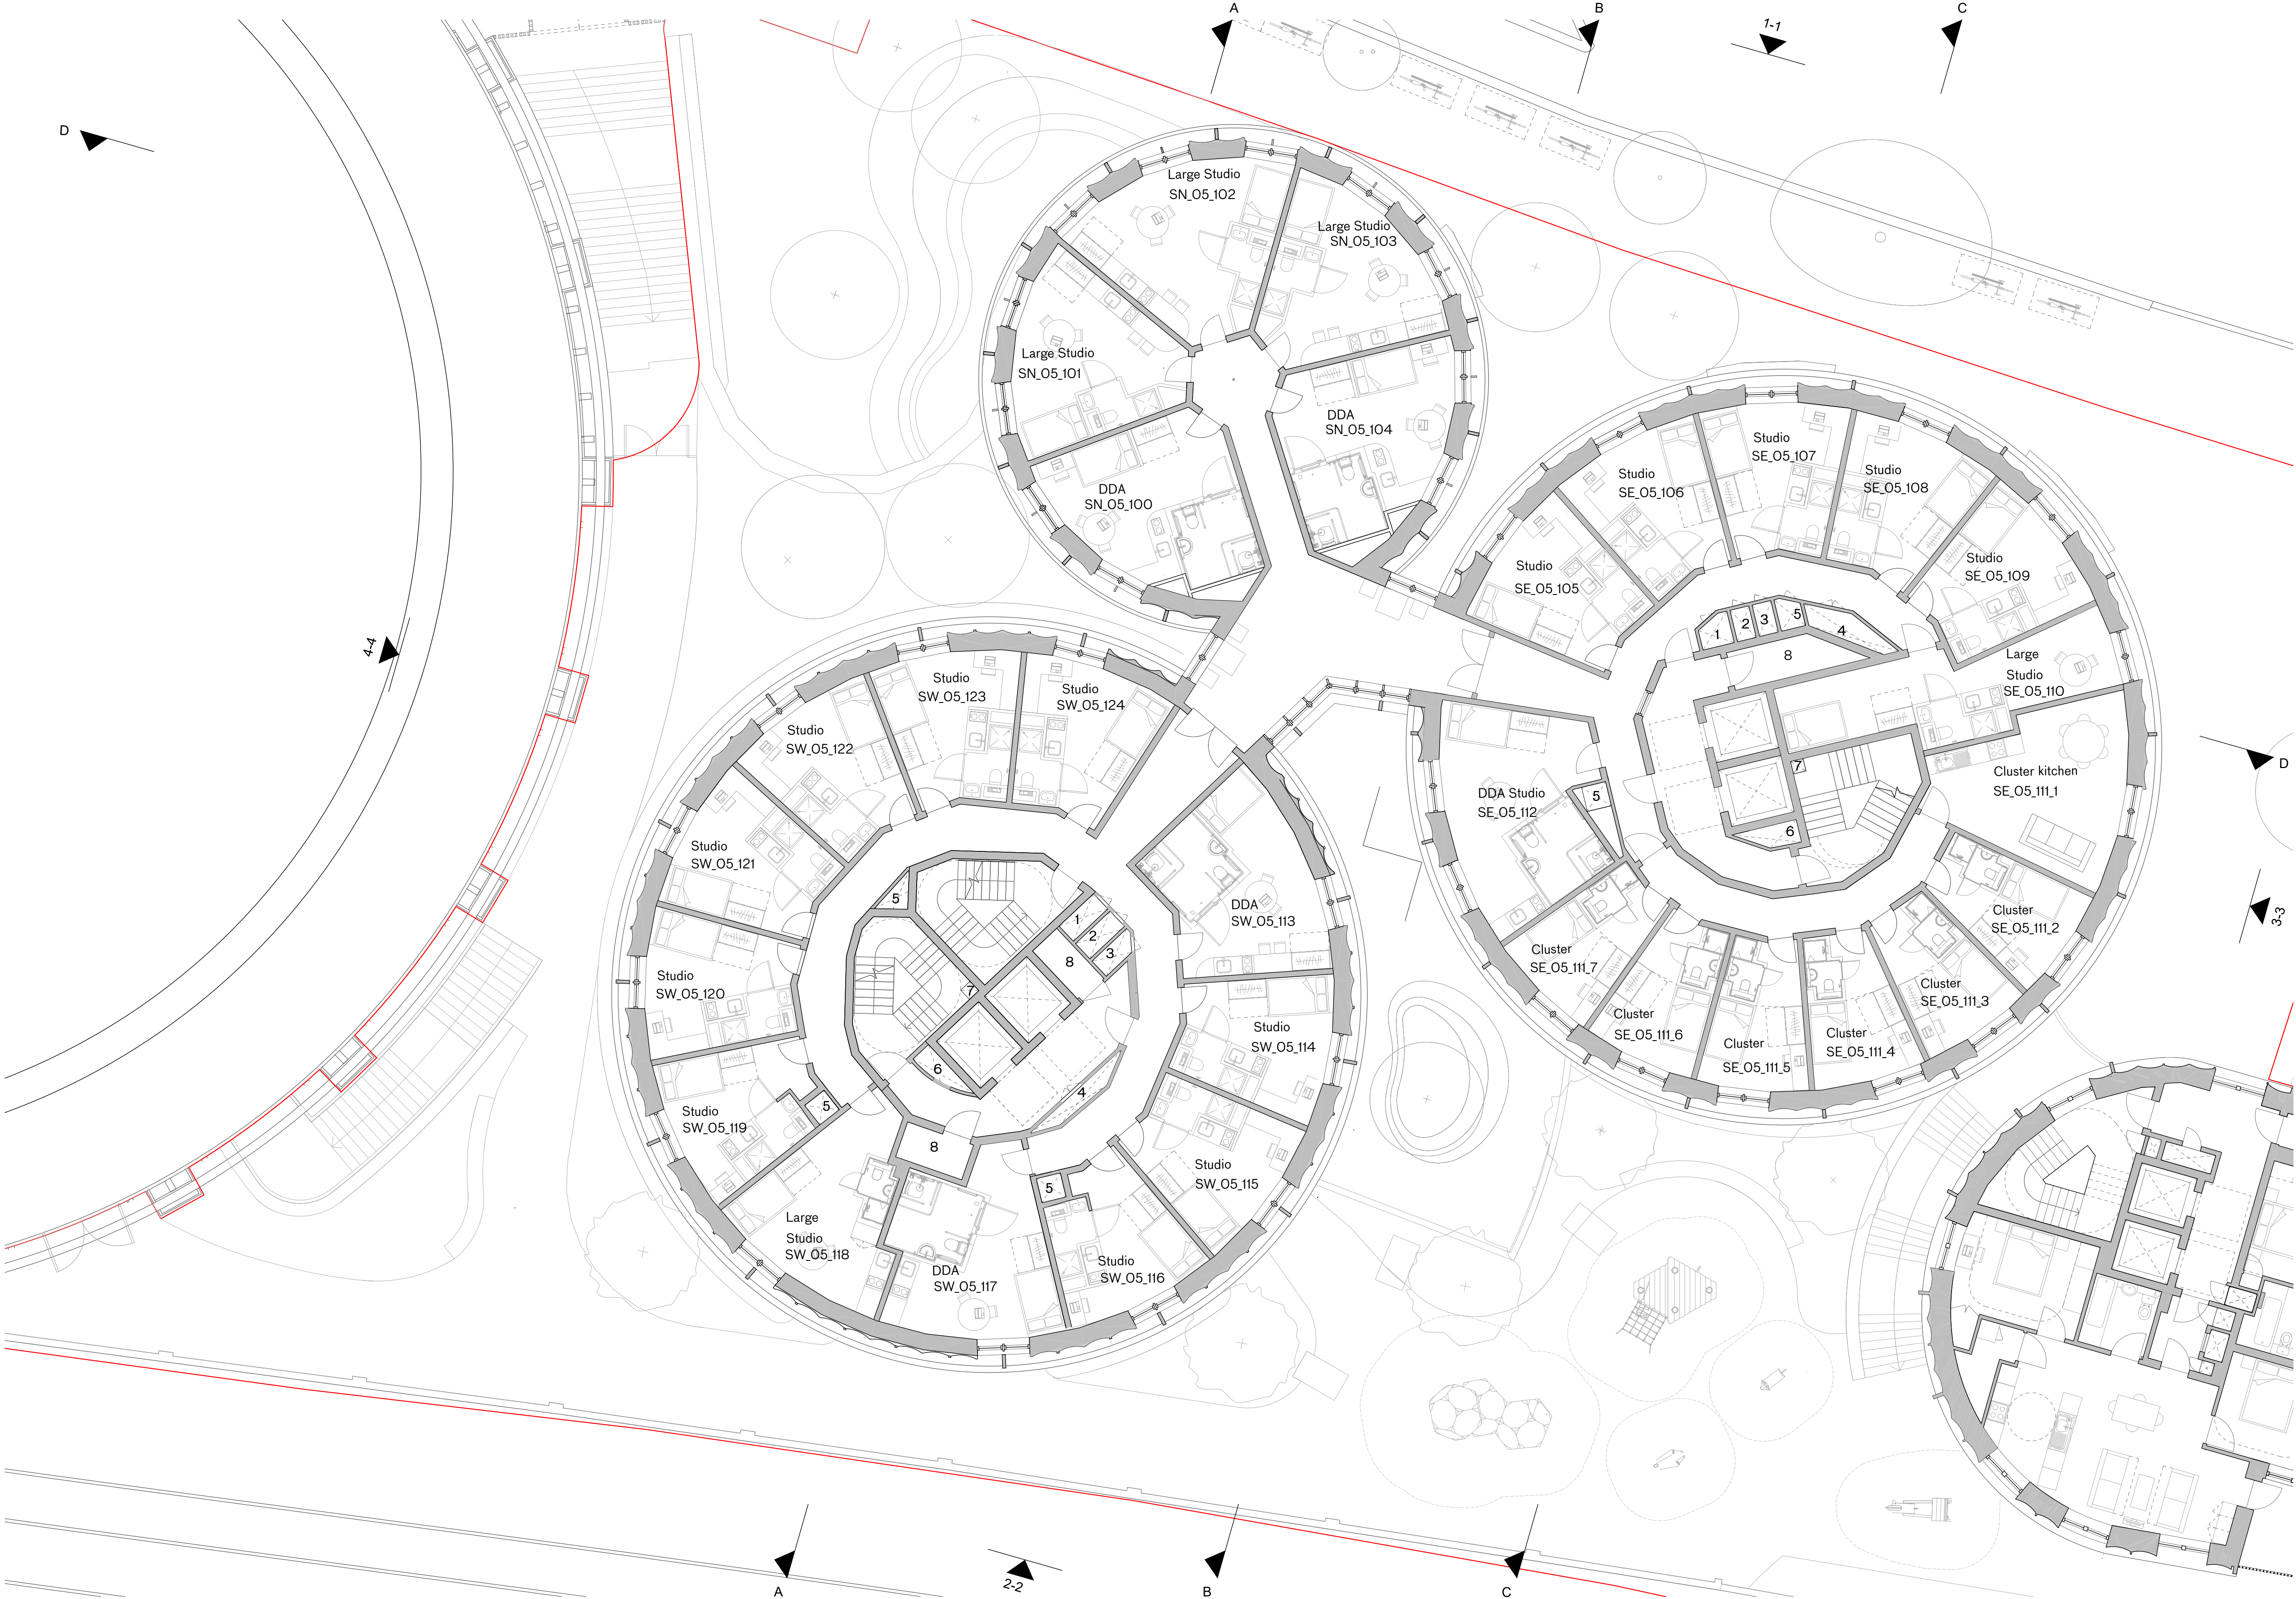

NOTES

Key to Risers

1 Heating Riser

2 Water Riser

3 Comms Riser

4 Electrical Riser

5 Smoke Outlet

6 Smoke Inlet

7 Dry Riser

8 MVHR Cupboard

9 Mechanical Ventilation

Site Boundary

Petrol Filling Station Consented Scheme, Planning Ref: 2022/3646/P

A - 31/01/24 Planning

Planning

rev	date	check	comments
DSDHA			
357 Kennington Lane London SE11 5QY			
T 020 7703 3555			
F 020 7703 3890			
E info@dshda.co.uk			
W www.dshda.co.uk			
project			
100 Chalk Farm Road			
drawing title			
PBSA Level 5 Floor Plan			
drawn	size	date	scale
SZ	A1	12/01/24	1 : 100
drawing number			revision
356_P20.135			A
REPORT DISCREPANCIES DO NOT SCALE FROM THIS DRAWING COPYRIGHT DSDHA		USE LATEST REVISION CHECK DIMENSIONS ON SITE	