


Affordable Housing Level 1 Floor Plan

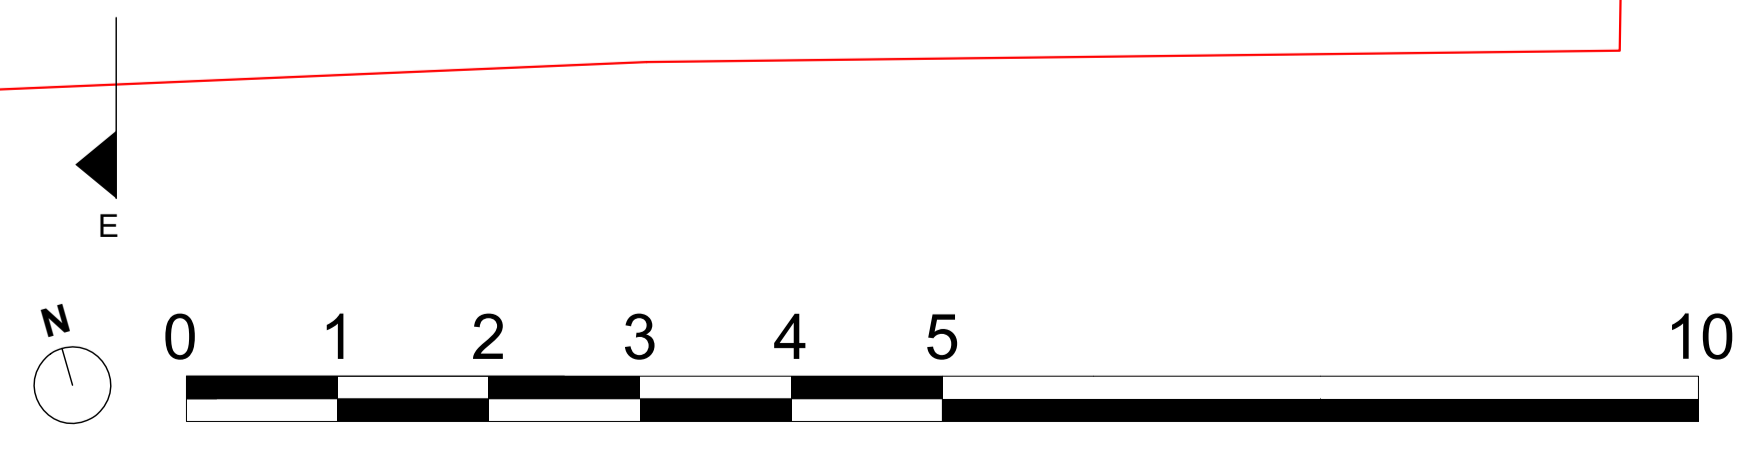

NOTES

Key to Risers
 1 Heating Riser
 2 Water Riser
 3 Comms Riser
 4 Electrical Riser
 5 Smoke Outlet
 6 Smoke Inlet
 7 Dry Riser
 8 MVHR Cupboard
 9 Mechanical Ventilation

— Site Boundary

— Petrol Filling Station Consented Scheme. Planning Ref: 2022/3646/P

A - 31/01/24 Planning

Planning

rev	date	check	comments
DSDHA			
357 Kennington Lane London SE11 5QY			
T 020 7703 3555			
F 020 7703 3890			
E info@dshda.co.uk			
W www.dshda.co.uk			
project			

100 Chalk Farm Road

drawing title
Affordable Housing Level 1 Floor Plan

drawn	size	date	scale
SZ	A1	12/01/24	1 : 50
drawing number	revision		
356_P20.161	A		

REPORT DISCREPANCIES DO NOT SCALE FROM THIS DRAWING COPYRIGHT DSDHA USE LATEST REVISION CHECK DIMENSIONS ON SITE