


Affordable Housing Level 9 Floor Plan

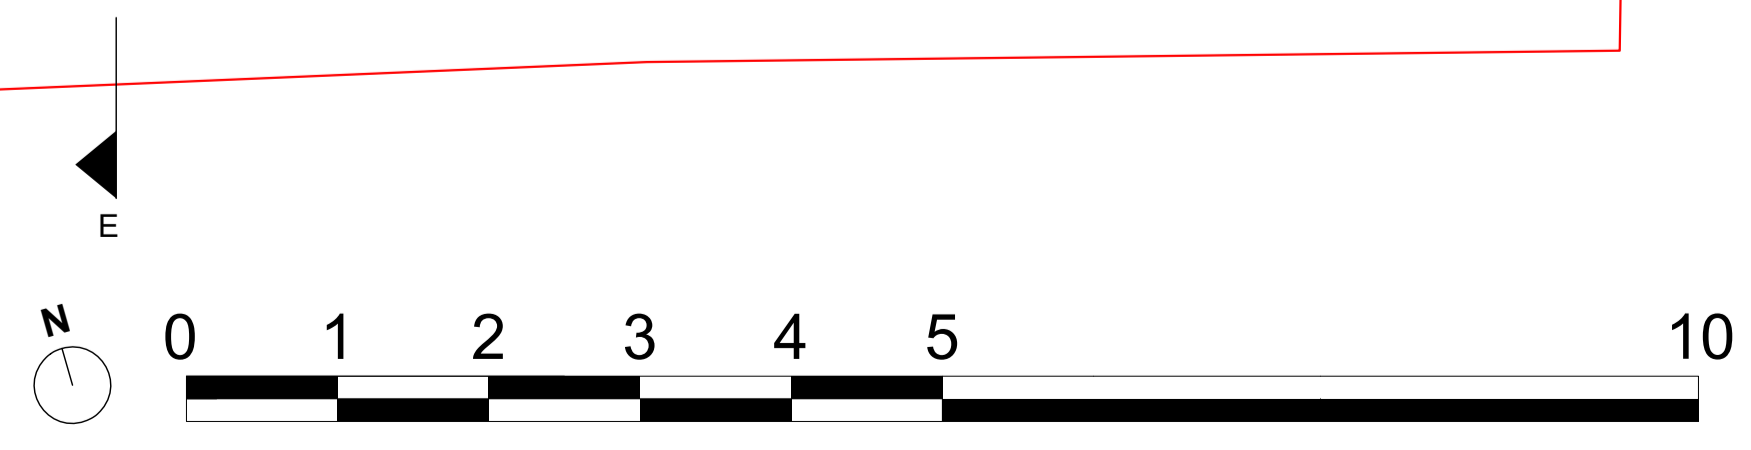

**NOTES**

**Key to Risers**  
 1 Heating Riser  
 2 Water Riser  
 3 Comms Riser  
 4 Electrical Riser  
 5 Smoke Outlet  
 6 Smoke Inlet  
 7 Dry Riser  
 8 MVHR Cupboard  
 9 Mechanical Ventilation

Site Boundary

Petrol Filling Station Consented Scheme. Planning Ref: 2022/3646/P

A - 31/01/24 Planning

# Planning

rev	date	check	comments
<b>DSDHA</b>			
357 Kennington Lane London SE11 5QY			
T 020 7703 3555			
F 020 7703 3890			
E info@dsdha.co.uk			
W www.dsdha.co.uk			
project			

100 Chalk Farm Road

drawing title

**Affordable Housing Level 9 Floor Plan**

drawn	size	date	scale
SZ	A1	12/01/24	1 : 50
drawing number	revision		
356_P20.169	A		

REPORT DISCREPANCIES DO NOT SCALE FROM THIS DRAWING COPYRIGHT DSDHA

USE LATEST REVISION CHECK DIMENSIONS ON SITE