



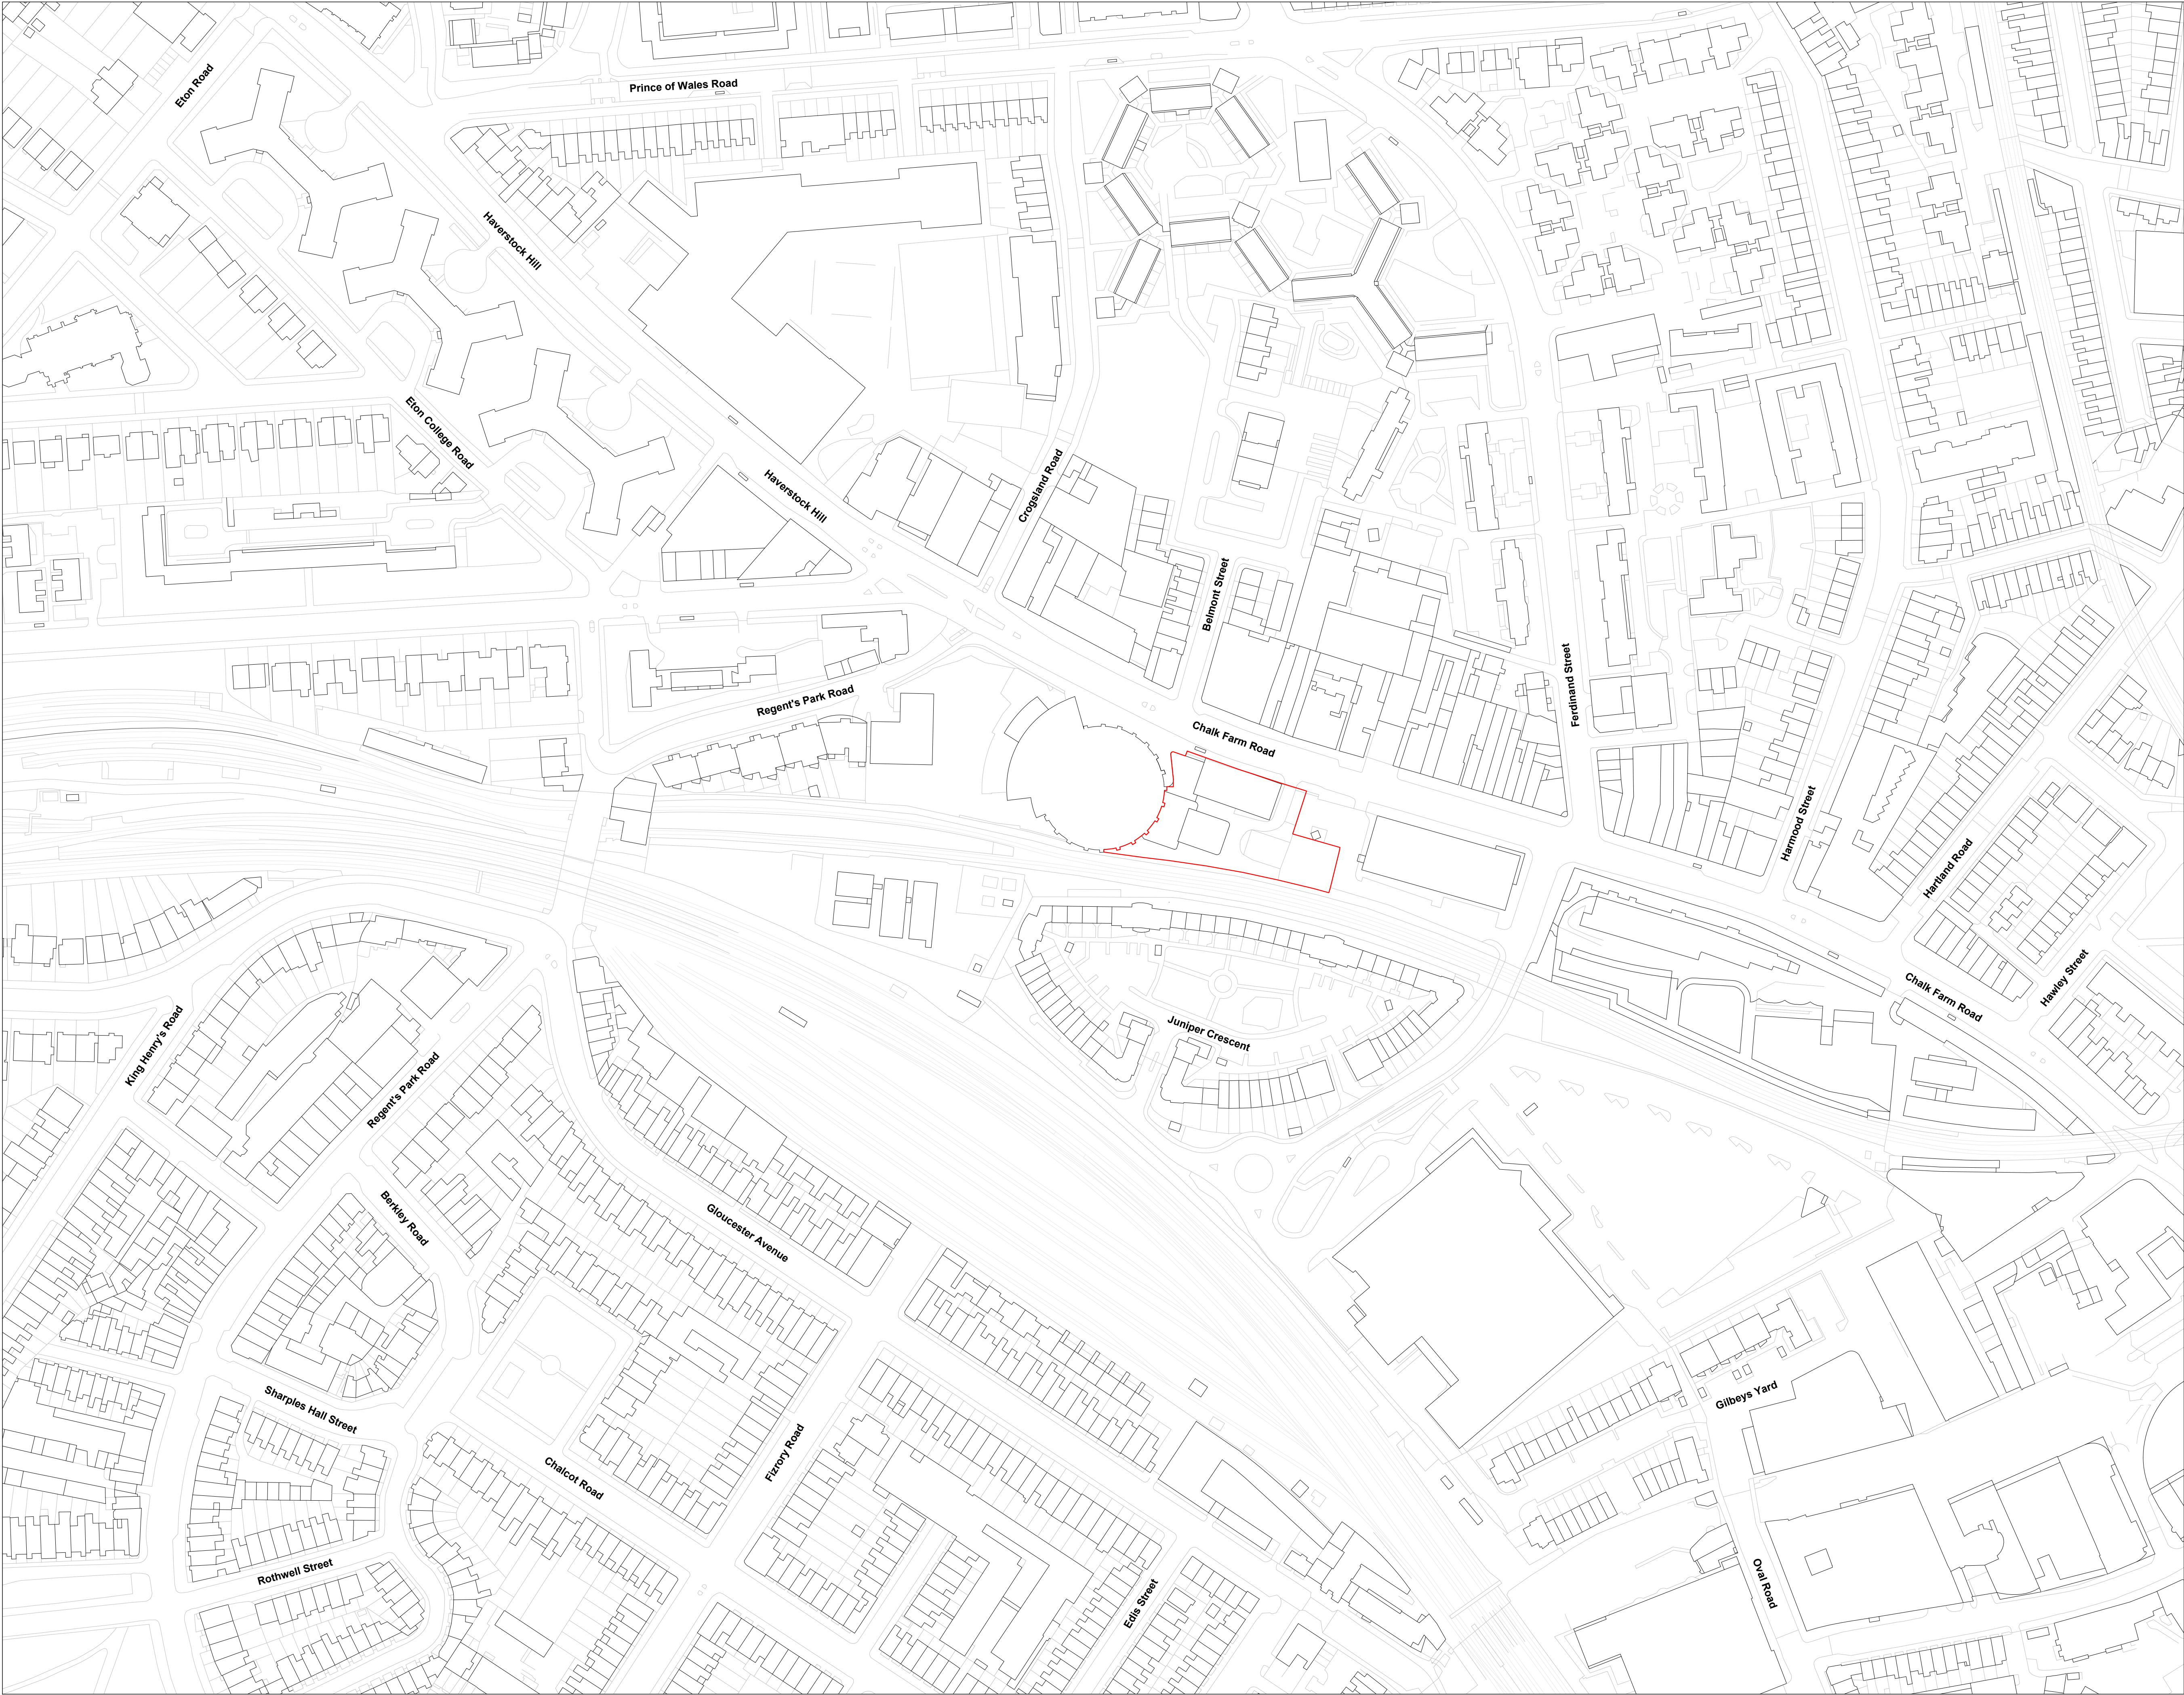


NOTES

A 24/01/15 Planning Draft

INFORMATION

rev	date	check	comments
DSDHA 357 Kennington Lane London SE11 5QY T 020 7703 3555 F 020 7703 3890 E info@dsdha.co.uk W www.dsdha.co.uk			
project			
100 Chalk Farm Road			
drawing title			
Existing Location Plan			
drawn	size	date	scale
SZ	A1	15/01/24	1 : 1250
drawing number			revision
356_P10.001			A
REPORT DISCREPANCIES DO NOT SCALE FROM THIS DRAWING COPYRIGHT DSDHA		USE LATEST REVISION CHECK DIMENSIONS ON SITE	

 
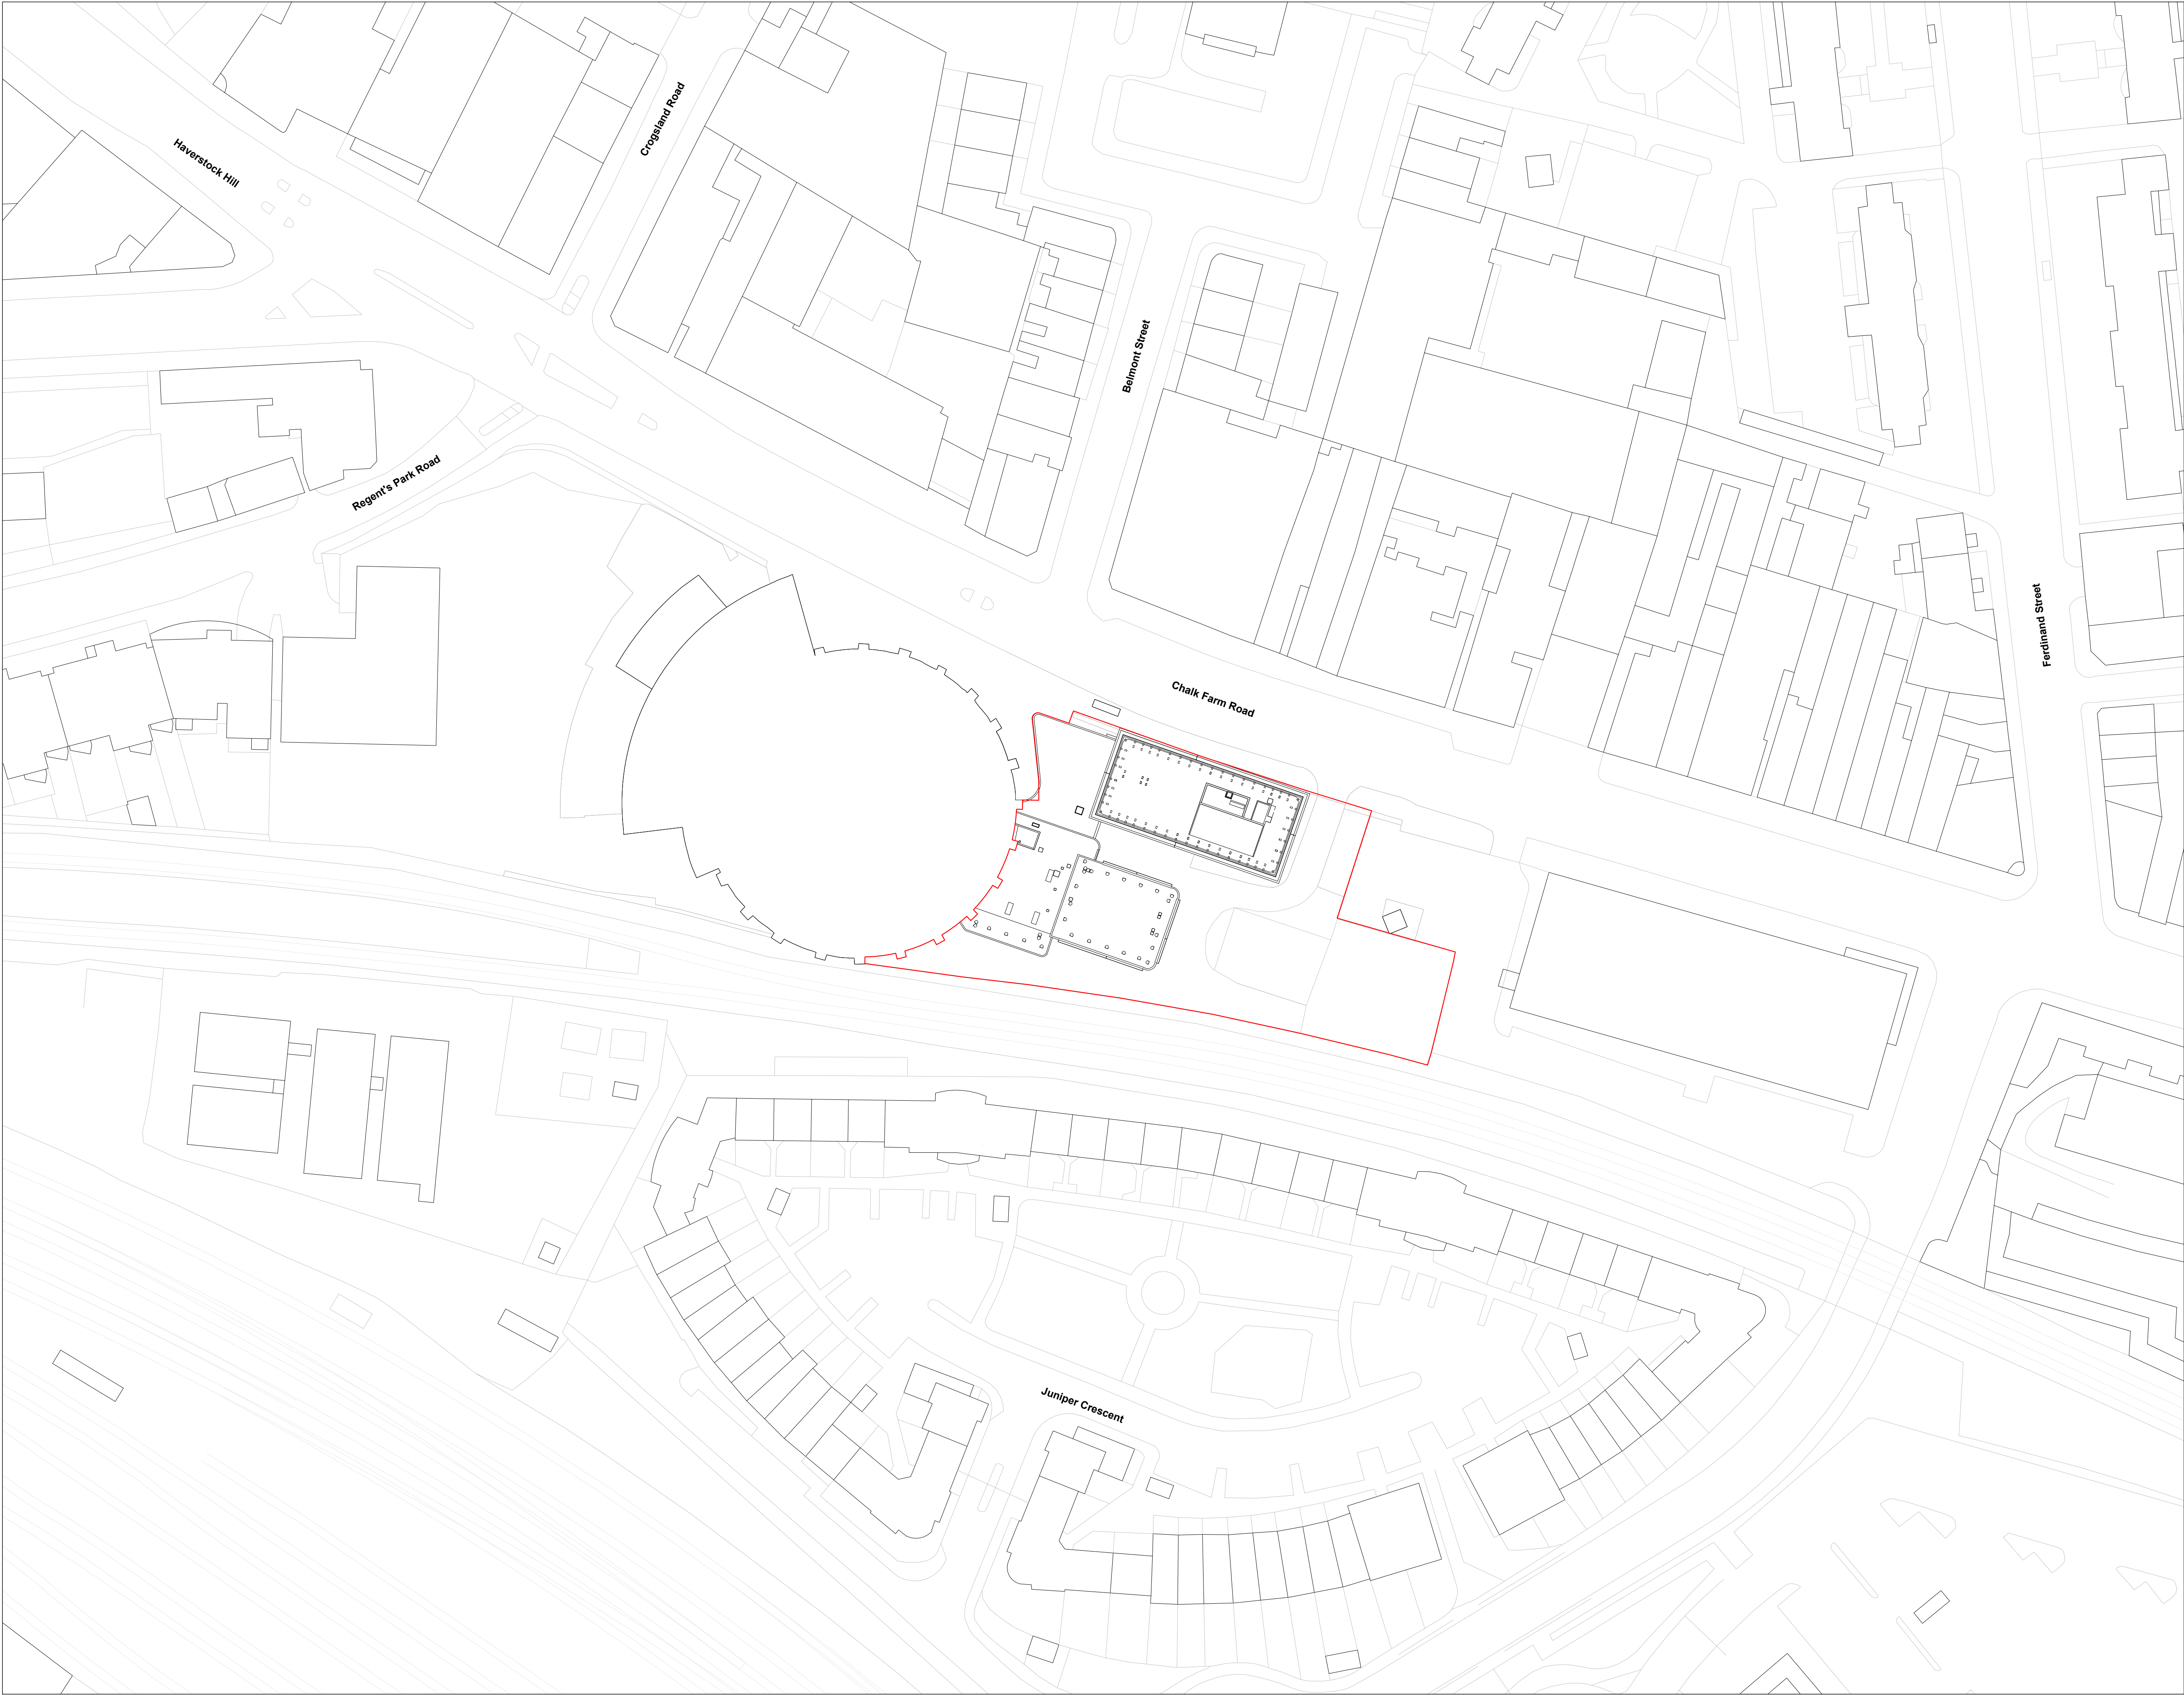


NOTES

A 24/01/15 Planning Draft

INFORMATION

rev	date	check	comments
DSDHA 357 Kennington Lane London SE11 5QY T 020 7703 3555 F 020 7703 3890 E info@dsdha.co.uk W www.dsdha.co.uk			
project			
100 Chalk Farm Road			
drawing title			
Existing Site Plan			
drawn	size	date	scale
SZ	A1	15/01/24	1 : 500
drawing number			revision
356_P10.002			A
REPORT DISCREPANCIES DO NOT SCALE FROM THIS DRAWING COPYRIGHT DSDHA		USE LATEST REVISION CHECK DIMENSIONS ON SITE	

 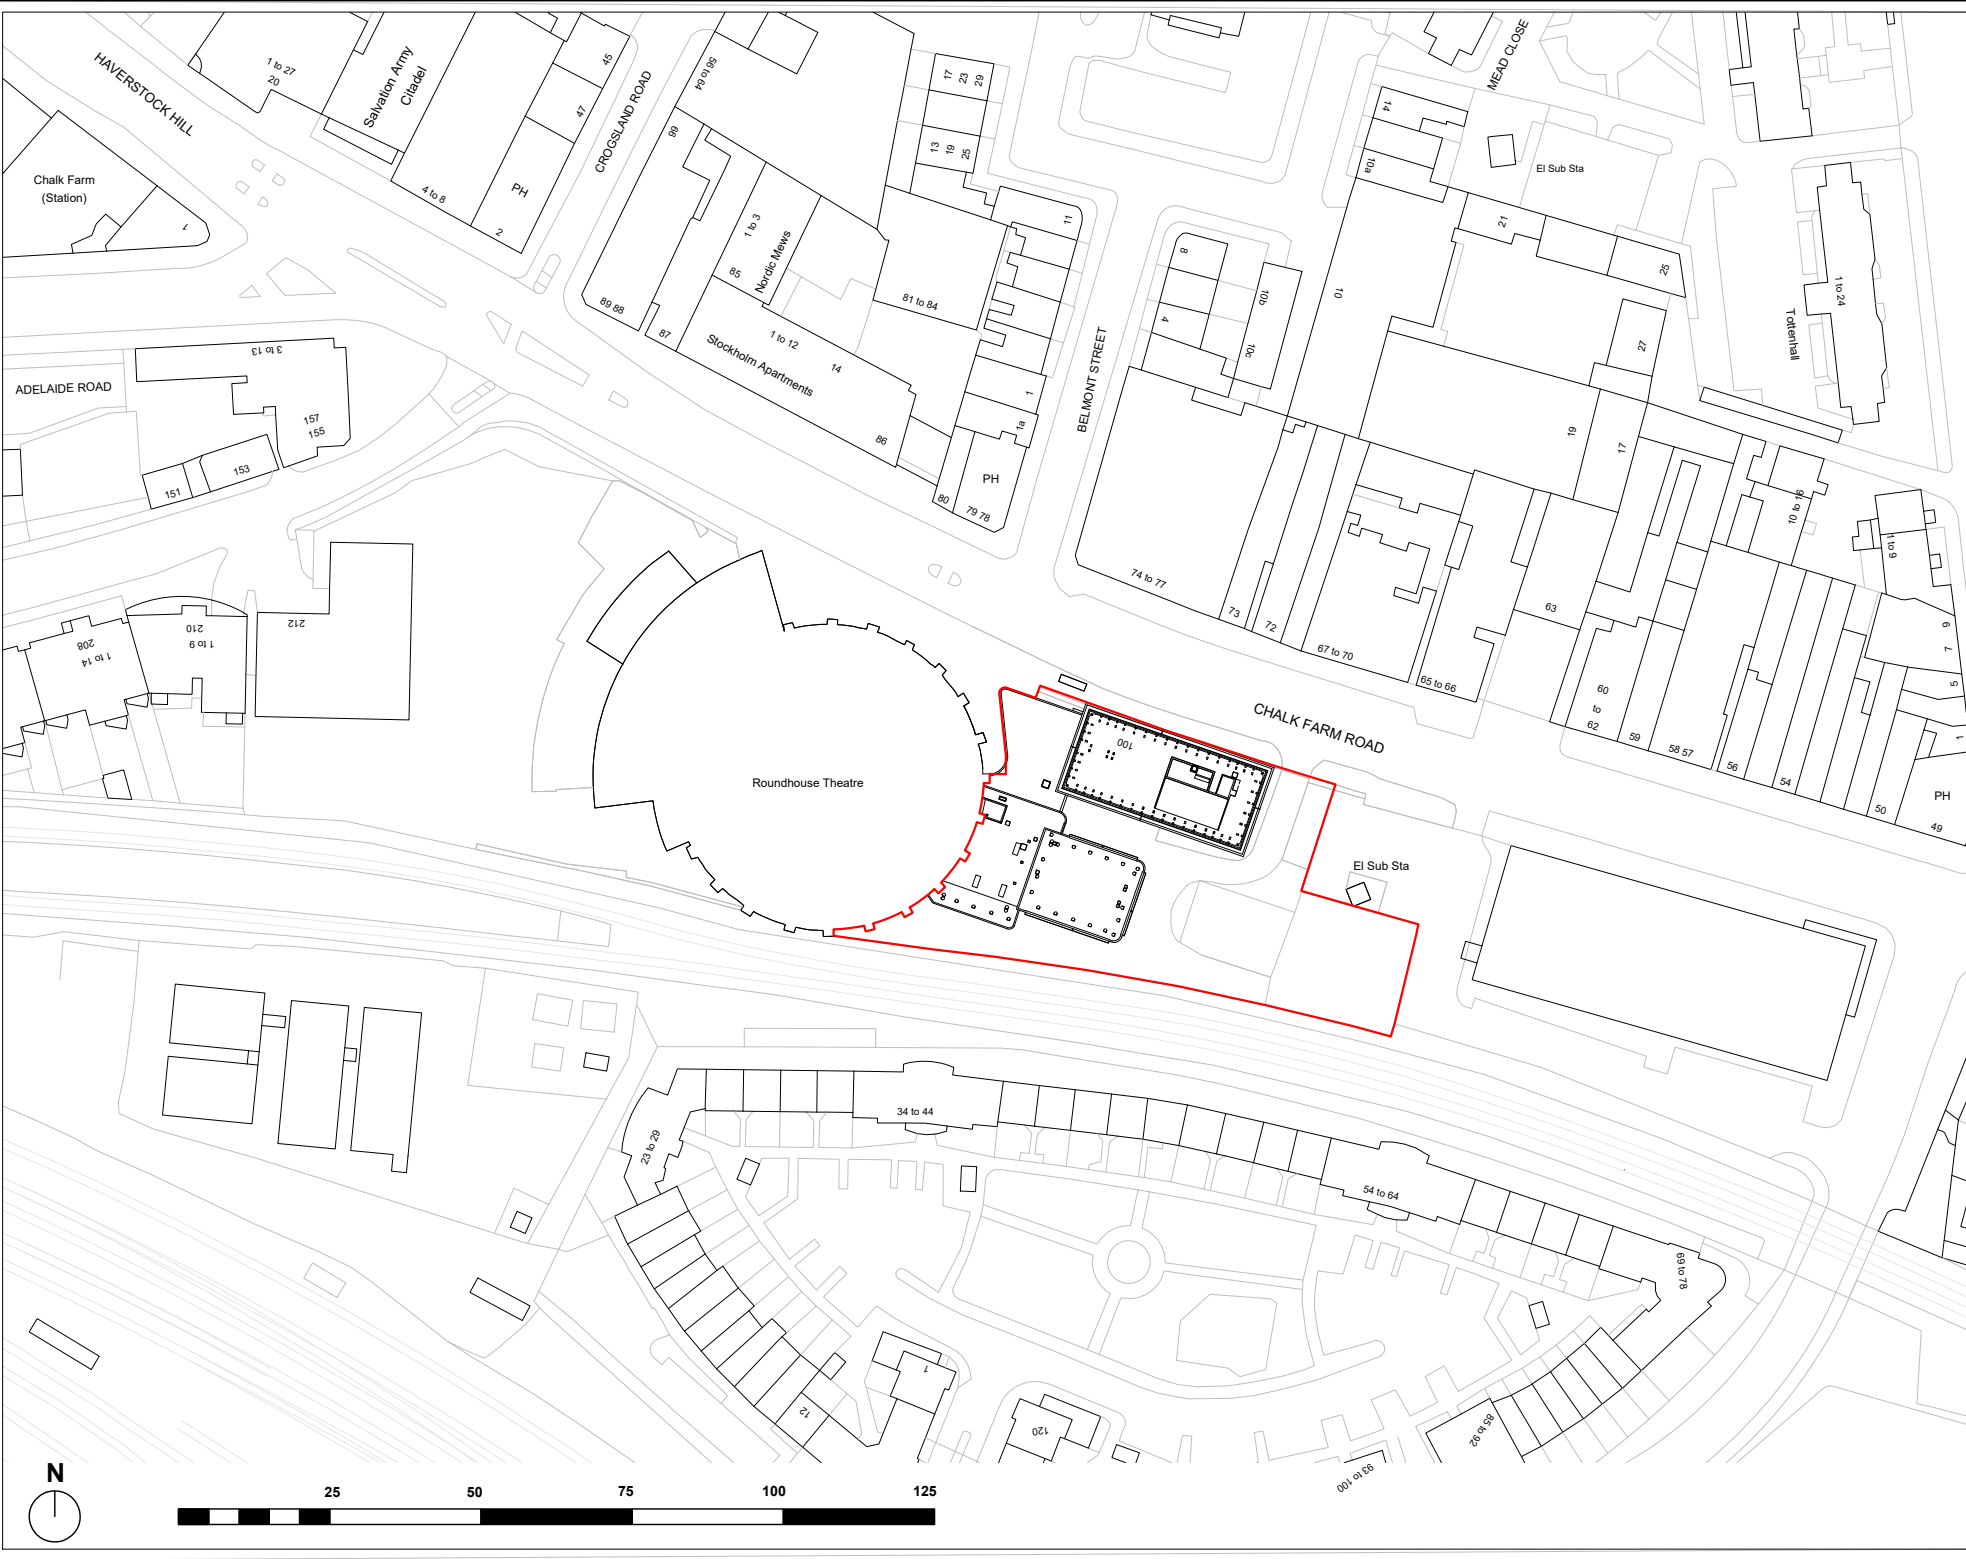

NOTES

A 24/01/15 Planning Draft

INFORMATION

rev	date	check	comments
DSDHA			
357 Kensington Lane London SE11 5QY			
T: 020 7703 3555			
F: 020 7703 3890			
E: info@dsha.co.uk			
W: www.dsha.co.uk			
project			
100 Chalk Farm Road			
drawing title			
Existing Location Plan			
drawn	size	date	scale
SZ	A4	15/01/24	1:1250
drawing number			revision
			A
REPORT DISCREPANCIES DO NOT SCALE FROM THIS DRAWING COPYRIGHT DSDHA		USE LATEST REVISION CHECK DIMENSIONS ON SITE	




- NOTES
- 1 Heating Riser
 - 2 Water Riser
 - 3 Comms Riser
 - 4 Electrical Riser
 - 5 Smoke Inlet
 - 6 Smoke Inlet
 - 7 Dry Riser
 - 8 MVHR Cupboard
 - 9 Mechanical Ventilation Vent

- G_24/01/16 Design Freeze 2
- F_24/01/12 Design Freeze 2
- E_23/12/19 Coordination
- D_23/11/22 Design Freeze
- C_23/11/17 Design Freeze
- B_23/11/09 Draft Design Freeze
- A_23/11/03 Draft Plan

INFORMATION

rev	date	check	comments
DSDHA 357 Kennington Lane London SE11 5QY T 020 7703 3555 F 020 7703 3890 E info@dsdha.co.uk W www.dsdha.co.uk			
project			
100 Chalk Farm Road			
drawing title			
Basement Floor Plan			
drawn	size	date	scale
SZ	A1	12/01/24	1 : 150
drawing number			revision
356_P20.099			G
REPORT DISCREPANCIES DO NOT SCALE FROM THIS DRAWING COPYRIGHT DSDHA		USE LATEST REVISION CHECK DIMENSIONS ON SITE	

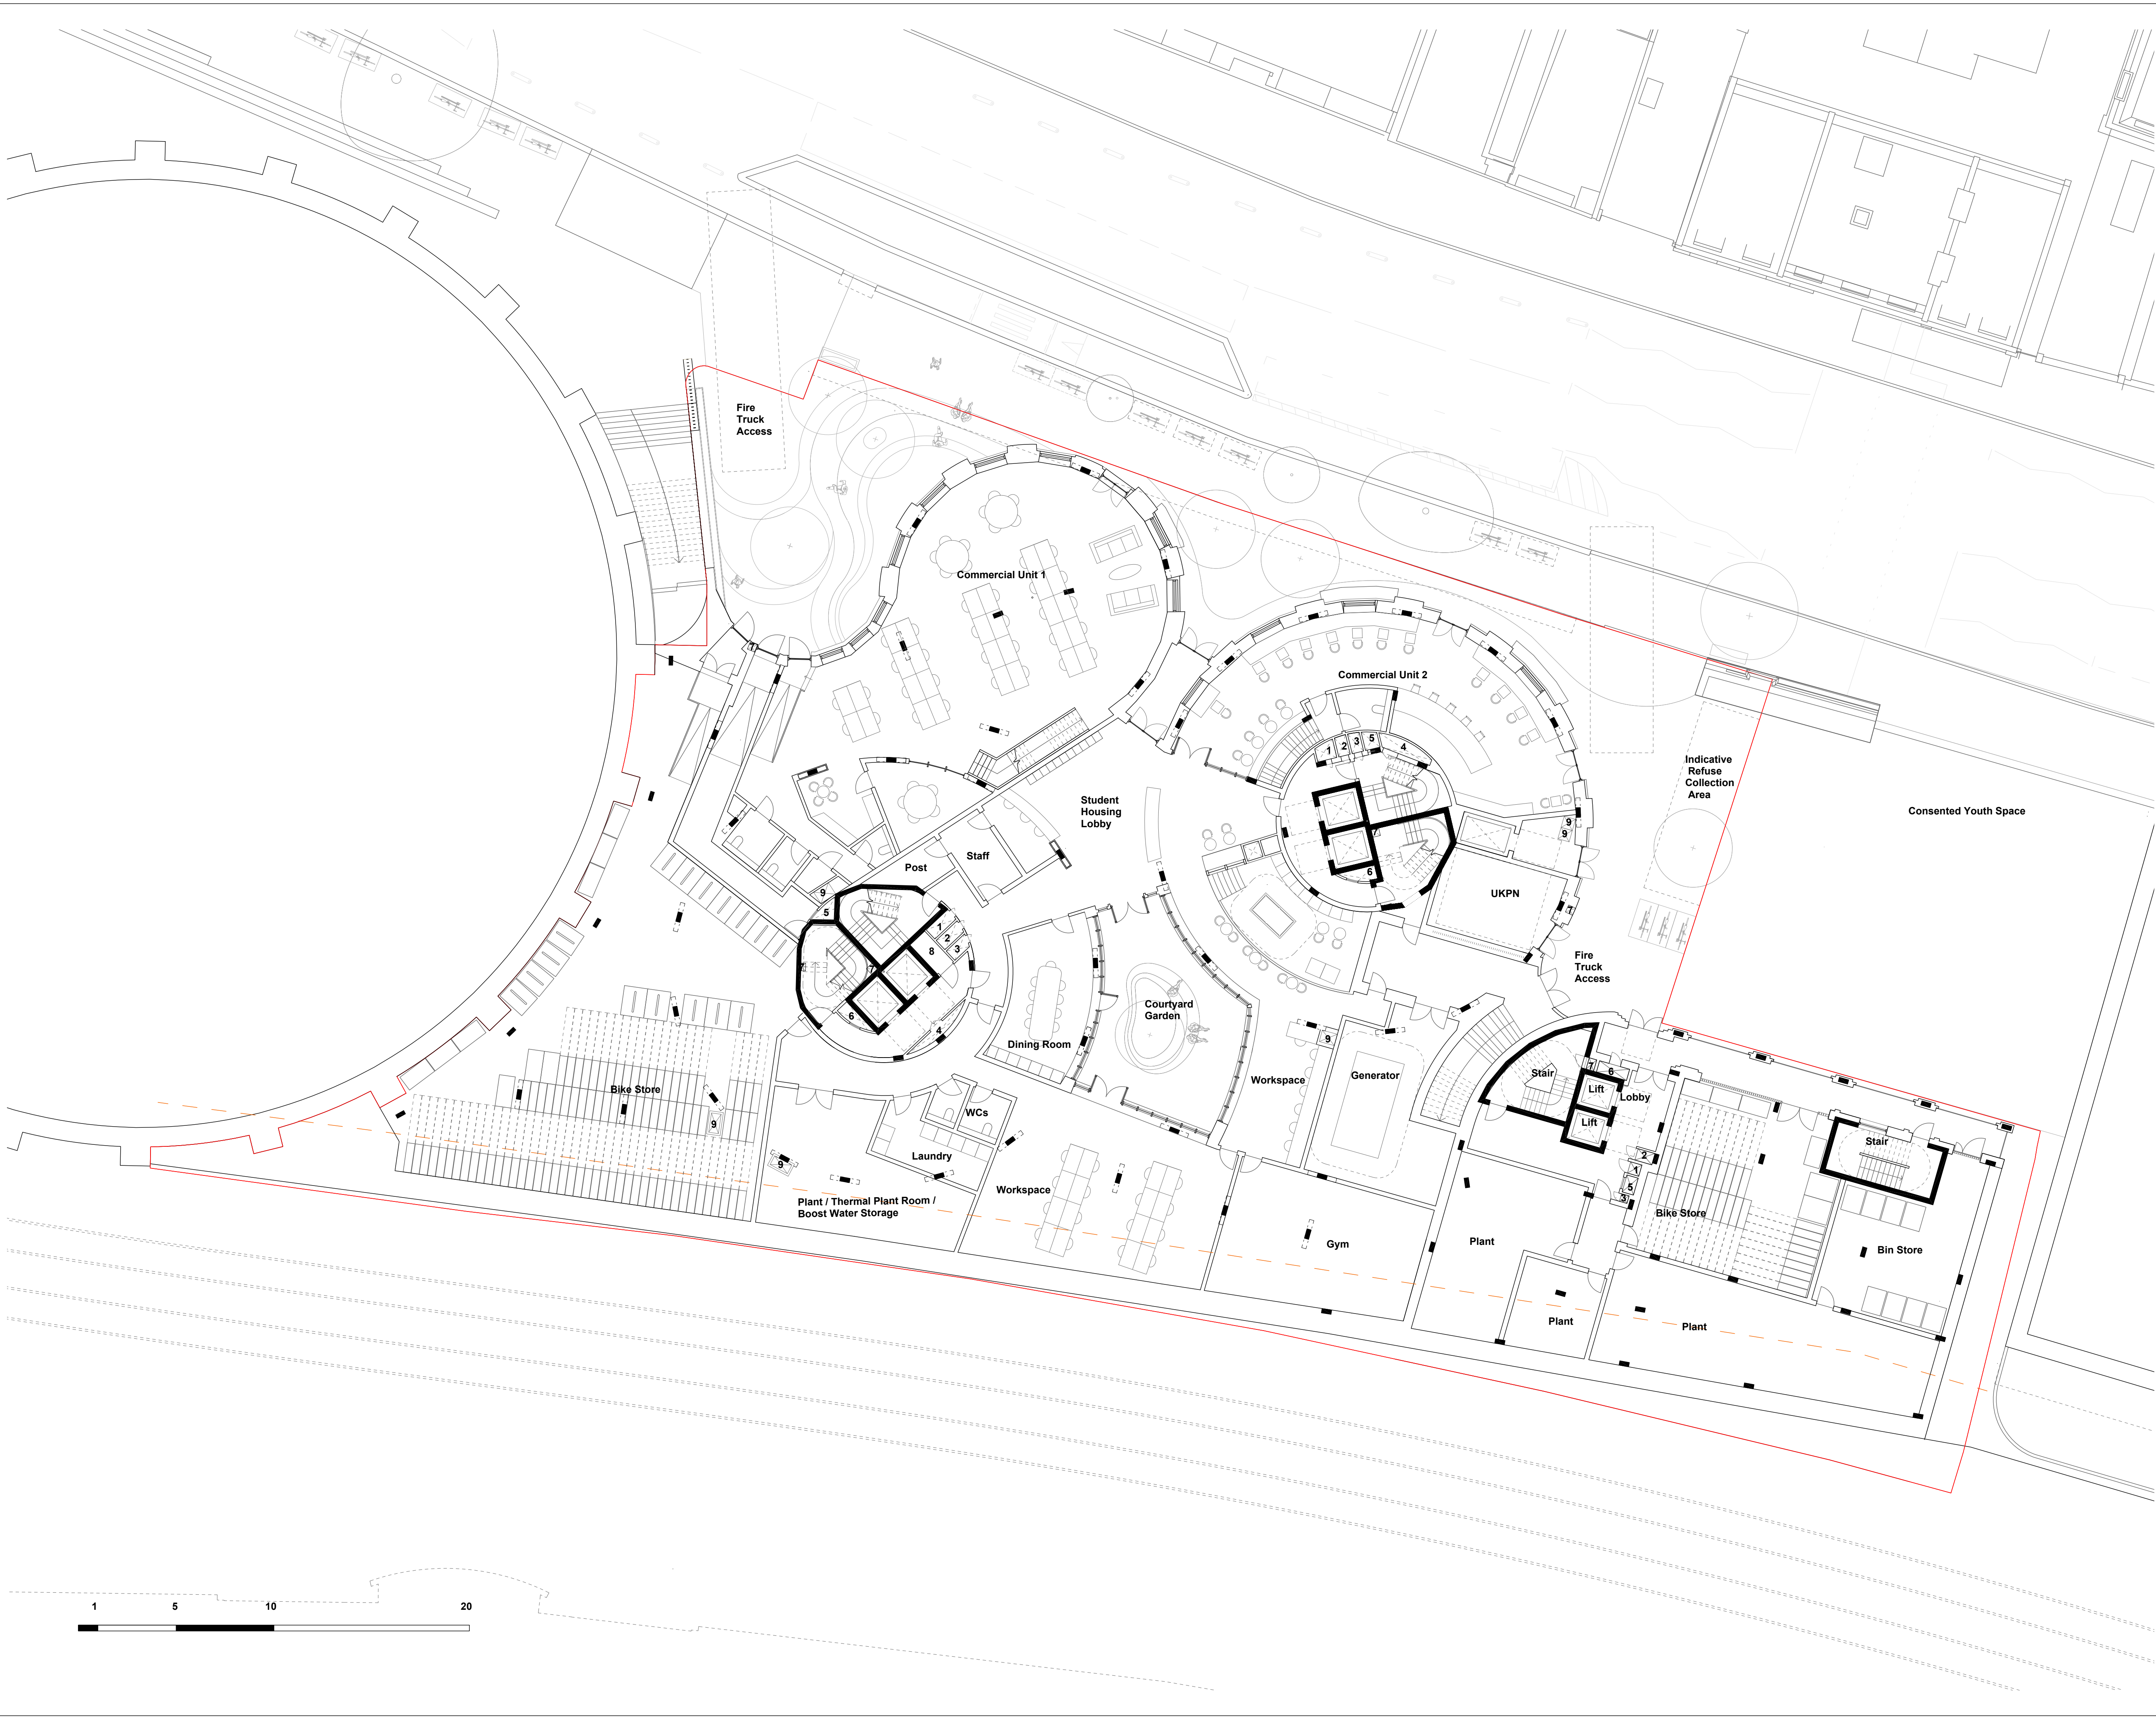

NOTES

1 Heating Riser

2 Water Riser

3 Comms Riser

4 Electrical Riser

5 Smoke Outlet

6 Smoke Inlet

7 Dry Riser

8 MVHR Cupboard

9 Mechanical Ventilation Vent

G_24/01/16 Design Freeze 2

F_24/01/12 Design Freeze 2

E_23/12/19 Coordination

D_23/11/22 Design Freeze

C_23/11/17 Design Freeze

B_23/11/09 Draft Design Freeze

A_23/11/03 Draft Plan

INFORMATION


rev	date	check	comments
DSDHA 357 Kennington Lane London SE11 5QY T 020 7703 3555 F 020 7703 3890 E info@dsdha.co.uk W www.dsdha.co.uk			

project

100 Chalk Farm Road

drawing title

Ground Floor Plan

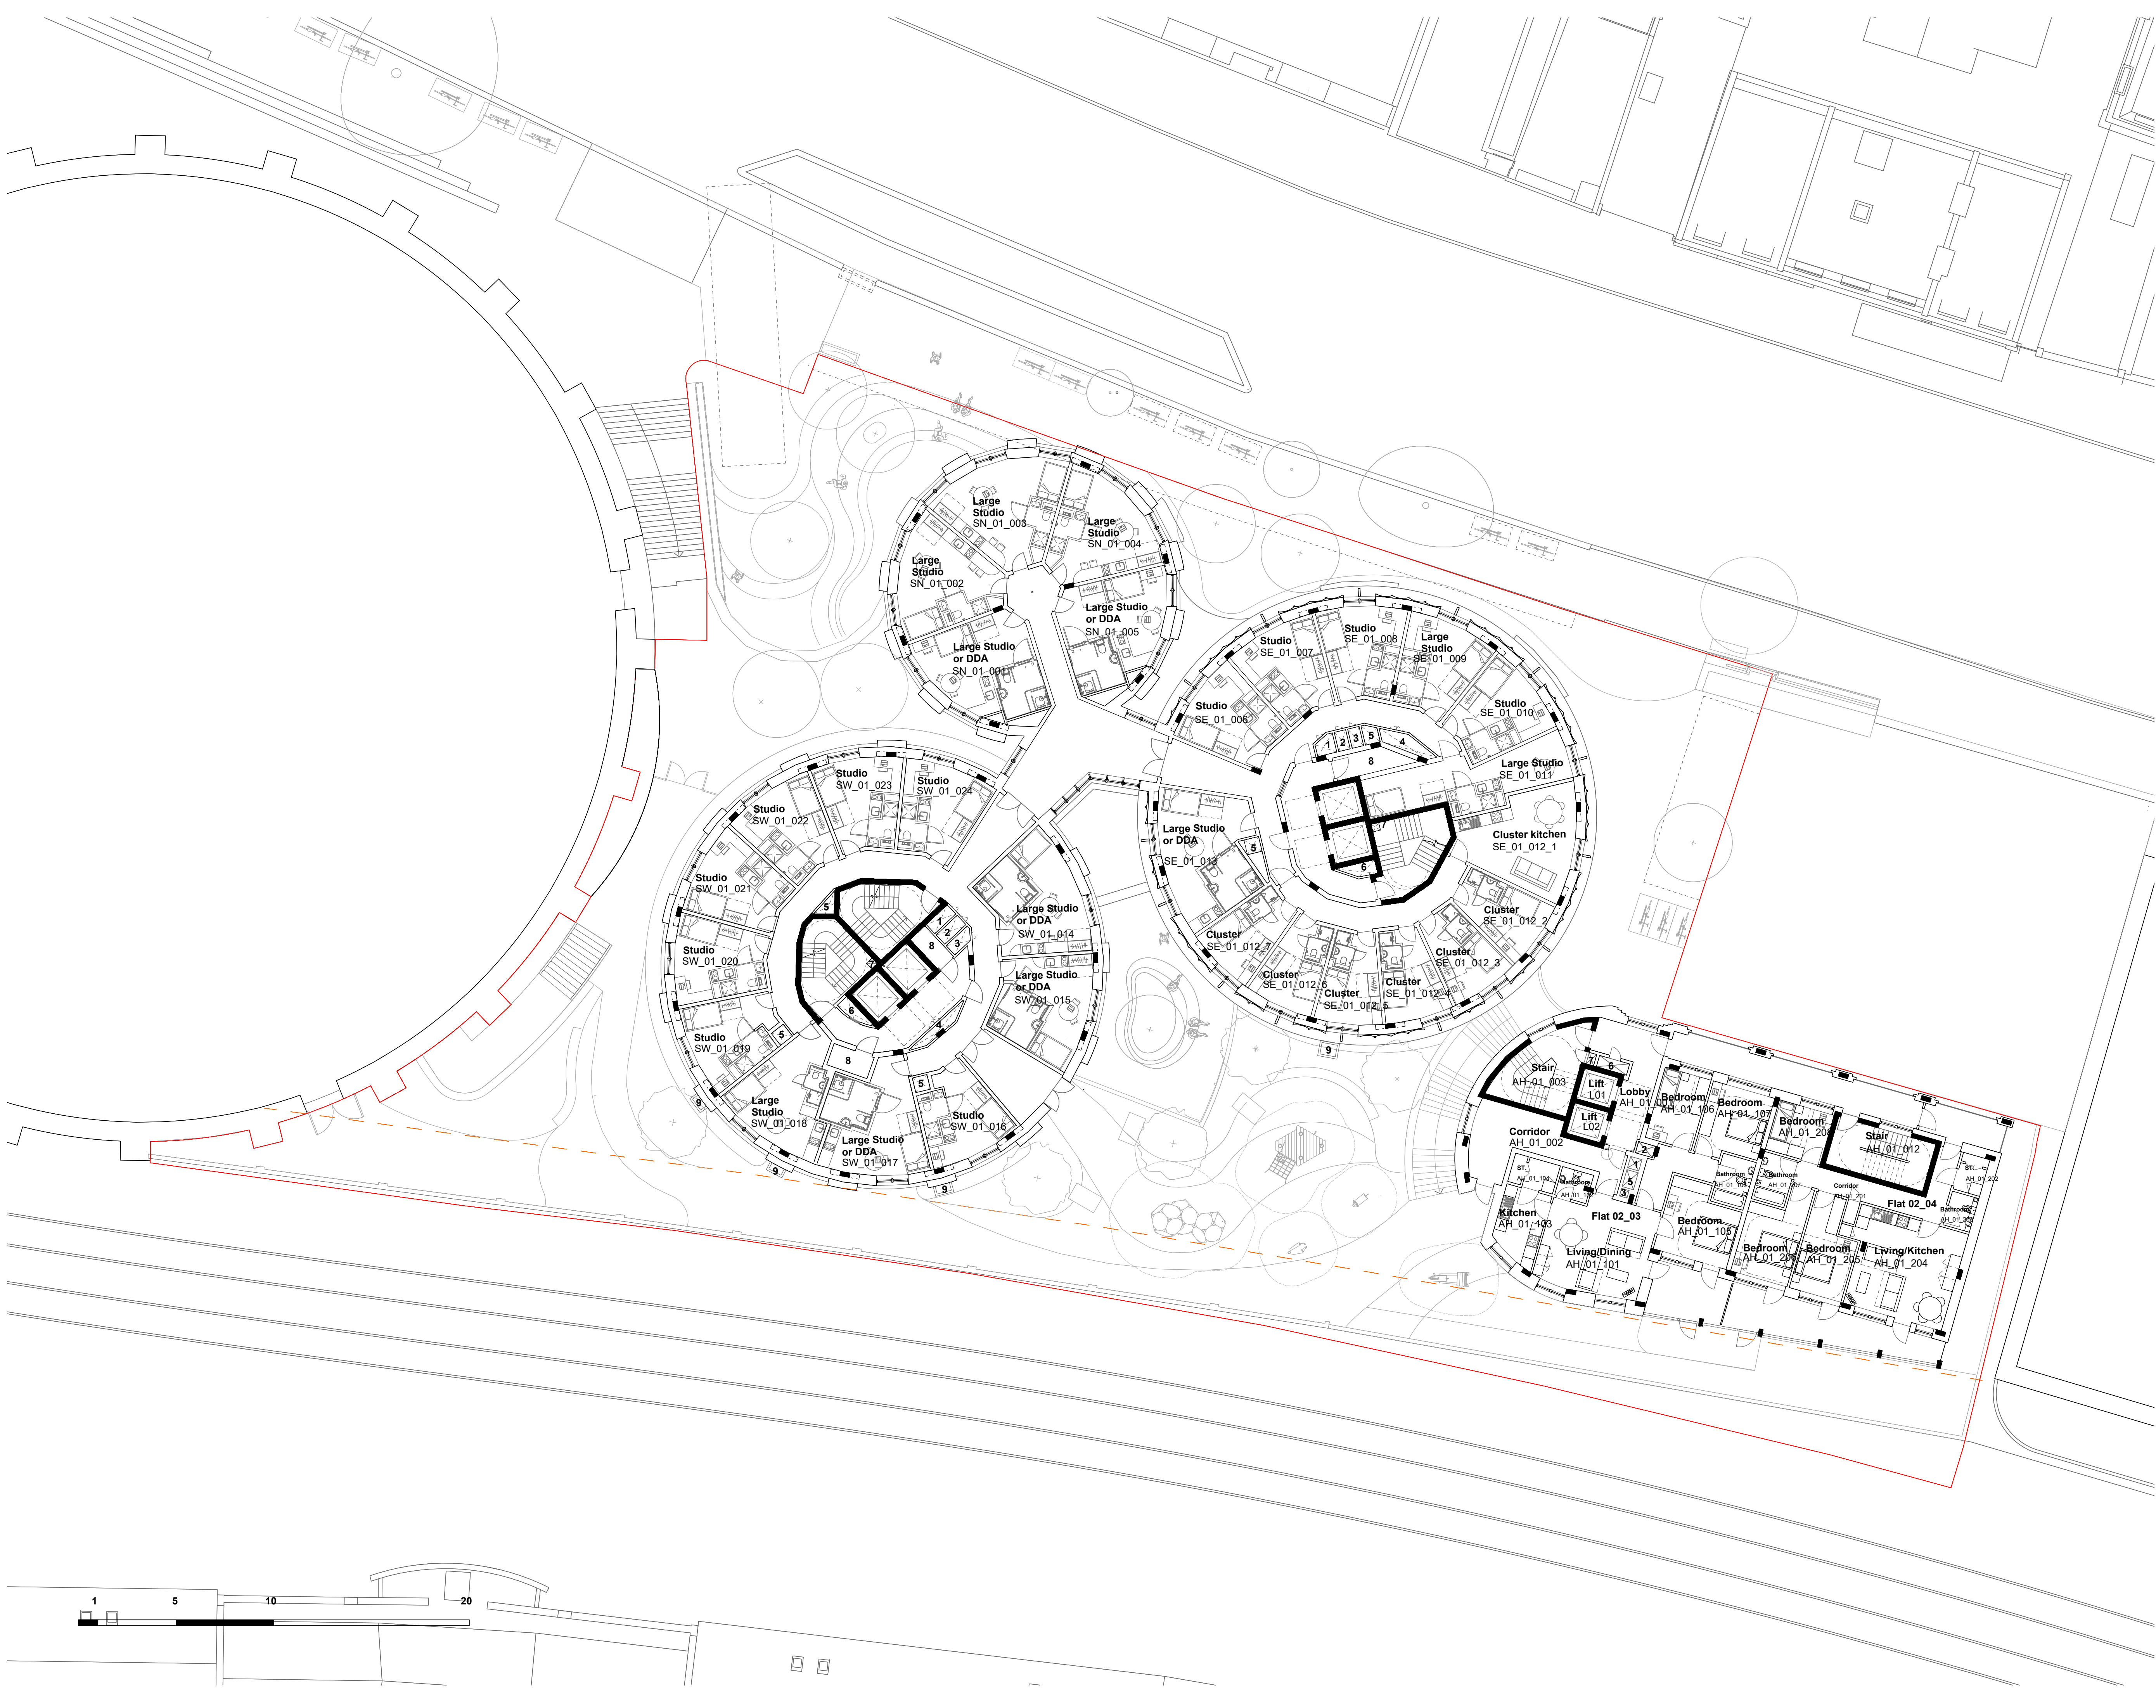


- NOTES
- 1 Heating Riser
 - 2 Water Riser
 - 3 Comms Riser
 - 4 Electrical Riser
 - 5 Smoke Outlet
 - 6 Smoke Inlet
 - 7 Dry Riser
 - 8 MVHR Cupboard
 - 9 Mechanical Ventilation Vent

G_24/01/16 Design Freeze 2
F_24/01/12 Design Freeze 2
E_23/12/19 Coordination
D_23/11/22 Design Freeze
C_23/11/17 Design Freeze
B_23/11/09 Draft Design Freeze
A_23/11/03 Draft Plan

INFORMATION

rev	date	check	comments
DSDHA 357 Kennington Lane London SE11 5QY T 020 7703 3555 F 020 7703 3890 E info@dsdha.co.uk W www.dsdha.co.uk			
project			
100 Chalk Farm Road			
drawing title			
Level 1 Floor Plan			
drawn	size	date	scale
SZ	A1	12/01/24	1 : 150
drawing number			revision
356_P20.101			G
REPORT DISCREPANCIES DO NOT SCALE FROM THIS DRAWING COPYRIGHT DSDHA		USE LATEST REVISION CHECK DIMENSIONS ON SITE	

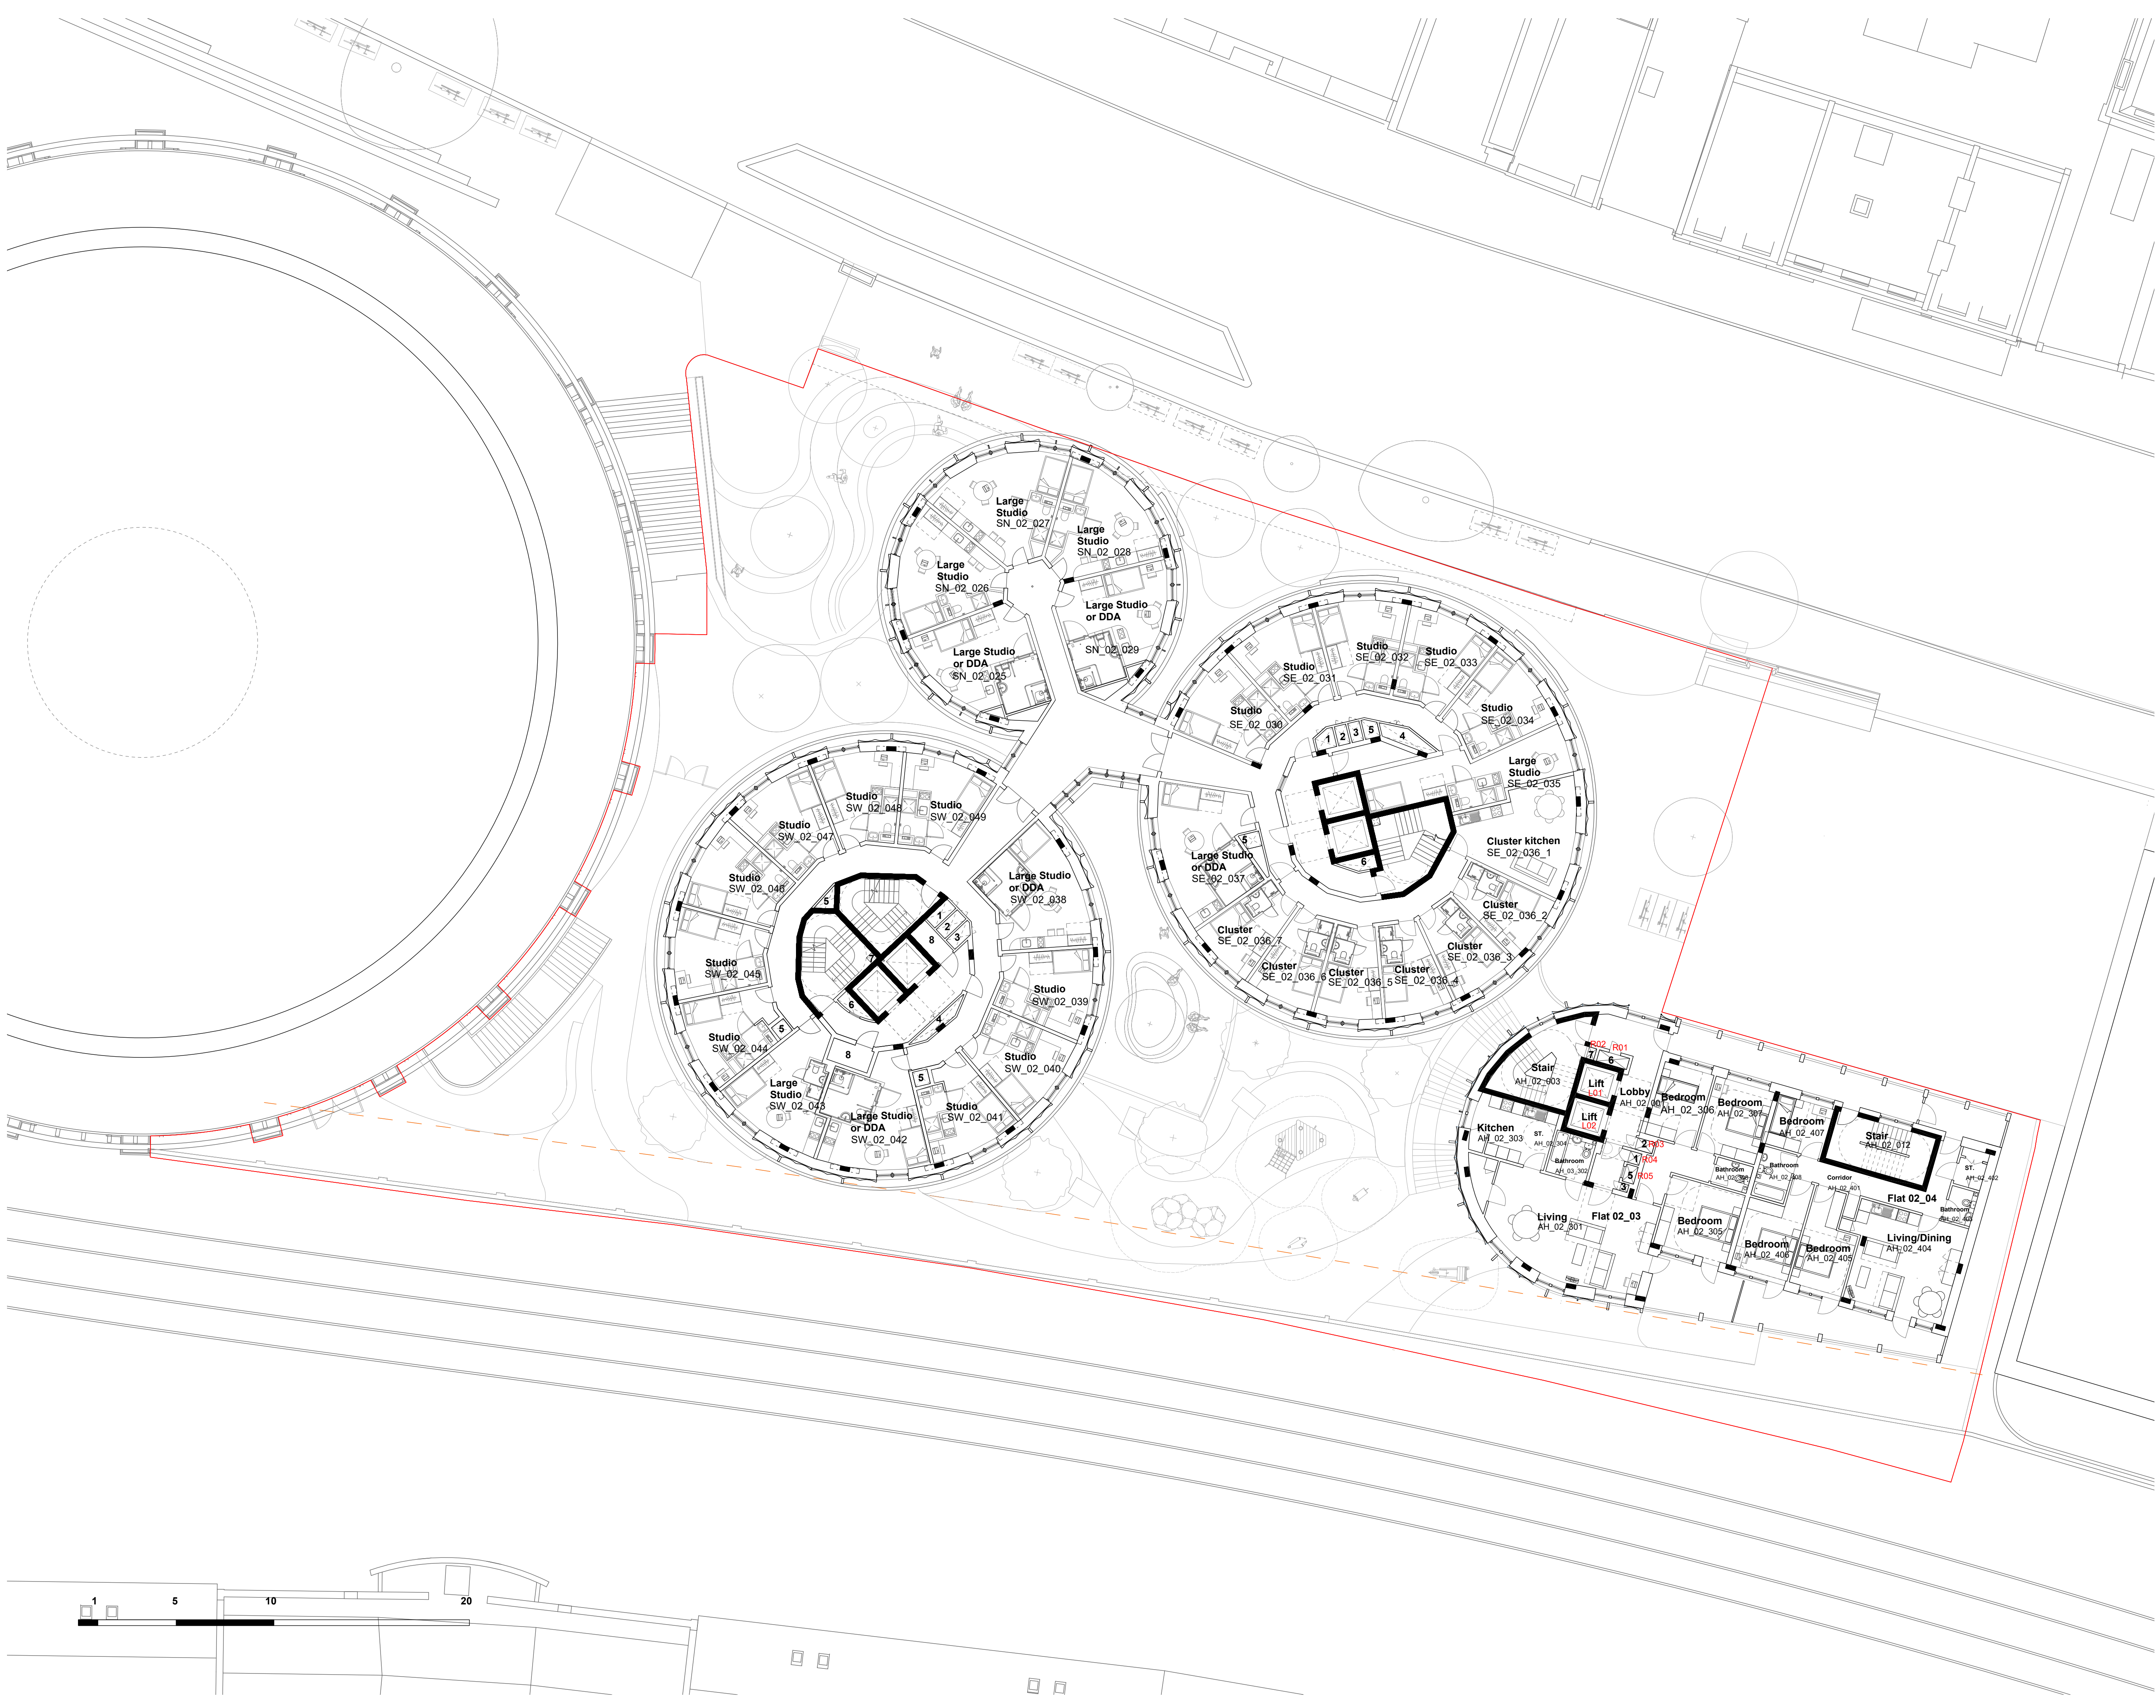


- NOTES
- 1 Heating Riser
 - 2 Water Riser
 - 3 Comms Riser
 - 4 Electrical Riser
 - 5 Smoke Inlet
 - 6 Smoke Inlet
 - 7 Dry Riser
 - 8 MVHR Cupboard
 - 9 Mechanical Ventilation Vent

G_24/01/16 Design Freeze 2
F_24/01/12 Design Freeze 2
E_23/12/19 Coordination
D_23/11/22 Design Freeze
C_23/11/17 Design Freeze
B_23/11/09 Draft Design Freeze
A_23/11/03 Draft Plan

INFORMATION

rev	date	check	comments
DSDHA 357 Kennington Lane London SE11 5QY T 020 7703 3555 F 020 7703 3890 E info@dsdha.co.uk W www.dsdha.co.uk			
project			
100 Chalk Farm Road			
drawing title			
Level 2-3 Floor Plan			
drawn	size	date	scale
SZ	A1	12/01/24	1 : 150
drawing number			revision
356_P20.102			G
REPORT DISCREPANCIES DO NOT SCALE FROM THIS DRAWING COPYRIGHT DSDHA		USE LATEST REVISION CHECK DIMENSIONS ON SITE	

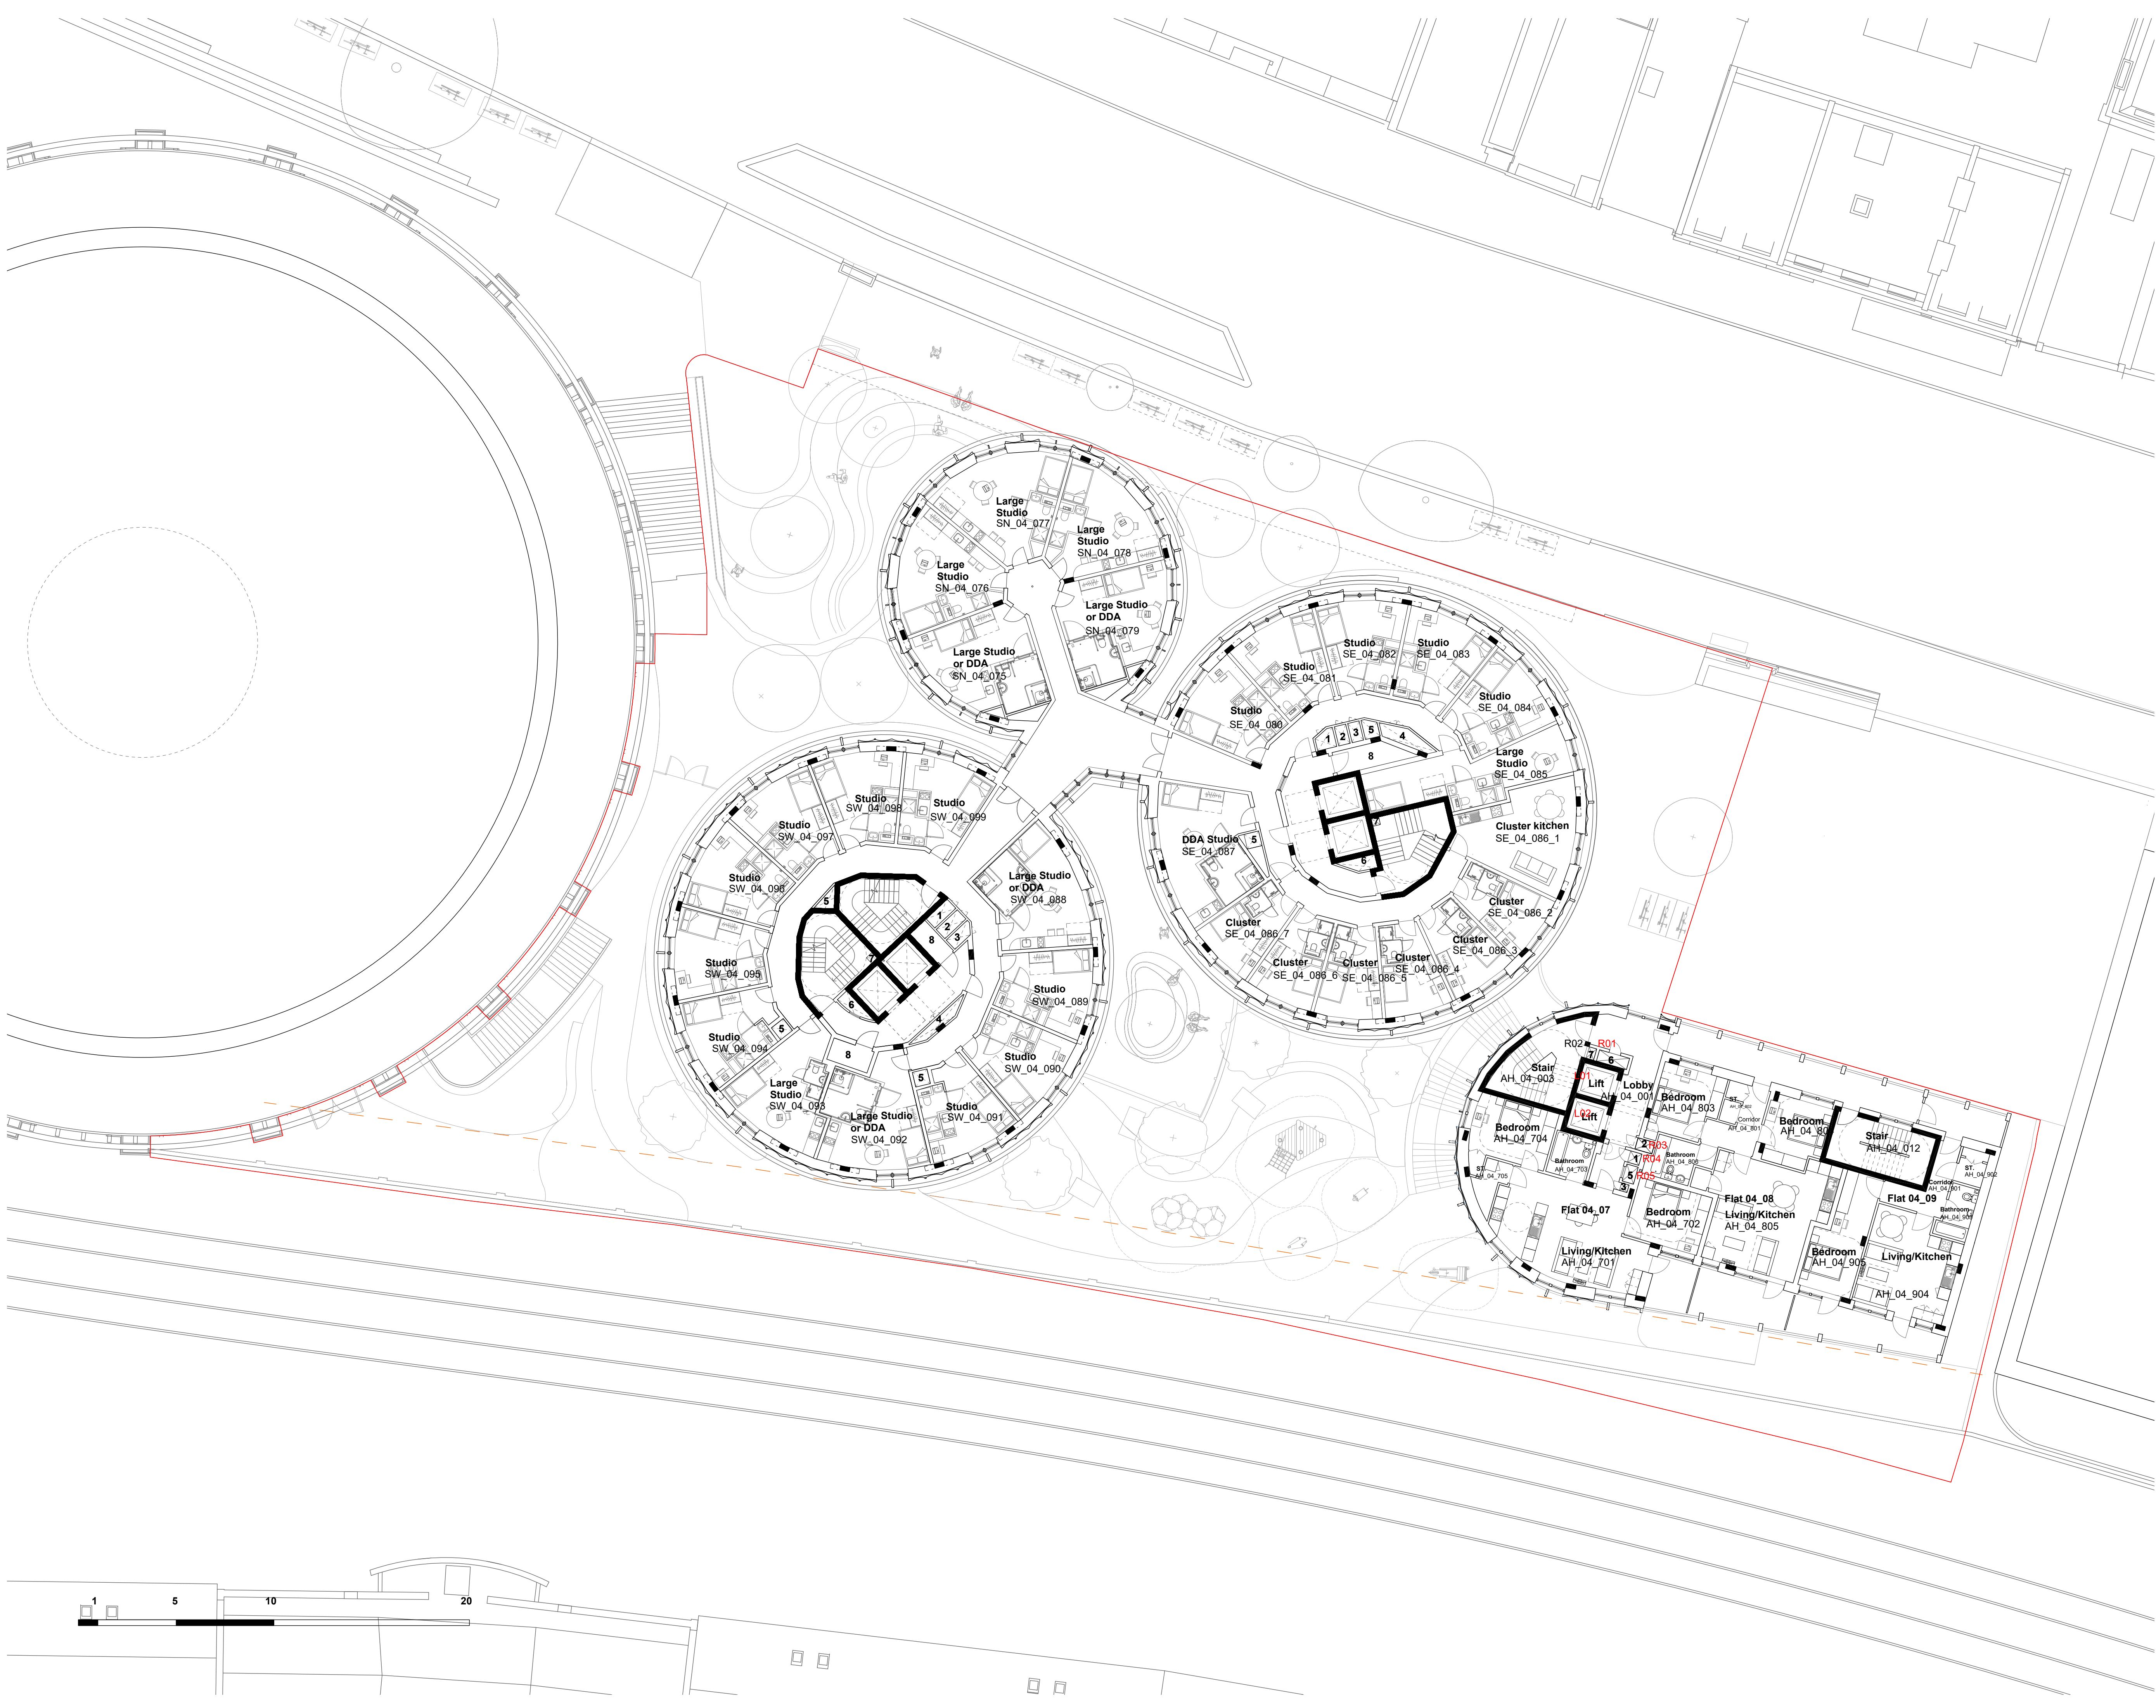

NOTES

1 Heating Riser

2 Water Riser

3 Comms Riser

4 Electrical Riser

5 Smoke Inlet

6 Smoke Inlet

7 Dry Riser

8 MVHR Cupboard

9 Mechanical Ventilation Vent

G_24/01/16 Design Freeze 2

F_24/01/12 Design Freeze 2

E_23/12/19 Coordination

D_23/11/22 Design Freeze


C_23/11/17 Design Freeze

B_23/11/09 Draft Design Freeze

A_23/11/03 Draft Plan

INFORMATION

rev	date	check	comments
DSDHA			
357 Kennington Lane London SE11 5QY			
T 020 7703 3555			
F 020 7703 3890			
E info@dsdha.co.uk			
W www.dsdha.co.uk			
project			
100 Chalk Farm Road			
drawing title			
Level 4-5 Floor Plan			
drawn	size	date	scale
SZ	A1	12/01/24	1 : 150
drawing number			revision
356_P20.104			G
REPORT DISCREPANCIES DO NOT SCALE FROM THIS DRAWING COPYRIGHT DSDHA		USE LATEST REVISION CHECK DIMENSIONS ON SITE	

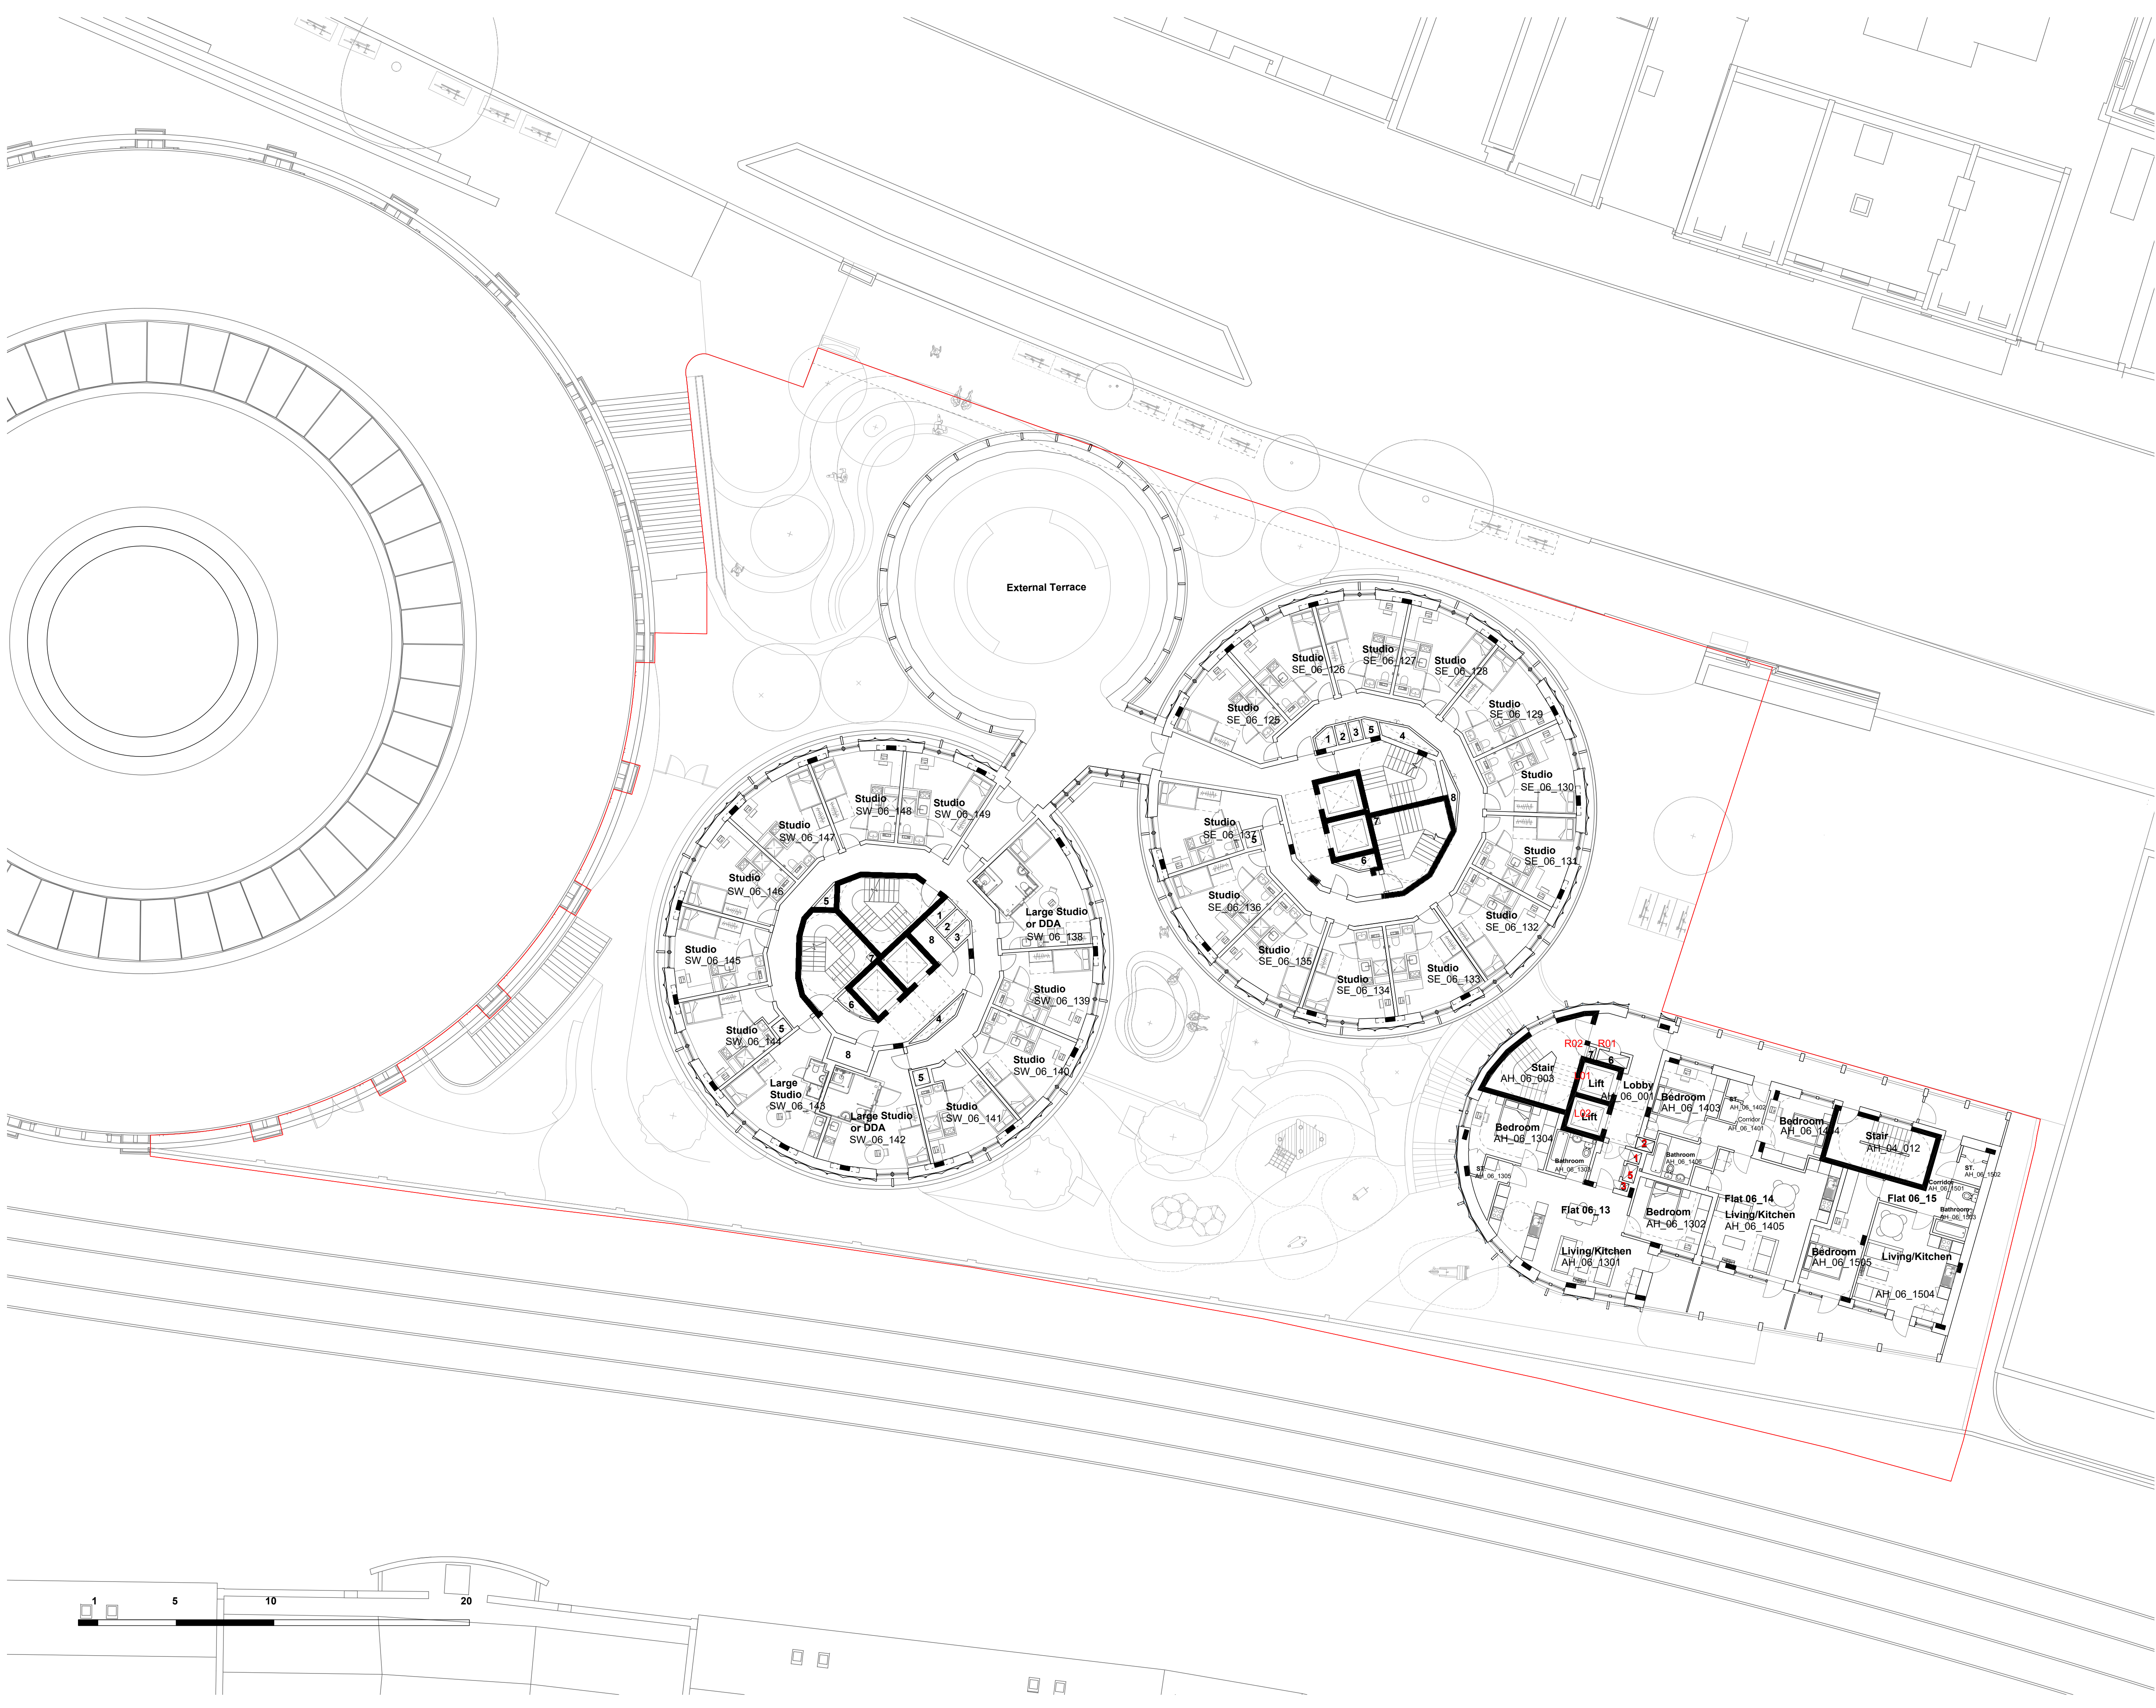

NOTES

1 Heating Riser

2 Water Riser

3 Comms Riser

4 Electrical Riser

5 Smoke Inlet

6 Smoke Inlet

7 Dry Riser

8 MVHR Cupboard

9 Mechanical Ventilation Vent

G_24/01/16 Design Freeze 2

F_24/01/12 Design Freeze 2

E_23/12/19 Coordination

D_23/11/22 Design Freeze


C_23/11/17 Design Freeze

B_23/11/09 Draft Design Freeze

A_23/11/03 Draft Plan

INFORMATION

rev	date	check	comments
DSDHA			
357 Kennington Lane London SE11 5QY			
T 020 7703 3555			
F 020 7703 3890			
E info@dsdha.co.uk			
W www.dsdha.co.uk			
project			
100 Chalk Farm Road			
drawing title			
Level 6 Floor Plan			
drawn	size	date	scale
SZ	A1	12/01/24	1 : 150
drawing number			revision
356_P20.106			G
REPORT DISCREPANCIES DO NOT SCALE FROM THIS DRAWING COPYRIGHT DSDHA		USE LATEST REVISION CHECK DIMENSIONS ON SITE	

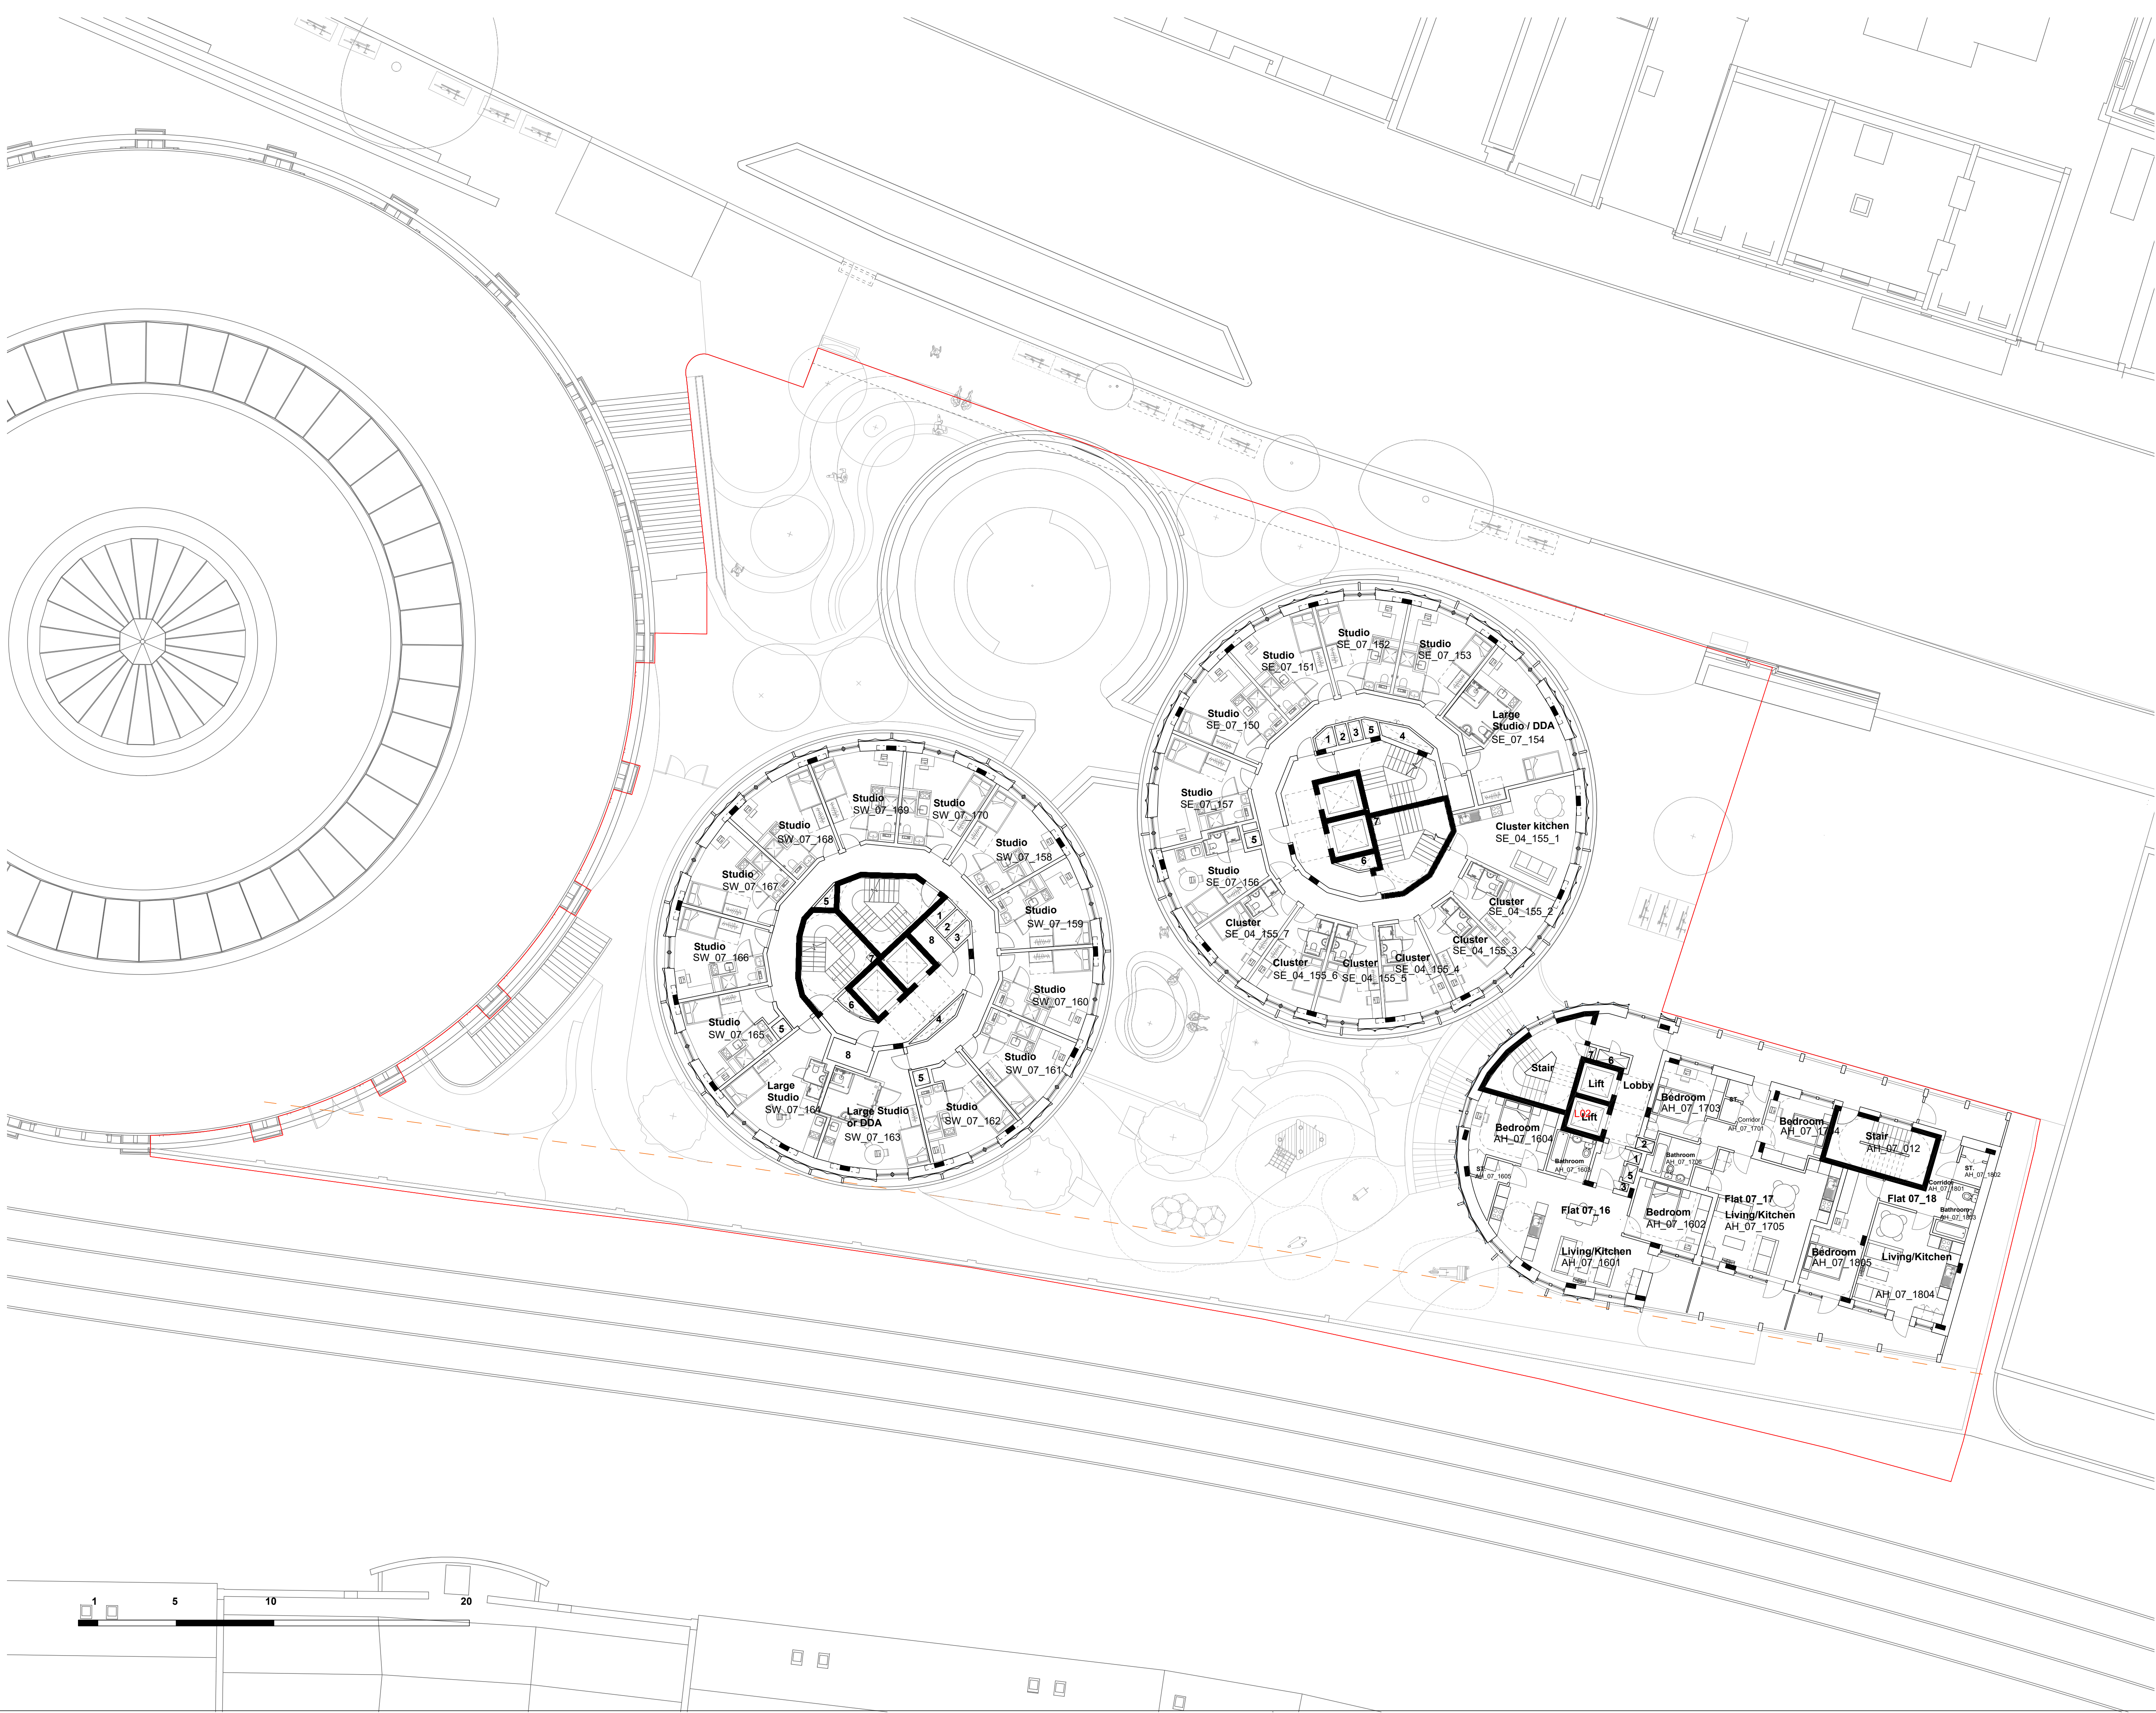


- NOTES
- 1 Heating Riser
 - 2 Water Riser
 - 3 Comms Riser
 - 4 Electrical Riser
 - 5 Smoke Outlet
 - 6 Smoke Inlet
 - 7 Dry Riser
 - 8 MVHR Cupboard
 - 9 Mechanical Ventilation Vent

G_24/01/16 Design Freeze 2
F_24/01/12 Design Freeze 2
E_23/12/19 Coordination
D_23/11/22 Design Freeze
C_23/11/17 Design Freeze
B_23/11/09 Draft Design Freeze
A_23/11/03 Draft Plan

INFORMATION

rev	date	check	comments
DSDHA 357 Kennington Lane London SE11 5QY T 020 7703 3555 F 020 7703 3890 E info@dsdha.co.uk W www.dsdha.co.uk			
project			
100 Chalk Farm Road			
drawing title			
Level 7 - 8 Floor Plan			
drawn	size	date	scale
SZ	A1	12/01/24	1 : 150
drawing number			revision
356_P20.107			G
REPORT DISCREPANCIES DO NOT SCALE FROM THIS DRAWING COPYRIGHT DSDHA		USE LATEST REVISION CHECK DIMENSIONS ON SITE	

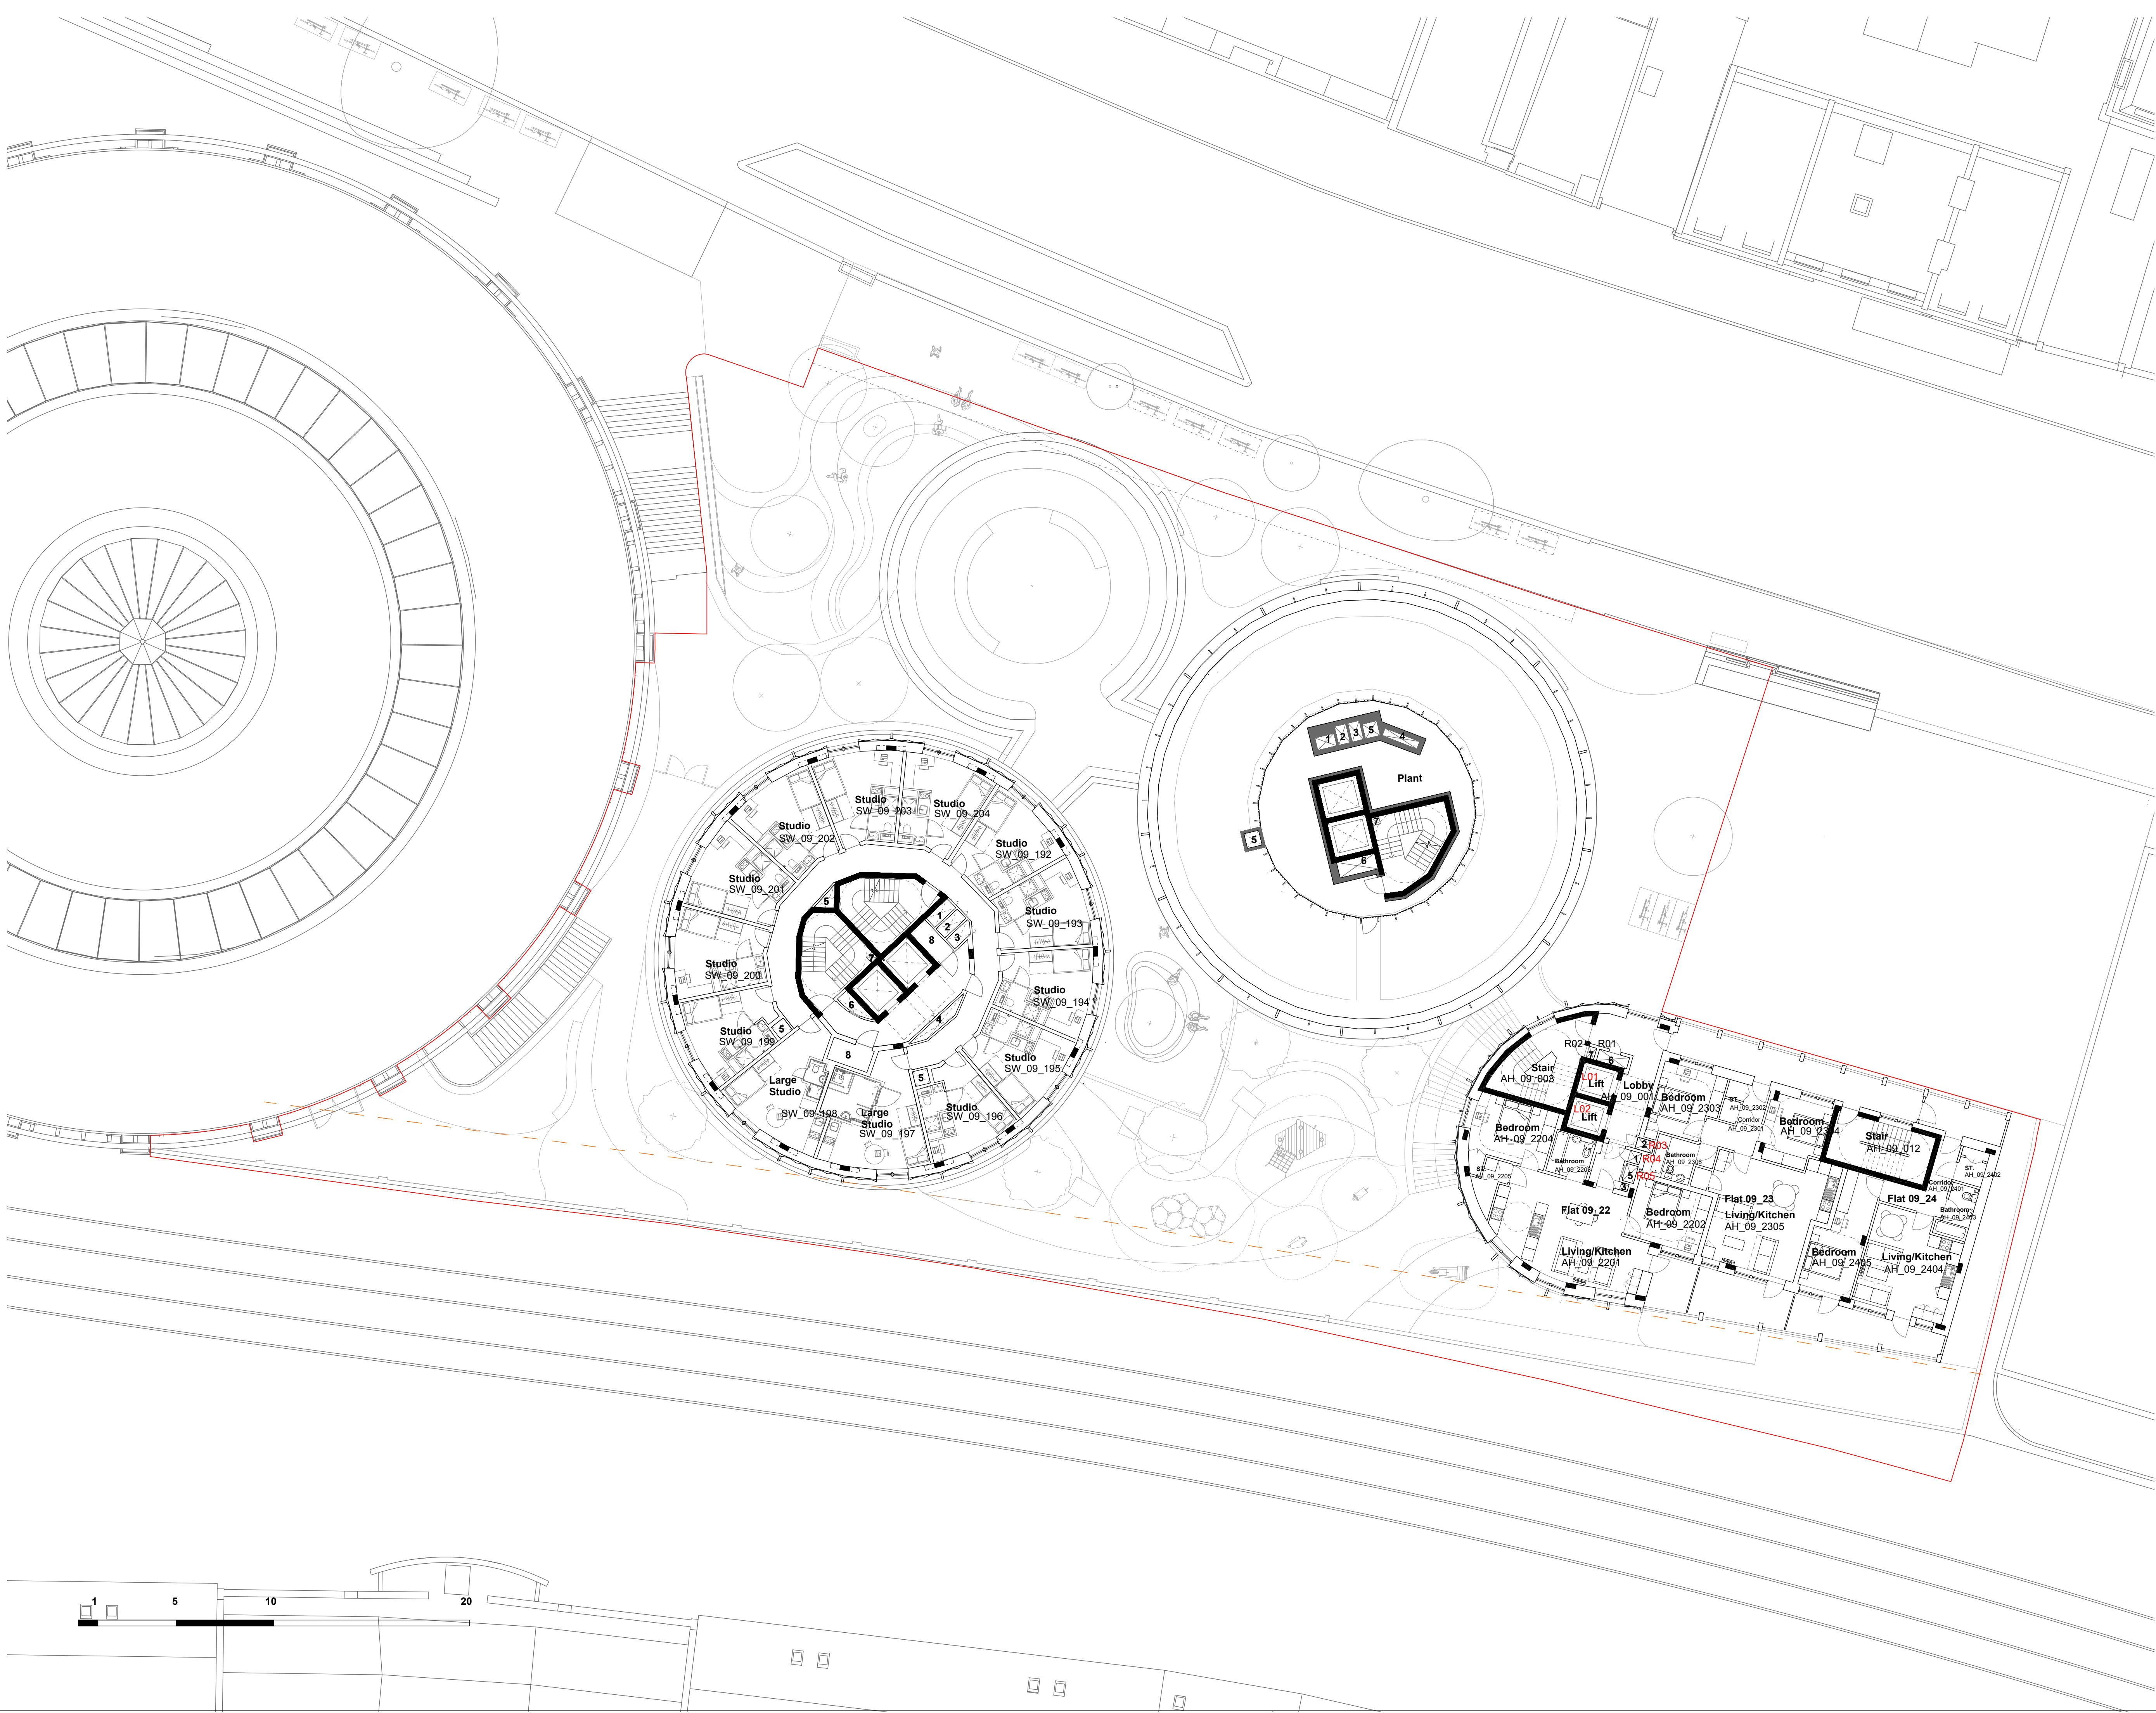


- NOTES
- 1 Heating Riser
 - 2 Water Riser
 - 3 Comms Riser
 - 4 Electrical Riser
 - 5 Smoke Inlet
 - 6 Smoke Inlet
 - 7 Dry Riser
 - 8 MVHR Cupboard
 - 9 Mechanical Ventilation Vent

G_24/01/16 Design Freeze 2
F_24/01/12 Design Freeze 2
E_23/12/19 Coordination
D_23/11/22 Design Freeze
C_23/11/17 Design Freeze
B_23/11/09 Draft Design Freeze
A_23/11/03 Draft Plan

INFORMATION

rev	date	check	comments
DSDHA 357 Kennington Lane London SE11 5QY T 020 7703 3555 F 020 7703 3890 E info@dsdha.co.uk W www.dsdha.co.uk			
project			
100 Chalk Farm Road			
drawing title			
Level 9 Floor Plan			
drawn	size	date	scale
SZ	A1	12/01/24	1 : 150
drawing number			revision
356_P20.109			G
REPORT DISCREPANCIES DO NOT SCALE FROM THIS DRAWING COPYRIGHT DSDHA		USE LATEST REVISION CHECK DIMENSIONS ON SITE	

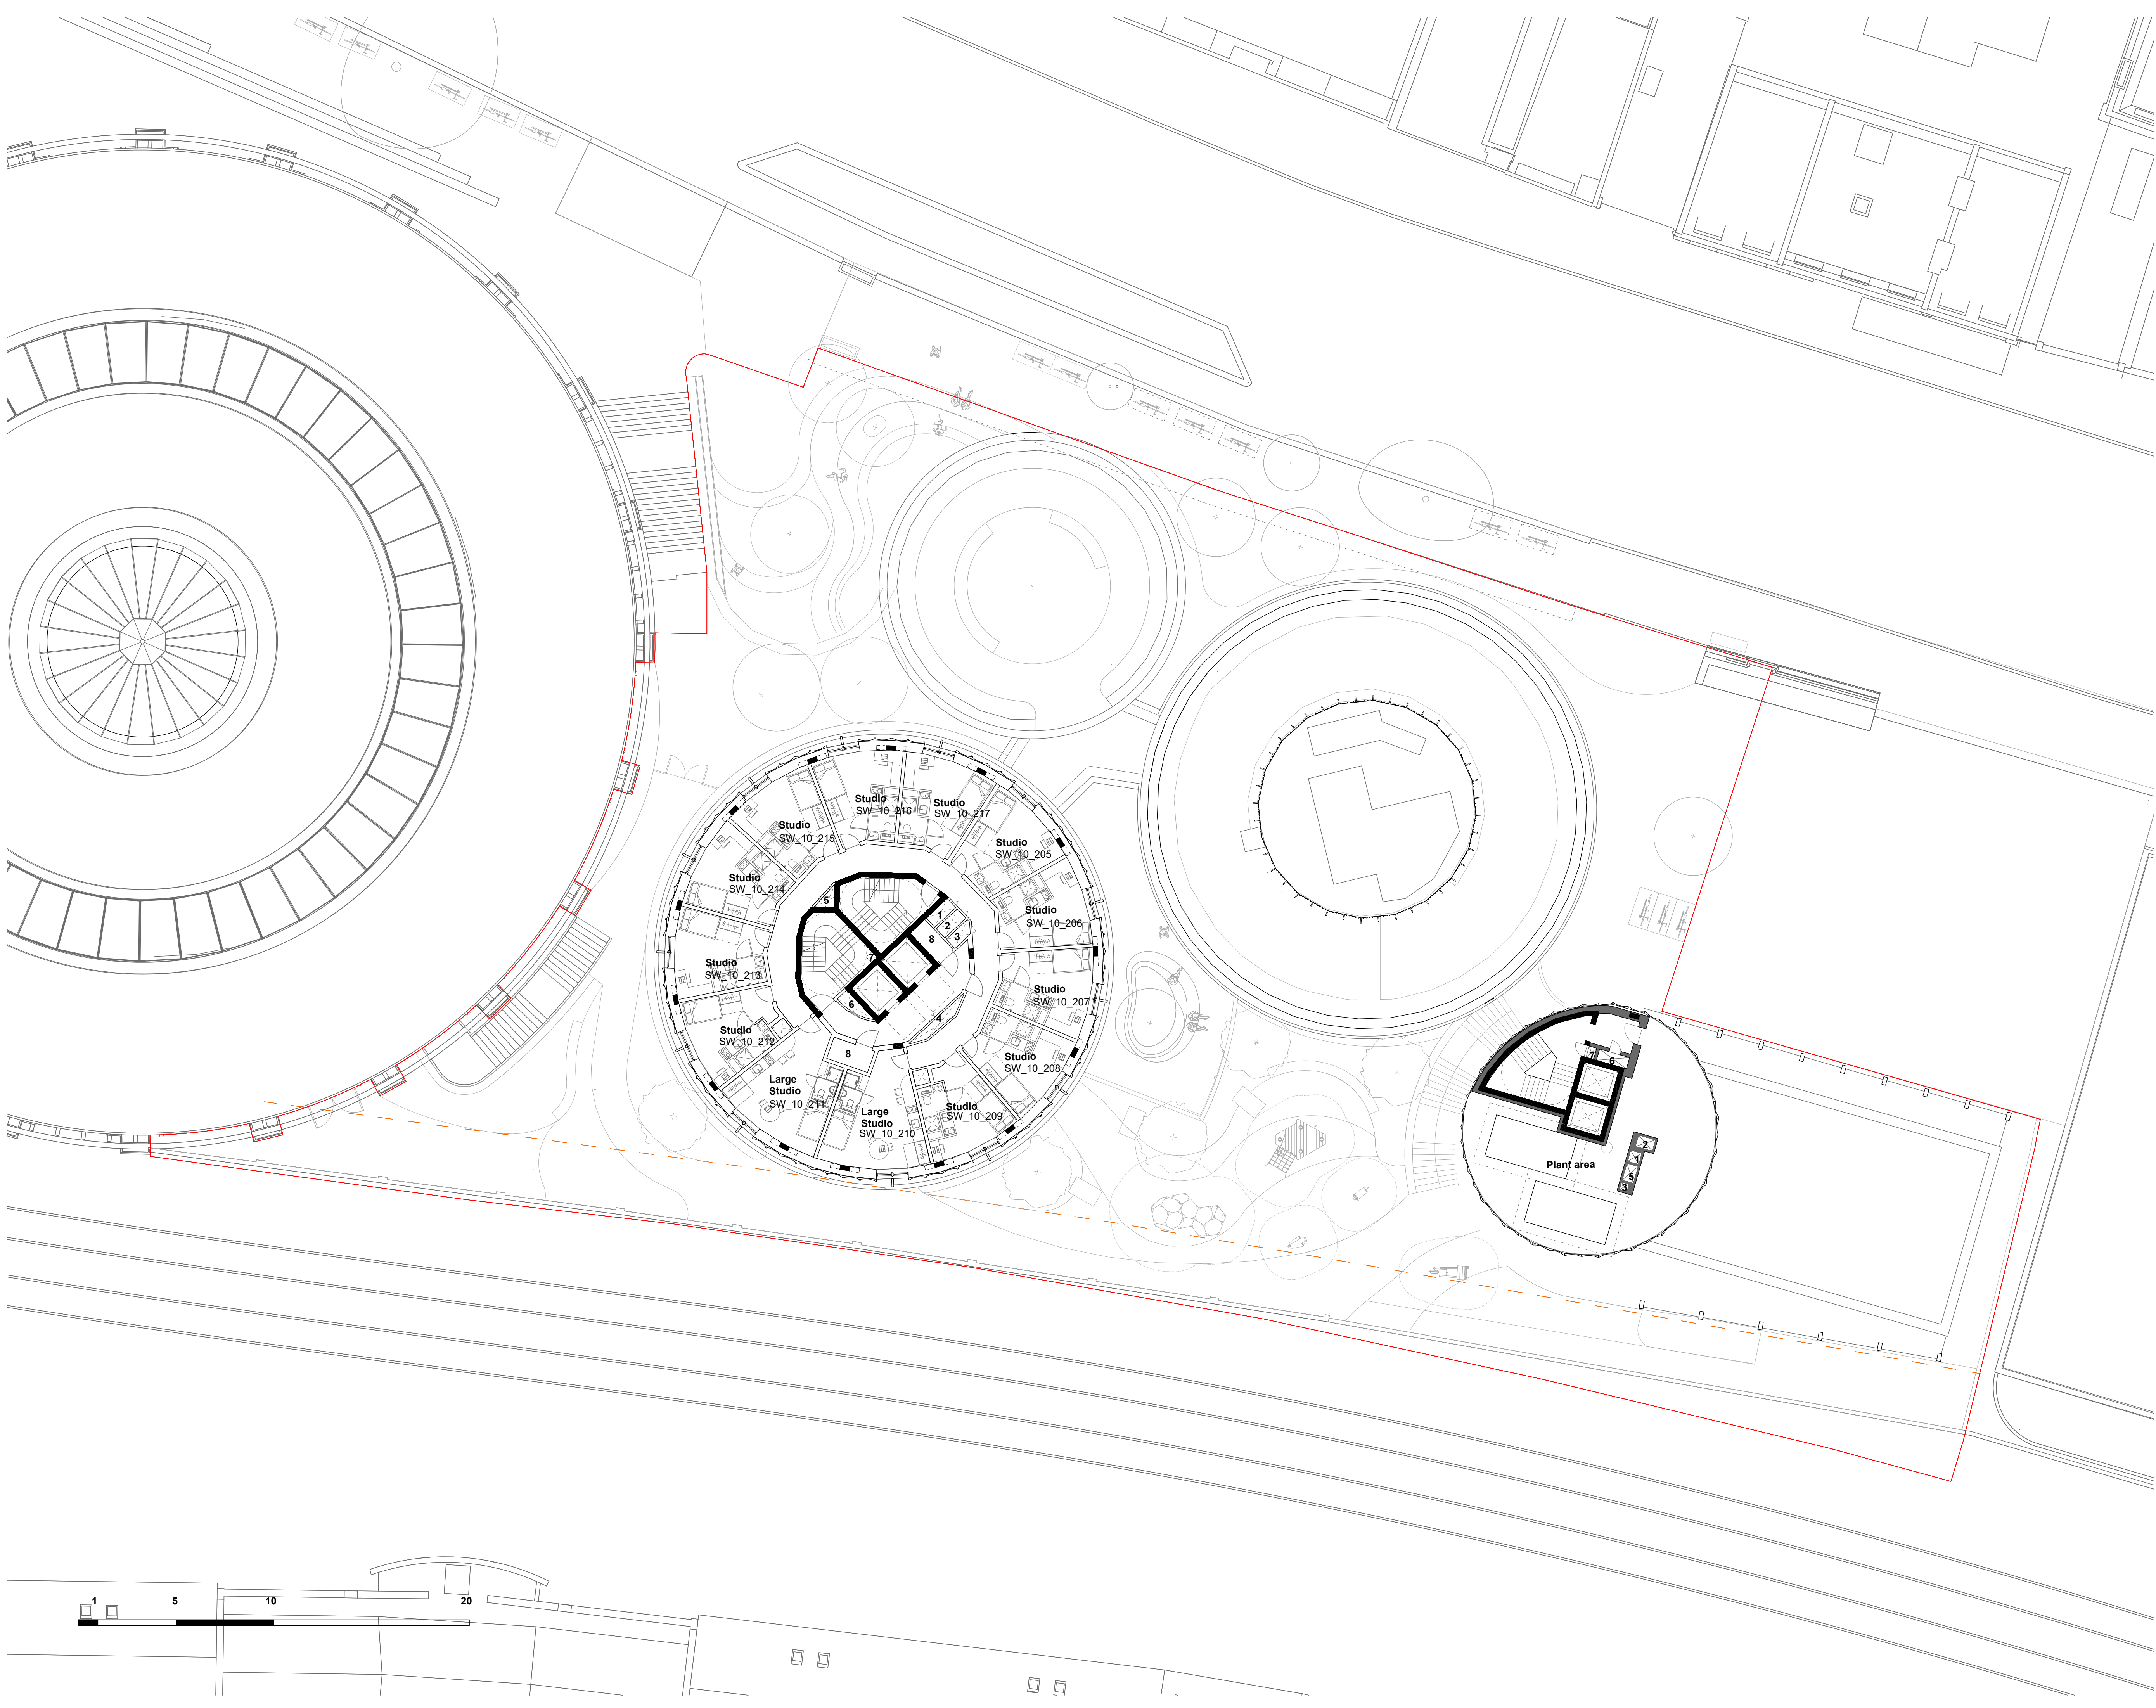

NOTES

1 Heating Riser

2 Water Riser

3 Comms Riser

4 Electrical Riser

5 Smoke Outlet

6 Smoke Inlet

7 Dry Riser

8 MVHR Cupboard

9 Mechanical Ventilation Vent

G_24/01/16 Design Freeze 2

F_24/01/12 Design Freeze 2

E_23/12/19 Coordination

D_23/11/22 Design Freeze


C_23/11/17 Design Freeze

B_23/11/09 Draft Design Freeze

A_23/11/03 Draft Plan

INFORMATION

rev	date	check	comments
DSDHA			
357 Kennington Lane London SE11 5QY			
T 020 7703 3555			
F 020 7703 3890			
E info@dsdha.co.uk			
W www.dsdha.co.uk			
project			
100 Chalk Farm Road			
drawing title			
Level 10 - 11 Floor Plan			
drawn	size	date	scale
SZ	A1	12/01/24	1 : 150
drawing number			revision
356_P20.110			G
REPORT DISCREPANCIES DO NOT SCALE FROM THIS DRAWING COPYRIGHT DSDHA		USE LATEST REVISION CHECK DIMENSIONS ON SITE	

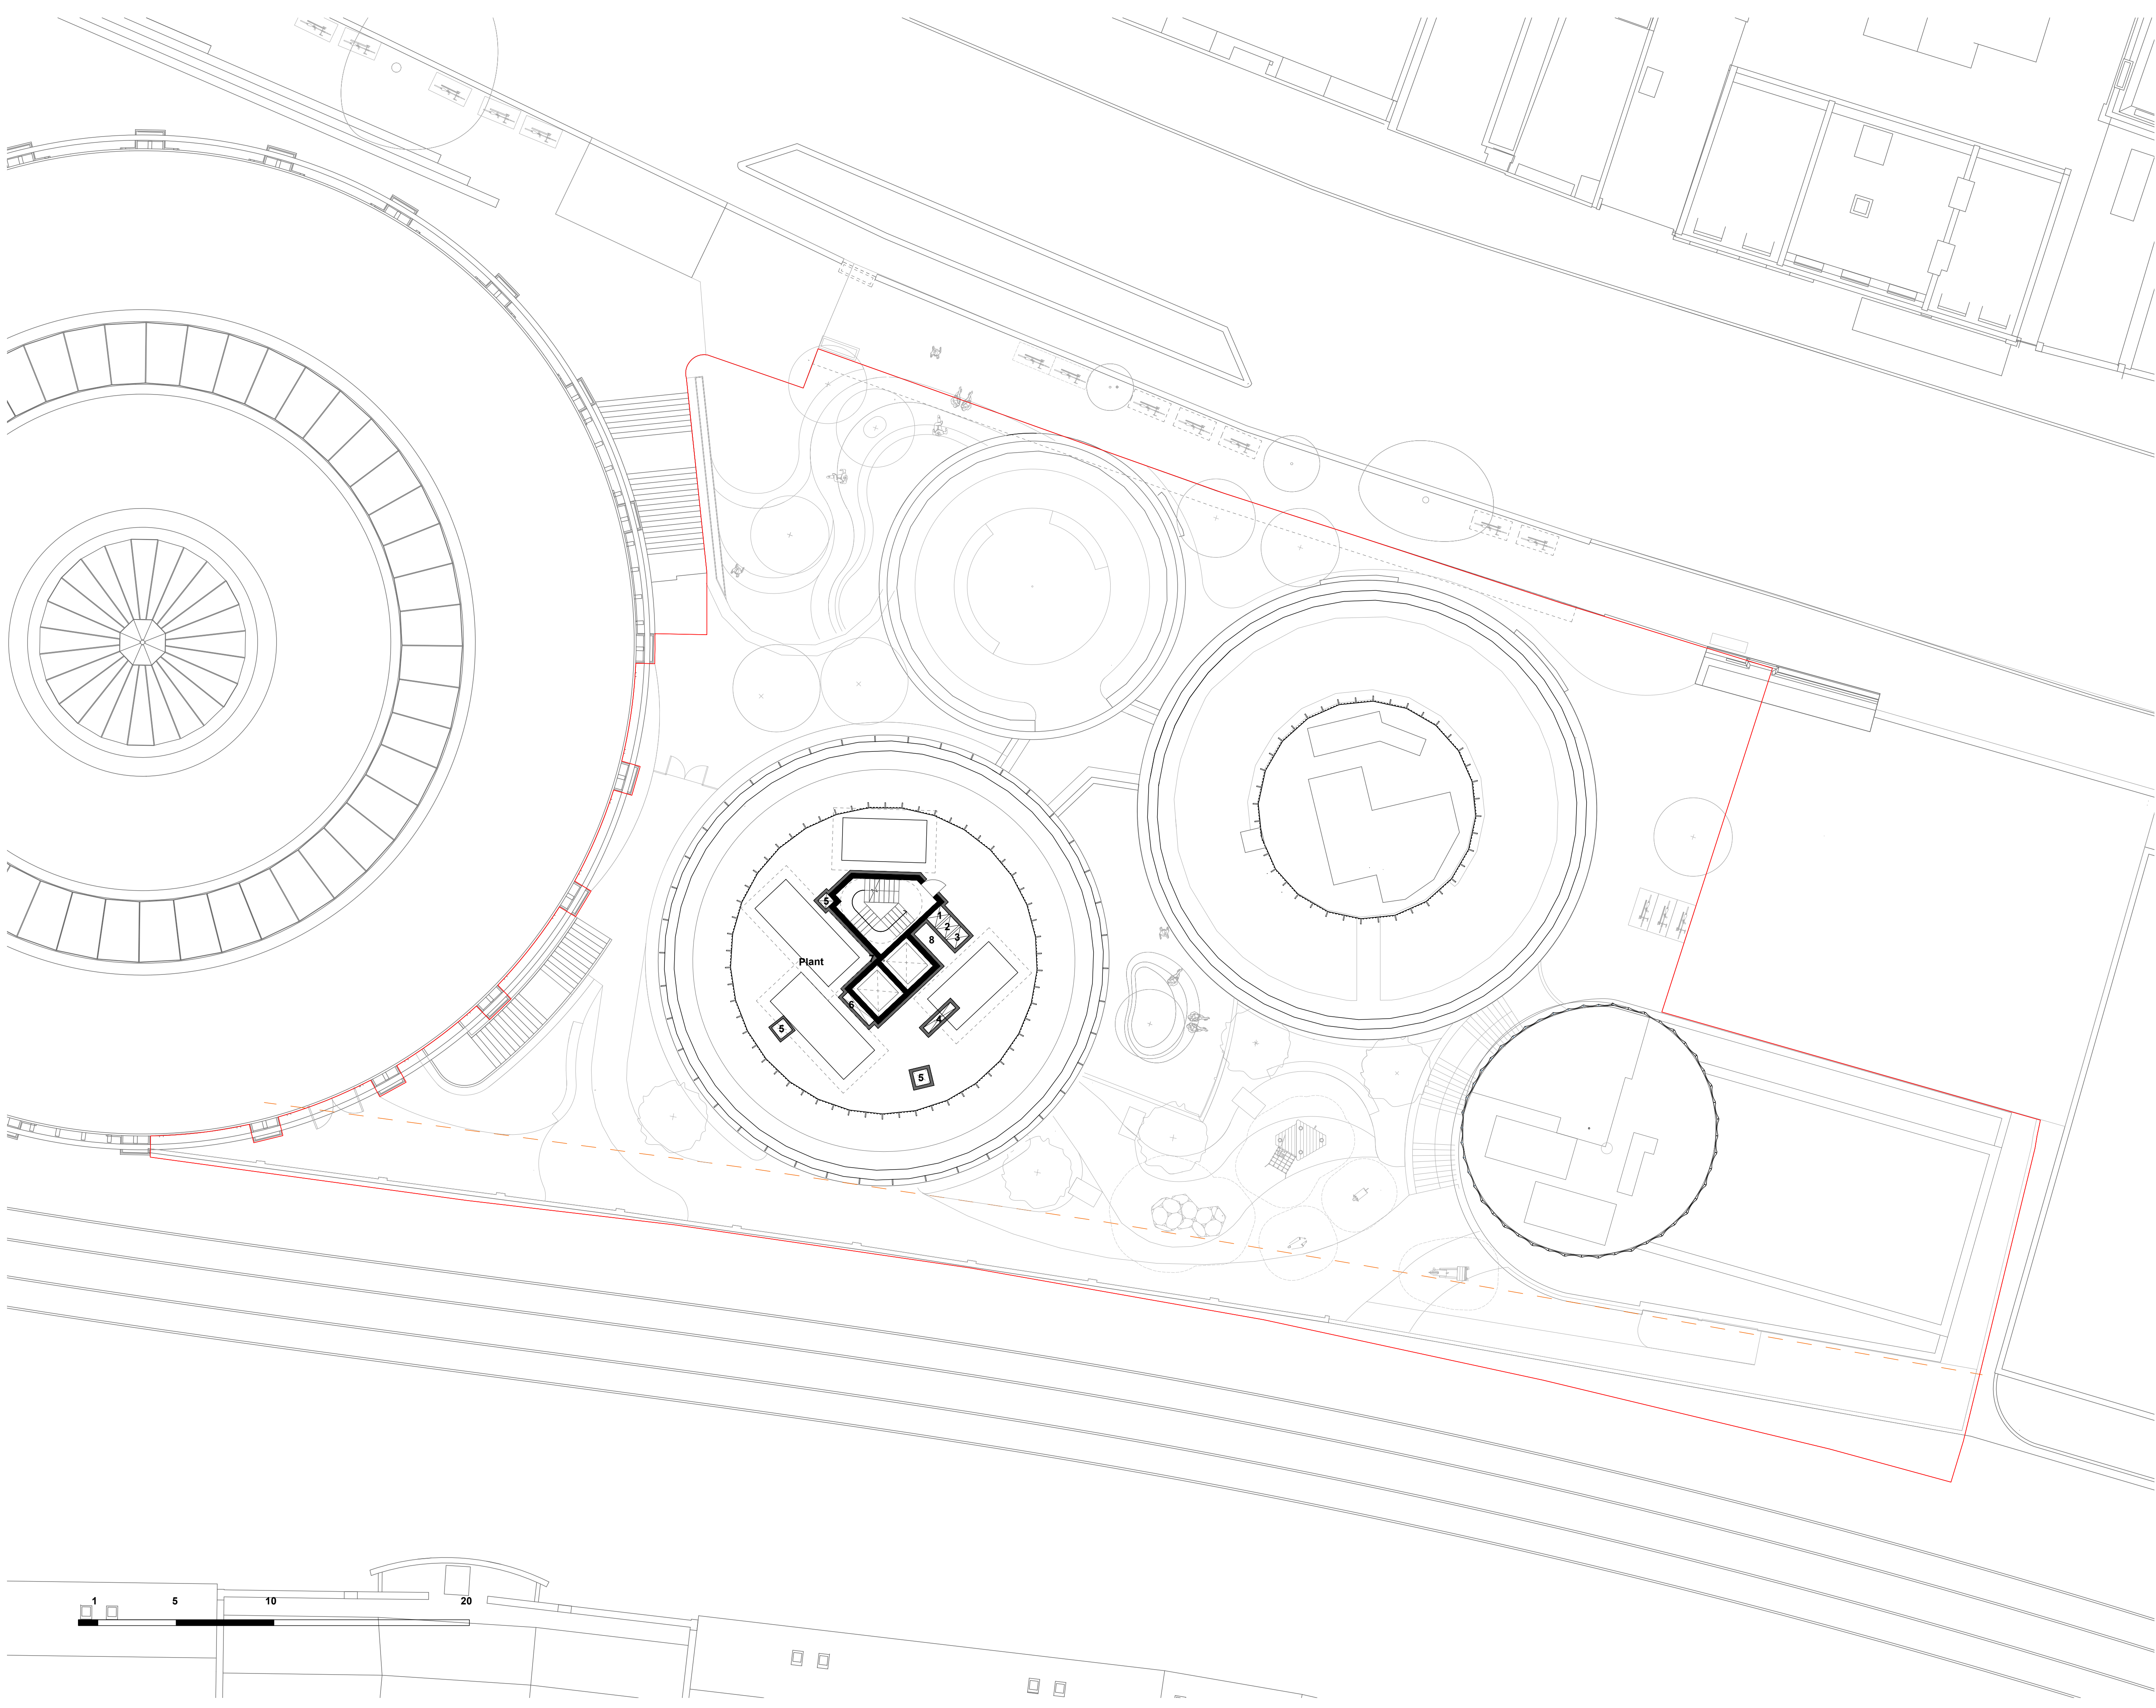


- NOTES
- 1 Heating Riser
 - 2 Water Riser
 - 3 Comms Riser
 - 4 Electrical Riser
 - 5 Smoke Outlet
 - 6 Smoke Inlet
 - 7 Dry Riser
 - 8 MVHR Cupboard
 - 9 Mechanical Ventilation Vent

- G_24/01/16 Design Freeze 2
- F_24/01/12 Design Freeze 2
- E_23/12/19 Coordination
- D_23/11/22 Design Freeze
- C_23/11/17 Design Freeze
- B_23/11/09 Draft Design Freeze
- A_23/11/03 Draft Plan

INFORMATION

rev	date	check	comments
DSDHA 357 Kennington Lane London SE11 5QY T 020 7703 3555 F 020 7703 3890 E info@dsdha.co.uk W www.dsdha.co.uk			
project			
100 Chalk Farm Road			
drawing title			
Level 12 Floor Plan			
drawn	size	date	scale
SZ	A1	12/01/24	1 : 150
drawing number			revision
356_P20.112			G
REPORT DISCREPANCIES DO NOT SCALE FROM THIS DRAWING COPYRIGHT DSDHA		USE LATEST REVISION CHECK DIMENSIONS ON SITE	

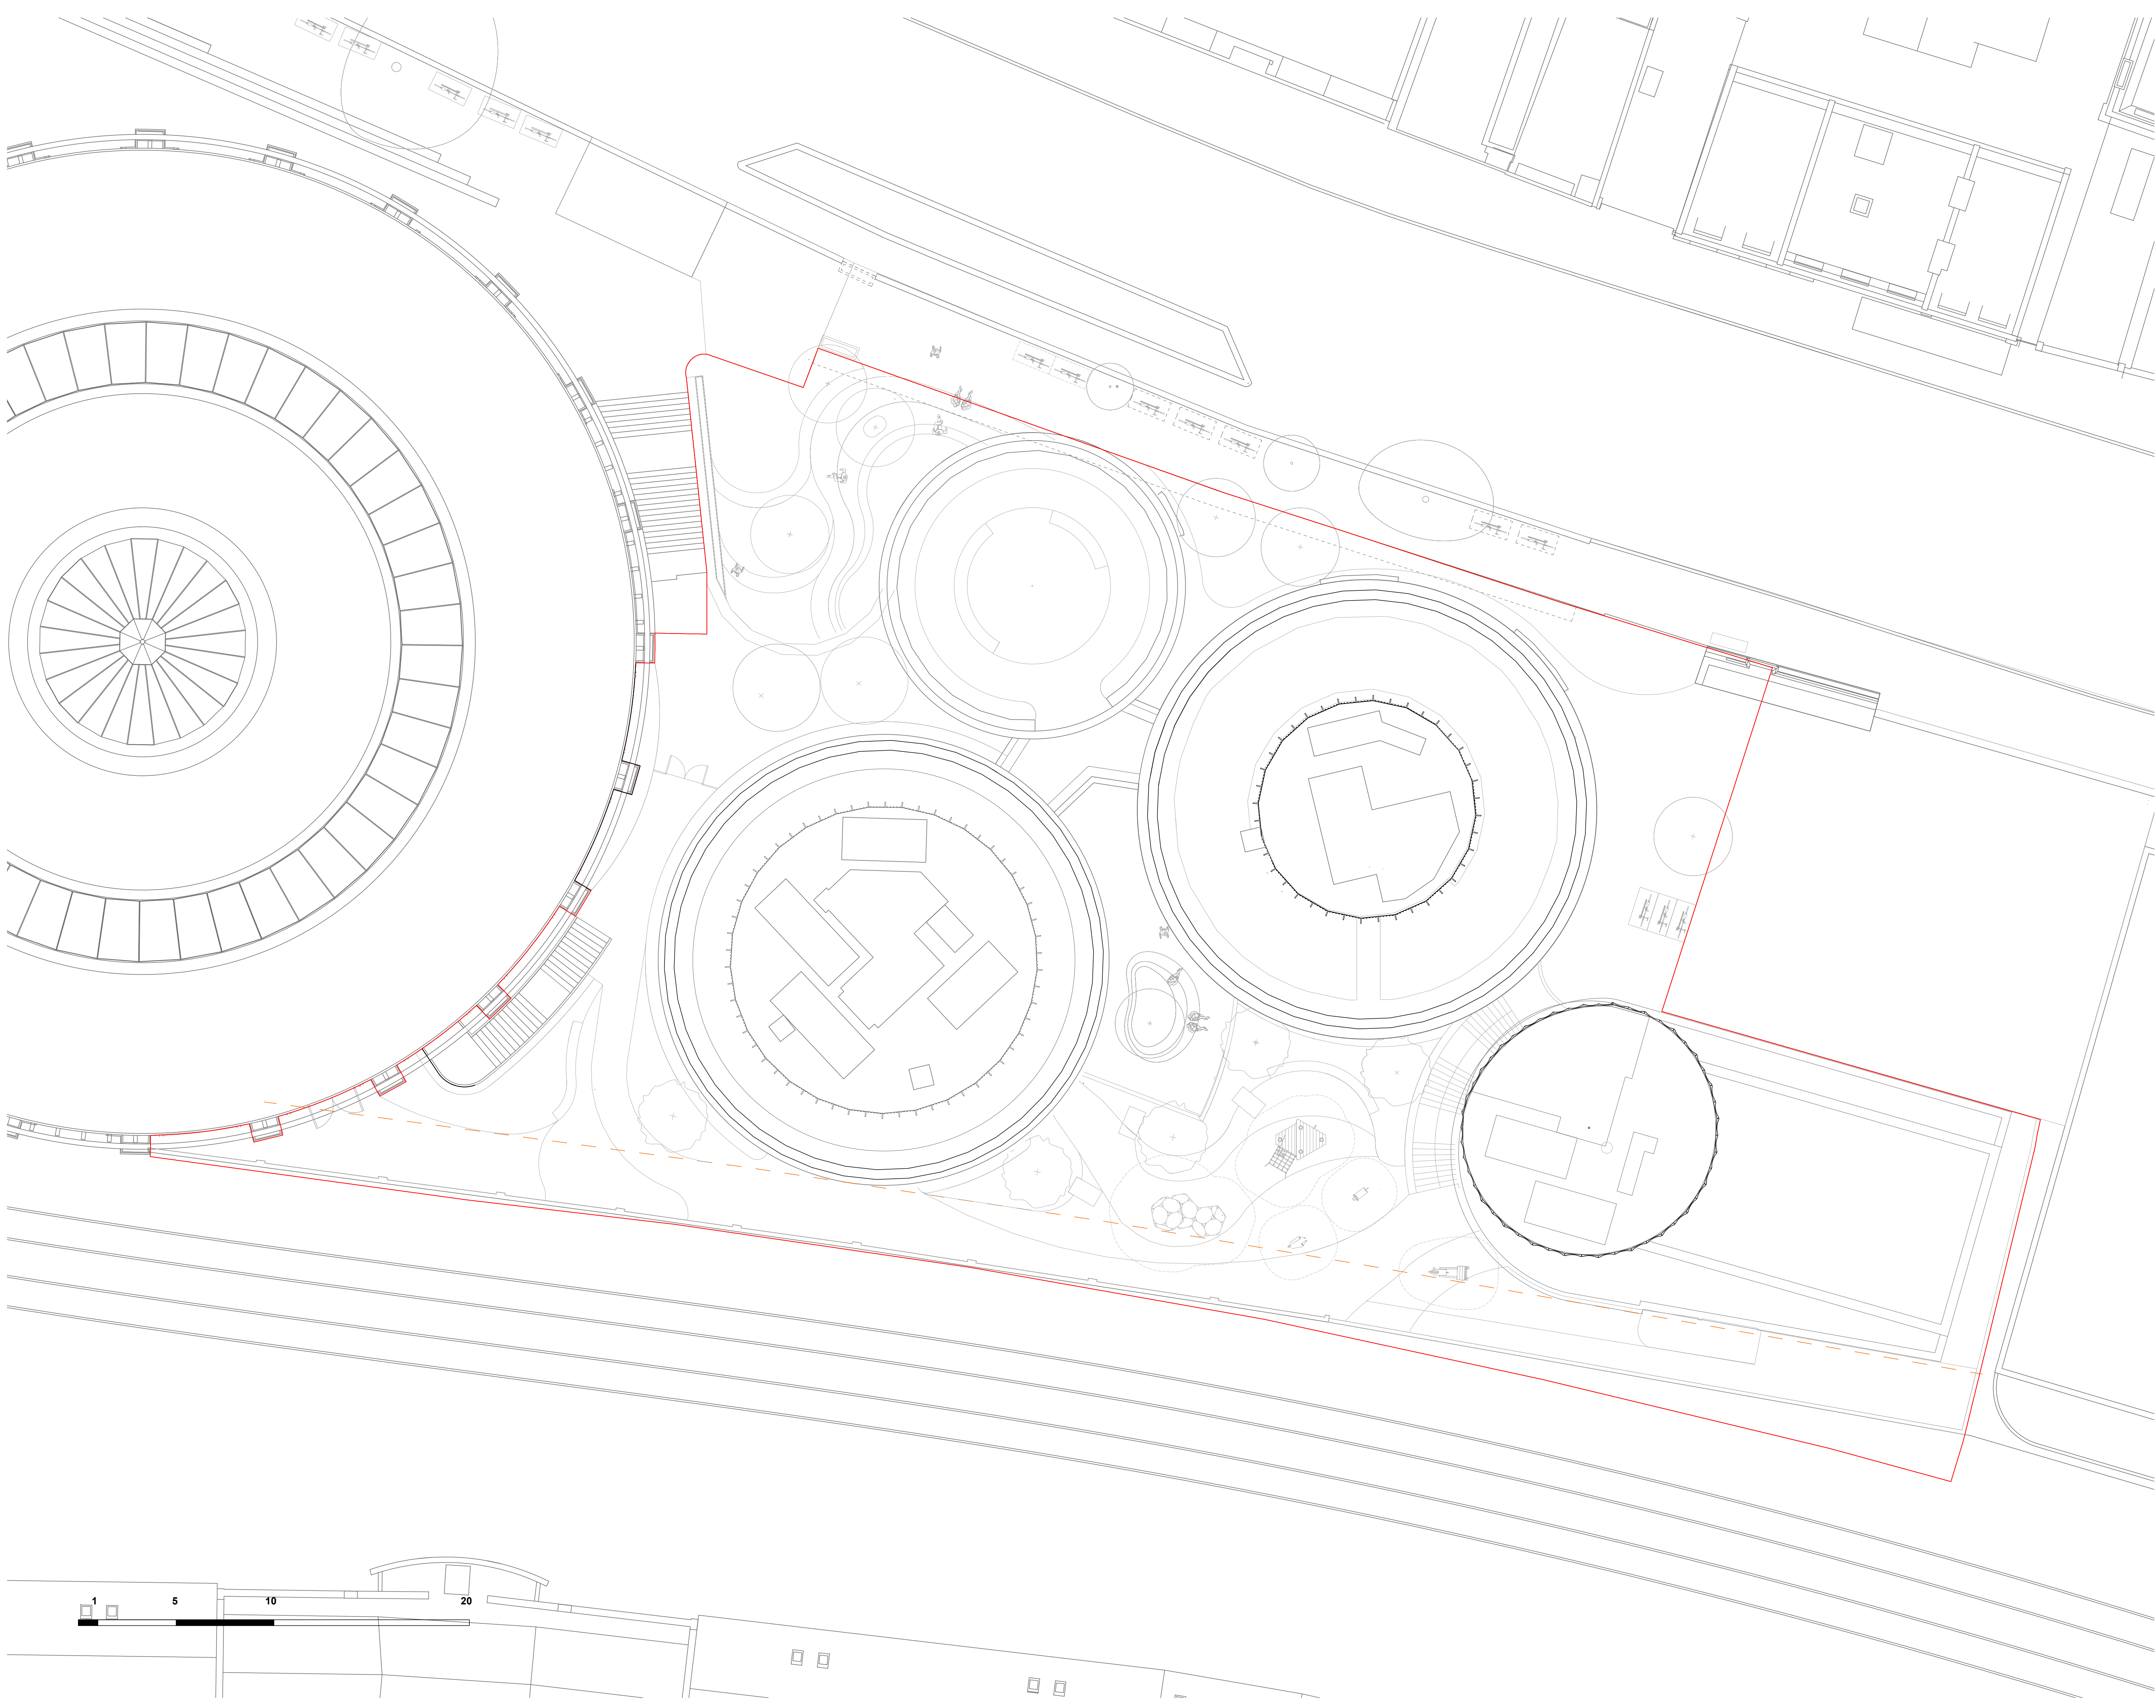

NOTES

1 Heating Riser

2 Water Riser

3 Comms Riser

4 Electrical Riser

5 Smoke Outlet

6 Smoke Inlet

7 Dry Riser

8 MVHR Cupboard

9 Mechanical Ventilation Vent

G_24/01/16 Design Freeze 2

F_24/01/12 Design Freeze 2

E_23/12/19 Coordination

D_23/11/22 Design Freeze


C_23/11/17 Design Freeze

B_23/11/09 Draft Design Freeze



A_23/11/03 Draft Plan

INFORMATION

rev	date	check	comments
DSDHA 357 Kennington Lane London SE11 5QY T 020 7703 3555 F 020 7703 3890 E info@dsdha.co.uk W www.dsdha.co.uk			
project			
100 Chalk Farm Road			
drawing title			
Roof Plan			
drawn	size	date	scale
SZ	A1	12/01/24	1 : 150
drawing number			revision
356_P20.113			G
REPORT DISCREPANCIES DO NOT SCALE FROM THIS DRAWING COPYRIGHT DSDHA		USE LATEST REVISION CHECK DIMENSIONS ON SITE	

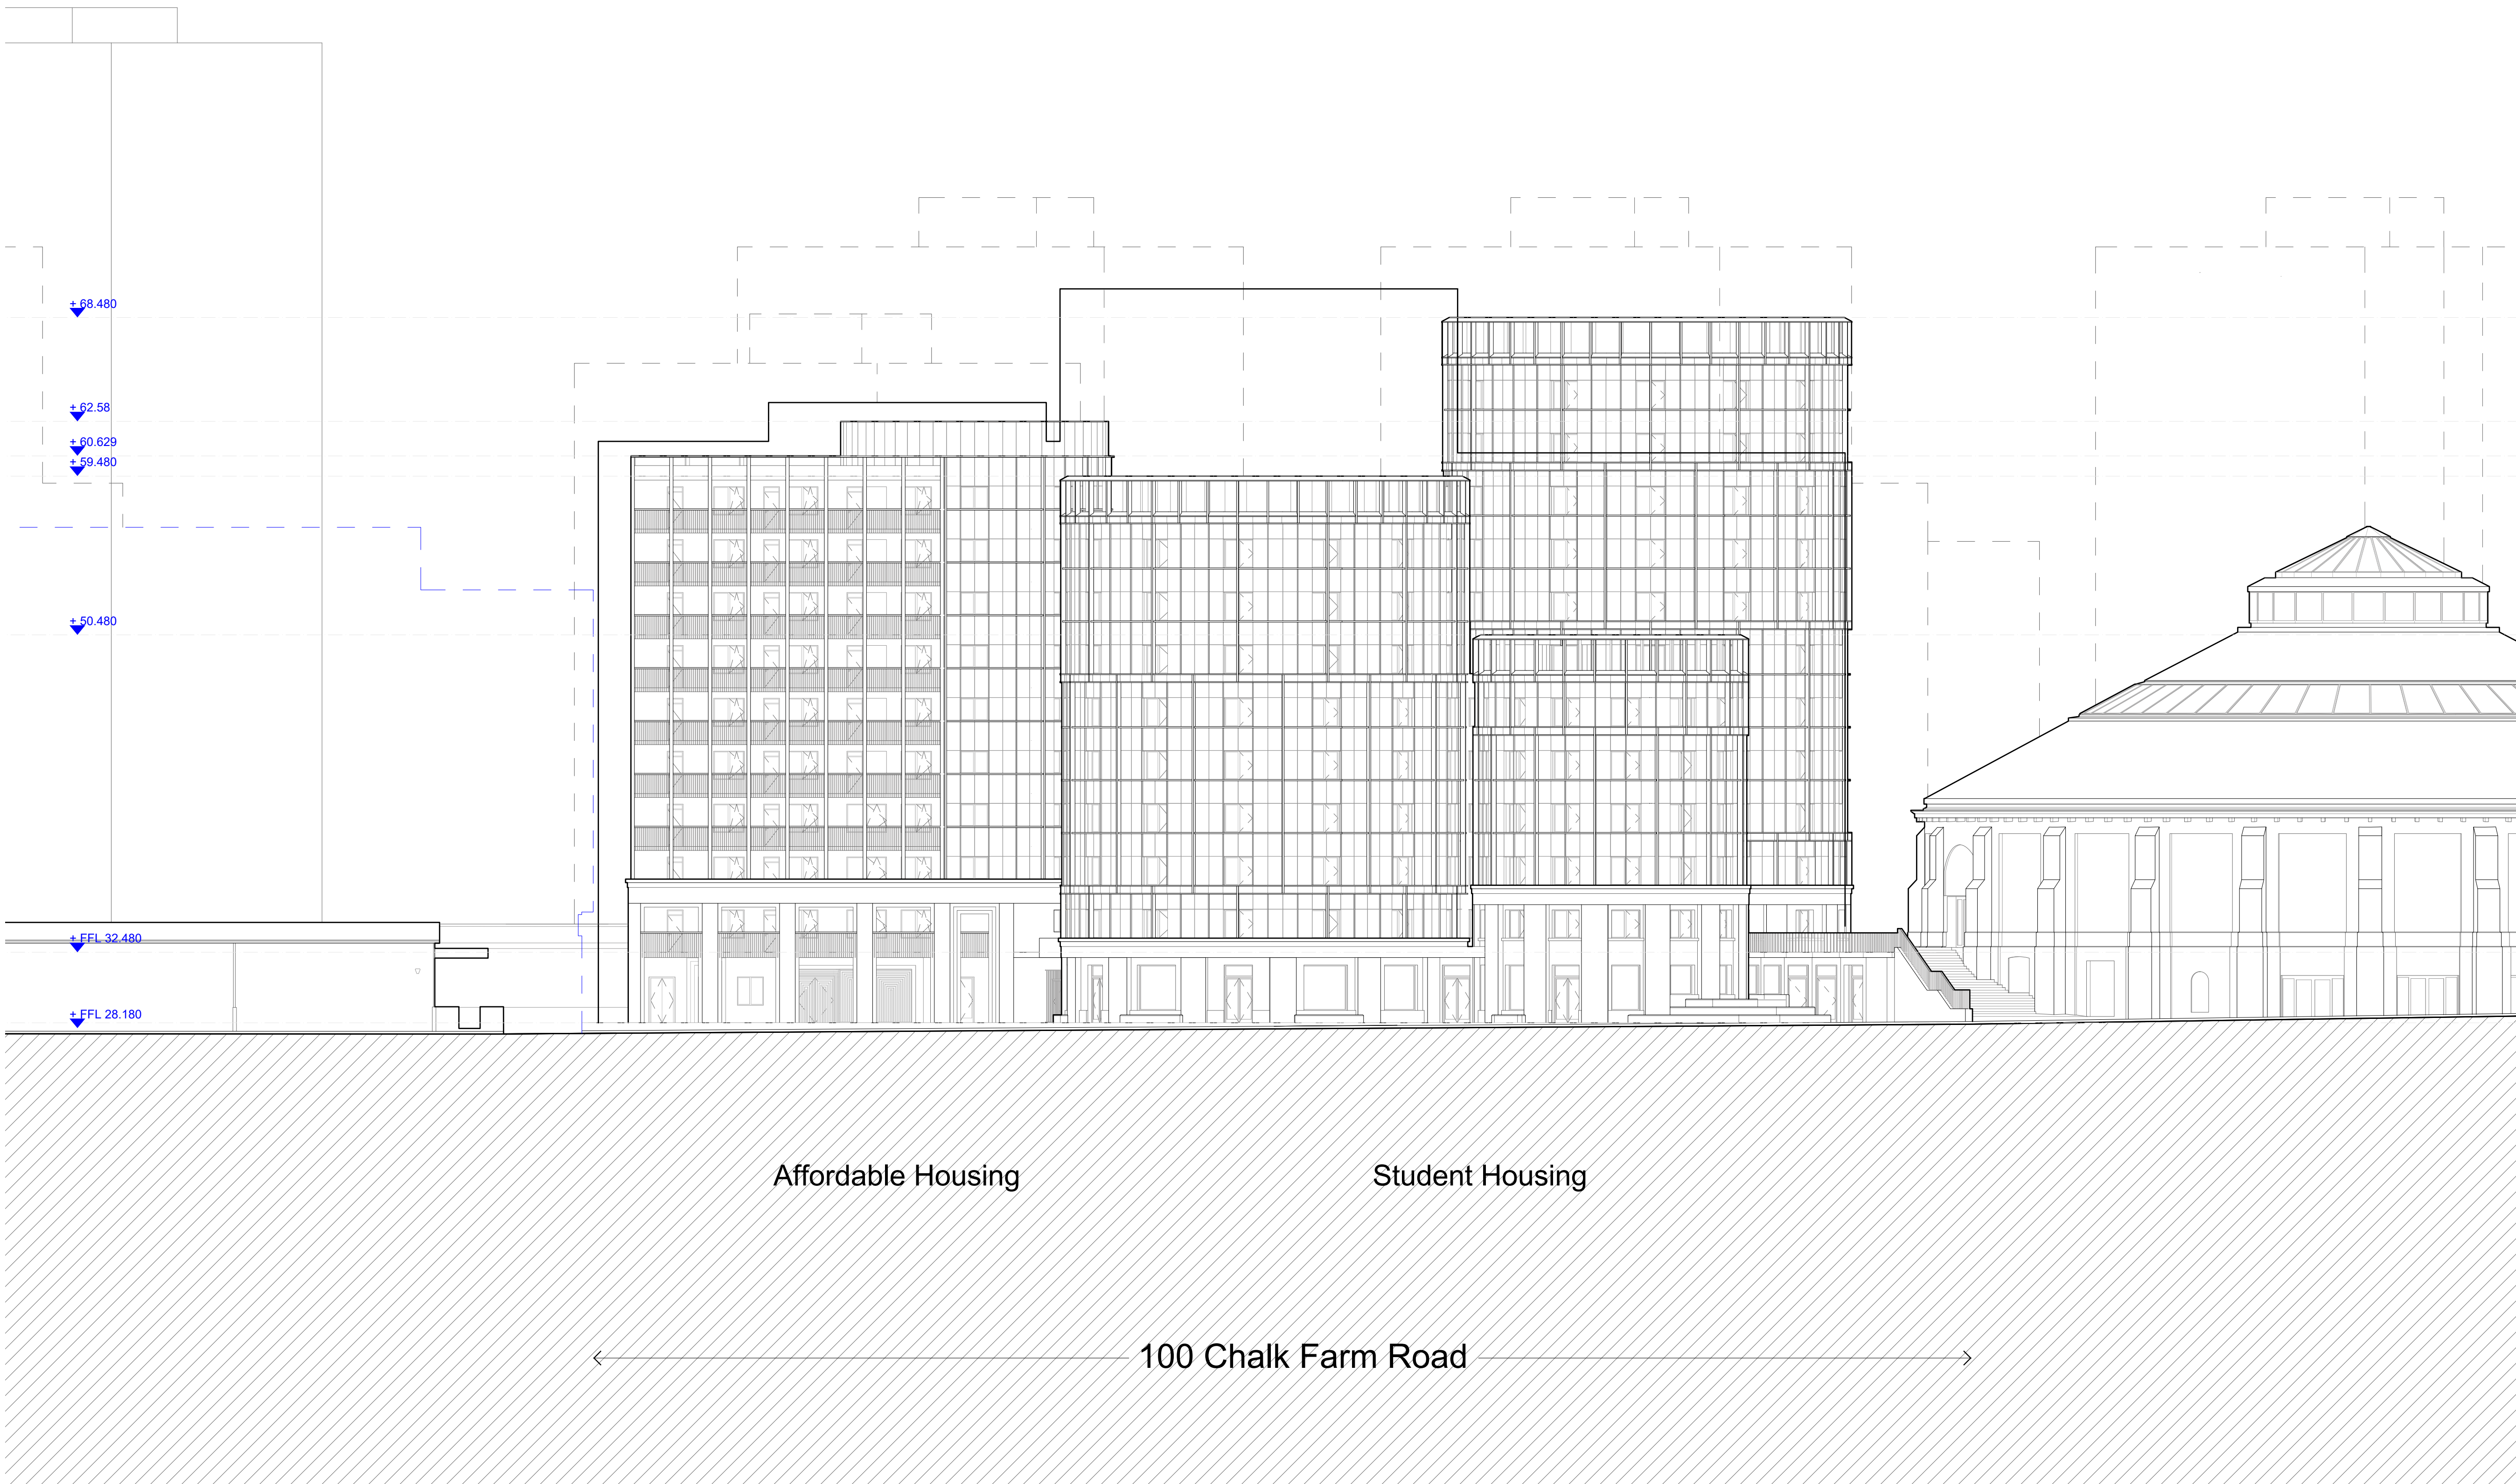


Proposed North Elevation

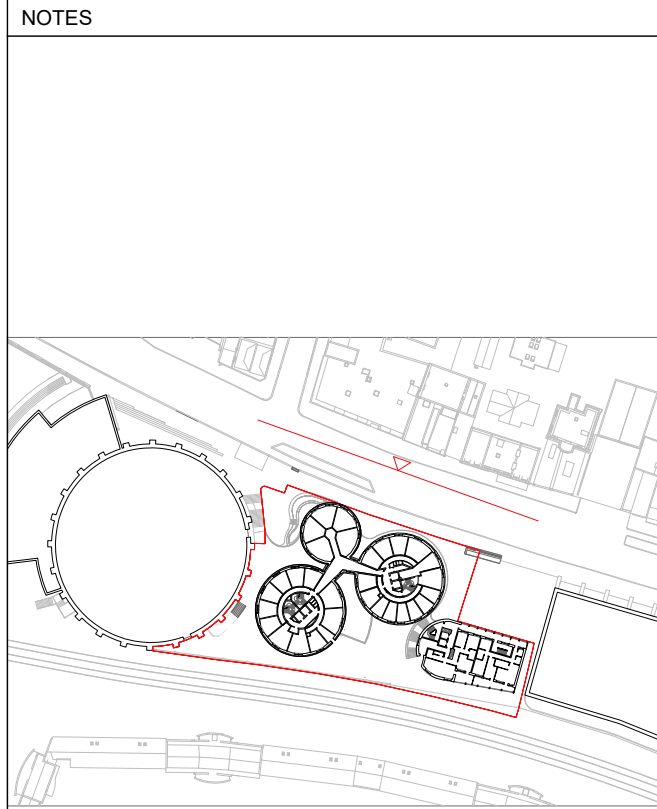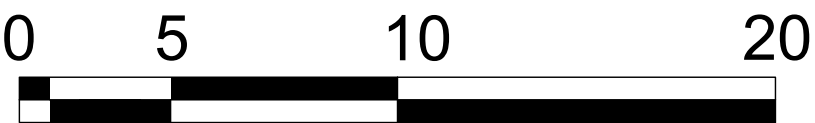



- G_24/01/16 Design Freeze 2
F_24/01/12 Design Freeze 2
D_23/11/22 Design Freeze
C_23/11/17 Design Freeze
B_23/11/09 Draft Design Freeze
A_23/11/03 Draft

INFORMATION

rev	date	check	comments
DSDHA 357 Kennington Lane London SE11 5QY T 020 7703 3555 F 020 7703 3890 E info@dsdha.co.uk W www.dsdha.co.uk			
project			
100 Chalk Farm Road			
drawing title			
Proposed North Elevation			
drawn	size	date	scale
FI	A1	24/01/12	Varies
drawing number			revision
356_P30.120			G
REPORT DISCREPANCIES DO NOT SCALE FROM THIS DRAWING COPYRIGHT DSDHA		USE LATEST REVISION CHECK DIMENSIONS ON SITE	

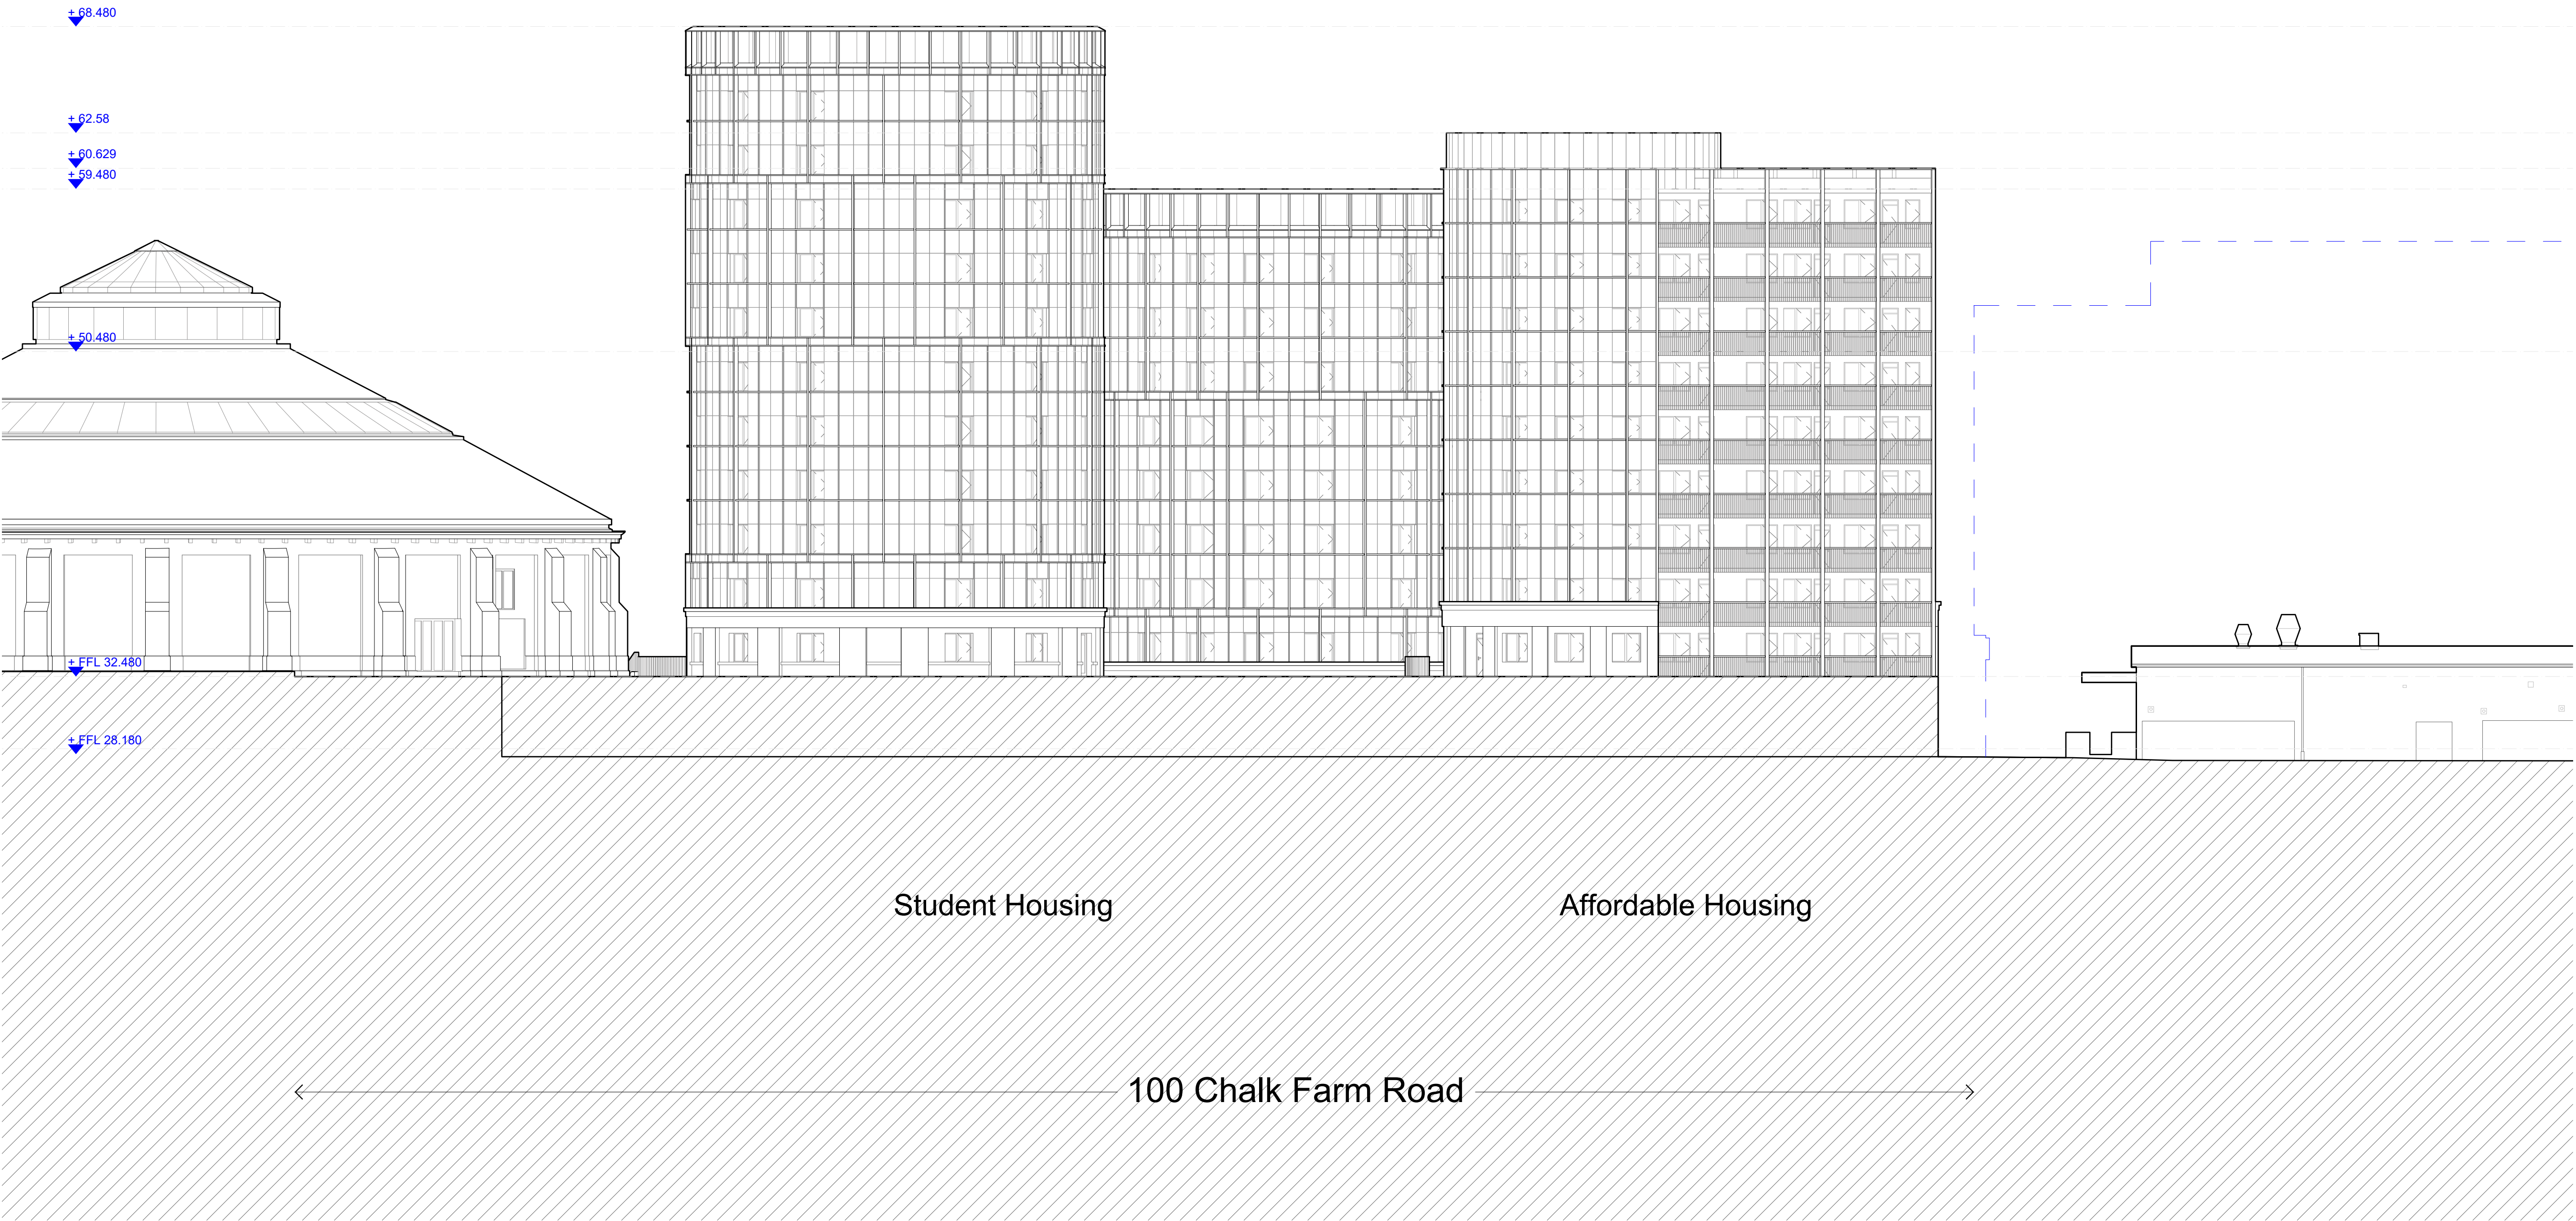


Proposed South Elevation

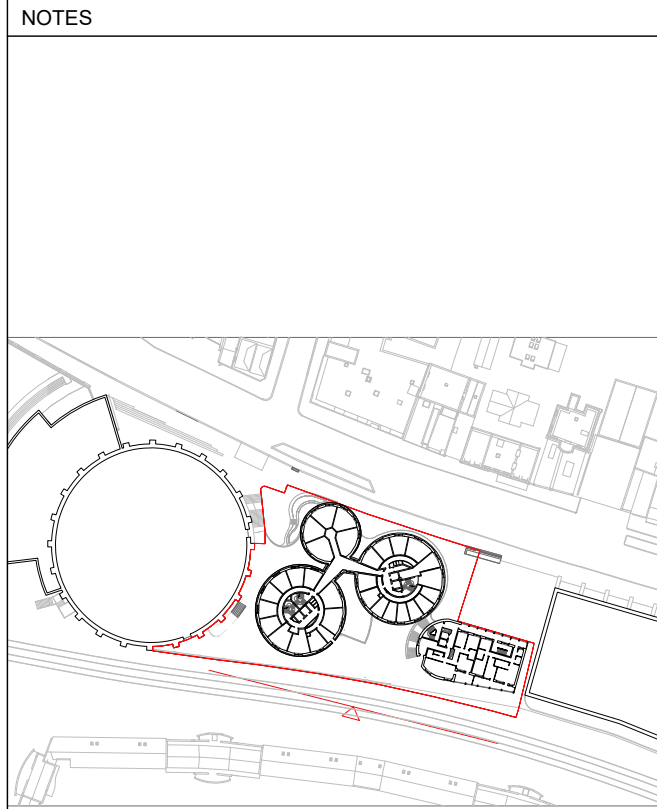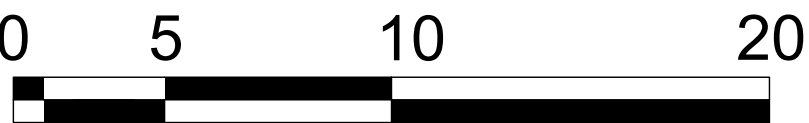


G_24/01/16 Design Freeze 2
F_24/01/12 Design Freeze 2
D_23/11/22 Design Freeze
C_23/11/17 Design Freeze
B_23/11/09 Draft Design Freeze
A 23/11/03 Draft

INFORMATION

rev	date	check	comments
DSDHA 357 Kennington Lane London SE11 5QY T 020 7703 3555 F 020 7703 3890 E info@dsdha.co.uk W www.dsdha.co.uk			
project			
100 Chalk Farm Road			
drawing title			
Proposed South Elevation			
drawn	size	date	scale
Fl	A1	24/01/12	Varies
drawing number			revision
356_P30.120			G
REPORT DISCREPANCIES DO NOT SCALE FROM THIS DRAWING COPYRIGHT DSDHA		USE LATEST REVISION CHECK DIMENSIONS ON SITE	

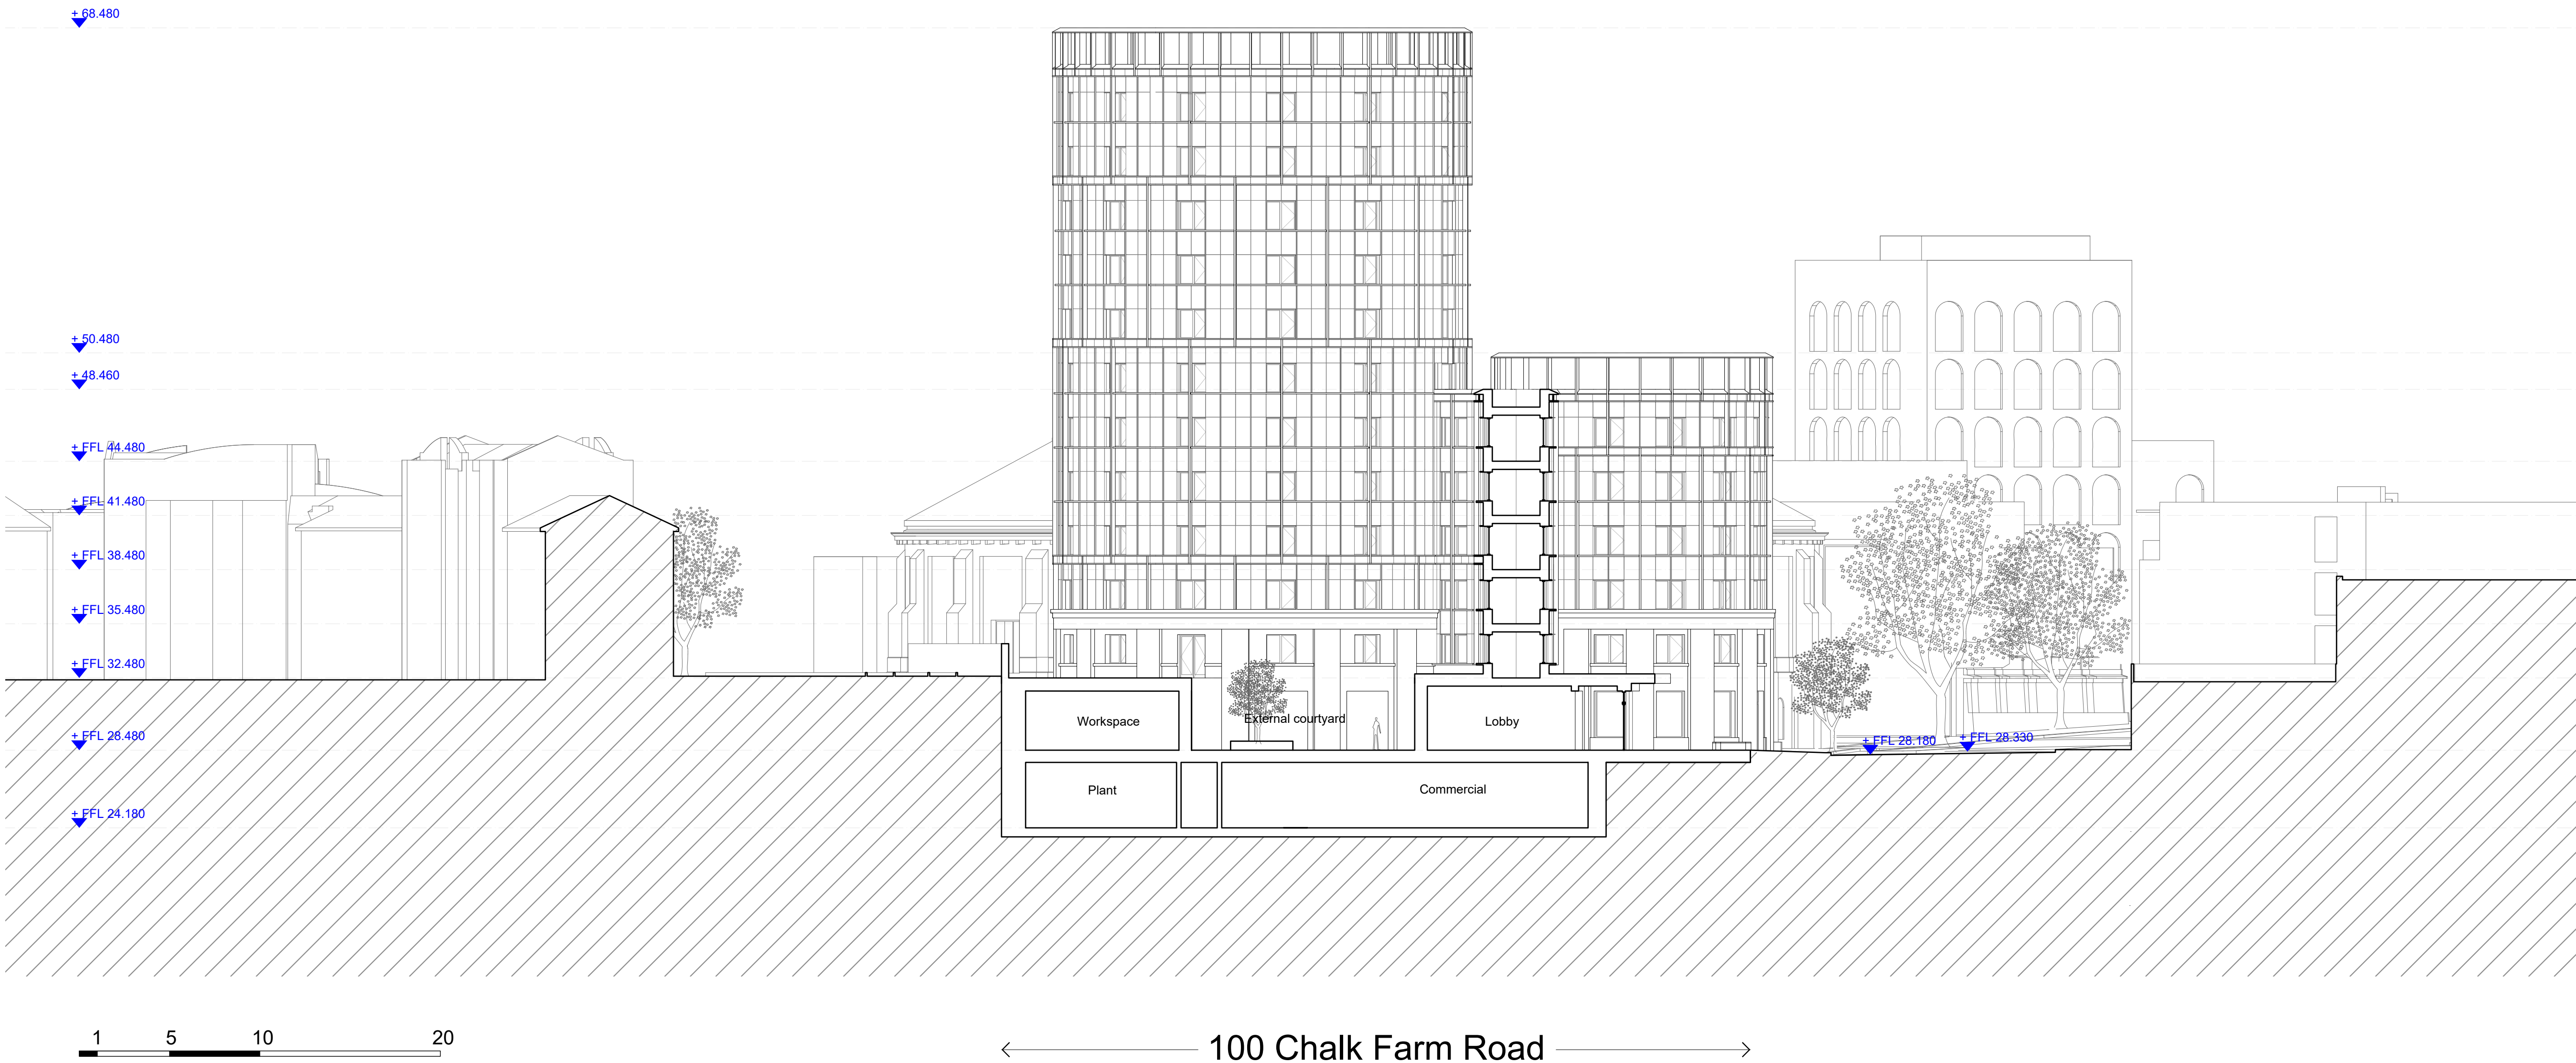


NOTES

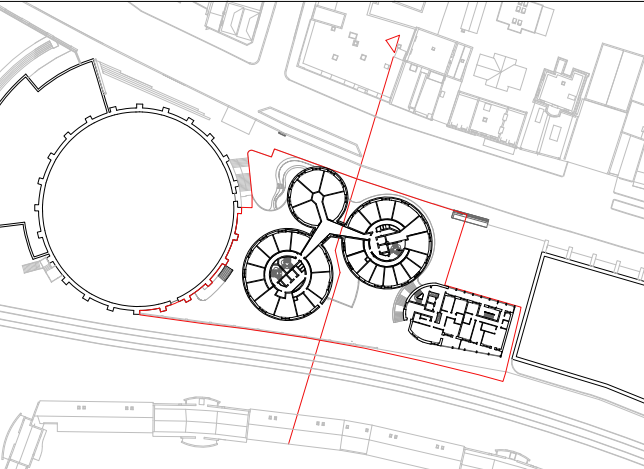


G_24/01/16 Design Freeze 2
F_24/01/12 Design Freeze 2
D_23/11/22 Design Freeze
C_23/11/17 Design Freeze
B_23/11/09 Draft Design Freeze
A 23/11/03 Draft

INFORMATION

rev	date	check	comments
DSDHA 357 Kennington Lane London SE11 5QY T 020 7703 3555 F 020 7703 3890 E info@dsha.co.uk W www.dsha.co.uk			
project			
100 Chalk Farm Road			
drawing title			
Site Section CC			
drawn	size	date	scale
FI	A1	23/11/17	1:200
drawing number			revision
356_P40.003			G
REPORT DISCREPANCIES DO NOT SCALE FROM THIS DRAWING COPYRIGHT DSDHA		USE LATEST REVISION CHECK DIMENSIONS ON SITE	

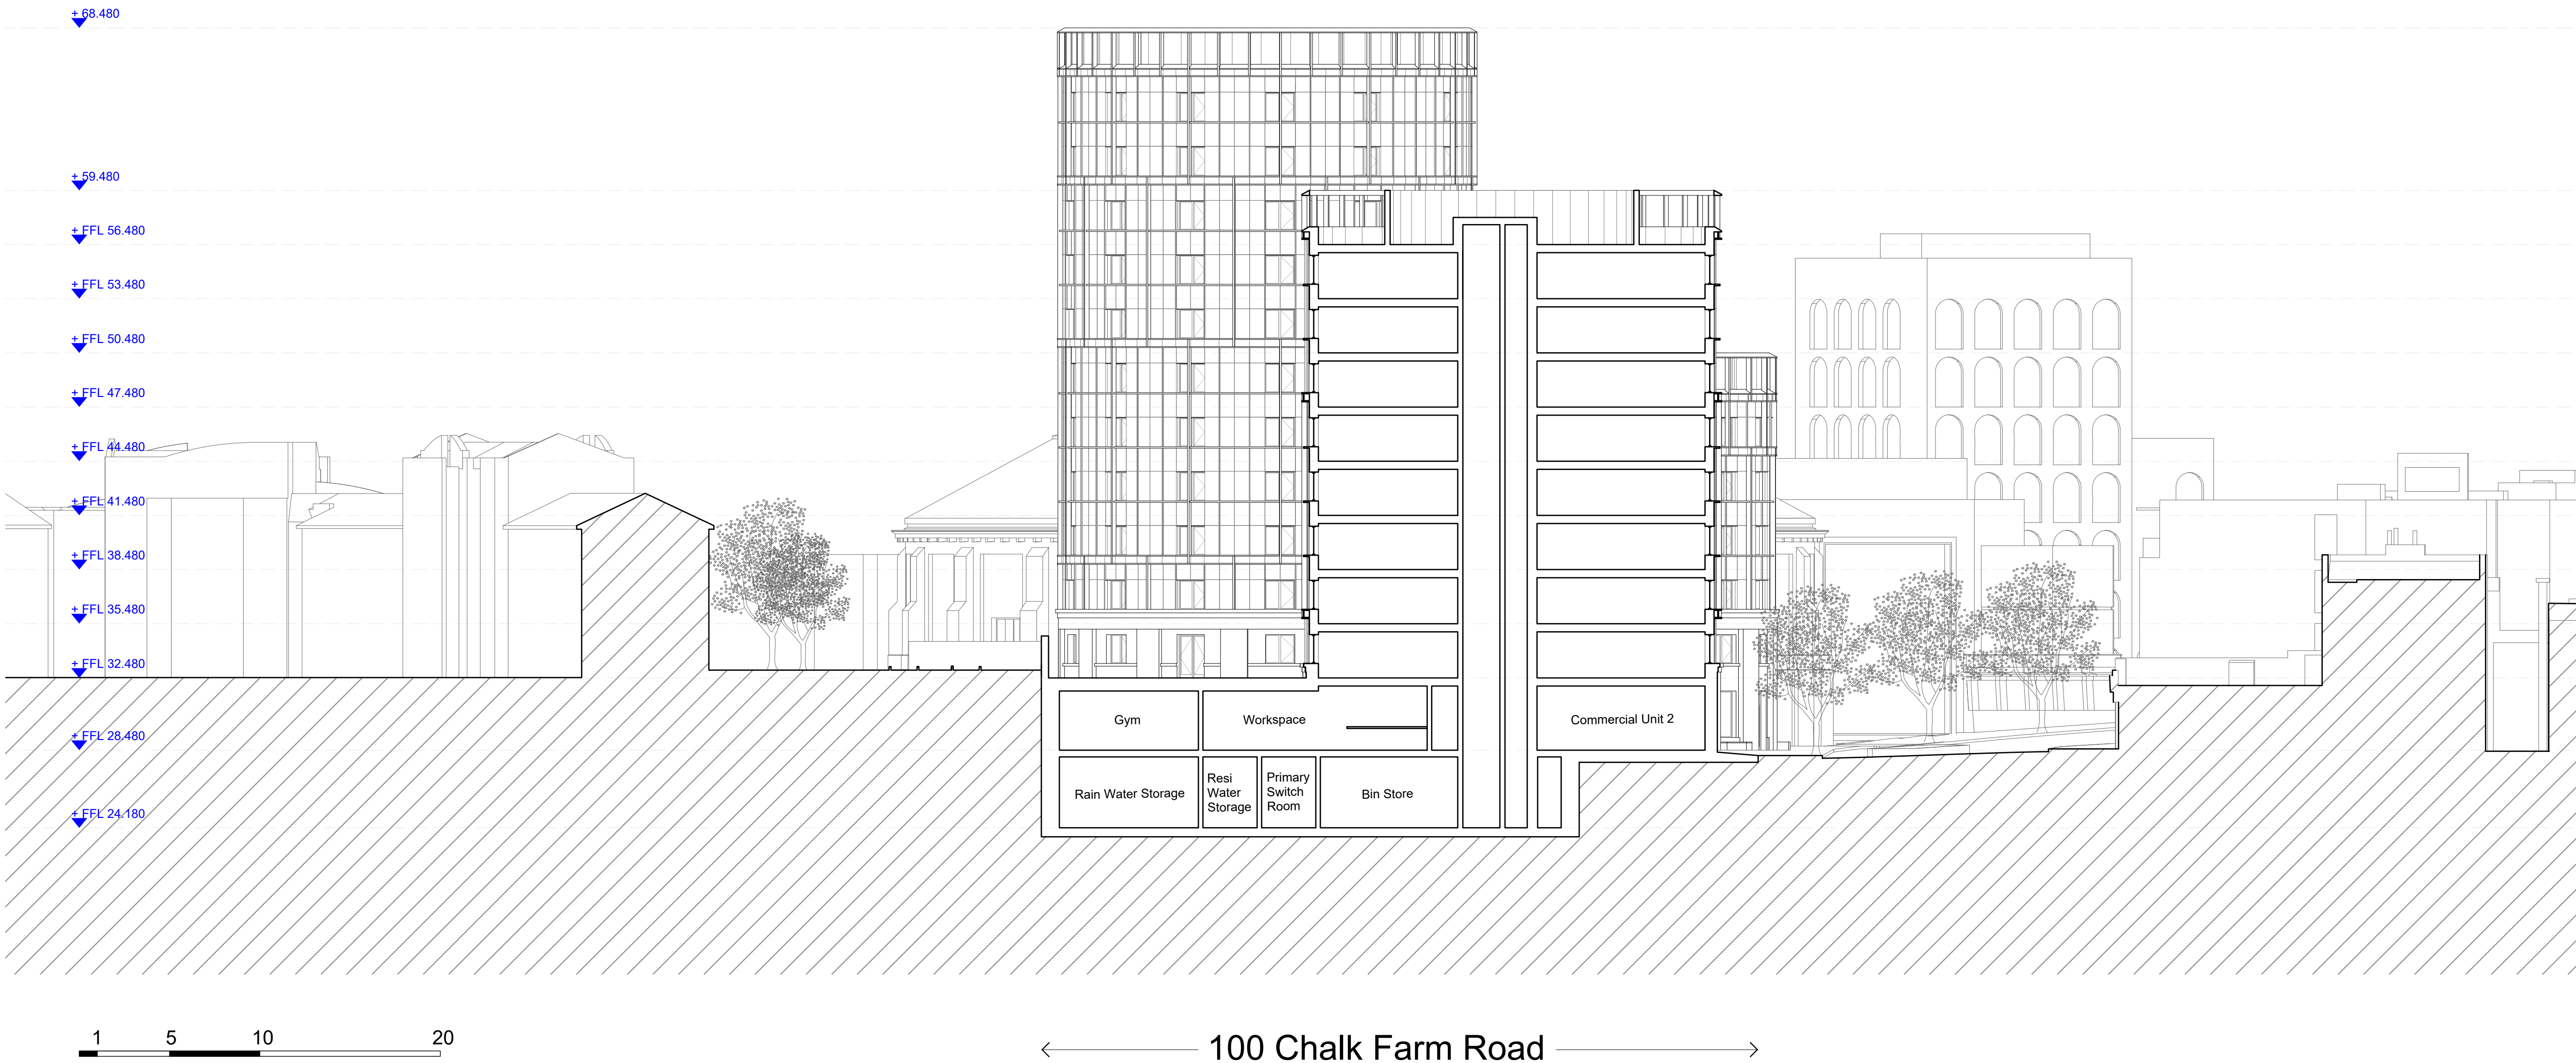

NOTES

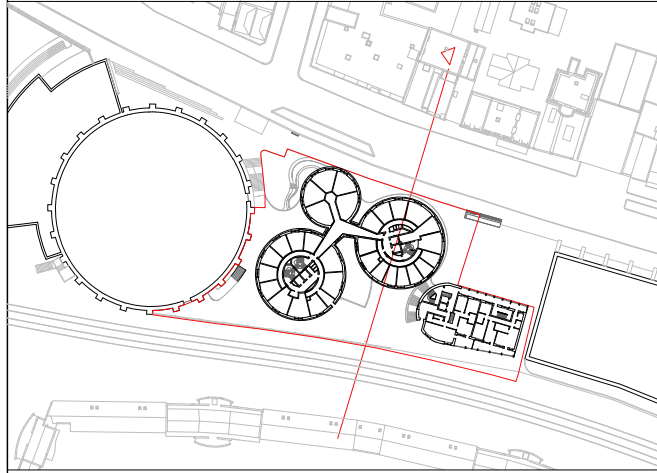

G_24/01/16 Design Freeze 2
F_24/01/12 Design Freeze 2
D_23/11/22 Design Freeze
C_23/11/17 Design Freeze
B_23/11/09 Draft Design Freeze
A 23/11/03 Draft

INFORMATION

rev	date	check	comments
DSDHA 357 Kennington Lane London SE11 5QY T 020 7703 3555 F 020 7703 3890 E info@dsdha.co.uk W www.dsdha.co.uk			
project			
100 Chalk Farm Road			
drawing title			
Site Section DD			
drawn	size	date	scale
FI	A1	23/11/17	1:200
drawing number			revision
356_P40.004			G
REPORT DISCREPANCIES DO NOT SCALE FROM THIS DRAWING COPYRIGHT DSDHA		USE LATEST REVISION CHECK DIMENSIONS ON SITE	



NOTES

G_24/01/16 Design Freeze 2
F_24/01/12 Design Freeze 2
D_23/11/22 Design Freeze
C_23/11/17 Design Freeze
B_23/11/09 Draft Design Freeze
A 23/11/03 Draft

INFORMATION

rev	date	check	comments
DSDHA 357 Kennington Lane London SE11 5QY T 020 7703 3555 F 020 7703 3890 E info@dsdha.co.uk W www.dsdha.co.uk			
project			
100 Chalk Farm Road			
drawing title			
Site Section EE			
drawn	size	date	scale
FI	A1	23/11/17	1:200
drawing number			revision
356_P40.005			G
REPORT DISCREPANCIES DO NOT SCALE FROM THIS DRAWING COPYRIGHT DSDHA		USE LATEST REVISION CHECK DIMENSIONS ON SITE	