
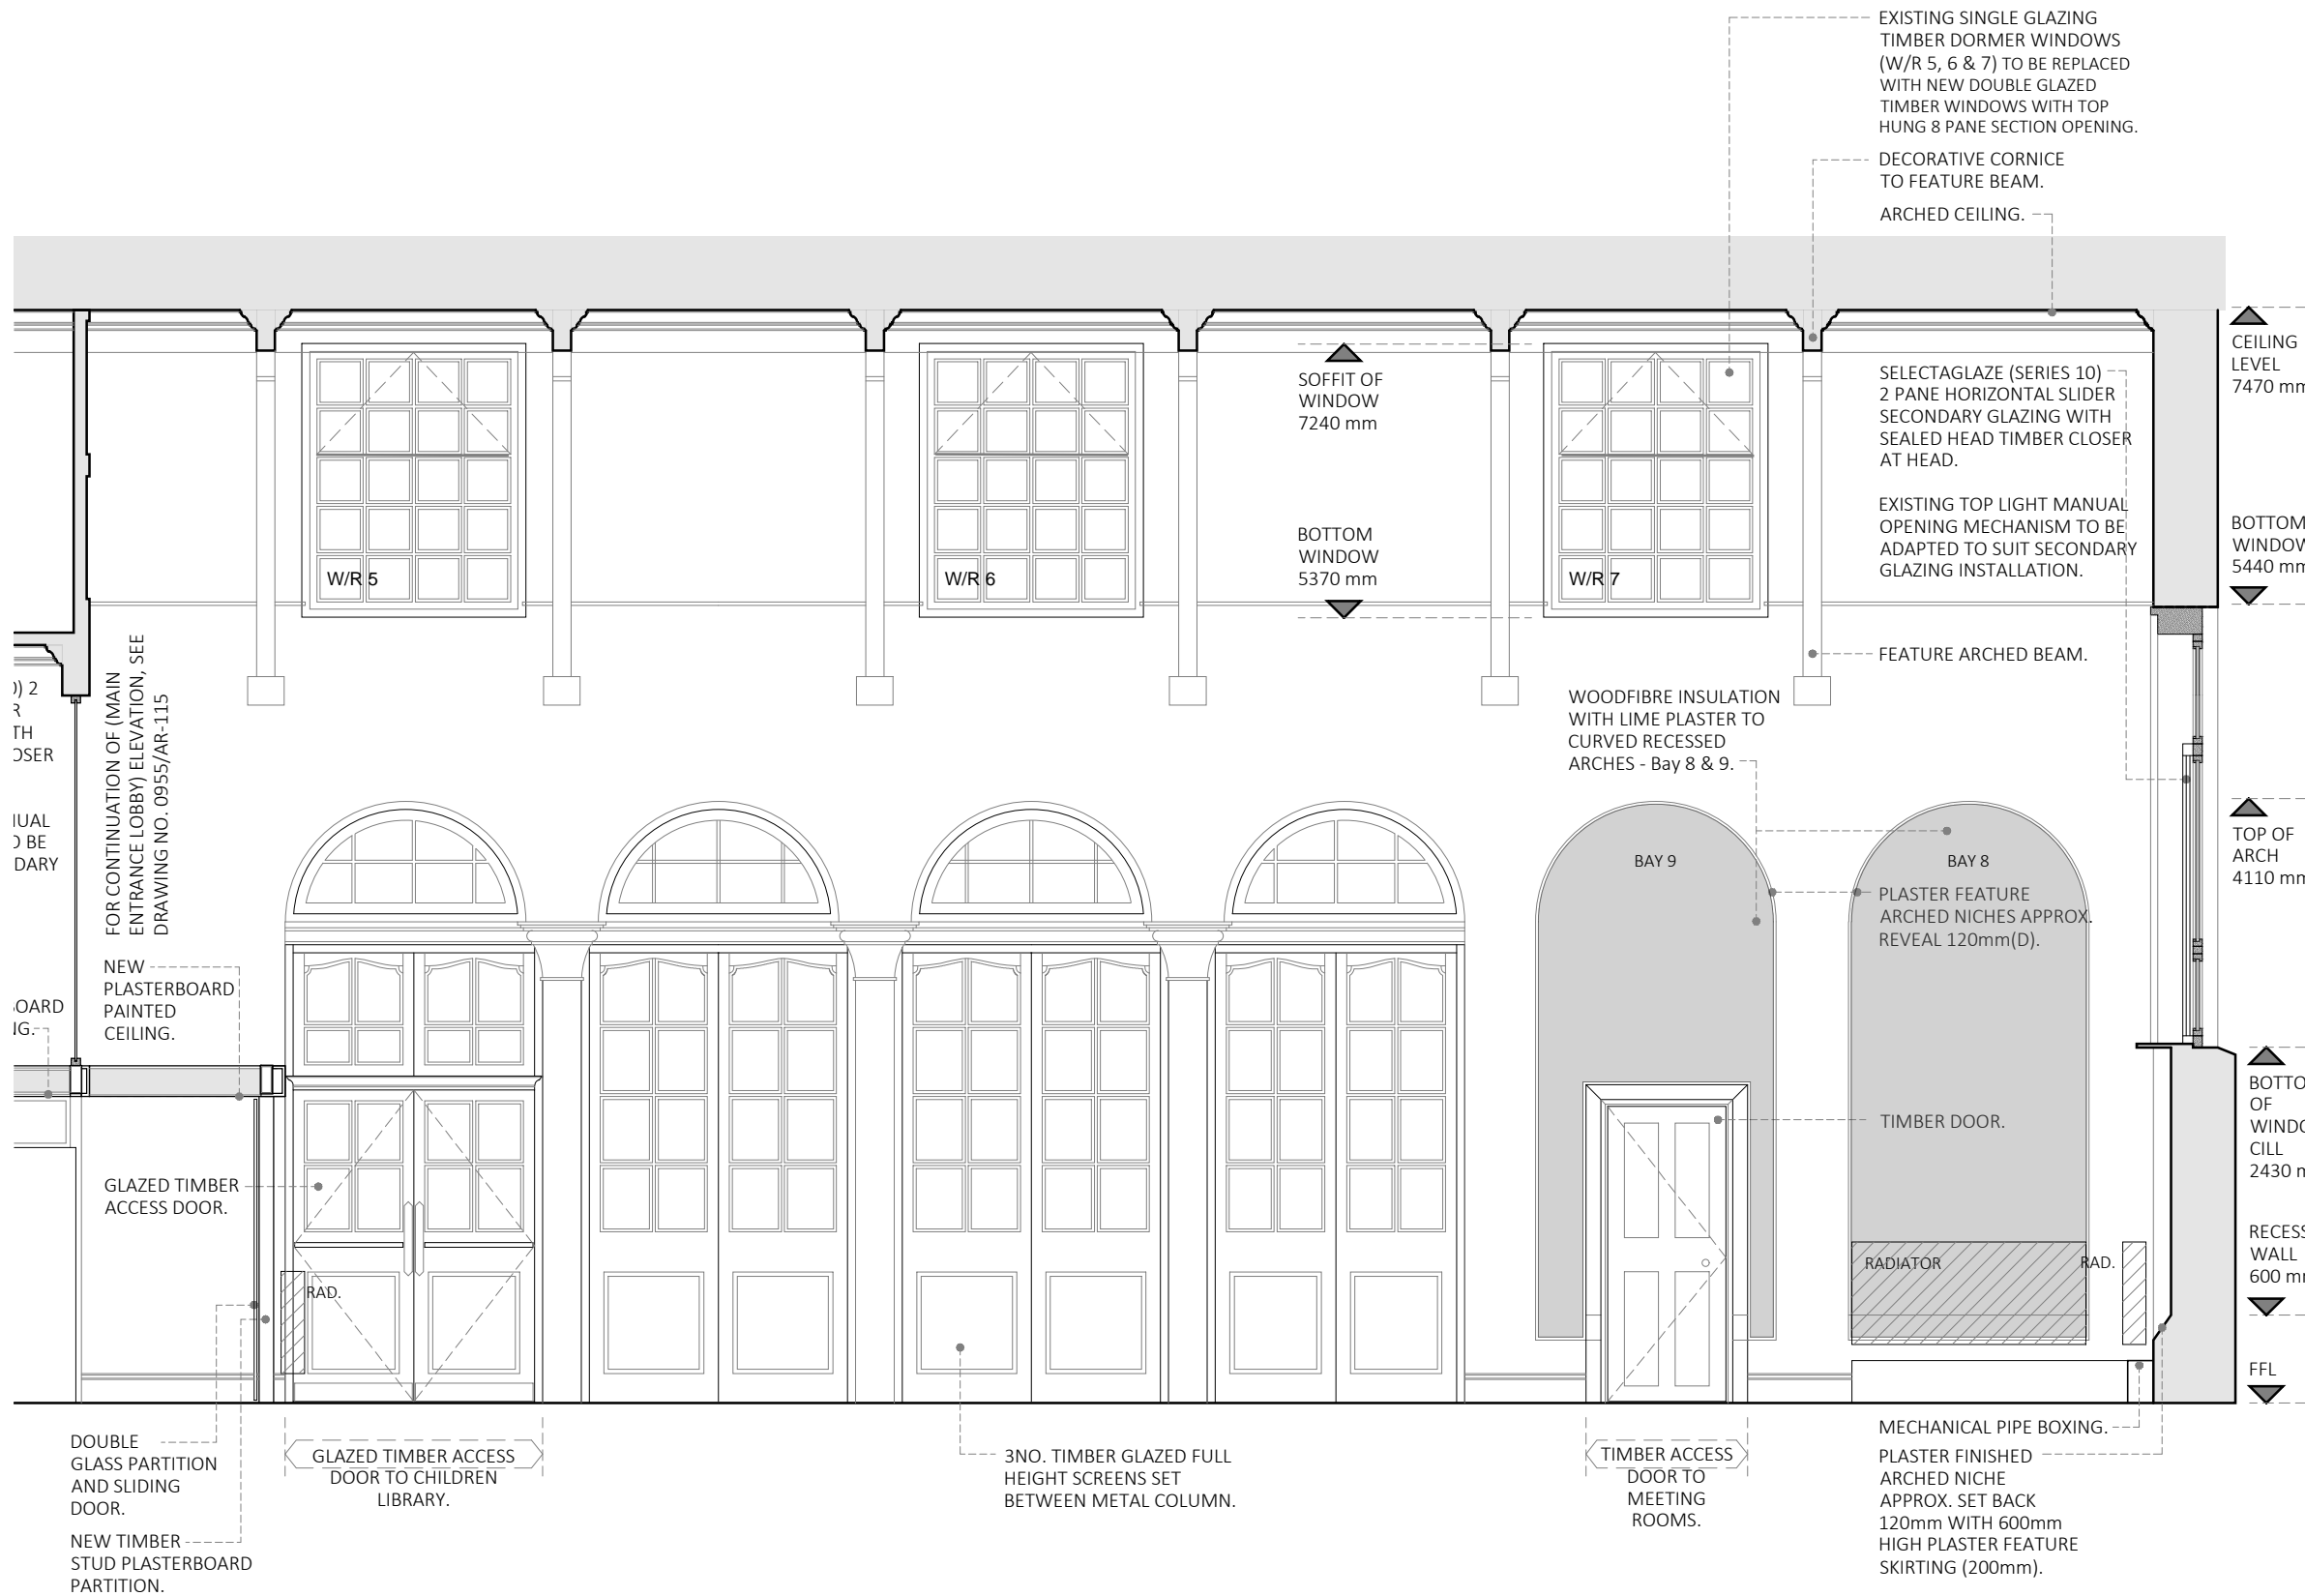


This drawing is copyright & the property of Chris Potter Associates Ltd & must not be copied in whole or in part without their written permission. Copyright is reserved. ©

This drawing must not be scaled. The Contractor is to report all dimensional discrepancies & errors to the Contract Administrator prior to construction commencing.

This drawing is to be read in conjunction with all specifications/schedule of works and all other associated documents. All works described and / or reasonably inferable from the same are deemed included in the contract sum.

BUILDING OUTLINE

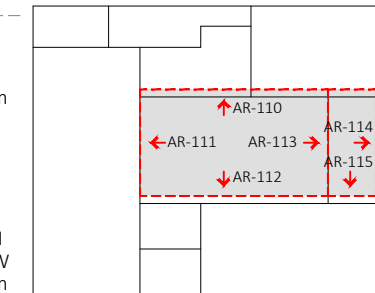

NOTES:

- FOR WALL INSULATION PLAN AND DETAILS, PLEASE DRAWING REF. NO. 0616-CP02 AND 0616-CP03 AND APPENDIX 10.
— WOODFIBRE INSULATION WITH LIME PLASTER TO CURVED RECESSED ARCHES.
— METAL STUD INSULATED WALL LINING.
- EXISTING PIPE RUNS & CONDUIT OMITTED FOR CLARITY.
- FOR SECONDARY GLAZING DETAILS AND SPECIFICATION, PLEASE REFER TO SELECTAGLAZE REPORT NO. KB/E/73081/R/0 AND APPENDIX 8.
— SECONDARY GLAZING HORIZONTAL SLIDING (SERIES 10 SLIMLINE).
- FOR HEATING & VENTILATION LAYOUTS AND SPECIFICATION, PLEASE REFER TO FLOH DRAWINGS AND APPENDIX 11

Thickening to line showing transom to top opening to windows		
Revisions	Comments	Dates
02.02.2024	issue for planning	22.11.2023
Status		
<input type="radio"/> Feasibility	<input type="radio"/> Tender	<input type="radio"/> For Client Approval
<input checked="" type="radio"/> Planning	<input type="radio"/> Construction	<input type="radio"/> Preliminary
<input type="radio"/> Building Regulations	<input type="radio"/> As Built	
Client Camden Council		Date 02/02.2024
Project Title Highgate Library Chester Road, London N19 5DH		Drawn IC
Drawing Title Main Library Hall Proposed East Elevation		Approved BB
		Scale 1:50 @A3
		Job No. 0955
		Dwg No. AR-112 Rev1

01 Main Library Hall - Proposed East Elevation
AR-112 Scale 1:50 @A3



South West Office: 3 Heanton Street, Devon, EX33 2JS Ph: 01271 615 450
 South East Office: 20-22 Wenlock Road, London, N1 7GU Ph: 0203 934 0000
 E: info@chrispotter.co.uk
 W: www.chrispotter.co.uk