



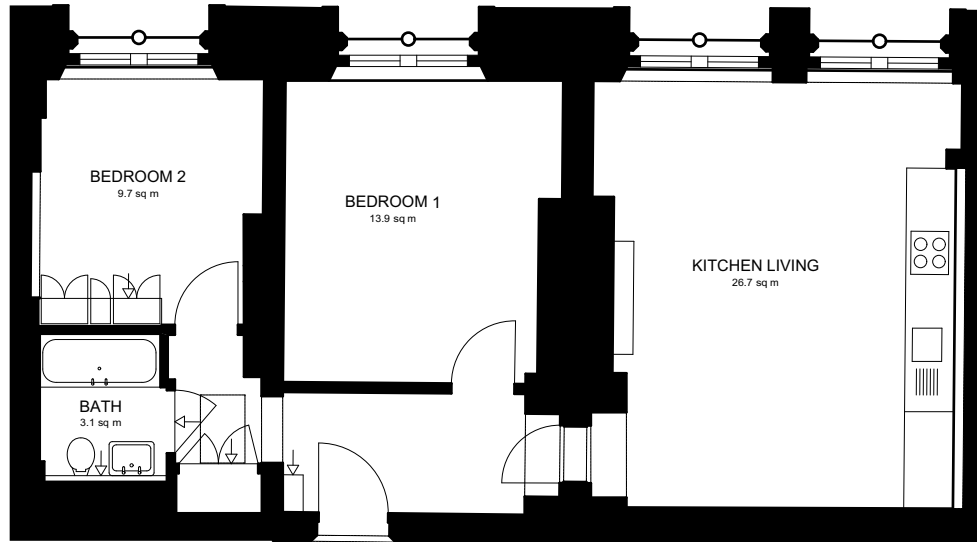

1 EXISTING PLAN
SCALE 1:100@A3

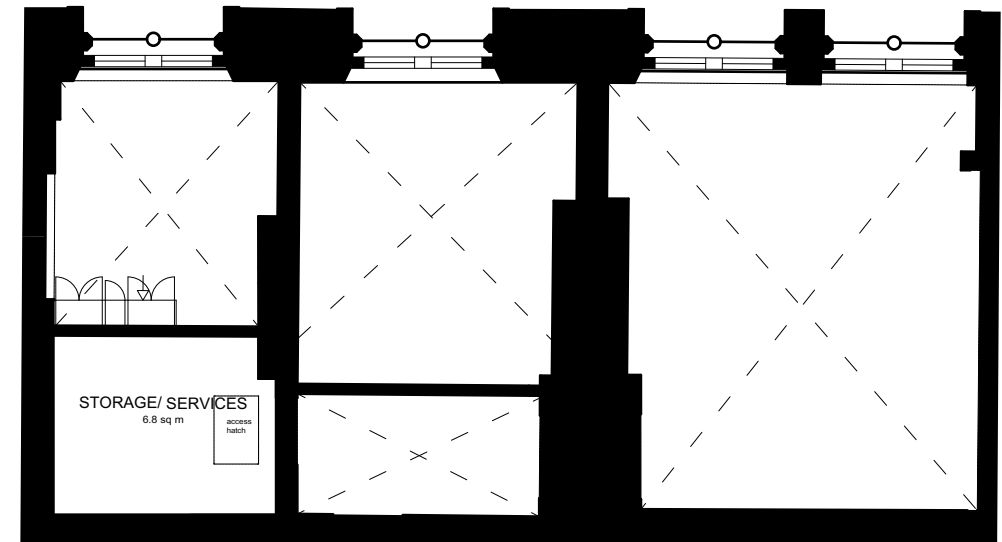


3 EXISTING STORAGE PLAN
SCALE 1:100@A3



2 PROPOSED PLAN
SCALE 1:100@A3

NEW WASTE PIPE TO RUN
BEHIND SKIRTING TO CONNECT
WITH EXISTING KITCHEN
DRAINAGE RUN

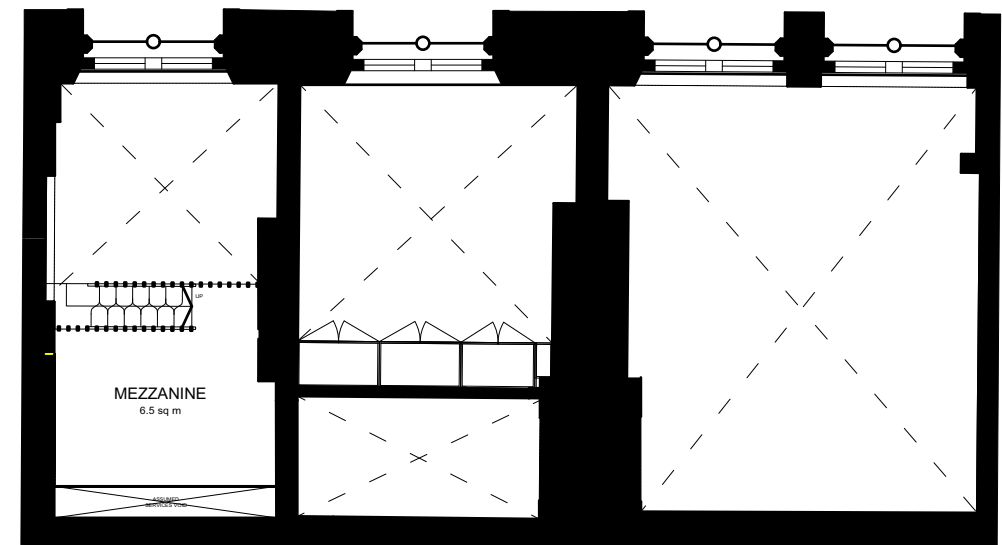

4 PROPOSED MEZZANINE PLAN
SCALE 1:100@A3

FOR PLANNING

REV: -

POB. ARCHITECTS
WWW.PICKOURBRAINS.CO.UK

PROJECT NAME: **APT 3-10 ST PANCRAS CHAMBERS**
PROJECT NUMBER: **212**
CLIENT: **ROBERTS**

DRAWING TITLE: **FLOOR PLAN**
DRAWING NO: **101**

SCALE: **1:100@A3** DATE: **MAR 2024**

NOTES:
DO NOT SCALE OFF THIS DRAWING
ALL DIMENSIONS TO BE CHECKED ON SITE

0 1m 2 3 4 5m

