


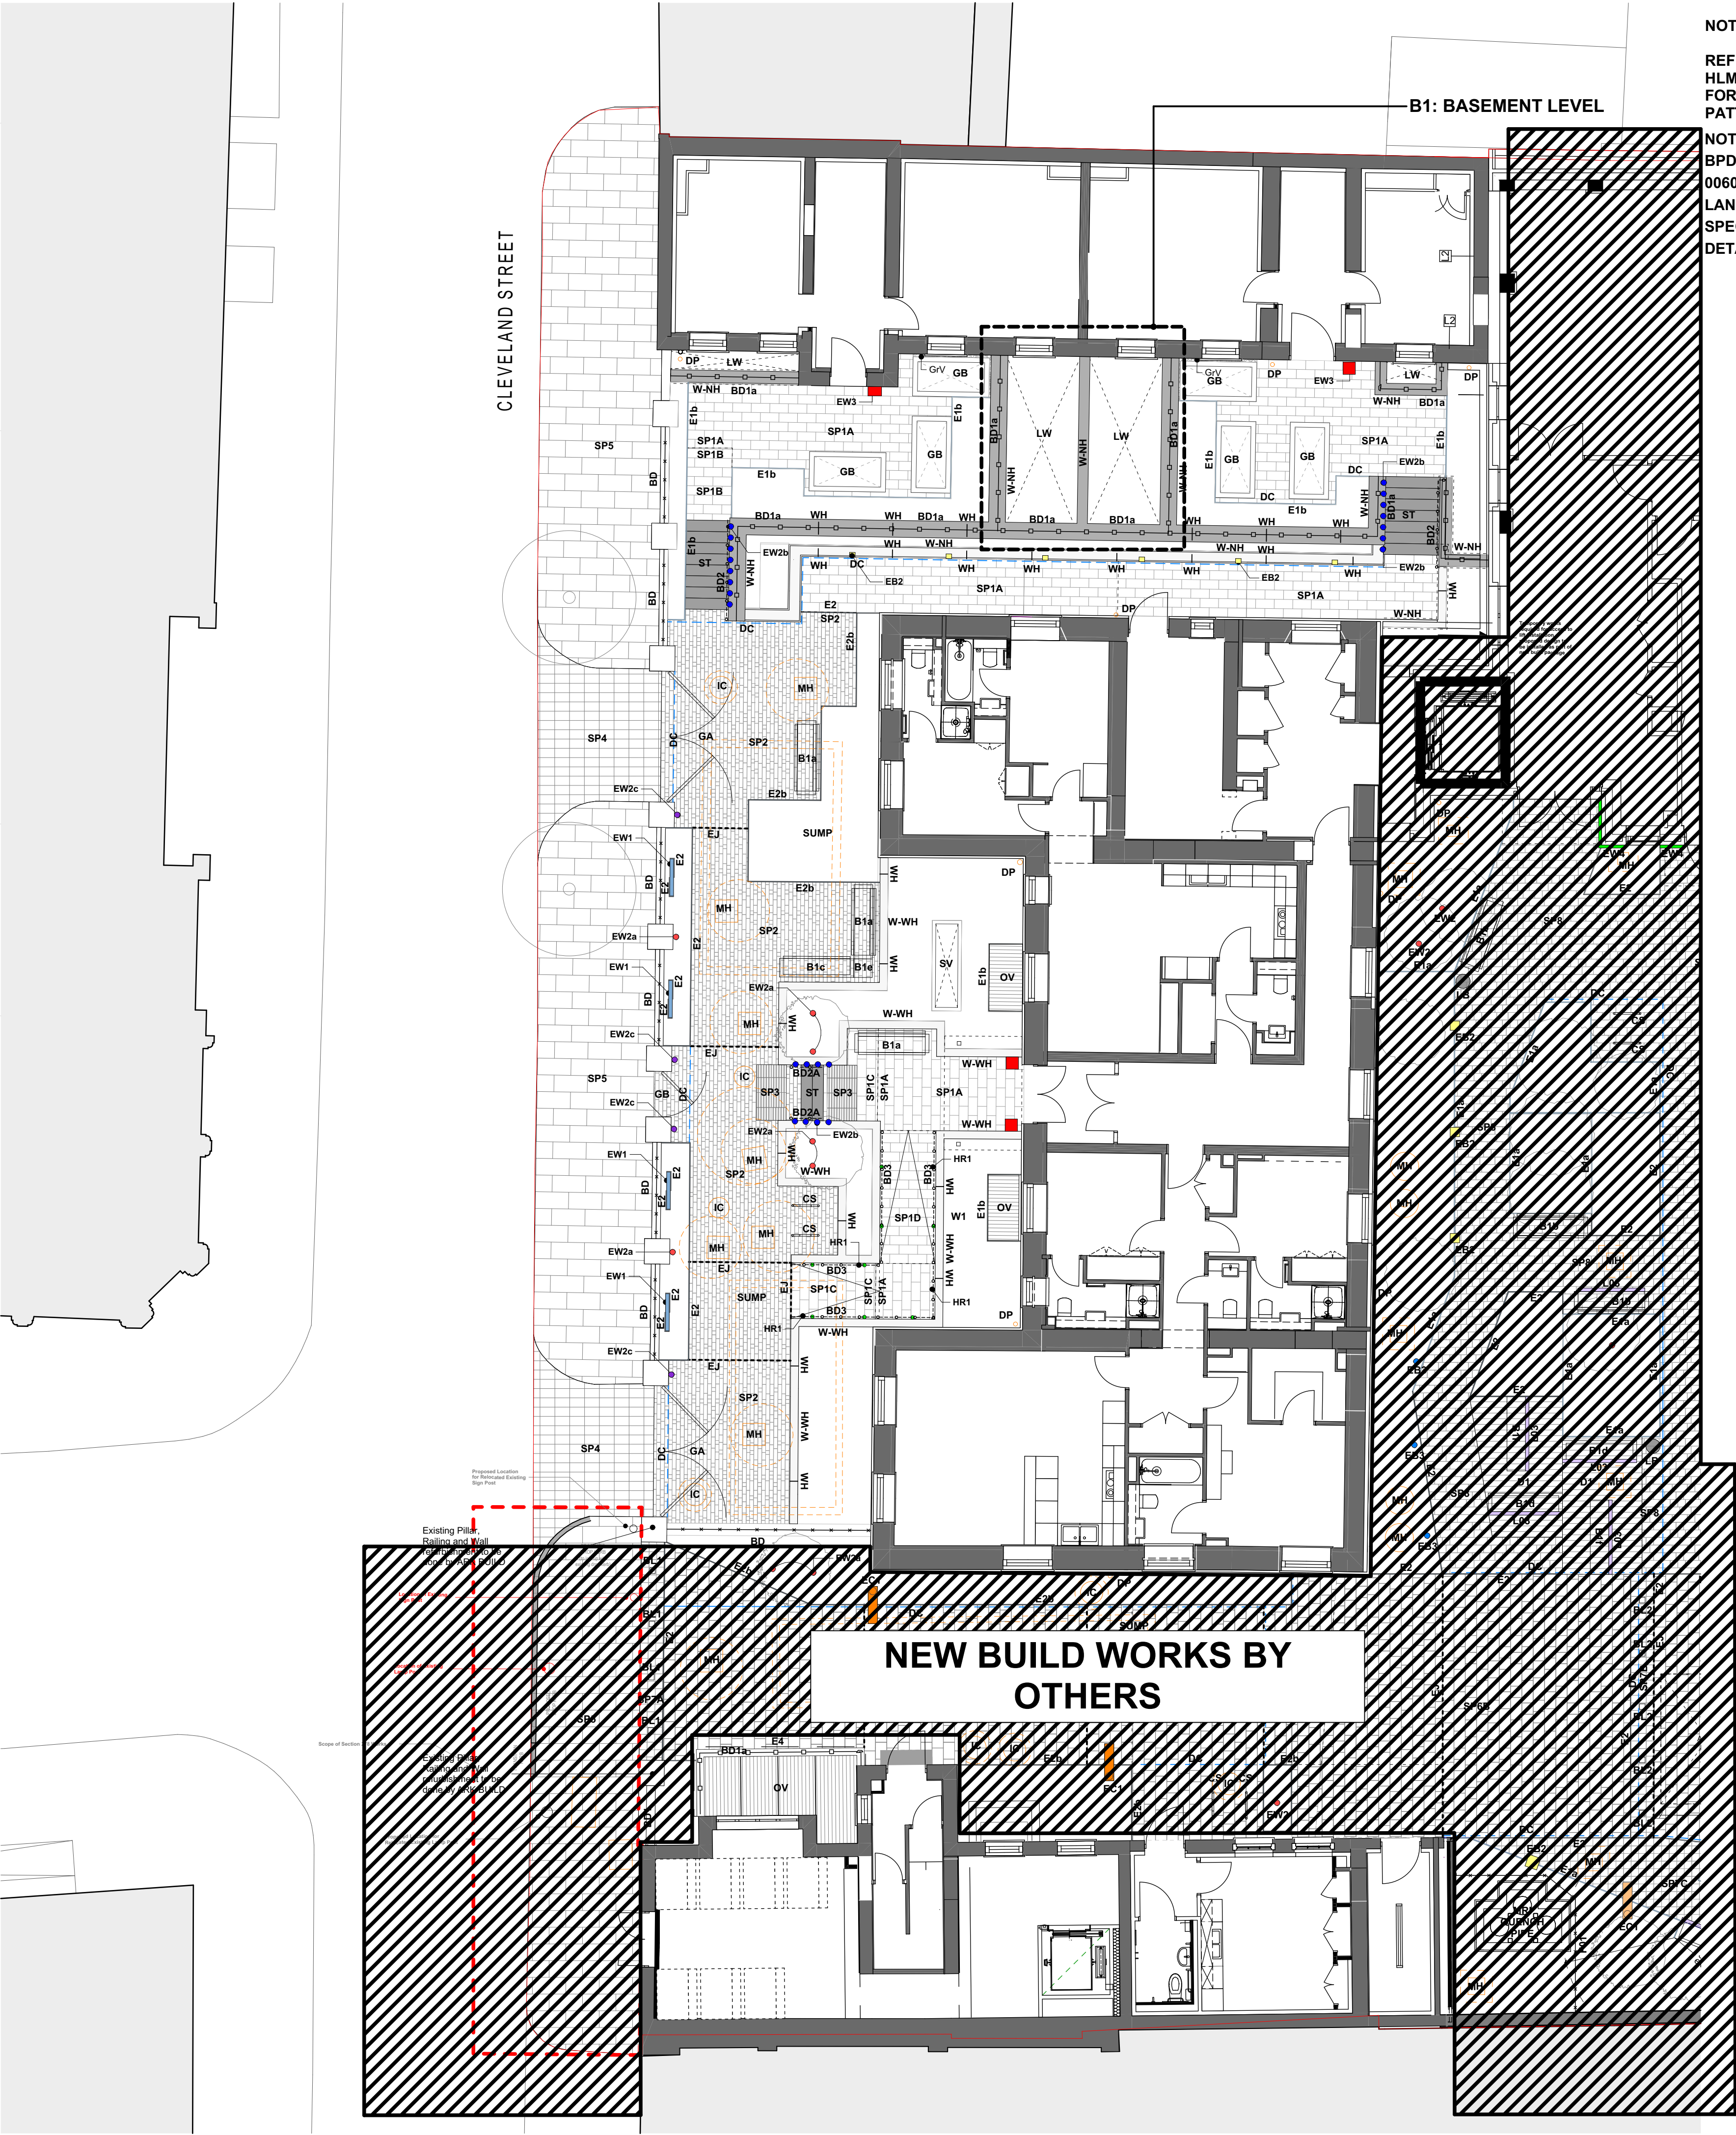

NOTE:

REFER TO DRAWING BPD-HLM-00-XX-DR-L-30411 FOR RELEVANT PAVING PATTERNS.

NOTE: TO BE READ WITH BPD-HLM-XX-XX-SP-L-00601 LANDSCAPE SPECIFICATION FOR DETAILS.


Hard Landscape GA Key

- SP1** Stone Paving Type 1 - Yorkstone Flag
Marshalls Yorkstone Flag Paving (50mm)
Scoutmoor Sandstone, 200 x 600mm
SP1A - Pedestrian loading over podium on pedestal
SP1B - Pedestrian loading - existing ground on pedestal
SP1C - Pedestrian loading - over existing ground
SP1D - Pedestrian loading - over podium
- SP2** Stone Paving Type 2 - Granite Sett
Marshalls Chinese Granite Sett Paving (50mm)
Callisto - Silver Grey - flamed (50%),
Mimas - Red - flamed (20%),
Larissa - Buff - fine picked (30%),
100 x 200 (10%) 300 (30%) 400 (60%) mm
- SP3** Stone Paving Type 3 - Tactile
Marshalls Chinese Granite Flag Paving (50mm)
Tactile Paving, Mimas - Red - light sand blasted,
400 x 400mm.
- SP4** Stone Paving Type 4 - Existing
Relaid Sett Paving (Existing)
Lift and relay to retain heritage of site access.
- SP5** Stone Paving Type 5 - Existing
Slab Paving (Existing)
Made good where necessary.
- ST** Marshalls Granite Steps with nosing
Chinese Granite - Callisto Silver grey - flamed finished,
200(H) x 300(W) x 1000(L)mm
- GrV** Decorative Gravel
CED Flat White Pebbles 20-40mm
To be dressed over drainage channel.
- E1b** Edging Type 1b
Logic Edinburgh Straight Module Planter System,
(E1b) Galvanised Steel & Powder Coated - Black
Finish, 6(W)mm, height varies.
- E2** Edging Type 2
Logic Edinburgh Edge Straight System, Galvanised
Steel Powder Coated Finish, 3(W) x 70(H) x 2000(L)mm
x 70(Base width)mm
- E2b** Edging Type 2b
Logic Edinburgh Edge Straight System, Galvanised steel
polyester powder coated black finish, 3(W) x 200(H) x
2000(L)mm x 100(Base width)mm. 100mm upstand
- E4** Edging Type 4
Marshalls Yorkstone Bespoke kerb
200(W) x 525(H) x 915(L)mm - 125-325mm upstand
- BD** Boundary Wall and Railings
Reference Architects drawing:
BPD-LDW-WH-ZZ-DR-A-251008
- BD1a** Boundary Type 1a
BD1a: New railings to match existing.
Black powder coated.
Drawing reference
- BD2** Boundary Type 2 & 2a
Hand Rail to all steps 45mm dia handrail
Black powder coated, 900(H)mm.
- BD3** Boundary Type 3
Hand Rail to all Workhouse Ramp 48mm dia handrail,
with integrated lighting
Black powder coated, 900(H)mm.
- W-NH** Walls Northouse
Details Refer: BPD-HLM-00-00-DR-L-00214
Copings Refer: BPD-HLM-00-ZZ-DR-L-25402
Refer Architects drawing BPD-LDW-WH-ZZ-DR-A-251004
- W-WH** Walls - Workhouse
Details Refer: BPD-HLM-00-00-DR-L-00216
Copings Refer: BPD-HLM-00-ZZ-DR-L-25404
Refer Architects drawing BPD-LDW-WH-ZZ-DR-A-301003
- WH** Weephole to wall
Refer to BPD-HLM-00-00-DR-L-00214 - DS03
- GA** Gate A
Market Housing Vehicle Entrance Gate - Double leaf
Refer Architects drawing:
BPD-LDW-WH-ZZ-DR-A-251008
- GB** Gate B
Market Housing Pedestrian Entrance Gate - Single leaf
Refer Architects drawing:
BPD-LDW-WH-ZZ-DR-A-251008
- B1a, b, c, e** Bench Type 1 - Surface Fixed
Escofet Boxland benches - various
a 2000 x 500 x 450mm - full seat - white
c 2000 x 500 x 450mm - backless seat - white
e 500 x 500 x 450mm - white

- CS** Cycle Stand
Marshalls Cycle Stand - Black Polyester Powder
Coated Steel 750(H) x 48(W) x 750(L)mm
Surface mounted Refer Detail: BPD-HLM-00-XX-DR-L-30404
- GB** Glass Bridge
to North House, To Architect's Details
- LW** Light Well/ Smoke Vent
To Architect's Details
- SV** Smoke Vent/ Breakout Panel
Refer to drawing BPD-HLM-00-XX-DR-L-30404
- OV** Open Vent/ Grille
To Architect's Details
- DC** Surface Drainage Channel
Refer to Aecom Civils Drainage plans
- EJ** Expansion/ Movement Joint
Refer to Aecom Civils Drawing for Details
- MH** Recessed Access Covers.
Refer to drawing BPD-HLM-00-XX-DR-L-30404
MH - Manholes
(Refer to Aecom Civils Drainage plans)
IC - Inspection Chambers
(Refer to Aecom Civils Drainage Plans)
YG - Yard Gullies
(Refer to Aecom Civils Drainage Plans)
- RWO** Rain Water Outlet
(Refer to AECOM Civils New Build Drainage plans)
DP - Down pipes
Ref detail L(00)9 drawing
BPD-HLM-00-00-DR-L-00215
(Refer to AECOM Civils New Build Drainage plans)
- ATT** Attenuation Tank
Refer to AECOM Civils Drainage plans

- LIGHTING PLAN KEY - HERRITAGE**
Refer to Arup MEP drawings MAS-ARP-ZZ-00-DR-E-2901 and lighting schedule for full details and specification
- Type EW1**
Linear wall wash lighting
- Type EW2a**
Tree uplighter, to be installed
outside of tree rootball
- Type EW2b**
Vertical wall recessed to steps
- Type EW2c**
Ground recessed lighting
- Type EB2**
Recessed wall luminaire.
To be set at 365mm or 5 brick courses from
ground
- Type EW3**
- Type HR1**
Handrail Lighting

NOTE:
EXPANSION JOINTS TO RIGID PAVING SYSTEM. REFER TO
AECOM DRAWING'S MHA-ACM-XX-XX-DR-C-00020 FOR
DETAILS.

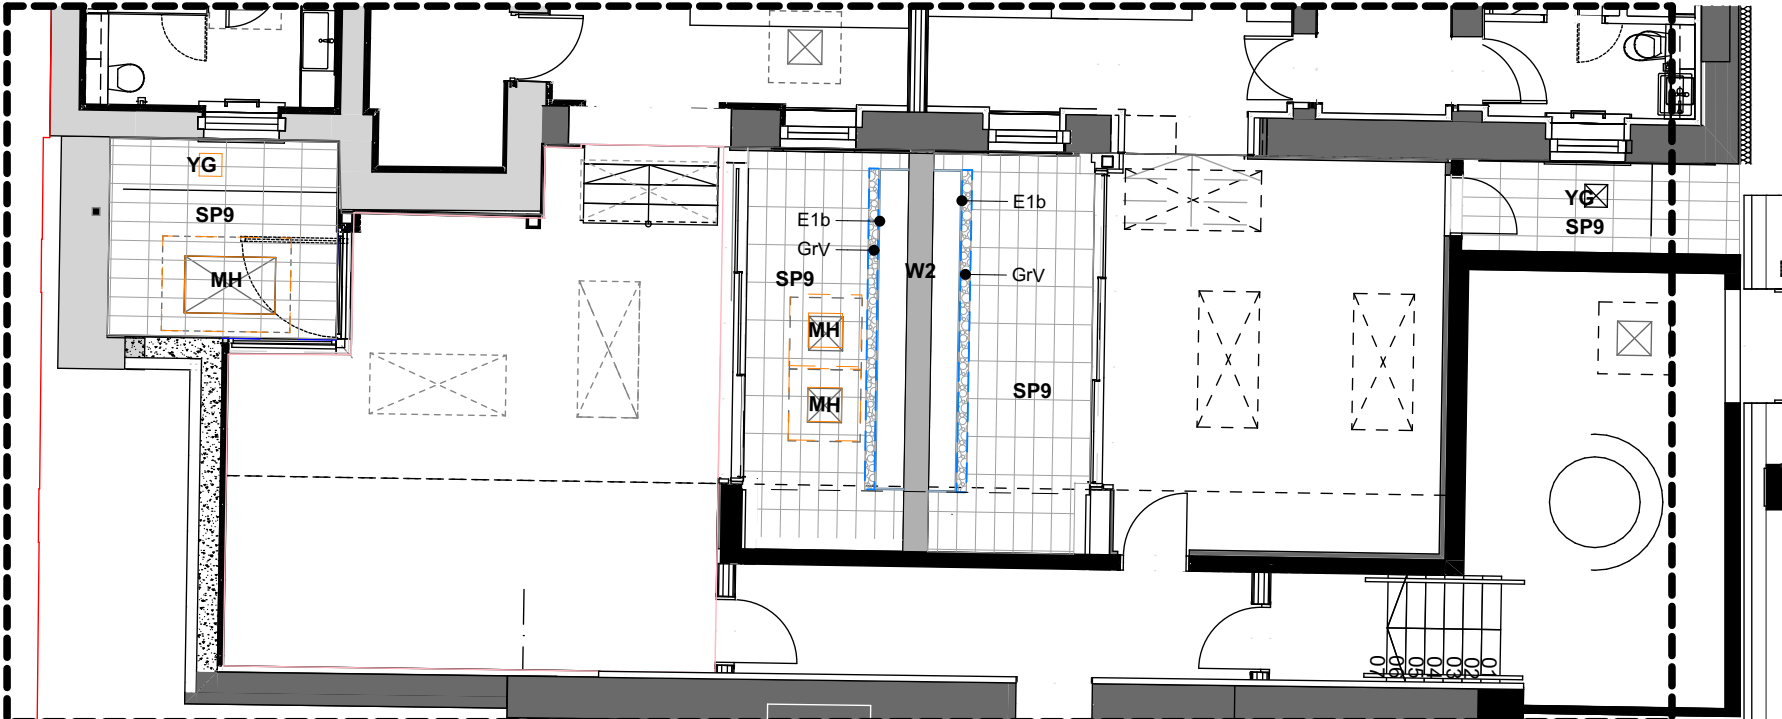

B1


BASEMENT LEVEL

1:100

1:200 m 0 2 4 6 8 10

Notes

Check all dimensions on site. Do not scale from this drawing
Report any discrepancies and omissions to HLM Architects
This Drawing is Copyright ©

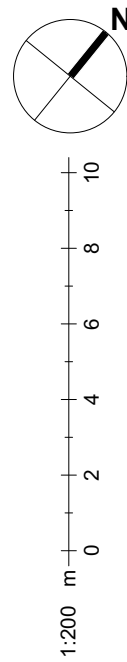

C17	LIGHTING POSITION REVISED/ COORDINATED WITH ARUP	14.07.23	HV	AO
C16	REVISED STAGE 5 ISSUE	19.12.22	AO	AO
C15	STAGE 5 ISSUE	21.11.22	AO	AO
C14	REFERENCE UPDATED	18.11.22	AO	AO
C13	REVISED STAGE 5 ISSUE	07.10.22	HV	AO
C12	NORTH HOUSE AND WORK HOUSE - STAGE 5 ISSUE	15.01.21	HV	AO
C11	REVISED STAGE 4 ISSUE	14.08.20	HV	AO
C10	STAGE 4 (PCSA STAGE 1 DESIGN REVIEW)	17.07.20	HV	AO
C09	REVISED STAGE 4 ISSUE	23.06.20	HV	AO
C08	REVISED STAGE 4 ISSUE	17.01.20	HV	AO
C07	ISSUED FOR COORDINATION	10/10/19	LF	AO
C06	ISSUED FOR COORDINATION	26/06/19	LF	AO
C05	UPDATE AS CLOUDED	13/06/19	LF	MC
C04	ISSUE FOR TENDER	22/02/19	LF	PI
C03	ISSUE FOR TENDER	08/02/19	MC	AO
C02	ISSUE FOR TENDER	26/10/18	MC	PI
C01	FOR INFORMATION	05/10/18	MC	PI

Revisions

Project

BEDFORD PASSAGE
DEVELOPMENT

Client

MIDDLESEX ANNEXE
LLP

Title

HARD LANDSCAPE GA
PLAN - GROUND FLOOR -
SHEET 01

Drawing No. BPD-HLM-00-00-DR-L-30001
Revision C17

Scale @ A1 1:100
Date 04/10/2018
Drawn BH
Checked HLM



© HLMArchitects
2nd Floor
The Ruskin Building
Tudor Square
Sheffield S1 2LA

www.hlmarchitects.com
T. +44 (0) 114 263 9600
F. +44 (0) 114 263 9650
sheffield@hlmarchitects.com