


LEGEND	
SYMBOL	DESCRIPTION
	EXISTING RECESSED DOWN LIGHT
	EXISTING WALL LIGHT
	EXISTING SUSPENDED PENDANT LIGHT
	EXISTING SURFACE MOUNT LINEAR LIGHT
	SURFACE MOUNT DOWN LIGHT


This drawing is protected under Copyright and at no time should any portion of this drawing be reproduced or copied without the permission of the Architect. (Design Copyright Act 1968)

This drawing must not be used for purposes other than that for which it is provided. It is supplied without liability for any errors or omissions.

Drawings only to be scaled for planning application purposes, all dimensions to be checked on site. All drawings subject to Statutory Authority Approval.

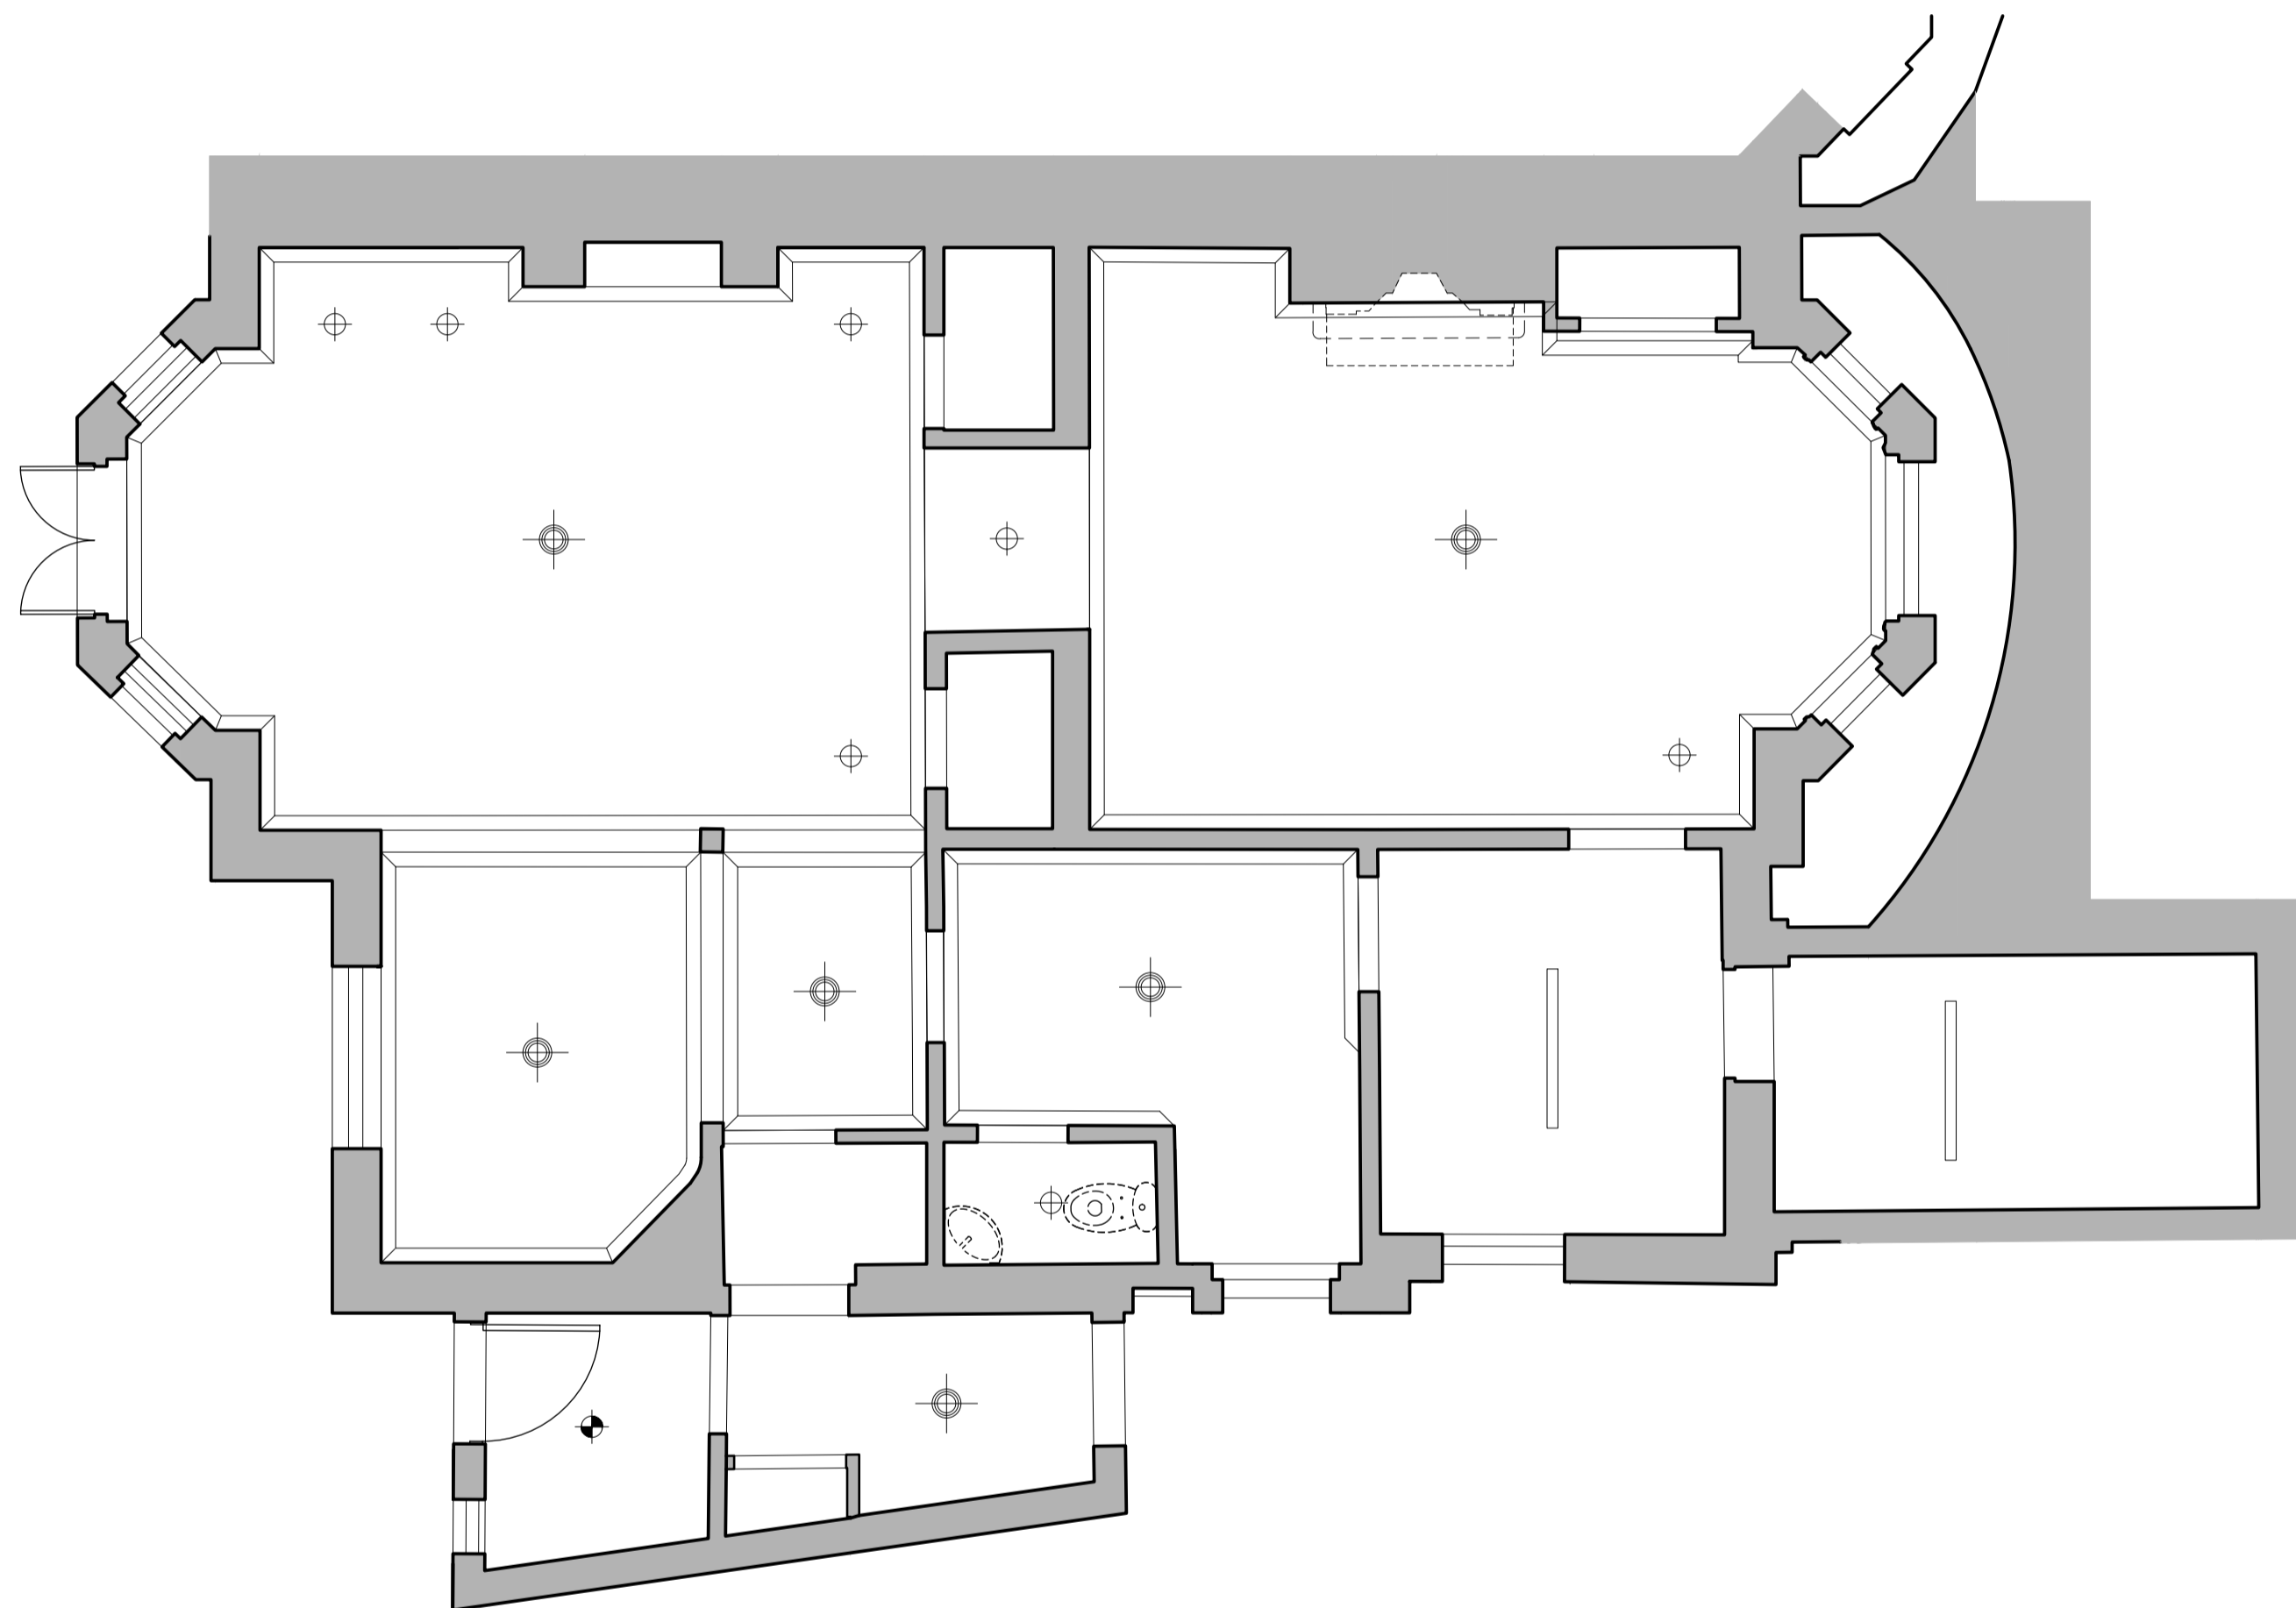

1 EXISTING LOWER GROUND FLOOR RCP LIGHTING PLAN
scale 1:50

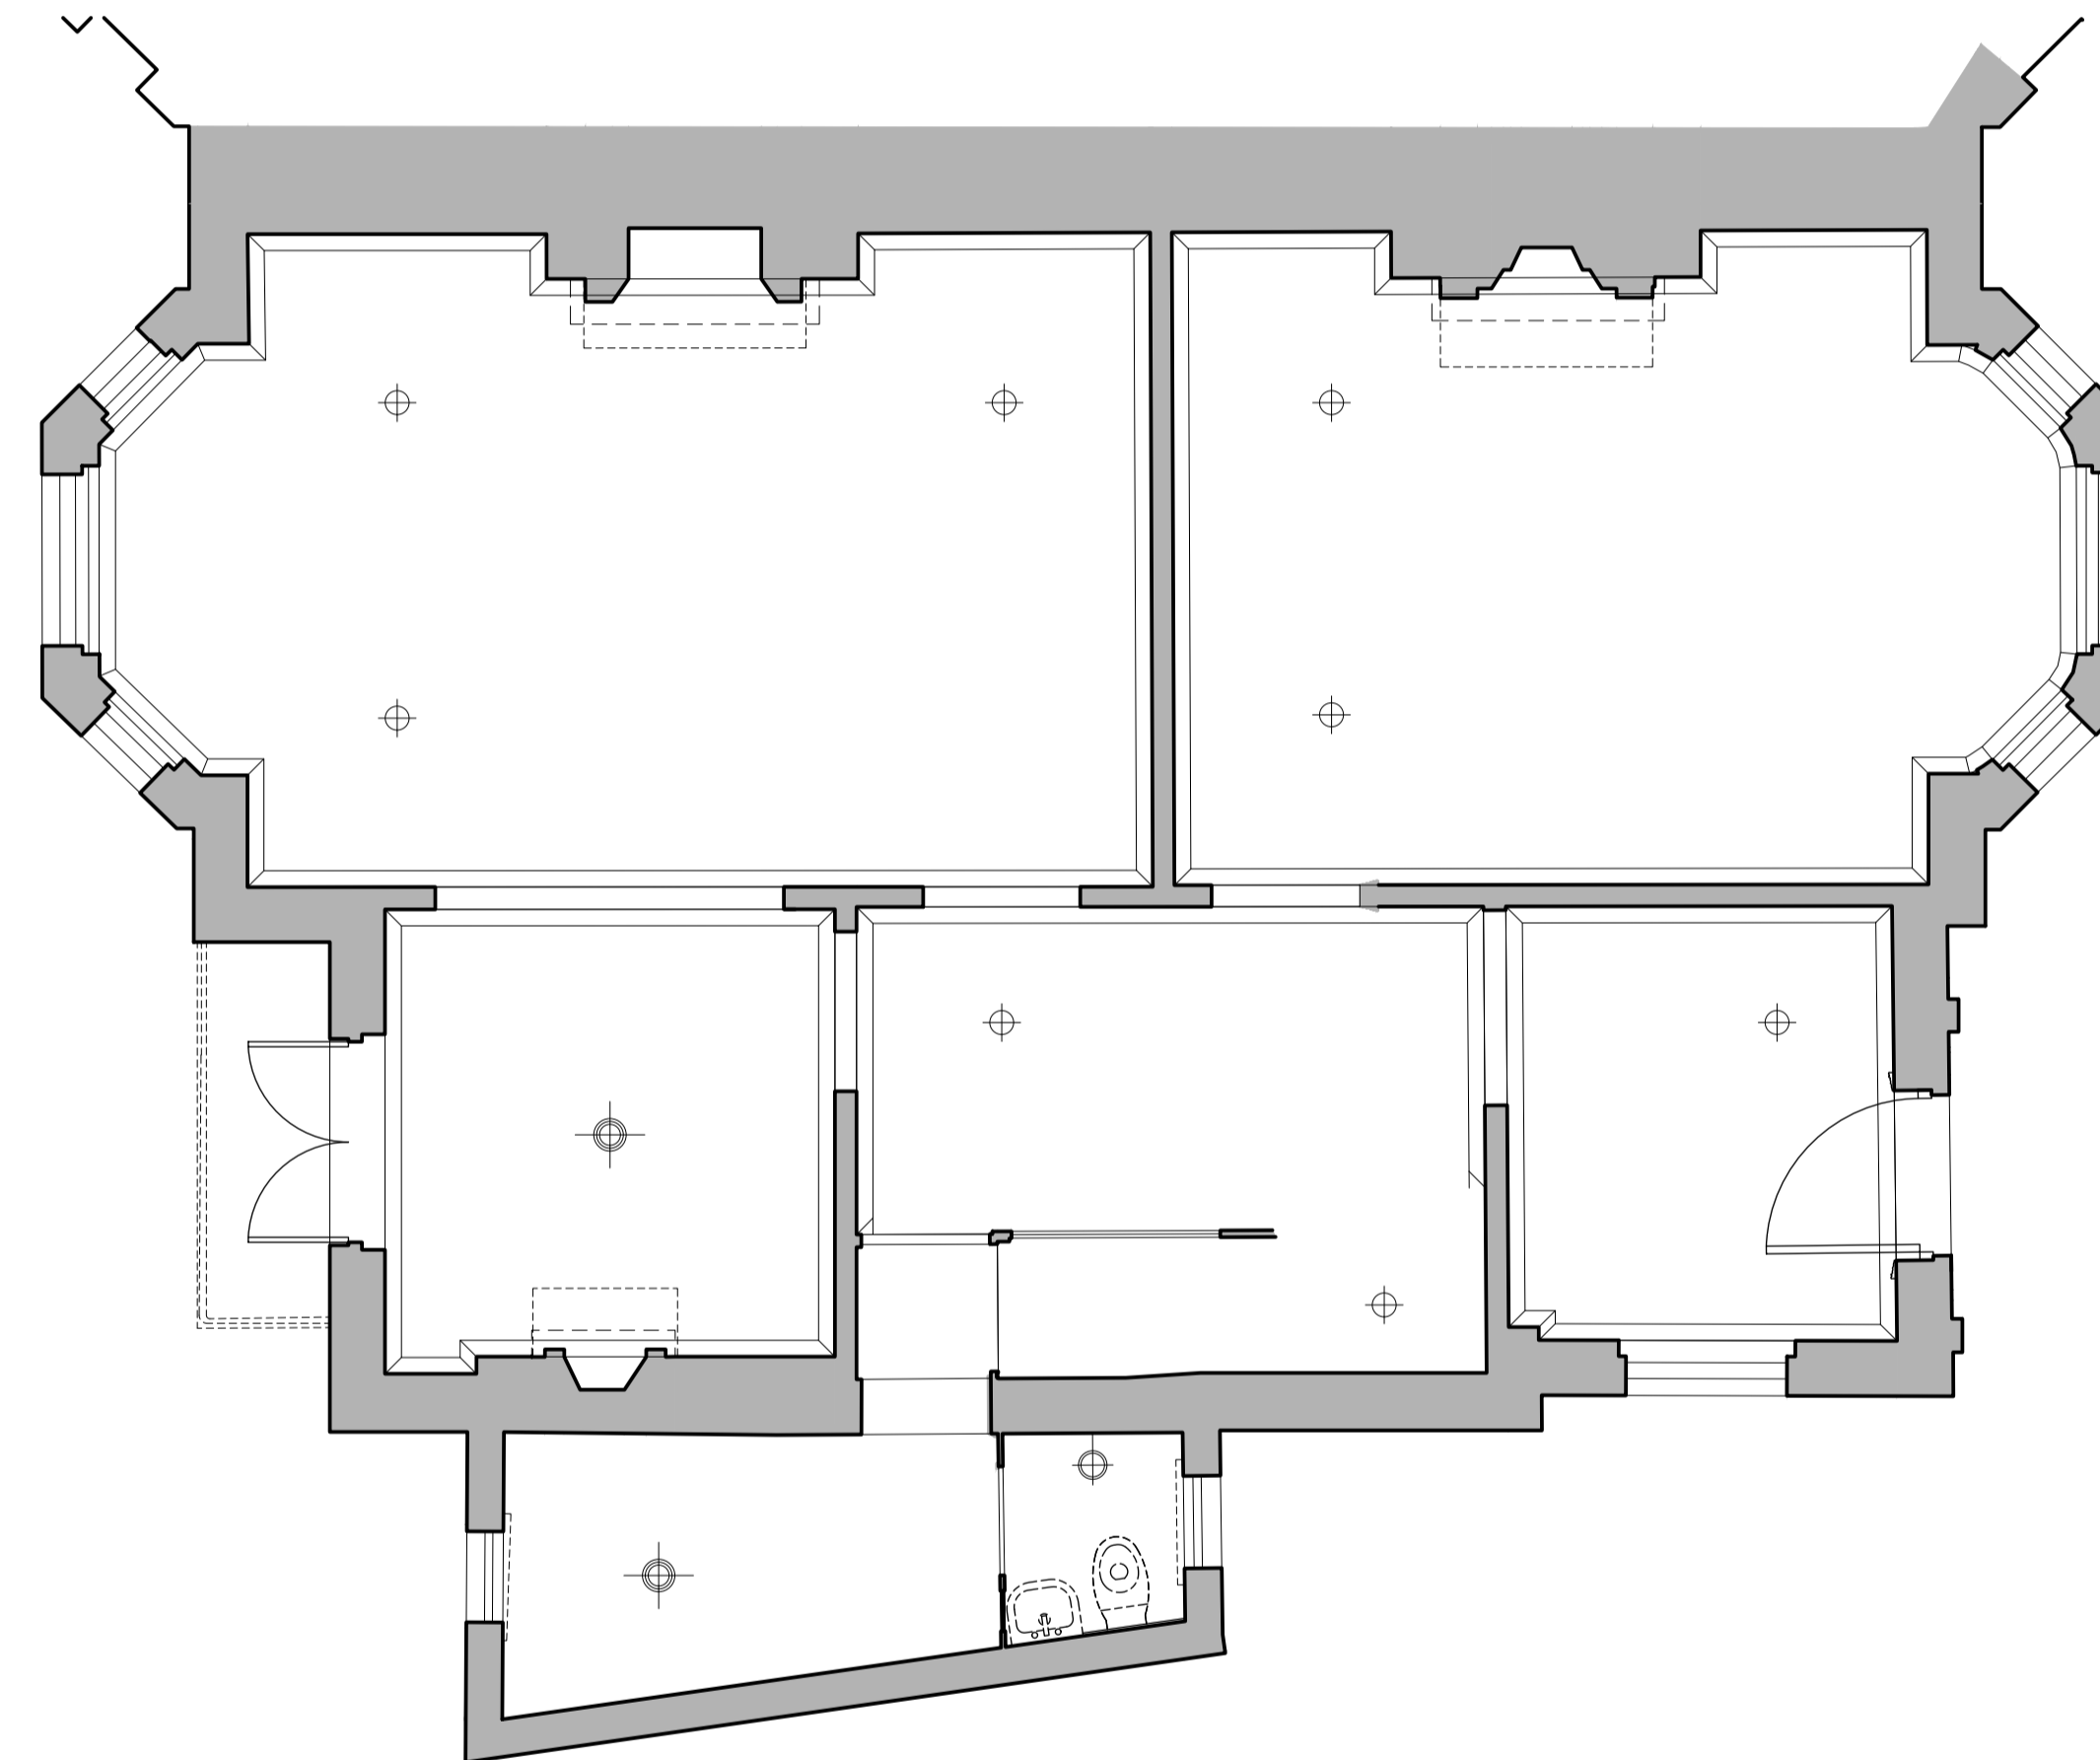

2 EXISTING GROUND FLOOR LIGHTING PLAN
scale 1:50



No	Rev	Date
A	-	22.03.2024
		18.08.2023

PLANNING



ARCHITECTS + INTERIOR DESIGNERS

91A - 91B HEATH STREET
LONDON NW3 6SS
Tel 020 7636 3838

INFO WWW.TG-STUDIO.CO.UK

Project: 9 GAINSBOROUGH GARDENS
NW3 1BJ

Date	18.08.23	Scale @ A1	1:50
------	----------	------------	------

Drawing: EXISTING LOWER GROUND & GROUND FLOOR RCP LIGHTING PLAN

Drawn by	AL	Checked by	TG
----------	----	------------	----

Job No.	270	Dwg No.	P-400	Rev	A
---------	-----	---------	-------	-----	---