


LEGEND	
SYMBOL	DESCRIPTION
	EXISTING RECESSED DOWN LIGHT
	EXISTING WALL LIGHT
	EXISTING SUSPENDED PENDANT LIGHT
	EXISTING SURFACE MOUNT LINEAR LIGHT
	EXISTING SURFACE MOUNT DOWN LIGHT
	EXISTING SURFACE MOUNT ADJUSTABLE DOWN LIGHT


This drawing is protected under Copyright and at no time should any portion of this drawing be reproduced or copied without the permission of the Architect. (Design Copyright Act 1968)

This drawing must not be used for purposes other than that for which it is provided. It is supplied without liability for any errors or omissions.

Drawings only to be scaled for planning application purposes, all dimensions to be checked on site. All drawings subject to Statutory Authority Approval.

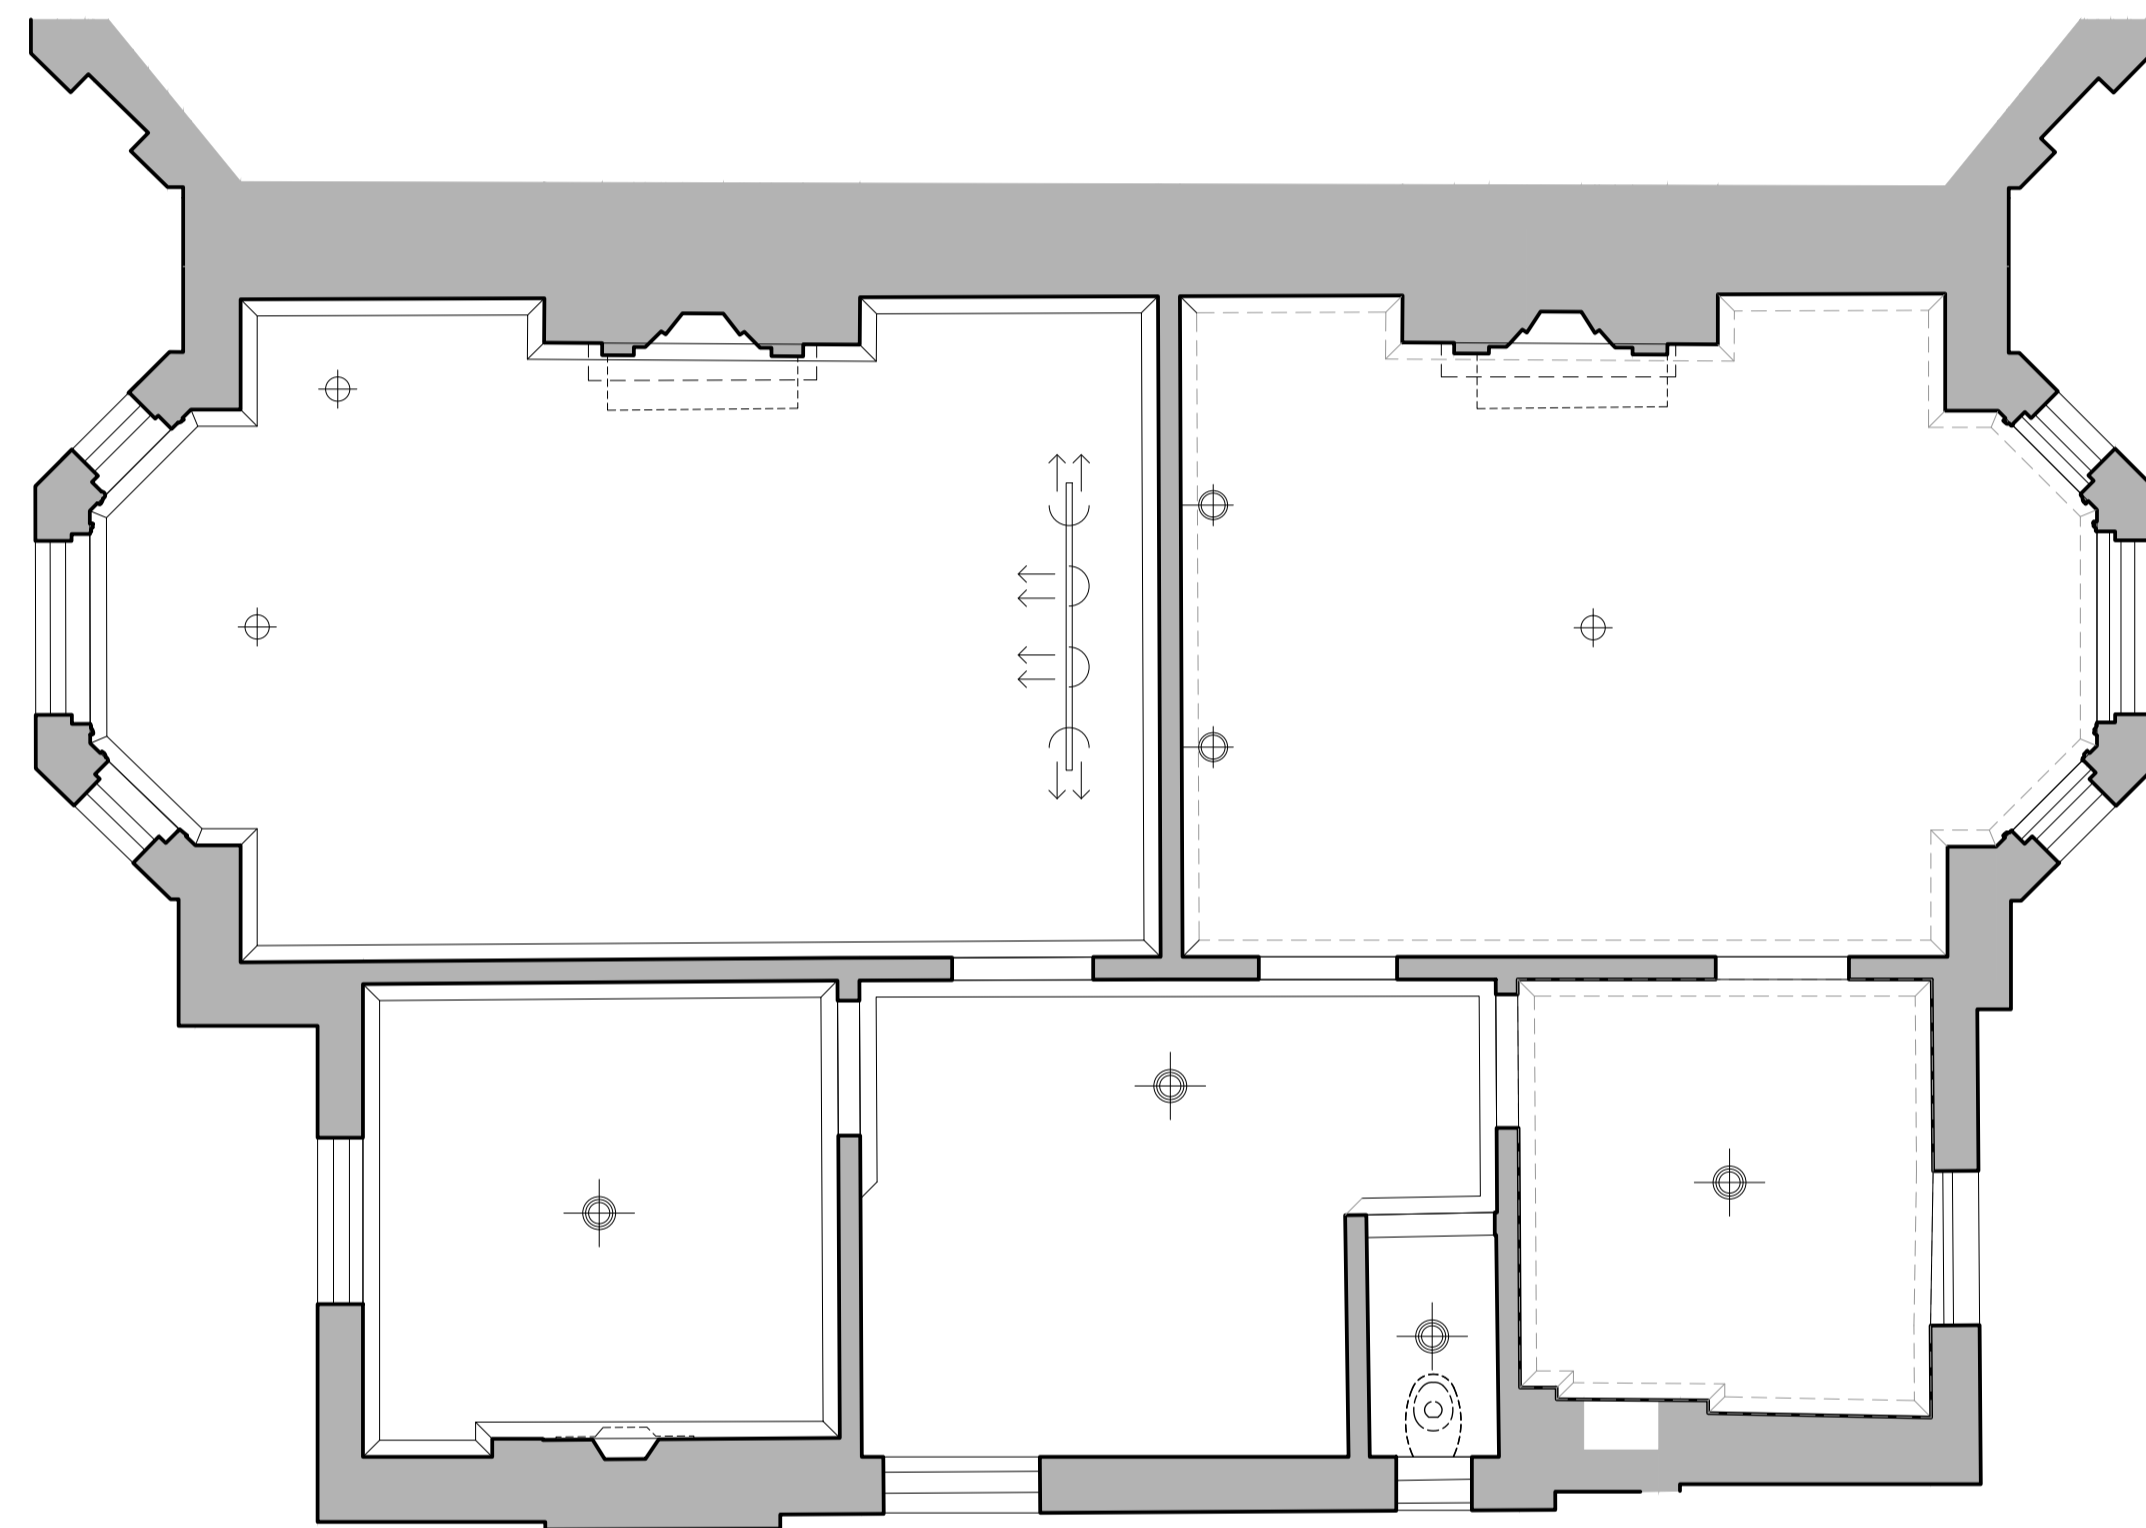

1 EXISTING FIRST FLOOR RCP LIGHTING PLAN
scale 1:50

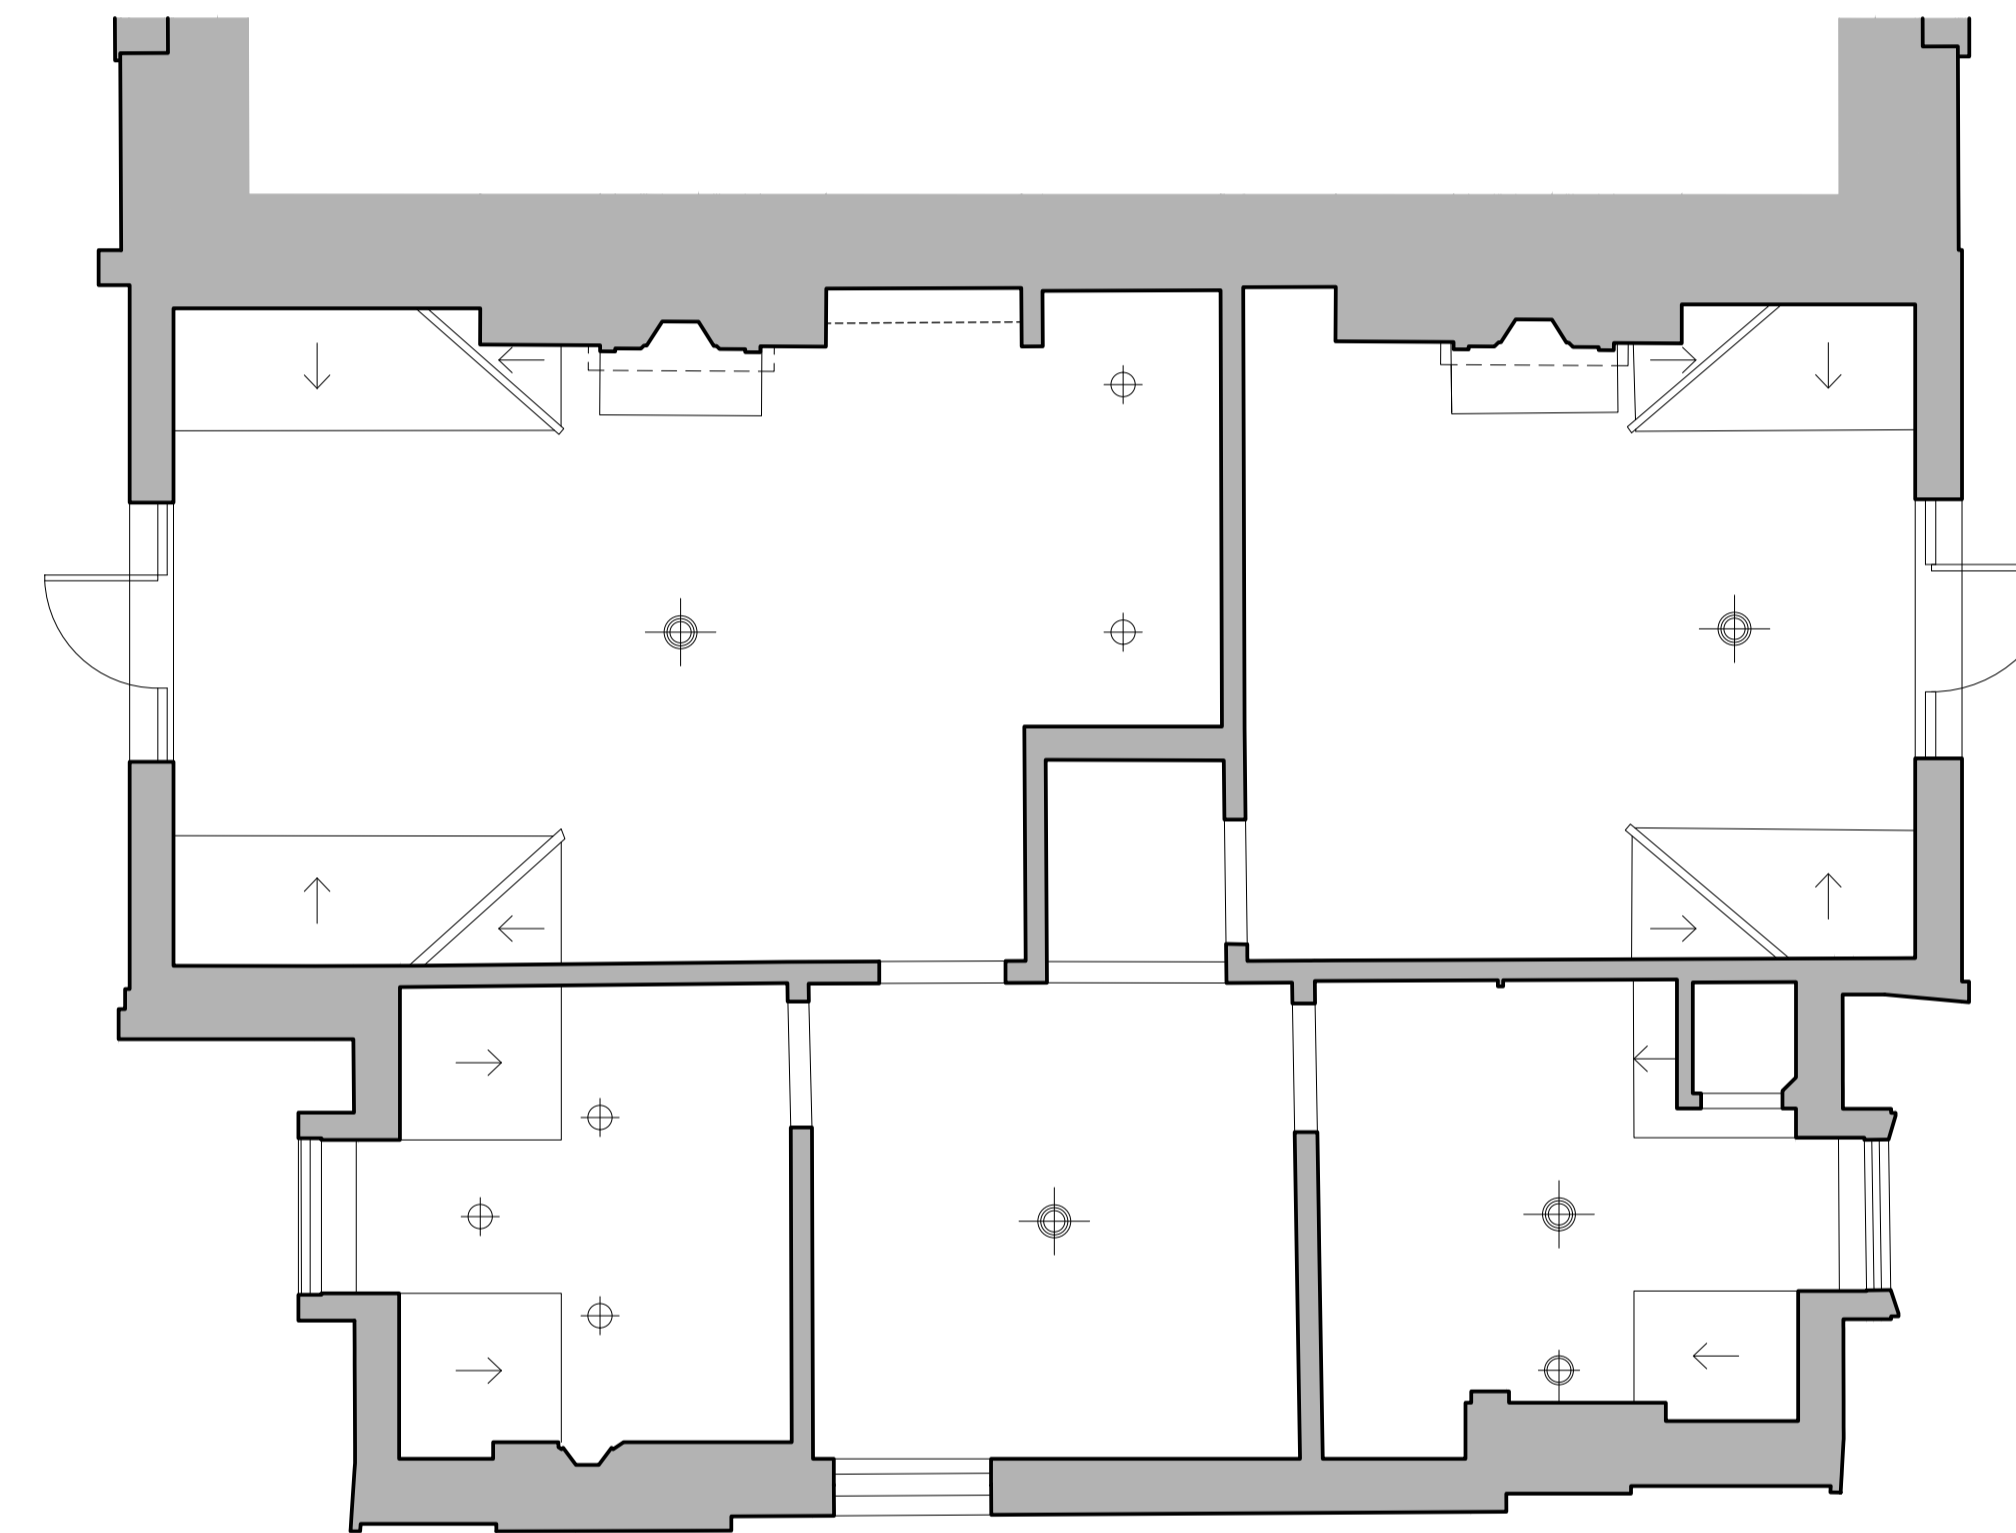

2 EXISTING SECOND FLOOR RCP LIGHTING PLAN
scale 1:50



No	Rev	Date
A	AMENDMENTS	22.03.2024
-	PLANNING	18.08.2023

Status **PLANNING**



ARCHITECTS + INTERIOR DESIGNERS

91A - 91B HEATH STREET
LONDON NW3 6SS
Tel 020 7636 3838

INFO WWW.TG-STUDIO.CO.UK

Project: 9 GAINSBOROUGH GARDENS
NW3 1BJ

Date	Scale @ A1
18.08.23	1:50

Drawing: EXISTING
FIRST & SECOND FLOOR
RCP LIGHTING PLAN

Drawn by	Checked by
AL	TG

Job No.	Dwg No.	Rev
270	P-401	A