

NOTE: All ceilings are original lath and plaster ceilings

LEGEND	
SYMBOL	DESCRIPTION
	EXISTING RECESSED DOWN LIGHT
	EXISTING WALL LIGHT
	EXISTING SUSPENDED PENDANT LIGHT
	EXISTING SURFACE MOUNT LINEAR LIGHT
	EXISTING SURFACE MOUNT DOWN LIGHT
	NEW RECESSED DOWN LIGHT
	NEW WALL LIGHT
	NEW SUSPENDED PENDANT LIGHT
	NEW SURFACE MOUNT LINEAR LIGHT
	NEW SURFACE MOUNT DOWN LIGHT

This drawing is protected under Copyright and at no time should any portion of this drawing be reproduced or copied without the permission of the Architect. (Design Copyright Act 1968)

This drawing must not be used for purposes other than that for which it is provided. It is supplied without liability for any errors or omissions.

Drawings only to be scaled for planning application purposes, all dimensions to be checked on site. All drawings subject to Statutory Authority Approval.

No	Rev	Date
A	AMENDMENTS	22.03.2024
-	PLANNING	18.08.2023

Status: PLANNING



ARCHITECTS + INTERIOR DESIGNERS

91A - 91B HEATH STREET  
LONDON NW3 6SS  
Tel 020 7636 3838

INFO WWW.TG-STUDIO.CO.UK


Project: 9 GAINSBOROUGH GARDENS  
NW3 1BJ

Date: 18.08.23  
Scale @ A1: 1:50


Drawing: PROPOSED  
FIRST & SECOND FLOOR  
RCP LIGHTING PLAN

Drawn by: AL  
Checked by: TG

Job No.: 270  
Dwg No.: P-403  
Rev: A

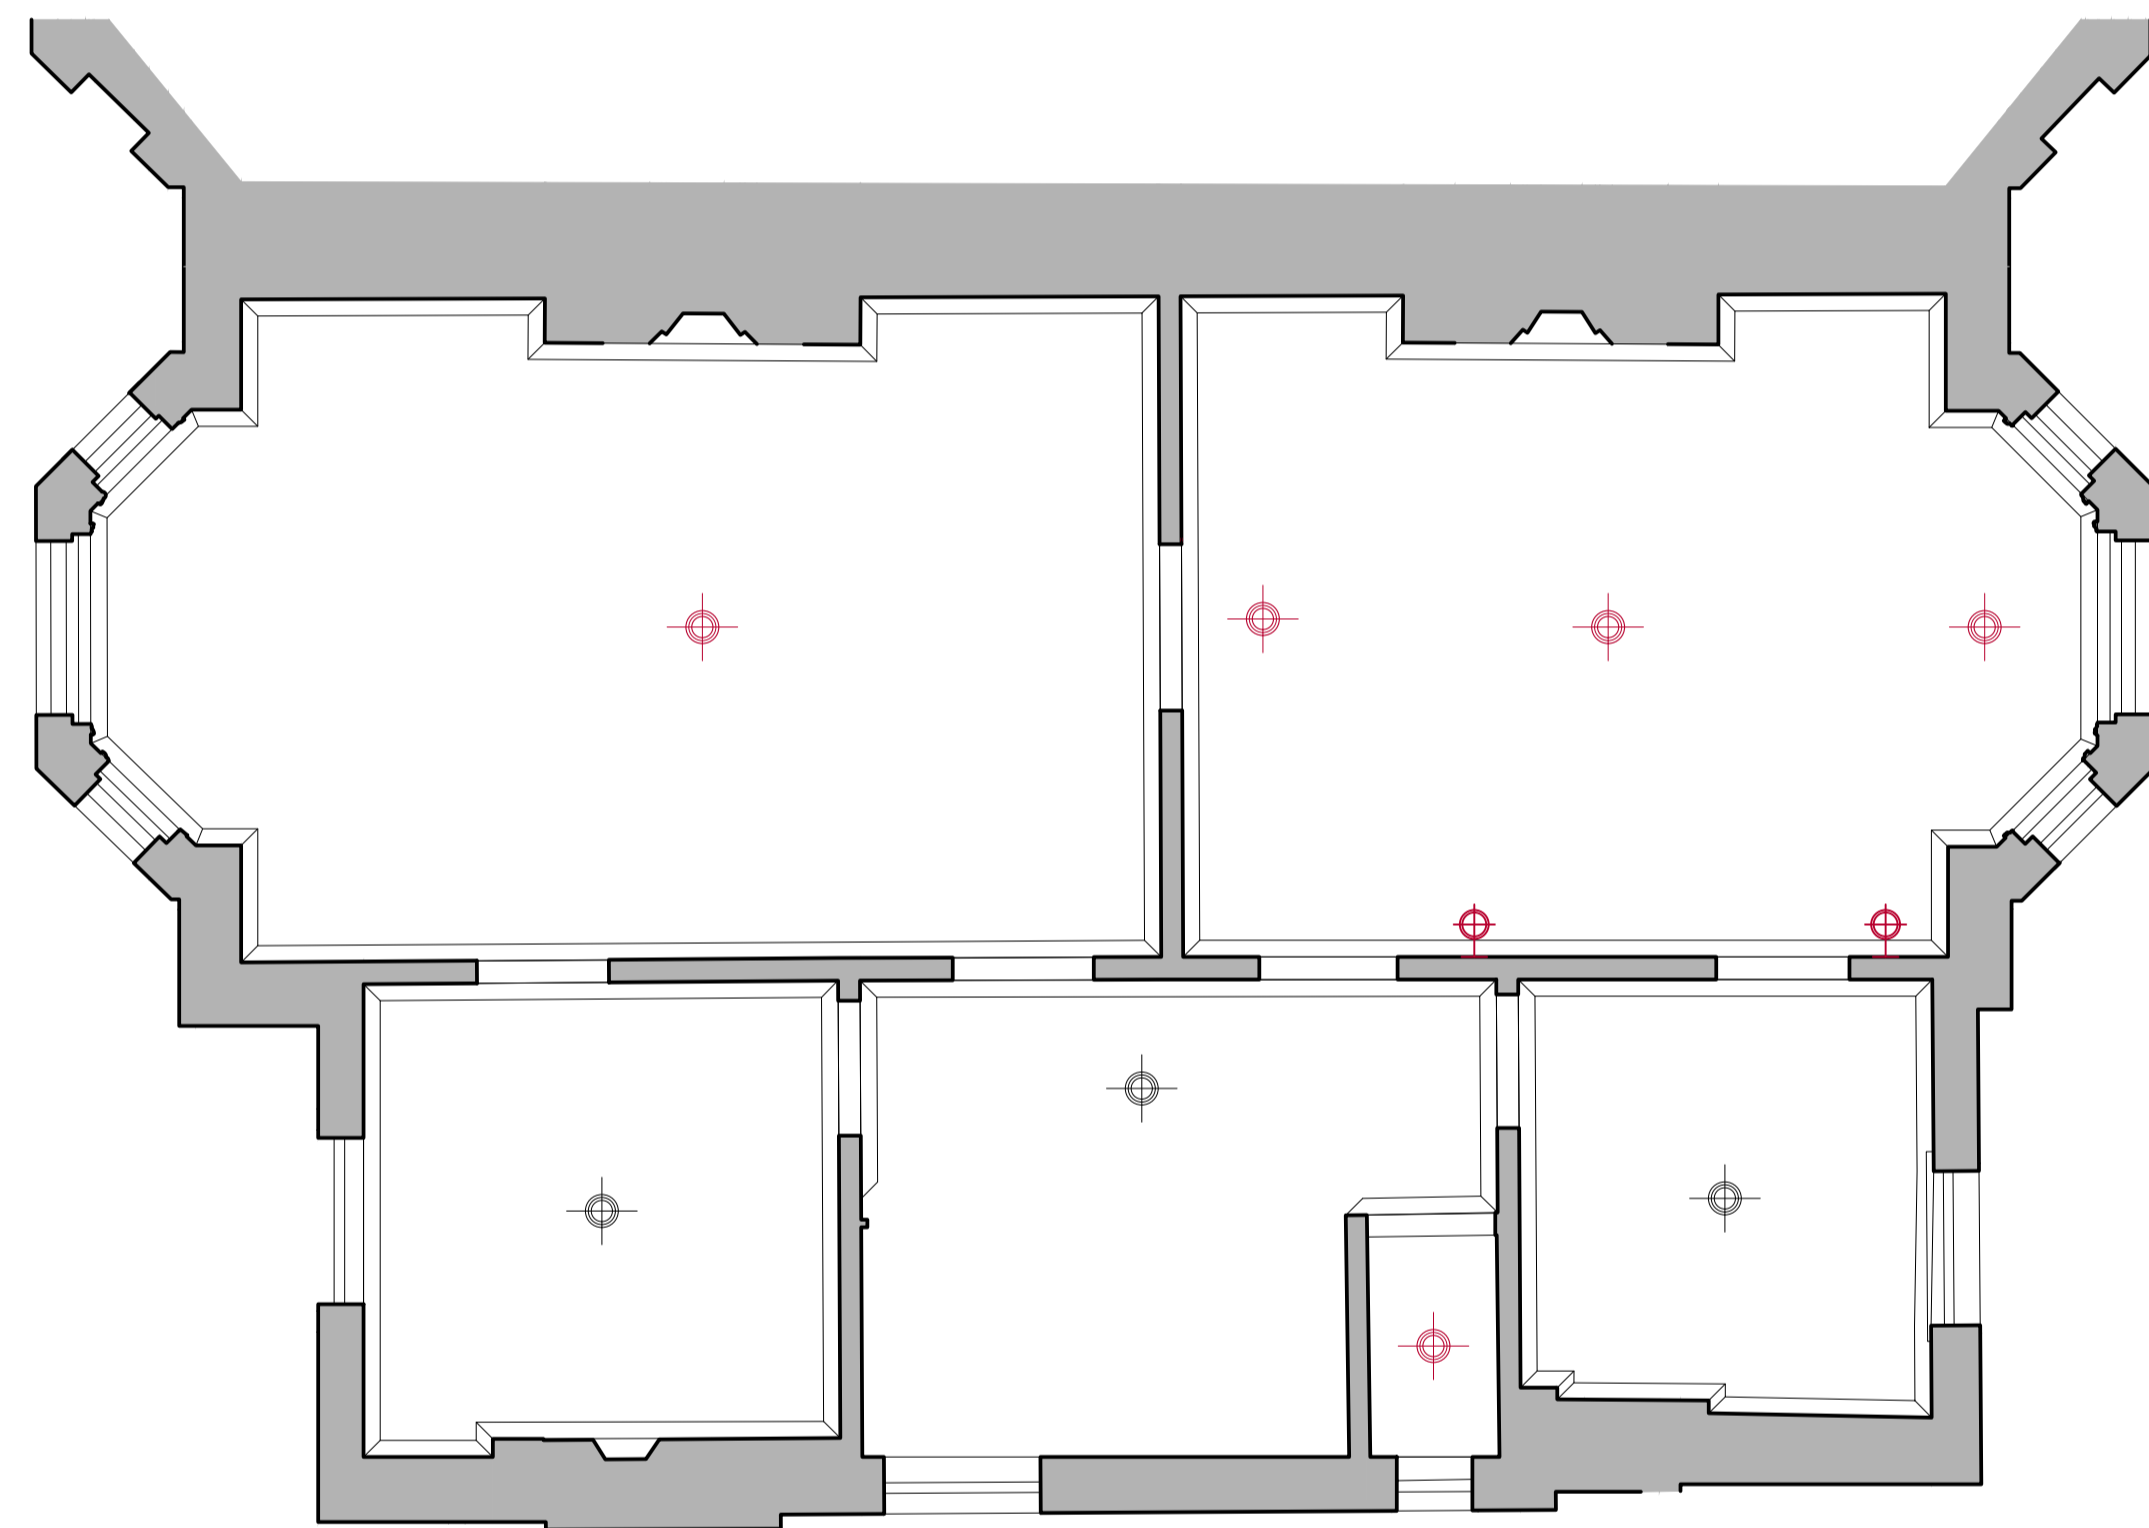

1 PROPOSED FIRST FLOOR RCP LIGHTING PLAN  
scale 1:50

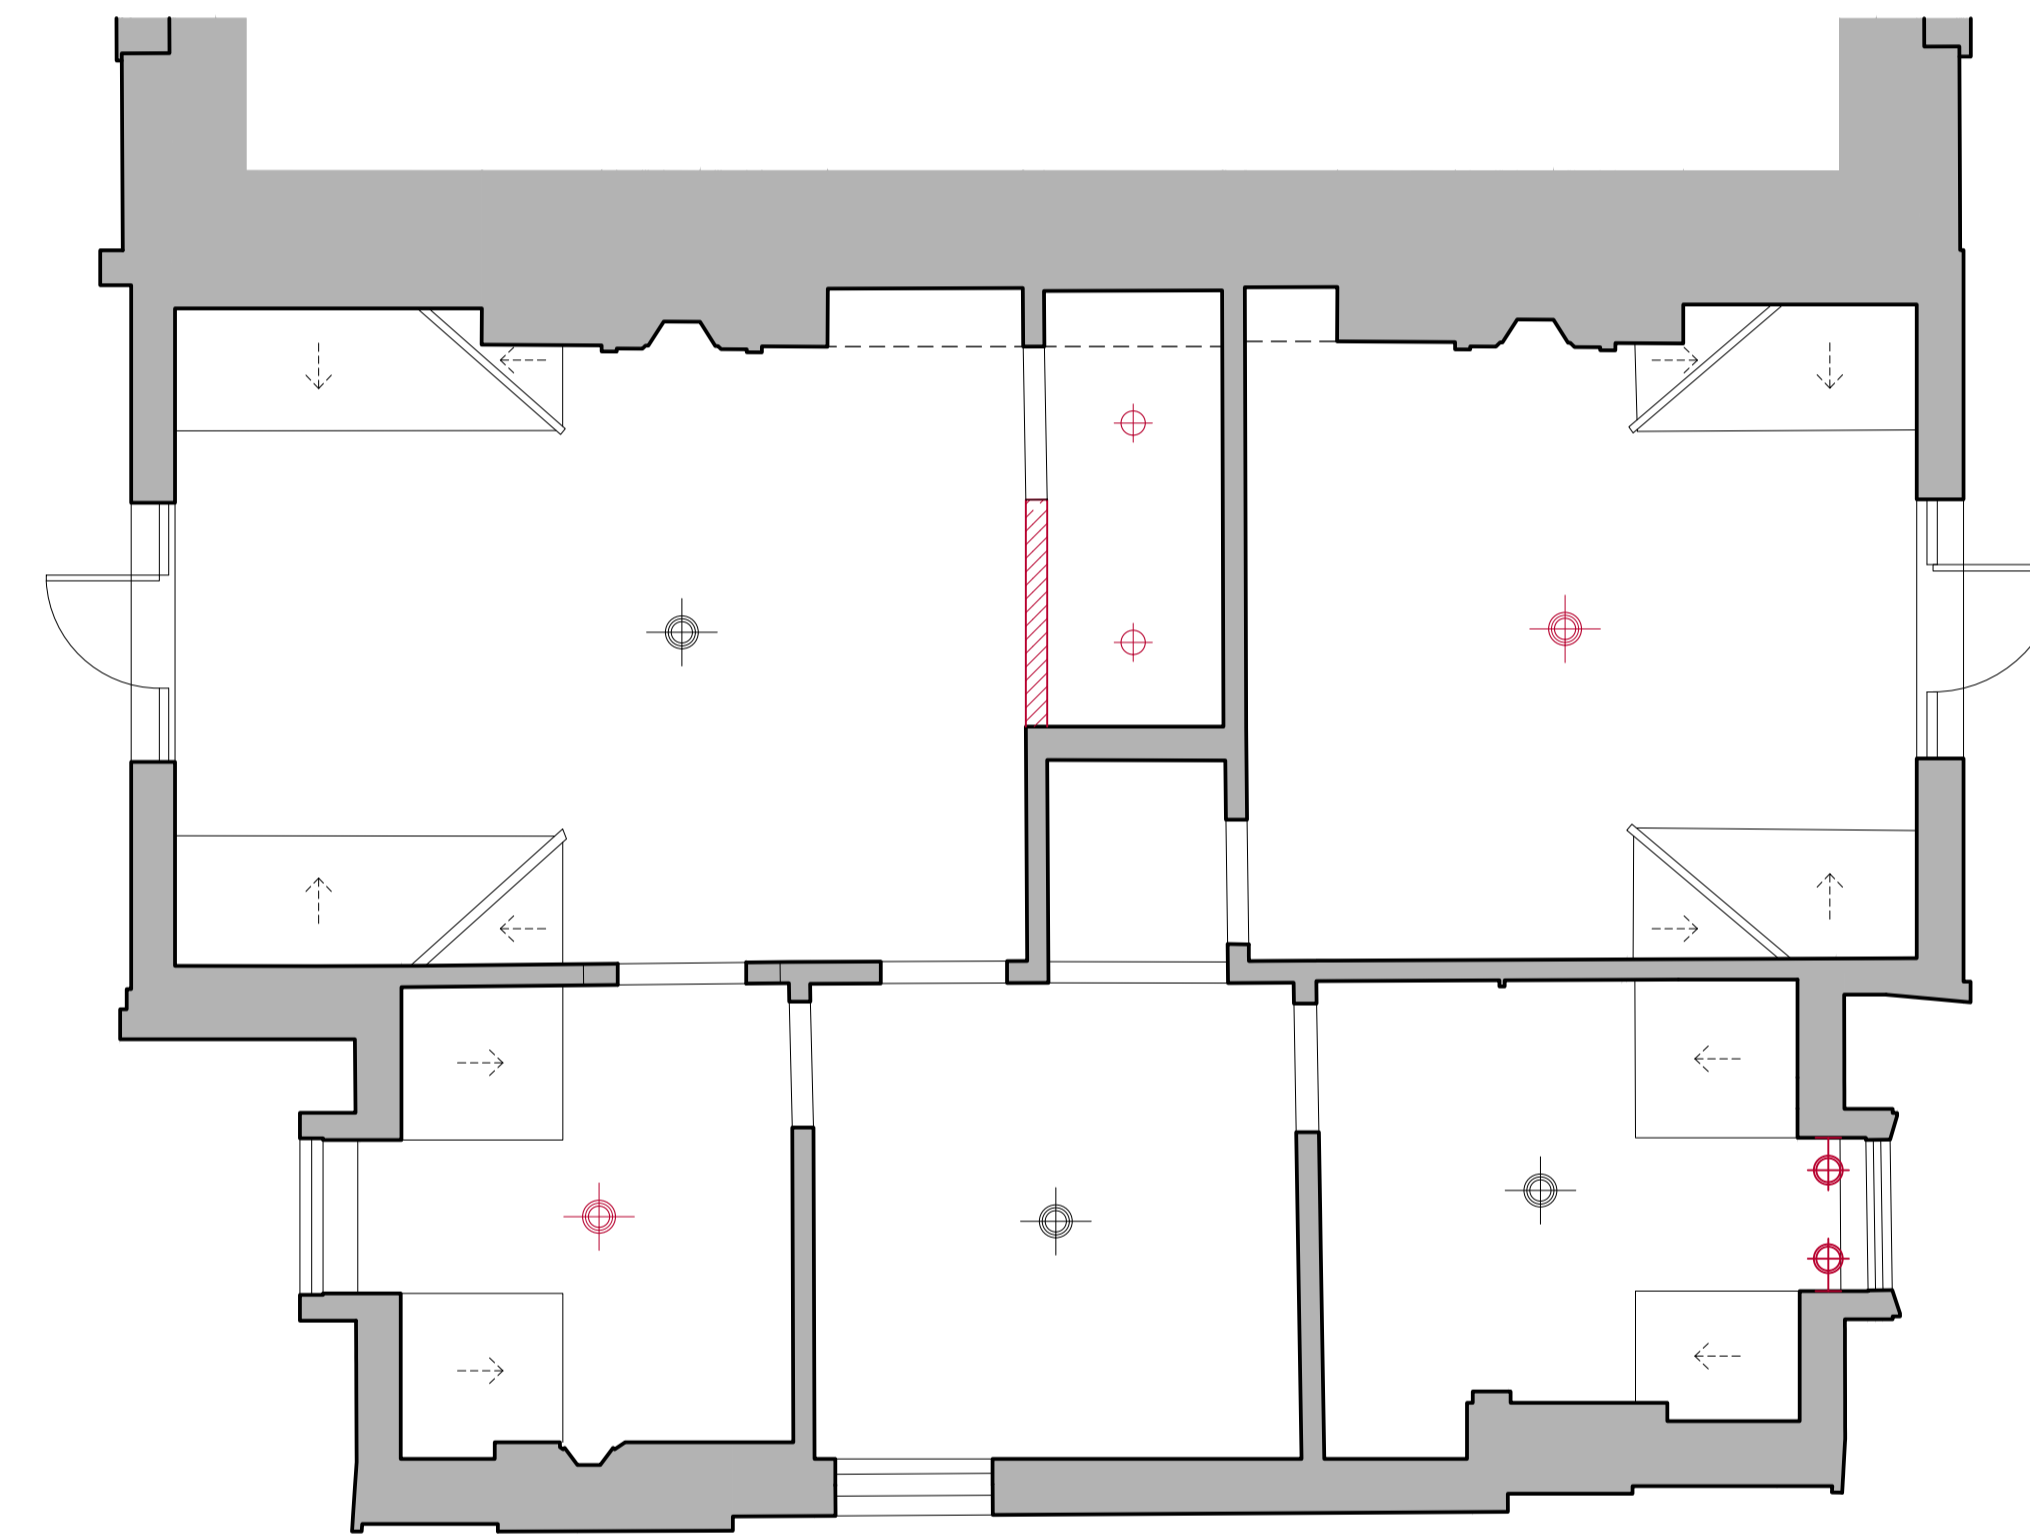

2 PROPOSED SECOND FLOOR RCP LIGHTING PLAN  
scale 1:50

