

LOWER GROUND FLOOR PLAN

C	MINOR AMENDMENT - ISSUED	05.02.2024
B	UPDATED AS PER COMMENTS	14.10.2023
REV	DESCRIPTION	DATE

Purpose of Issue MINOR-AMENDMENT		
Drawn	-	Checked -
Date	27.06.23	
Scale	1:50	@A3
Project Number	4033	Sheet Number DR-03-005
		Rev C




PROJECT:
 10 Thanet St. London WC1H 9QL

DRAWING NAME:
 Proposed Lower Ground Floor Plan

NOTES:
 Orientated to fit sheet size, 1:50@A3

© Copyright Once Printed and distributed this document is assumed uncontrolled.
 © All rights reserved. No part of this drawing may be reproduced or transmitted in any form by any means without the written permission of the copyright holder.



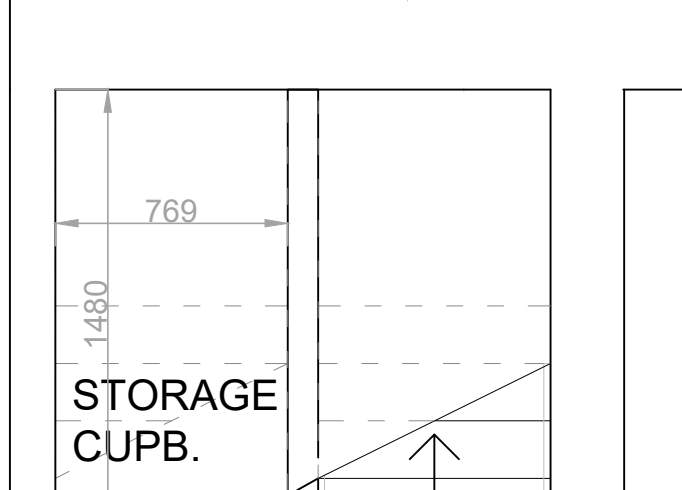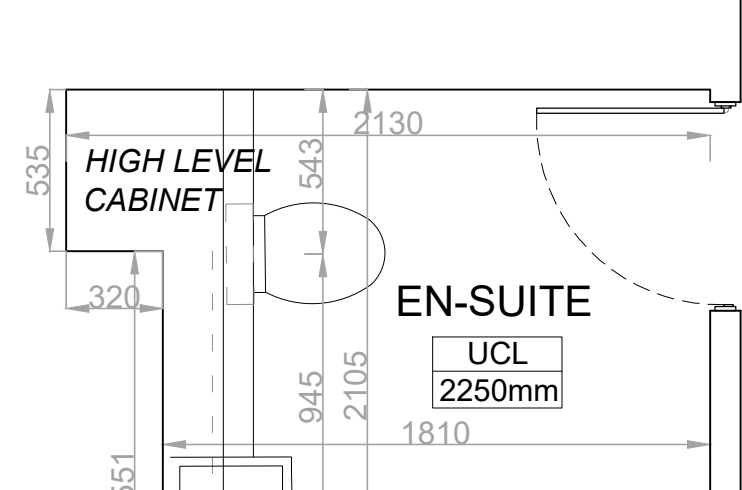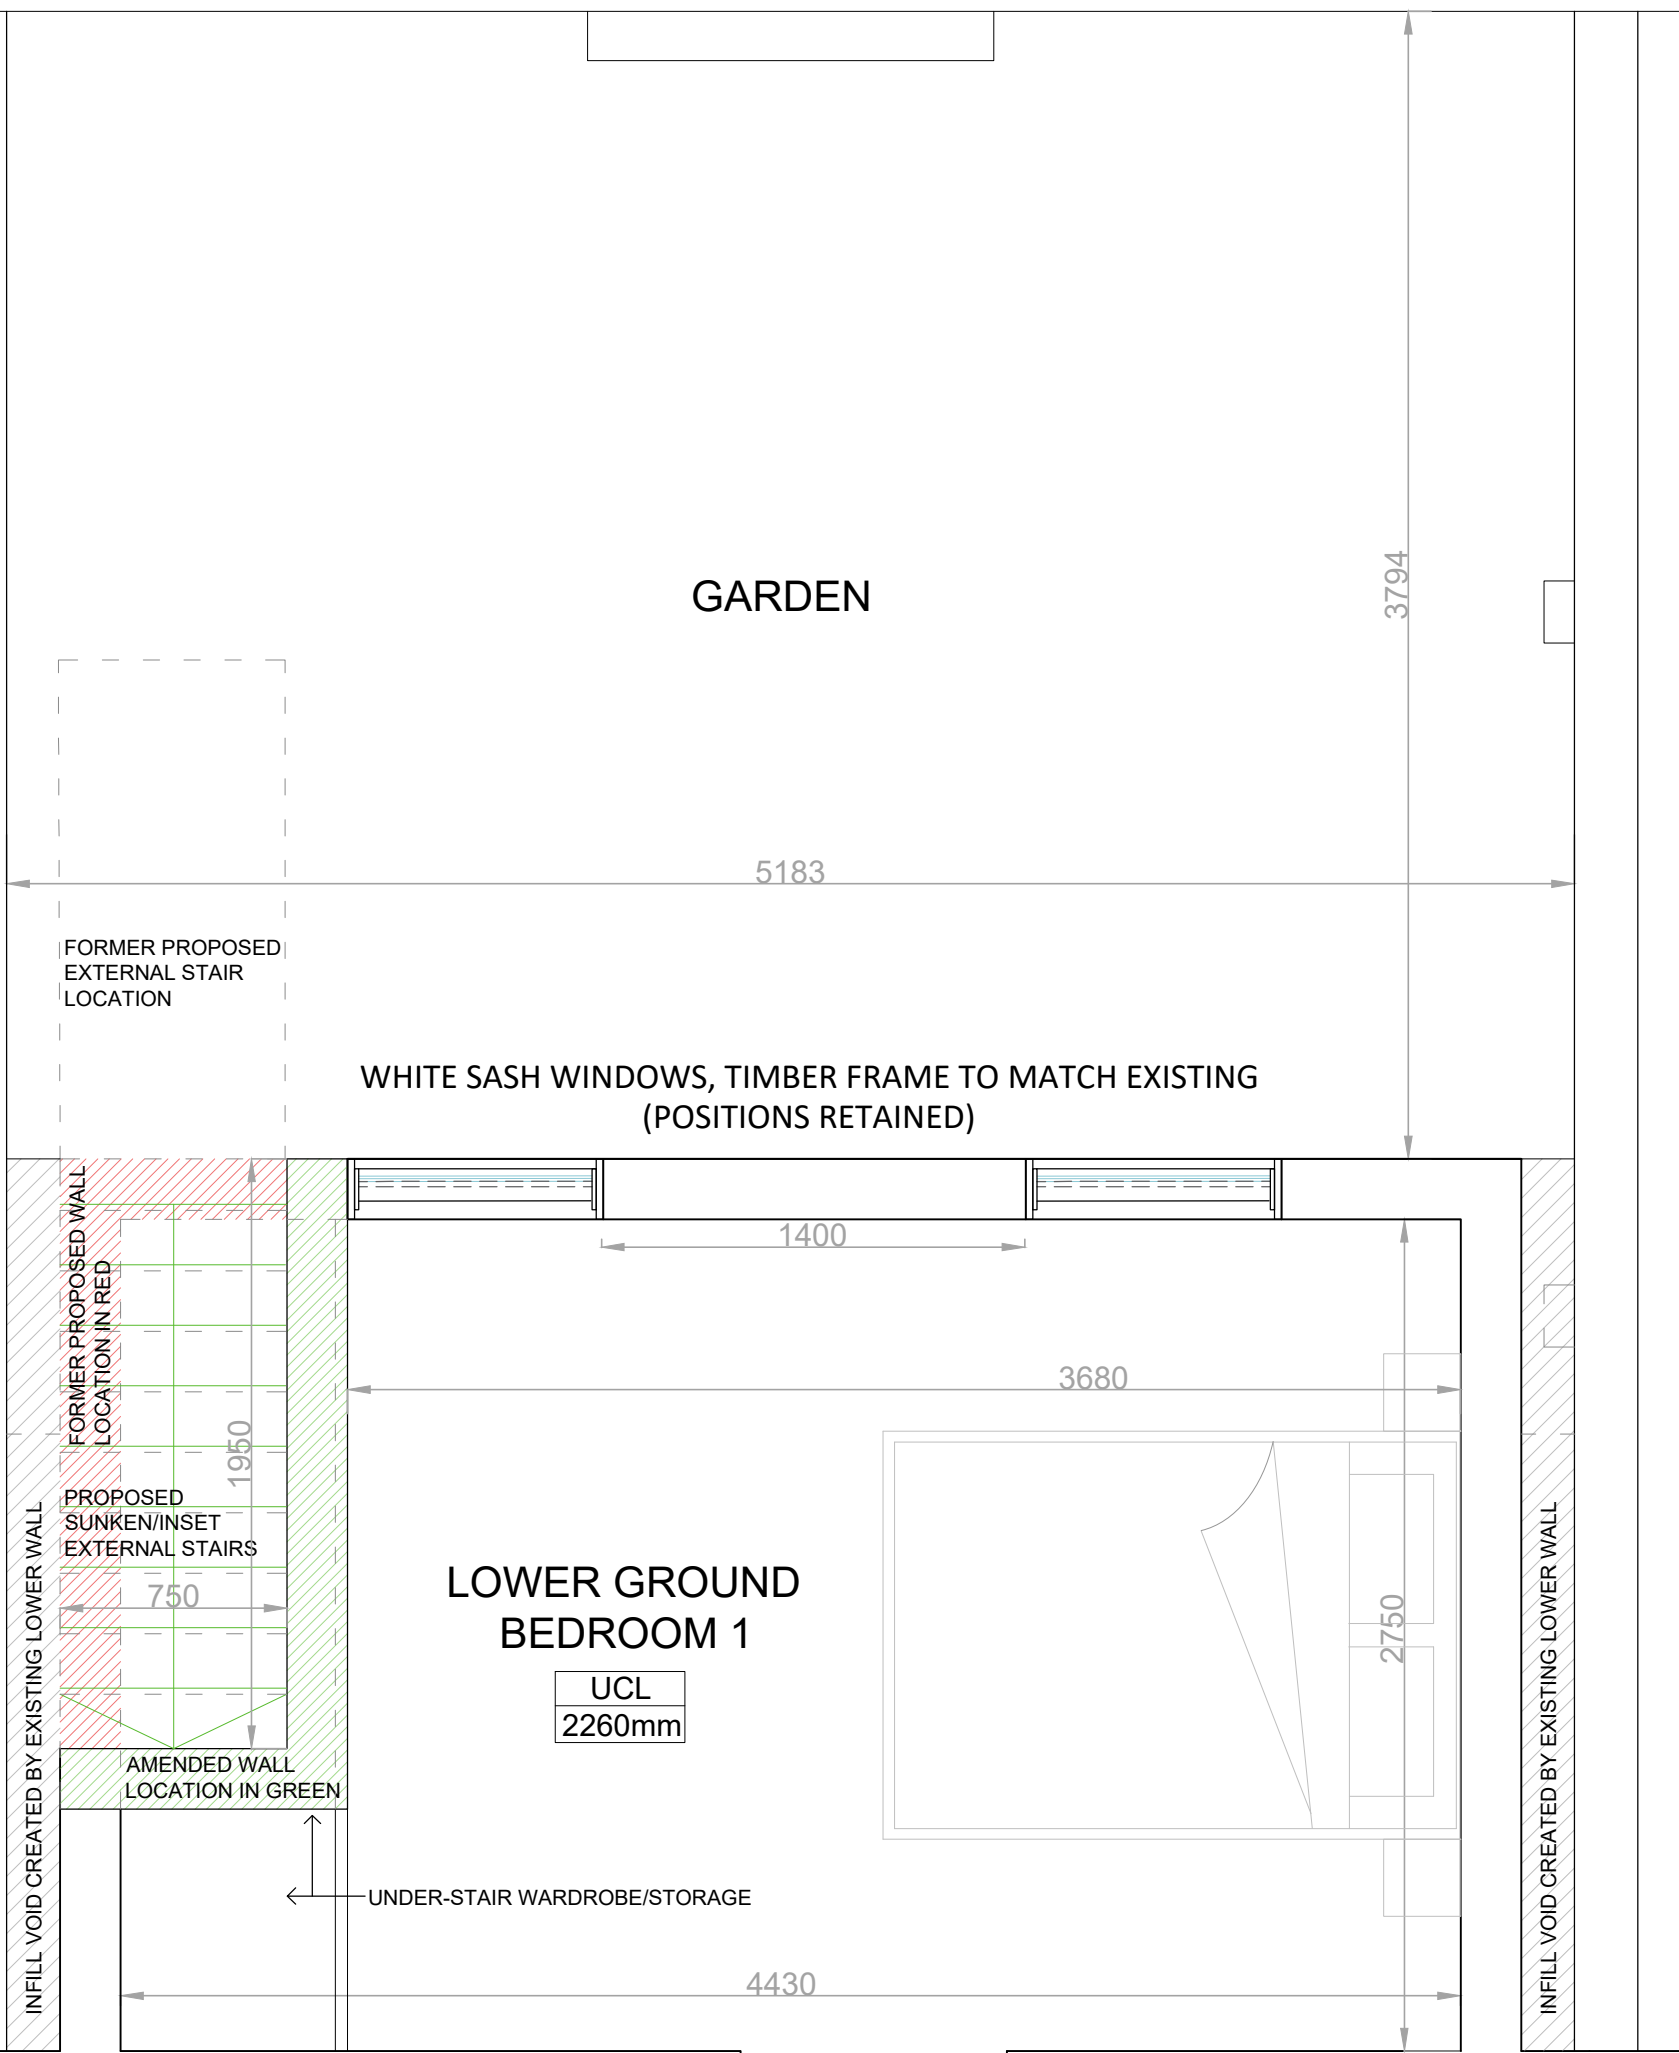


PROJECT:
10 Thanet St. London WC1H 9QL

DRAWING NAME:
Proposed Lower Ground Floor Plan

NOTES:
Orientated to fit sheet size, 1:25@A3

© Copyright Once Printed and distributed this document is assumed uncontrolled.
© All rights reserved. No part of this drawing may be reproduced or transmitted in any form by any means without the written permission of the copyright holder.

A	MINOR AMENDMENT - ISSUED	05.02.2024
REV	DESCRIPTION	DATE
Purpose of Issue MINOR-AMENDMENT		
Drawn	-	Checked -
Date	05.02.2024	
Scale	1:25	@A3
Project Number	Sheet Number	Rev
4033	DR-03-005A	A

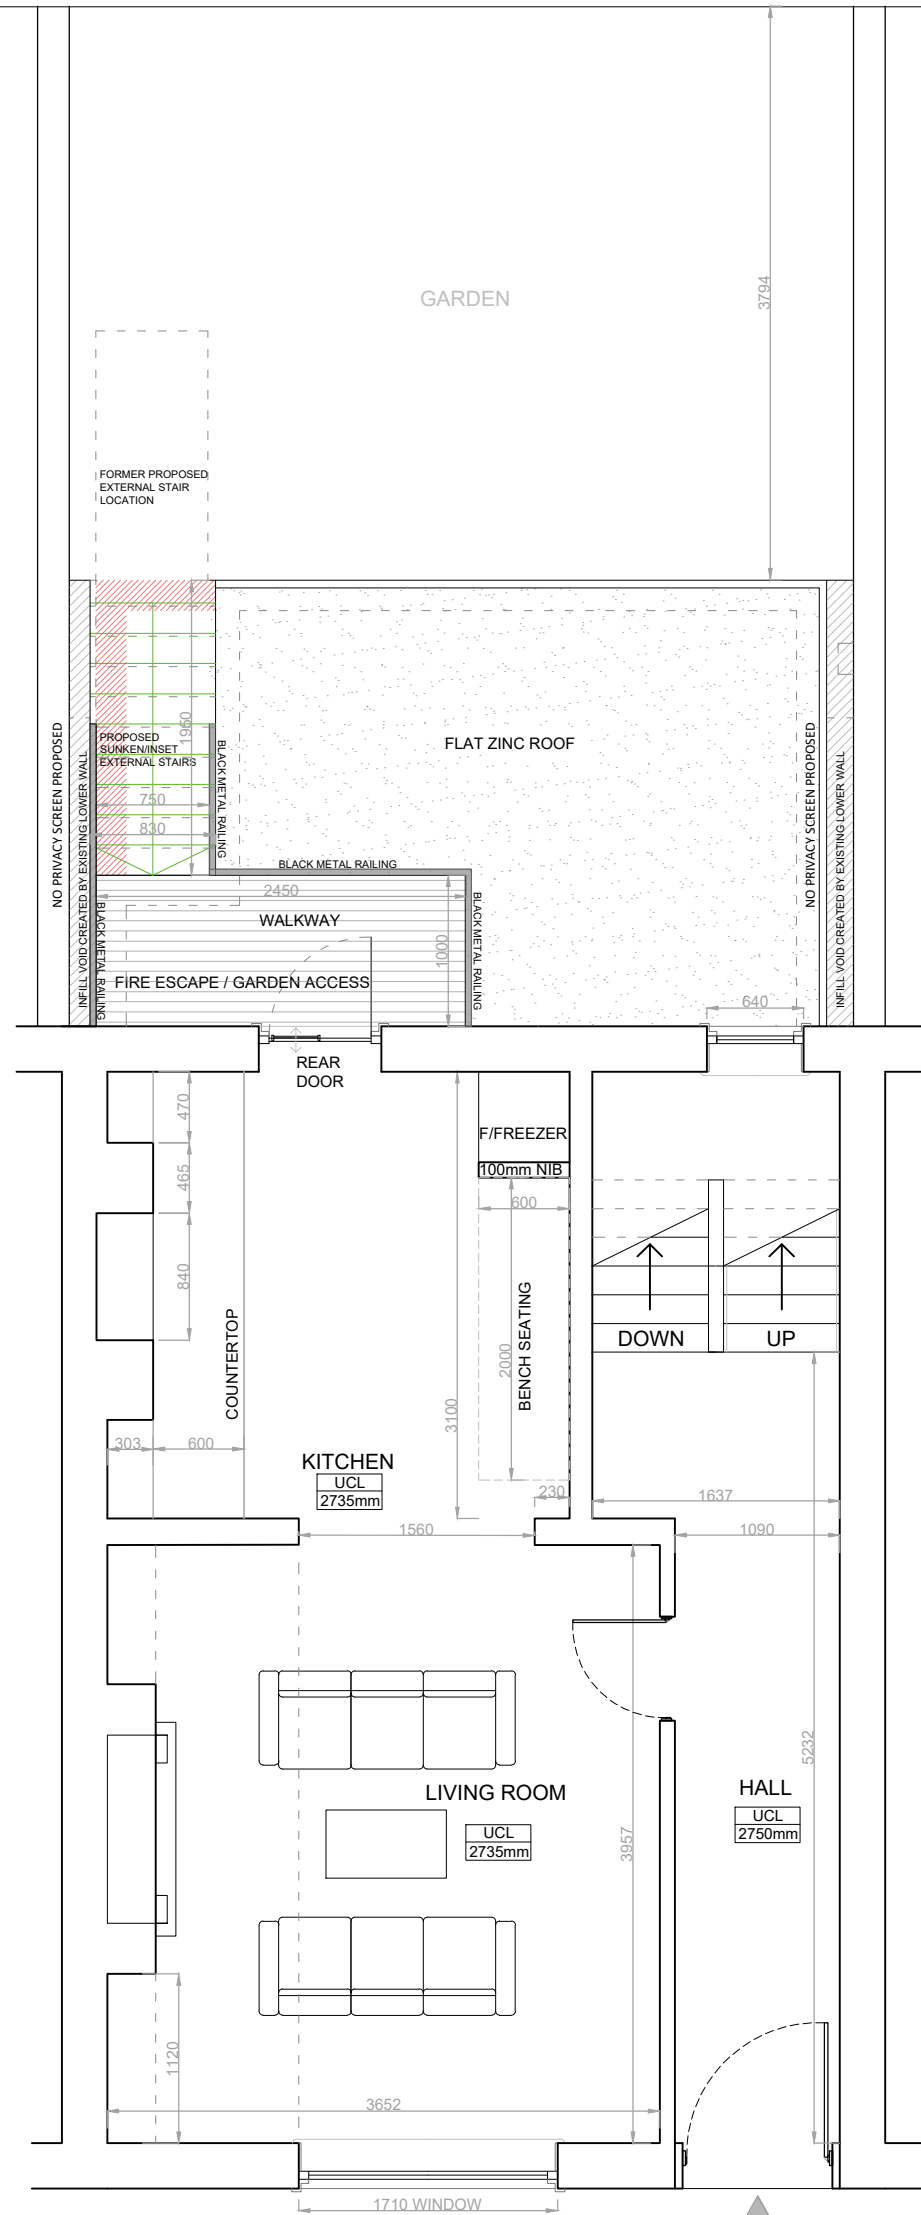

GROUND FLOOR PLAN

21.




PROJECT:
 10 Thanet St. London WC1H 9QL

DRAWING NAME:
 Proposed Ground Floor Plan

NOTES:
 Orientated to fit sheet size, 1:50@A3

© Copyright Once Printed and distributed this document is assumed uncontrolled.
 © All rights reserved. No part of this drawing may be reproduced or transmitted
 in any form by any means without the written permission of the copyright holder.

C	UPDATED INTERNAL OPENING	03.04.2024
REV	DESCRIPTION	DATE
Purpose of Issue MINOR-AMENDMENT		
Drawn	-	Checked -
Date	27.06.23	
Scale	1:50	@A3
Project Number	Sheet Number	Rev
4033	DR-03-006	C

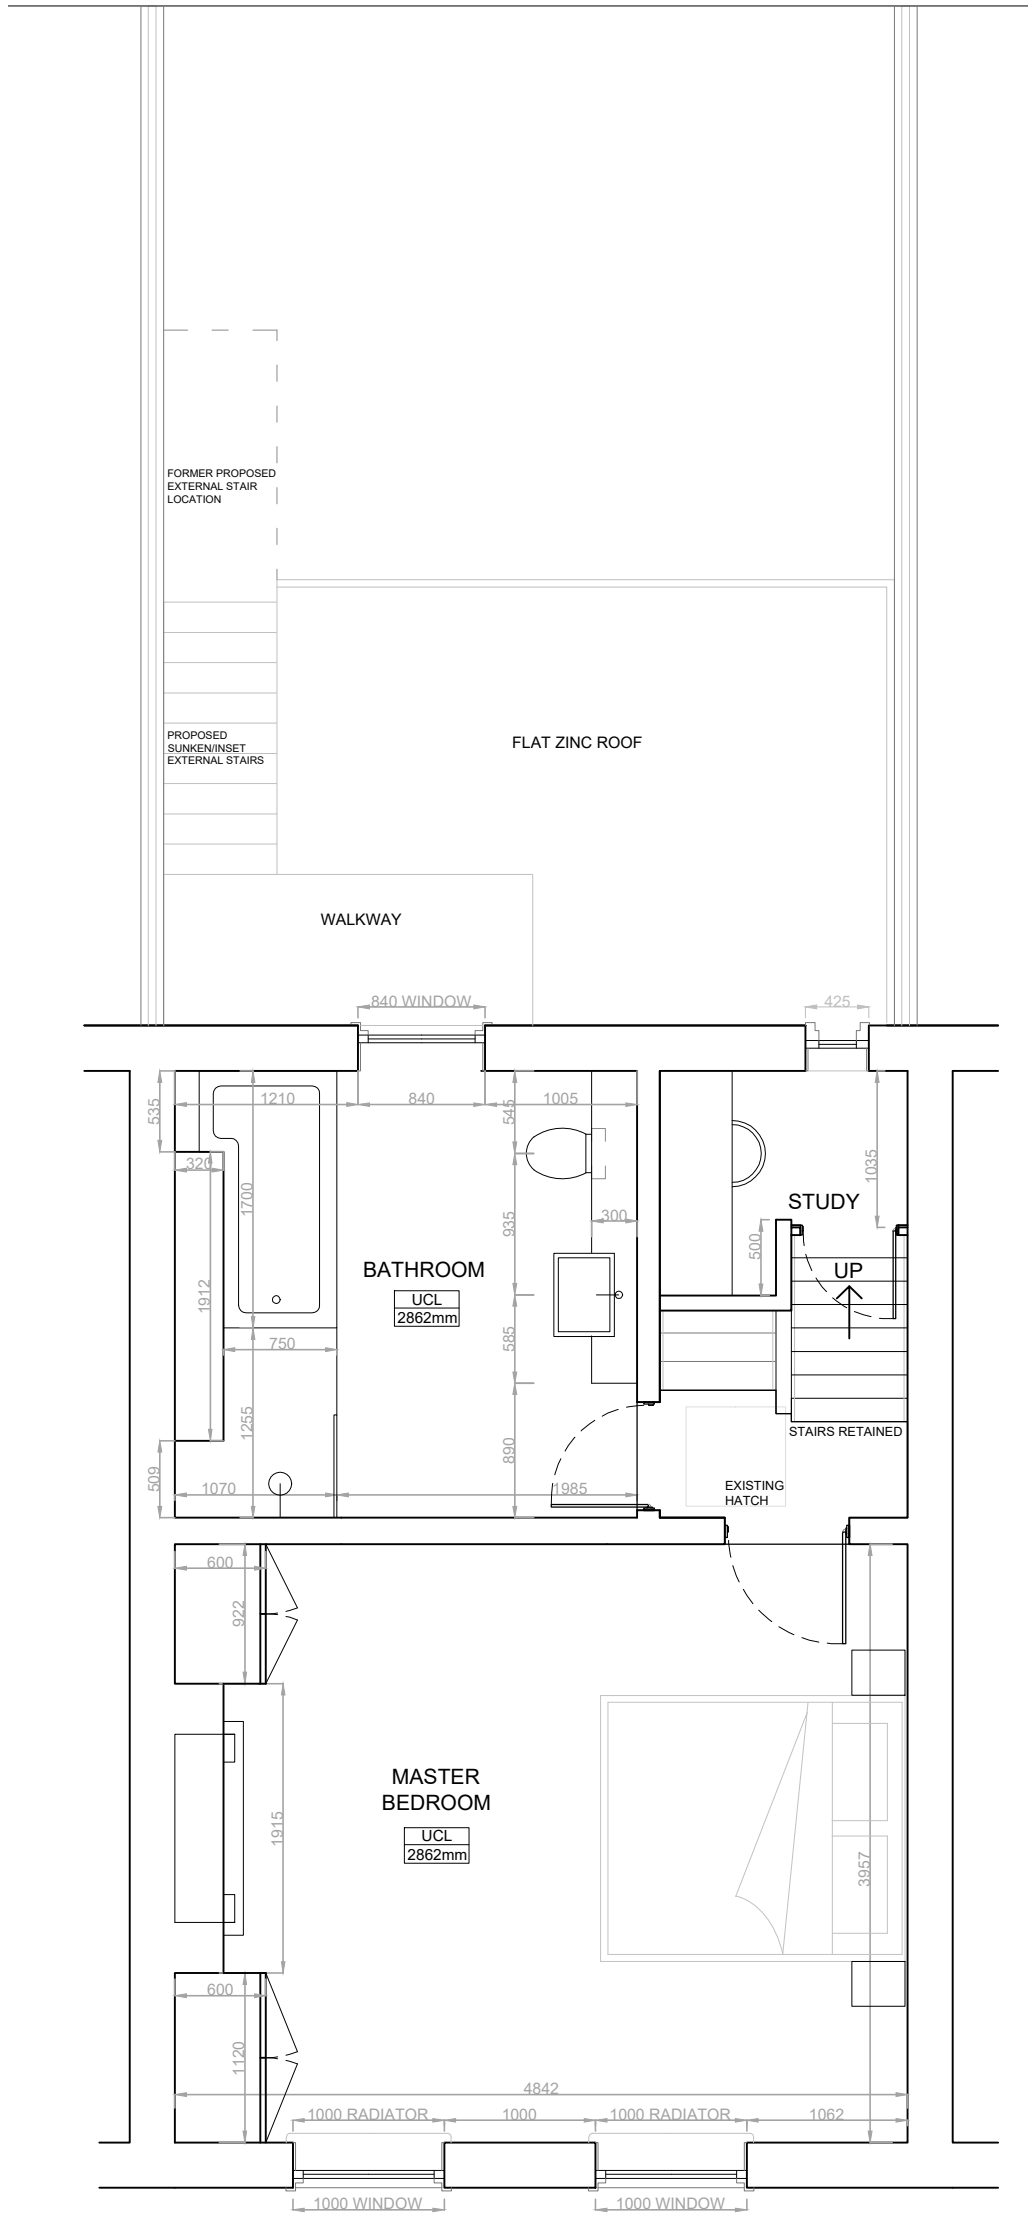

FIRST FLOOR PLAN

C	MINOR AMENDMENT - ISSUED	05.02.2024
B	UPDATED AS PER COMMENTS	14.10.2023
REV	DESCRIPTION	DATE


Purpose of Issue MINOR-AMENDMENT		
Drawn	-	Checked -
Date	27.06.2024	
Scale	1:25	@A3
Project Number	Sheet Number	Rev
4033	DR-03-007	C

PROJECT:
10 Thanet St. London WC1H 9QL

DRAWING NAME:
Proposed First Floor Plan

NOTES:
Orientated to fit sheet size, 1:25@A3

© Copyright Once Printed and distributed this document is assumed uncontrolled.
© All rights reserved. No part of this drawing may be reproduced or transmitted
in any form by any means without the written permission of the copyright holder.

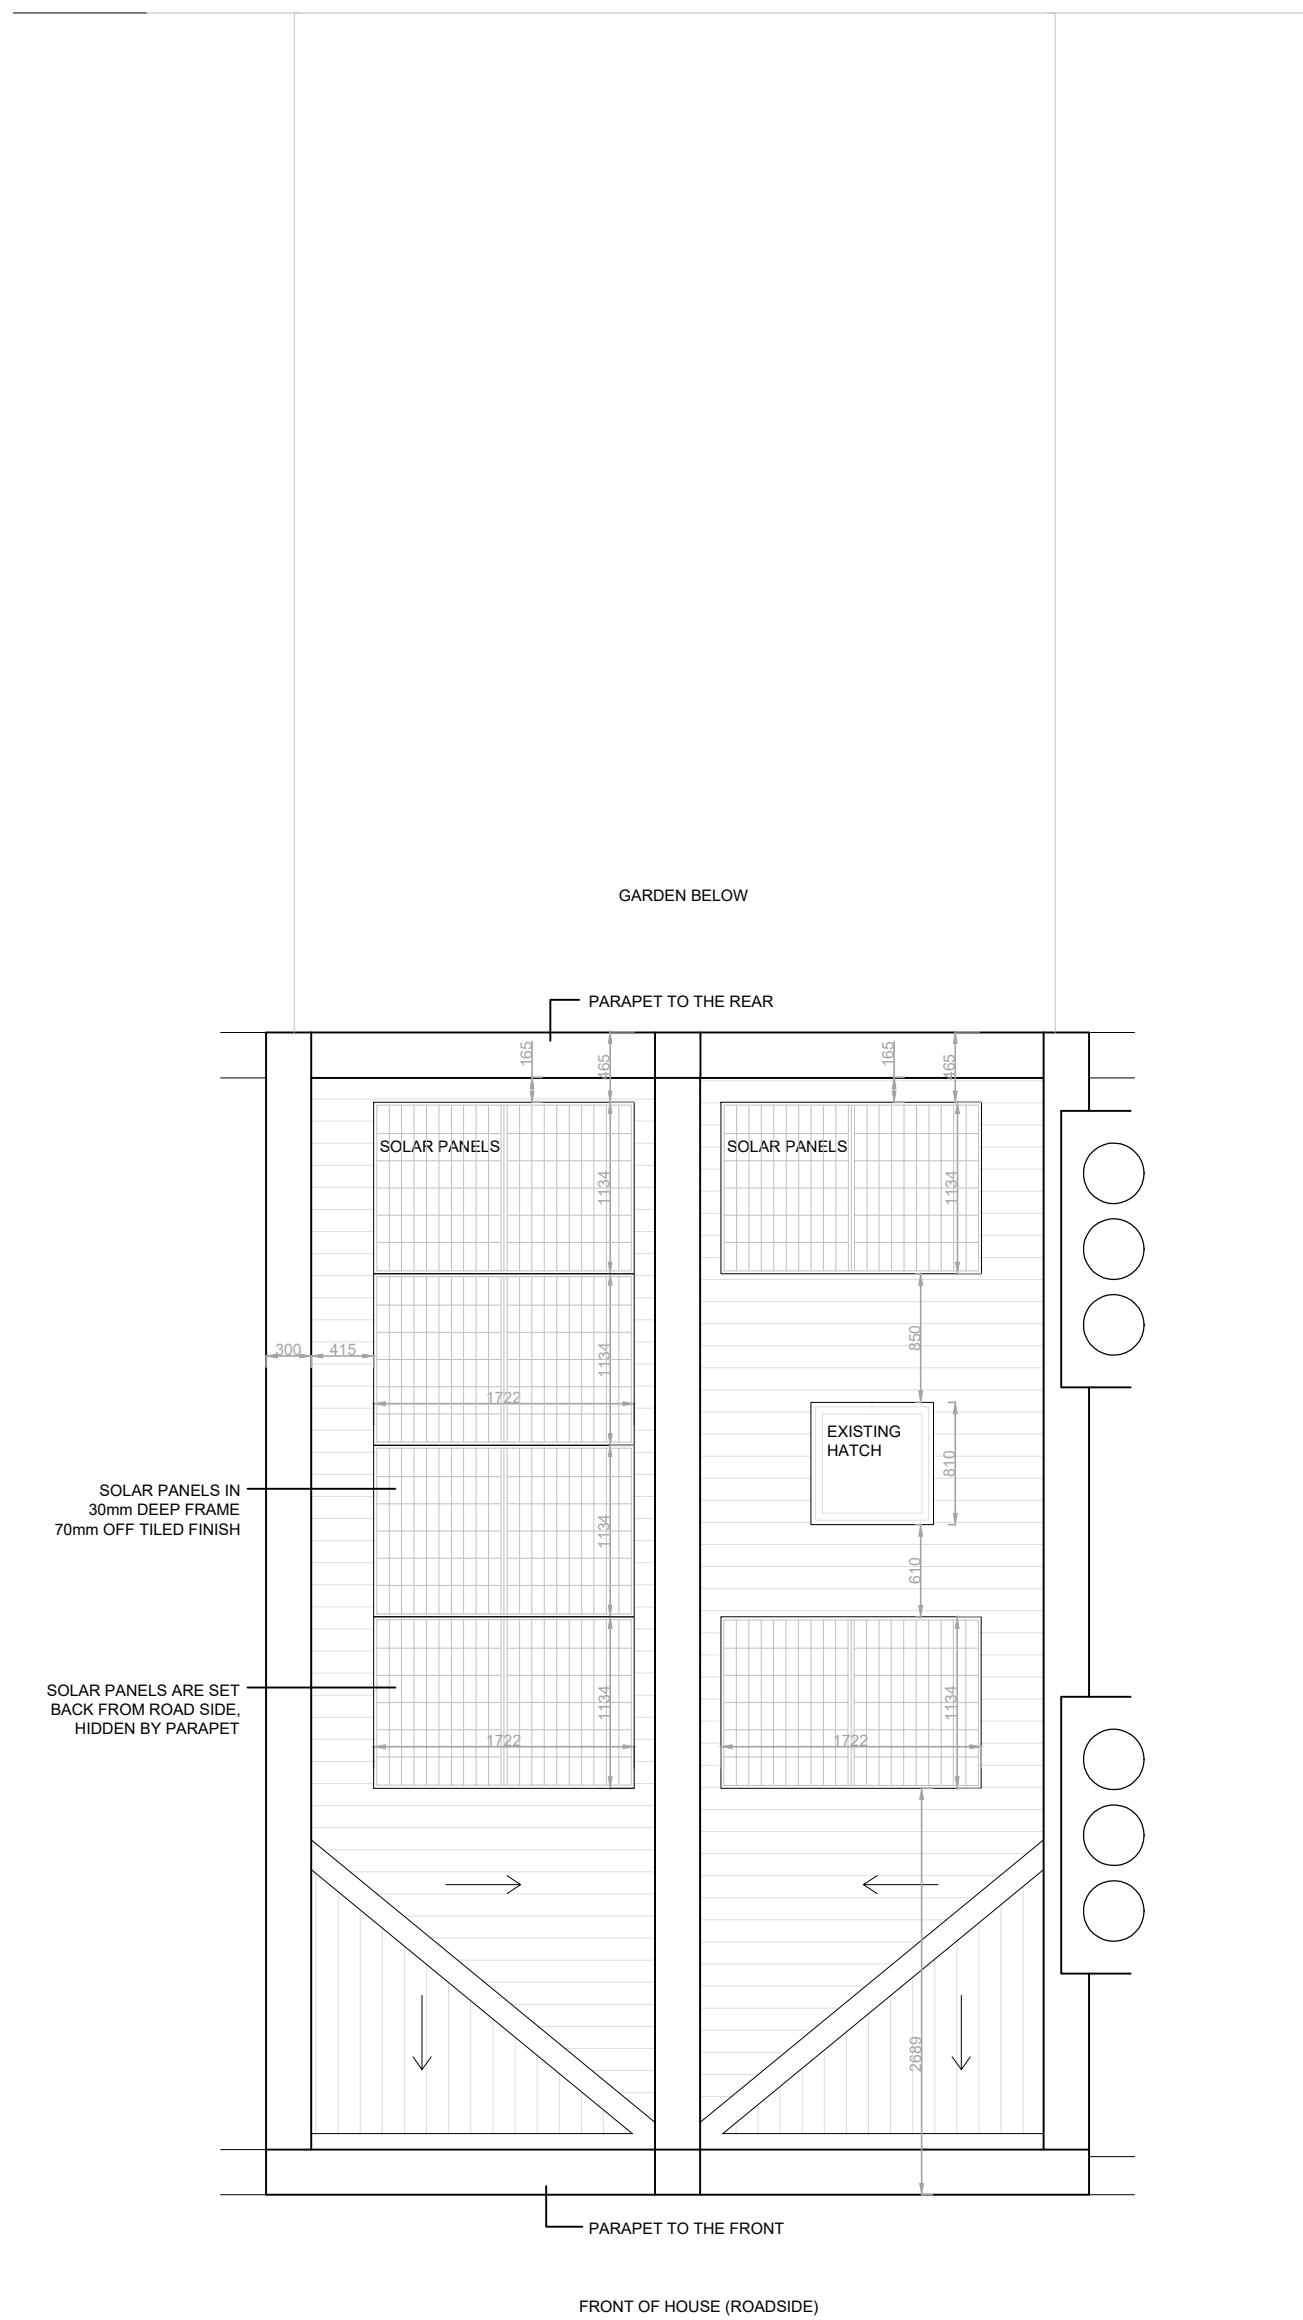

SOLAR PANELS IN
30mm DEEP FRAME
70mm OFF TILED FINISH

SOLAR PANELS ARE SET
BACK FROM ROAD SIDE,
HIDDEN BY PARAPET

B	MINOR AMENDMENT - ISSUED	05.02.2024
A	UPDATED AS PER COMMENTS	12.10.2023
REV	DESCRIPTION	DATE

Purpose of Issue MINOR-AMENDMENT		
Drawn	-	Checked -
Date	27.06.2023	
Scale	1:50	@A3
Project Number	4033	Sheet Number DR-03-008
		Rev B



PROJECT:
10 Thanet St. London WC1H 9QL

DRAWING NAME:
Proposed Roof Plan

NOTES:
Orientated to fit sheet size, 1:50@A3

© Copyright Once Printed and distributed this document is assumed uncontrolled.
© All rights reserved. No part of this drawing may be reproduced or transmitted in any form by any means without the written permission of the copyright holder.



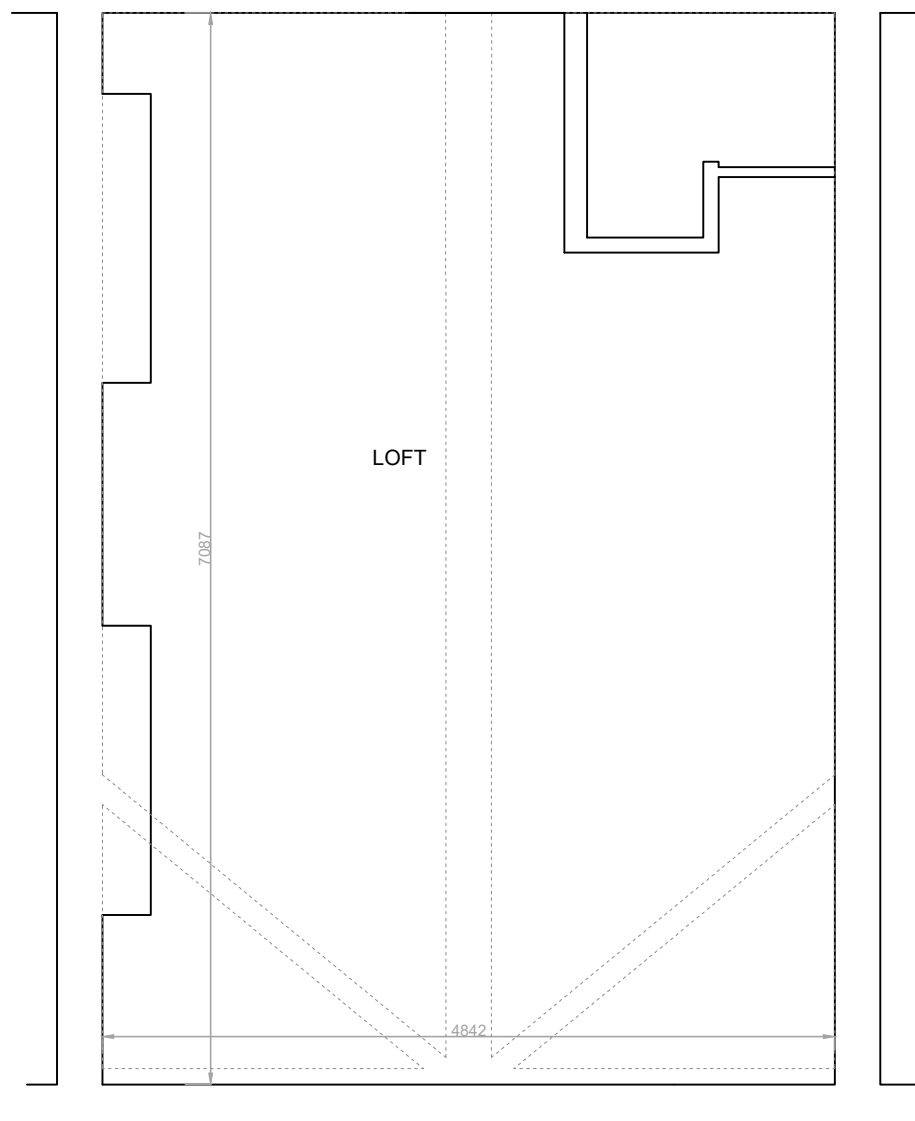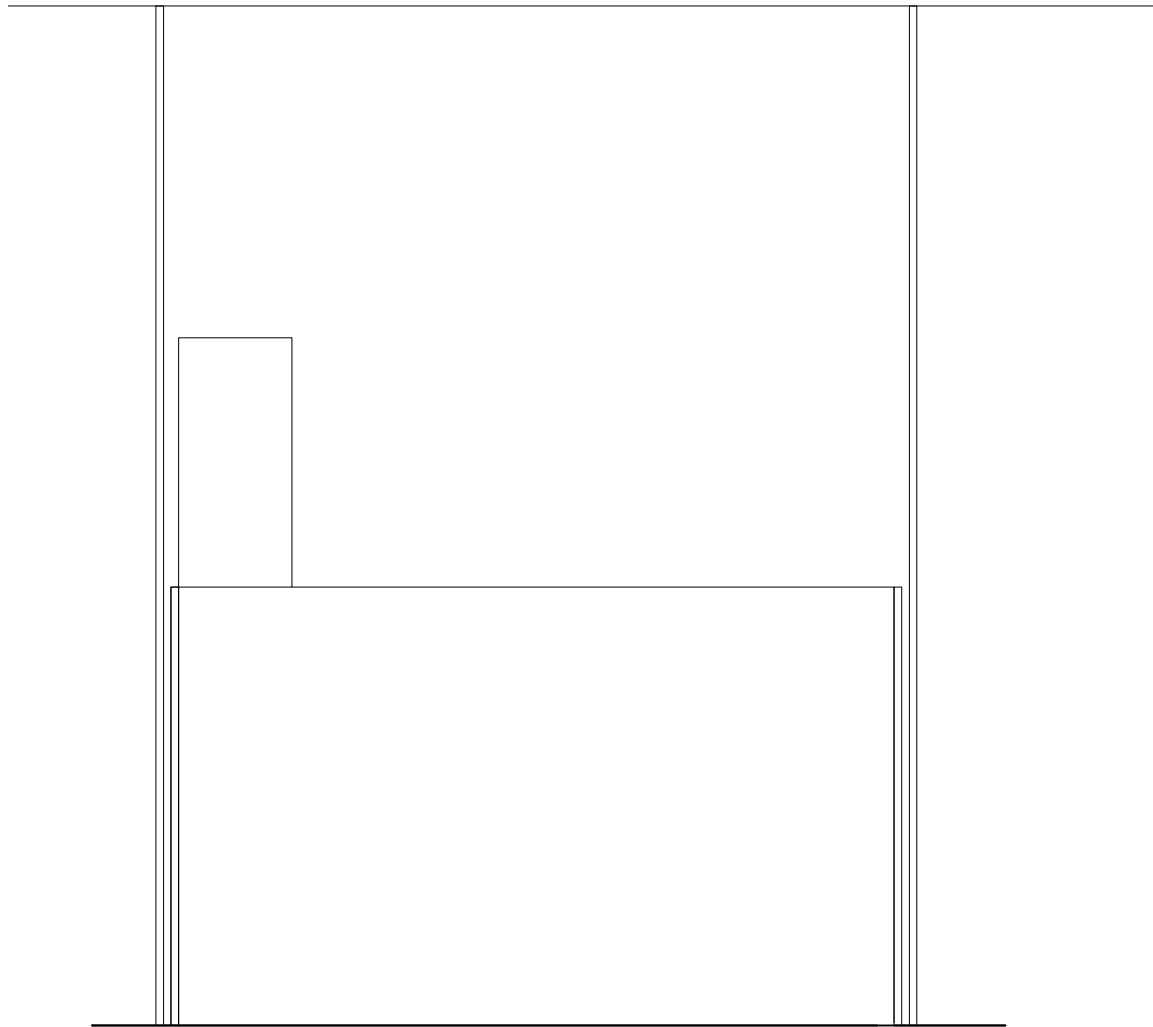


LOFT PLAN

B	MINOR AMENDMENT - ISSUED	05.02.2024
A	UPDATED AS PER COMMENTS	27.06.2023
REV	DESCRIPTION	DATE

Purpose of Issue MINOR-AMENDMENT		
Drawn	-	Checked -
Date	27.06.2023	
Scale	1:50	@A3
Project Number	Sheet Number	Rev
4033	DR-03-009	B

PROJECT:
 10 Thanet St. London WC1H 9QL
DRAWING NAME:
 Proposed Loft Plan
NOTES:
 Orientated to fit sheet size, 1:50@A3
 © Copyright Once Printed and distributed this document is assumed uncontrolled.
 © All rights reserved. No part of this drawing may be reproduced or transmitted
 in any form by any means without the written permission of the copyright holder.



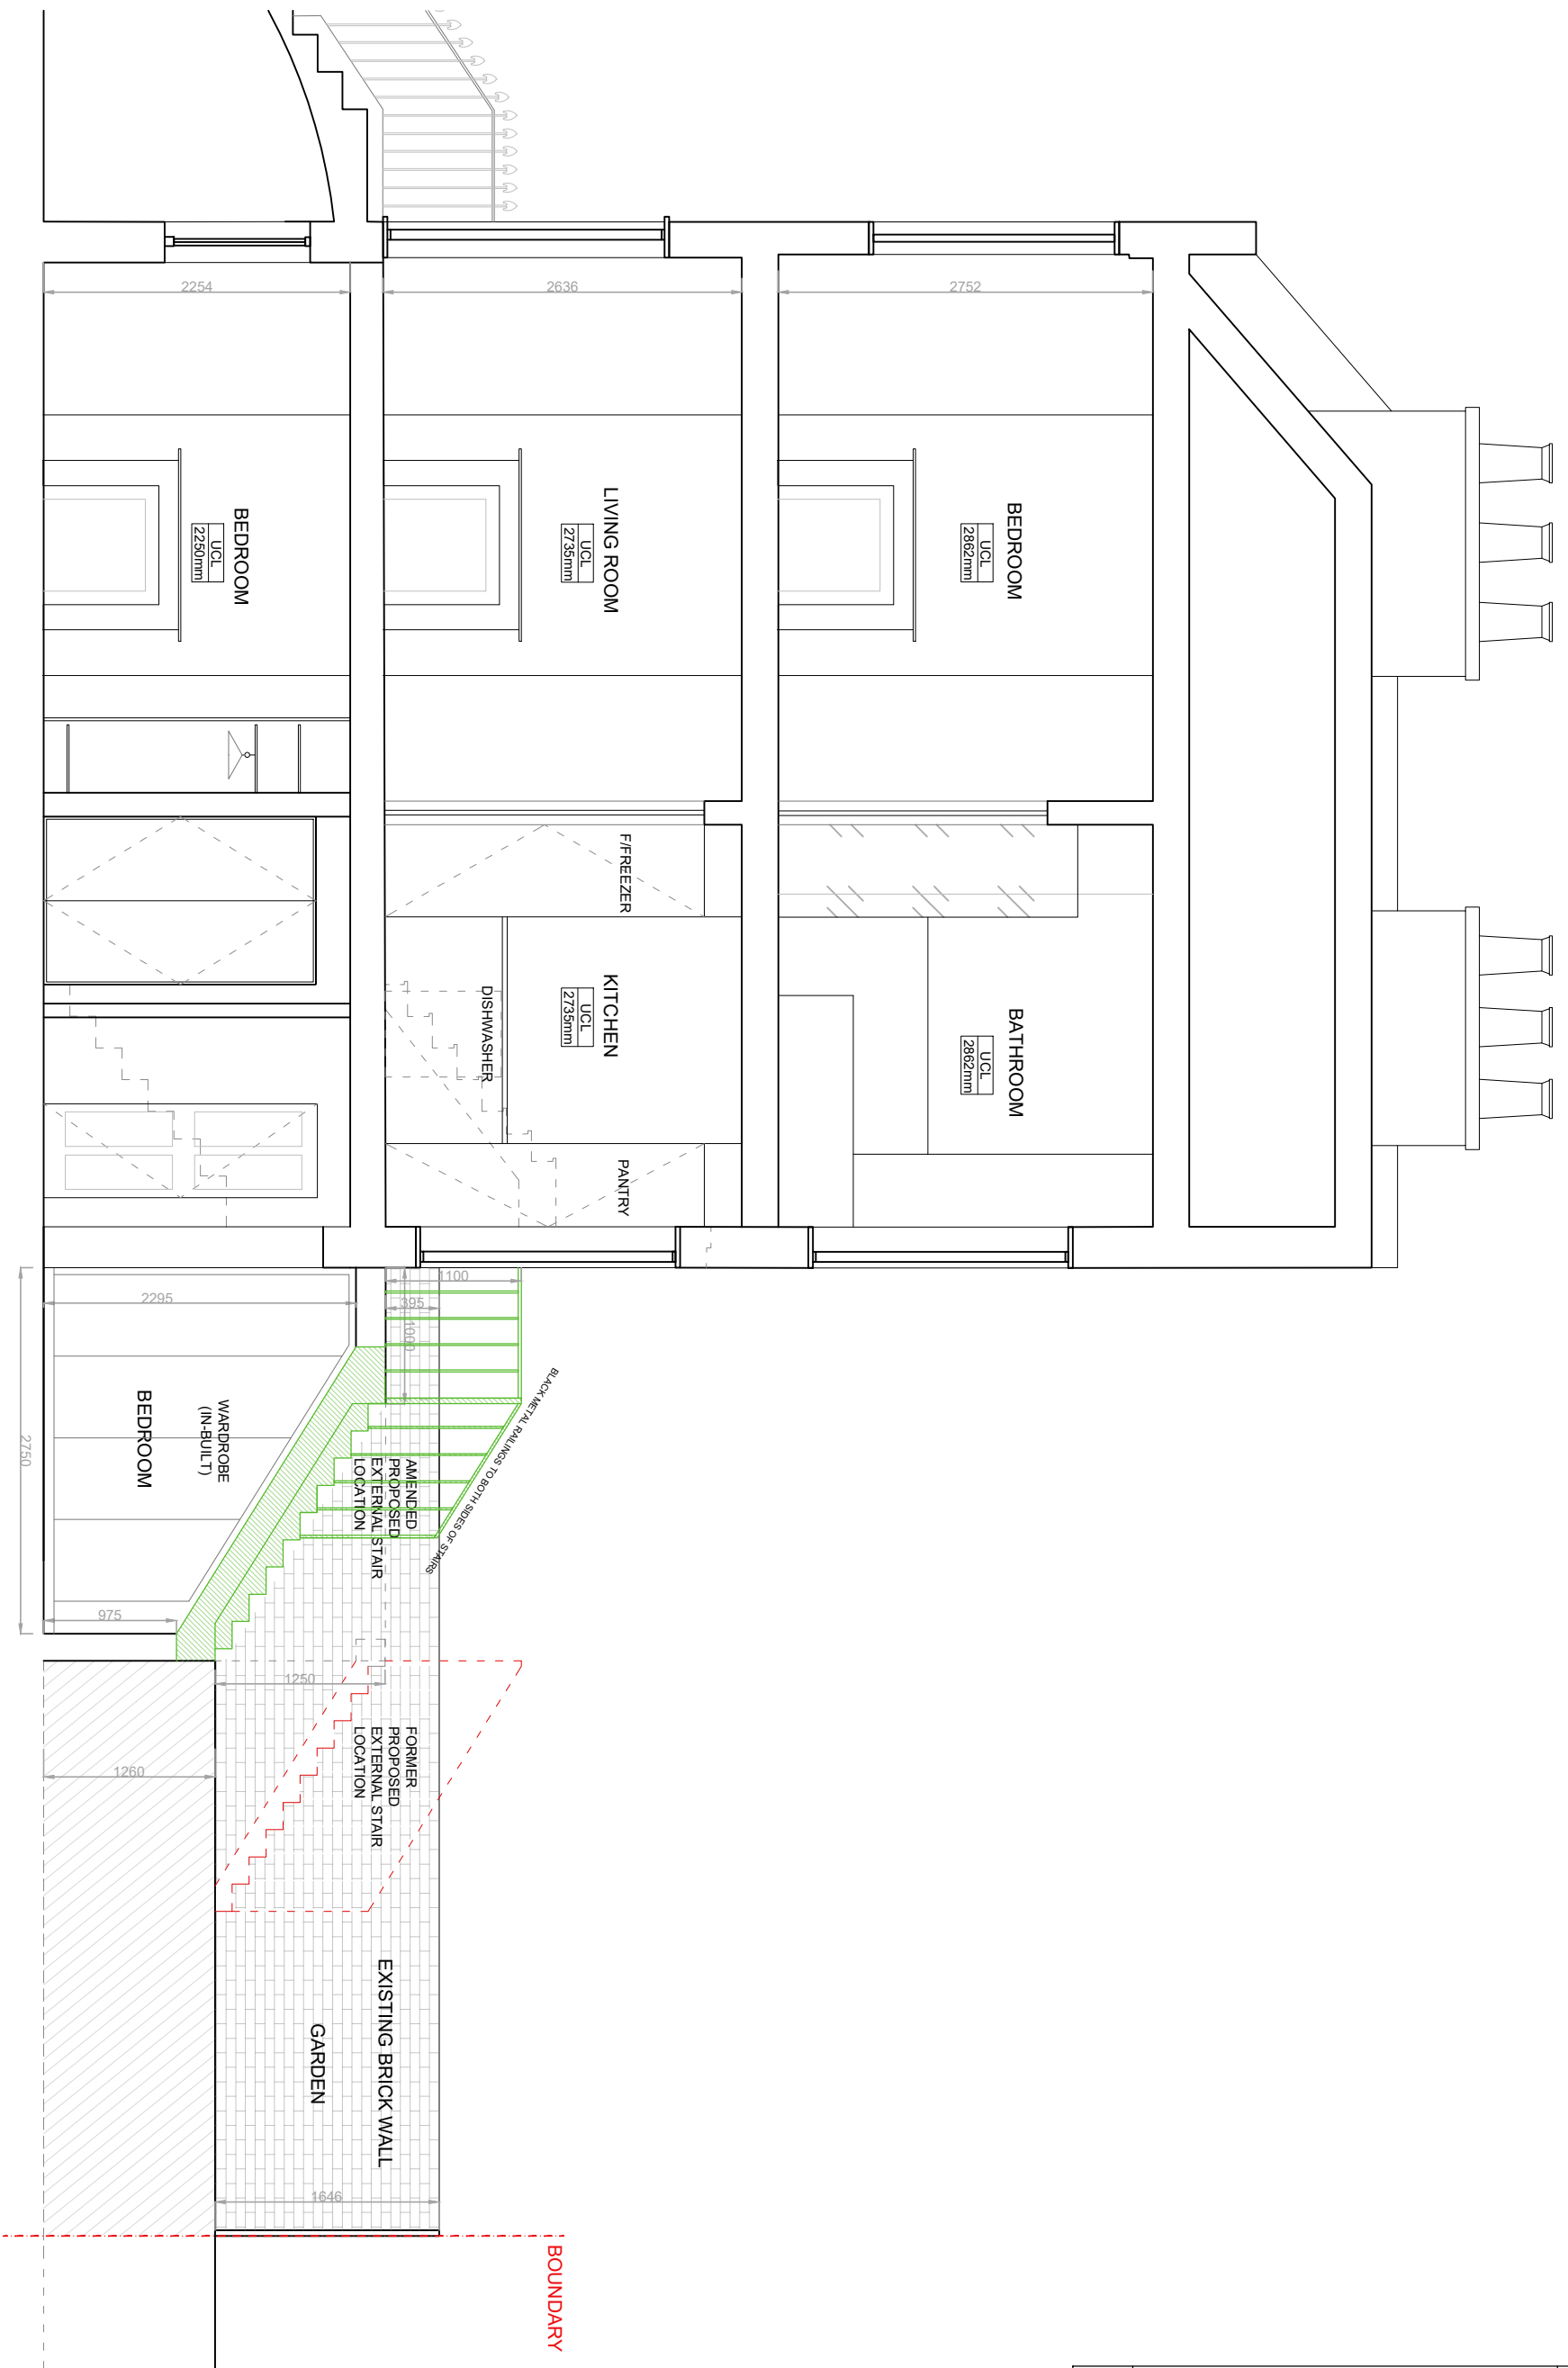

Proposed Section - 1:50



PROJECT:
10 Thanet St. London WC1H 9QL


DRAWING NAME:
Proposed Section

NOTES:
Orientated to fit sheet size, 1:50@A3


© Copyright Once Printed and distributed this document is assumed uncontrolled.
© All rights reserved. No part of this drawing may be reproduced or transmitted
in any form by any means without the written permission of the copyright holder.

C	MINOR AMENDMENT - ISSUED	05.02.2024
B	UPDATED AS PER COMMENTS	14.10.2023
REV	DESCRIPTION	DATE

Purpose of Issue MINOR-AMENDMENT		
Drawn	-	Checked -
Date	27.06.2023	
Scale	1:50	@A3
Project Number	4033	Sheet Number DR-04-002
		Rev C

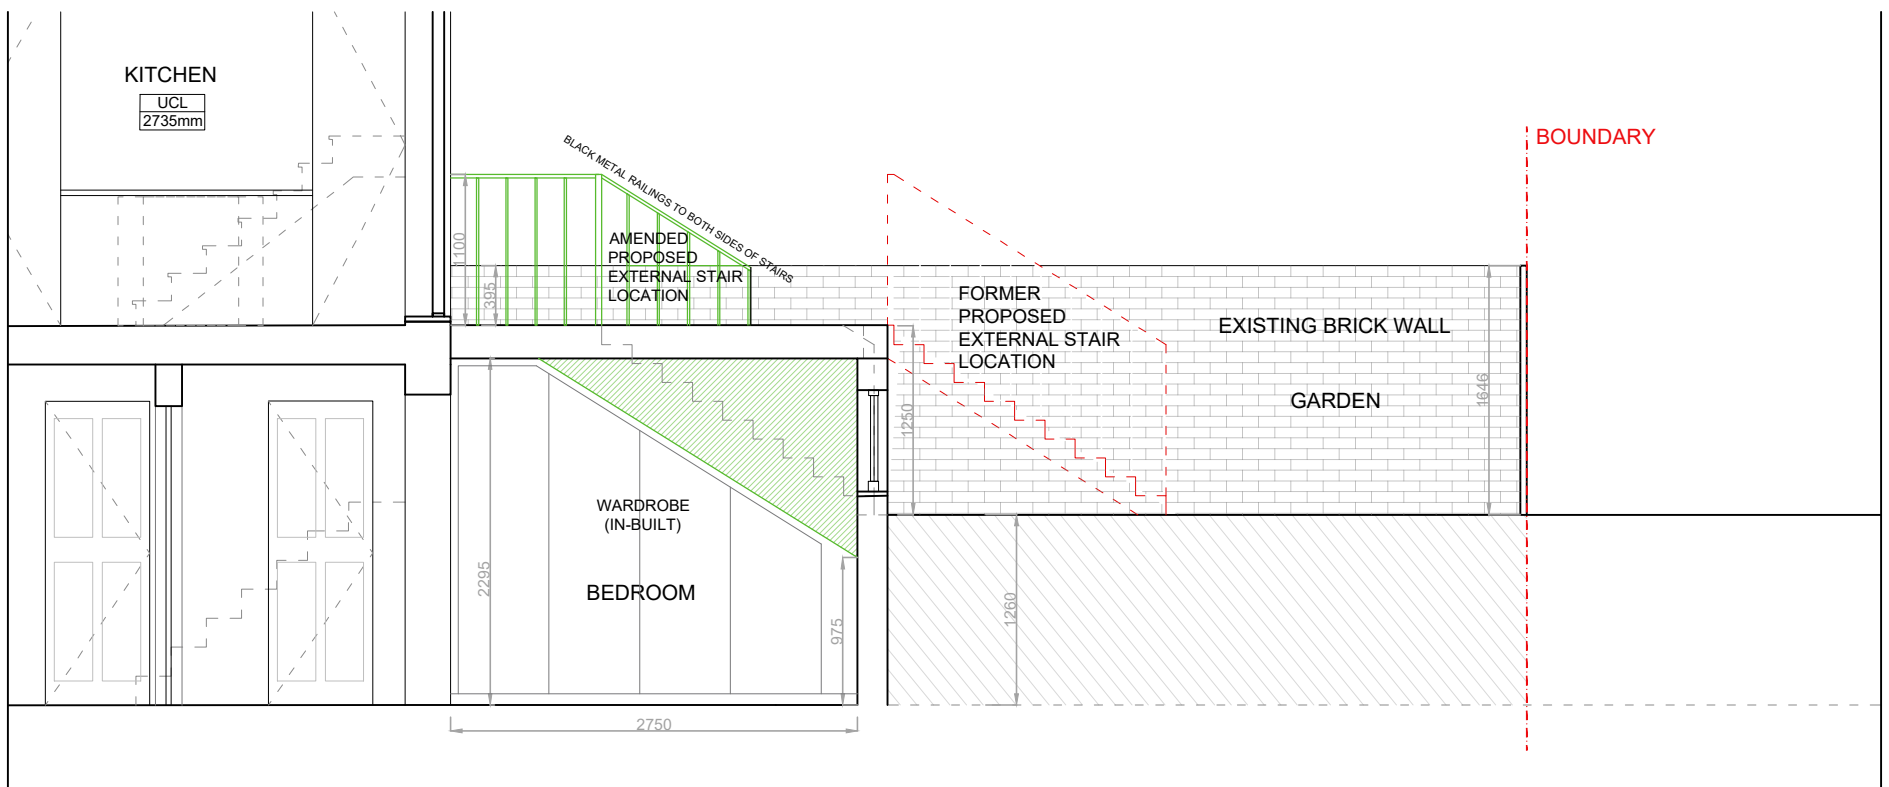

Proposed Section 01 - 1:50

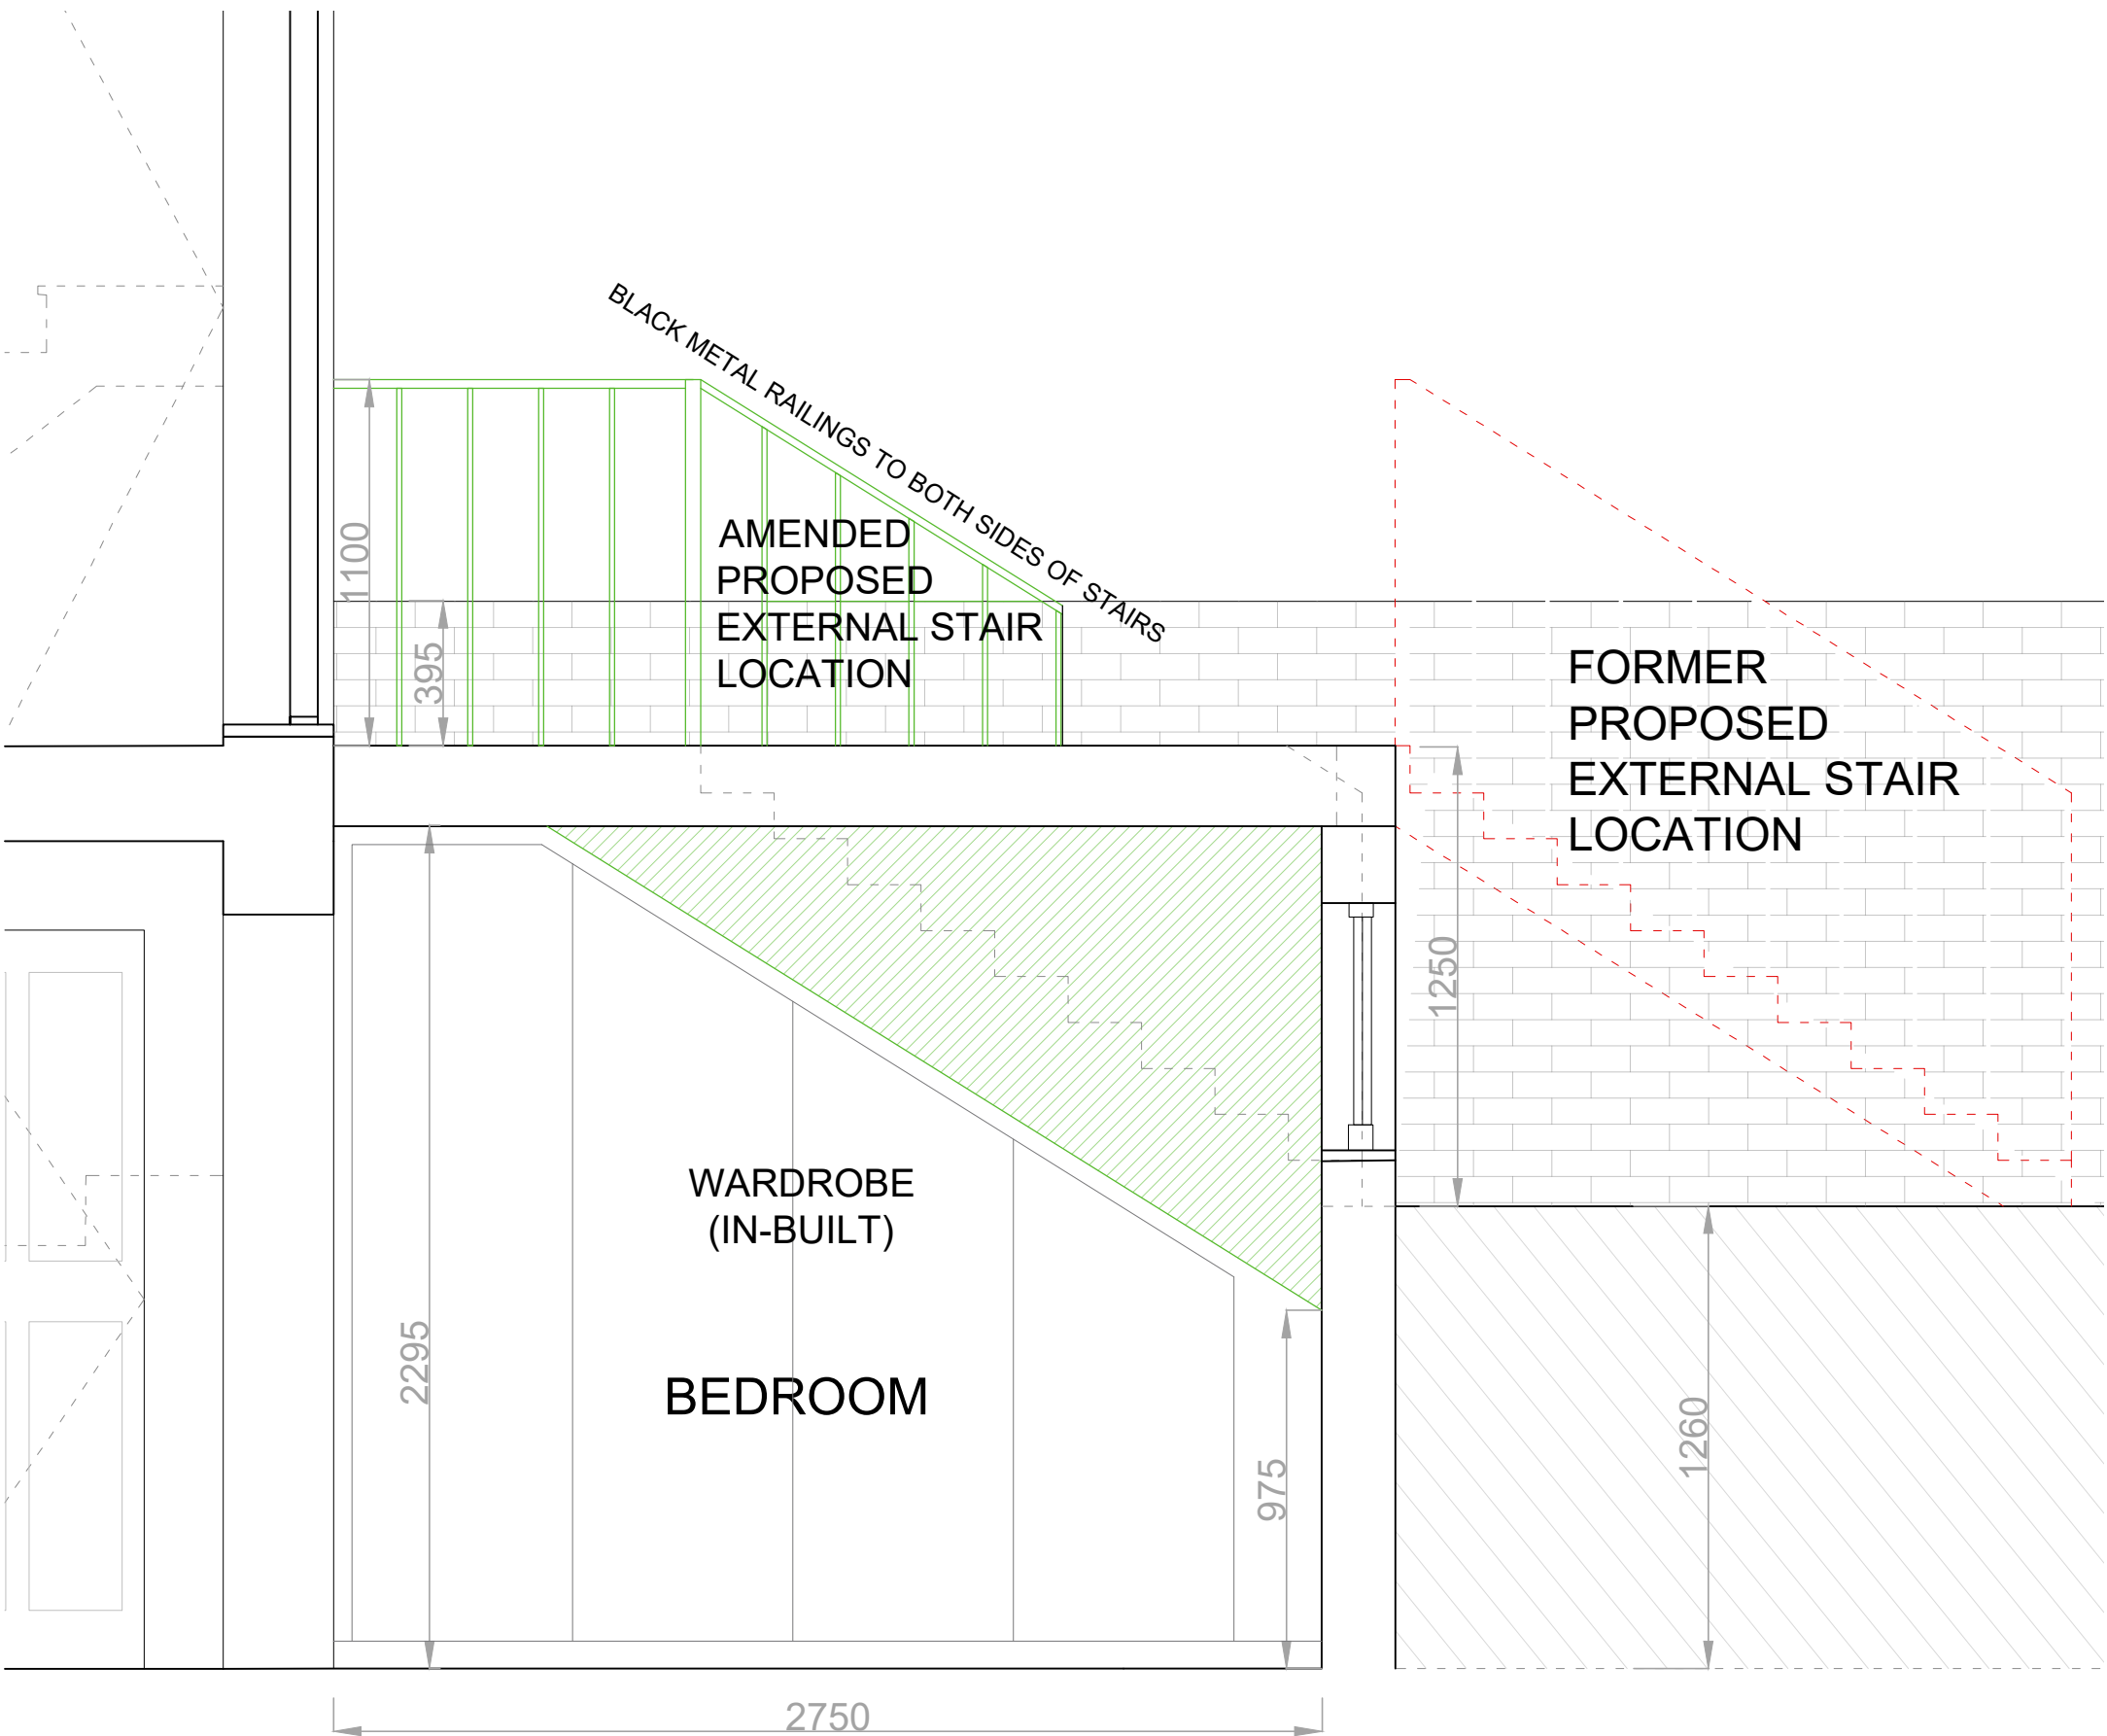

Proposed Section 01 - 1:20



PROJECT:
10 Thanet St. London WC1H 9QL


DRAWING NAME:
Section 01 - Lower Ground

NOTES:
Orientated to fit sheet size, 1:20@A3


© Copyright Once Printed and distributed this document is assumed uncontrolled.
© All rights reserved. No part of this drawing may be reproduced or transmitted
in any form by any means without the written permission of the copyright holder.

A	MINOR AMENDMENT - ISSUED	05.02.2024
REV	DESCRIPTION	DATE

Purpose of Issue MINOR-AMENDMENT		
Drawn	-	Checked -
Date	05.02.2024	
Scale	1:20	@A3
Project Number	Sheet Number	Rev
4033	DR-04-004	A

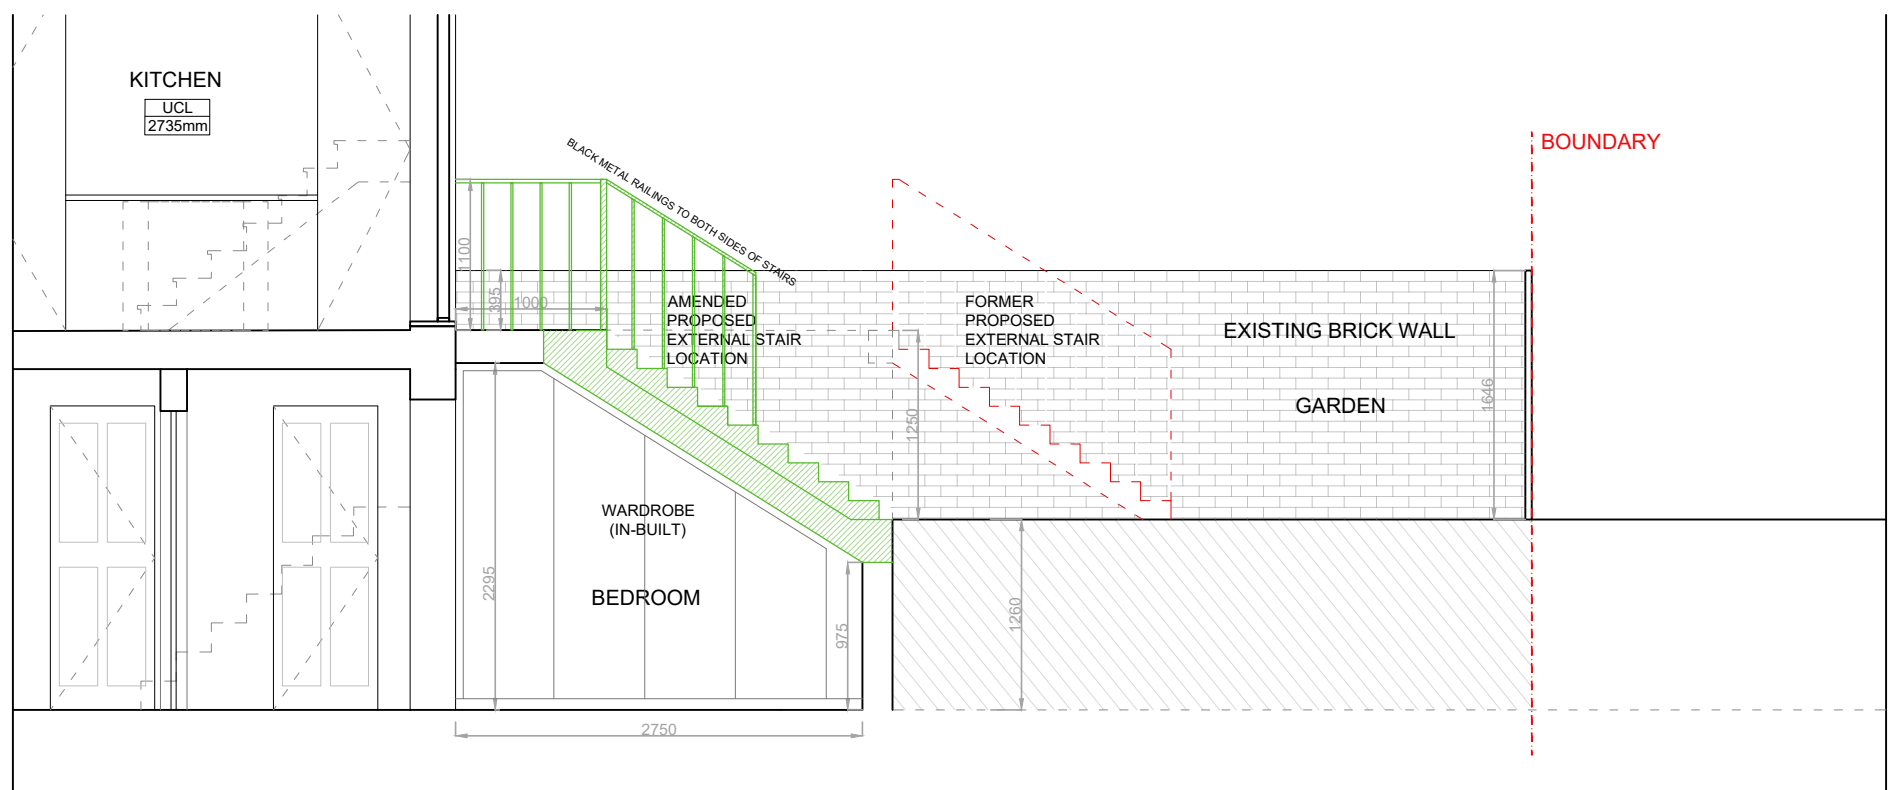

Proposed Section 02 - 1:50

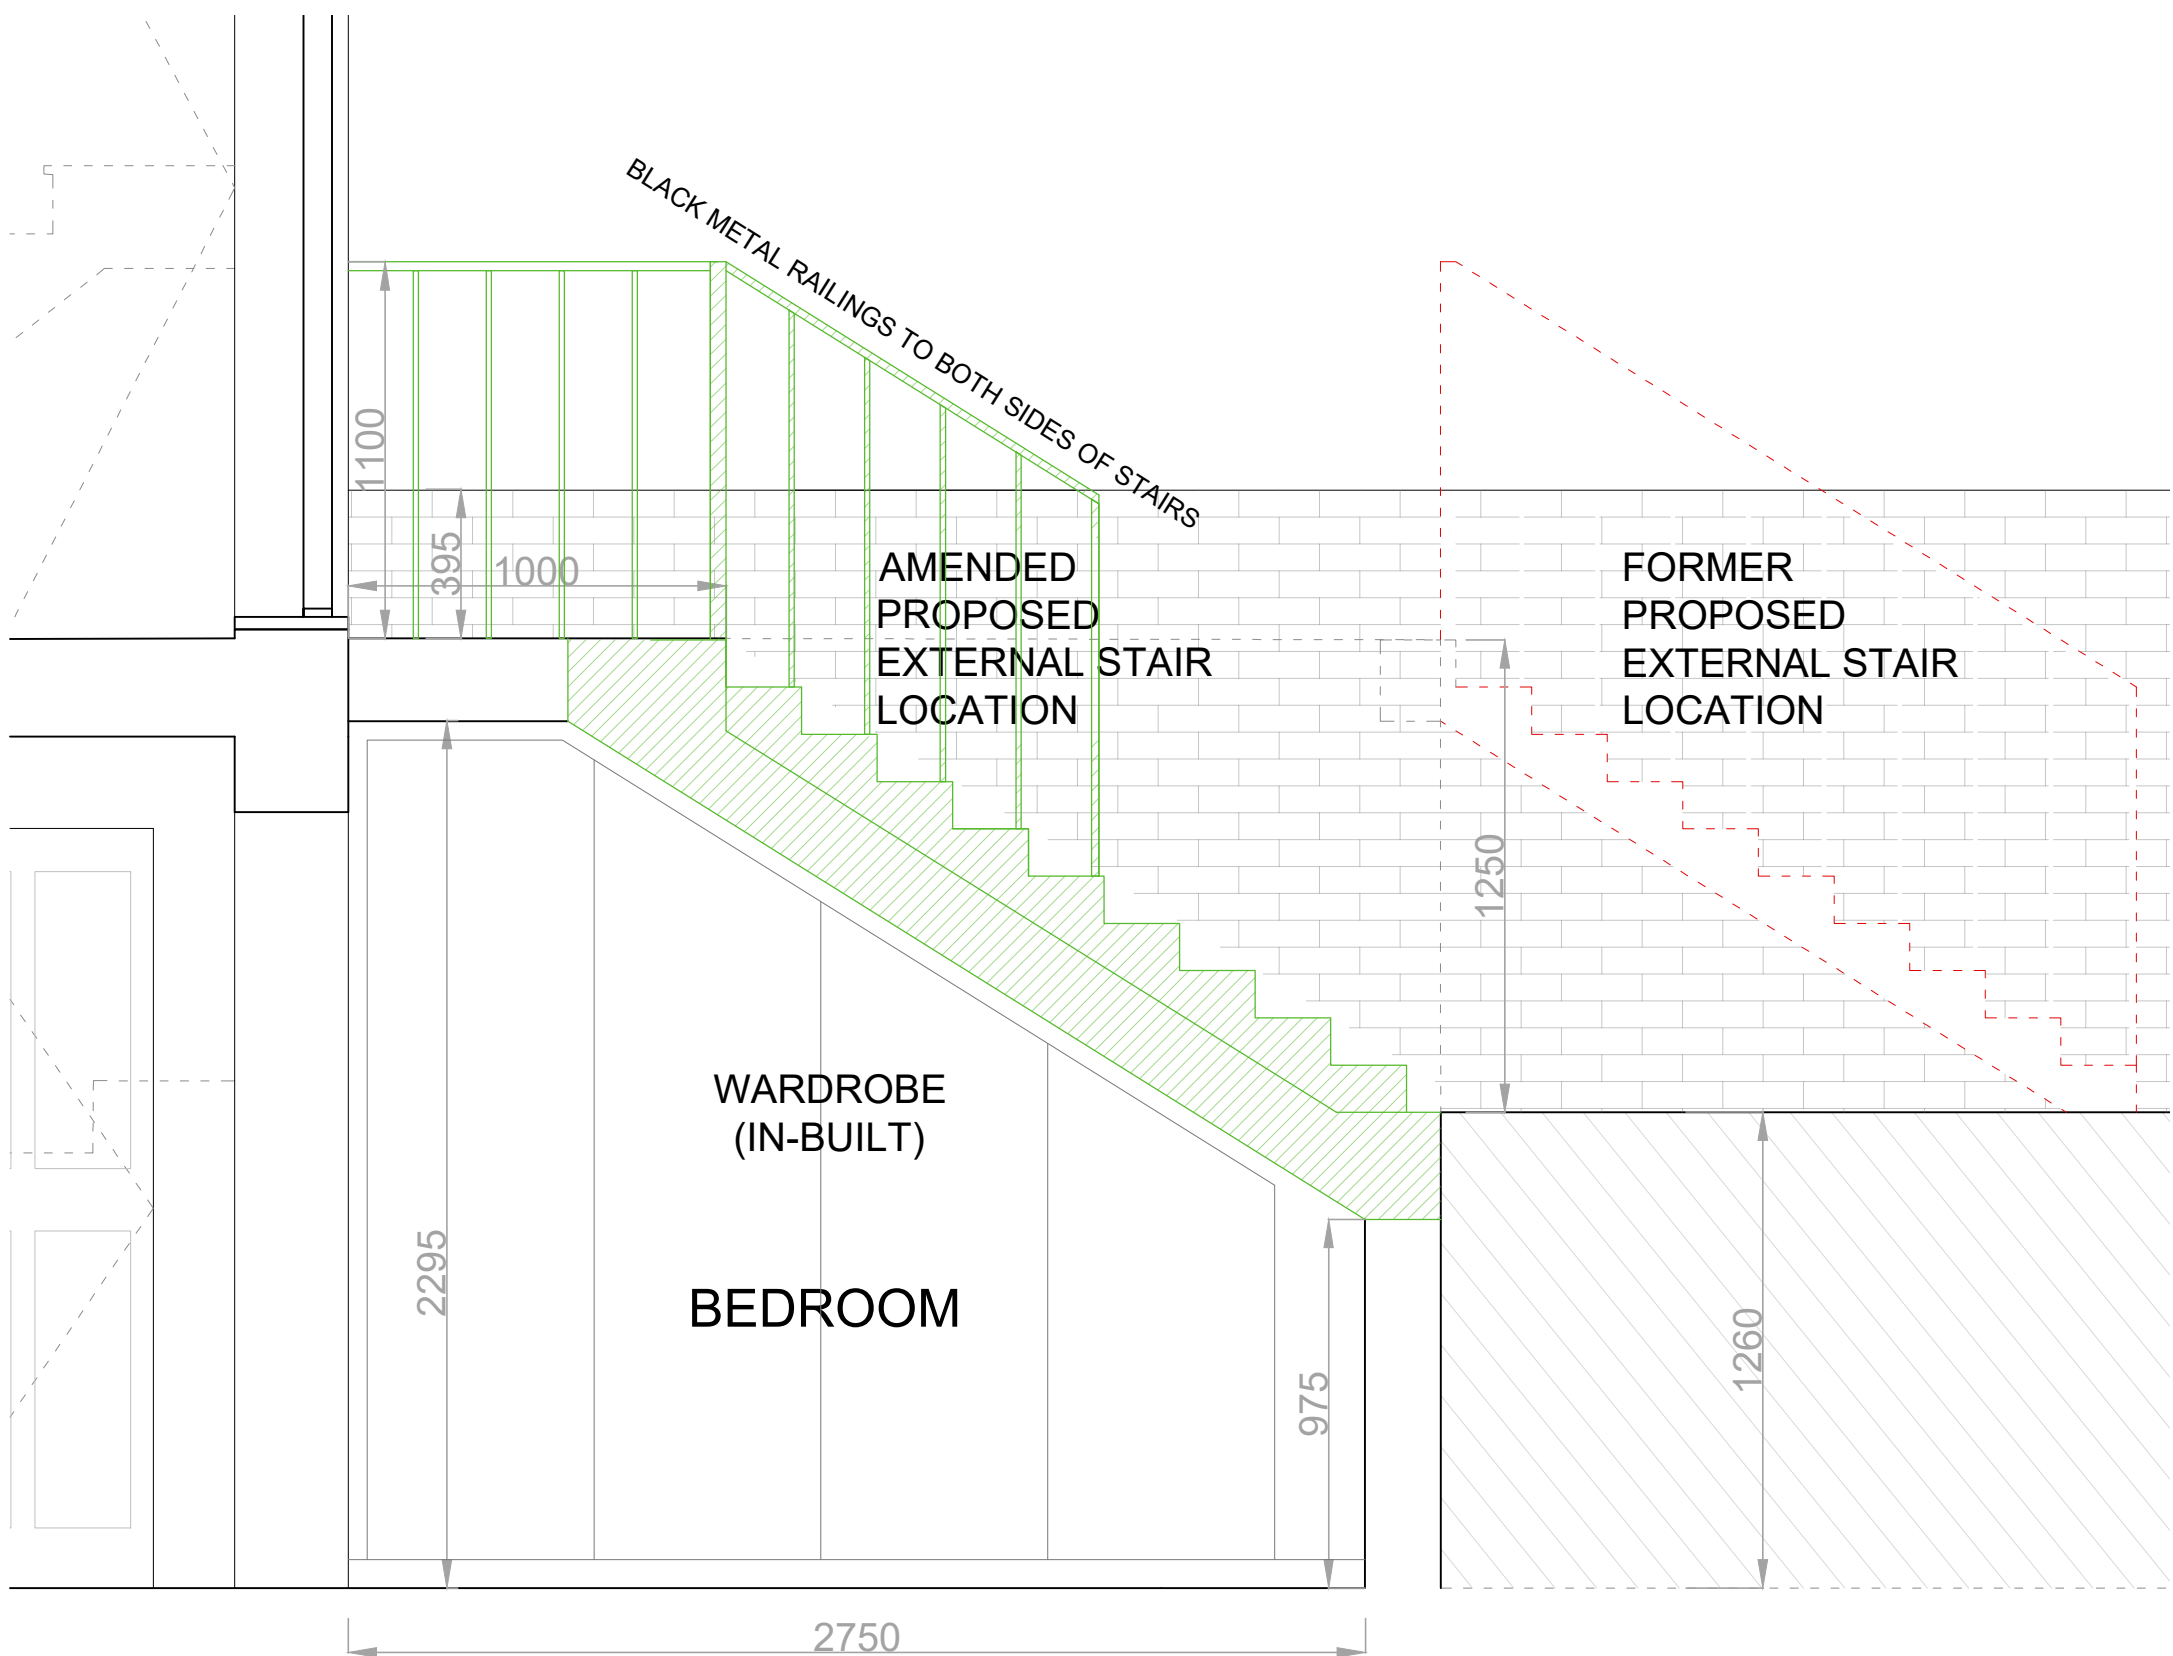

Proposed Section 02 - 1:20



PROJECT:
10 Thanet St. London WC1H 9QL


DRAWING NAME:
Section 02 - Lower Ground

NOTES:
Orientated to fit sheet size, 1:20@A3


© Copyright Once Printed and distributed this document is assumed uncontrolled.
© All rights reserved. No part of this drawing may be reproduced or transmitted
in any form by any means without the written permission of the copyright holder.

A	MINOR AMENDMENTS - ISSUED	05.02.2024
REV	DESCRIPTION	DATE

Purpose of Issue MINOR-AMENDMENT		
Drawn	-	Checked -
Date	05.02.2024	
Scale	1:20	@A3
Project Number	Sheet Number	Rev
4033	DR-04-005	A

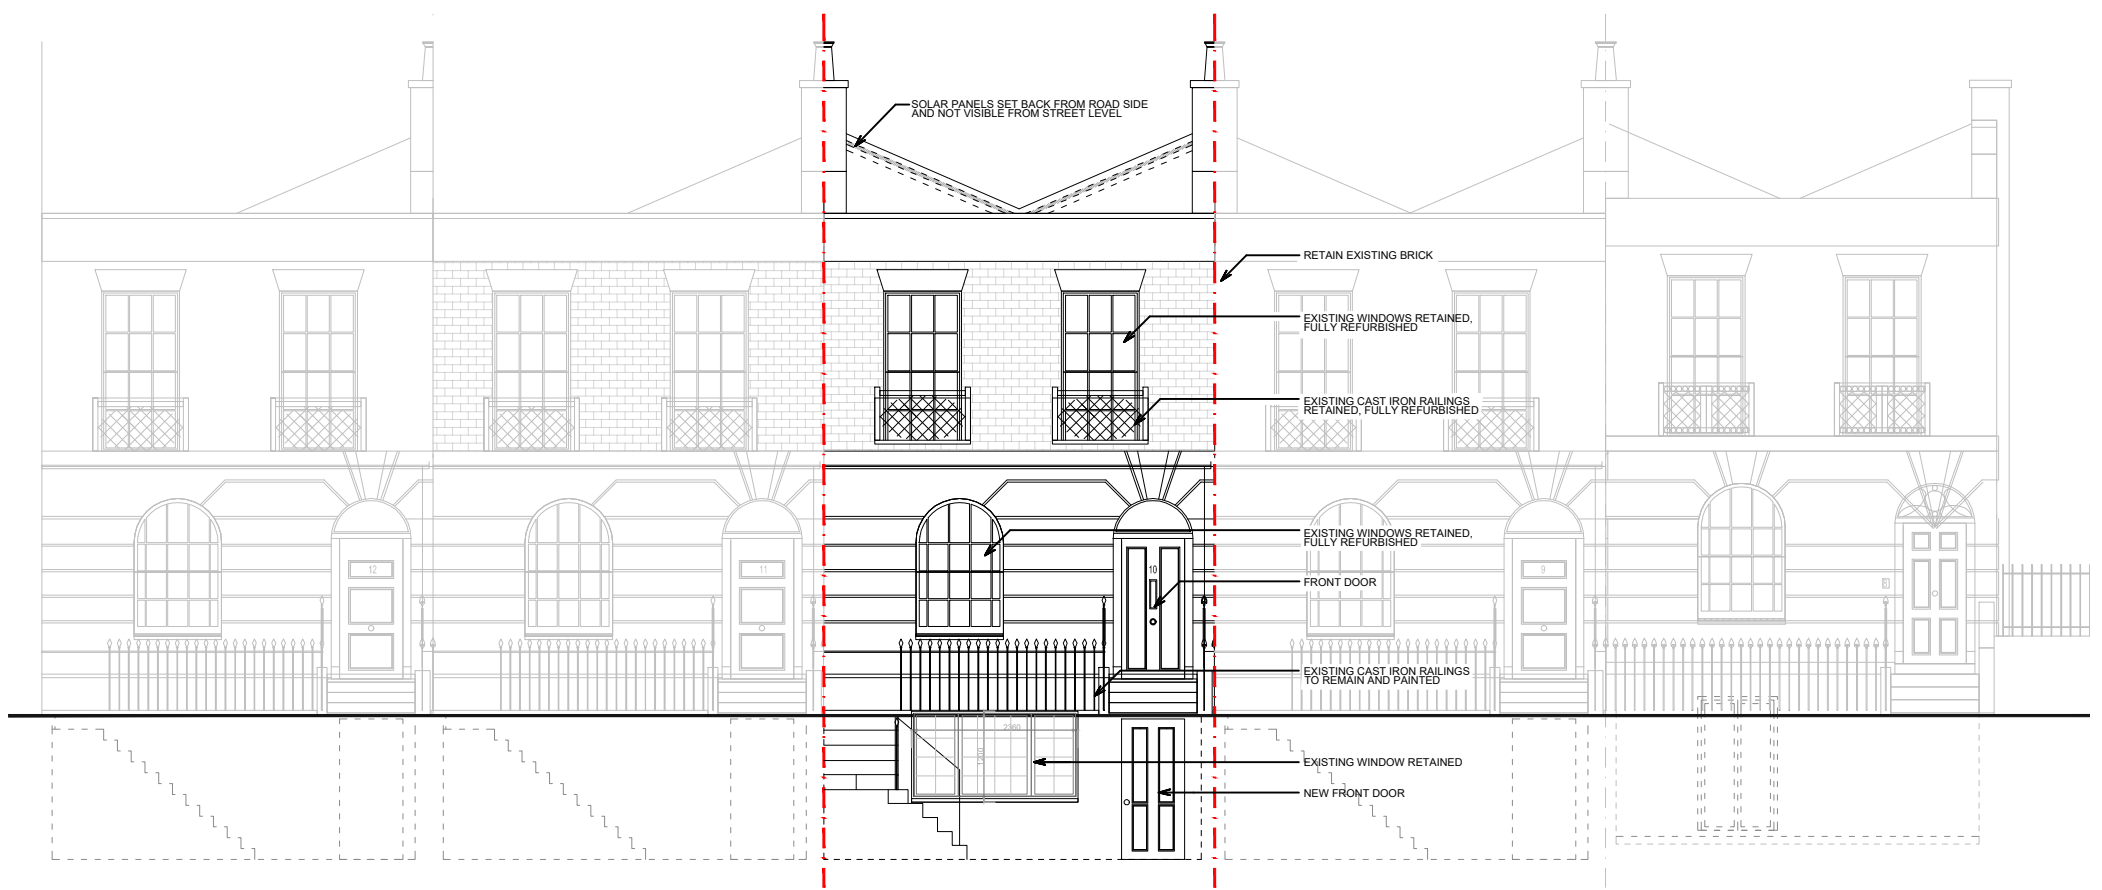

Front Elevation (South West) 1:100

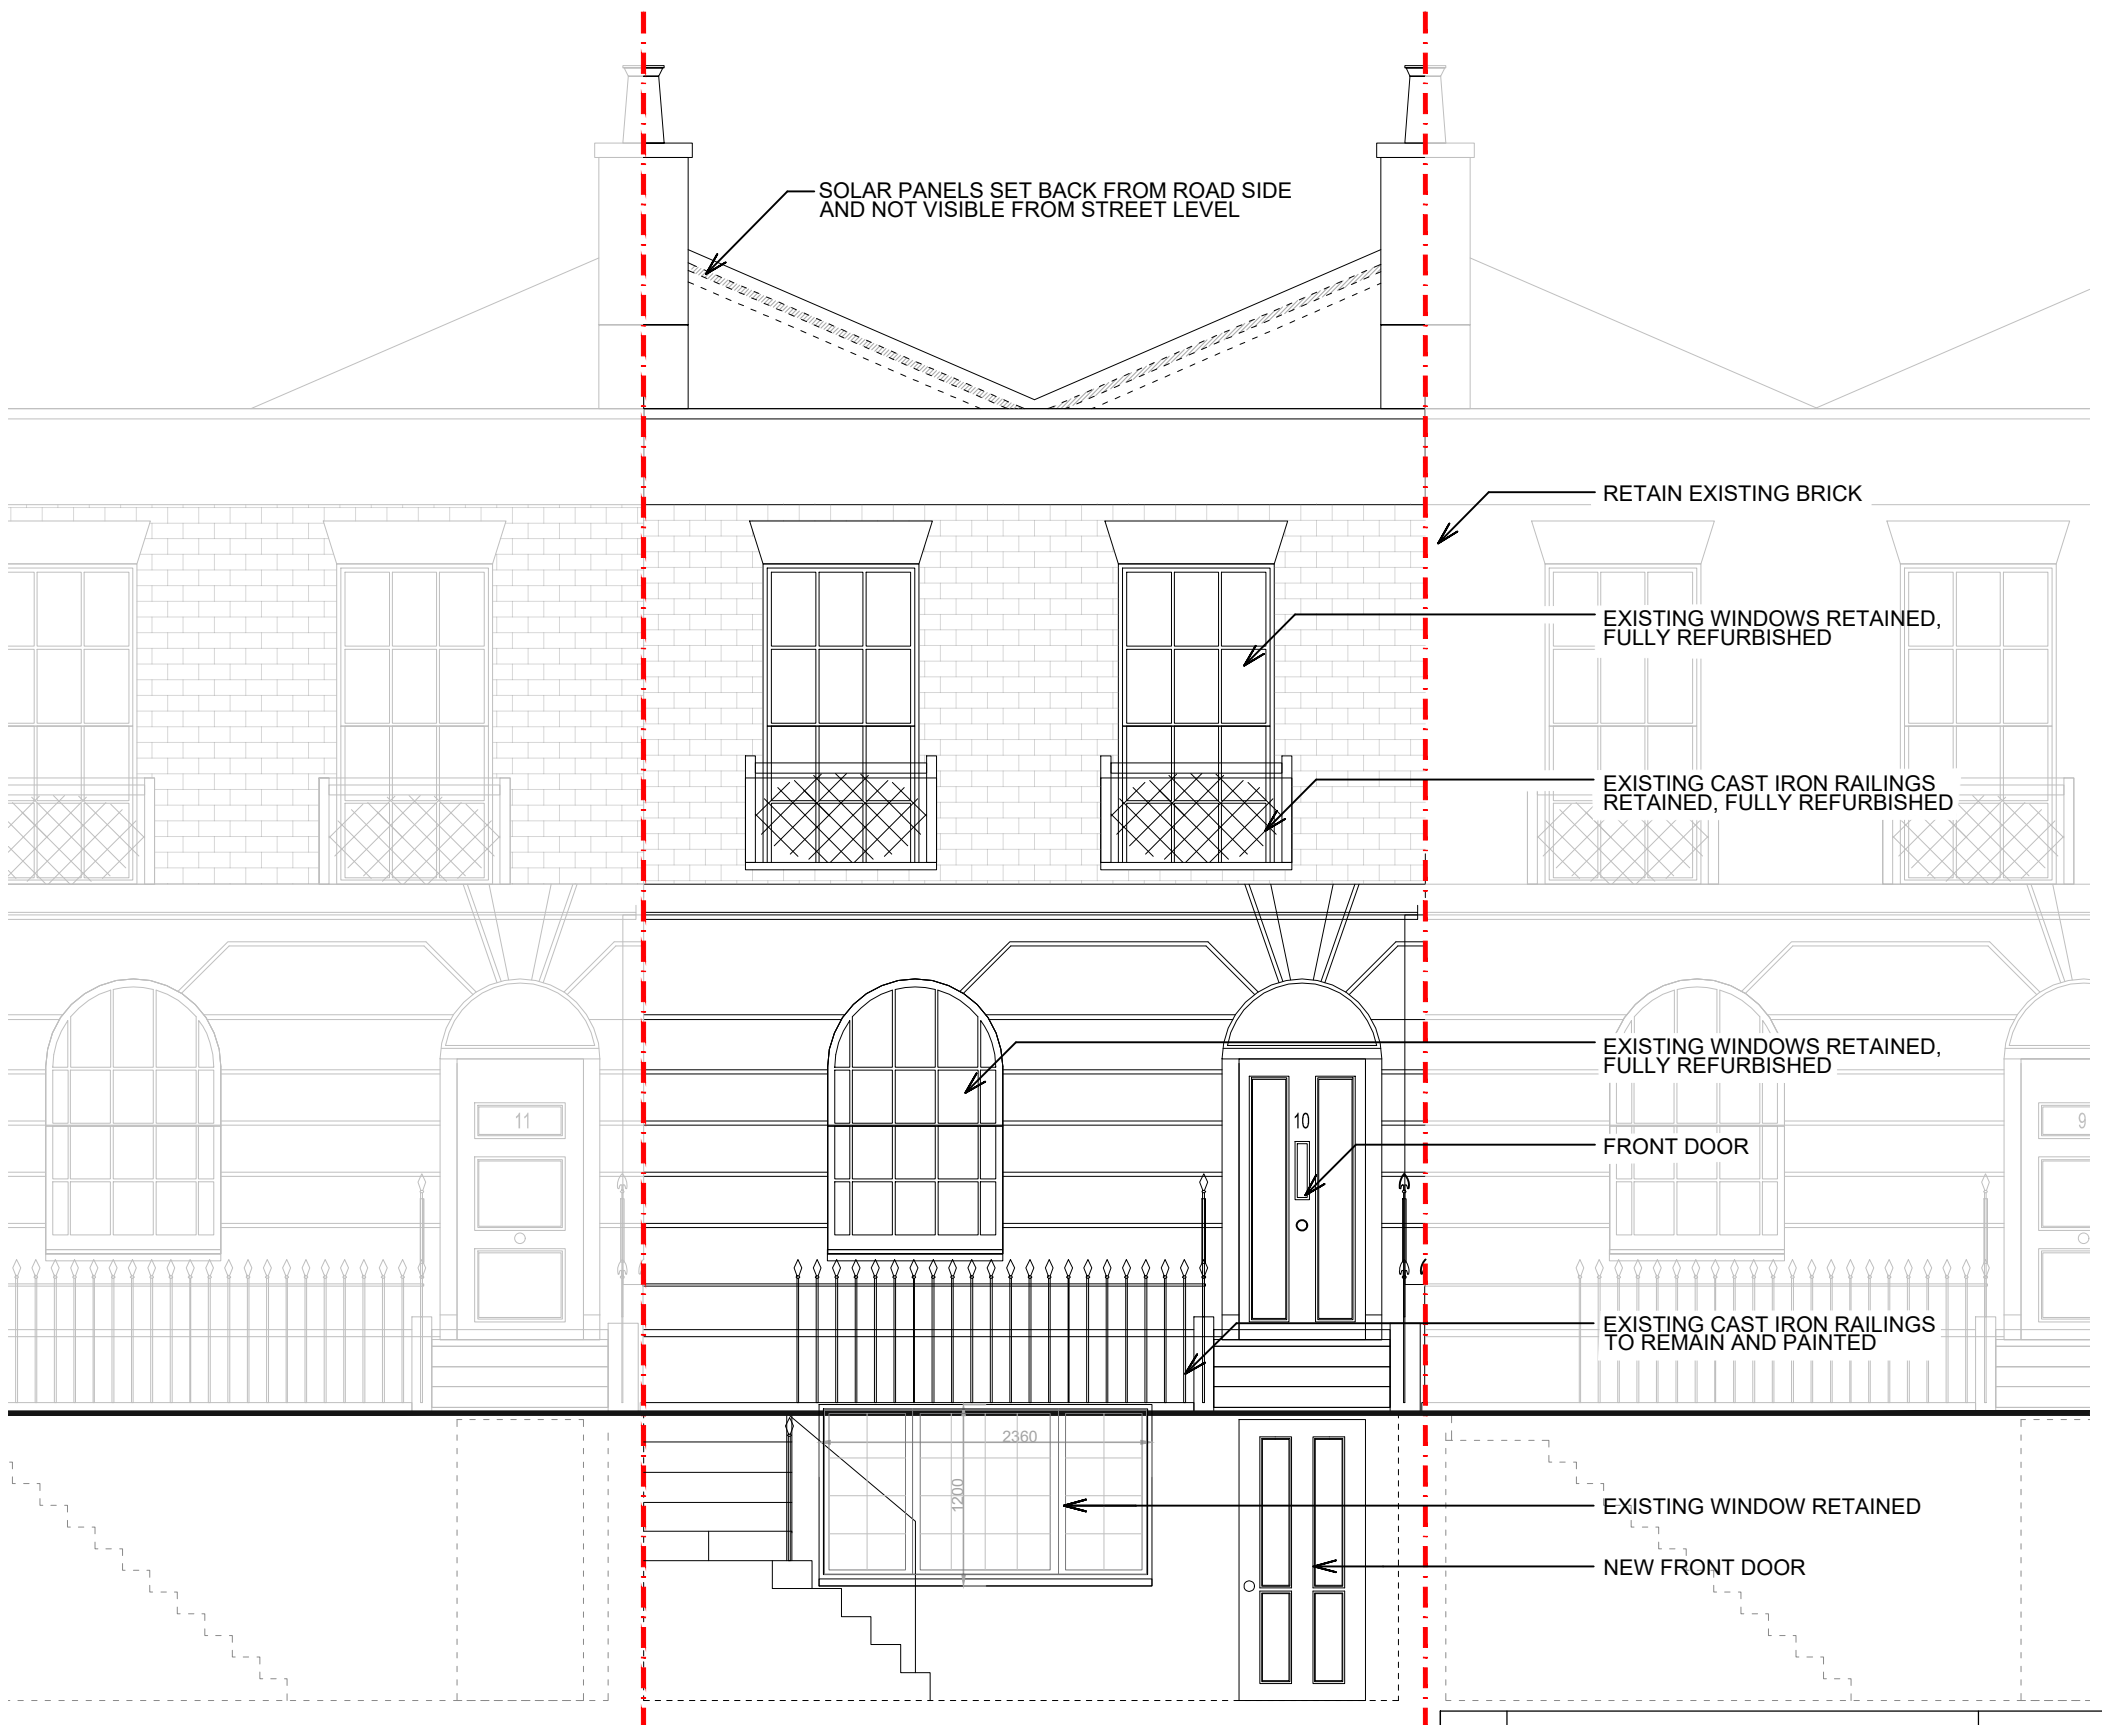

Front Elevation (South West) 1:50



PROJECT:
10 Thanet St. London WC1H 9QL
DRAWING NAME:
Proposed Front (South West) Elevation
NOTES:
Orientated to fit sheet size, 1:50@A3


© Copyright Once Printed and distributed this document is assumed uncontrolled.
© All rights reserved. No part of this drawing may be reproduced or transmitted in any form by any means without the written permission of the copyright holder.

B	UPDATED AS PER COMMENTS	14.10.2023
REV	DESCRIPTION	DATE

Purpose of Issue INFORMATION		
Drawn	-	Checked -
Date	27.06.23	
Scale	1:50	@A3
Project Number	Sheet Number	Rev
4033	DR-05-002	B



Rear Elevation (South West) 1:100

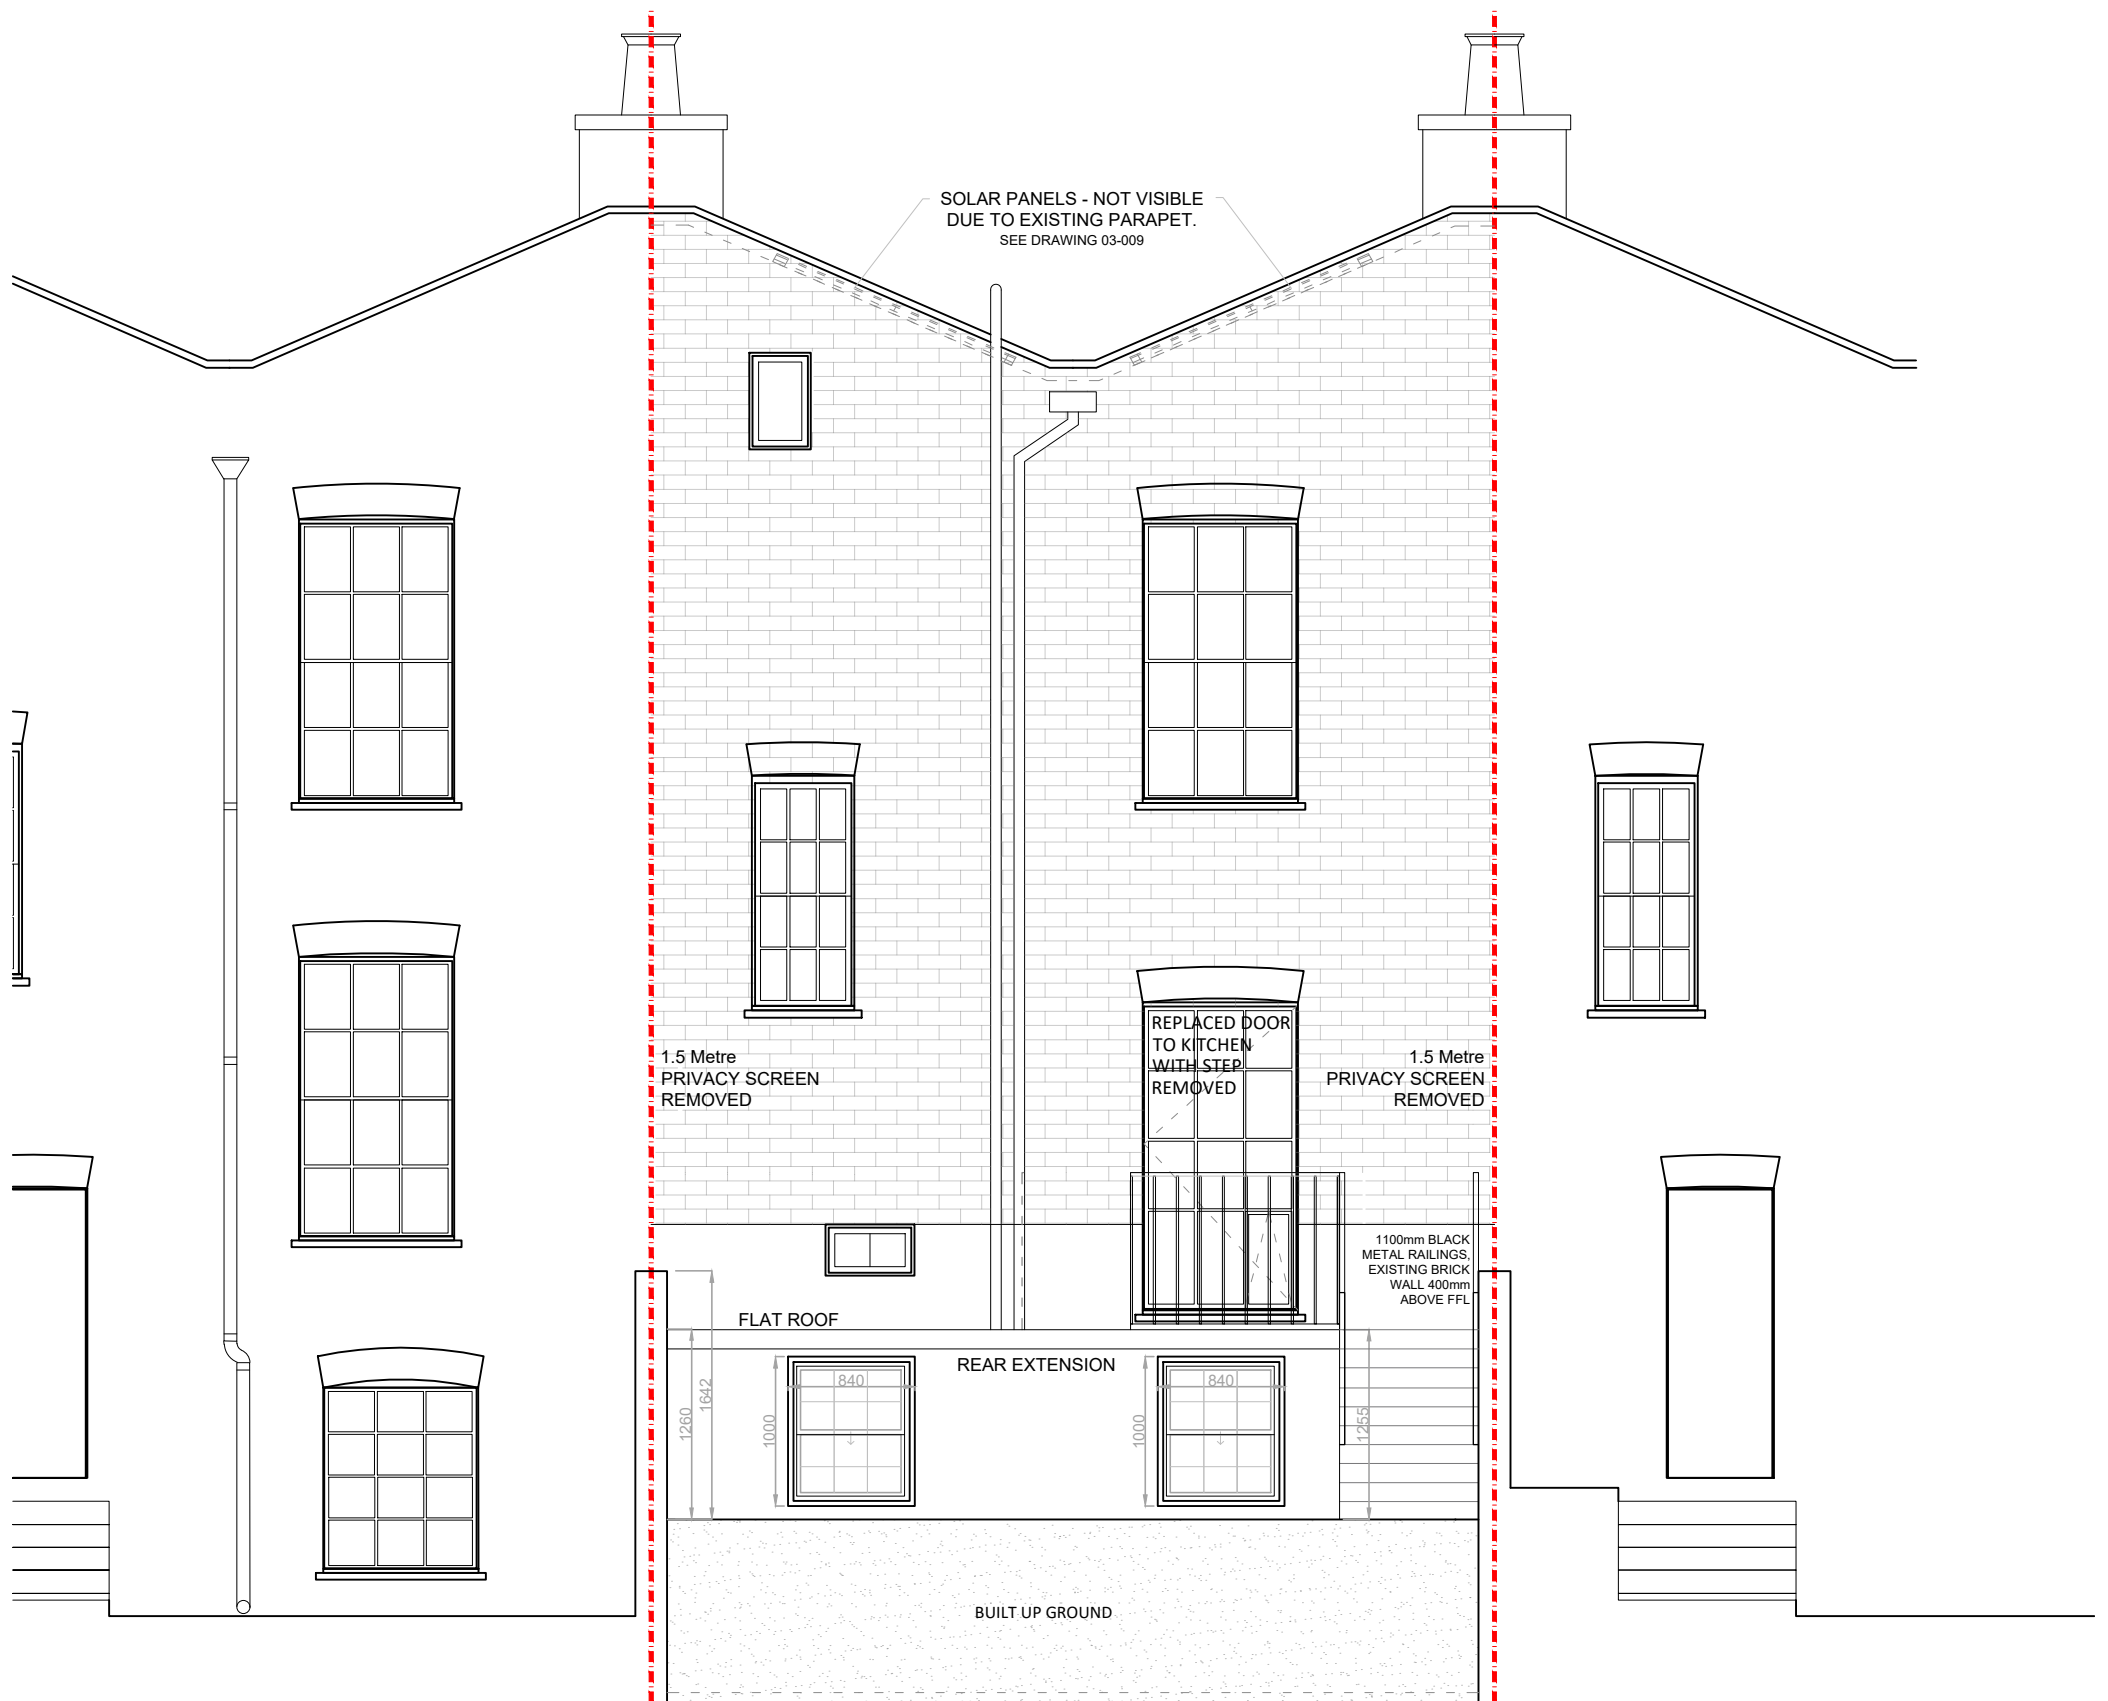

Rear Elevation (South West) 1:50




PROJECT:
10 Thanet St. London WC1H 9QL
DRAWING NAME:
Proposed Rear (North East) Elevation
NOTES:
Orientated to fit sheet size, 1:50@A3


© Copyright Once Printed and distributed this document is assumed uncontrolled.
© All rights reserved. No part of this drawing may be reproduced or transmitted in any form by any means without the written permission of the copyright holder.

D	MINOR AMENDMENTS - ISSUED	05.02.2024
C	UPDATED AS PER COMMENTS	15.10.2023
REV	DESCRIPTION	DATE

Purpose of Issue MINOR-AMENDMENT		
Drawn	-	Checked -
Date	27.06.2023	
Scale	1:50	@A3
Project Number	4033	Sheet Number DR-05-004
		Rev D

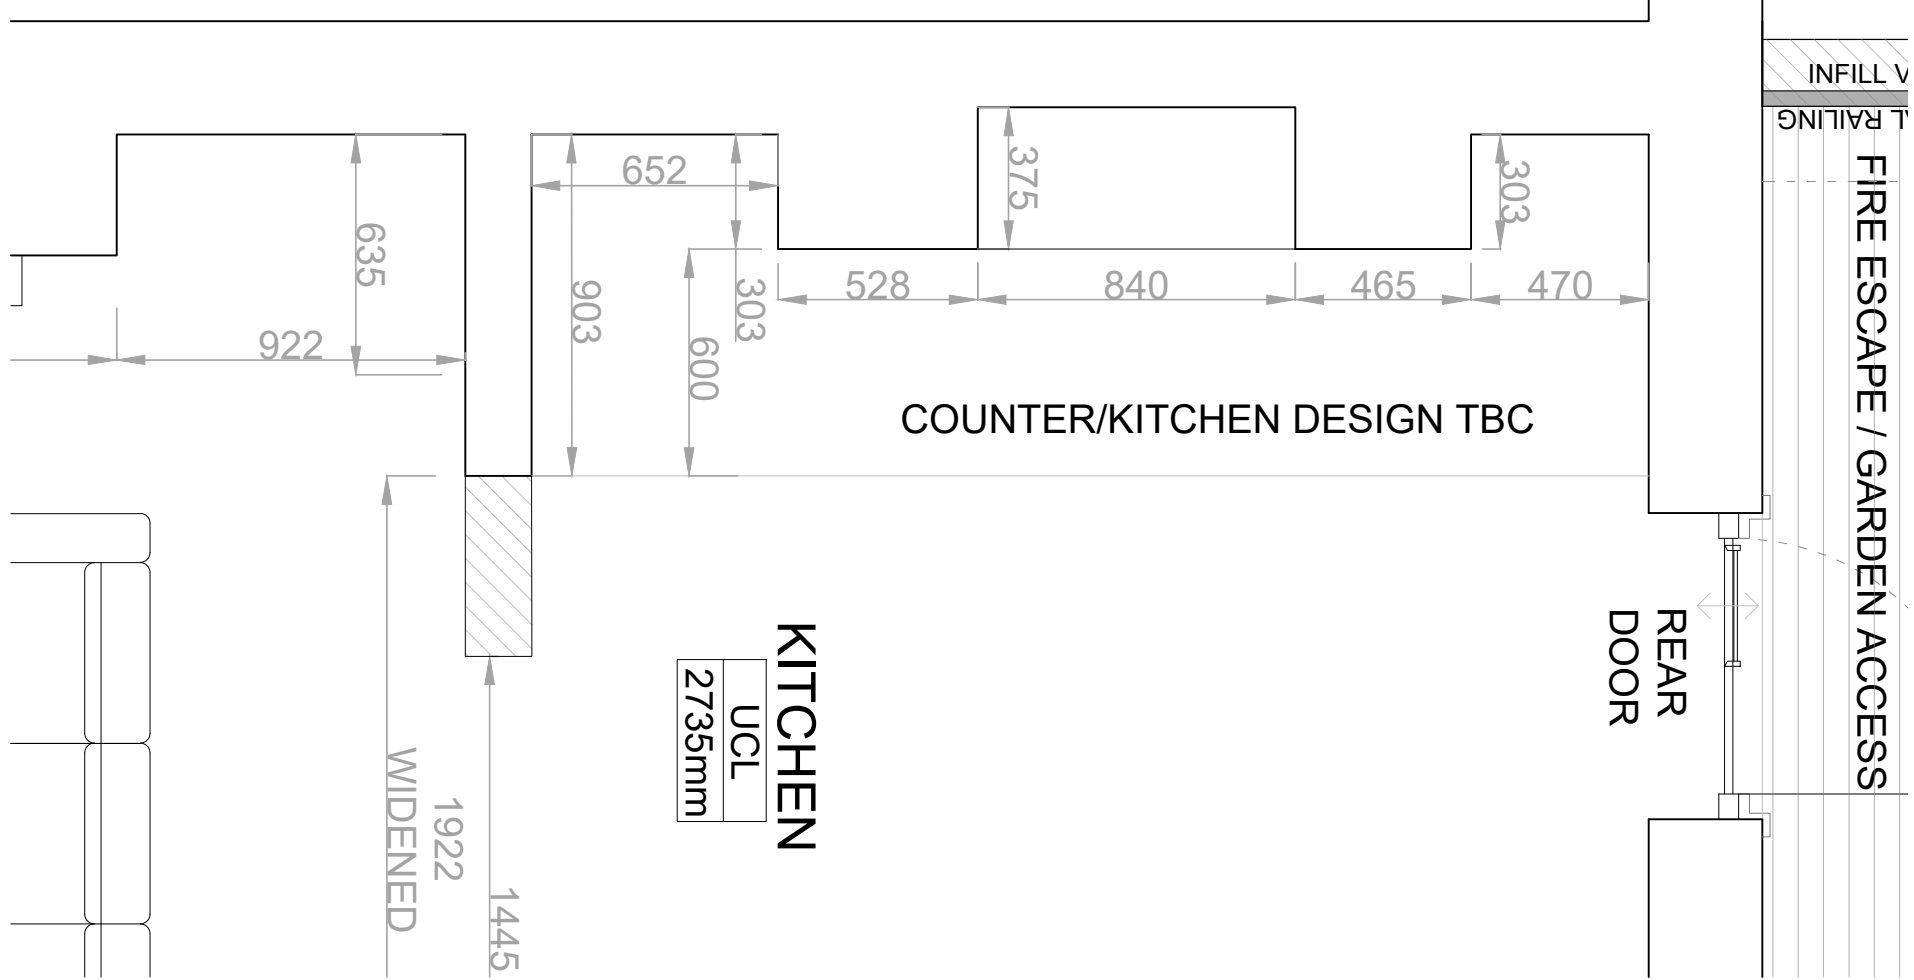

Kitchen Reference plan - 1:20

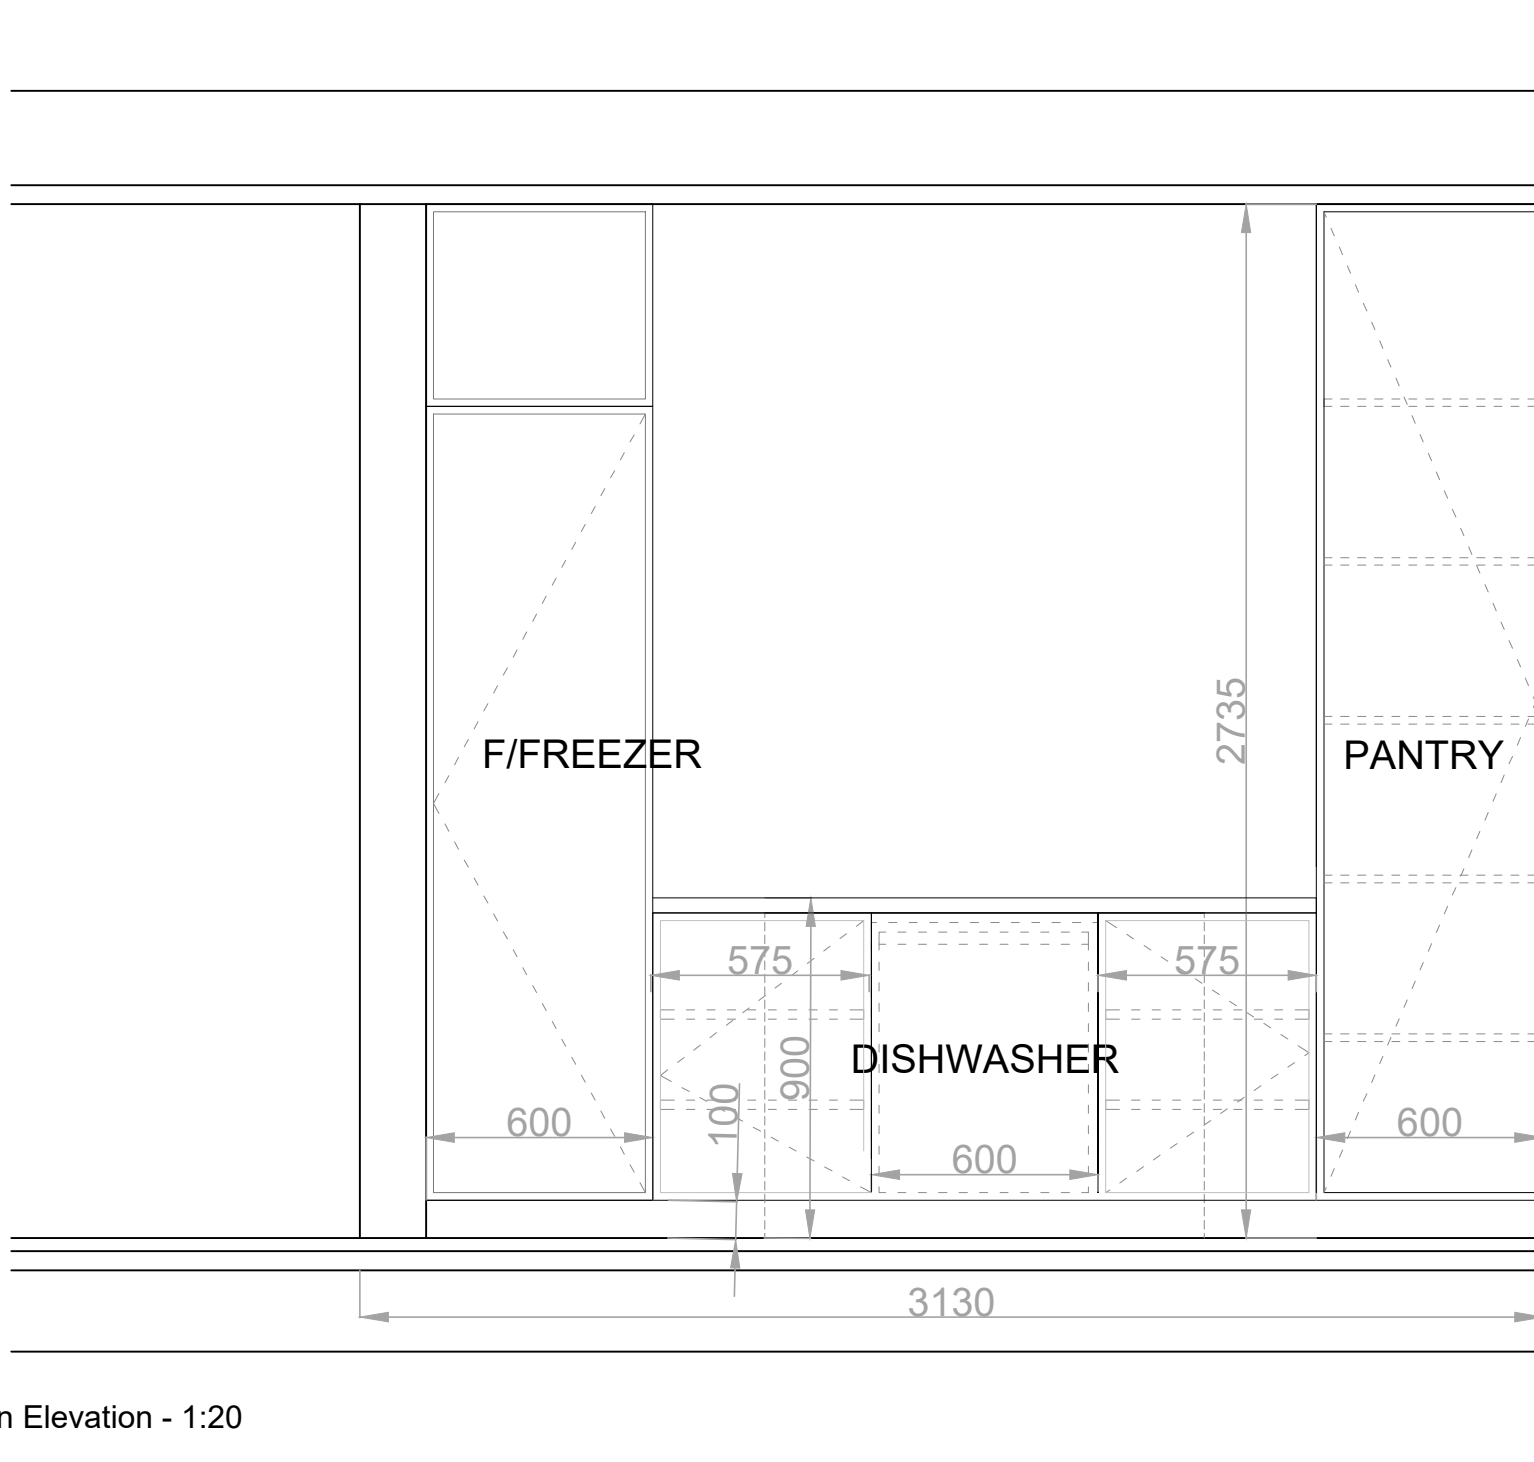

Kitchen Elevation - 1:20

C	MINOR AMENDMENTS - ISSUED	05.02.2024
B	UPDATED AS PER COMMENTS	14.10.2023
REV	DESCRIPTION	DATE

Purpose of Issue MINOR-AMENDMENT		
Drawn	-	Checked -
Date	27.06.2023	
Scale	1:20	@A3
Project Number	4033	Sheet Number DR-05-005
		Rev C




PROJECT:
10 Thanet St. London WC1H 9QL


DRAWING NAME:
Proposed Kitchen - Elevation

NOTES:
Orientated to fit sheet size, 1:20@A3

© Copyright Once Printed and distributed this document is assumed uncontrolled.
© All rights reserved. No part of this drawing may be reproduced or transmitted in any form by any means without the written permission of the copyright holder.

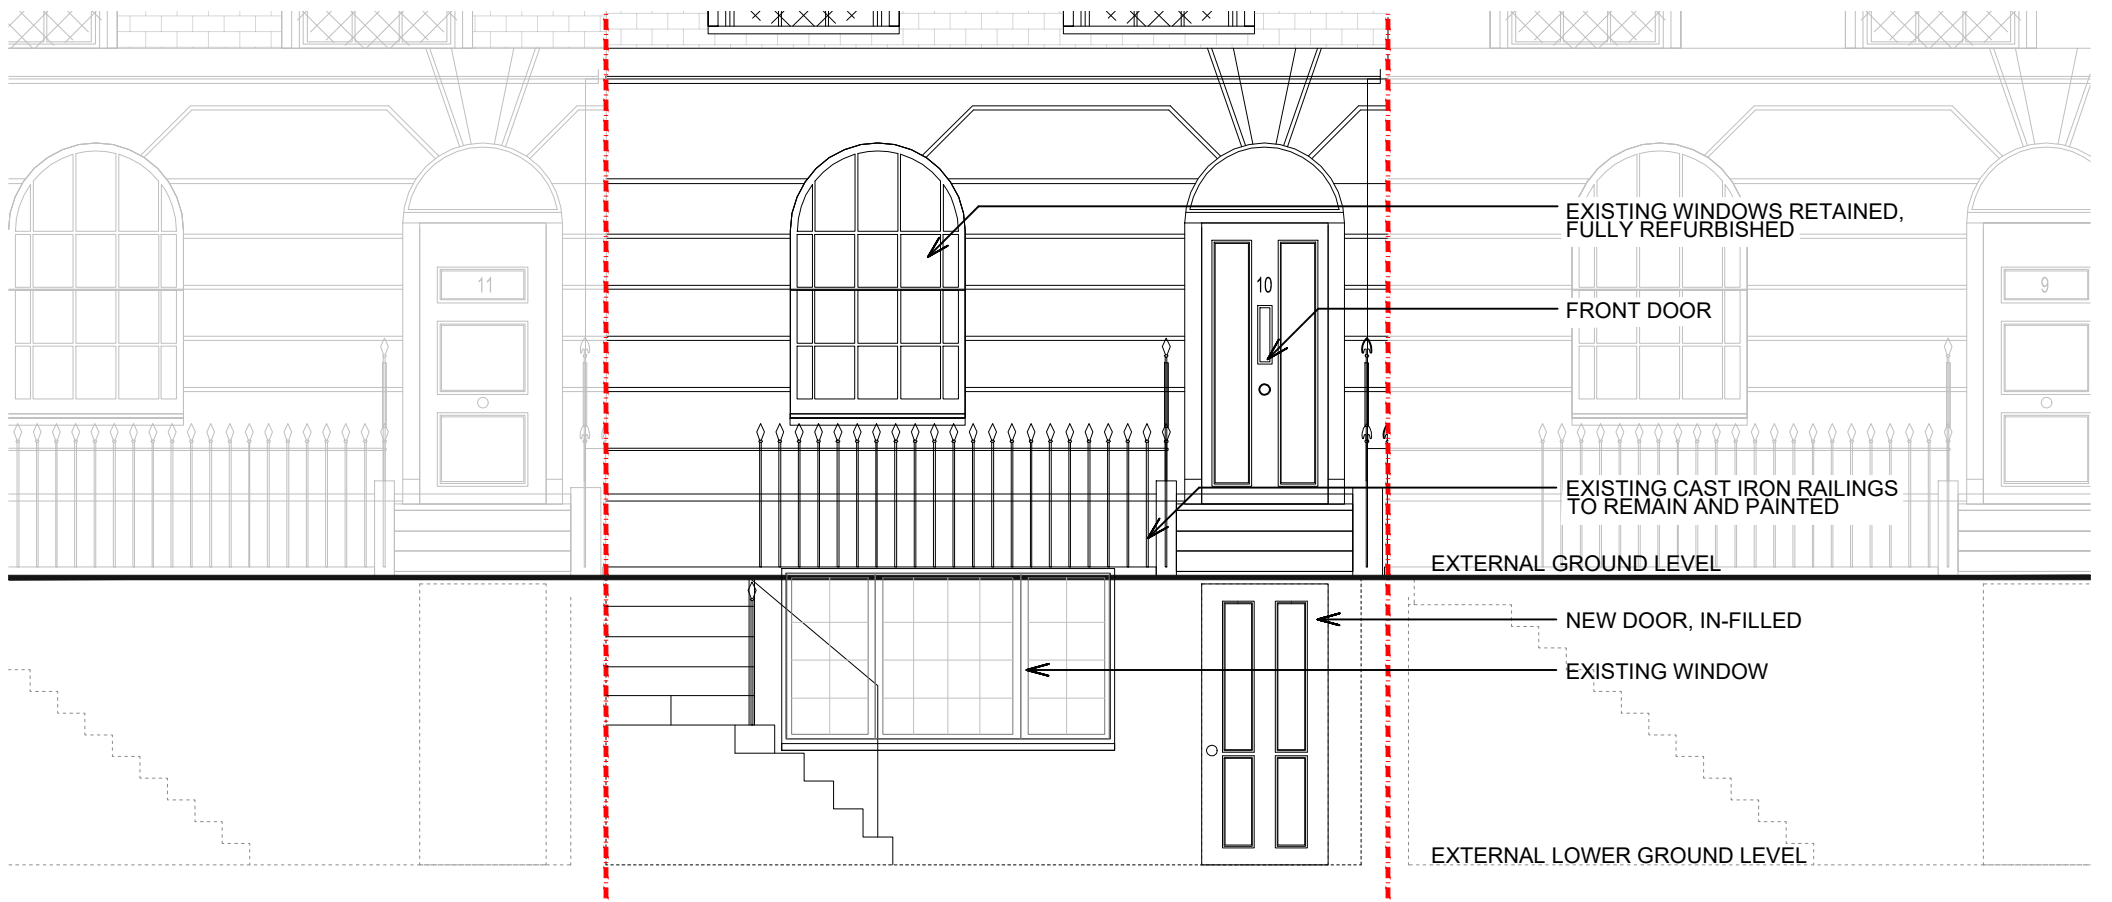

Front Elevation (North East) 1:50

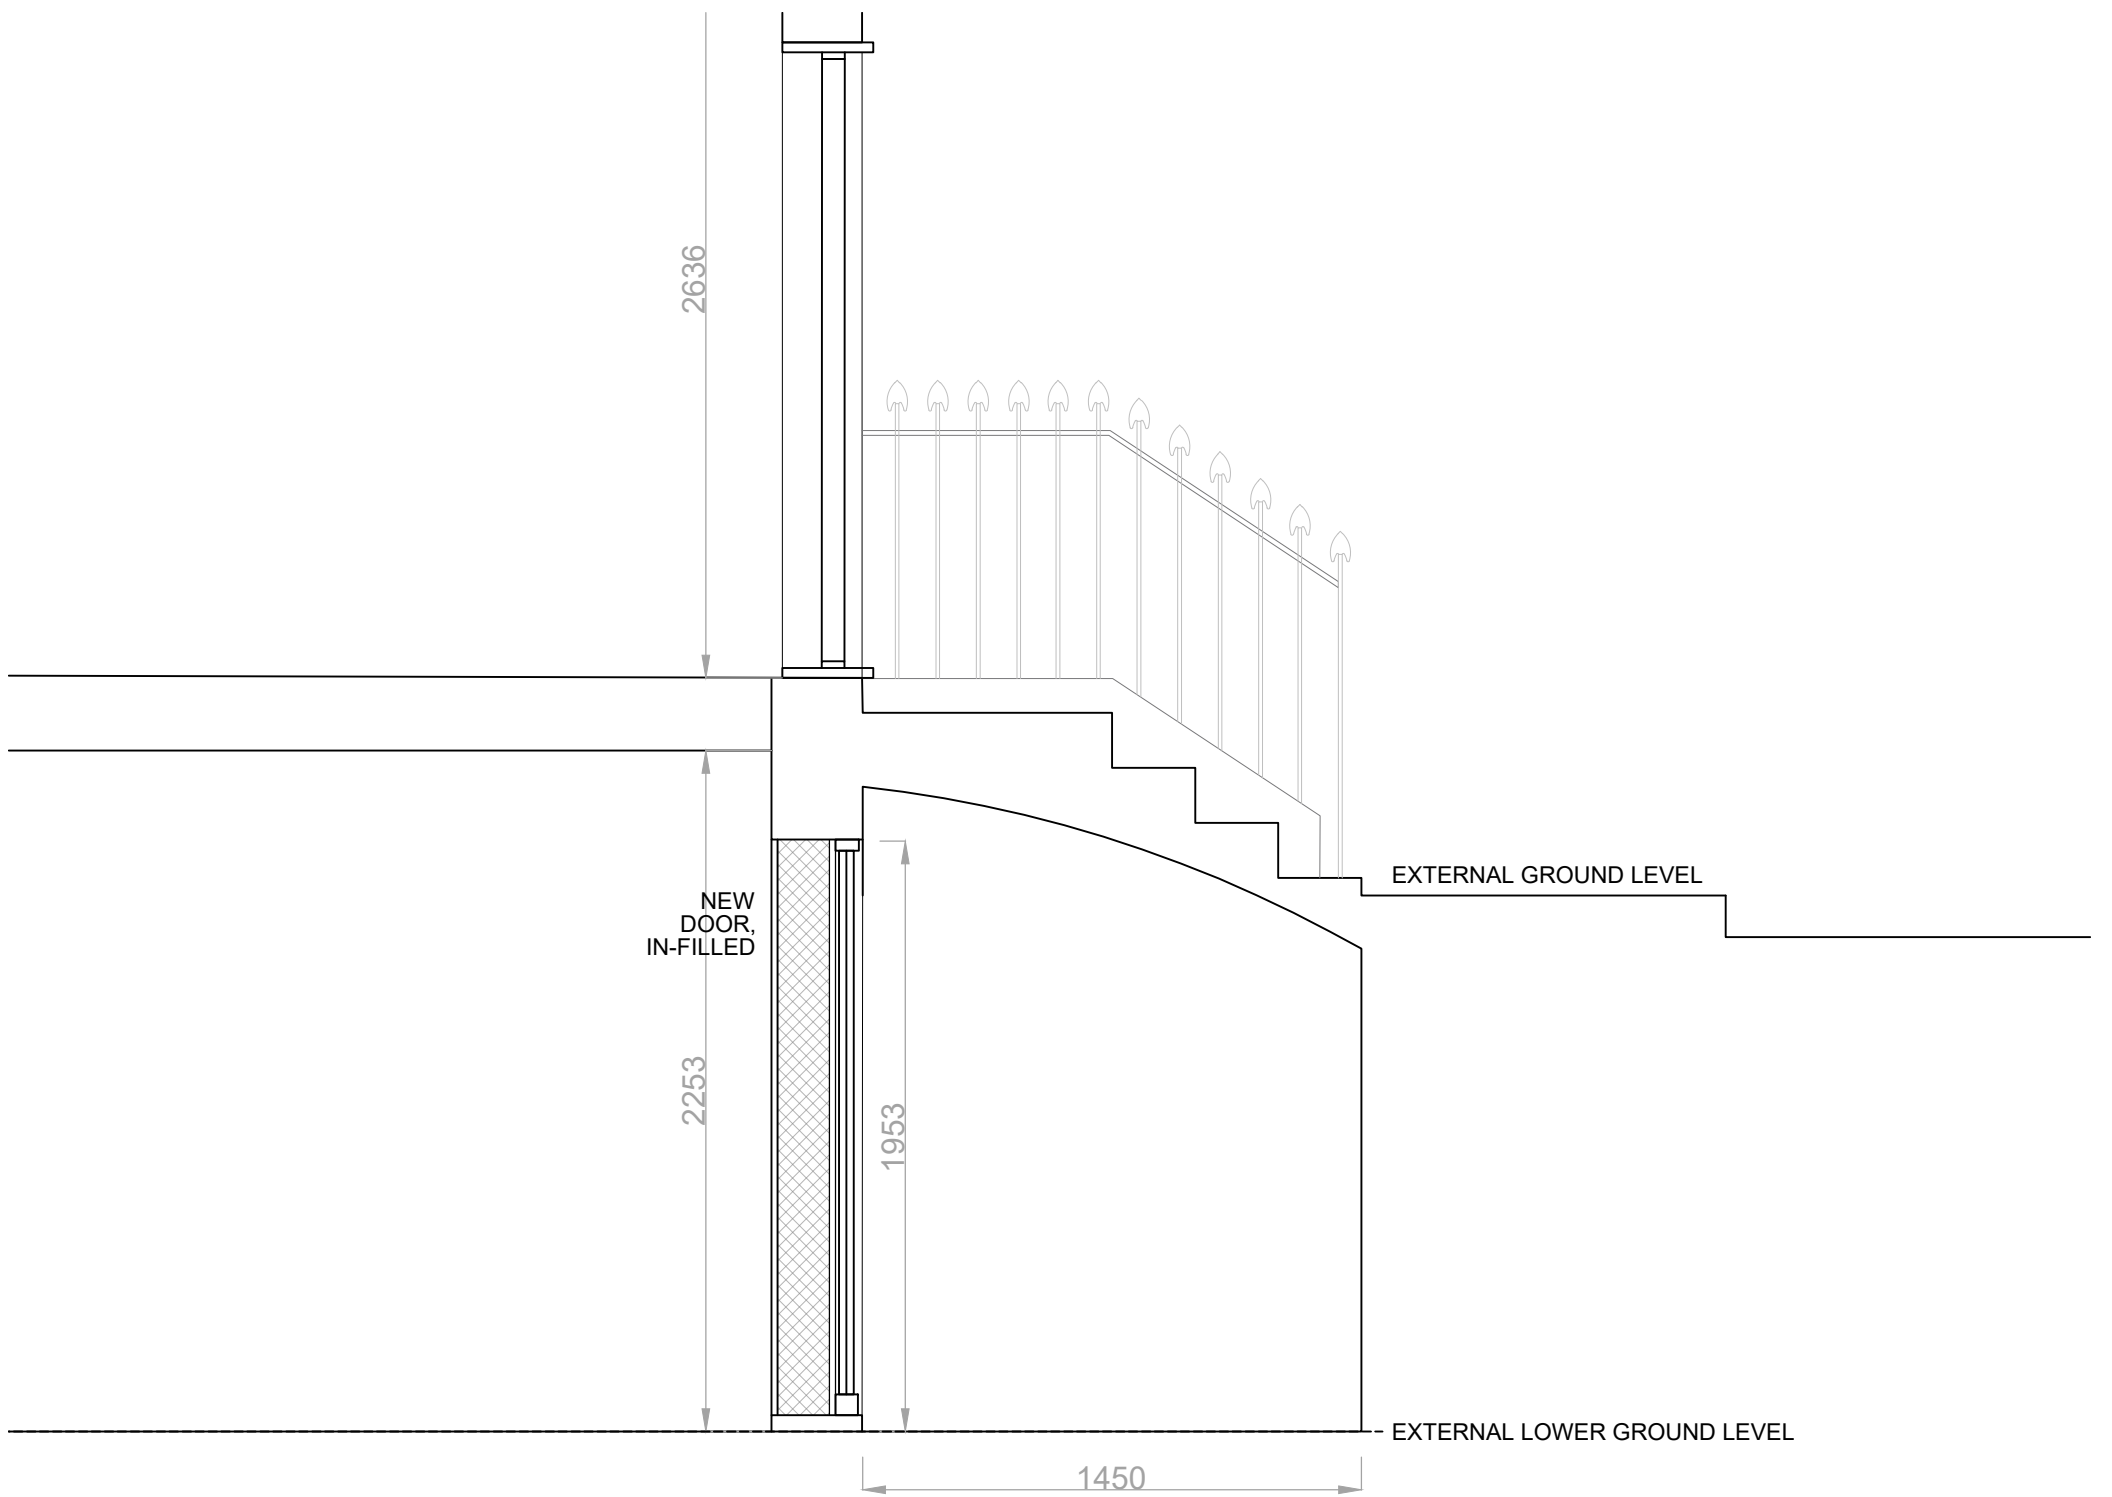


Lightwell End Elevation - 1:25

B	HEAT PUMP REMOVED	18.02.2024
A	MINOR AMENDMENTS - ISSUED	05.02.2024
REV	DESCRIPTION	DATE


Purpose of Issue MINOR-AMENDMENT		
Drawn	-	Checked -
Date	05.02.2024	
Scale	1:25	@A3
Project Number	Sheet Number	Rev
4033	DR-05-006	B



PROJECT:
10 Thanet St. London WC1H 9QL
DRAWING NAME:
Proposed Front (North East) Elevation - Basement Lightwell
NOTES:
Orientated to fit sheet size, 1:25@A3
© Copyright Once Printed and distributed this document is assumed uncontrolled.
© All rights reserved. No part of this drawing may be reproduced or transmitted in any form by any means without the written permission of the copyright holder.

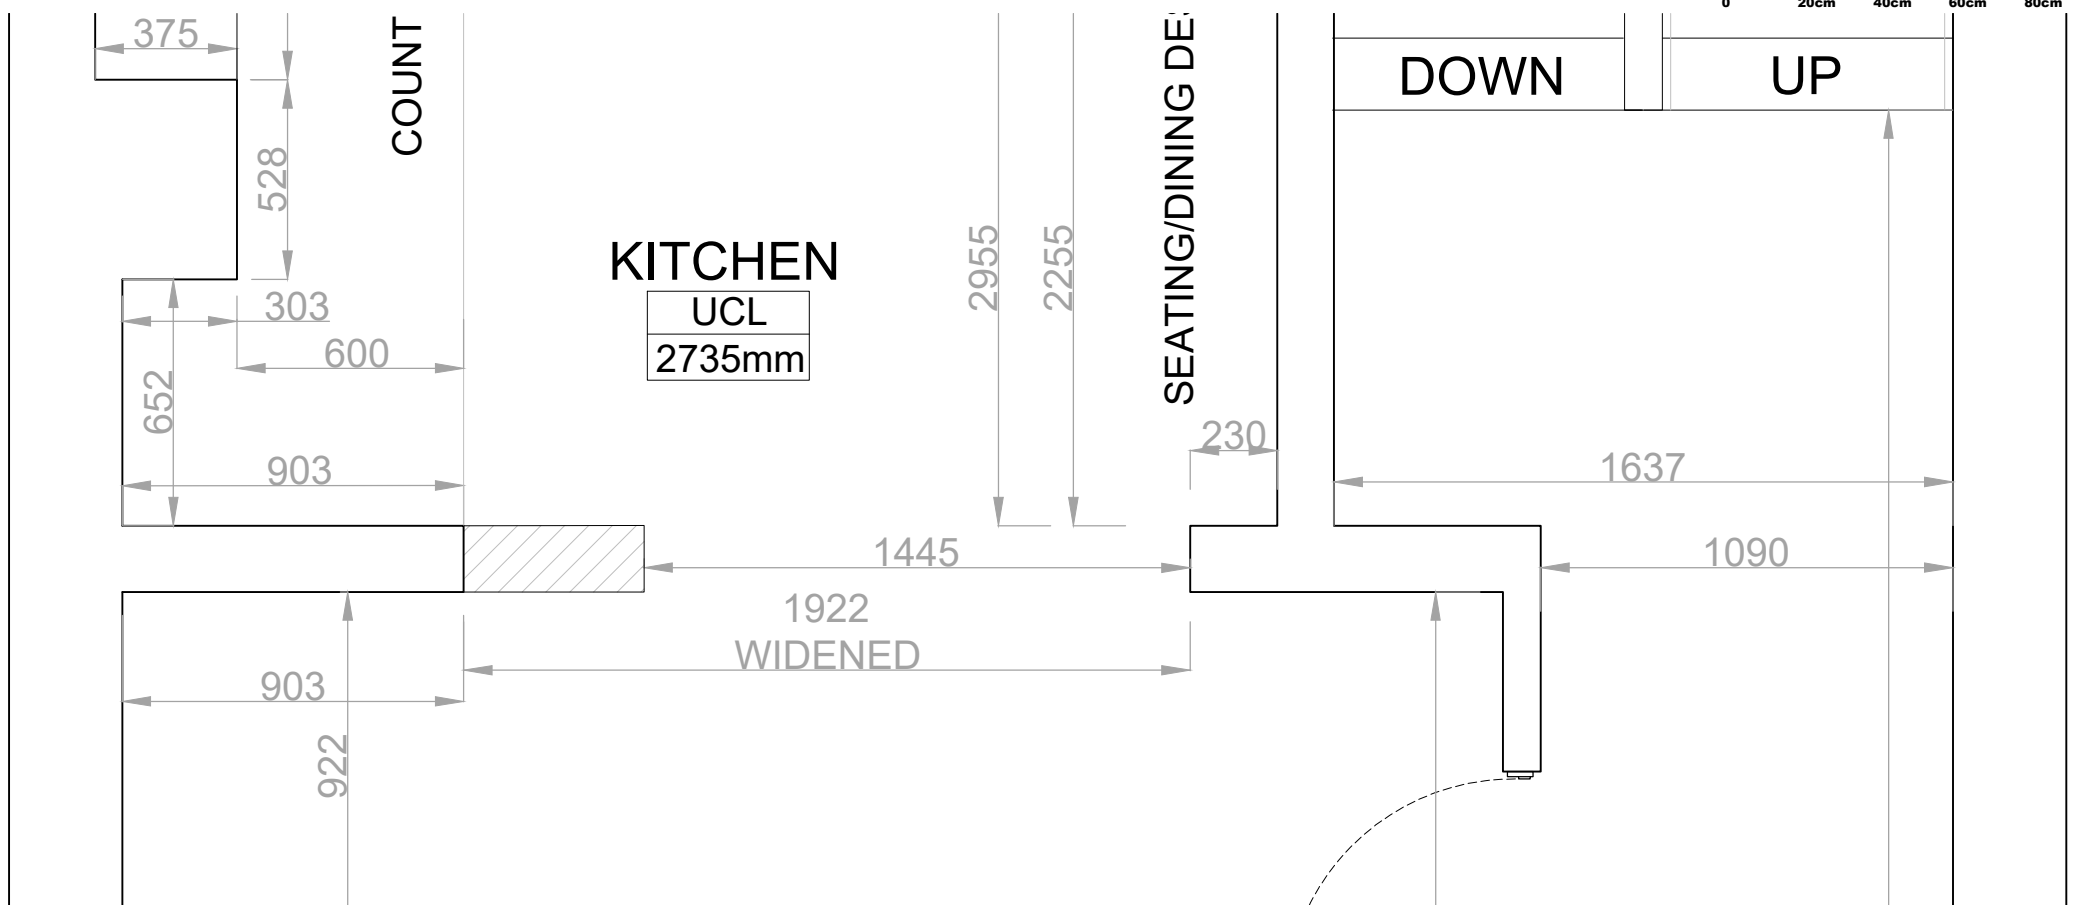

Proposed Opening Reference Plan - 1:20

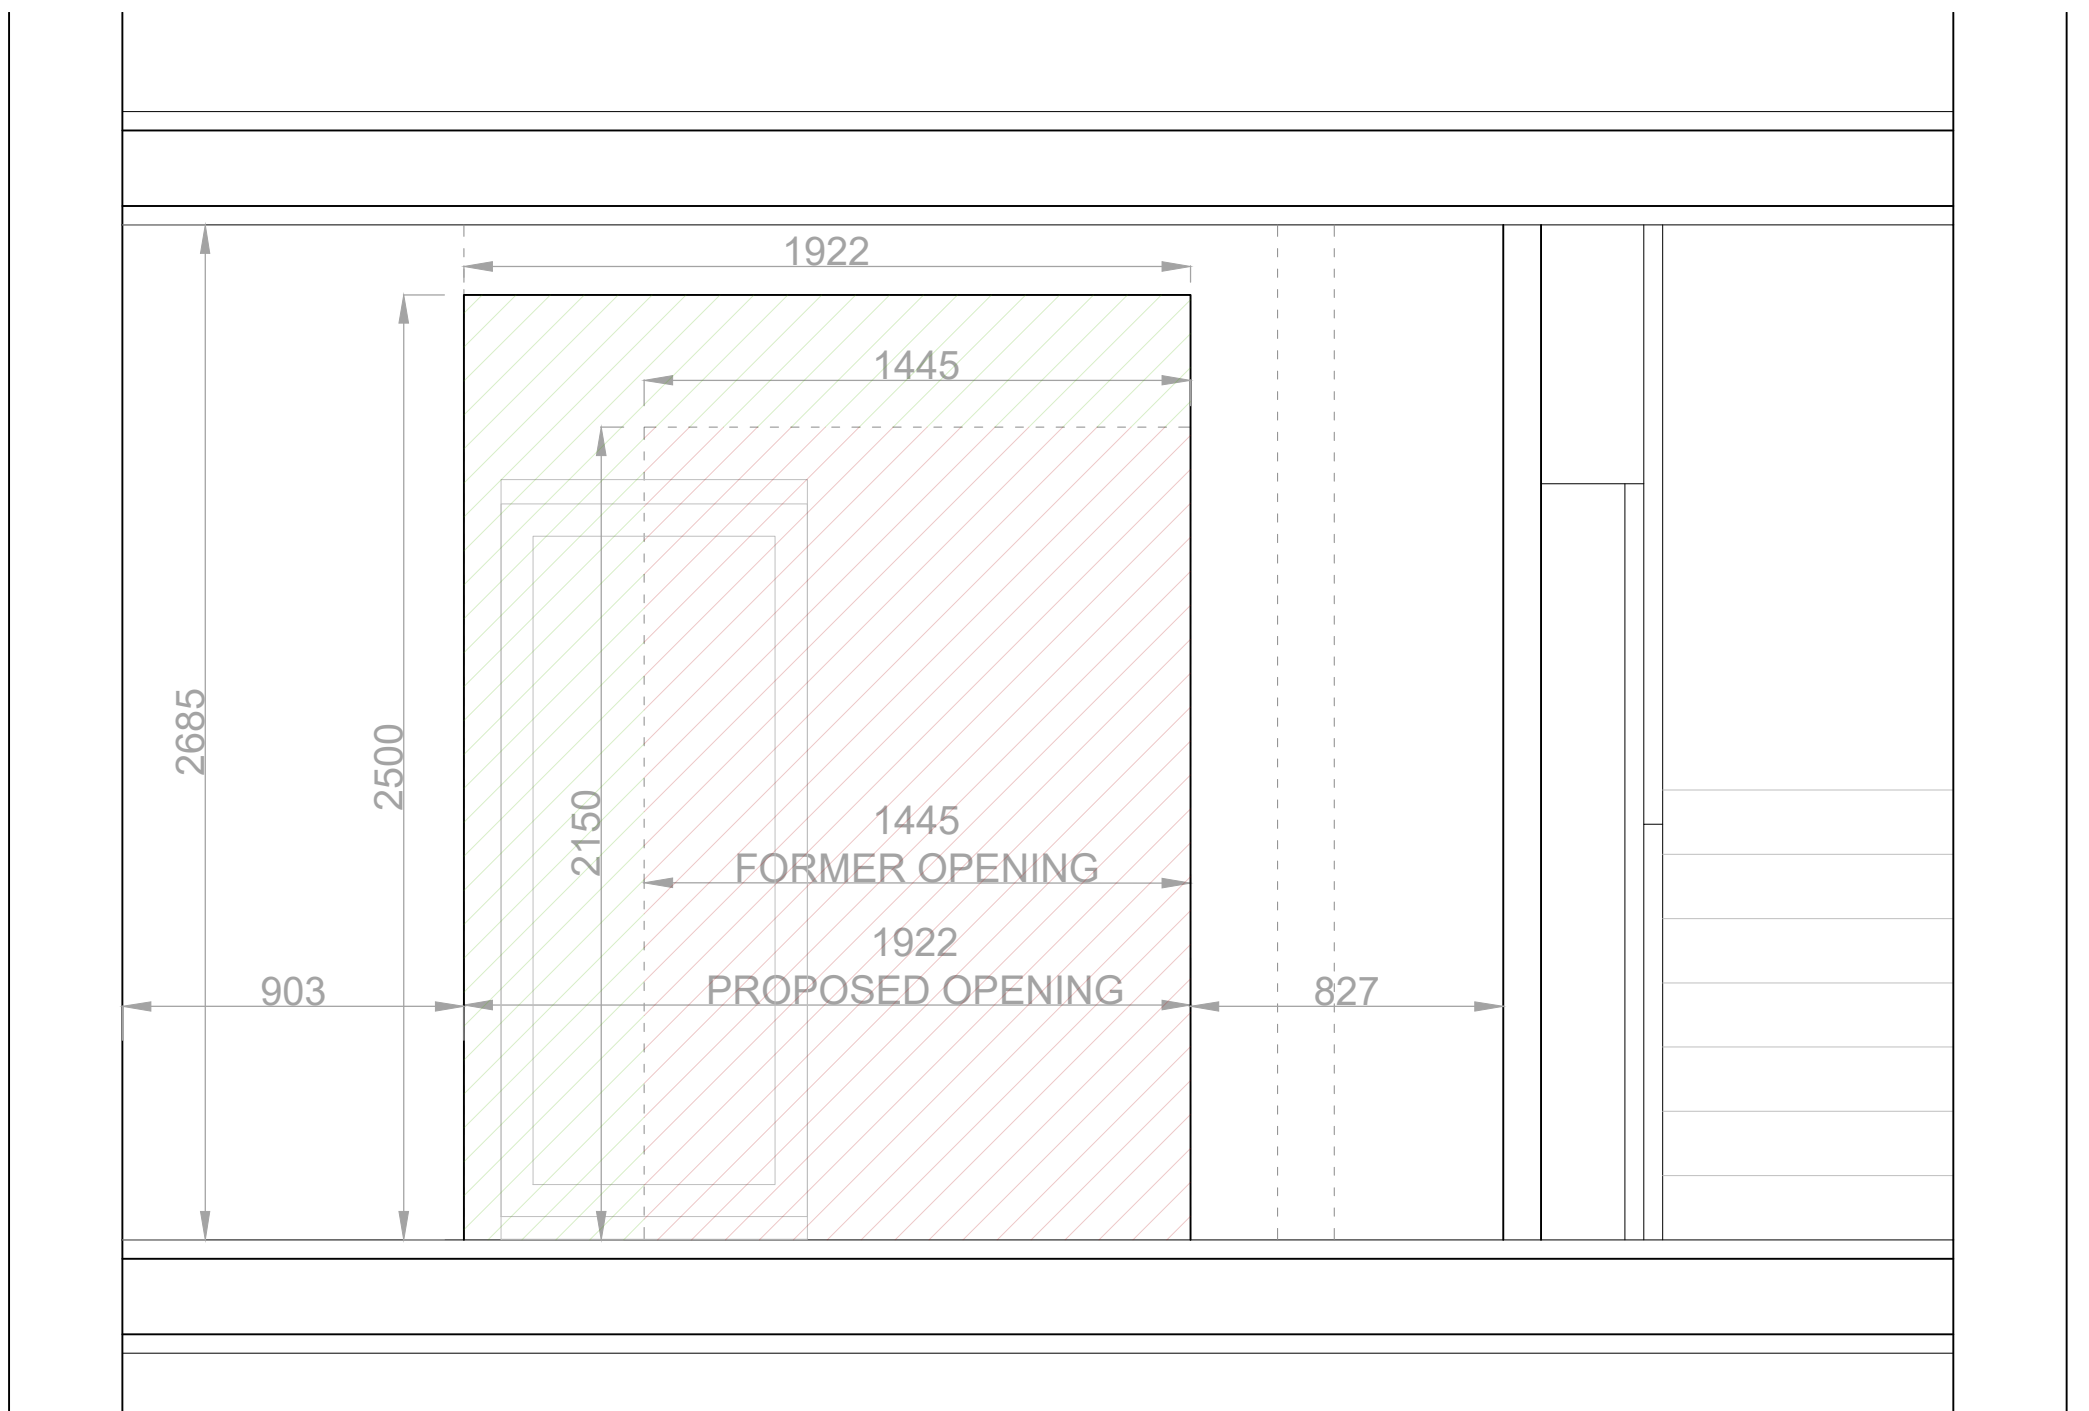


Proposed Opening Elevation - 1:20



PROJECT:
10 Thanet St. London WC1H 9QL
DRAWING NAME:
Proposed Ground Floor Internal Opening
NOTES:
Orientated to fit sheet size, 1:20@A3
© Copyright Once Printed and distributed this document is assumed uncontrolled.
© All rights reserved. No part of this drawing may be reproduced or transmitted in any form by any means without the written permission of the copyright holder.

A	MINOR AMENDMENTS - ISSUED	06.02.2024
REV	DESCRIPTION	DATE
Purpose of Issue MINOR-AMENDMENT		
Drawn	-	Checked -
Date	06.02.2024	
Scale	1:20	@A3
Project Number	Sheet Number	Rev
4033	DR-05-007	A

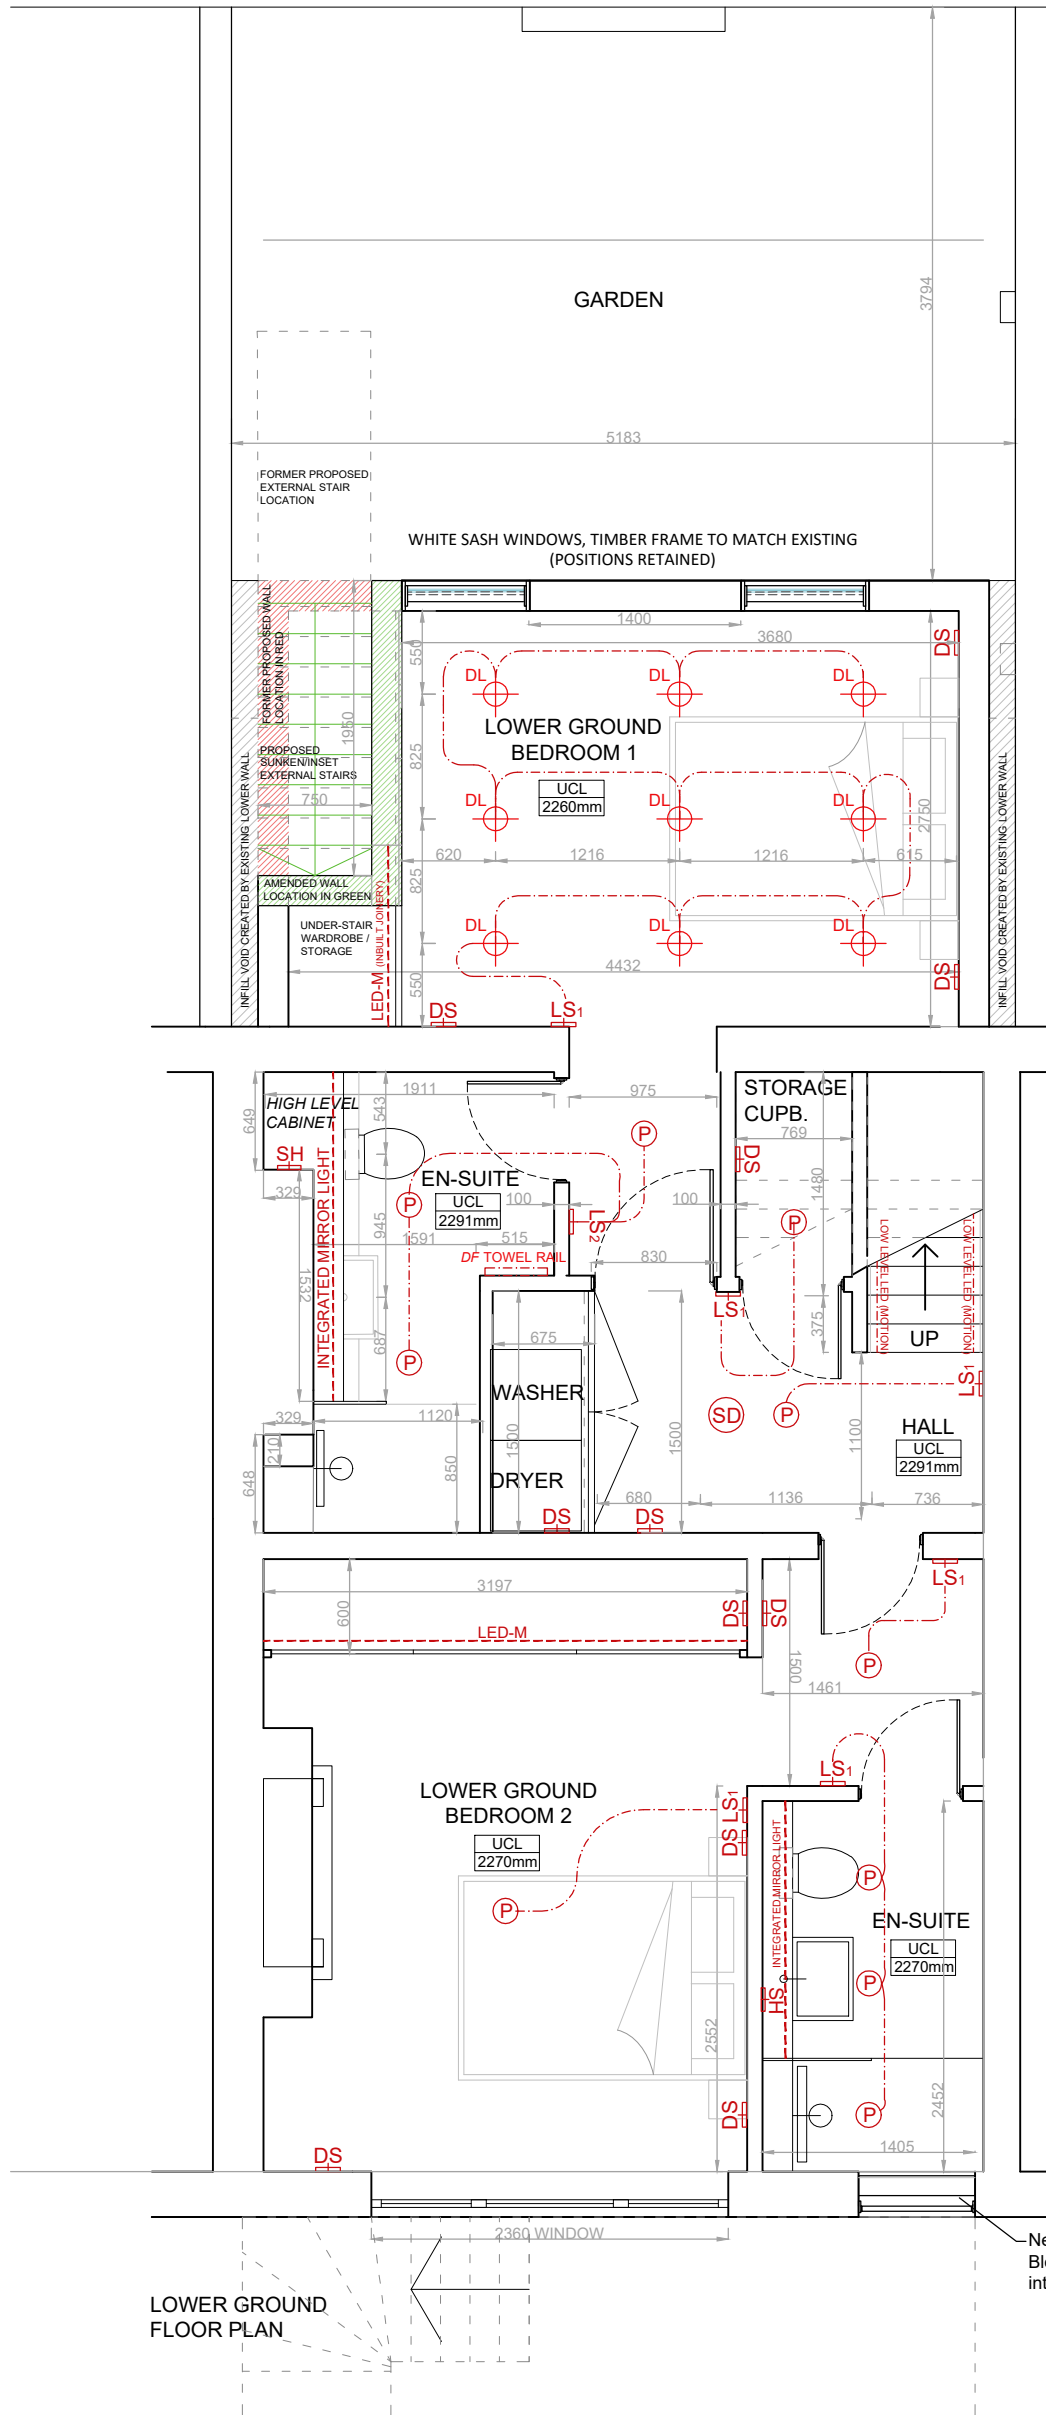

- LEGEND:**
- LS₁ 1 Gang Light Switch
 - LS₂ 2 Gang Light Switch
 - SS Single Socket
 - DS Double Socket
 - BT RJ11 Socket
 - 5A 5 Amp Socket
 - SH Shaver Socket
 - SD Mains Wired Smoke Detector (Battery back-up)
 - HD Mains Wired Heat Detector (Battery back-up)
 - P Pendant Light
 - DL IP65 Recessed Downlight
 - WL Wall Light
 - LED Recessed LED's
 - LED-M Recessed LED's - Motion Activated

C	UPDATED AS PER COMMENTS	04.04.2024
REV	DESCRIPTION	DATE
Purpose of Issue MINOR-AMENDMENT		
Drawn	-	Checked -
Date	27.06.23	
Scale	1:50	@A3
Project Number	Sheet Number	Rev
4033	DR-60-001	C


PROJECT:
10 Thanet St. London WC1H 9QL

DRAWING NAME:
Proposed Lower Ground Floor Electrical Plan

NOTES:
Orientated to fit sheet size, 1:50@A3

© Copyright Once Printed and distributed this document is assumed uncontrolled.
© All rights reserved. No part of this drawing may be reproduced or transmitted in any form by any means without the written permission of the copyright holder.



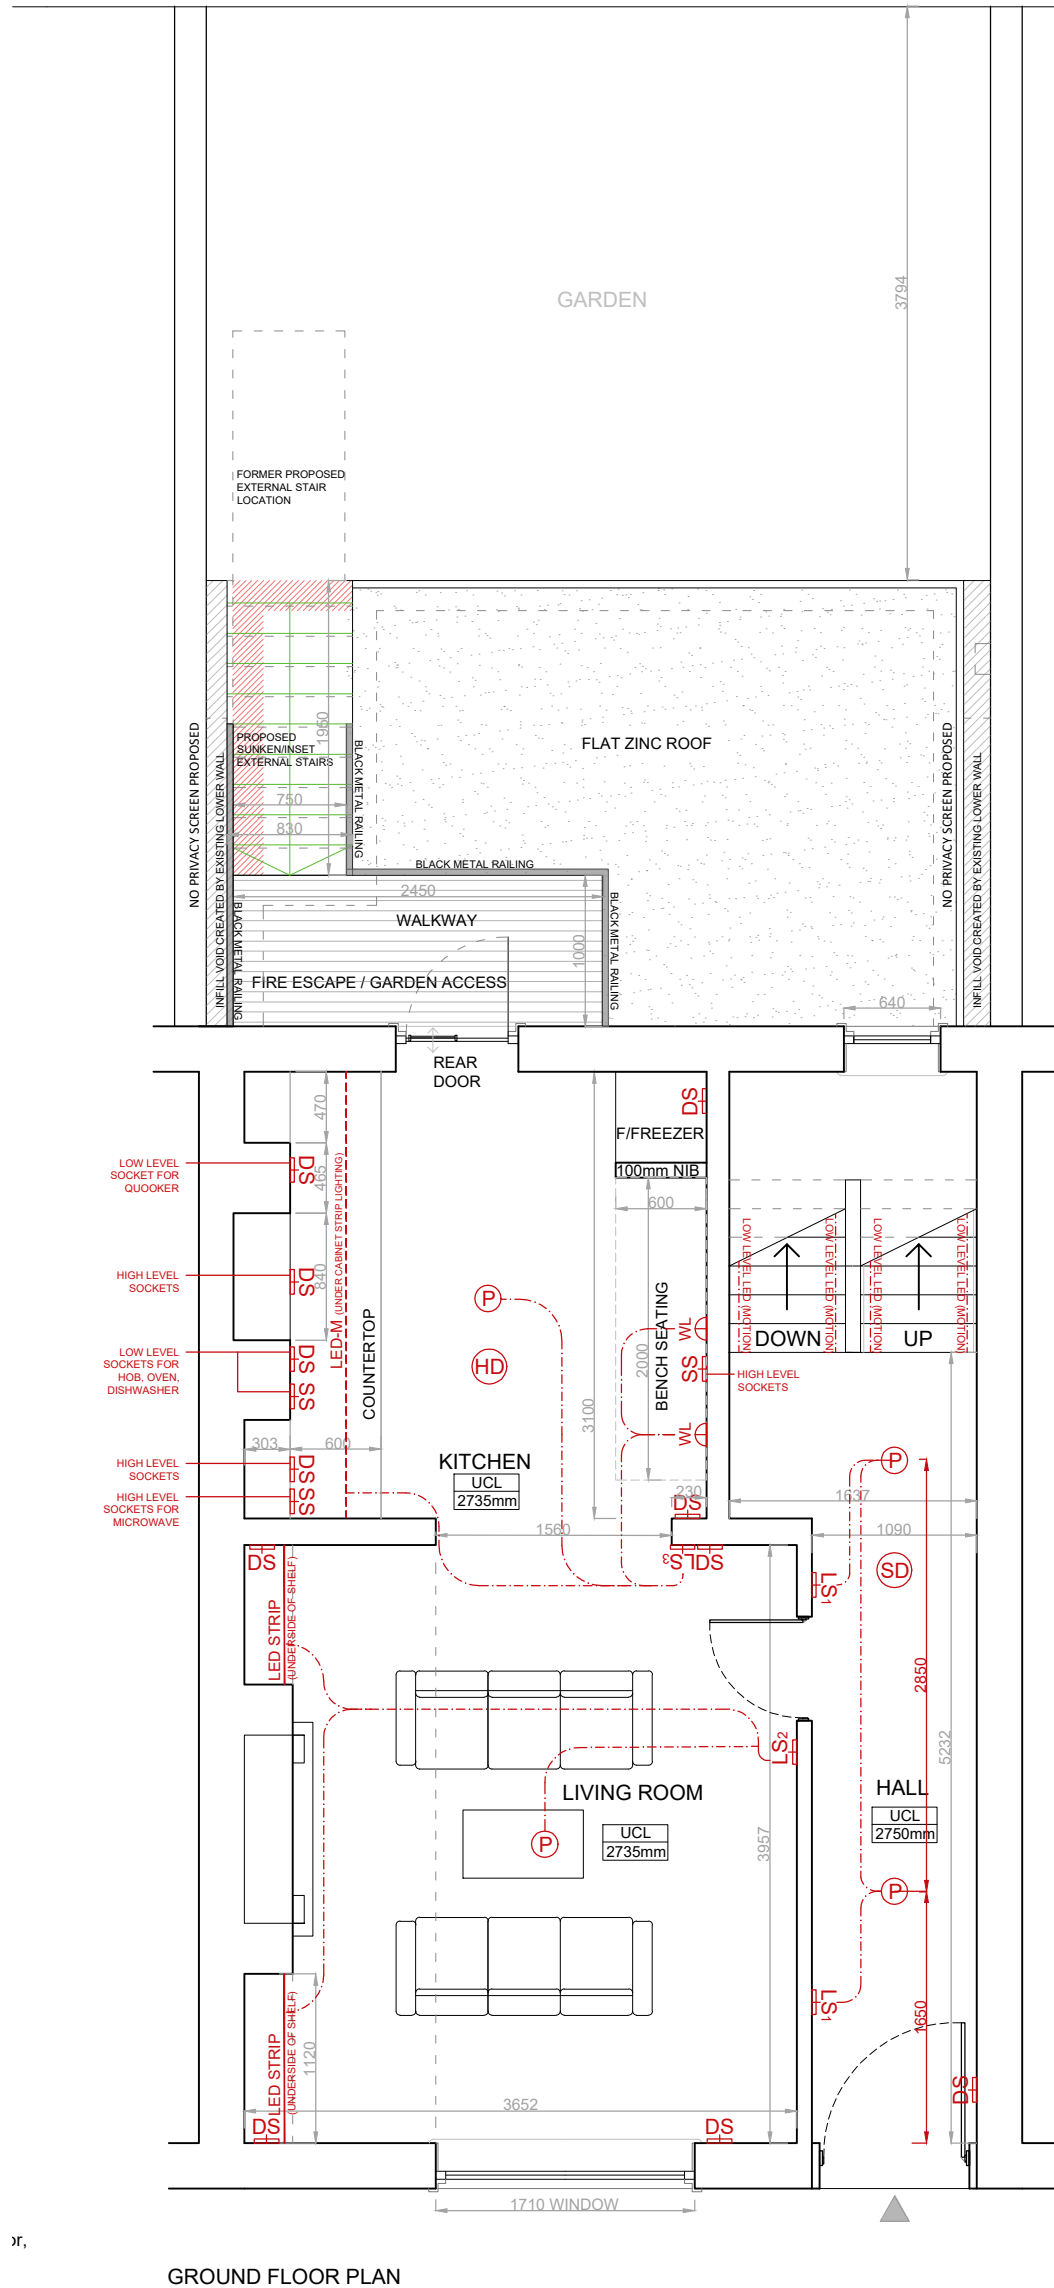

LEGEND:

- LS₁ 1 Gang Light Switch
- LS₂ 2 Gang Light Switch
- SS Single Socket
- DS Double Socket
- BT RJ11 Socket
- 5A 5 Amp Socket
- SH Shaver Socket
- SD Mains Wired Smoke Detector (Battery back-up)
- HD Mains Wired Heat Detector (Battery back-up)
- P Pendant Light
- DL IP65 Recessed Downlight
- WL Wall Light
- LED Recessed LED's
- LED-M Recessed LED's - Motion Activated


C	UPDATED AS PER COMMENTS	04.04.2024
REV	DESCRIPTION	DATE

Purpose of Issue MINOR-AMENDMENT		
Drawn	-	Checked -
Date	27.06.23	
Scale	1:50	@A3
Project Number	4033	Sheet Number DR-60-002
		Rev C

PROJECT:
10 Thanet St. London WC1H 9QL
DRAWING NAME:
Proposed Ground Floor Electrical Plan
NOTES:
Orientated to fit sheet size, 1:50@A3

© Copyright Once Printed and distributed this document is assumed uncontrolled.
© All rights reserved. No part of this drawing may be reproduced or transmitted in any form by any means without the written permission of the copyright holder.



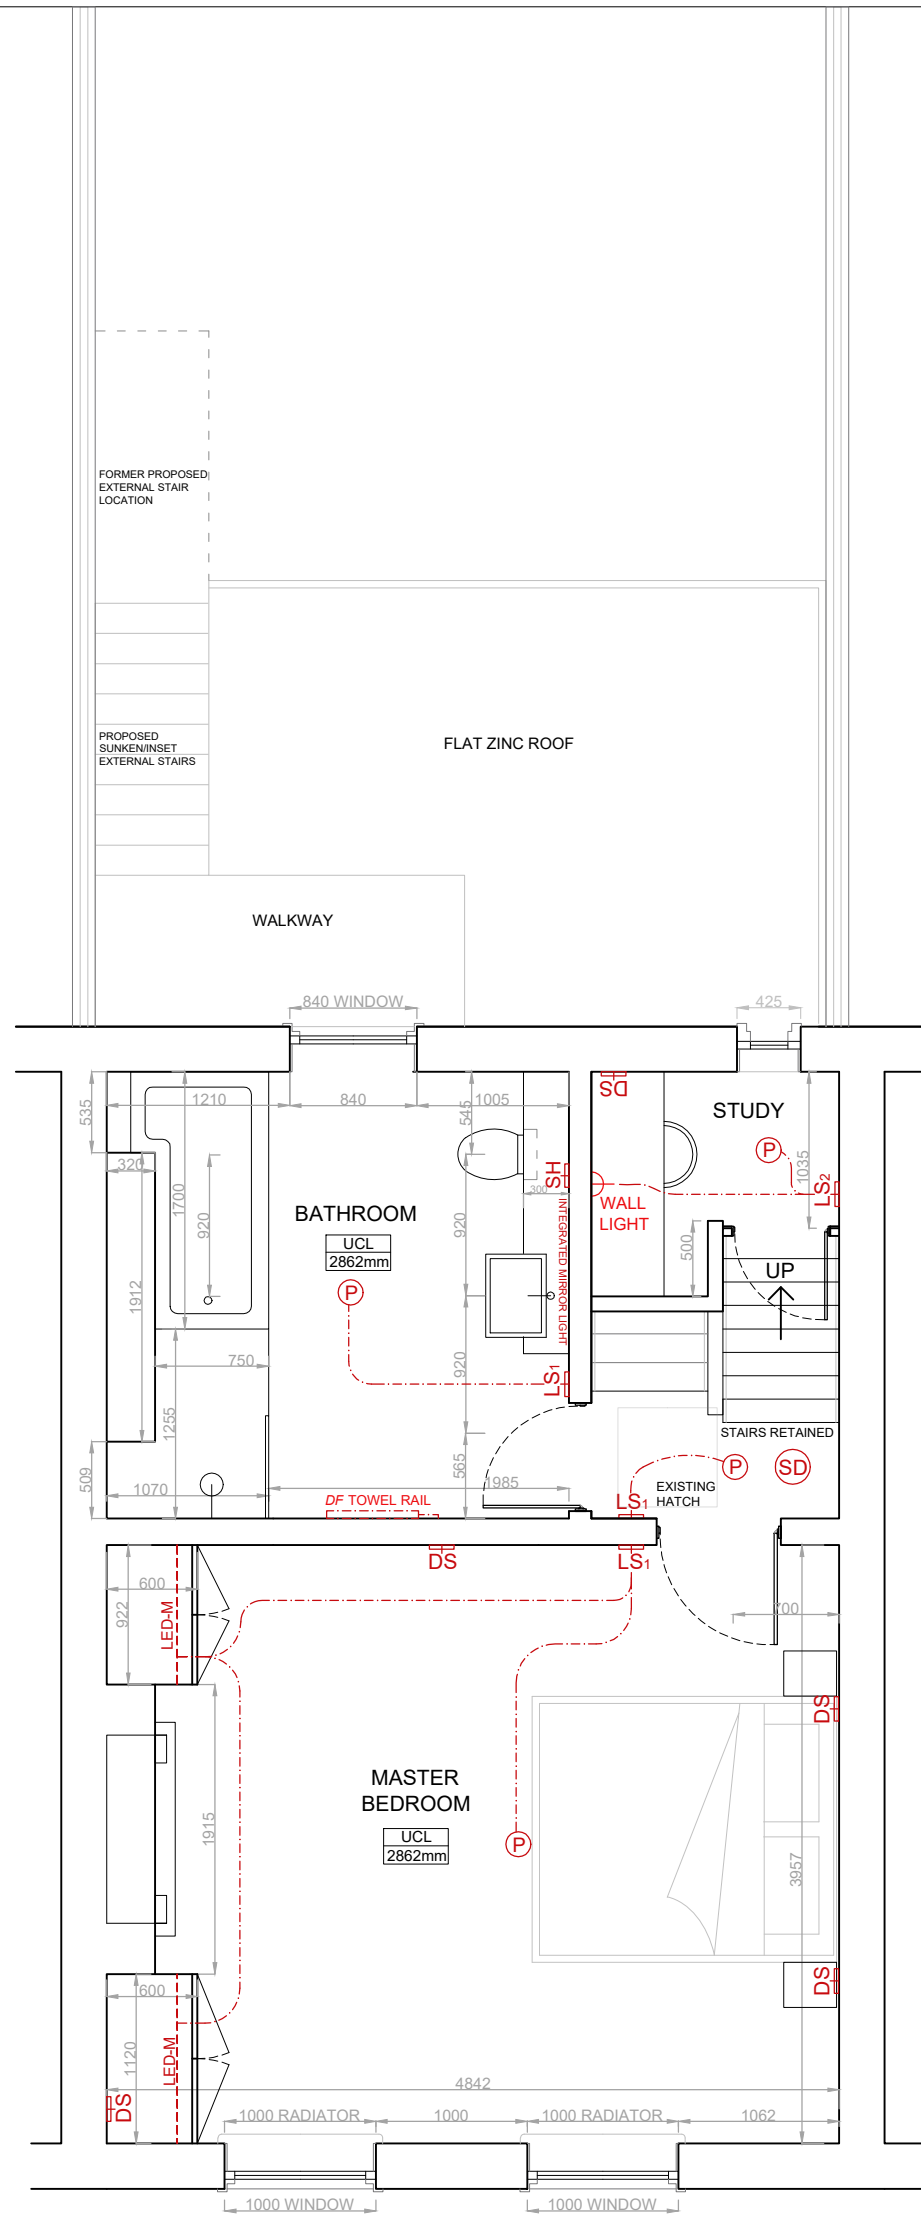

FIRST FLOOR PLAN

LEGEND:

- LS₁ 1 Gang Light Switch
- LS₂ 2 Gang Light Switch
- SS Single Socket
- DS Double Socket
- BT RJ11 Socket
- 5A 5 Amp Socket
- SH Shaver Socket
- SD Mains Wired Smoke Detector (Battery back-up)
- HD Mains Wired Heat Detector (Battery back-up)
- P Pendant Light
- DL IP65 Recessed Downlight
- W Wall Light
- LED Recessed LED's
- LED-M Recessed LED's - Motion Activated

C	UPDATED AS PER COMMENTS	04.03.2024
B	MINOR AMENDMENTS - ISSUED	05.02.2024
REV	DESCRIPTION	DATE


Purpose of Issue MINOR-AMENDMENT		
Drawn	-	Checked -
Date	27.06.23	
Scale	1:50	@A3
Project Number	4033	Sheet Number DR-60-003
		Rev C

PROJECT:
 10 Thanet St. London WC1H 9QL
 DRAWING NAME:
 Proposed First Floor Electrical Plan

NOTES:
 Orientated to fit sheet size, 1:50@A3

© Copyright Once Printed and distributed this document is assumed uncontrolled.
 © All rights reserved. No part of this drawing may be reproduced or transmitted in any form by any means without the written permission of the copyright holder.



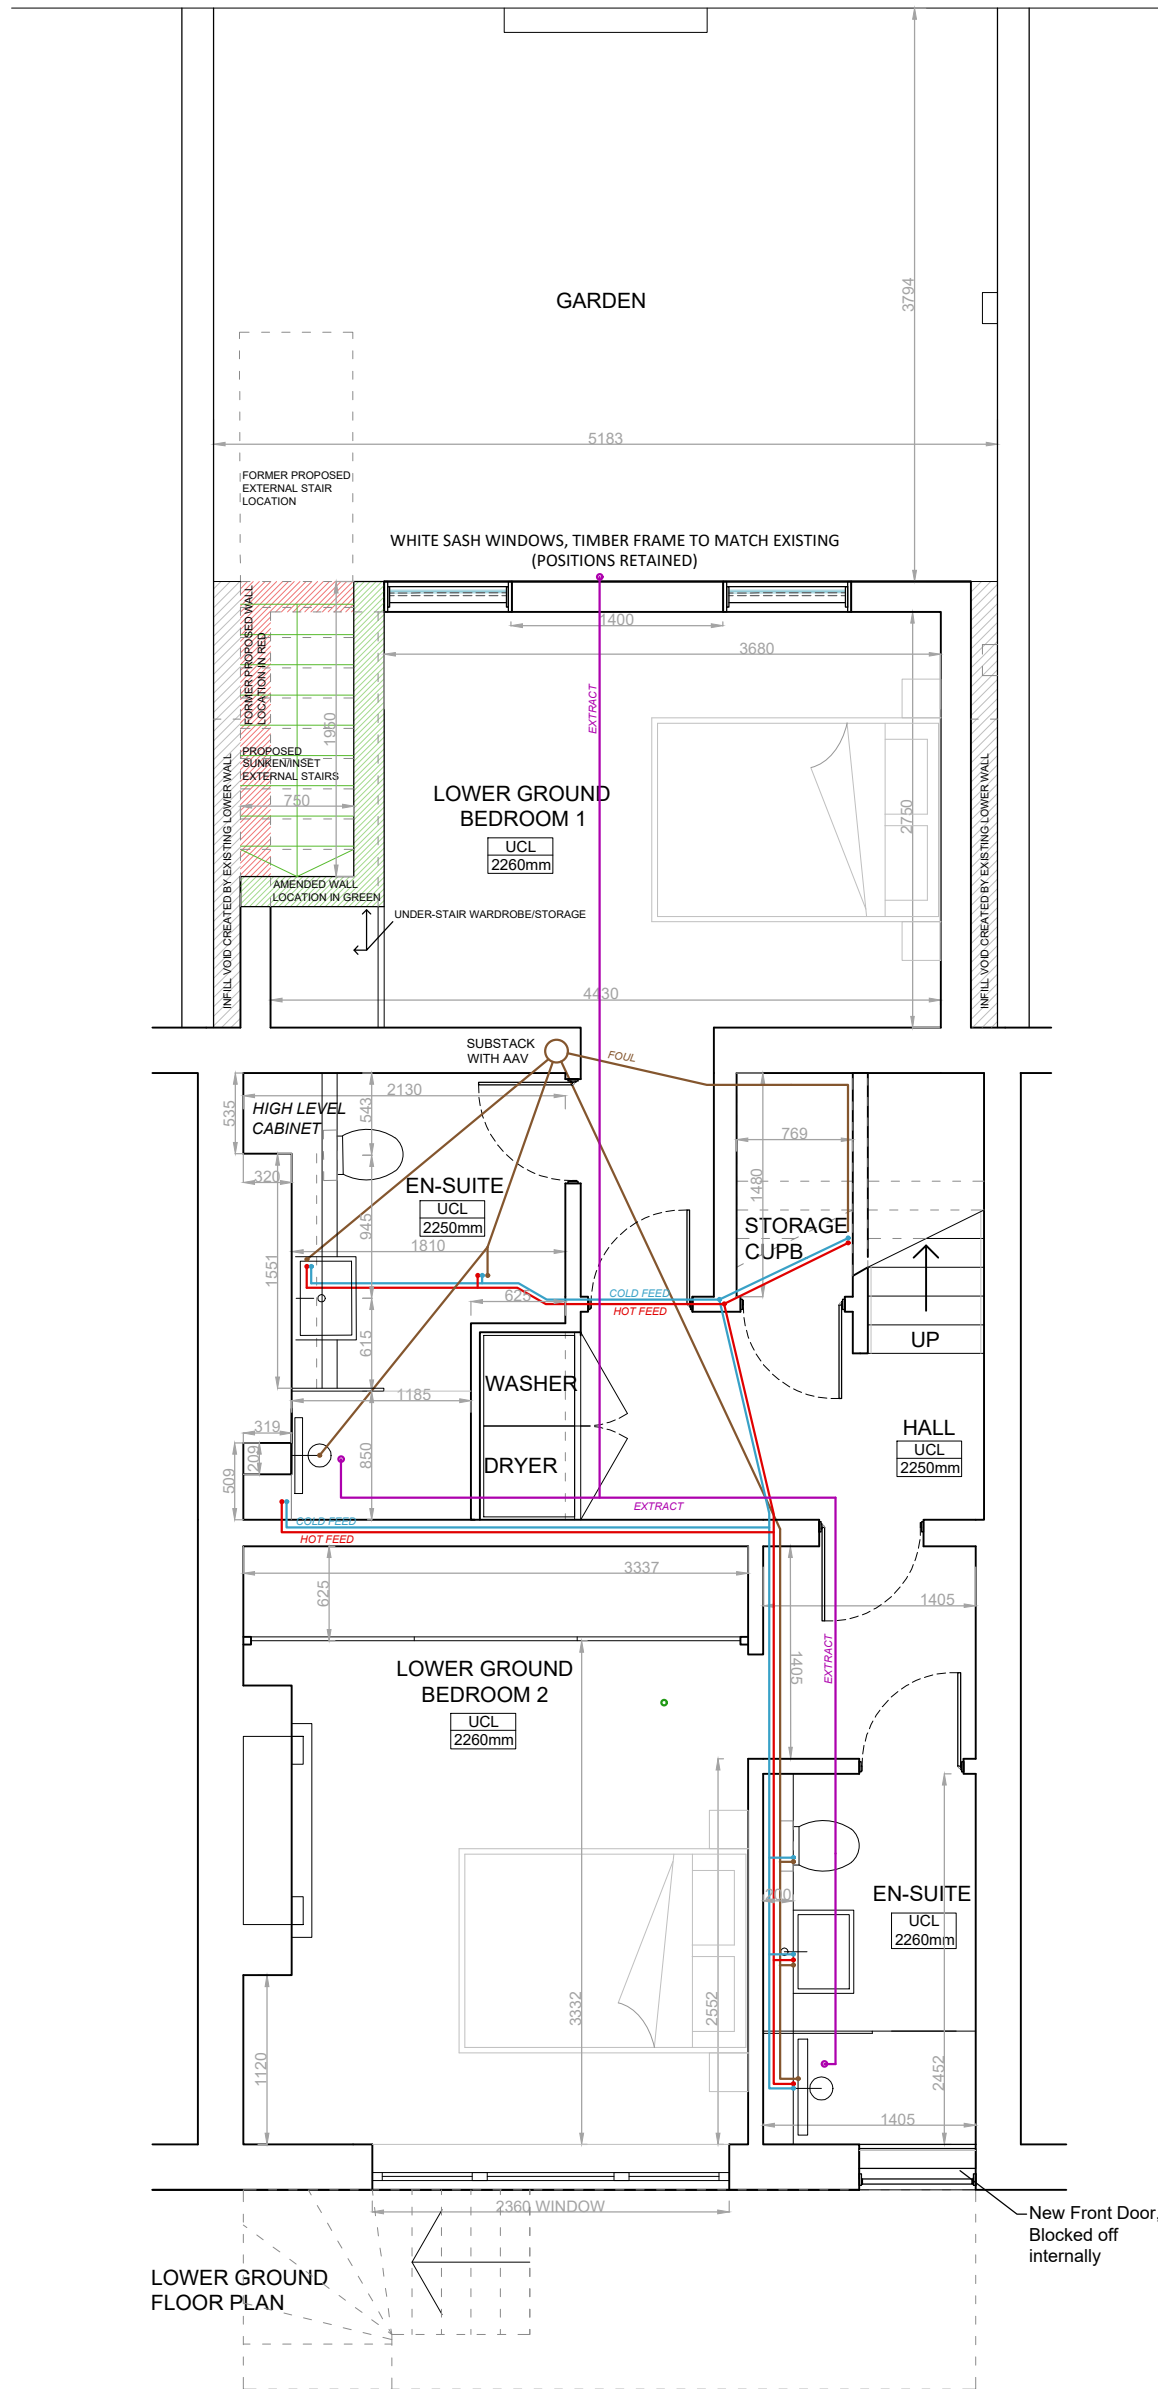

REV	DESCRIPTION	DATE
C	UPDATED AS PER COMMENTS	18.02.2024
B	MINOR AMENDMENTS - ISSUED	05.02.2024

Purpose of Issue			MINOR-AMENDMENT		
Drawn	-	Checked	-		
Date	27.06.23				
Scale	1:50	@A3			
Project Number	4033	Sheet Number	DR-65-001	Rev	C


PROJECT:
10 Thanet St. London WC1H 9QL

DRAWING NAME:
Proposed Lower Ground Floor Services Schematic

NOTES:
Orientated to fit sheet size, 1:50@A3

© Copyright Once Printed and distributed this document is assumed uncontrolled.
© All rights reserved. No part of this drawing may be reproduced or transmitted in any form by any means without the written permission of the copyright holder.



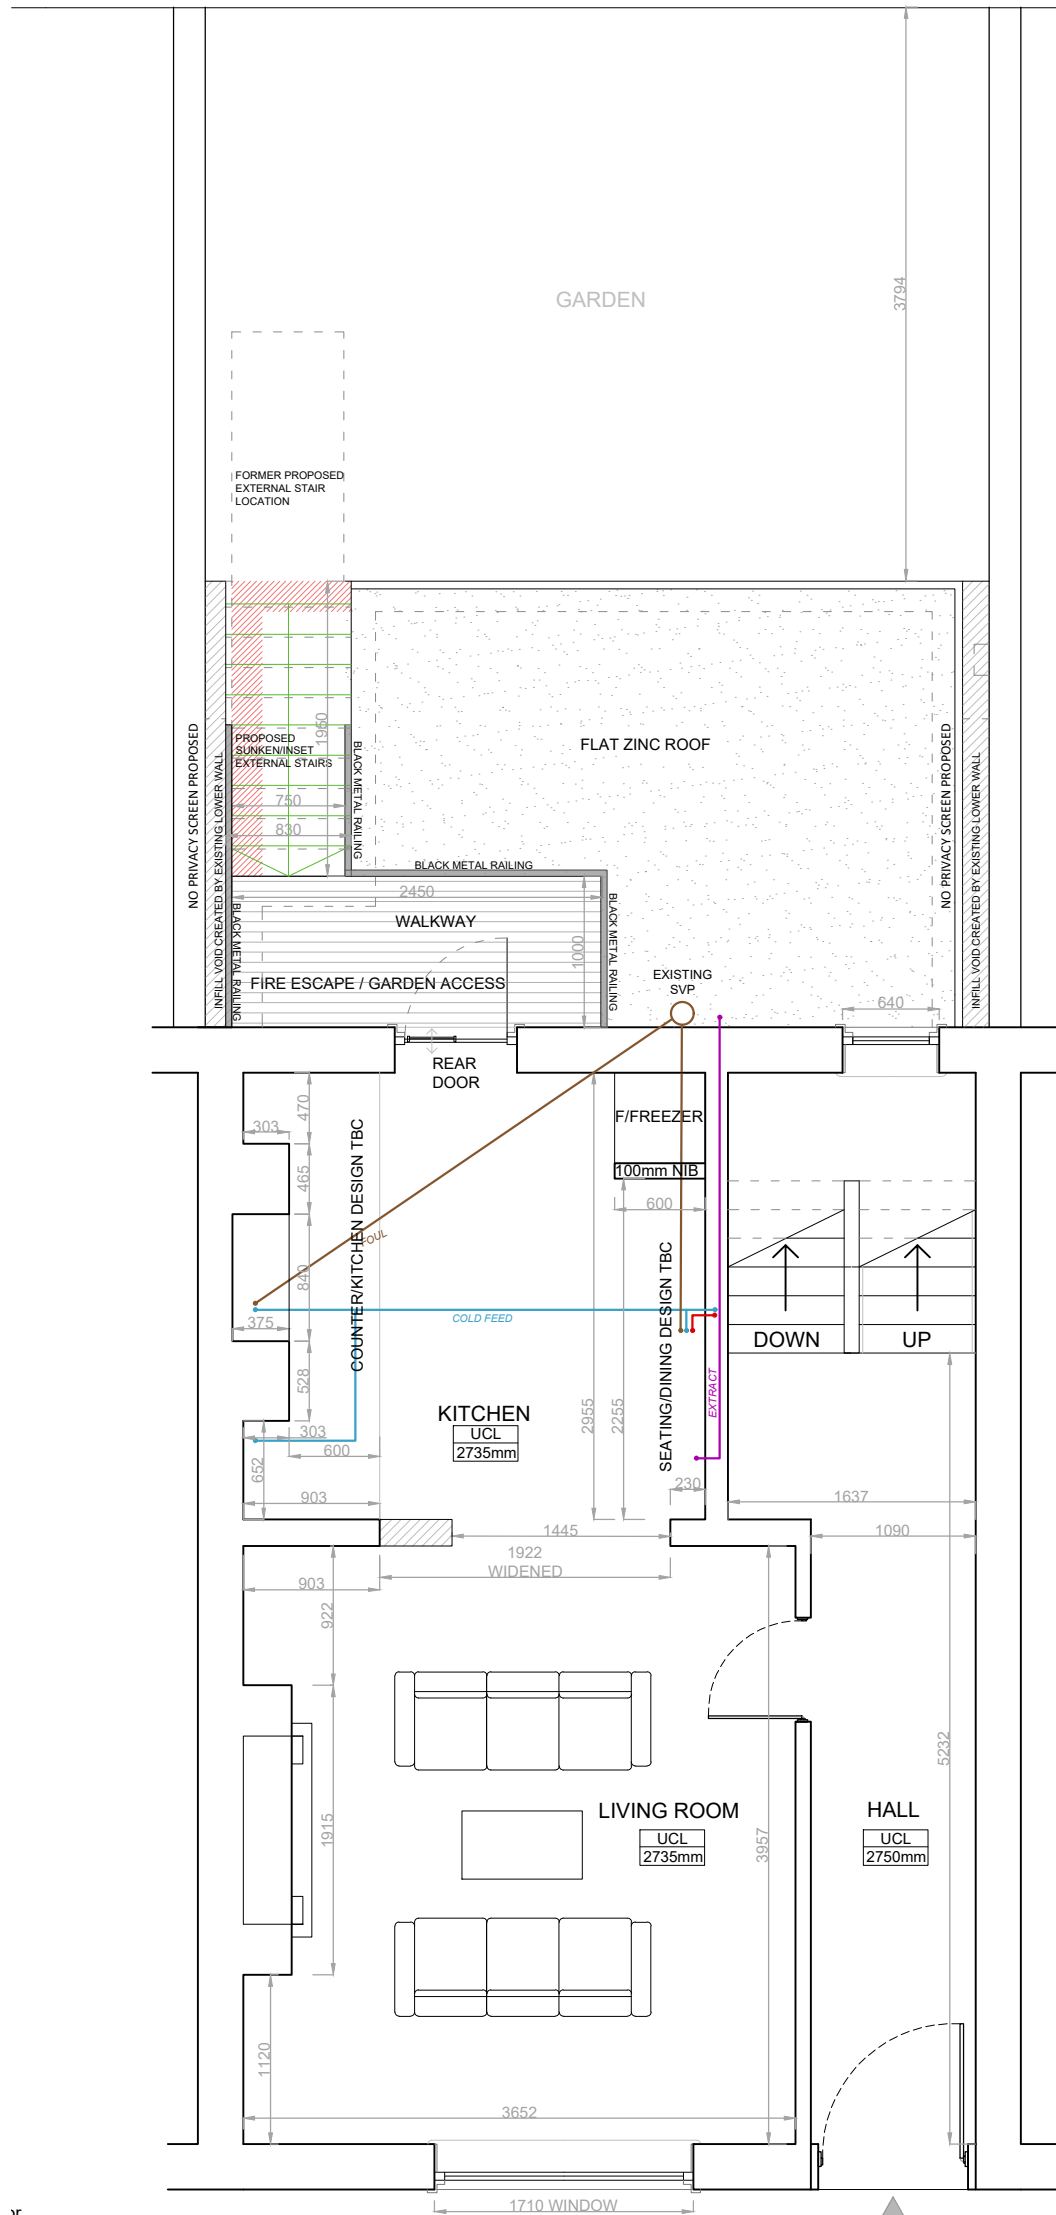

GROUND FLOOR PLAN

C	UPDATED AS PER COMMENTS	18.02.2024
B	MINOR AMENDMENTS - ISSUED	05.02.2024
REV	DESCRIPTION	DATE

Purpose of Issue INFORMATION		
Drawn	-	Checked -
Date	27.06.23	
Scale	1:50	@A3
Project Number	4033	Sheet Number DR-65-002
		Rev C


PROJECT:
10 Thanet St. London WC1H 9QL

DRAWING NAME:
Proposed Ground Floor Services Schematic

NOTES:
Orientated to fit sheet size, 1:50@A3

© Copyright Once Printed and distributed this document is assumed uncontrolled.
© All rights reserved. No part of this drawing may be reproduced or transmitted in any form by any means without the written permission of the copyright holder.



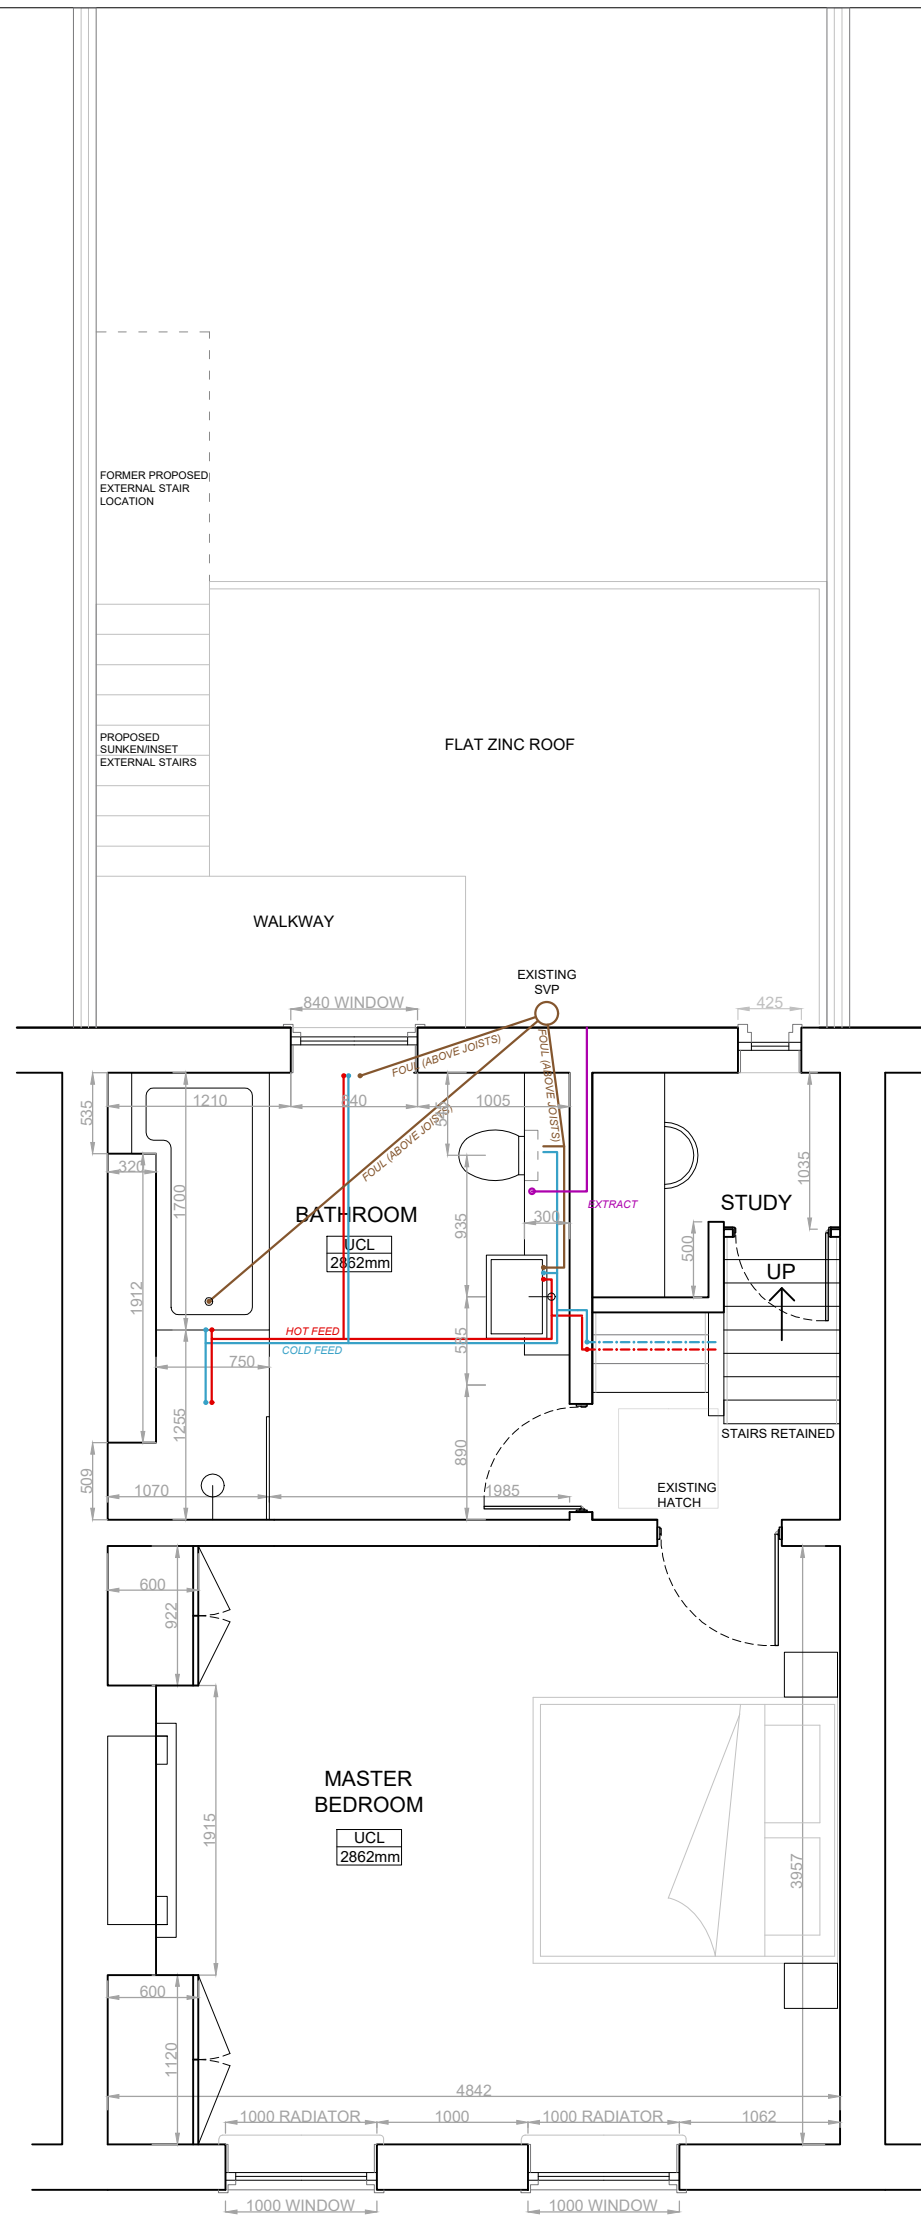

FIRST FLOOR PLAN

C	UPDATED AS PER COMMENTS	18.02.2024
B	MINOR AMENDMENTS - ISSUED	05.02.2024
REV	DESCRIPTION	DATE



Purpose of Issue INFORMATION		
Drawn	-	Checked -
Date	27.06.23	
Scale	1:50	@A3
Project Number	4033	Sheet Number DR-65-003
		Rev C

PROJECT:
 10 Thanet St. London WC1H 9QL
DRAWING NAME:
 Proposed First Floor Services Schematic

NOTES:
 Orientated to fit sheet size, 1:50@A3

© Copyright Once Printed and distributed this document is assumed uncontrolled.
 © All rights reserved. No part of this drawing may be reproduced or transmitted
 in any form by any means without the written permission of the copyright holder.



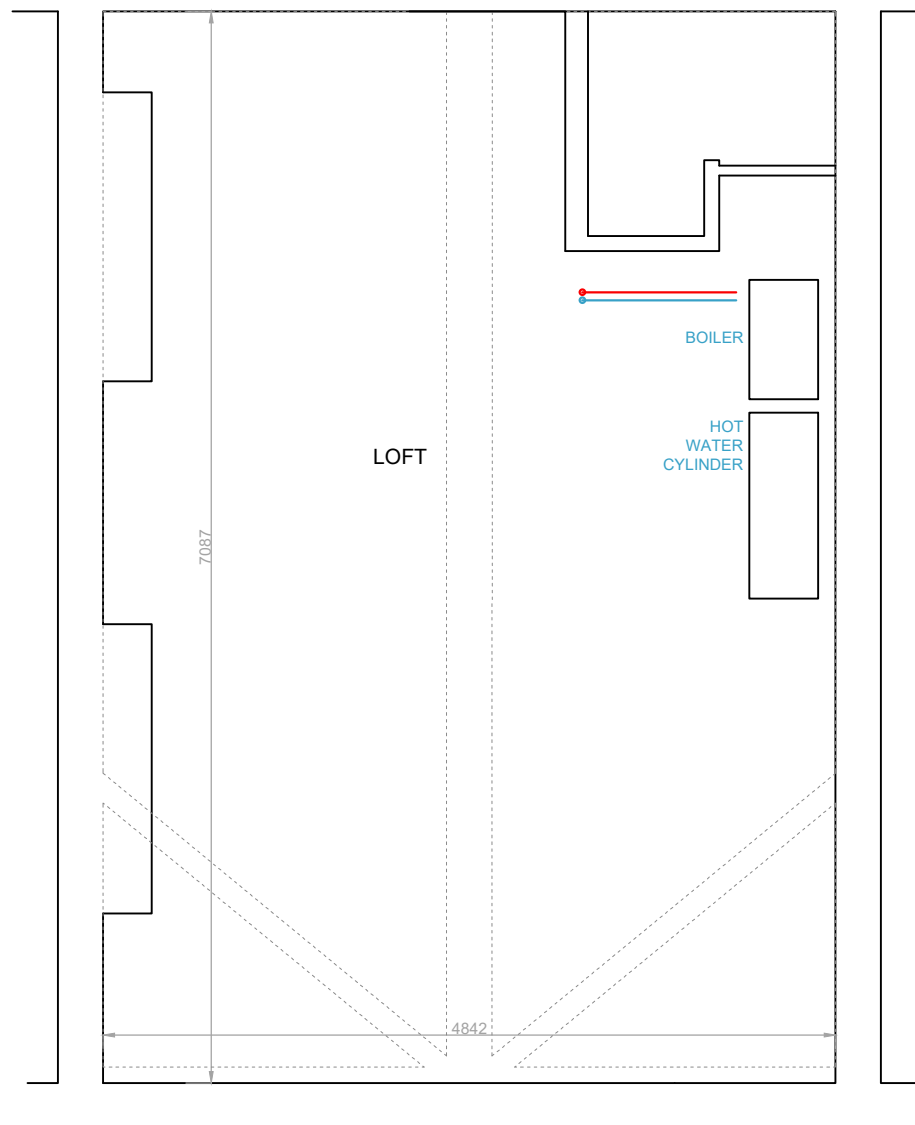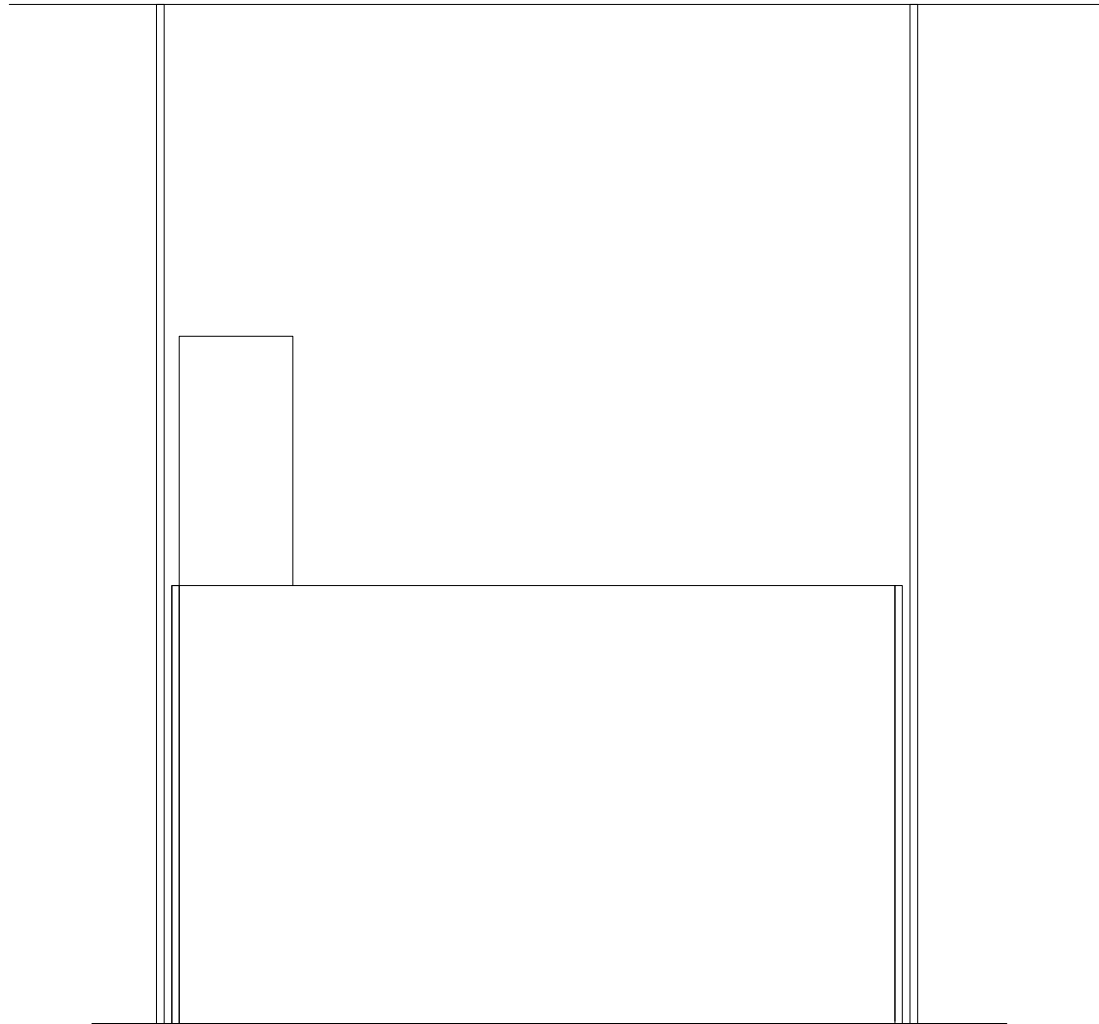

LOFT PLAN

C	UPDATED AS PER COMMENTS	19.02.2024
B	MINOR AMENDMENTS - ISSUED	05.02.2024
REV	DESCRIPTION	DATE


Purpose of Issue			INFORMATION		
Drawn	-	Checked	-		
Date	27.06.23				
Scale	1:50	@A3			
Project Number	4033	Sheet Number	DR-65-004	Rev	C

PROJECT:
 10 Thanet St. London WC1H 9QL
DRAWING NAME:
 Proposed Loft Plan Services Schematic


NOTES:
 Orientated to fit sheet size, 1:50@A3

© Copyright Once Printed and distributed this document is assumed uncontrolled.
 © All rights reserved. No part of this drawing may be reproduced or transmitted
 in any form by any means without the written permission of the copyright holder.




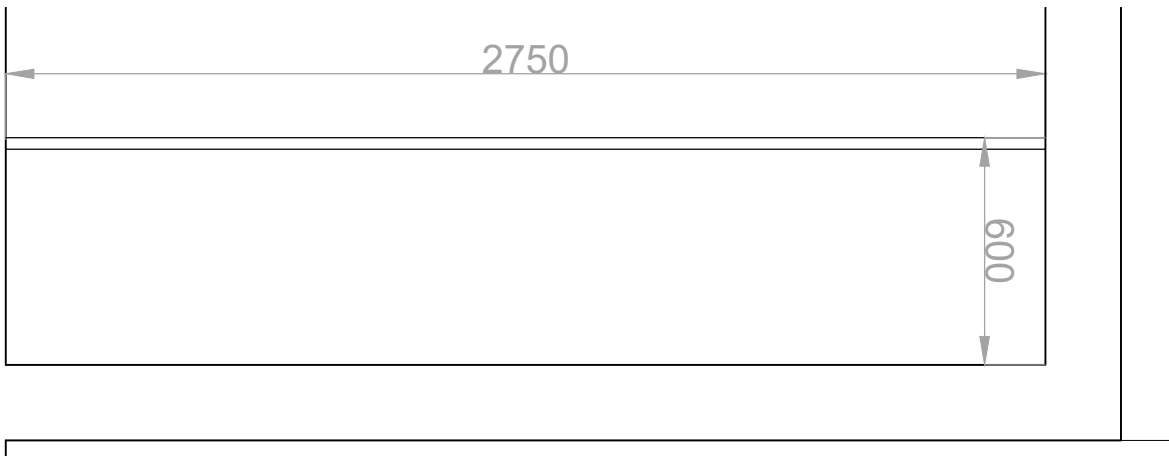

Lower Ground Bedroom 1 - Wardrobe Plan 1:20

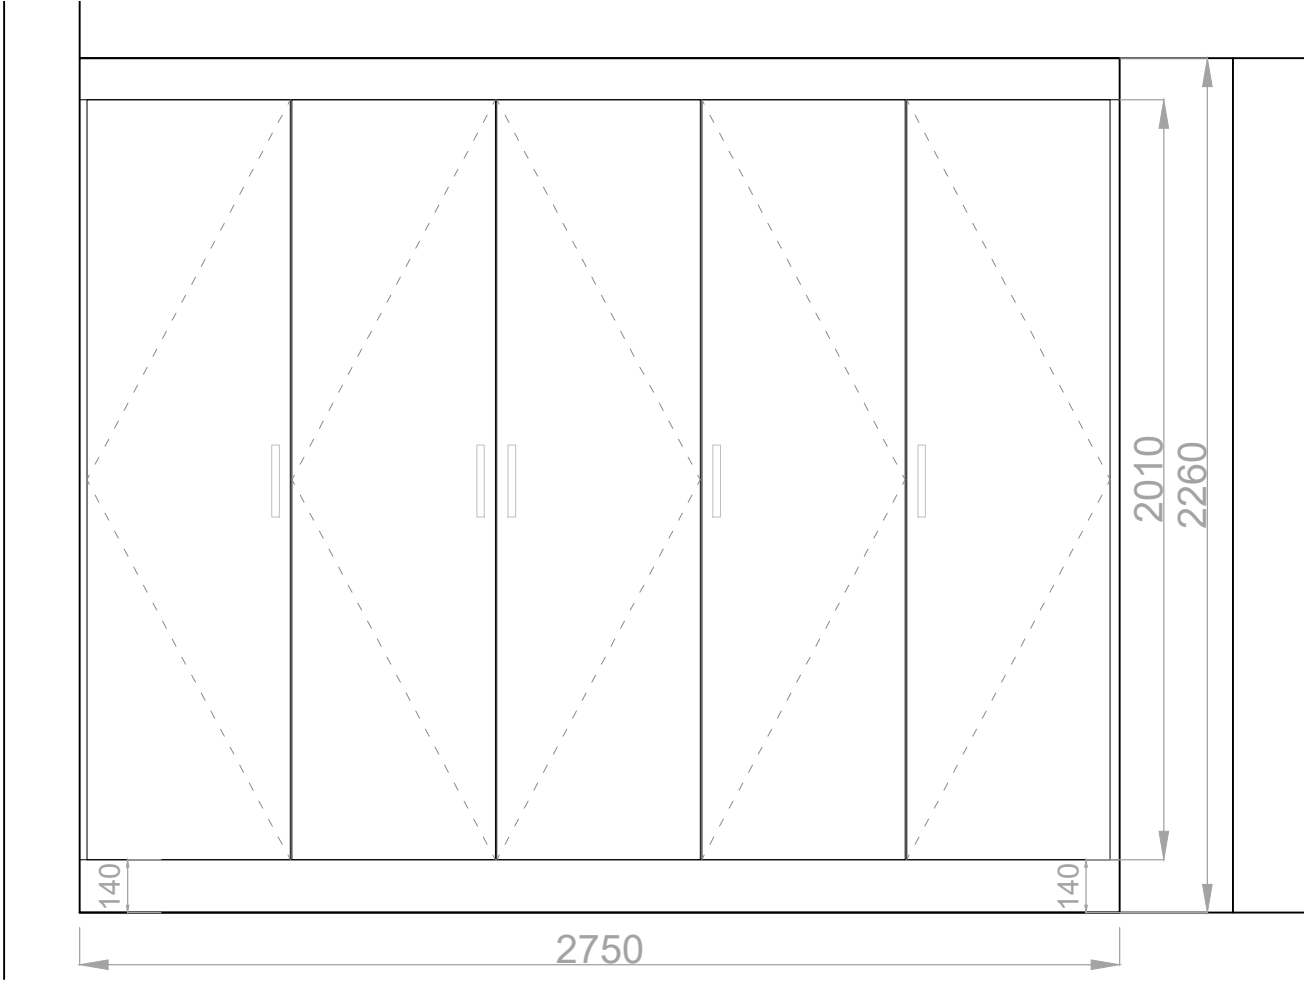

Lower Ground Bedroom 1 - Wardrobe Elevation 1:20

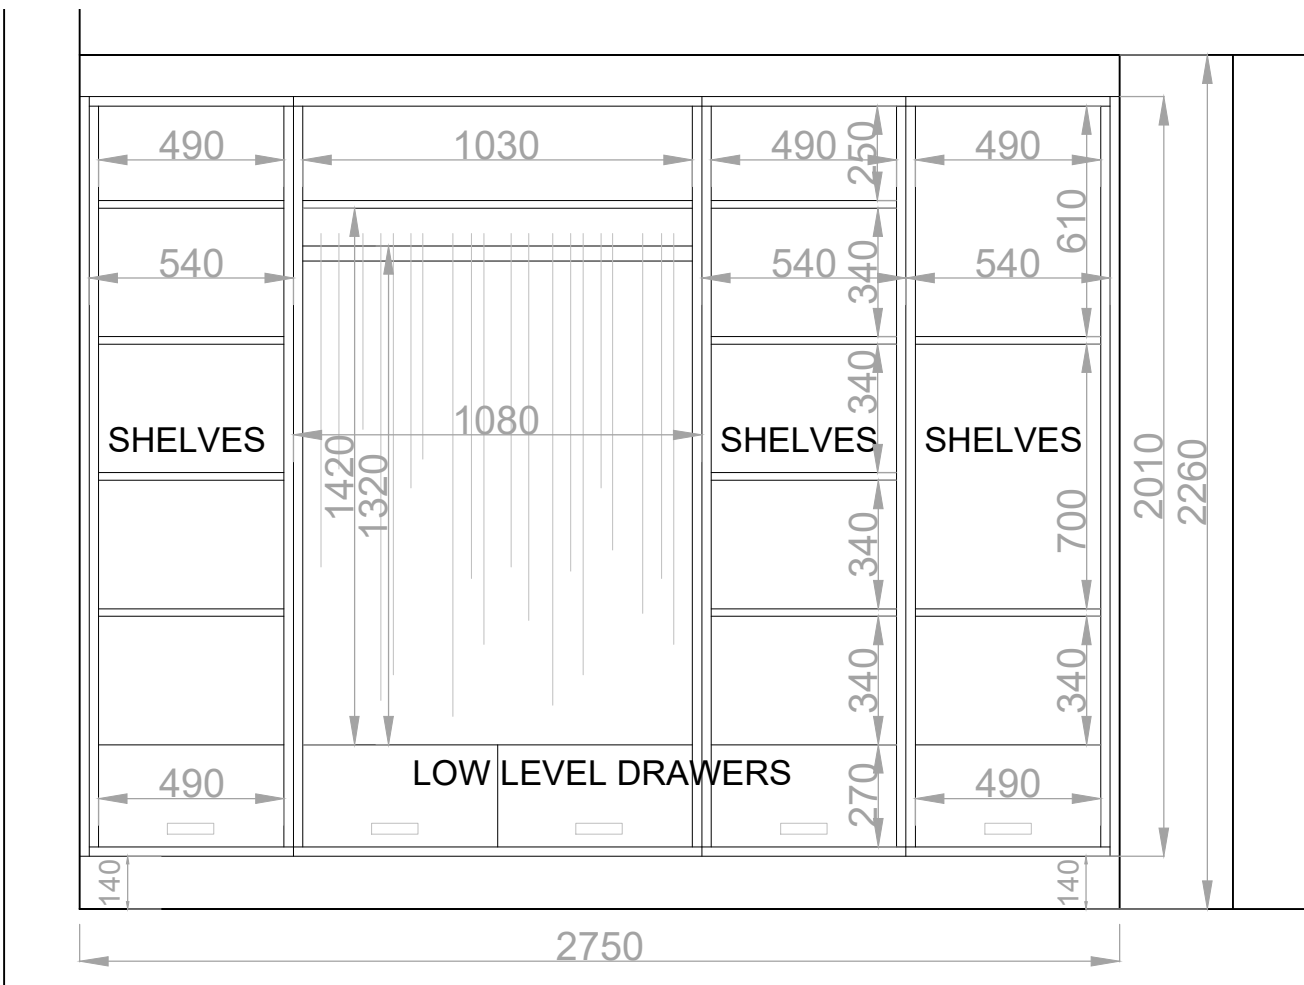


Lower Ground Bedroom 1 - Wardrobe (Open) Elevation 1:20




PROJECT:
 10 Thanet St. London WC1H 9QL
DRAWING NAME:
 Lower Ground Bedroom 1 - Joinery - Wardrobe Plan & Elevations
NOTES:
 Orientated to fit sheet size, 1:20@A3
 © Copyright Once Printed and distributed this document is assumed uncontrolled.
 © All rights reserved. No part of this drawing may be reproduced or transmitted
 in any form by any means without the written permission of the copyright holder.


B	MINOR AMENDMENTS - ISSUED	05.02.2024
REV	DESCRIPTION	DATE
Purpose of Issue MINOR-AMENDMENT		
Drawn	-	Checked -
Date	27.06.23	
Scale	1:20	@A3
Project Number	Sheet Number	Rev
4033	DR-72-001	B

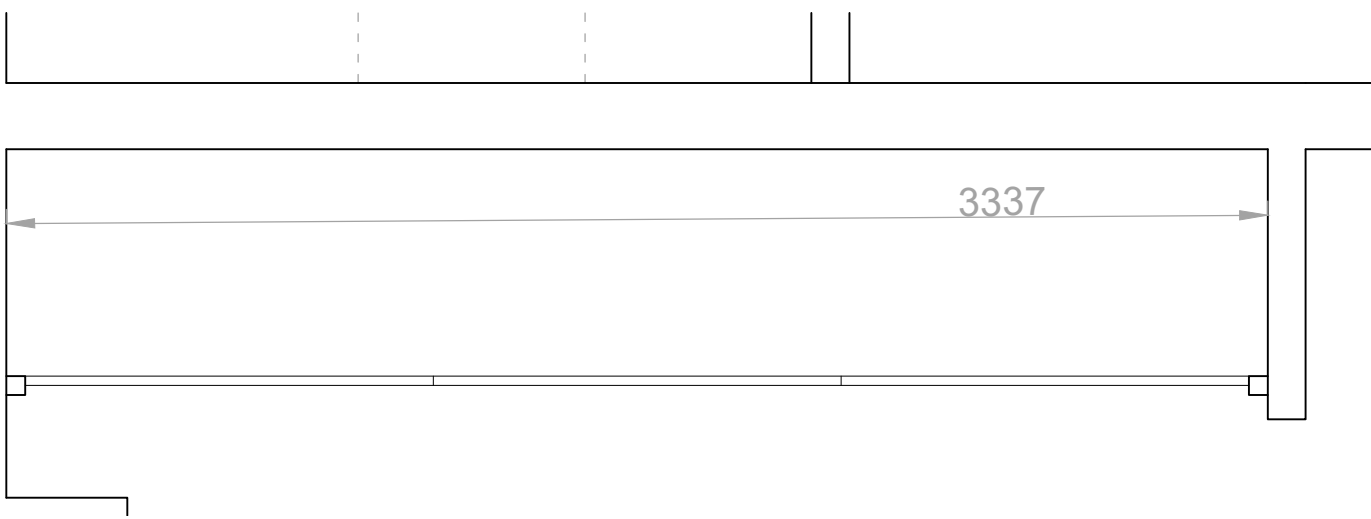

Lower Ground Bedroom 2 - Wardrobe Plan - 1:20

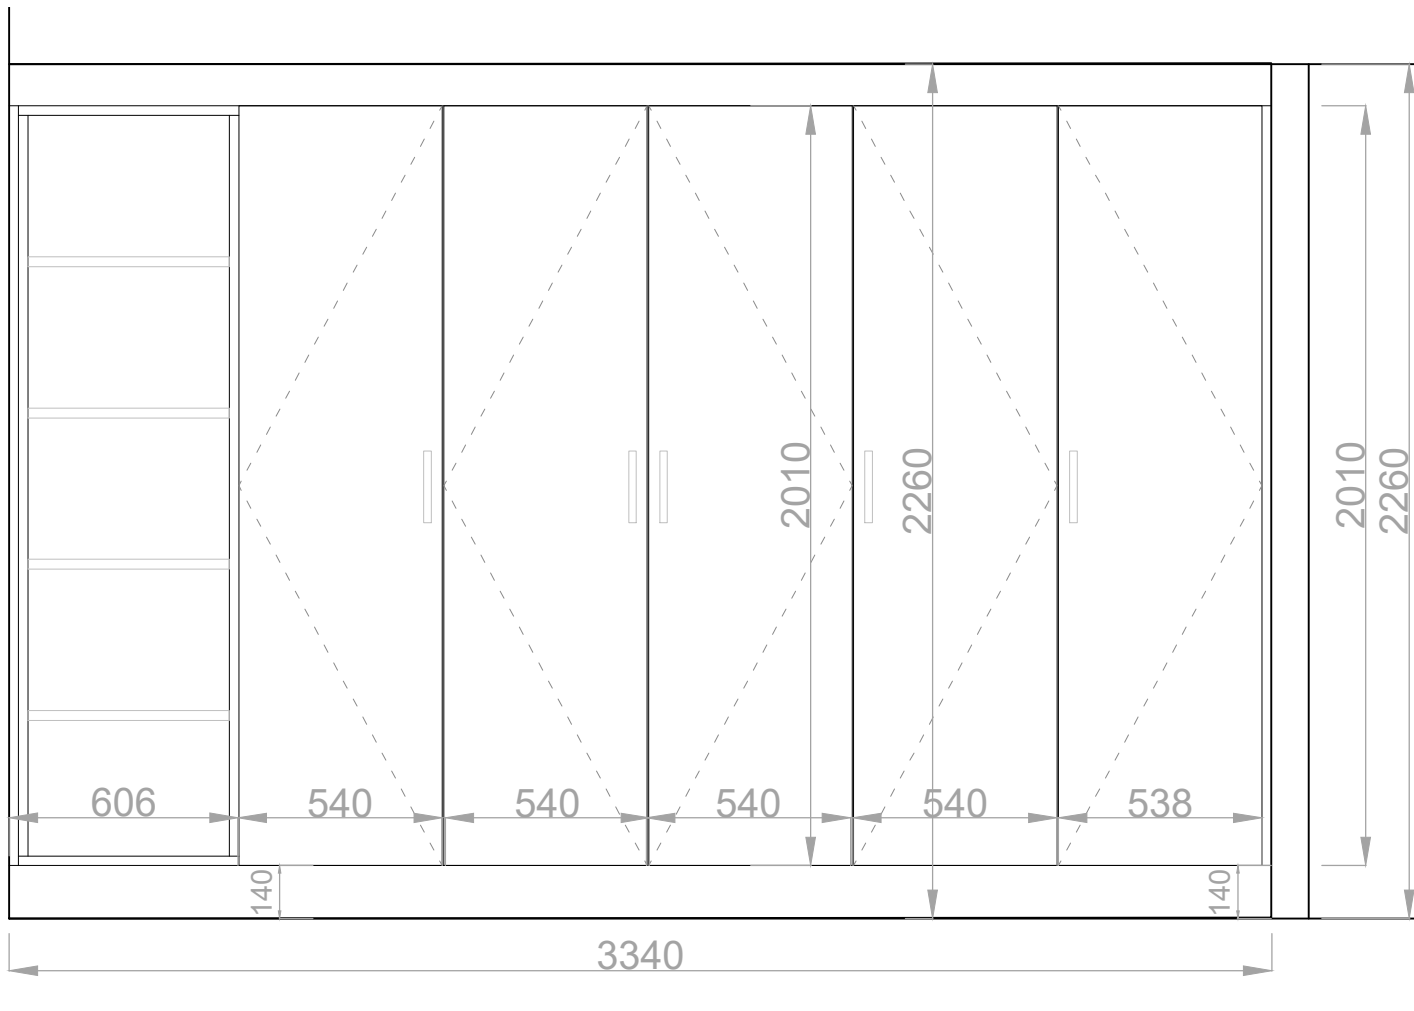

Lower Ground Bedroom 2 - Wardrobe Elevation - 1:20

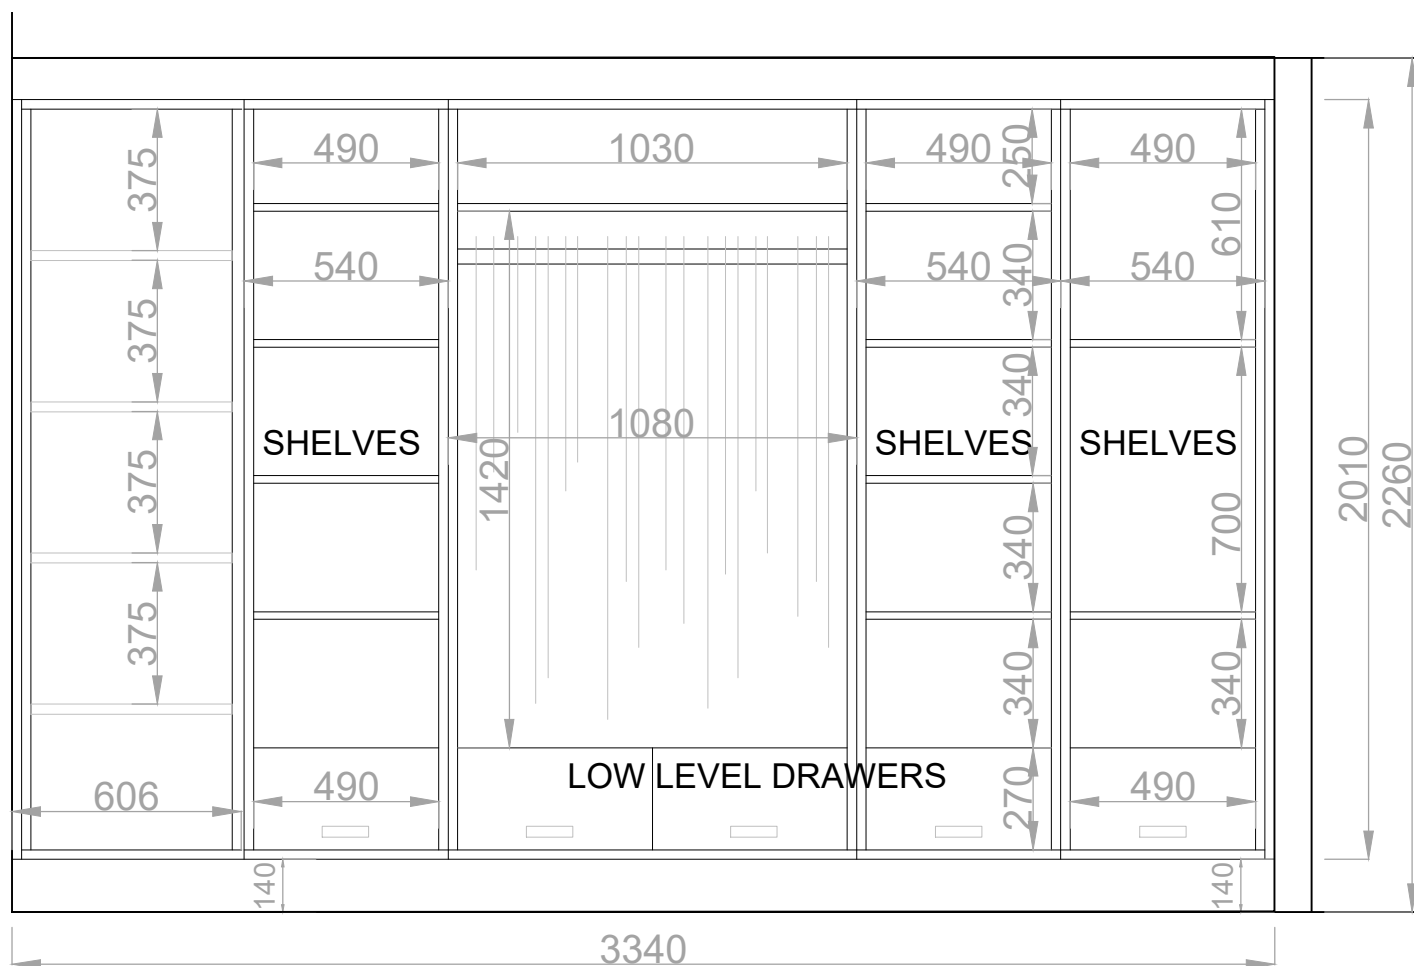

Lower Ground Bedroom 2 - Wardrobe Elevation - 1:20

B	MINOR AMENDMENTS - ISSUED	05.02.2024
REV	DESCRIPTION	DATE

Purpose of Issue MINOR-AMENDMENT		
Drawn	-	Checked -
Date	27.06.23	
Scale	1:20	@A3
Project Number	4033	Sheet Number DR-72-002
		Rev B



PROJECT:
 10 Thanet St. London WC1H 9QL
 DRAWING NAME:
 Lower Ground Bedroom 2 - Joinery - Wardrobe Plan & Elevations
 NOTES:
 Orientated to fit sheet size, 1:20@A3
 © Copyright Once Printed and distributed this document is assumed uncontrolled.
 © All rights reserved. No part of this drawing may be reproduced or transmitted in any form by any means without the written permission of the copyright holder.