


SIDE ELEVATION

 


CHARLOTTE STREET

ROOF

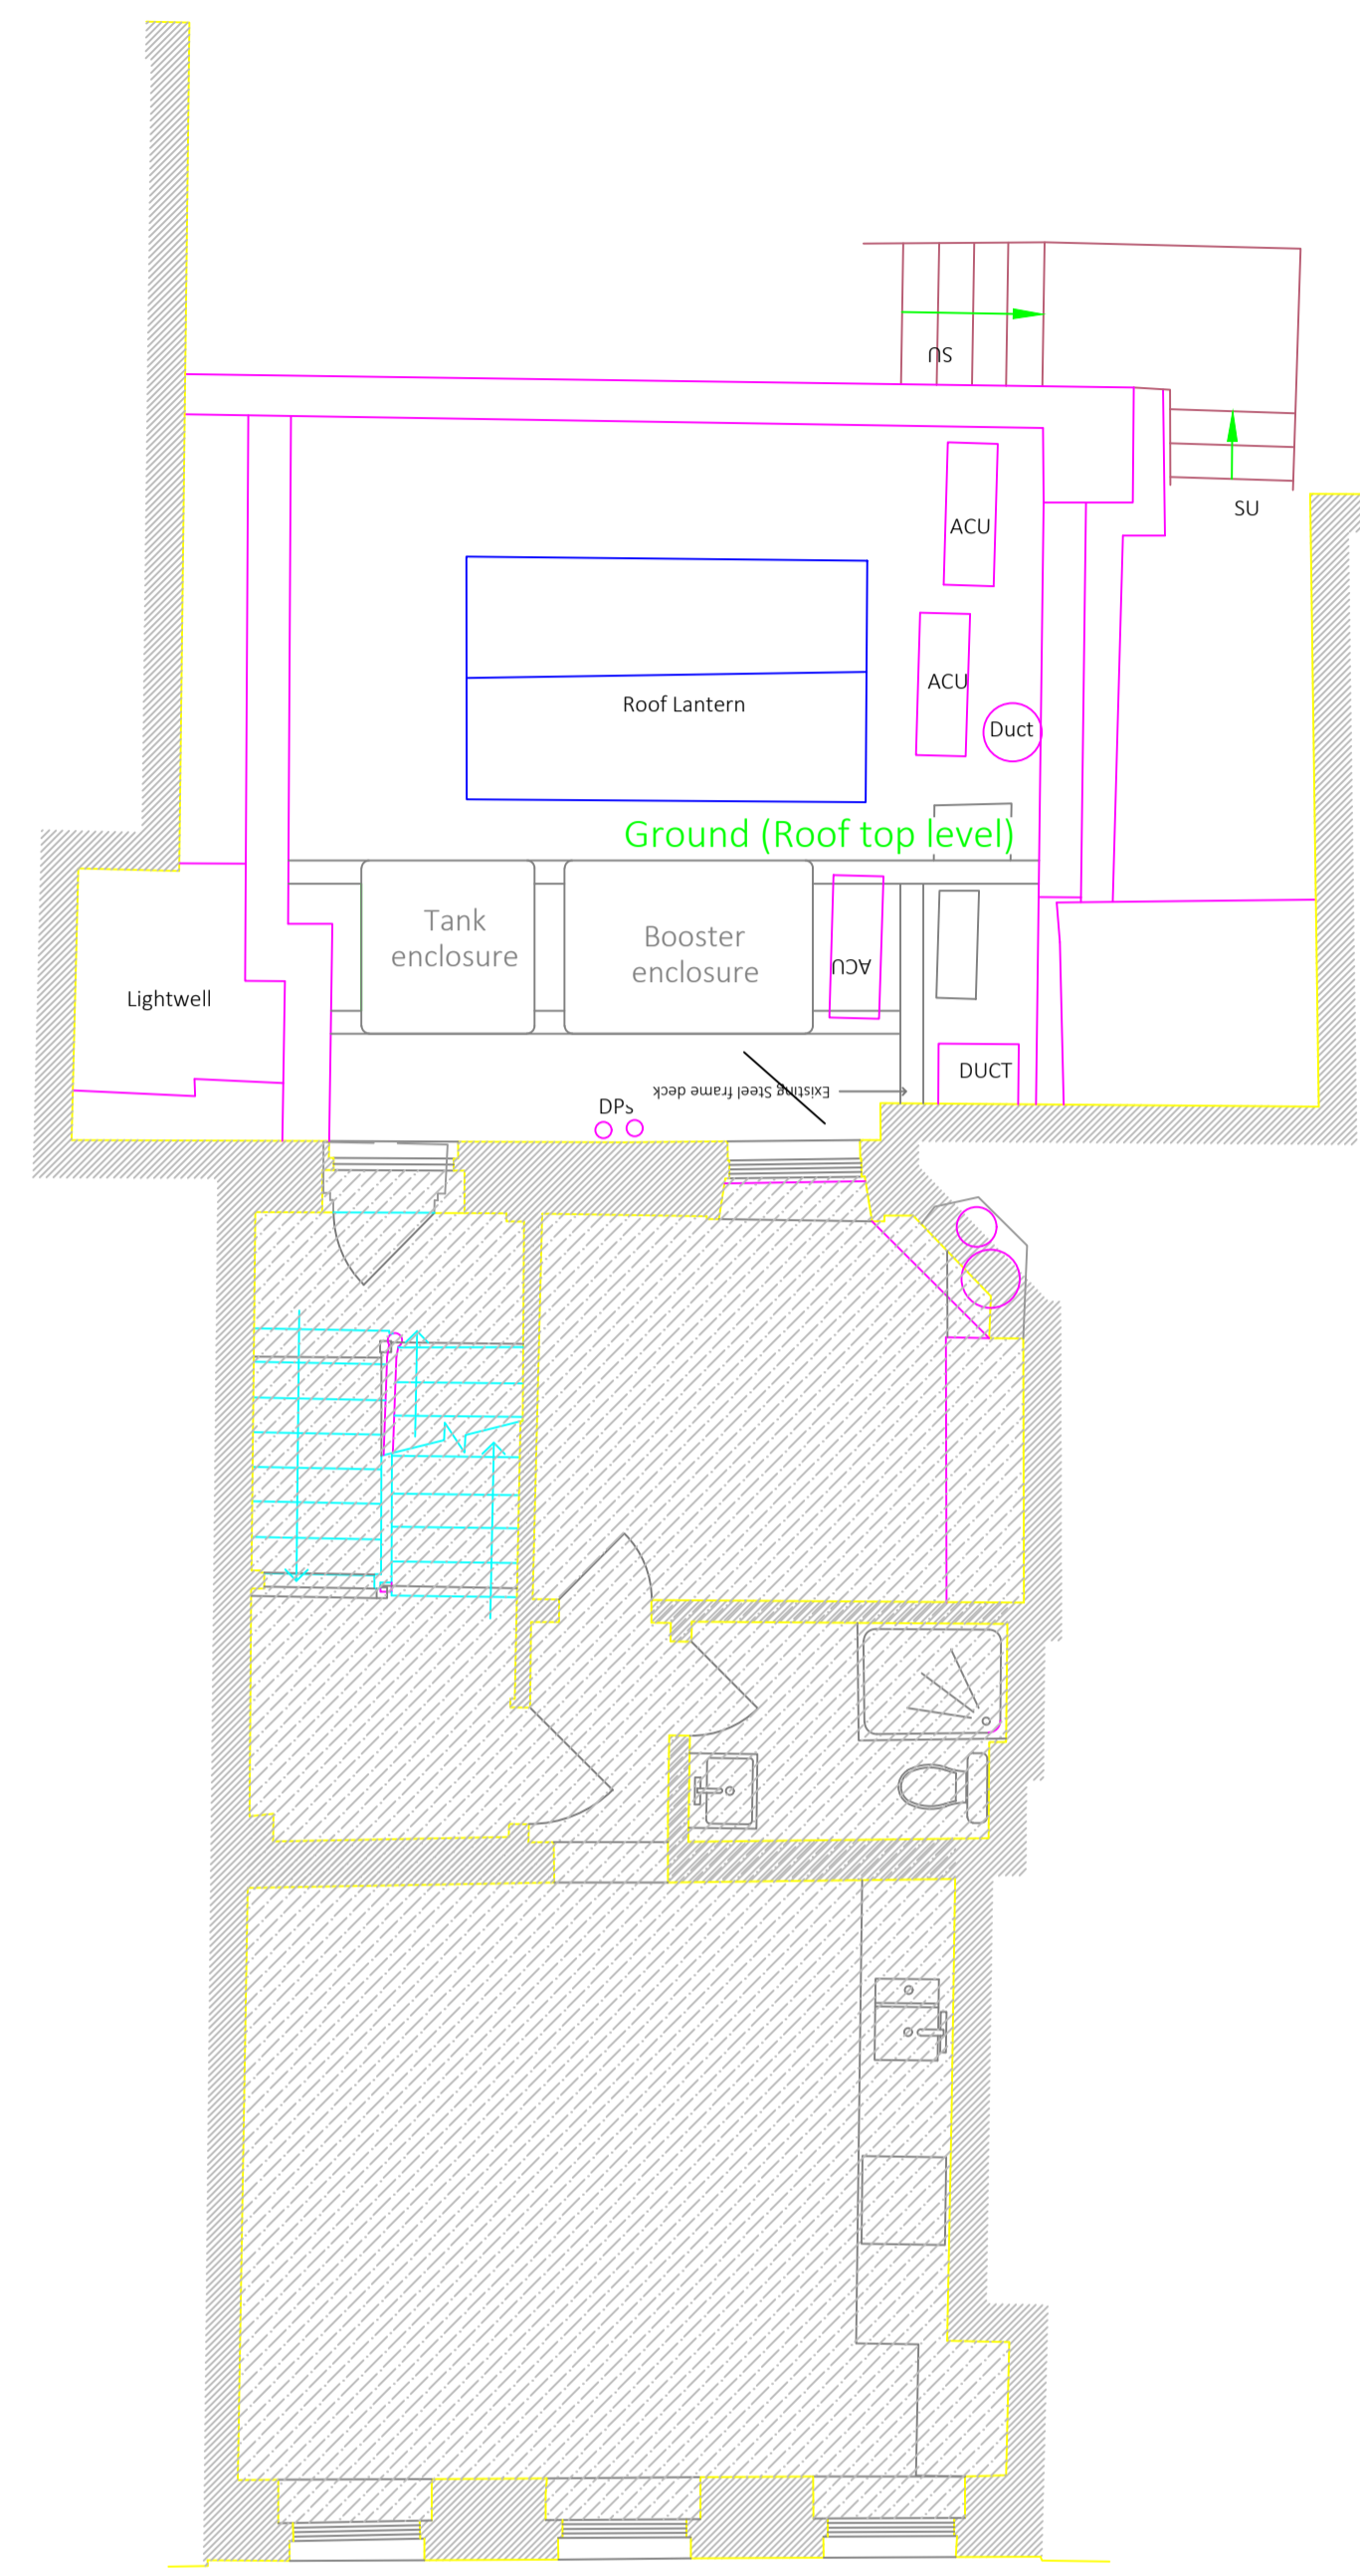

REAR ELEVATION



Client	JULY		
Project	CHARLOTTE STREET		
Title	VENTILATION LAYOUT - EXISTING LAYOUT		
Contract No.	1059	Drawing No.	TFP-1059-201 ~
Scale	1:50:A1 1:100:A3	Date	02/04/2024

the fellerman partnership