


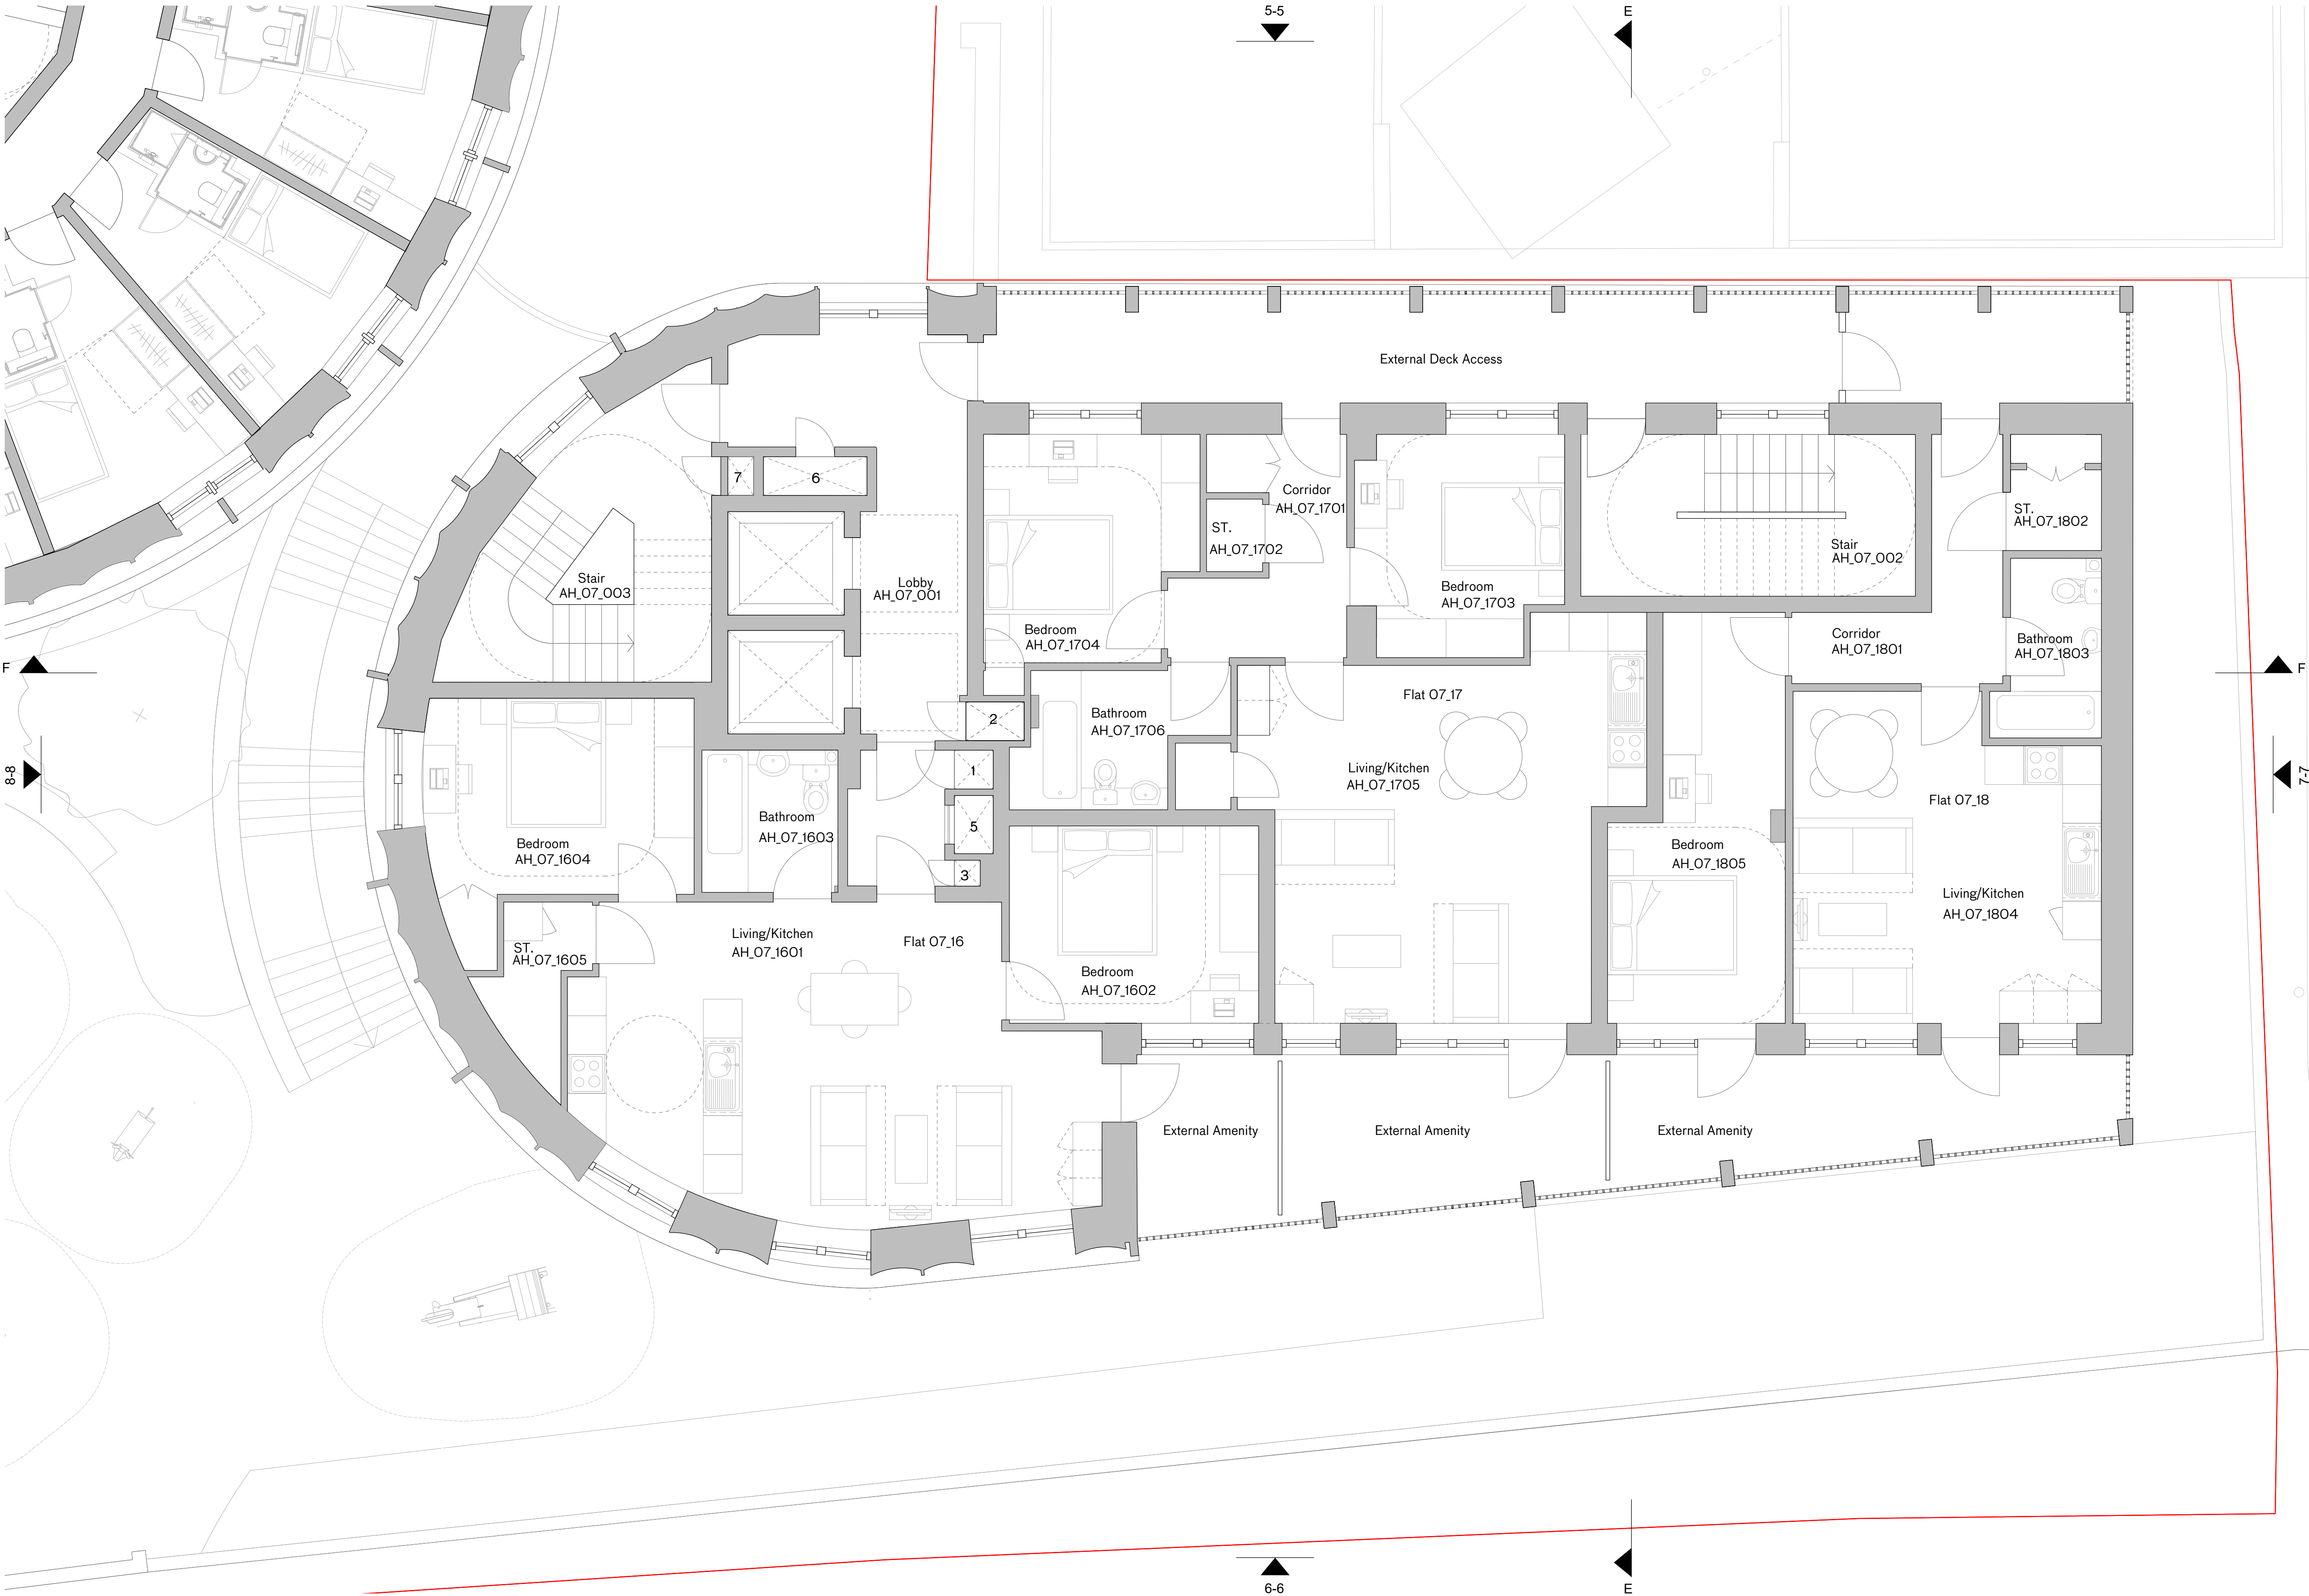

Affordable Housing Level 7 - 8 Floor Plan

NOTES

Key to Risers

- 1 Heating Riser
- 2 Water Riser
- 3 Comms Riser
- 4 Electrical Riser
- 5 Smoke Outlet
- 6 Smoke Inlet
- 7 Dry Riser
- 8 MVHR Cupboard
- 9 Mechanical Ventilation

Site Boundary

Petrol Filling Station Consented Scheme. Planning Ref: 2022/3646/P

B -21/03/24 Planning

A - 31/01/24 Planning

Planning

rev	date	check	comments
DSDHA 357 Kennington Lane London SE11 5QY T 020 7703 3555 F 020 7703 3890 E info@dsdha.co.uk W www.dsdha.co.uk			
project			
100 Chalk Farm Road			
drawing title			
Affordable Housing Level 7 - 8 Floor Plan			
drawn	size	date	scale
SZ	A1	21/03/24	1 : 50
drawing number			revision
356_P20.167			B
REPORT DISCREPANCIES DO NOT SCALE FROM THIS DRAWING COPYRIGHT DSDHA		USE LATEST REVISION CHECK DIMENSIONS ON SITE	