
 
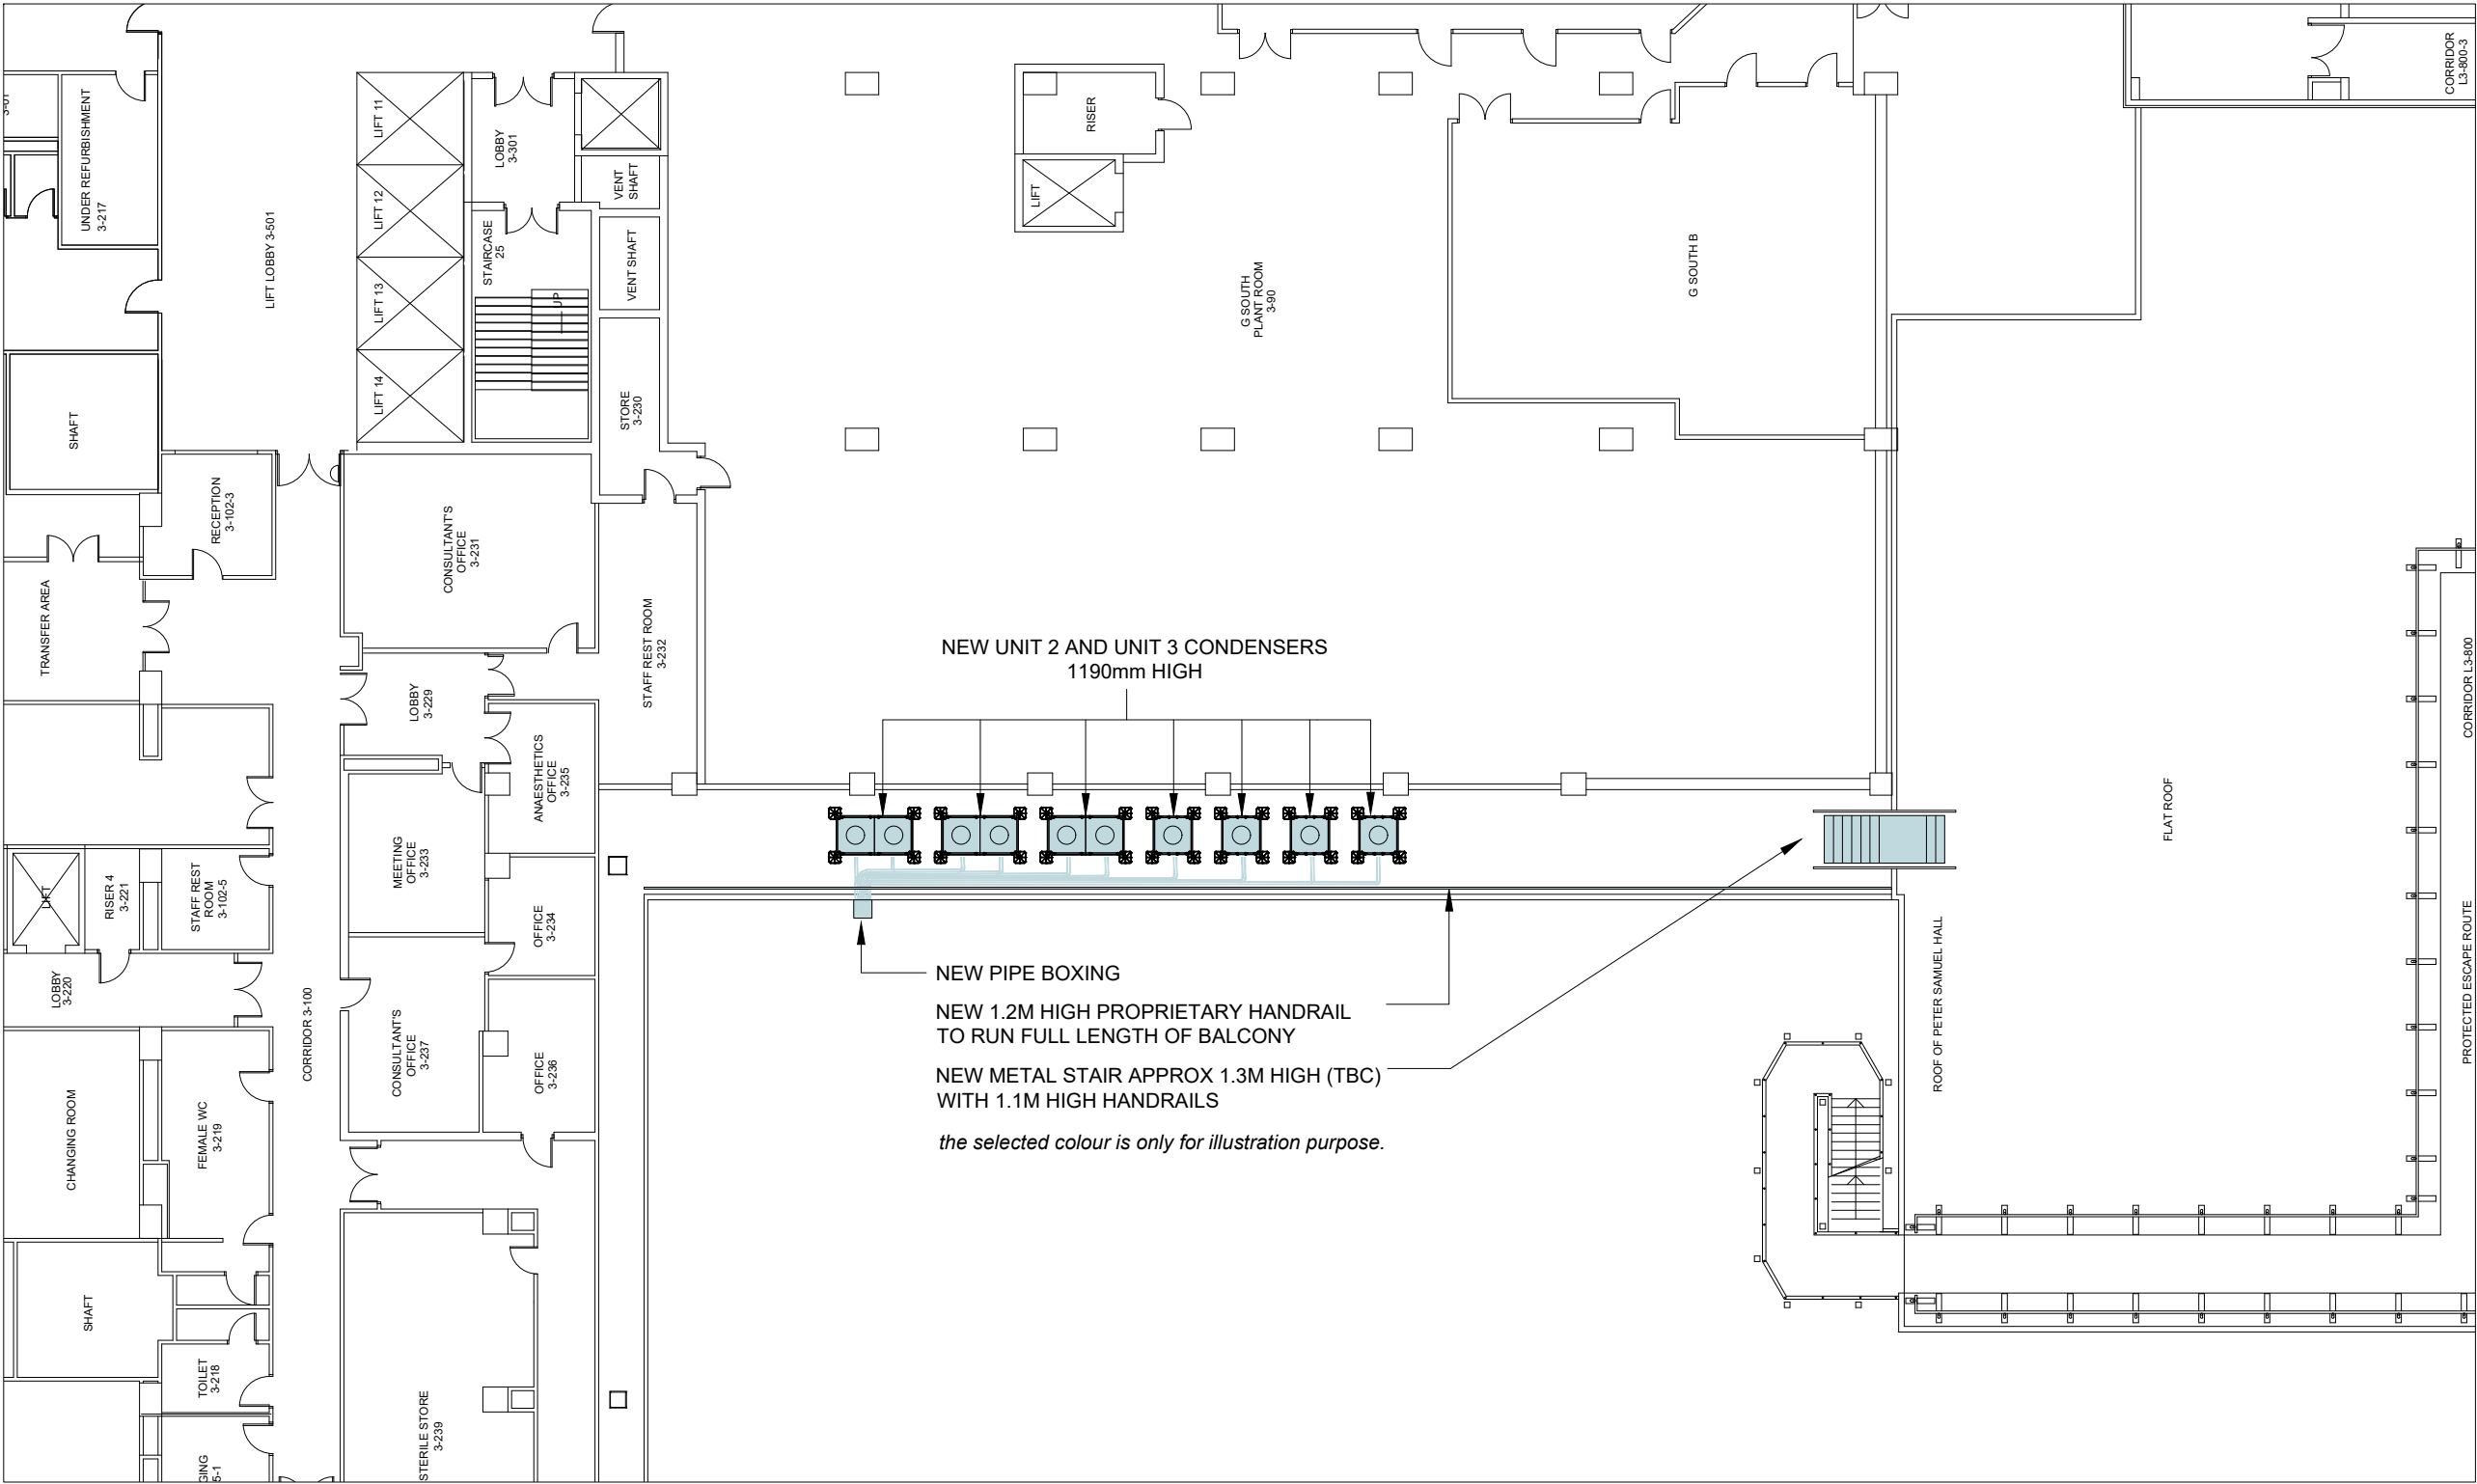


THIS DRAWING IS PROTECTED BY COPYRIGHT - FIGURED DIMENSIONS ONLY TO BE TAKEN FROM THIS DRAWING. DIMENSIONS TO BE CHECKED ON SITE AND ANY DISCREPANCIES REPORTED TO THE ARCHITECT IMMEDIATELY.				
PURPOSE OF ISSUE: (I)Info/Comment (S)Sign Off (P)Planning (B)Building Control (T)Tender (C)Construction (F)Final Revision				
Rev	Rev Date	Revision Description	Drawn/Checked	Purpose of Issue
/A	12/03/2024 13/05/2024	Initial issue for comment. Issued for Planning.	JD/CBT CBT/CBT	I P



01 Proposed 3rd Floor Plan
(01)002 1:200 @ A3

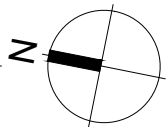

FOR PLANNING

Proposed 3rd Floor Plan	24003 JOB NUMBER	(01)002 DRAWING NUMBER	A REV
ROYAL FREE LONDON AHU Condenser Units	Mar 2024 DATE	1:200@A3 SCALE	

Ansell & Bailey Ltd Chartered Architects 99-101 Farringdon Road London EC1R 3BN 020 7387 0141 architects@ansellandbailey.com

ANSELL + BAILEY