


A horizontal number line is shown, labeled from 0 to 9m. Major tick marks are placed at every integer from 0 to 9. The line is divided into 10 equal segments by these tick marks. Shaded regions are present in the following intervals: from 0 to 1, from 2 to 3, from 4 to 5, from 6 to 7, and from 8 to 9. Each of these shaded intervals is further divided into 10 smaller, equal sub-intervals by vertical lines, representing a scale of 0.1 meters.

A number line from 0 to 30 with major tick marks every 6 units and minor tick marks every 2 units. Three shaded regions represent the number of hours: 0 to 6, 12 to 18, and 24 to 30.

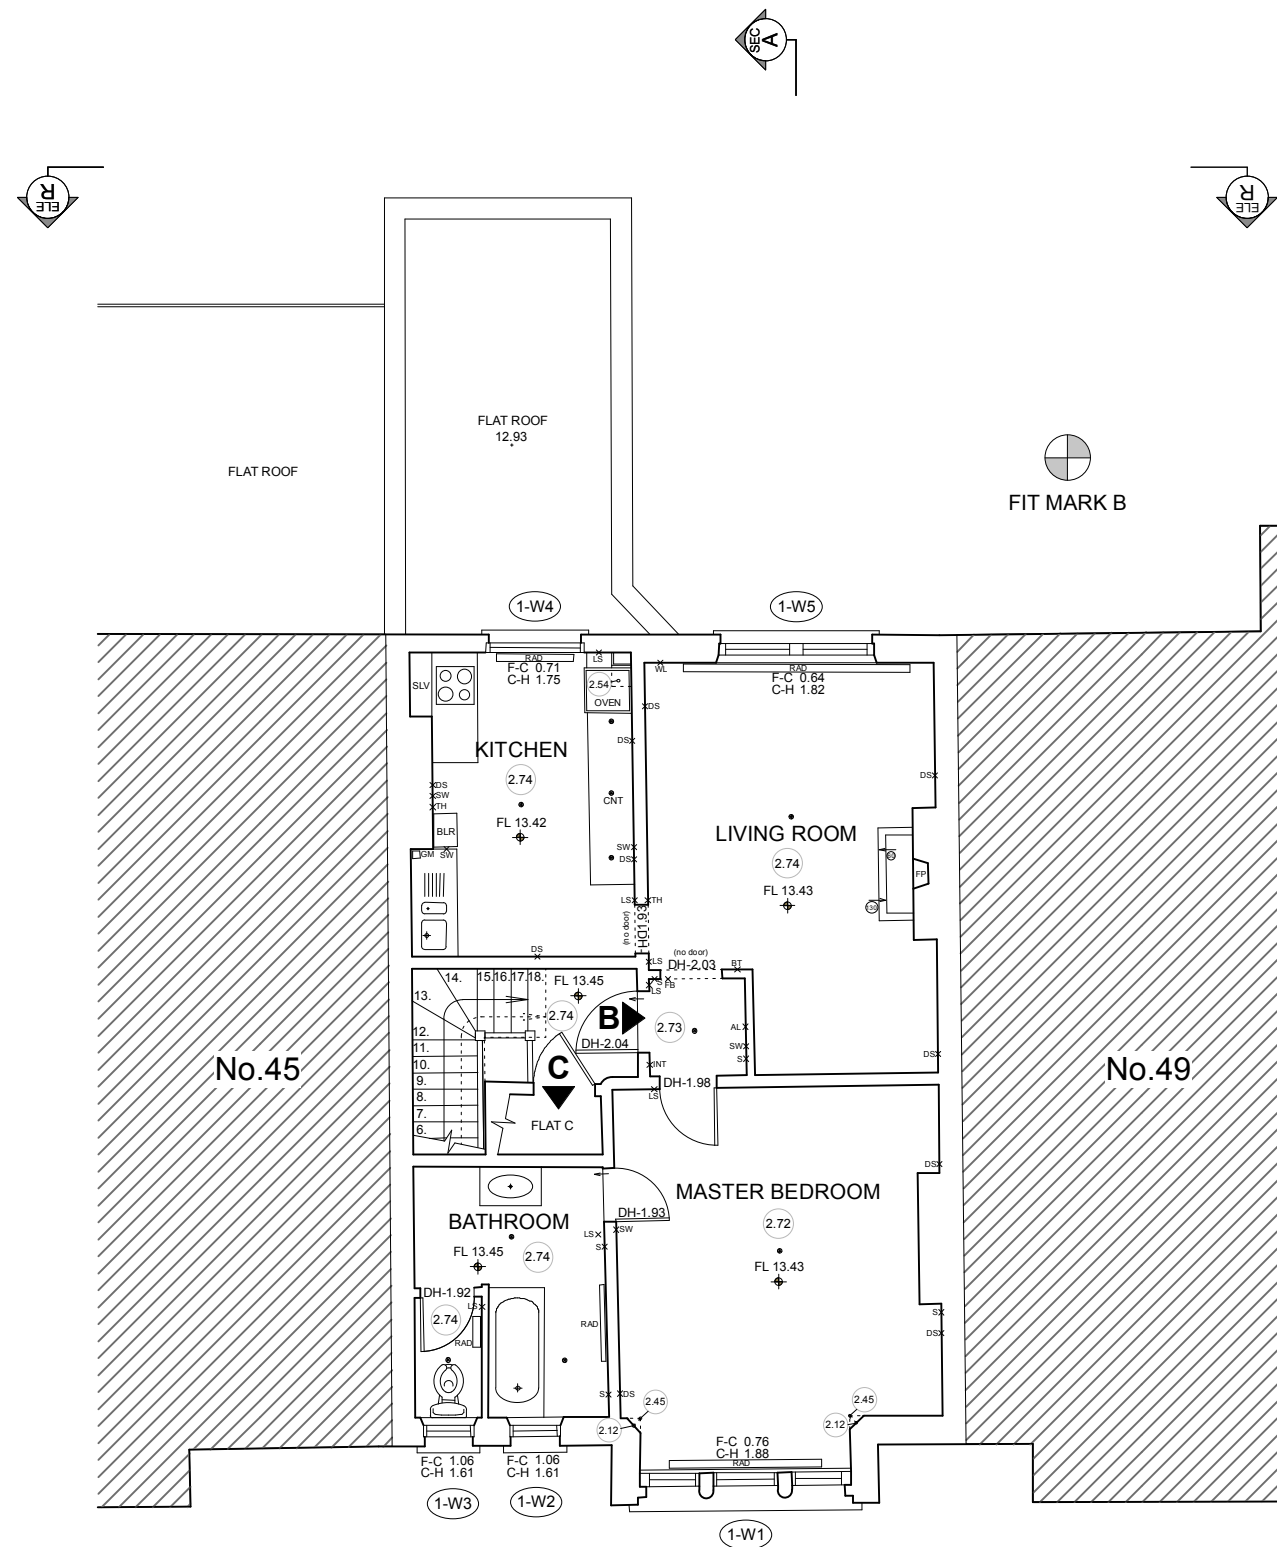


●	CEILING LIGHT
● SA	SMOKE ALARM
FB	FUSE BOX
SS	SECURITY SYSTEM
C	CAMERA
SW	SWITCH
TH	THERMOSTAT
AL	ALARM
AR	AERIAL
BT	BRITISH TELECOM
IS	ISOLATOR SWITCH
V	VENT
WL	WALL LIGHT
RAD	RADIATOR
LS	LIGHT SWITCH
S	SINGLE SOCKET
DS	DOUBLE SOCKET
INT	INTERCOM
SP	SPEAKERS
CMA	CARBON MONOXIDE ALARM

METRO PLANS SURVEYS	
MEASURED BUILDING SURVEY	
LEGEND	
F.C. 0.00	FLOOR TO RISE HEIGHT
C.H. 0.00	CELL TO HEAD HEIGHT
FL 21.80	FLOOR LEVEL
0.0000	SPRING HEIGHT
BLR	SINGLE STEP HEIGHT
AH	ACCESS HATCH
ARL	ARCH HEAD LEVEL
BSL	BOLLER
BOL	BOLLARD
BM	BENCHMARK
BS	BEAM SPLITTING LEVEL
BSH	BEAM SPLIT HEIGHT
CB	CABINET
CABV	CABLE TV
CBD	CLIFFBOARD
CCTV	CCTV CAMERA
CL	CEILING LEVEL
CHT	COUNTER
CH	CEILING HATCH
CL	CEILING LIGHT
CH	CEILING VENT
DV	DOOR HEIGHT
EW	EAVE LEVEL
EM	ELECTRIC METER
EP	ELECTRICAL POLE
FC	FALL BE CEILING
FP	FIX PLACE
FB	FUSE BOARD
FA	FIRE ALARM
FI	FIRE INDICATOR
FE	FIRE EXTINGUISHER
GM	GAS METER
GP	GATE POST
GV	GAS VALVE
GY	GULY
IR	INSPECTION CHAMBER
SI	STORM WATER INLET
LP	LAMP POST
BN	BRANDLE
CL	COVER LEVEL
SI	INVERT LEVEL
CHC	OVERHEAD CABLE
OH	OVERHEAD
P	POLE
PLR 0.00	PARALLEL LEVEL
PT	POST & TELEPHONE
PS	POWER SUPPLY
RAD	RADIATOR
RI	RICHMOND LEVEL
RD	ROAD SIGN
RWP	RAIN WATER PIPE
RID 0.00	RIDGE LEVEL PIPE
SLV	SHIELDING
BL	SKYLIGHT
SV	STOP VALVE
SVP	SOIL VENT PIPE
BUS	SUSPENDED CEILING
SW	SWITCH
TOP 0.00	TOP OF FENCE
TOP 0.00	TOP OF WALL
TP	TELEPHONE POLE
WH	WATER HEATER
WM	WATER MAIN
WT	WATER TANK
WV	WATER VALVE
WL	WALL LAMP
WS	WORK SURFACE
WS	SURVEY STATION
THREE DECIMALS	None (1) None (2) Height (3)
WALL CONCRETE	None (1) None (2) Height (3)
BLSH	BLUSH
ELECTRICAL LAYOUT	
△	SINGLE SOCKET
△	DOUBLE SOCKET
△	TELECOM
△	TV
△	ALARM
△	LIGHTING
△	ULTRALIGHT
△	SINGLE SWITCH
△	DOUBLE SWITCH

All levels to arbitrary datum

-	-	-	-
-	-	-	-
-	-	-	-
-	-	-	-
-	FULL ISSUE	06/02/2024	DC

 


33 GOLDSMITH ROAD
ACTON
LONDON W3 6PX
TEL NO. + 44 (0) 20 8354 9331
EMAIL: info@metroplans.com
WEB: www.metroplans.com

LAND & MEASURED BUILDING SURVEYS

SURVEY TYPE

EXISTING 1st FLR PLAN

Drawn by	TZ	Scale	1:100@A3 1:50@A1
Checked by	DC	Job No.	1139
Date	FEB 2024	Dwg No.	1139-S04

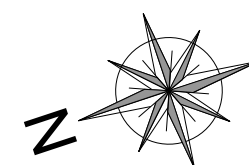

FIT MARK A