


A horizontal number line is shown, labeled from 0 to 9 meters. Major tick marks are placed at every integer from 0 to 9. Shaded rectangular regions are drawn above the number line to represent the lengths of the four pieces of wood. The first shaded region starts at 0 and ends at 1. The second shaded region starts at 2 and ends at 3. The third shaded region starts at 4 and ends at 6. The fourth shaded region starts at 8 and ends at 9.


A number line from 0 to 30. Major tick marks are labeled at 0, 6, 12, 18, 24, and 30. Minor tick marks are placed every 2 units. Three regions are shaded gray: from 0 to 6, from 12 to 18, and from 24 to 30.

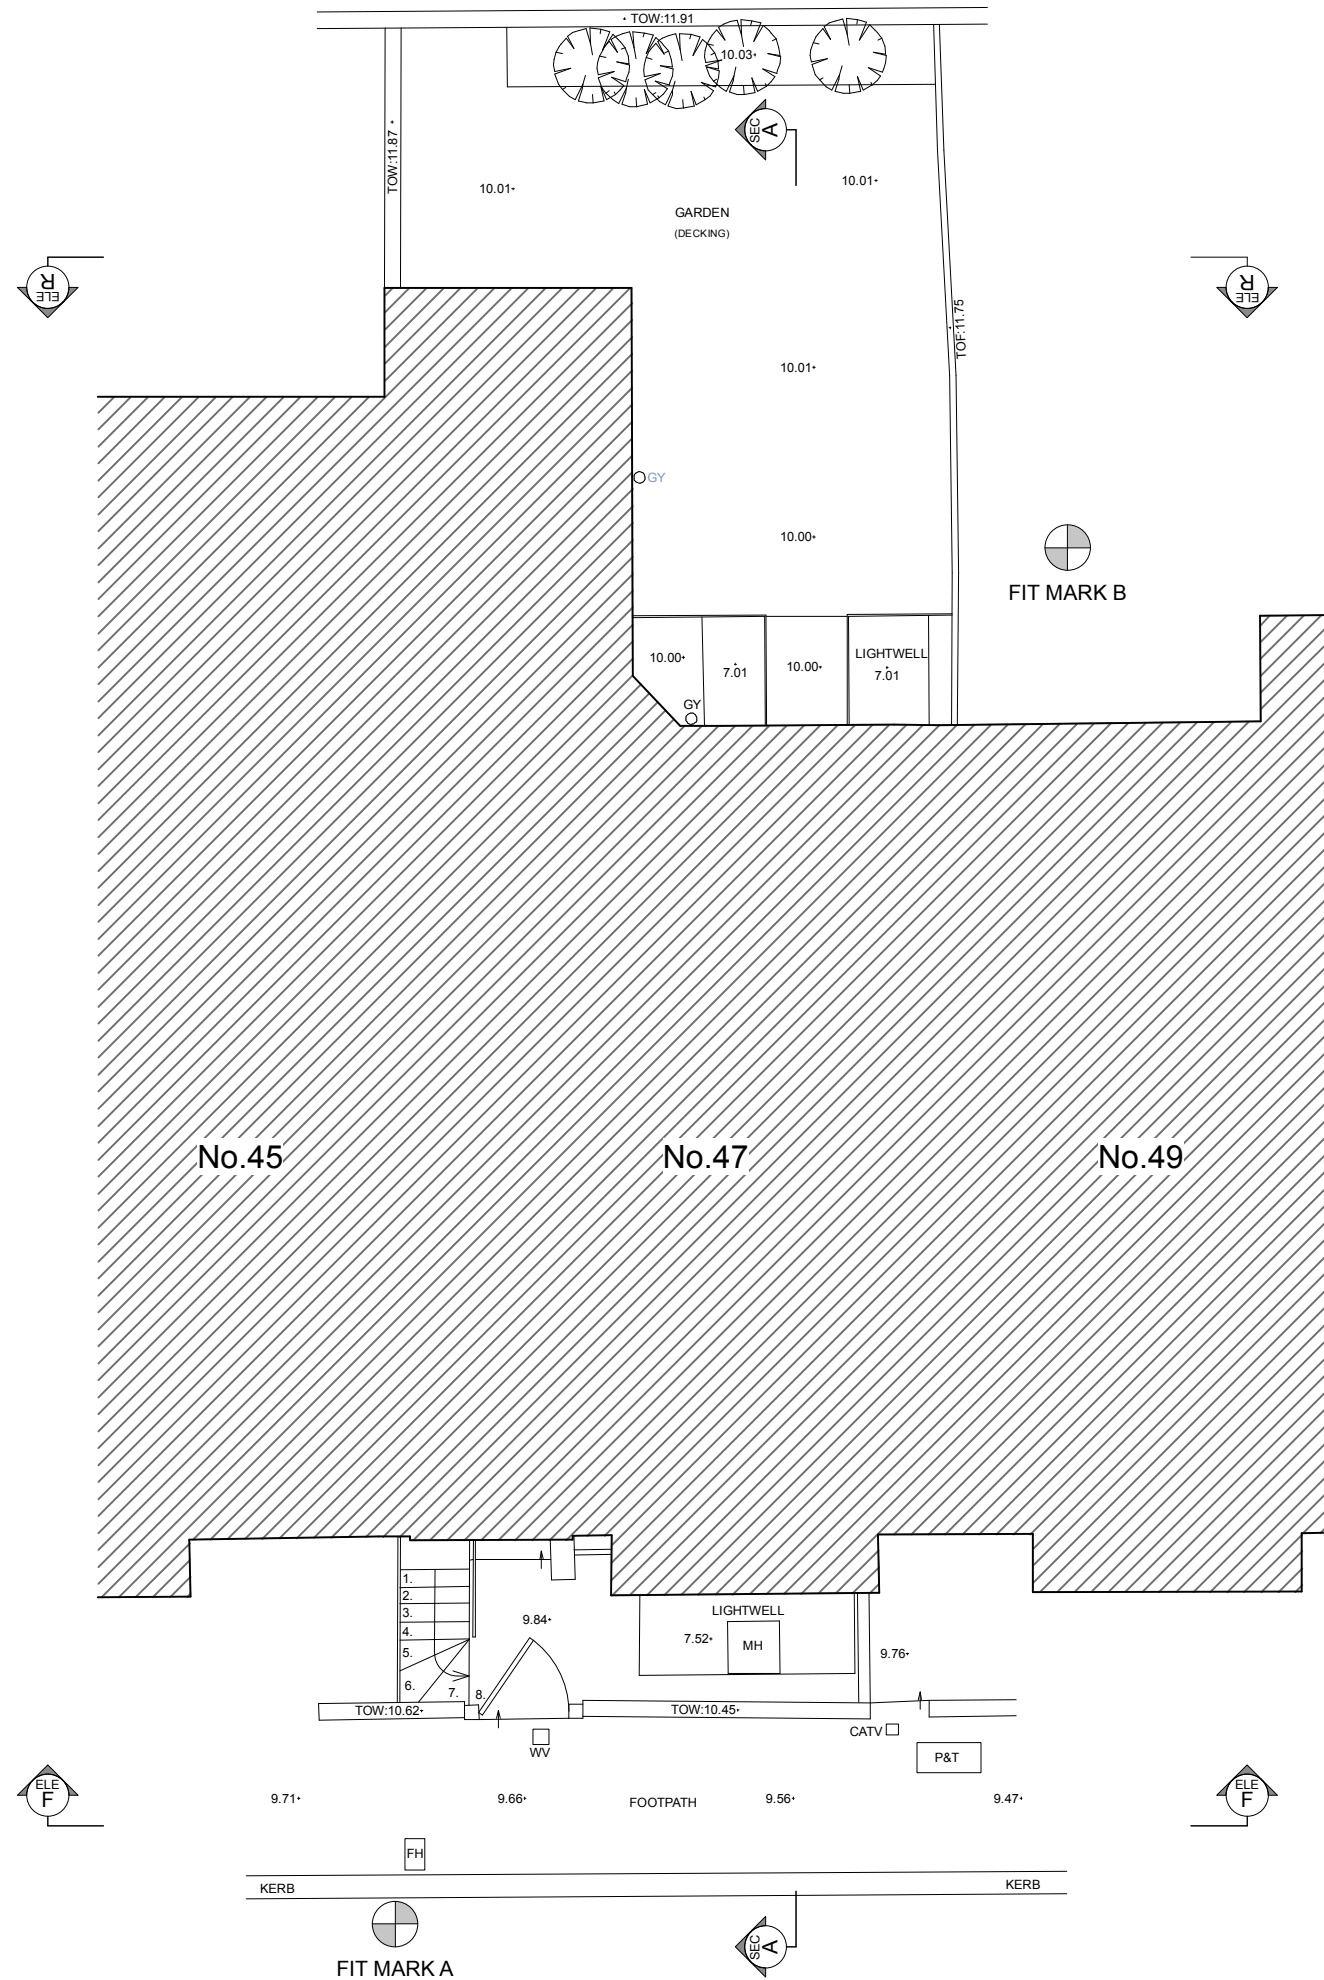

METRO PLANS SURVEYS	
MEASURED BUILDING SURVEY	
LEGEND	
F.C. 0.00	FLOOR TO CEIL HEIGHT
C.H. 0.00	CALL TO HEAD HEIGHT
FL 21.80	FLOOR TO CEILING HEIGHT
FL 21.80	FLOOR LEVEL
0.00m	SPRING HEIGHT
0.00m	SINGLE STEP HEIGHT
AN	ACCESS HATCH
ANL	ARCH HEAD LEVEL
BLR	BOLLARD
BOL	BOLLARD
BM	BENCH-MARK
BEL	BEAM SPLITTER LEVEL
BSH	BEAM SPLITTER HEIGHT
CAB	CABINET
CATV	CABLE TV
CLD	CULPBOARD
CCTV	CCTV CAMERA
CLB	CeILING LEVEL
CNT	COUNTER
CH	CEILING HATCH
CL	CEILING LIGHT
CV	CEILING VENT
DN	DOOR HEIGHT
EAVE 0.00	EAVE LEVEL
EM	ELECTRIC METER
EP	ELECTRIC POLE
FC	F.A.SE CEILING
FP	FIRE PLACE
FB	FIRE BOARD
FA	FIRE ALARM
FI	FIRE INDICATOR
FE	FIRE EXTINGUISHER
GM	GAS METER
GP	GATE POST
GV	GAS VALVE
GY	GULLY
IC	INSPECTION CHAMBER
NO	STORM WATER INLET
LP	LAMP POST
LM	MANHOLE
-CL	COVER LEVEL
-IL	INVERT LEVEL
CHD	OVER HEAD CABLE
CHD	OVERHANG
P	POLE
PRM 0.00	PARAPET LEVEL
PT	POST & TELECOM
PS	POWER SUPPLY
RAD	RADIATOR
RE	ROOFING LINE
RS	ROAD SIGN
RSP	RAIN WATER PIPE
RSG 0.00	ROOF LEVEL
SLV	SHELVING
SL	SUNLIGHT
SV	STOP VALVE
SVB	SOIL VENT PIPE
SUSP	SUSPENDED CEILING
SW	SWITCH
TOP 0.00	TOP OF DE FENCE
TOP 0.00	TOP OF WALL
TP	TELEPHONE POLE
WH	WATER HEATER
WM	WATER MAIN
WT	WATER TANK
WV	WATER VALVE
WL	WALL LAMP
WS	WORK SURFACE
BS	SURVEY STATION
TH	THREE DECISIONS: - turn (D) - merge (D) - merge (D)
TC	TREE CONVERGENCE: - turn (D) - merge (D) - merge (D)
BUSH	BUSH
ELECTRICAL LAYOUT	
	SINGLE SOCKET
	DOUBLE SOCKET
	TELECOM
	TV
	ALARM
	LIGHTING
	UPLIGHT
	SINGLE SWITCH
	DOUBLE SWITCH

All levels to arbitrary datum
-

-	-	-	-
-	-	-	-
-	-	-	-
-	-	-	-
-	FULL ISSUE	06/02/2024	DC

 

33 GOLDSMITH ROAD
ACTON
LONDON W3 6PX
TEL NO. + 44 (0) 20 8354 9331
EMAIL: info@metroplans.com
WEB: www.metroplans.com

LAND & MEASURED BUILDING SURVEYS

EXISTING & PROPOSED SITE PLANS

NO CHANGES

Drawn by	TZ	Scale	1:100@A3 1:50@A1
Checked by	DC	Job No.	1139
Date	FEB 2024	Dwg No.	1139-S01