



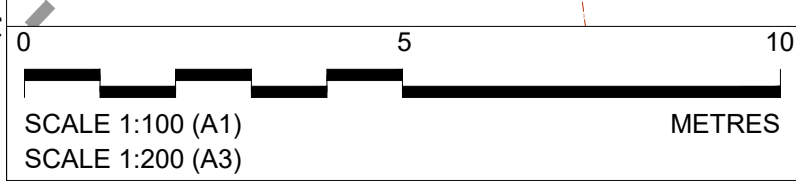

FOR CONTINUATION PLEASE REFER TO DRAWING No. 10033252-ARC-VUT-ZZ-DR-HE-1020

**NOTES**  
1. ALL DIMENSIONS ARE IN METRES UNLESS OTHERWISE STATED.  
2. DO NOT SCALE FROM THIS DRAWING

This map is based upon Ordnance Survey material with the permission of Ordnance Survey on behalf of the Controller of Her Majesty's Stationery Office. © Crown copyright. Unauthorised reproduction infringes Crown copyright and may lead to prosecution or civil proceedings. London Borough of Camden Licence 100019726 2017.

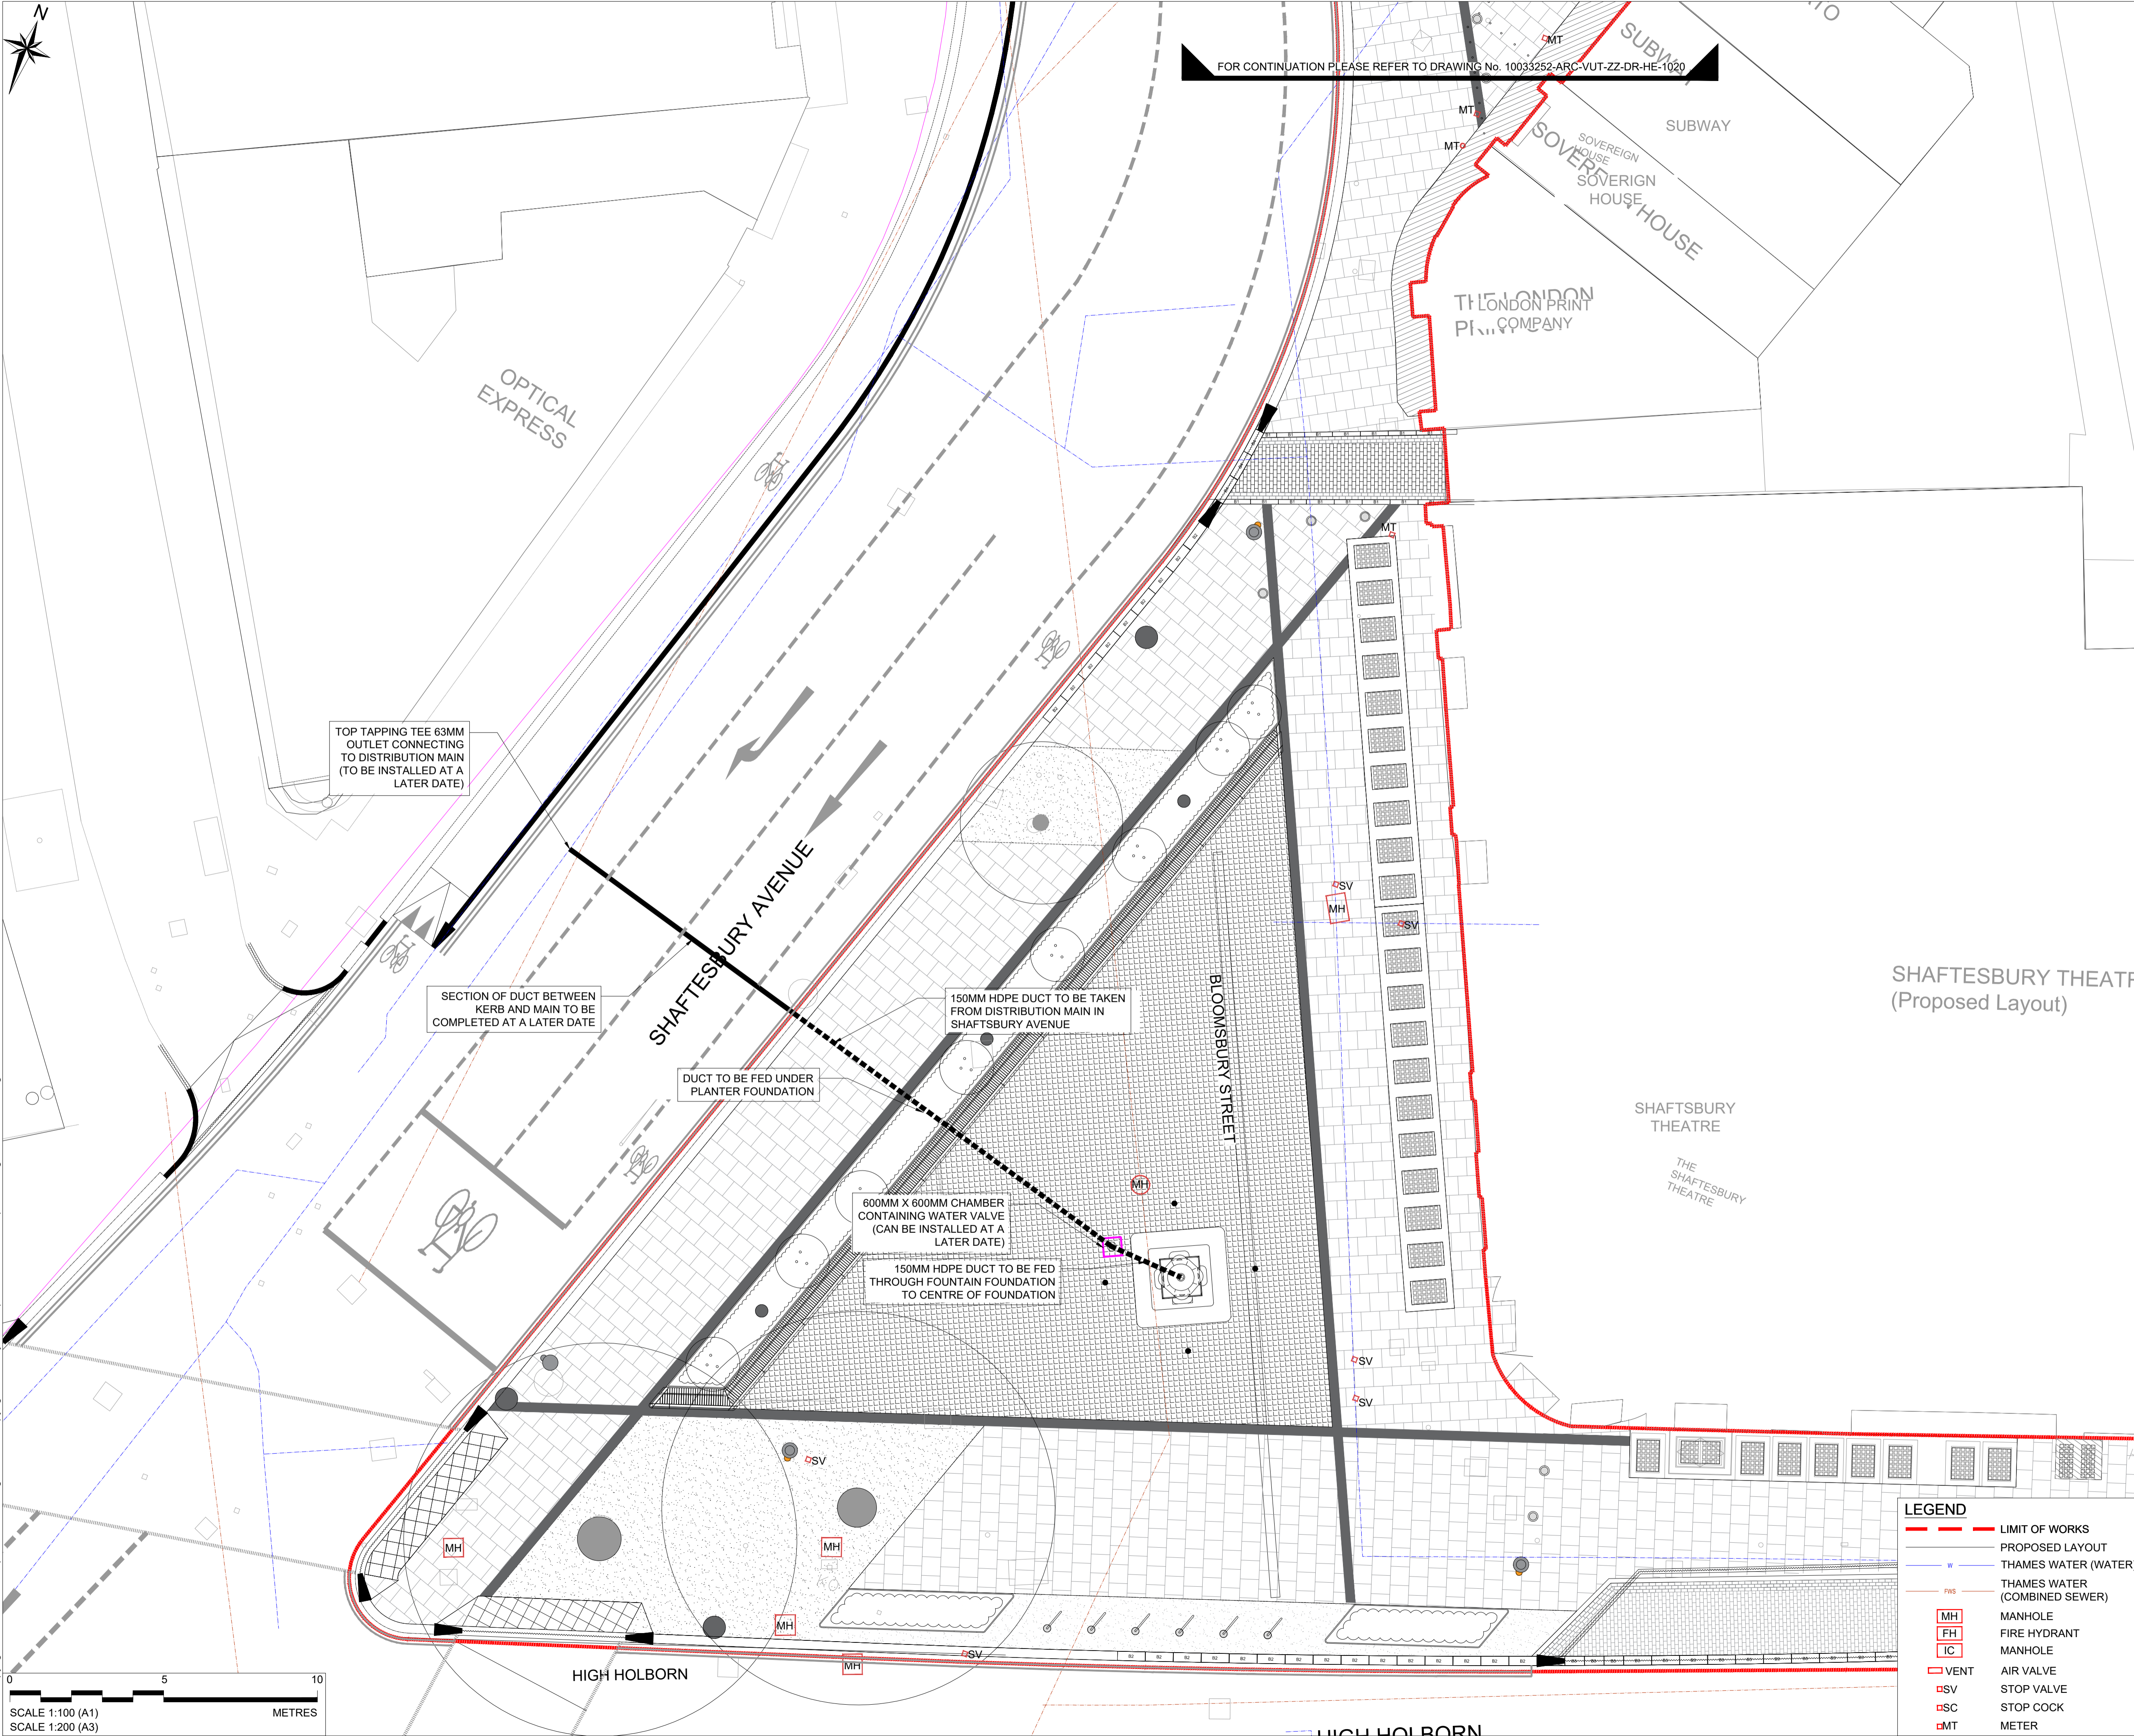

Print Date: 2023-04-20 10:20:52

C:\Users\cgs10538\ARCADIS\Camden WEP Squares - Documents\E-OurDrawings\Princes Circus\WIP\Drawings\10033252-ARC-VUT-ZZ-DR-HE-1019 to 1021 - Thames Water.dwg

**LEGEND**

---	LIMIT OF WORKS
- - -	PROPOSED LAYOUT
W	THAMES WATER (WATER)
FWS	THAMES WATER (COMBINED SEWER)
MH	MANHOLE
FH	FIRE HYDRANT
IC	MANHOLE
VENT	AIR VALVE
SV	STOP VALVE
SC	STOP COCK
MT	METER

Rev	Date	Description	Drawn	Check	Approv
P00	18JUN20	DRAFT ISSUE			HGS

**Client**

**PROJECT:**  
CAMDEN GREEN SPACES  
PRINCES CIRCUS

**Site**      **Client**

Address: Design Team  
City: Transport Strategy Service  
London Borough of Camden  
5 Pancras Square  
Phone: +44 (0)20 7974 5551  
Fax: +44 (0)20 7974 6952

Registered office: Arcadis House, 34 York Way, London, N1 9AB  
Coordinating office: Arcadis House, 34 York Way, London, N1 9AB, Tel: 44 (0)20 7812 2000

www.arcadis.com

**TITLE:**  
THAMES WATER UTILITY PLAN  
SHEET 3 OF 3

Designed	X.XXXXX	Signed	X.XXXXX	Date	31JAN23
Drawn	H.G.SHOBHA	Signed	H.G.SHOBHA	Date	31JAN23
Checked	X.XXXXX	Signed	X.XXXXX	Date	31JAN23
Approved	X.XXXXX	Signed	X.XXXXX	Date	31JAN23
Scale:	1:100	Datum:	AOD		
Original Size:	A1	Grid:	OS		
Suitability Code:	S2	Project Number:	10033252		
Suitability Description: <b>FOR INFORMATION</b>					
Drawing Number:	10033252-ARC-VUT-ZZ-DR-HE-1021	Revision:	P00		

**DRAFT**