



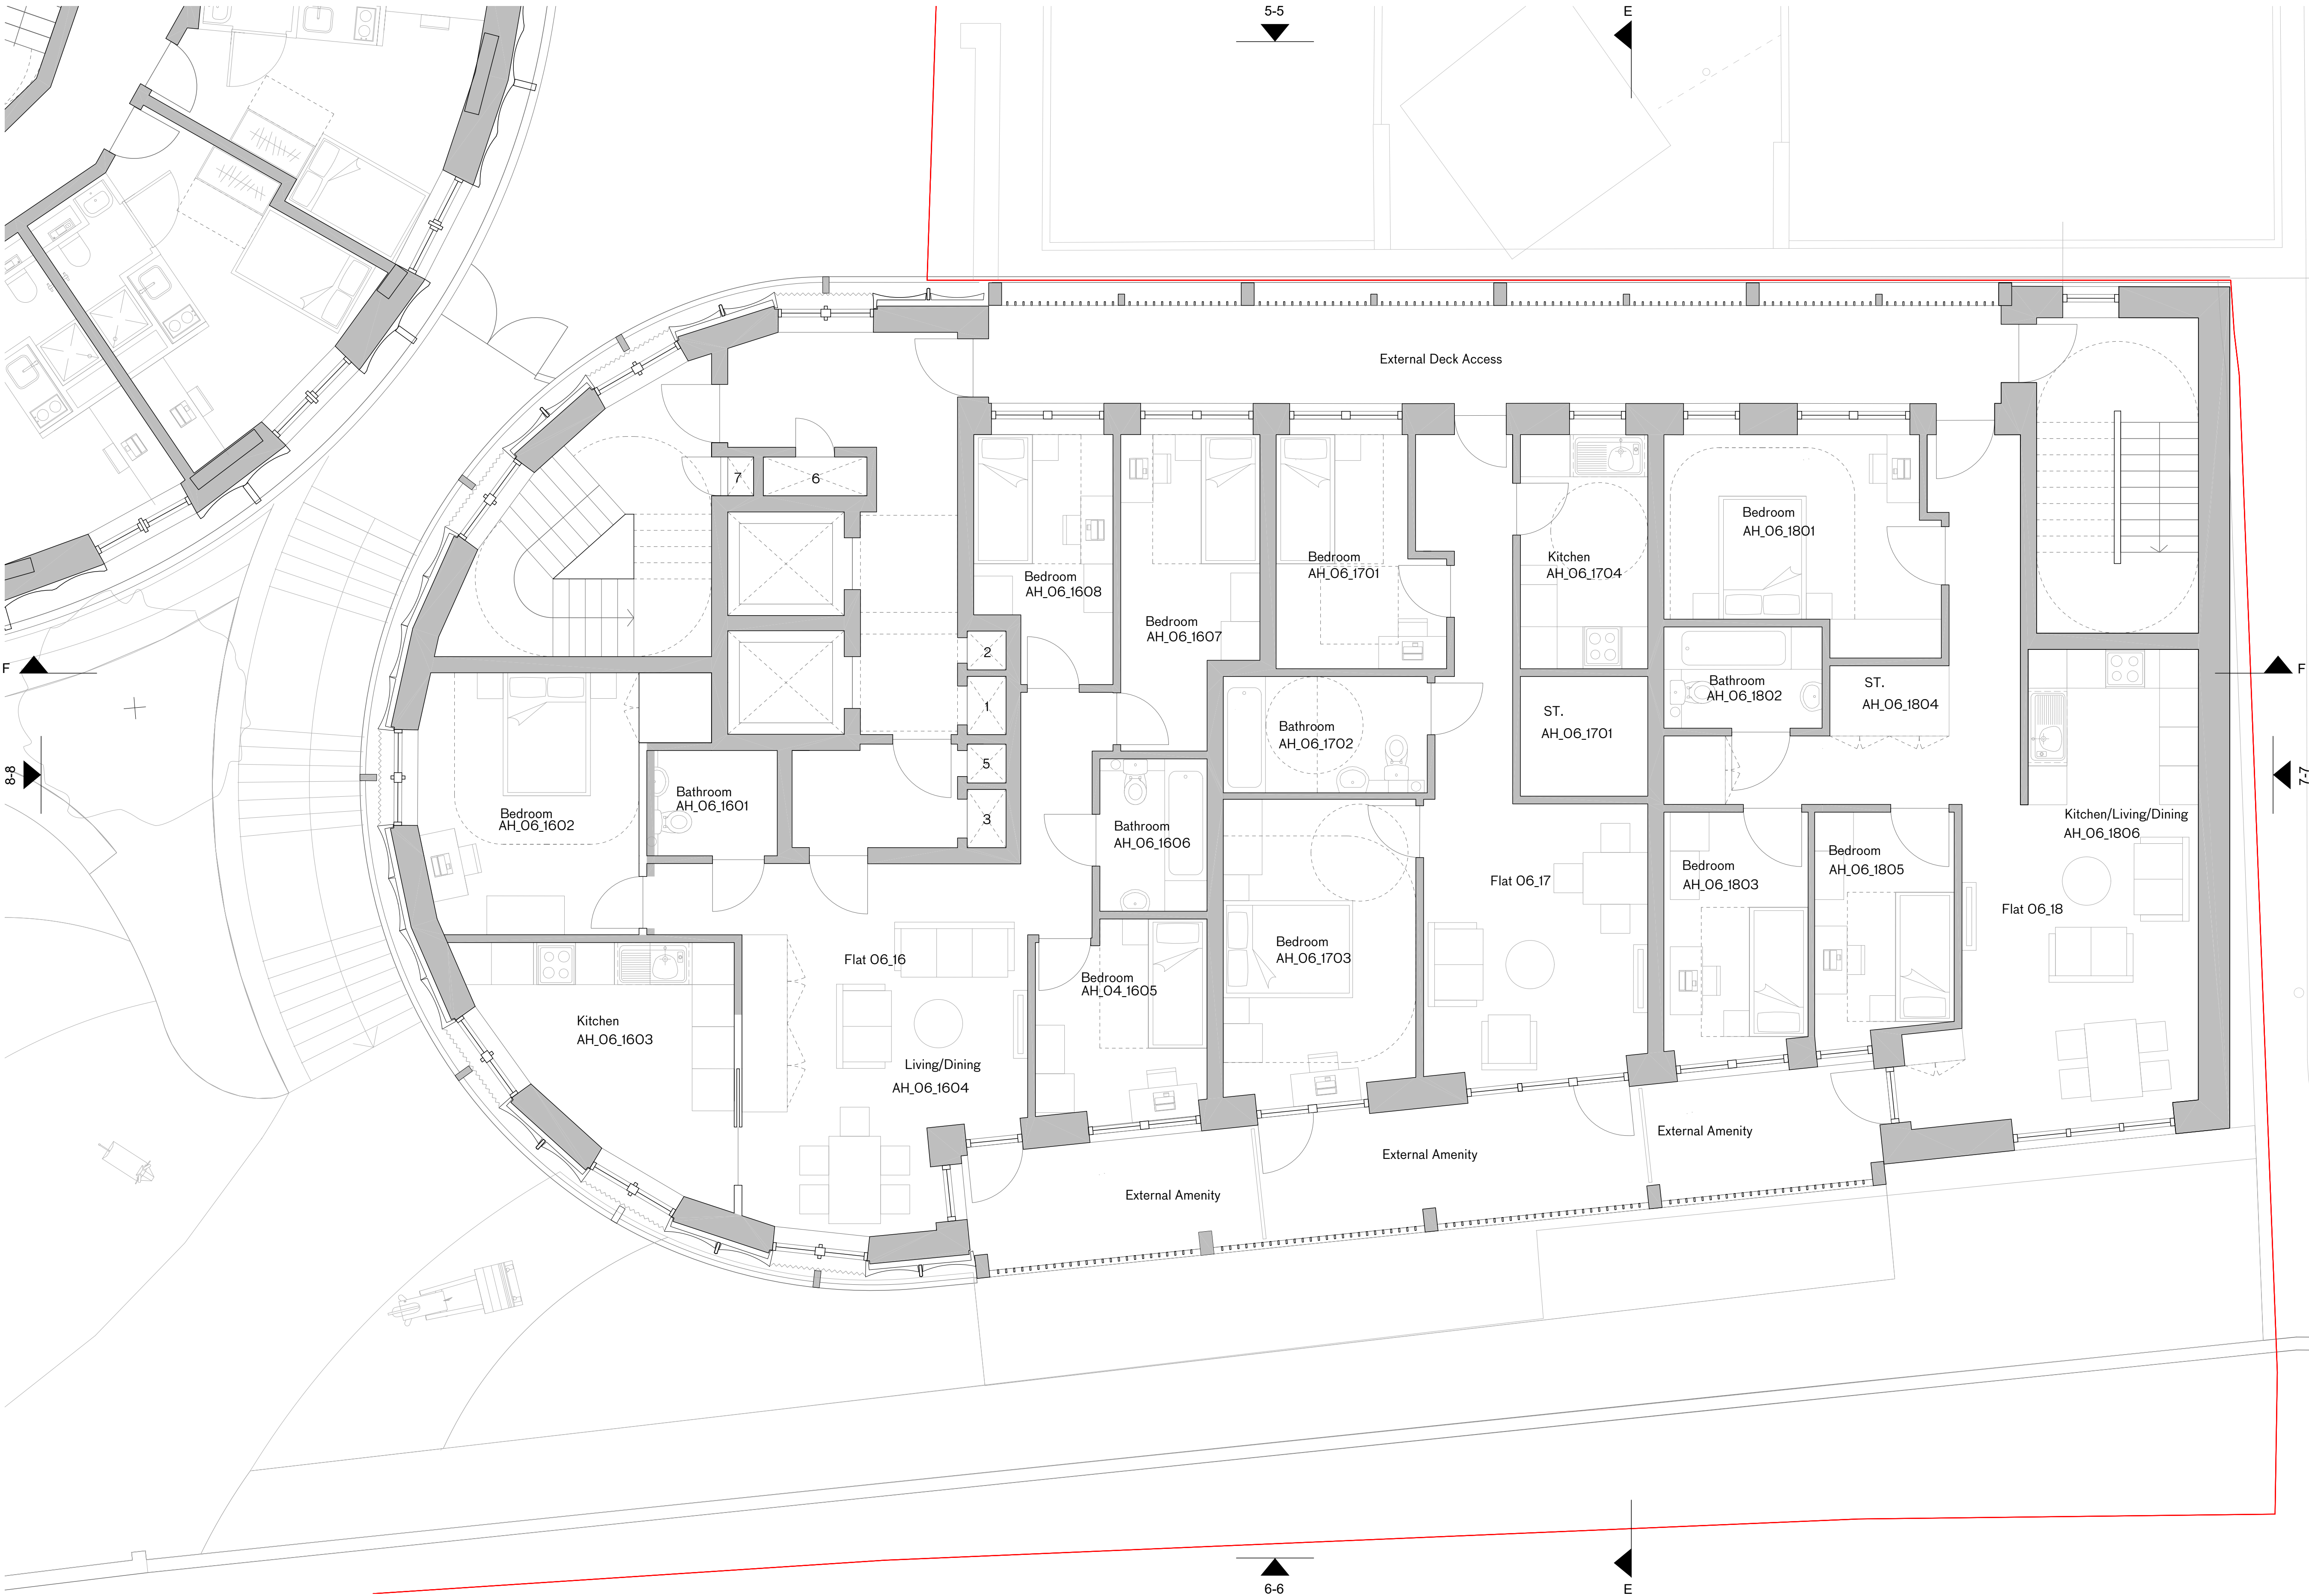

Affordable Housing Level 6 Floor Plan

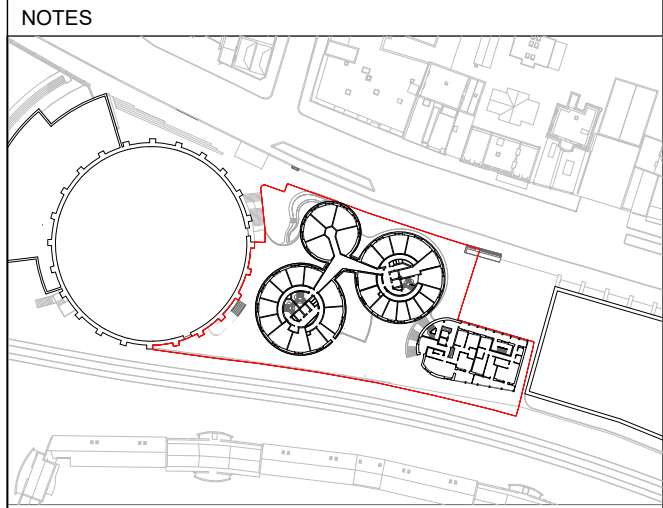

- Key to Risers
- 1 Heating Riser
 - 2 Water Riser
 - 3 Comms Riser
 - 4 Electrical Riser
 - 5 Smoke Outlet
 - 6 Smoke Inlet
 - 7 Dry Riser
 - 8 MVHR Cupboard
 - 9 Mechanical Ventilation
- Site Boundary
- Petrol Filling Station Consented Scheme, Planning Ref: 2022/3646/P

C -28/05/24 Planning
B -17/05/24 Revised PBSA Layouts
A - 31/01/24 Planning

PLANNING

rev	date	check	comments
DSDHA 357 Kennington Lane London SE11 5QY T 020 7703 3555 F 020 7703 3890 E info@dsdha.co.uk W www.dsdha.co.uk			
project			
100 Chalk Farm Road			
drawing title			
Affordable Housing Level 6 Floor Plan			
drawn	size	date	scale
FI	A1	28/05/24	1 : 50
drawing number			revision
356_P20.166			C
REPORT DISCREPANCIES DO NOT SCALE FROM THIS DRAWING COPYRIGHT DSDHA		USE LATEST REVISION CHECK DIMENSIONS ON SITE	