



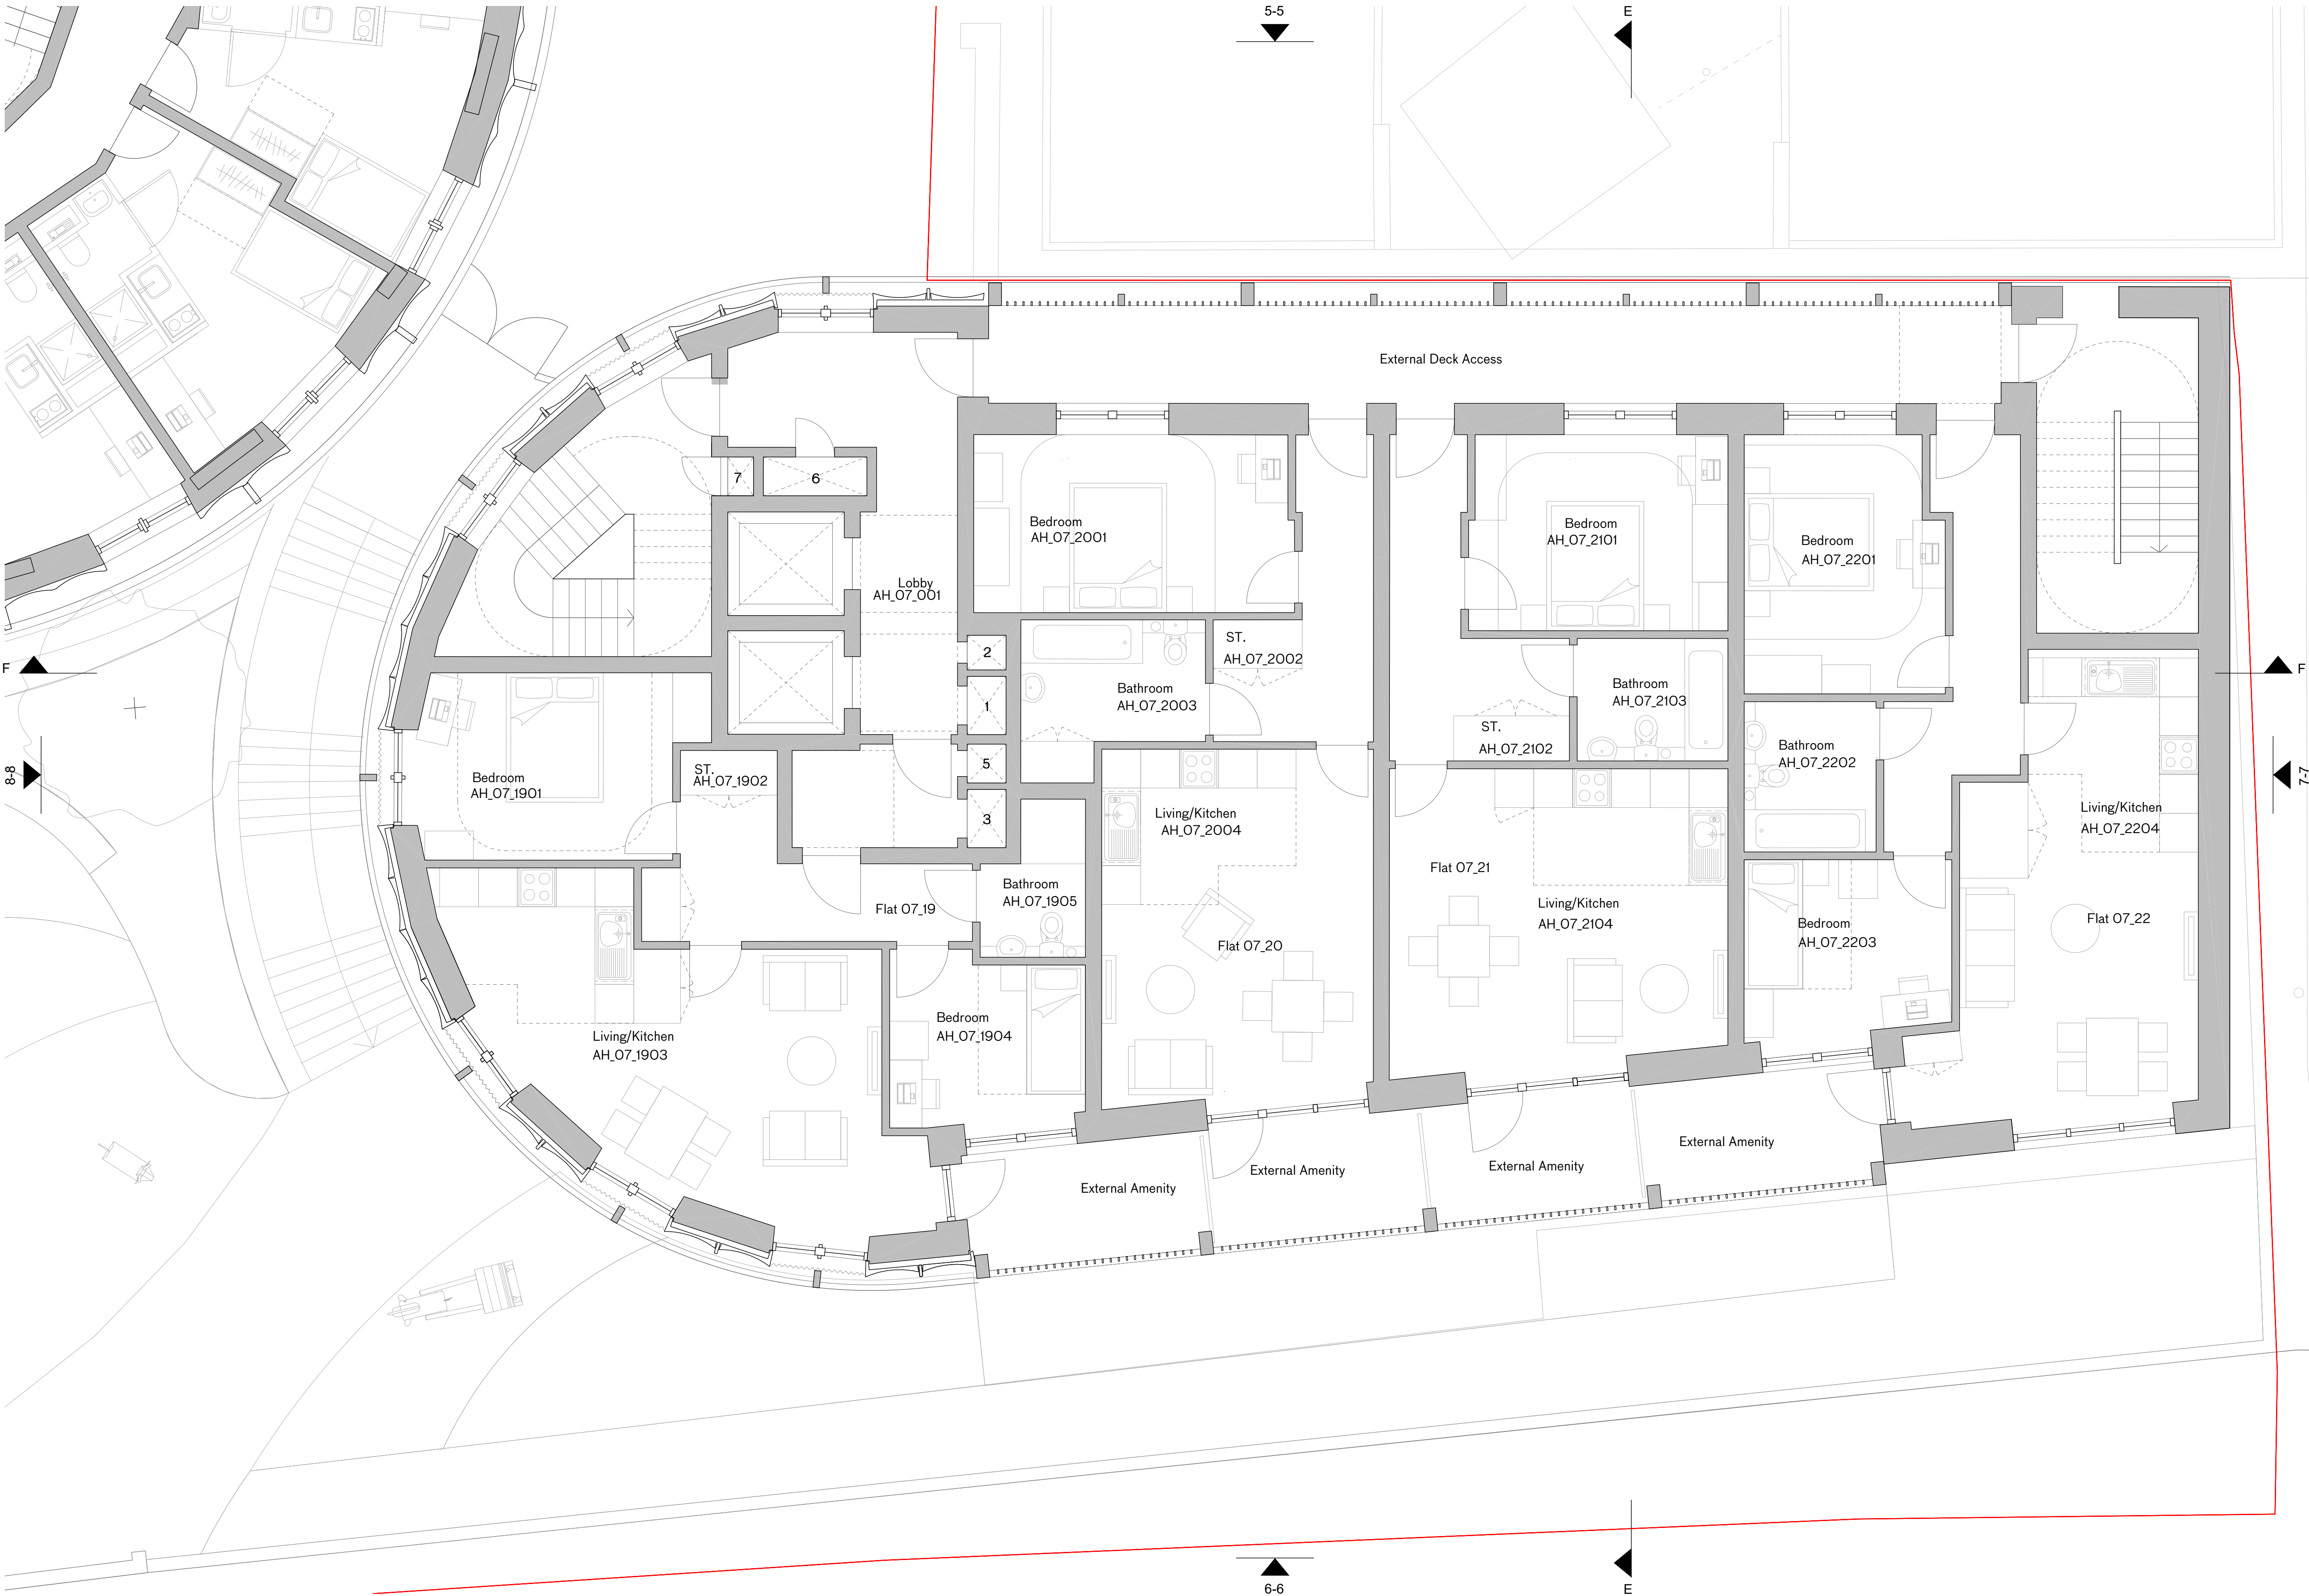

Affordable Housing Level 7 - 8 Floor Plan

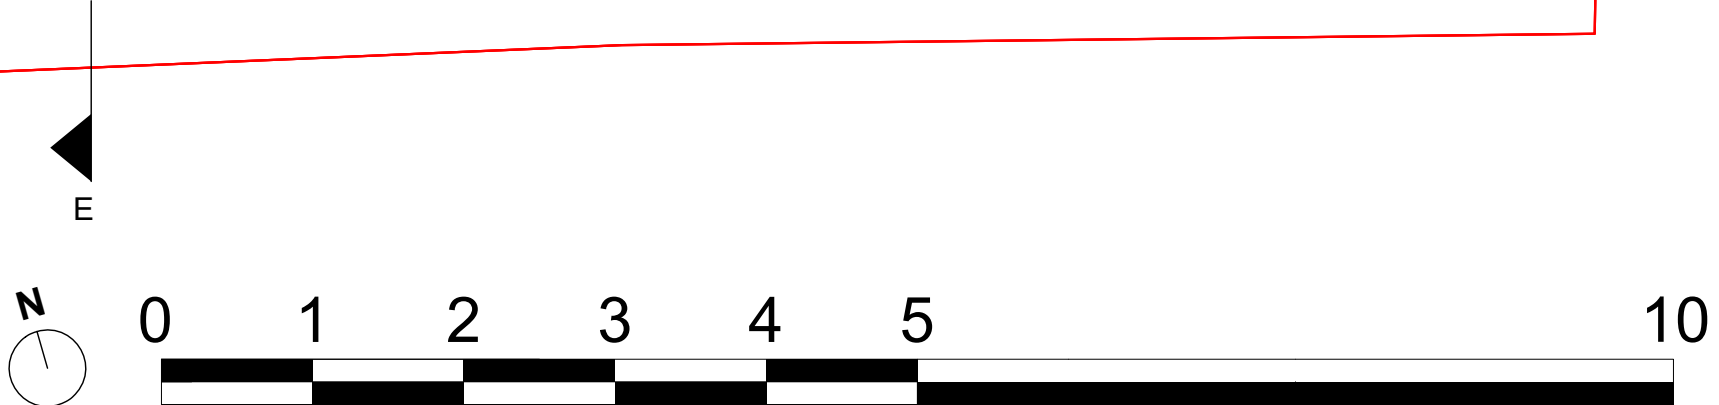

NOTES

Key to Risers

1 Heating Riser

2 Water Riser

3 Comms Riser

4 Electrical Riser

5 Smoke Outlet

6 Smoke Inlet

7 Dry Riser

8 MVHR Cupboard

9 Mechanical Ventilation

Site Boundary

Petrol Filling Station Consented Scheme, Planning Ref: 2022/3646/P

C -28/05/24 Planning

B -17/05/24 Revised PBSA Layouts

A - 31/01/24 Planning

PLANNING

rev	date	check	comments
DSDHA			
357 Kennington Lane London SE11 5QY			
T 020 7703 3555			
F 020 7703 3890			
E info@dsdha.co.uk			
W www.dsdha.co.uk			
project			

100 Chalk Farm Road

drawing title

Affordable Housing Level 7 - 8 Floor Plan

drawn	size	date	scale
FI	A1	28/05/24	1 : 50
drawing number			revision
356_P20.167			C

REPORT DISCREPANCIES
DO NOT SCALE FROM THIS DRAWING
COPYRIGHT DSDHA

USE LATEST REVISION
CHECK DIMENSIONS ON SITE