
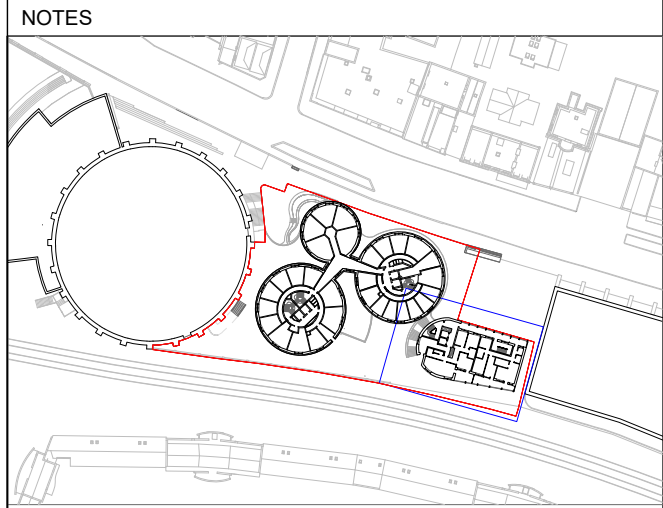


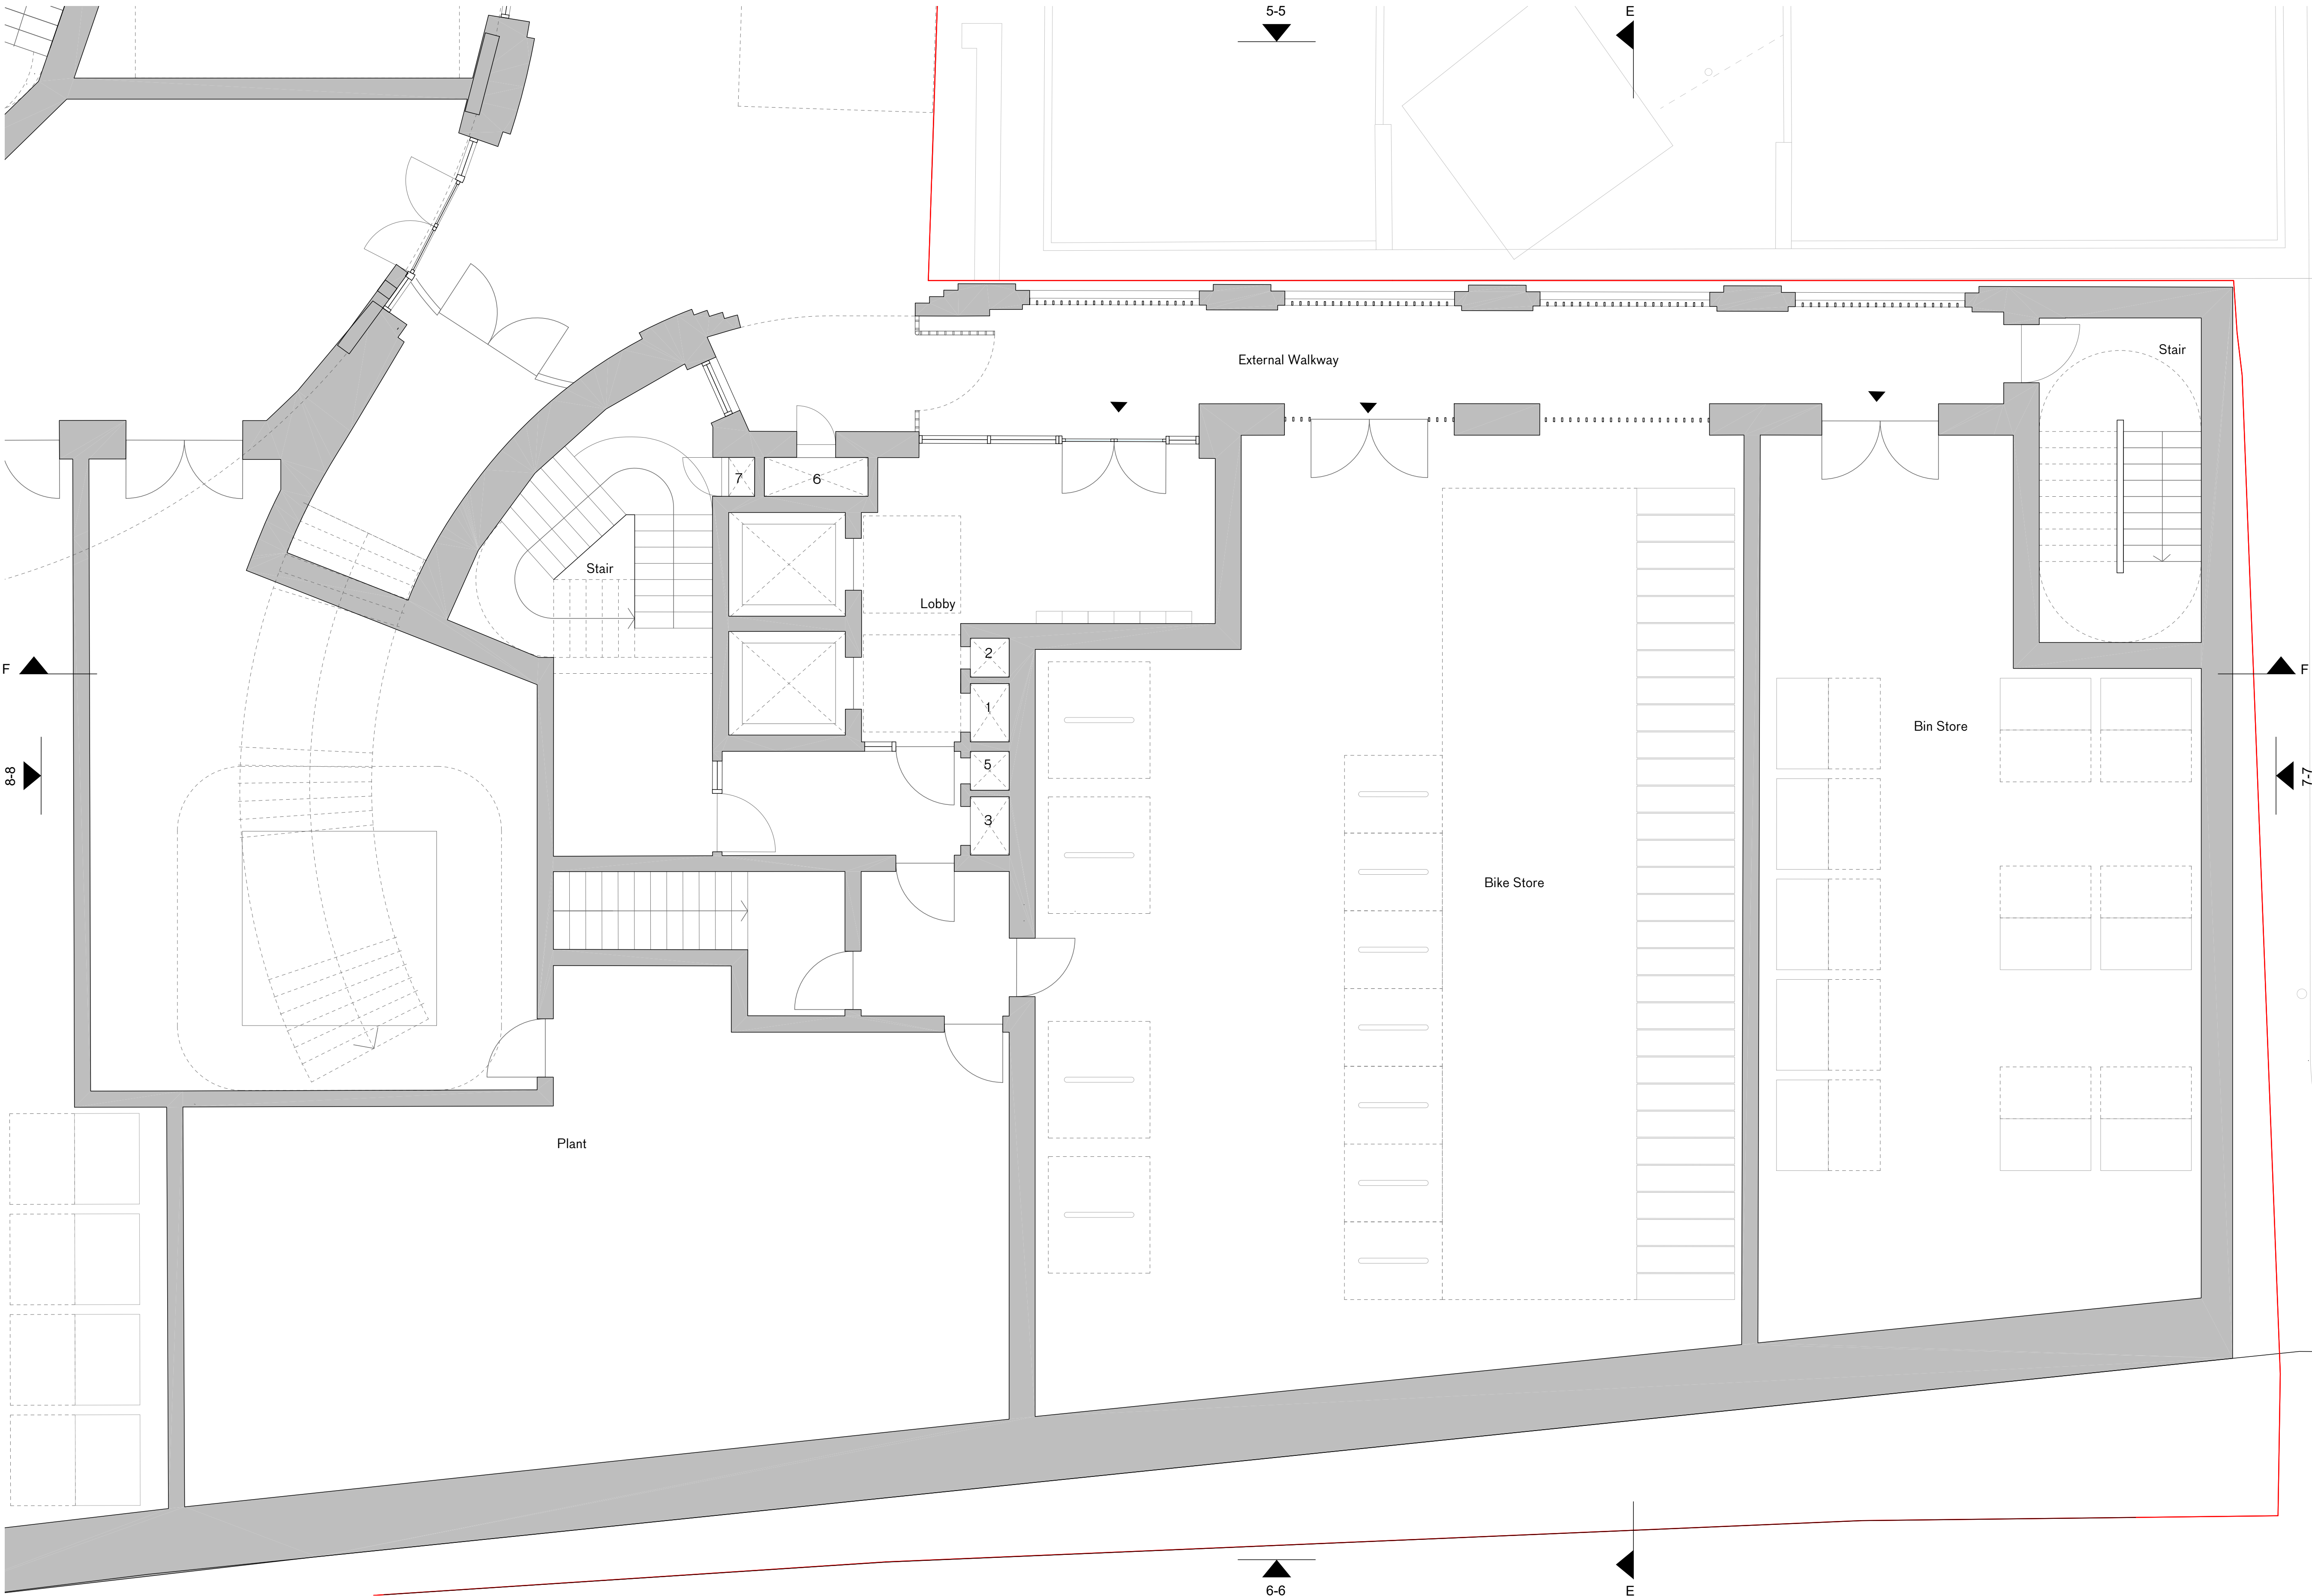

- Key to Risers
- 1 Heating Riser
 - 2 Water Riser
 - 3 Comms Riser
 - 4 Electrical Riser
 - 5 Smoke Outlet
 - 6 Smoke Inlet
 - 7 Dry Riser
 - 8 MVHR Cupboard
 - 9 Mechanical Ventilation
- Site Boundary
- Petrol Filling Station Consented Scheme, Planning Ref: 2022/3646/P

C -28/05/24 Planning
B -17/05/24 Revised PBSA Layouts
A - 31/01/24 Planning

PLANNING

rev date check comments

DSDHA
357 Kennington Lane London SE11 5QY
T 020 7703 3555
F 020 7703 3890
E info@dsdha.co.uk
W www.dsdha.co.uk

project

100 Chalk Farm Road

drawing title

Affordable Housing Ground Floor Plan

drawn	size	date	scale
FI	A1	28/05/24	1 : 50
drawing number			revision

356_P20.160 C

REPORT DISCREPANCIES
DO NOT SCALE FROM THIS DRAWING
COPYRIGHT DSDHA

USE LATEST REVISION
CHECK DIMENSIONS ON SITE