


Affordable Housing Level 1 Floor Plan

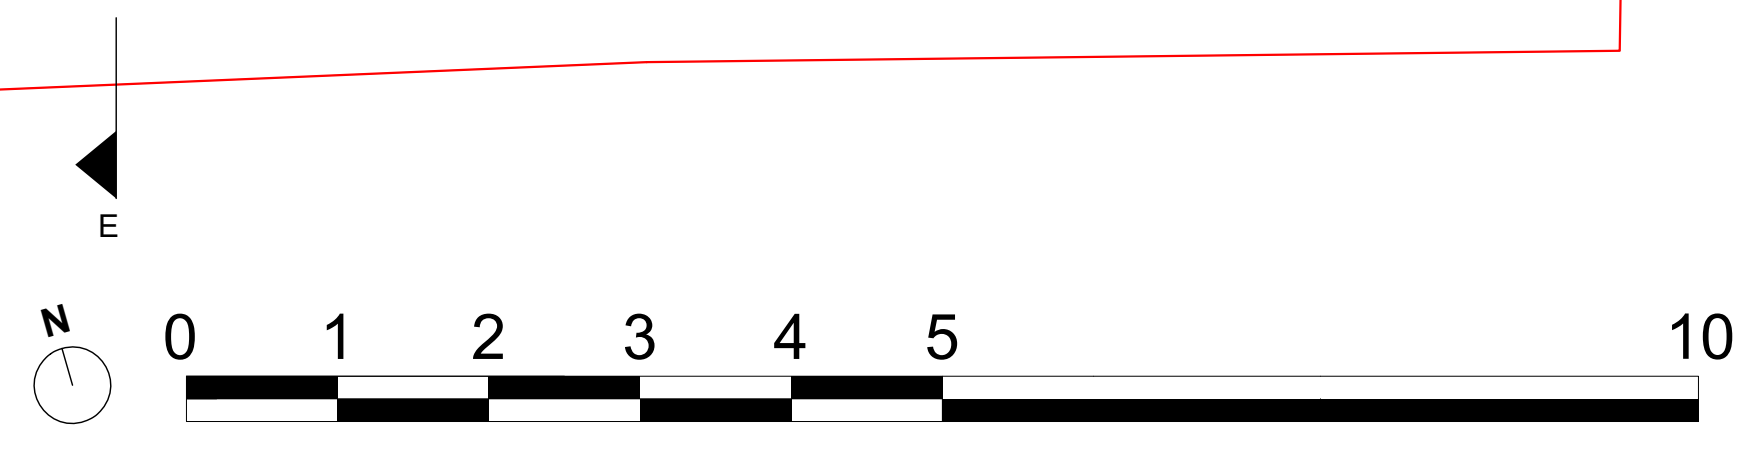

NOTES

Key to Risers
 1 Heating Riser
 2 Water Riser
 3 Comms Riser
 4 Electrical Riser
 5 Smoke Outlet
 6 Smoke Inlet
 7 Dry Riser
 8 MVHR Cupboard
 9 Mechanical Ventilation

— Site Boundary

— Petrol Filling Station Consented Scheme. Planning Ref: 2022/3646/P

C -28/05/24 Planning
 B -17/05/24 Revised PBSA Layouts
 A - 31/01/24 Planning

PLANNING

rev	date	check	comments
DSDHA			
357 Kennington Lane London SE11 5QY			
T 020 7703 3555			
F 020 7703 3890			
E info@dsdha.co.uk			
W www.dsdha.co.uk			
project			

100 Chalk Farm Road

drawing title

Affordable Housing Level 1 Floor Plan

drawn	size	date	scale
FI	A1	28/05/24	1 : 50
drawing number	revision		
356_P20.161	C		

REPORT DISCREPANCIES DO NOT SCALE FROM THIS DRAWING COPYRIGHT DSDHA

USE LATEST REVISION CHECK DIMENSIONS ON SITE