



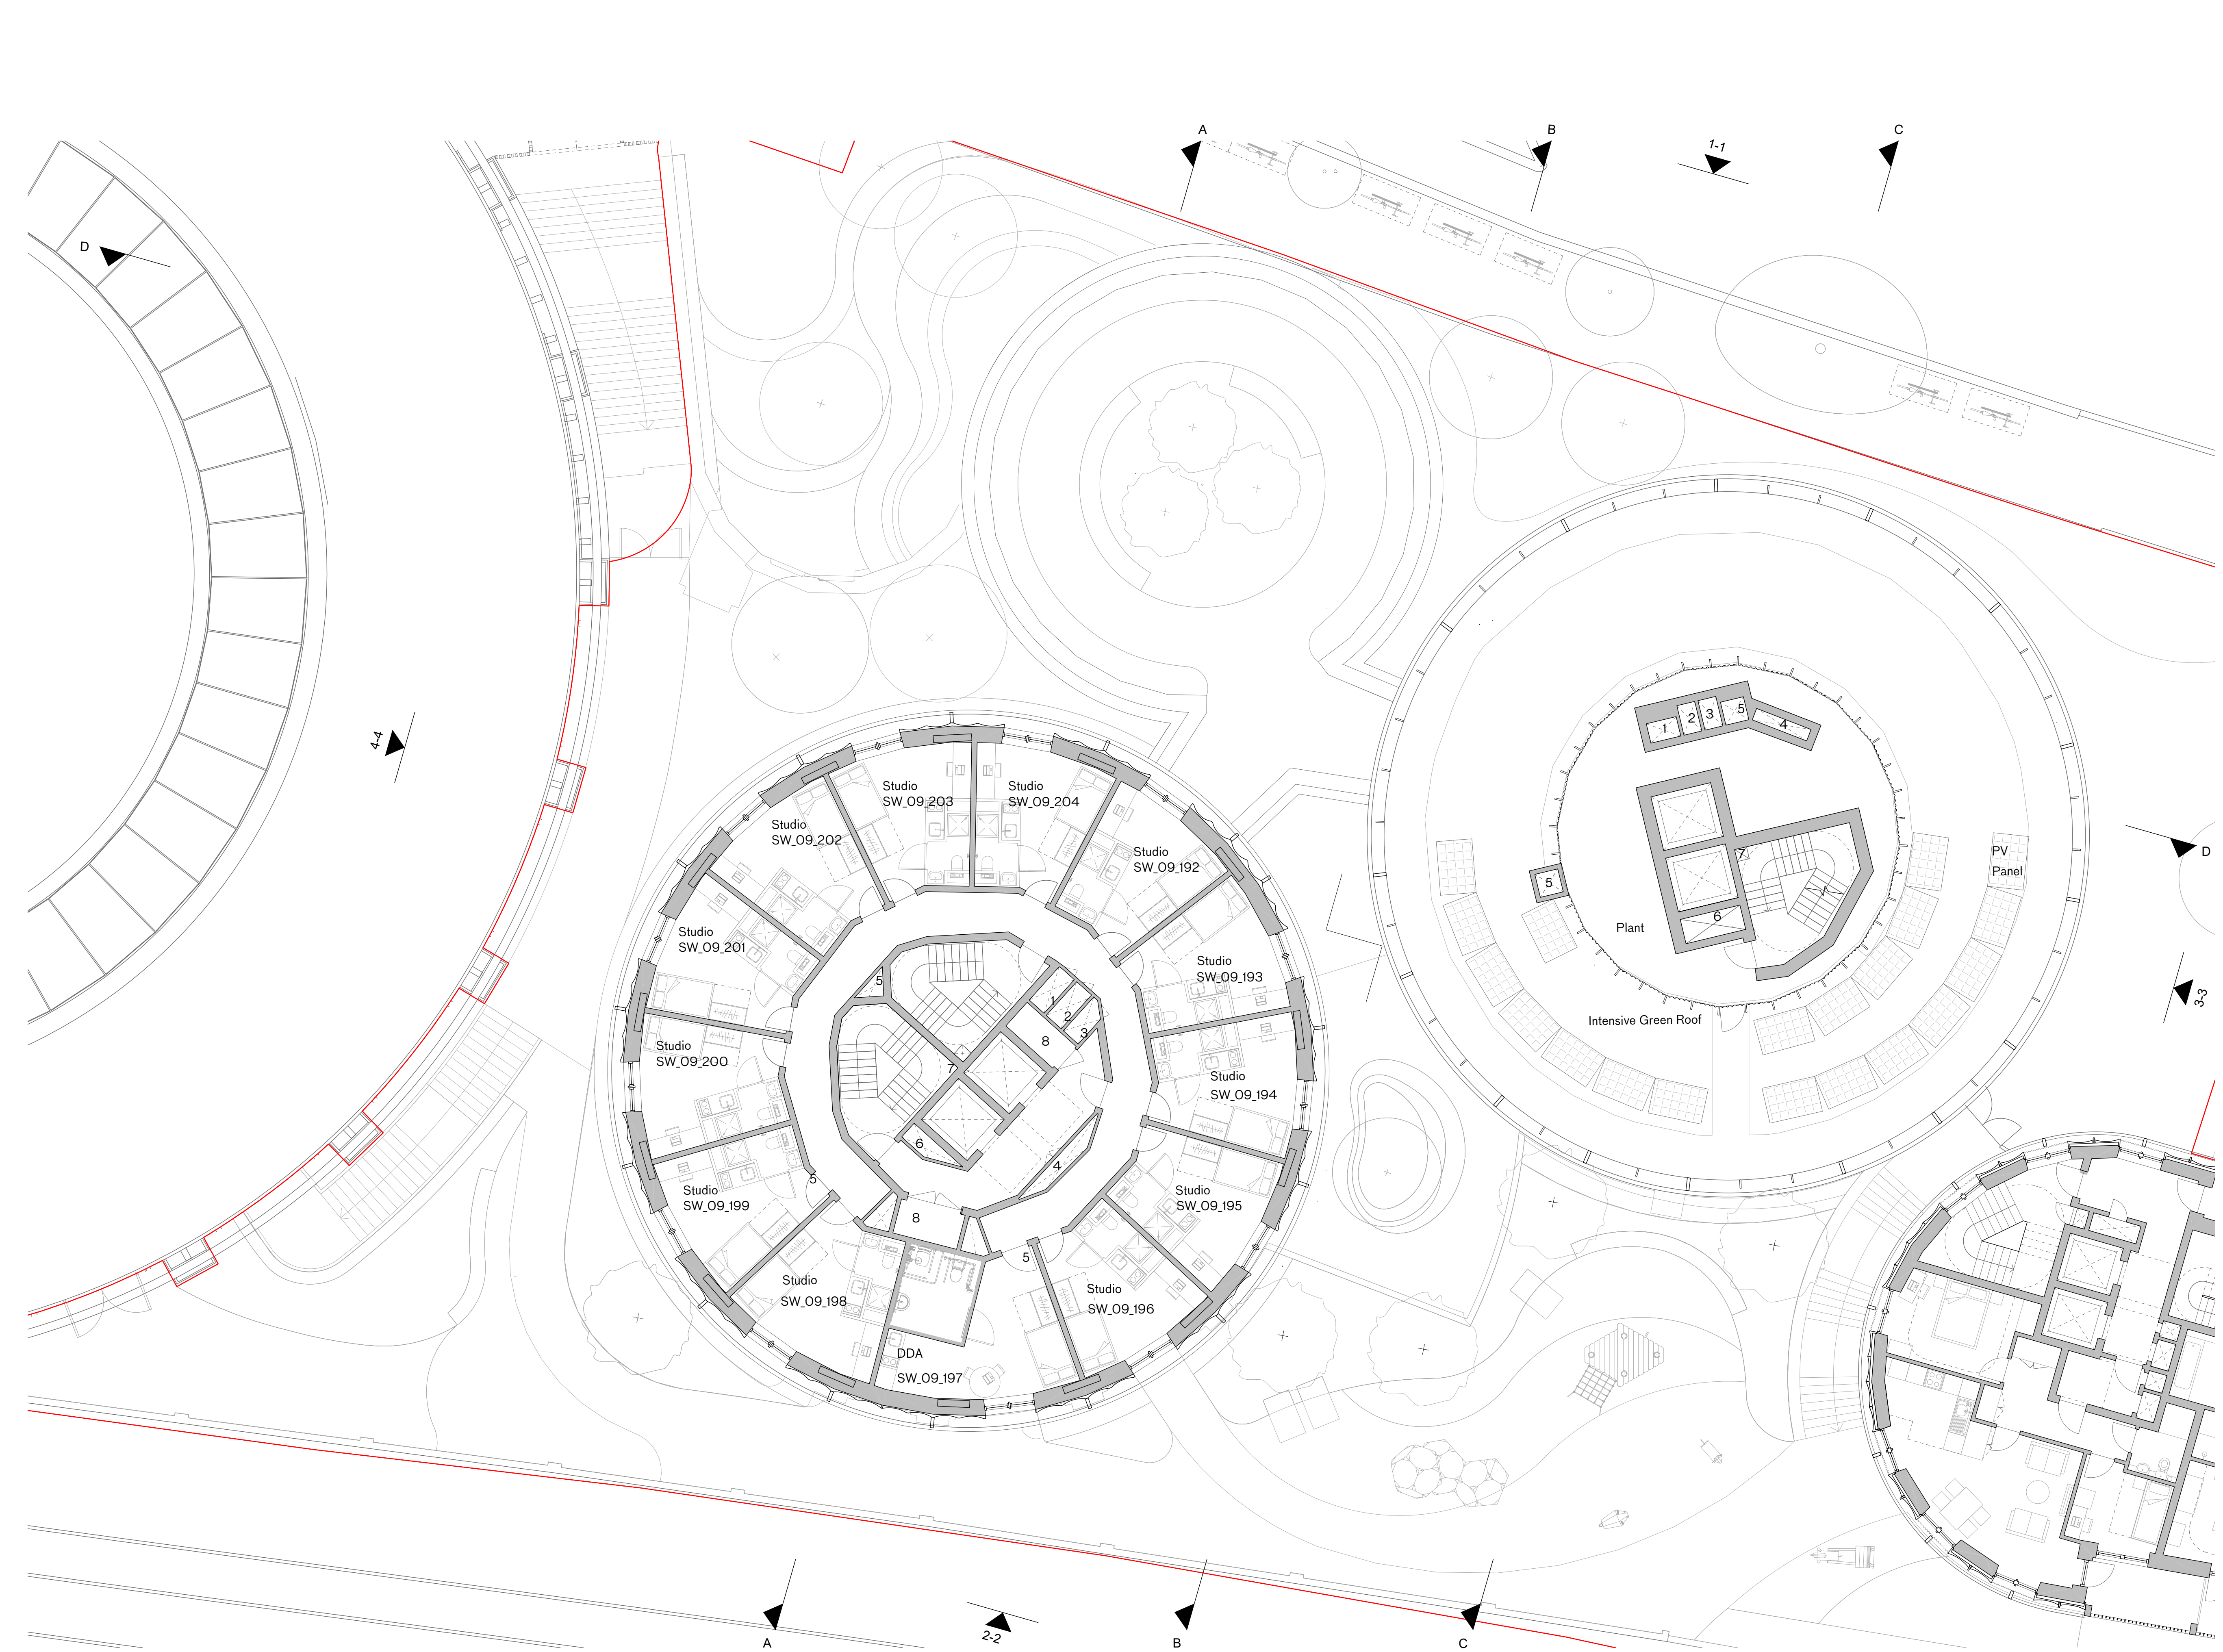

PBSA Level 9 Floor Plan

NOTES

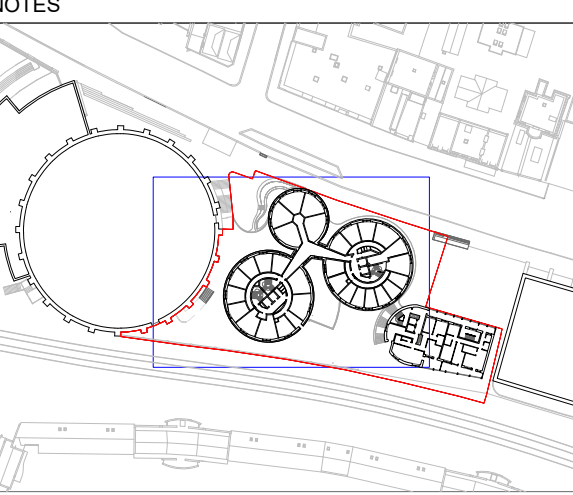

Key to Risers
1 Heating Riser
2 Water Riser
3 Comms Riser
4 Electrical Riser
5 Smoke Outlet
6 Smoke Inlet
7 Dry Riser
8 MVHR Cupboard
9 Mechanical Ventilation
Site Boundary

Petrol Filling Station Consented Scheme. Planning Ref: 2022/3646/P

C -28/05/24 Planning
B -17/05/24 Revised PBSA Layouts
A - 31/01/24 Planning

PLANNING

rev	date	check	comments
DSDHA 357 Kennington Lane London SE11 5QY T 020 7703 3555 F 020 7703 3890 E info@dsdha.co.uk W www.dsdha.co.uk			
project			
100 Chalk Farm Road			
drawing title			
PPSA Level 9 Floor Plan			
drawn	size	date	scale
Fl	A1	28/05/24	1 : 100
drawing number			revision
356_P20.139			C
REPORT DISCREPANCIES DO NOT SCALE FROM THIS DRAWING COPYRIGHT DSDHA		USE LATEST REVISION CHECK DIMENSIONS ON SITE	