


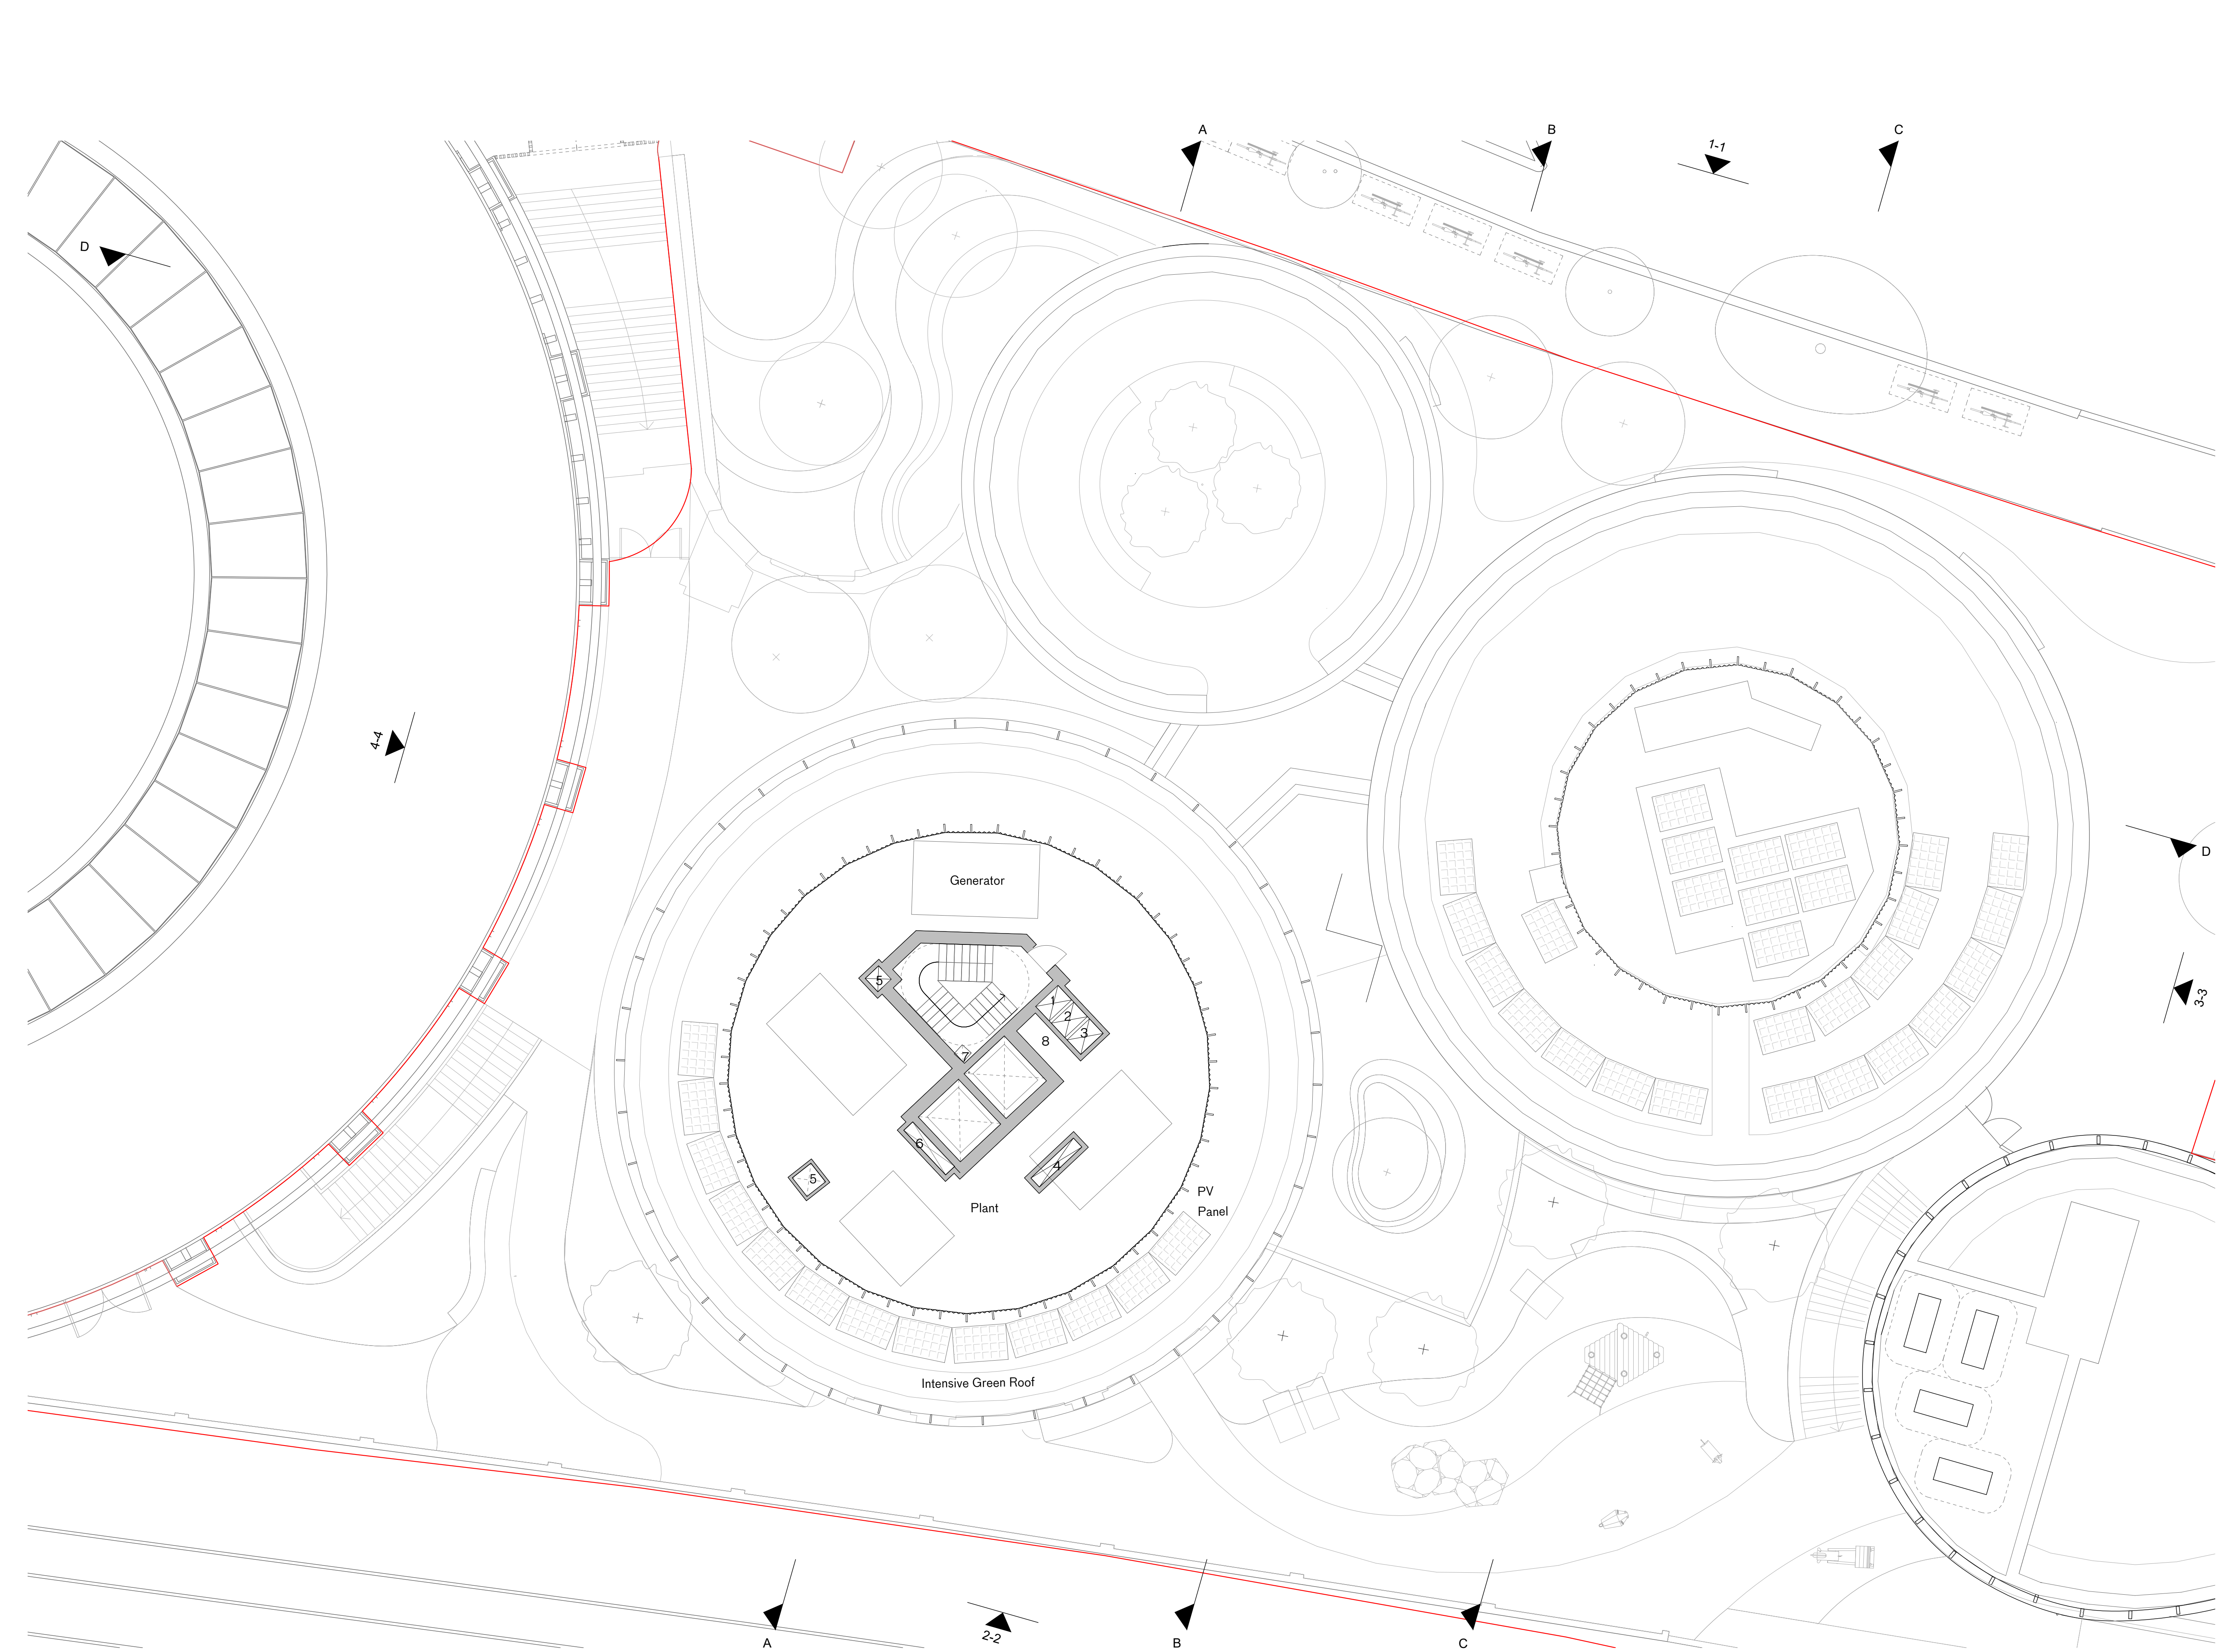

PBSA Level 12 Floor Plan

NOTES

Key to Risers

- 1 Heating Riser
- 2 Water Riser
- 3 Comms Riser
- 4 Electrical Riser
- 5 Smoke Outlet
- 6 Smoke Inlet
- 7 Dry Riser
- 8 MVHR Cupboard
- 9 Mechanical Ventilation

Site Boundary

Petrol Filling Station Consented Scheme. Planning Ref: 2022/3646/P

C -28/05/24 Planning
B -17/05/24 Revised PBSA Layouts
A - 31/01/24 Planning

PLANNING

rev	date	check	comments
DSDHA 357 Kennington Lane London SE11 5QY T 020 7703 3555 F 020 7703 3890 E info@dsdha.co.uk W www.dsdha.co.uk			
project			
100 Chalk Farm Road			
drawing title			
PPSA Level 12 Floor Plan			
drawn	size	date	scale
Fl	A1	28/05/24	1 : 100
drawing number			revision
356_P20.142			C
REPORT DISCREPANCIES DO NOT SCALE FROM THIS DRAWING COPYRIGHT DSDHA		USE LATEST REVISION CHECK DIMENSIONS ON SITE	