
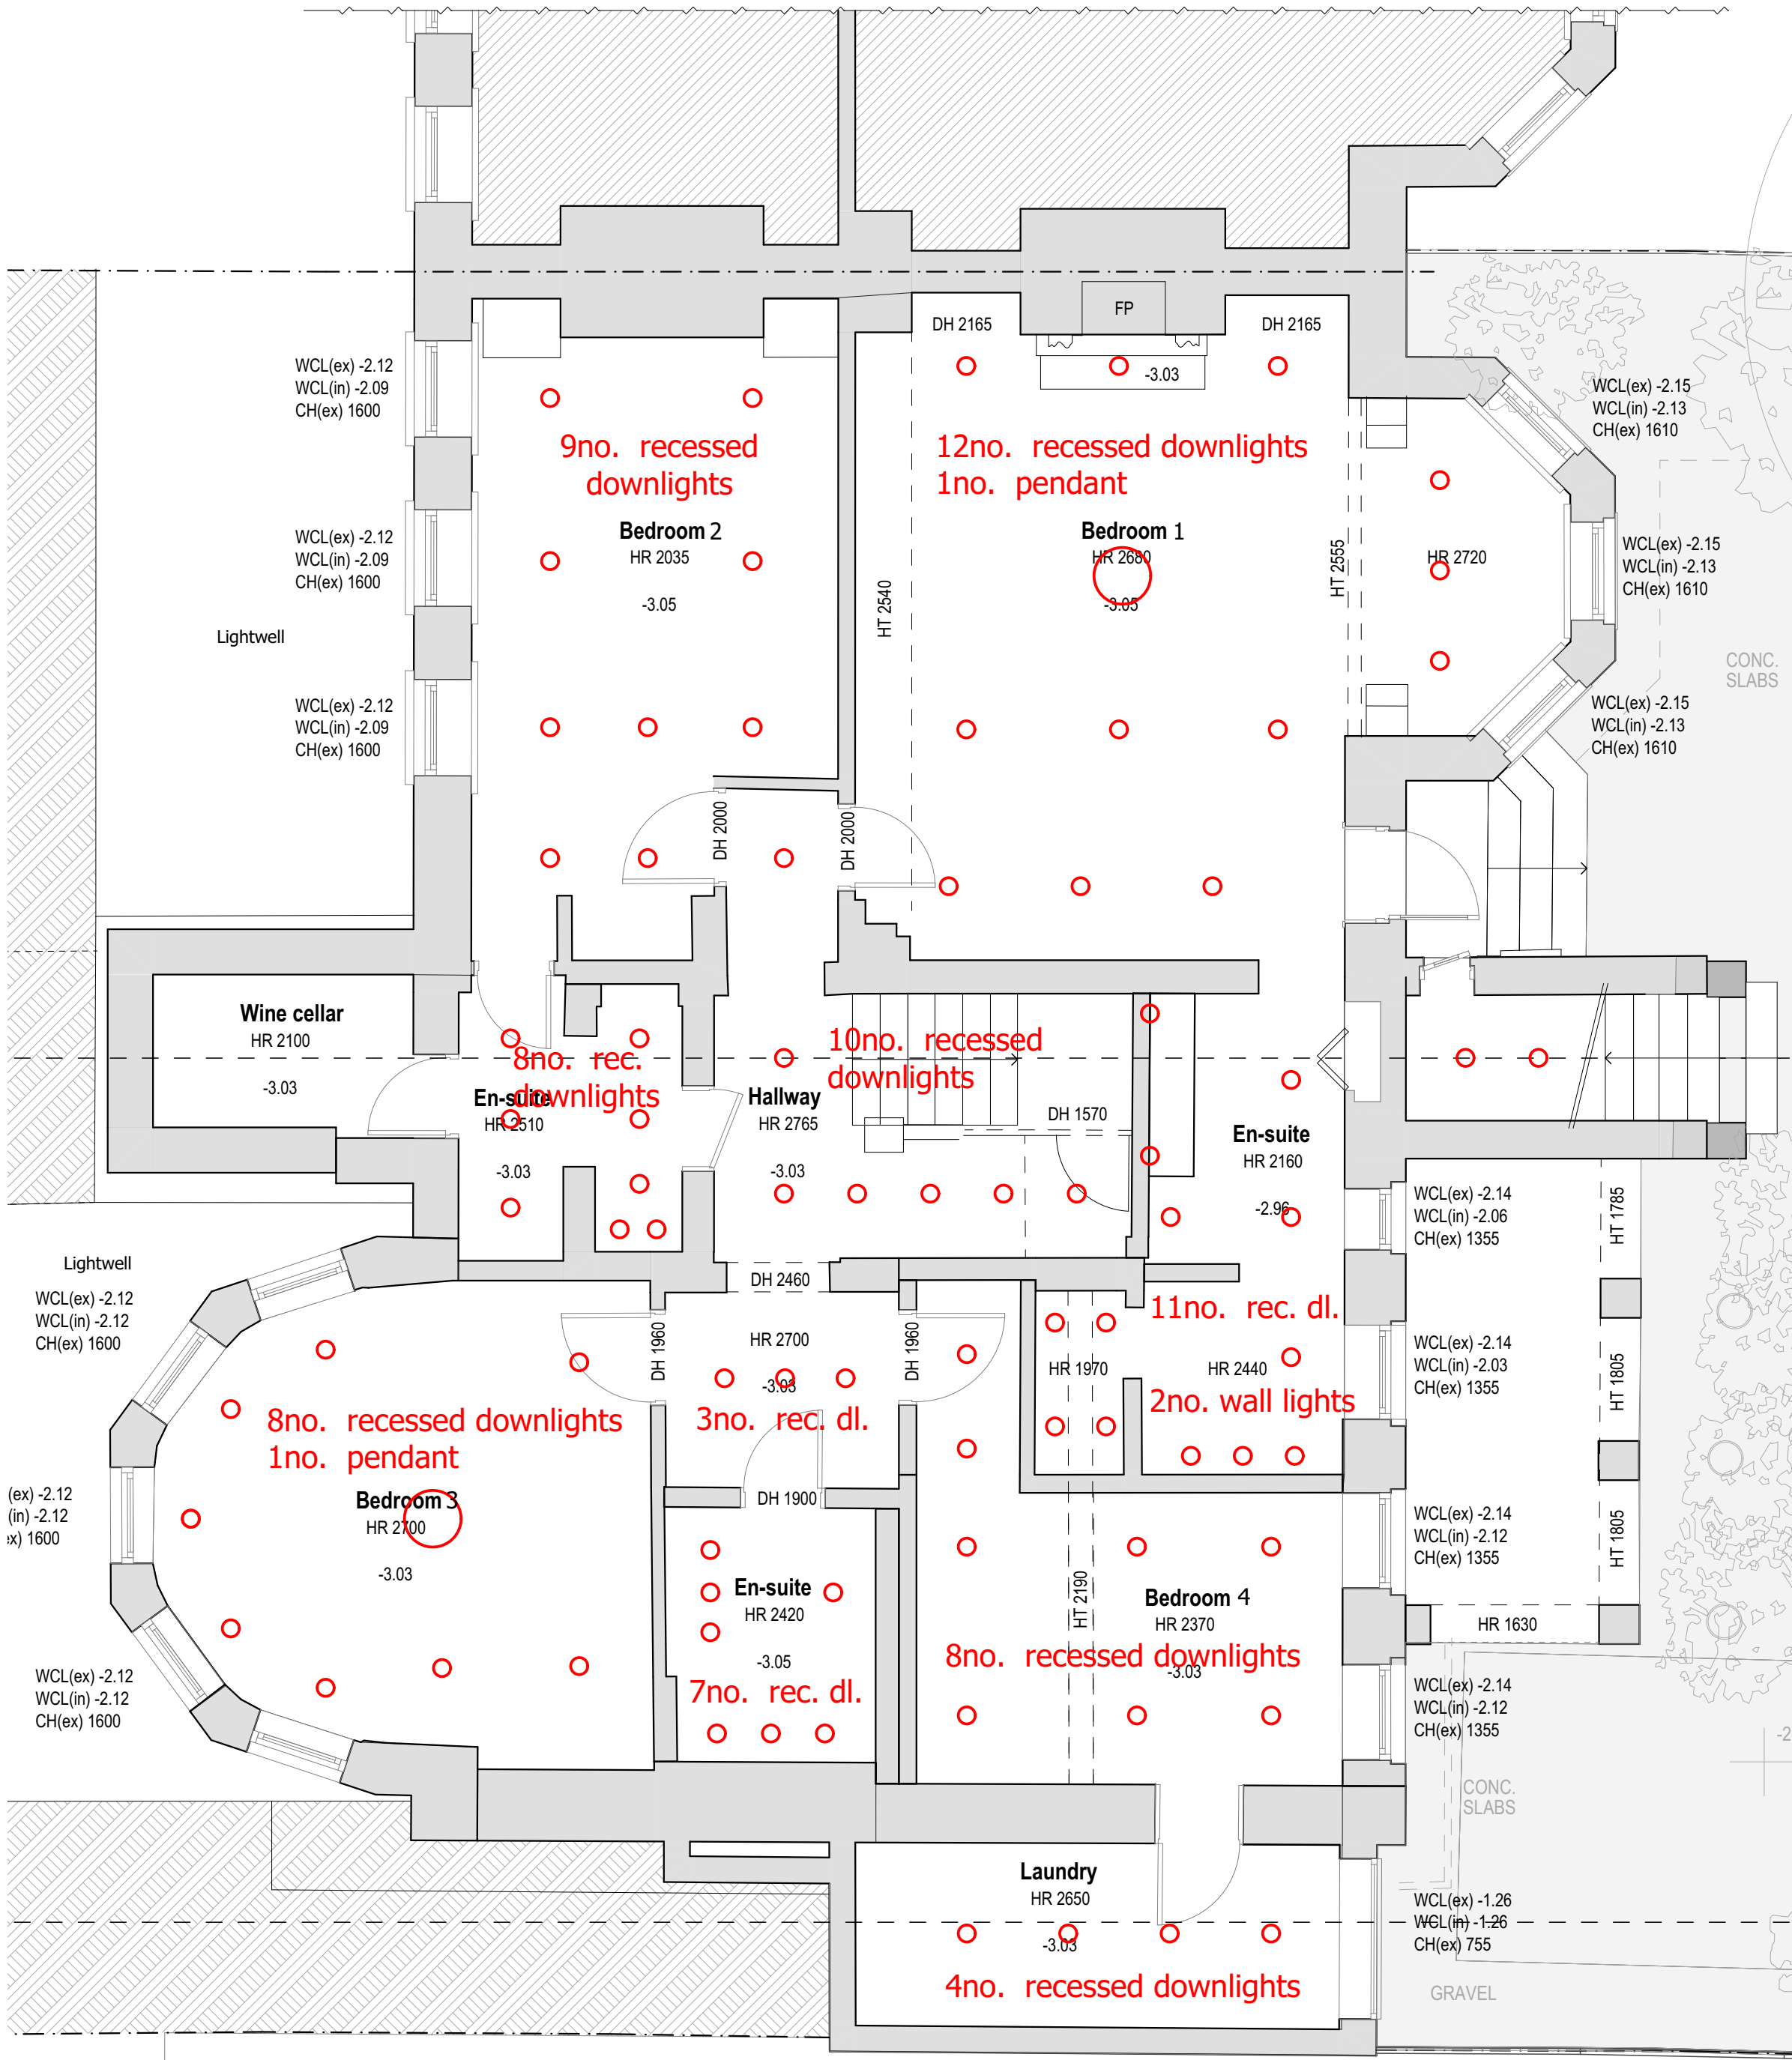
 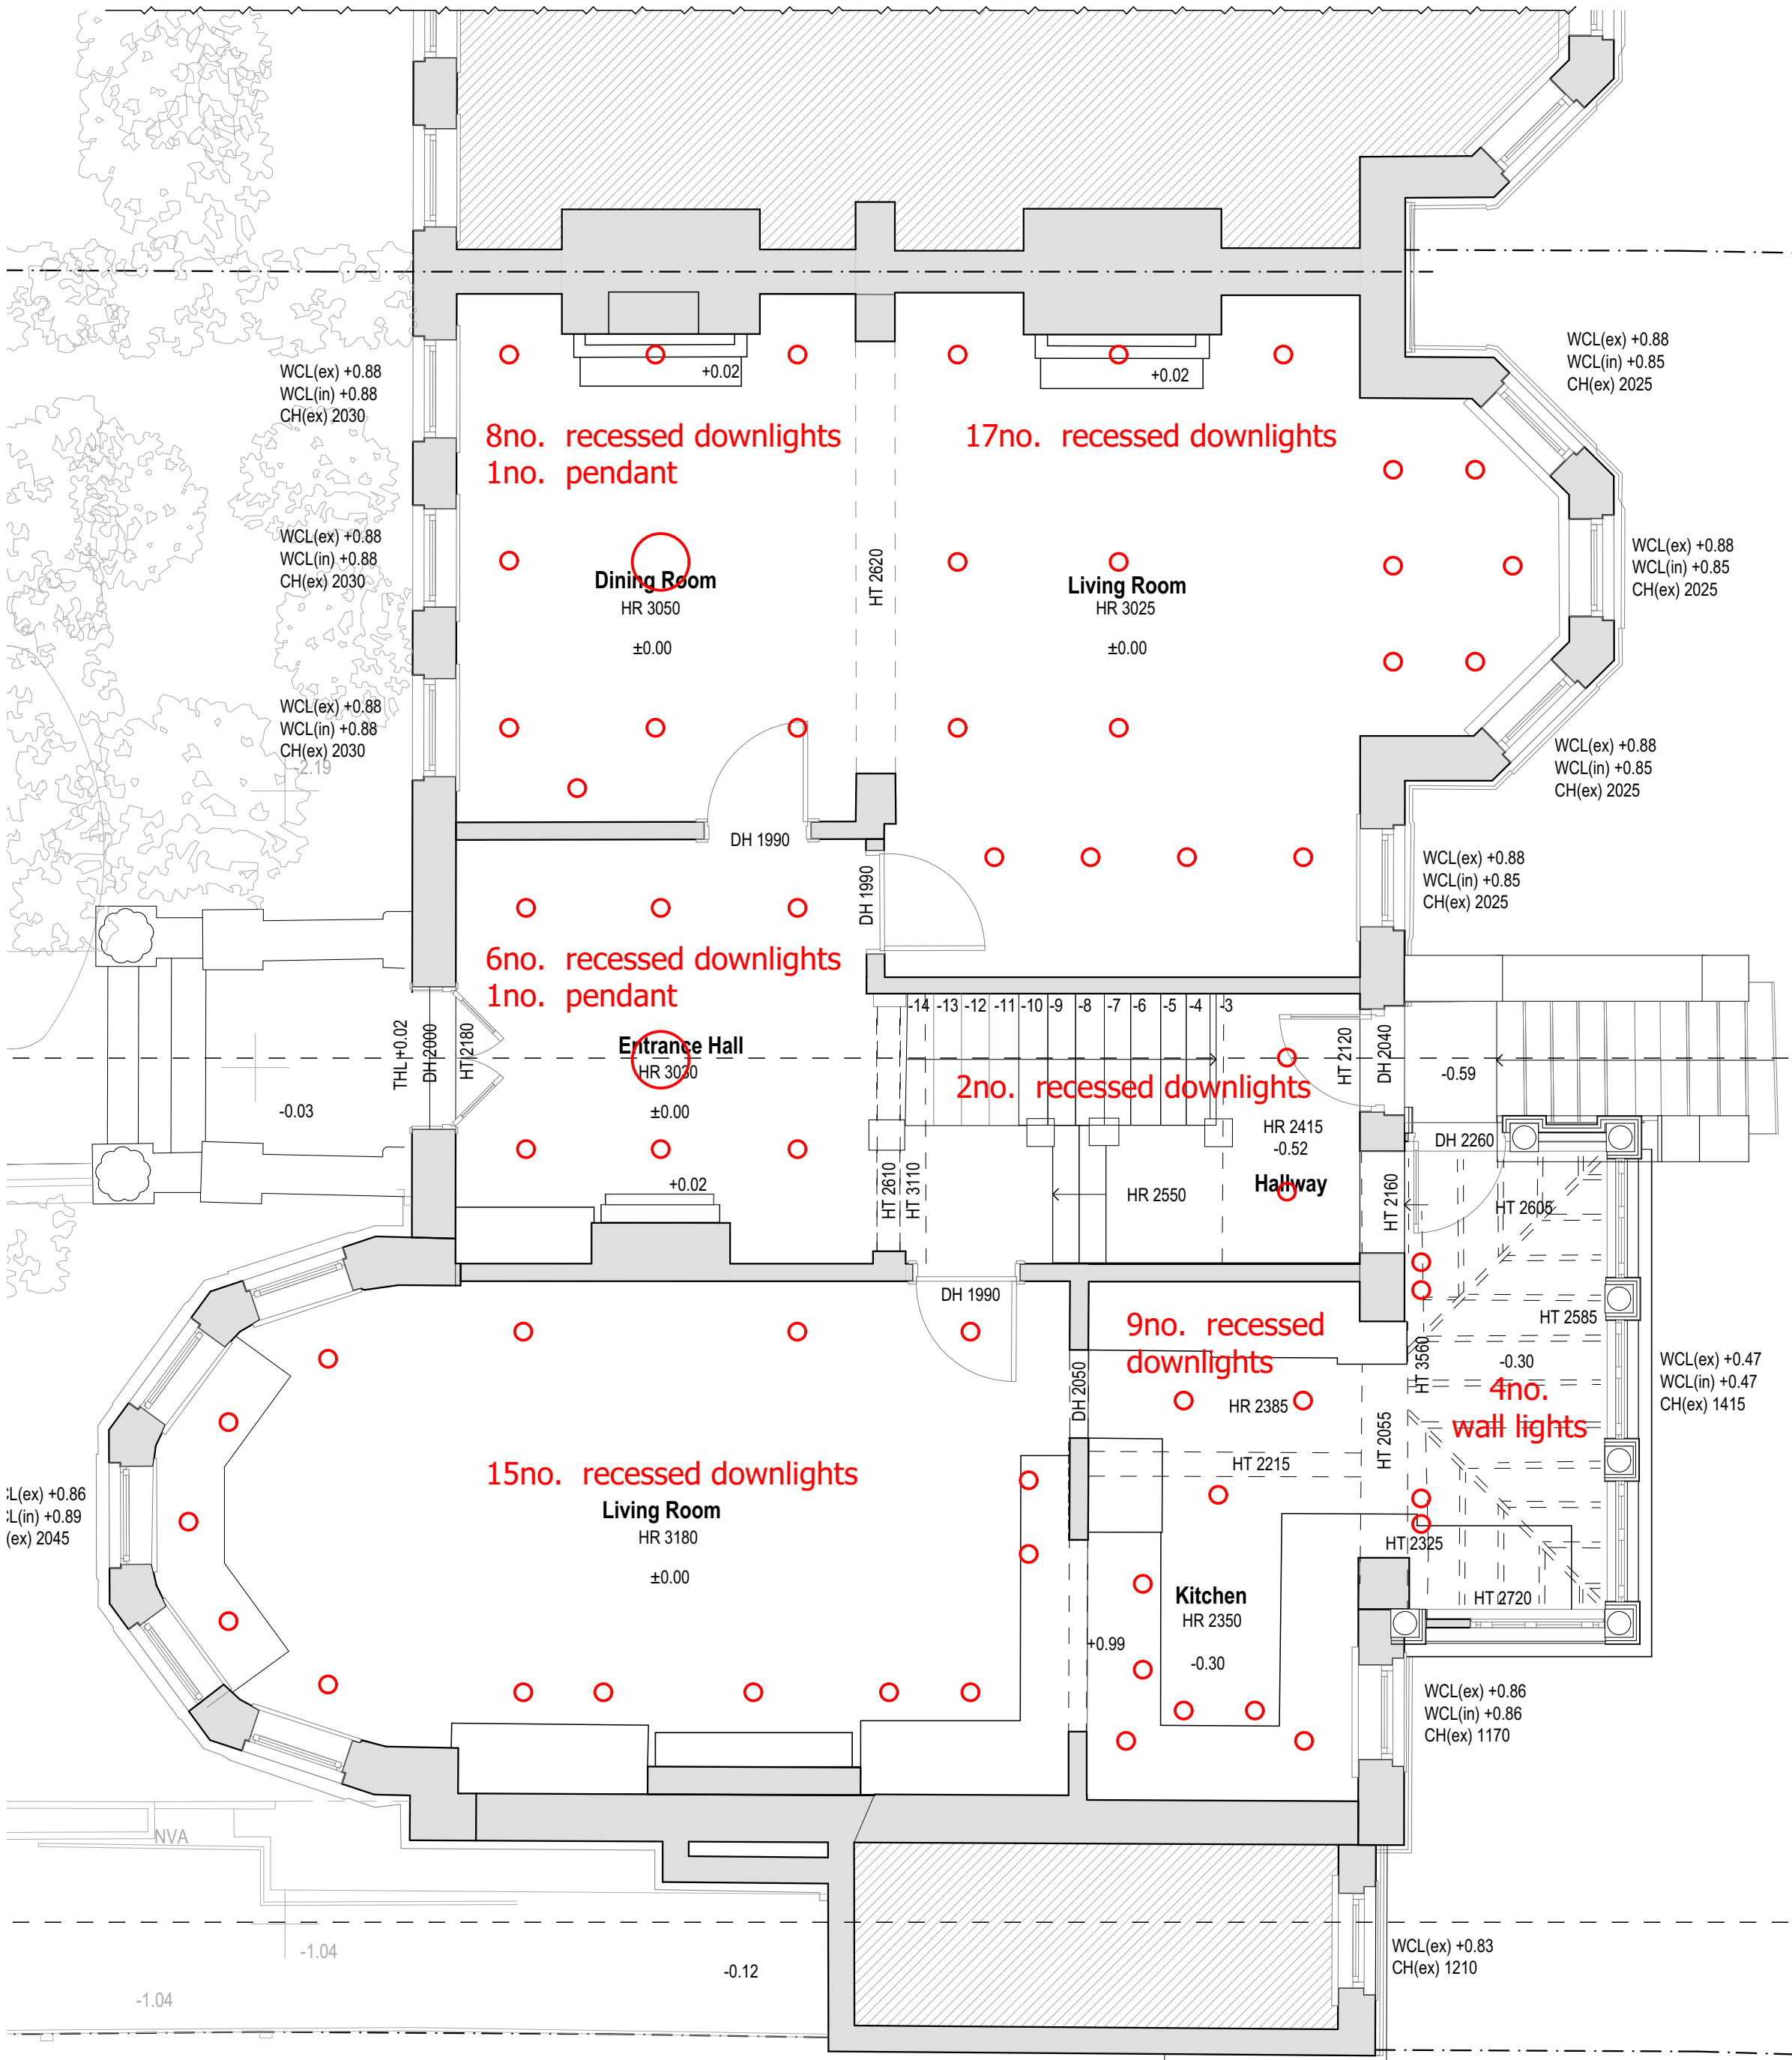




1 Pre-Existing Lighting - Ground Floor

Room	Pre-Existing			
	Downlight	Pendant	Wall	
Entrance	6	1	-	
Hallway	2	-	-	
Formal Dining	8	1	-	
Formal Living	17	-	-	
Living	15	-	-	
Kitchen	9	-	-	
Conservatory	-	-	4	
TOTAL	57	2	4	63

Room	Proposed				
	Downlight	Pendant	Wall	Night (low level)	
Entrance	6	1	2	1	
Hallway	4	-	-	2	
Formal Dining	4	1	2	-	
Formal Living	10	-	2	-	
Kitchen	8	4	-	-	
Snug	4	-	2	-	
Conservatory	-	-	5	-	
WC	2		1	-	
TOTAL	38	6	14	3	58+3

Number of recessed downlights to be reduced by: 19 fittings (57-38)

2 Pre-Existing Lighting - Lower Ground Floor

Room	Pre-Existing			
	Downlight	Pendant	Wall	
Hallway	10	-	-	
Bedroom 1	12	1	-	
En-suite 1	11	-	2	
Bedroom 2	9	-	-	
En-suite 2	8	-	-	
Bedroom 3	8	1	-	
Bathroom	7	-	-	
Bedroom 4	8	-	-	
Laundry	4	-	-	
	77	2	4	83

Room	Proposed				
	Downlight	Pendant	Wall	Night (low level)	
Hallway	8	-	3	1	
Bedroom 1	9	1	2	1	
En-suite 1	10	-	-	1	
Bedroom 2	5	1	2	1	
En-suite 2	3	-	1	1	
Bedroom 3	9	1	-	1	
Bathroom	3	-	1	1	
Bedroom 4	8	-	-	-	
En-suite 4	4	-	-	1	
	59	3	9	8	71+8

Number of recessed downlights to be reduced by: 18 fittings (77-59)

3 Number of fittings - Ground Floor

4 Number of fittings - Lower Ground Floor

Rev.	Date	Descriptor
LBC01	18.05.2024.	Listed Building Consent
project	131_9 Wedderburn Road	
site address	9 Wedderburn Road London NW3 5QS	
client	Private Client	
drawing title	Pre-Existing Lighting Plan	
project number_drawing number_revision	131_108_LBC01	
date	18.05.2024.	
designed / drawn by	4H Architecture 0751572458 info@4harchitecture.co.uk	
scale	0 1 2.5m scale 1:50	