


9 **PROPOSED STORAGE PLAN**  
SCALE 1:50@A3

 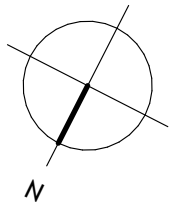


New walls, doors, plumbing fixtures,  
electrical appliances.



New plasterboard structures

This scale is 10cm in length when printed at the size indicated in the title block



Project Title:  
**Apartment 3-08**  
St. Pancras Chambers,  
Euston Road,  
London,  
NW1 2AR

Project Descrip on :  
**PROPOSED STORAGE PLAN.**

Scale:  
1:50 @ A3  
Date:  
JAN '12  
Drawing number:  
009

Drawing buy:  
LD  
Checked buy:  
LD  
Revision:  
P.05-11.06.24

LANYON DEVELOPMENT

Room LU.320  
The Light Bulb  
1 Filament Walk  
SW18 4GQ

Lanyondevelopment.co.uk

L

D