 

 


SAFETY, HEALTH AND ENVIRONMENTAL INFORMATION

NO SIGNIFICANT RISK WHICH REQUIRES TO BE COMMUNICATED TO A COMPETENT CONTRACTOR HAS BEEN IDENTIFIED IN RELATION TO THIS DRAWING.

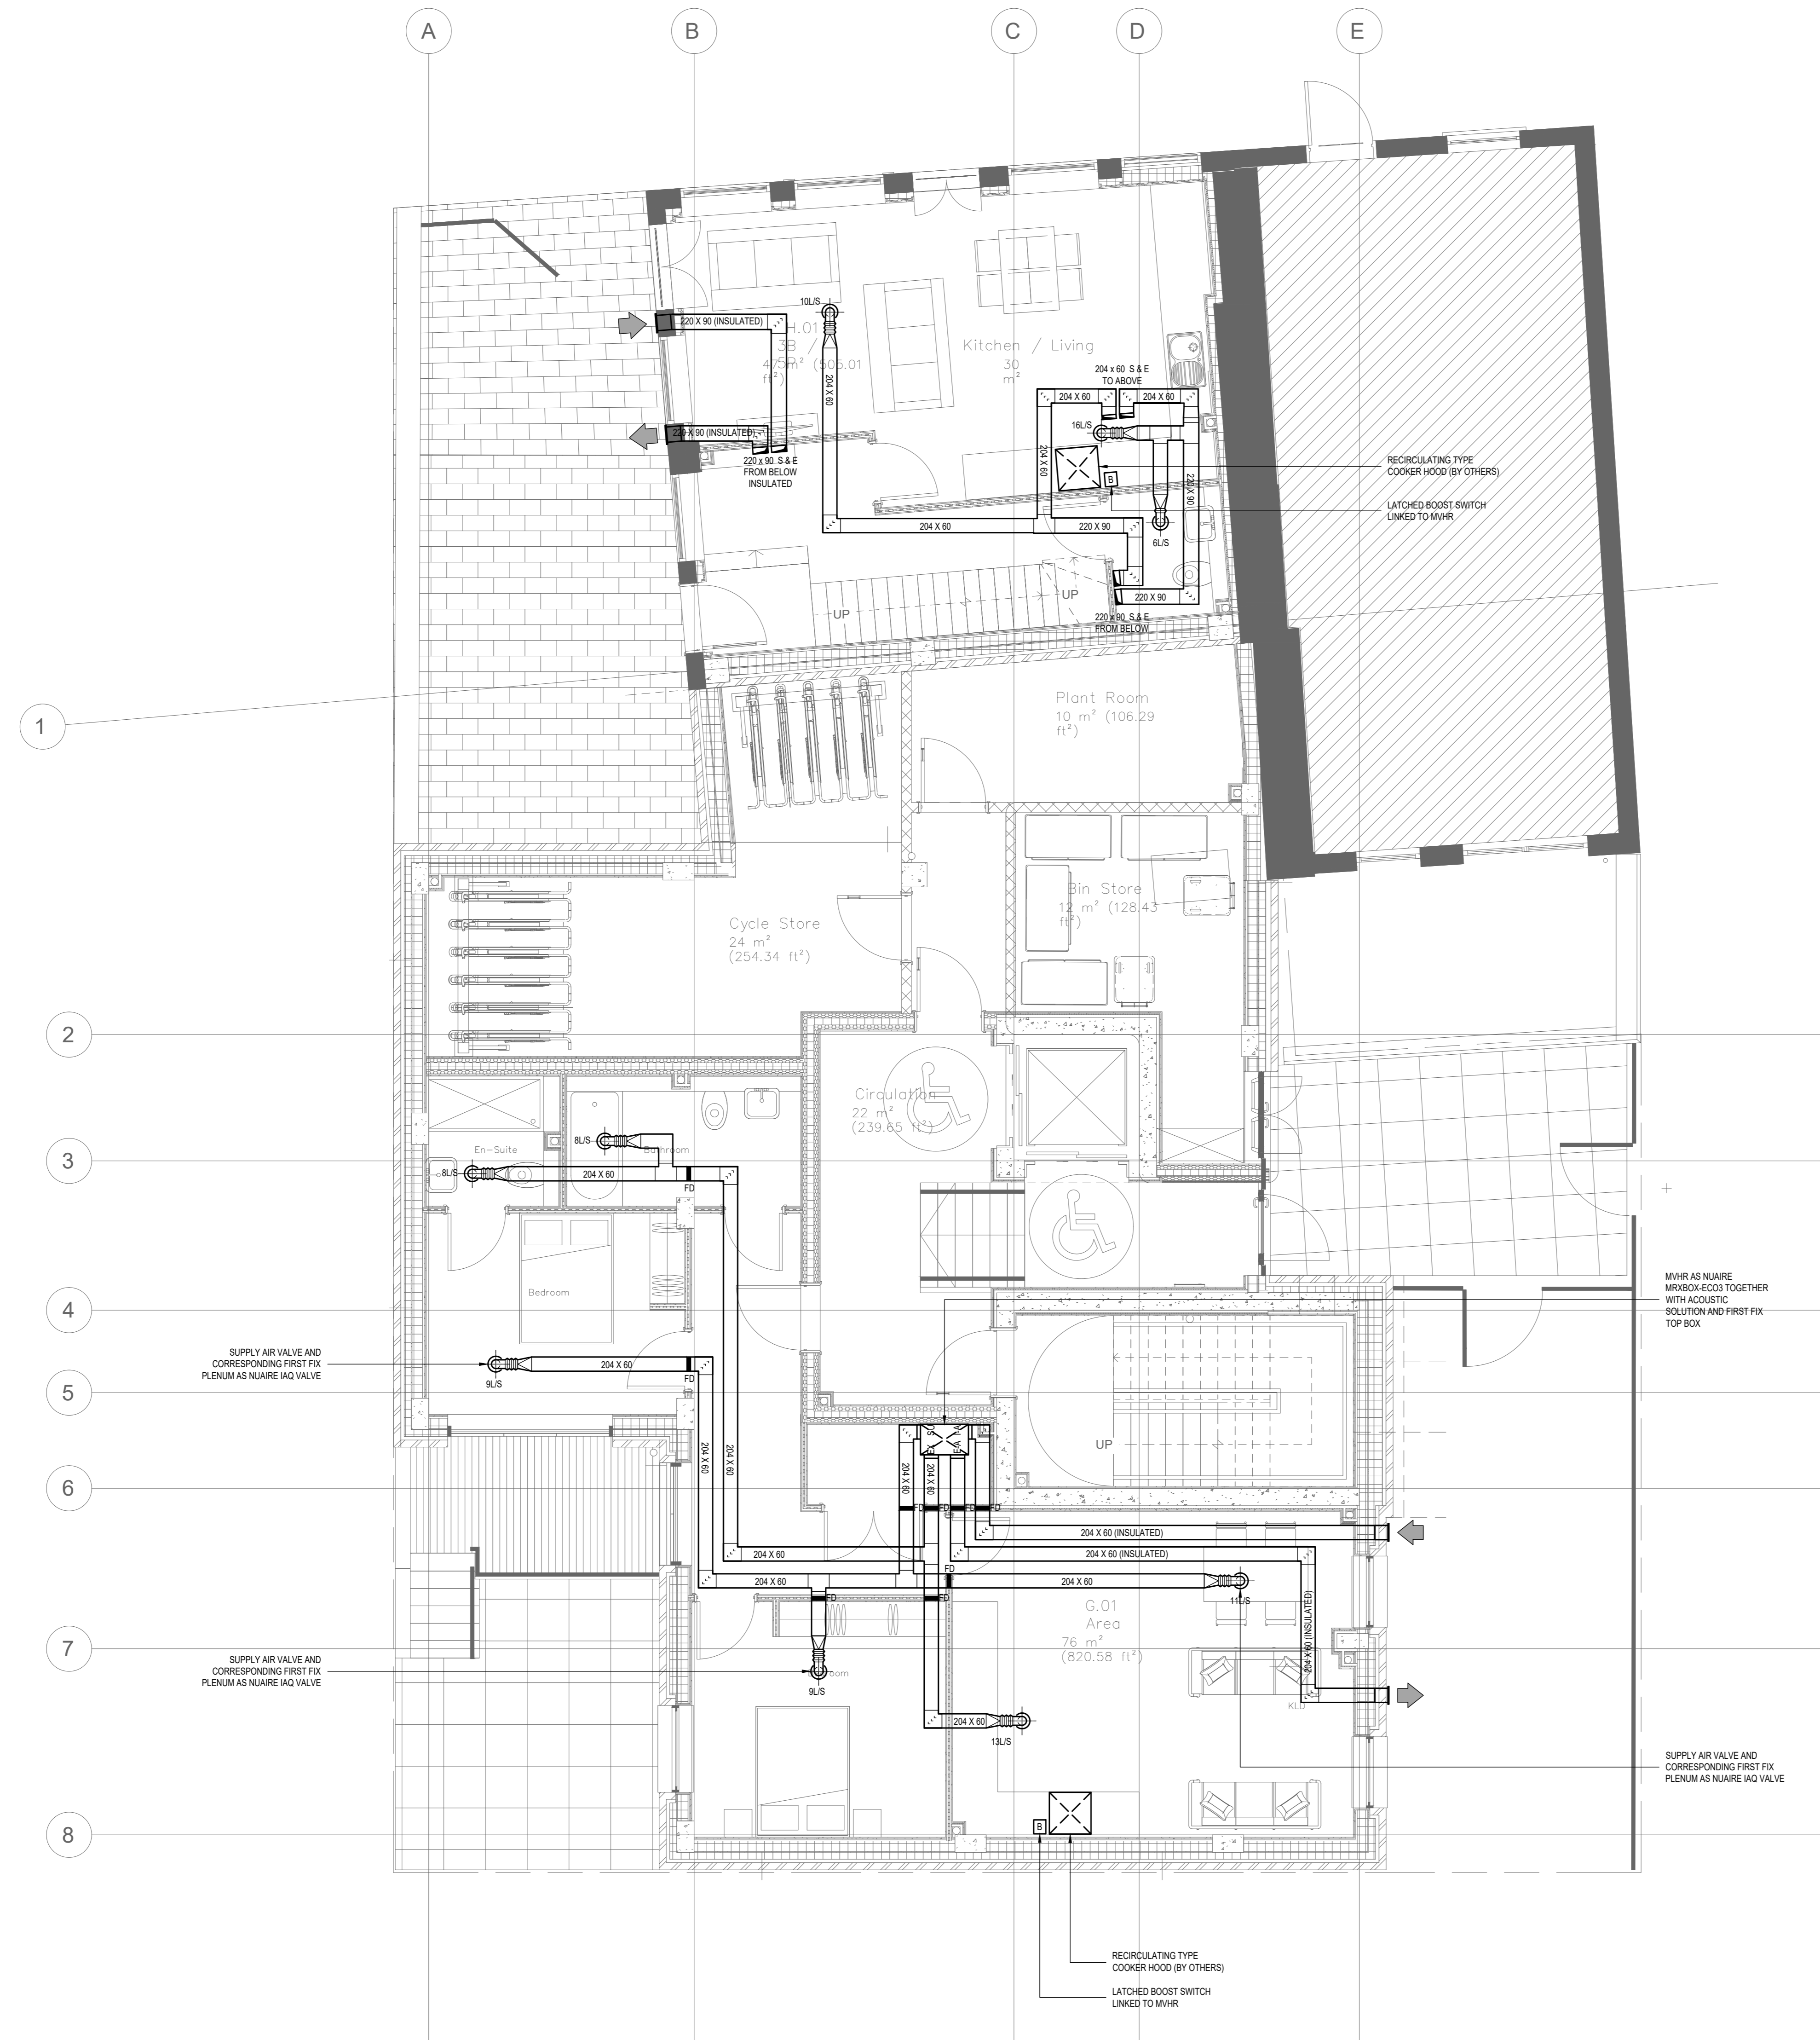
THESE NOTES ARE BASED ON THE USE OF EXPERIENCED AND COMPETENT CONTRACTORS CARRYING OUT THE WORK USING AN APPROVED SAFE METHOD OF WORKING.

LEGEND:

-  RECTANGULAR DUCTWORK (AT ALL LEVELS)
-  FIRE DAMPER
-  FLEXIBLE CONNECTION

NOTES:

1. THIS DRAWING SHALL BE READ IN CONJUNCTION WITH ALL OTHER M&E SERVICES DRAWINGS, TOGETHER WITH THE ARCHITECTS & STRUCTURAL DRAWINGS AND ASSOCIATED SPECIFICATIONS.
2. ALL SERVICES PASSING THROUGH FIRE COMPARTMENT WALLS WILL BE IN ACCORDANCE WITH THE RELEVANT SPECIFICATION & BRITISH STANDARDS.
3. FLEXIBLE DUCTWORK LENGTHS SHALL NOT EXCEED 500mm AND SHALL NOT BE USED FOR CHANGES OF DIRECTION.
4. THE RESPONSIBILITY FOR THE SUPPORT OF THE ENTIRE DUCTWORK SYSTEMS AND ASSOCIATED PLANT SHALL BE THAT OF THE MECHANICAL CONTRACTOR.



| No. | Description | Origin | Drawn | Checked | Date |
|-----|--------------|--------|-------|---------|----------|
| T2 | TENDER ISSUE | J.I. | J.I. | J.I. | 31/05/24 |
| T1 | TENDER ISSUE | J.I. | J.I. | J.I. | 09/02/24 |

Revisions:

| Checked by | Date |
|---------------------------------------|------|
| A - Approved | |
| B - Approved with comments | |
| C - Revised with comments & re-submit | |
| D - Do not use | |



Drawing Status:
TENDER ISSUE

Client:
KK4 LTD

Project Title:
**BIRD IN HAND
WEST END LANE
NW6 4NX**

Drawing Title:
**VENTILATION LAYOUT
GROUND FLOOR**

| Scale @ A0 | Originator | Drawn by | Checked |
|------------|------------|----------|---------|
| 1:50 | J.I. | J.I. | J.I. |

| Project No. | Date |
|-------------|--------|
| IP23040 | JAN 24 |

| Drawing No. | Revision |
|-----------------|----------|
| IP23040-L-M-211 | T2 |

DO NOT SCALE FROM THIS DRAWING
ALL DIMENSIONS TO BE CONFIRMED ON SITE